


V-3250
LOW PRESSURE SEPARATOR
 1067mm OD x 4572mm S/S
 (42" OD x 15'-0" S/S)
 D.P.: 9930 kPa @ -45/54°C
 (1440 psig @ -49/129°F)
 1.6mm C.A.

LCV-3251
LIQUID DUMP VALVES
 MAKE: FISHER
 MODEL: 2" D4
 c/w 1" TRIM

PV-3250
BACK PRESSURE VALVE
 MAKE: DYNAFLO
 MODEL: 3" 360
 2-5/16" REDUCED PORT TRIM

FE-3251
LIQUID METERS
 MAKE: TBD
 MODEL: TBD

PV-3251
PRESSURE CONTROL VALVE
 MAKE: FISHER
 MODEL: 2" D BODY
 1/2" EQZ TRIM FLOW UP

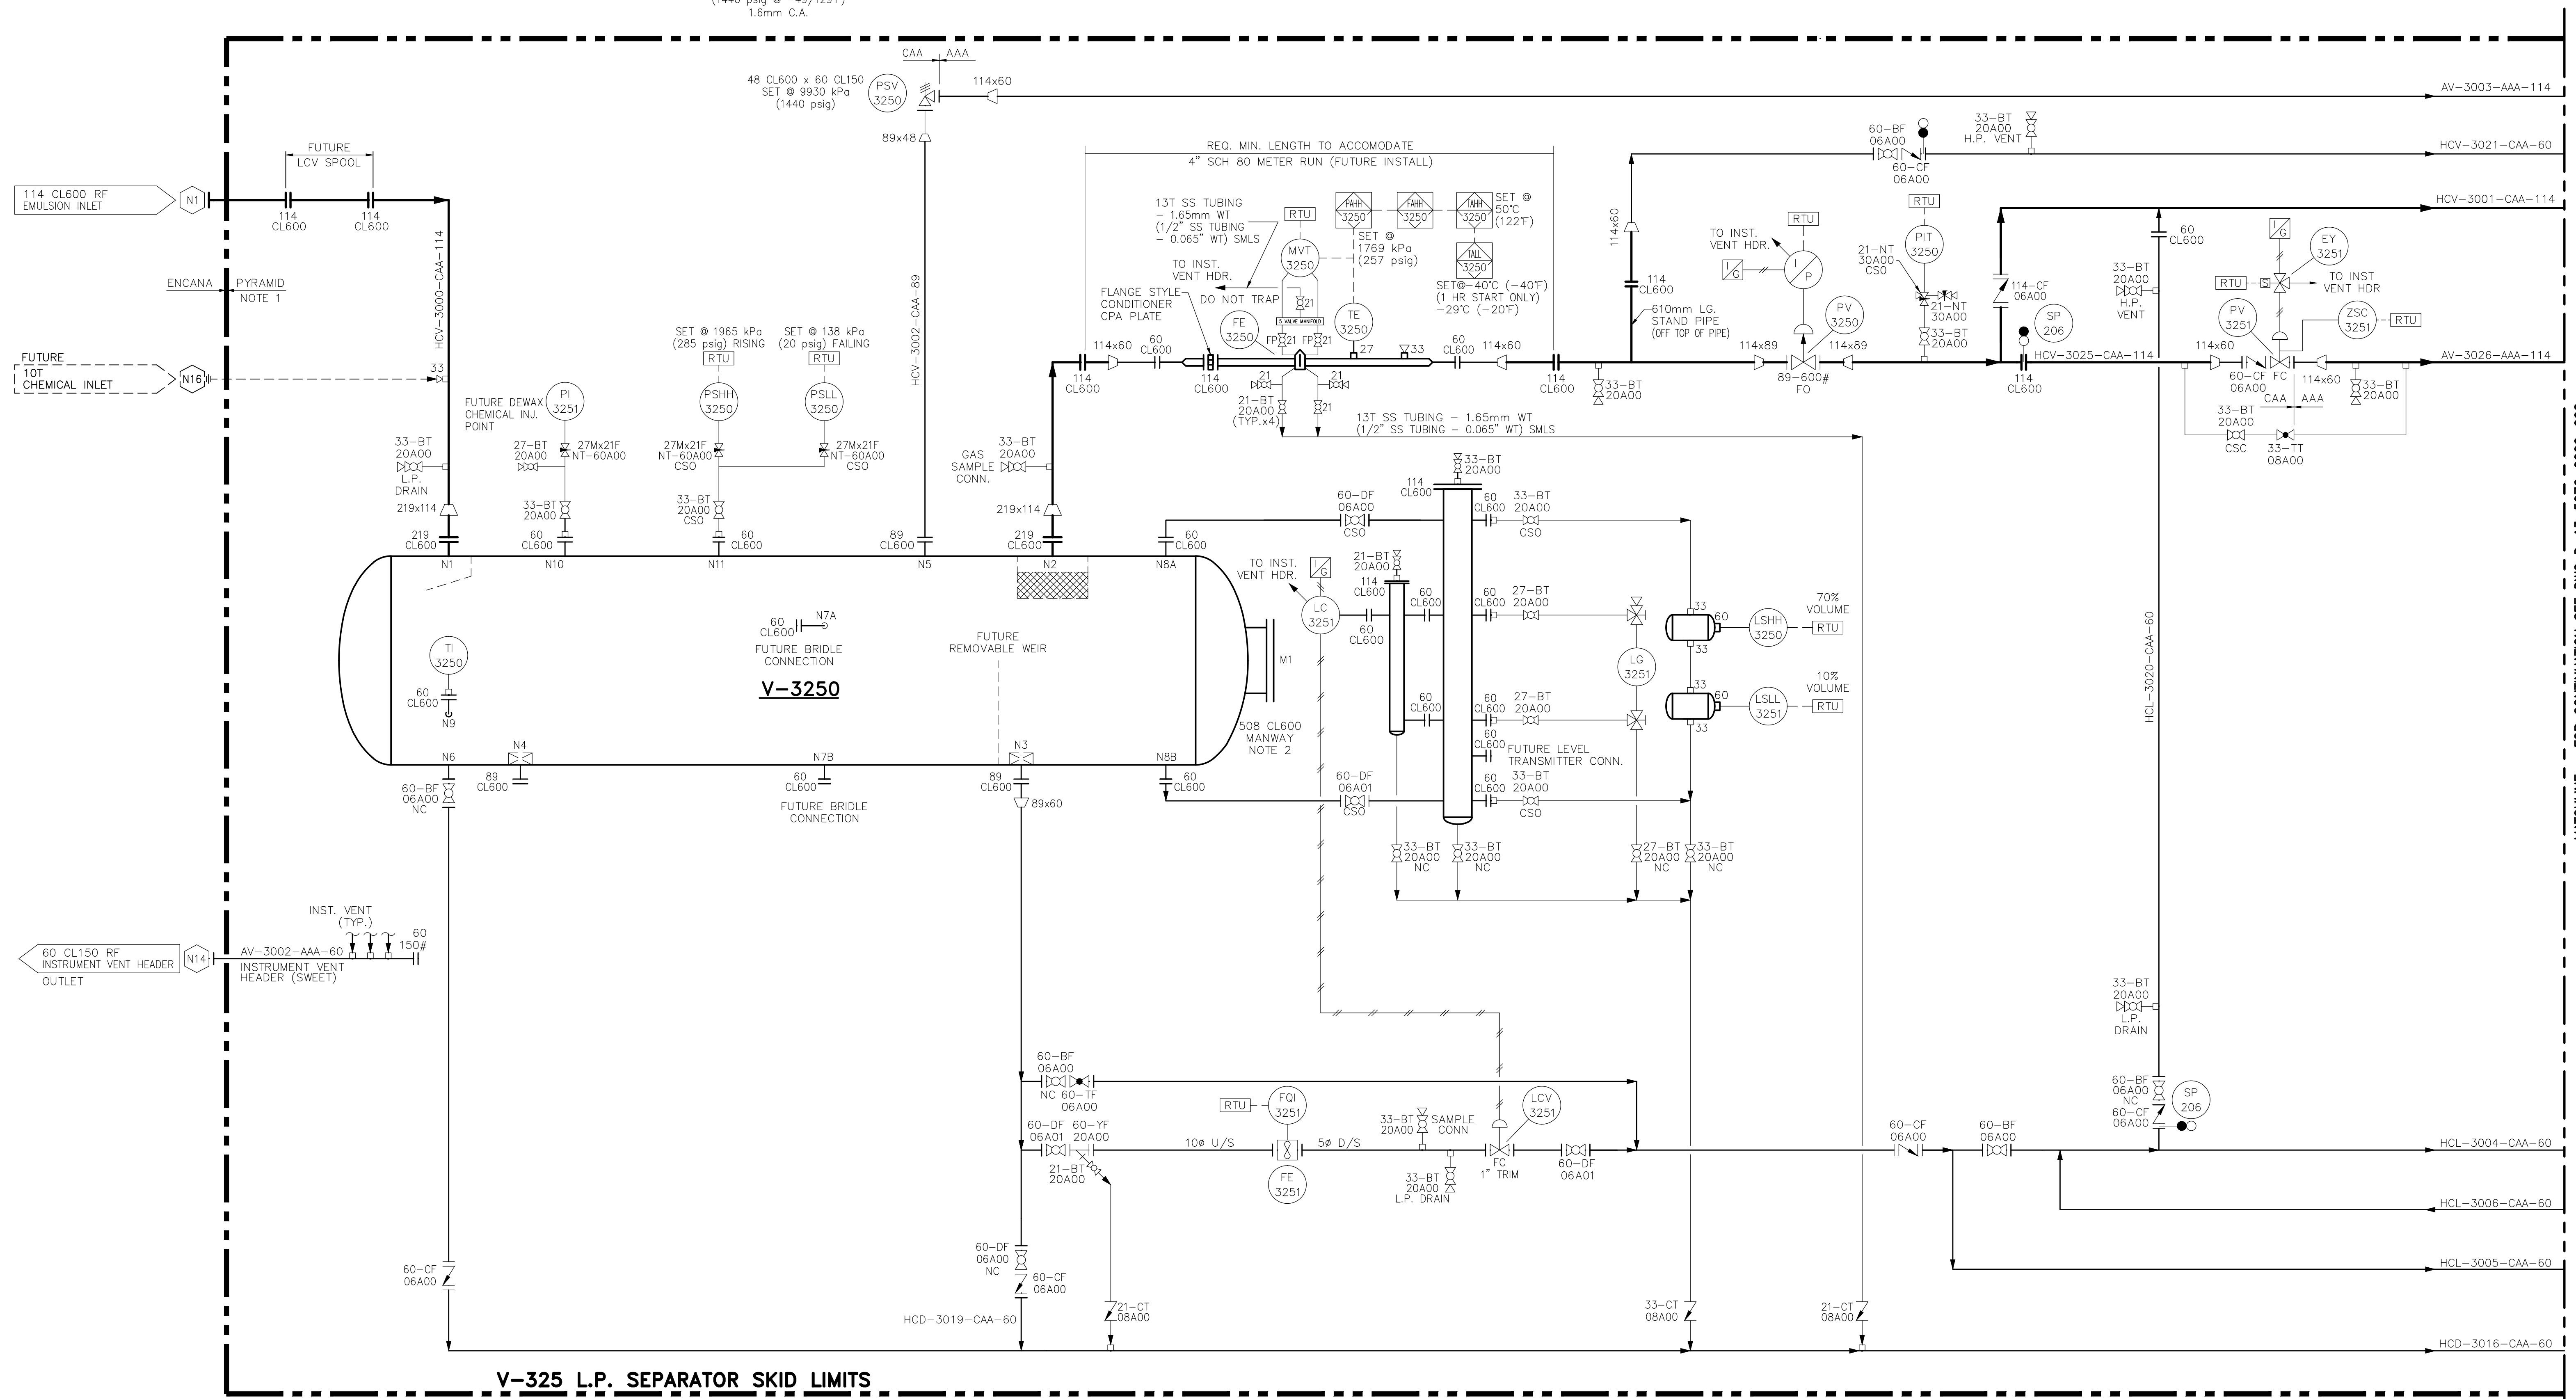


V-325 L.P. SEPARATOR SKID LIMITS

NOTES:

1. LOW TEMPERATURE MATERIAL PROVIDED UP TO ONE (1) METER INSIDE OR TO FIRST WELD INSIDE BLDG; WHICHEVER IS WORST CASE.
2. VESSEL MANWAY NOZZLE TO EXTEND O/S OF BUILDING WALL.

DRAWING NO.	DESCRIPTION	REV.	BY	CHECKED BY	PROJECT MGR.	DATE
		0	SF	CM	HW	ISSUED FOR CONSTRUCTION 04/11/13
		A	SF	CM	HW	ISSUED FOR APPROVAL 01/10/13
REFERENCE DRAWINGS			REVISIONS			

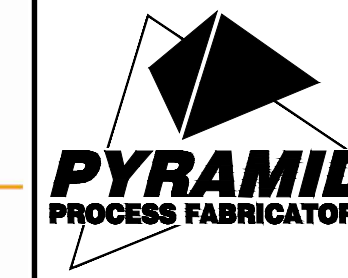

PYRAMID PROCESS FABRICATORS	
HIGU - ALBERTA - CANADA / www.pyramidfabricators.com	
DRAWING TITLE:	RED ROCK DEVELOPMENT L.P. SEPARATOR P&ID
JOB NO.:	5076
CLIENT:	ENCANA c/o PRECISION ENGINEERING INC.
SCALE:	1:1
DATE:	12-12-063-08 W6M
DWG. NO.:	D-13-5076-0000-001
REV. NO.:	0

MATCHLINE -- FOR CONTINUATION SEE DWG D-13-5076-0000-002