

F-3212
CACTUS DRYER

F-3210/3211
COALESCING FILTERS

BH-3220/3230/3240
BUILDING HEATER
MAKE: CATADYNE
MODEL: BX 24X24
DUTY: 16,000 BTU/HR
PROPANE

V-3210
FUEL GAS SCRUBBER
SIZE: 324mm OD x 1524mm LG (12" OD x 5'-0" S/S)
SCH 40 CRN
CA: 1.6mm (1/16")
MAWP: 1965kPa (285psig)
MDMT: -29°C (-20°F) @ 1965kPa (285psig)


P-3260
CORROSIVE INHIBITOR

LG-3260
RATE/LEVEL GAUGE

MVT-3210
MULTIVARIABLE TRANSMITTER
MAKE: SCHNEIDER ELECTRIC
MODEL: SCADAPAK 4102
PART NO.: TBUT4102M22101U00A
c/w TE-101(PART No. TBUM 298258
& MOUNTING BRACKET (TBUM 298277))

FQI-3210
FUEL GAS METER
MAKE: ROMET
MODEL: STD CTR RM55
CAPACITY: 18927 SCFM@125psig

MATCHLINE -- FOR CONTINUATION SEE DWG D-13-5076-0000-001

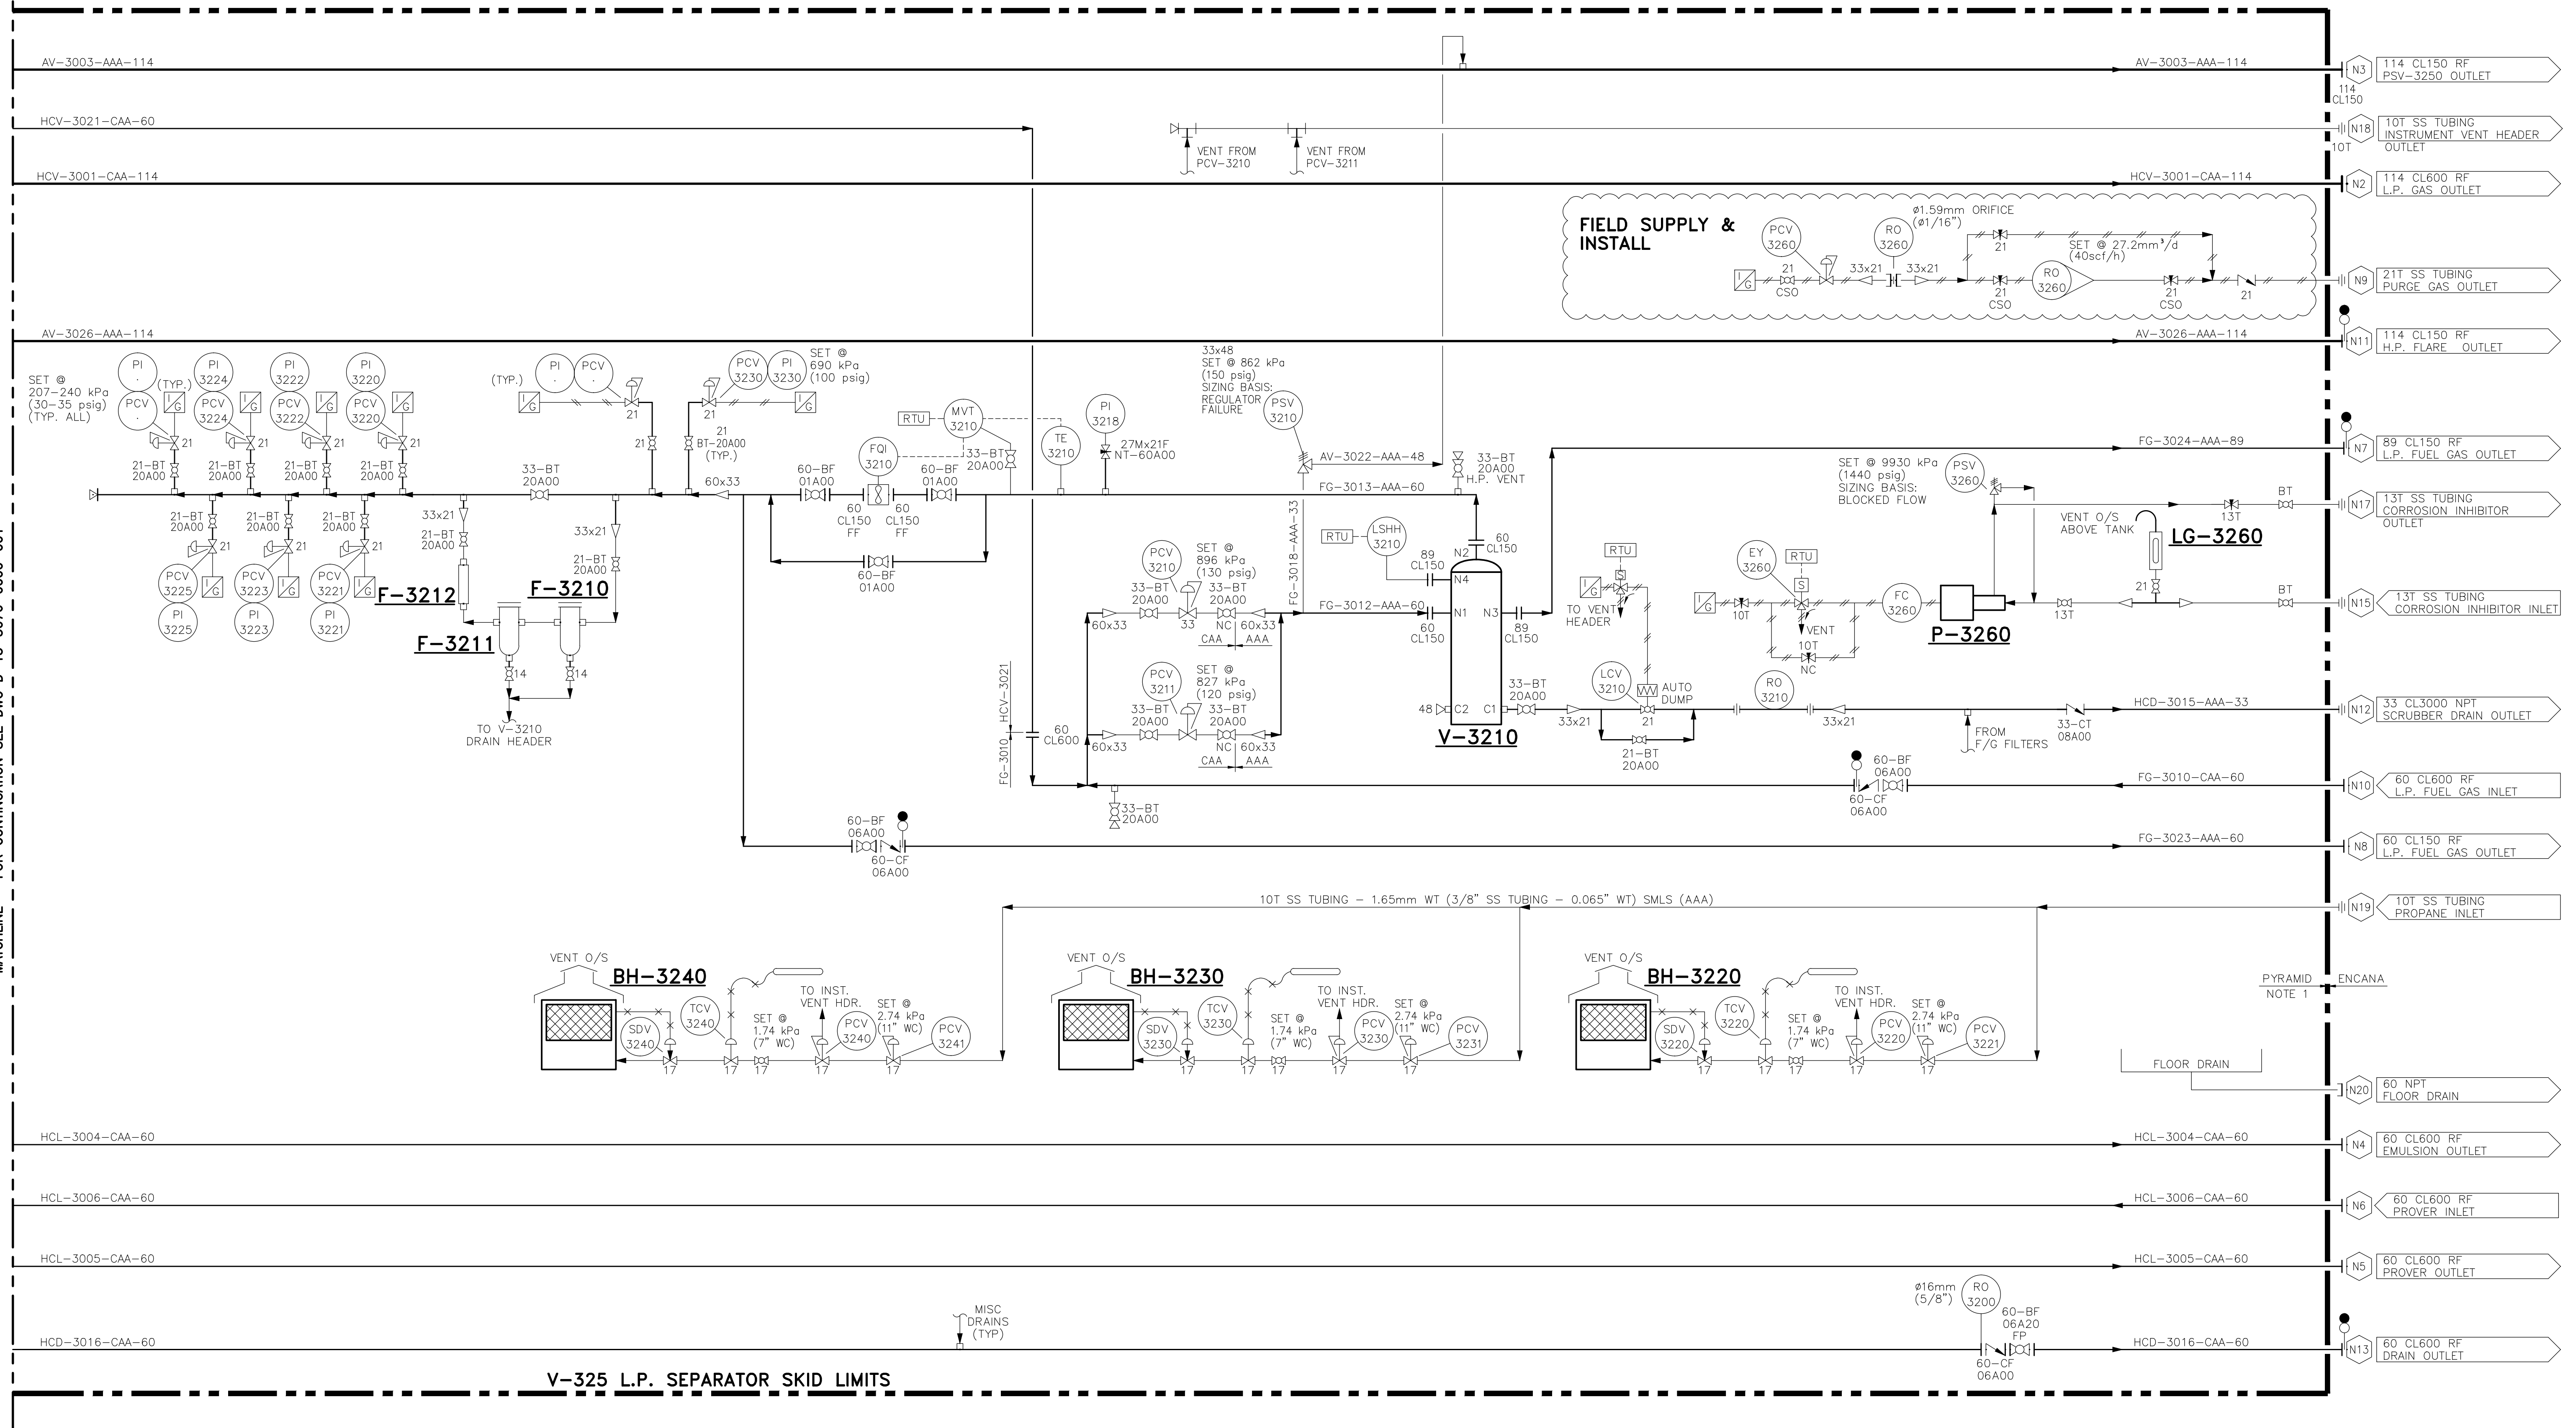


V-325 L.P. SEPARATOR SKID LIMITS

NOTES:

1. LOW TEMPERATURE MATERIAL PROVIDED UP TO ONE (1) METER INSIDE OR TO FIRST WELD INSIDE BLDG; WHICHEVER IS WORST CASE.
2. VENT TO BE ADEQUATELY SUPPORTED BY CONTRACTOR IN FIELD.

REV.	BY	CHECKED BY	PROJECT MGR.	DESCRIPTION	DATE
0	SF	CM	HW	ISSUED FOR CONSTRUCTION	04/11/13
A	SF	CM	HW	ISSUED FOR APPROVAL	01/10/13

DRAWING NO.	DESCRIPTION	REV.	BY	CHECKED BY	PROJECT MGR.	DESCRIPTION	DATE
REFERENCE DRAWINGS				REVISIONS			

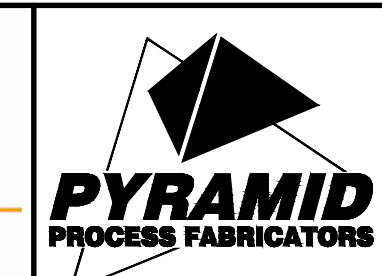

PYRAMID PROCESS FABRICATORS	
WIDJU - ALBERTA - CANADA / www.pyramidfabricators.com	
DRAWING TITLE:	RED ROCK DEVELOPMENT L.P. SEPARATOR P&ID
JOB NO.:	5076
CLIENT:	ENCANA c/o PRECISION ENGINEERING INC.
DATE:	12-12-063-08 W6M
SCALE:	NTS
REV. NO.:	0