


P-100
CHEMICAL PUMP
ARROW 500 1 1/4" [31.75mm] PLUNGER

P-101
METHANOL PUMP
ARROW 510 3/8" [13.7mm] PLUNGER

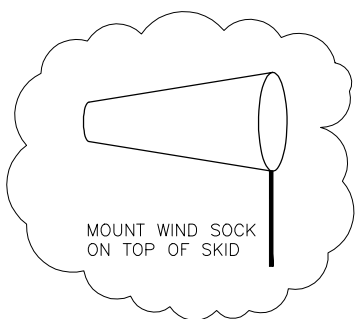


V-100
VERTICAL SWEETENING CONTACTOR
810mm O.D. x 6096mm S/S
DESIGN PRESSURE: 9929 KPAG (1440 PSIG)
D.T.: (38°C) 100°F
C.A. 3.2 mm, RADIOGRAPHY: FULL (RT-1)
MANUFACTURED BY PLATINUM ENERGY SERVICES LTD.

V-200
VERTICAL SEPARATOR
406.4mm O.D. x 2286mm S/S
DESIGN PRESSURE: 9929 KPAG (1440 PSIG)
D.T.: (54°C) 130°F
C.A. 3.2 mm, RADIOGRAPHY: SPOT (RT-2)
MANUFACTURED BY PLATINUM ENERGY SERVICES LTD.

V-300
FUEL GAS SCRUBBER
168.3mm O.D. x 914mm S/S
DESIGN PRESSURE: 1724 KPAG (250 PSIG)
MANUFACTURED BY LO-TECH

H-100
HEATER
[24x24] 609x609 BRUEST 12V HEATER
C/W CABLES, CLAMPS 912MAXITROL
100% SHUT OFF, GRILL AND HOOD

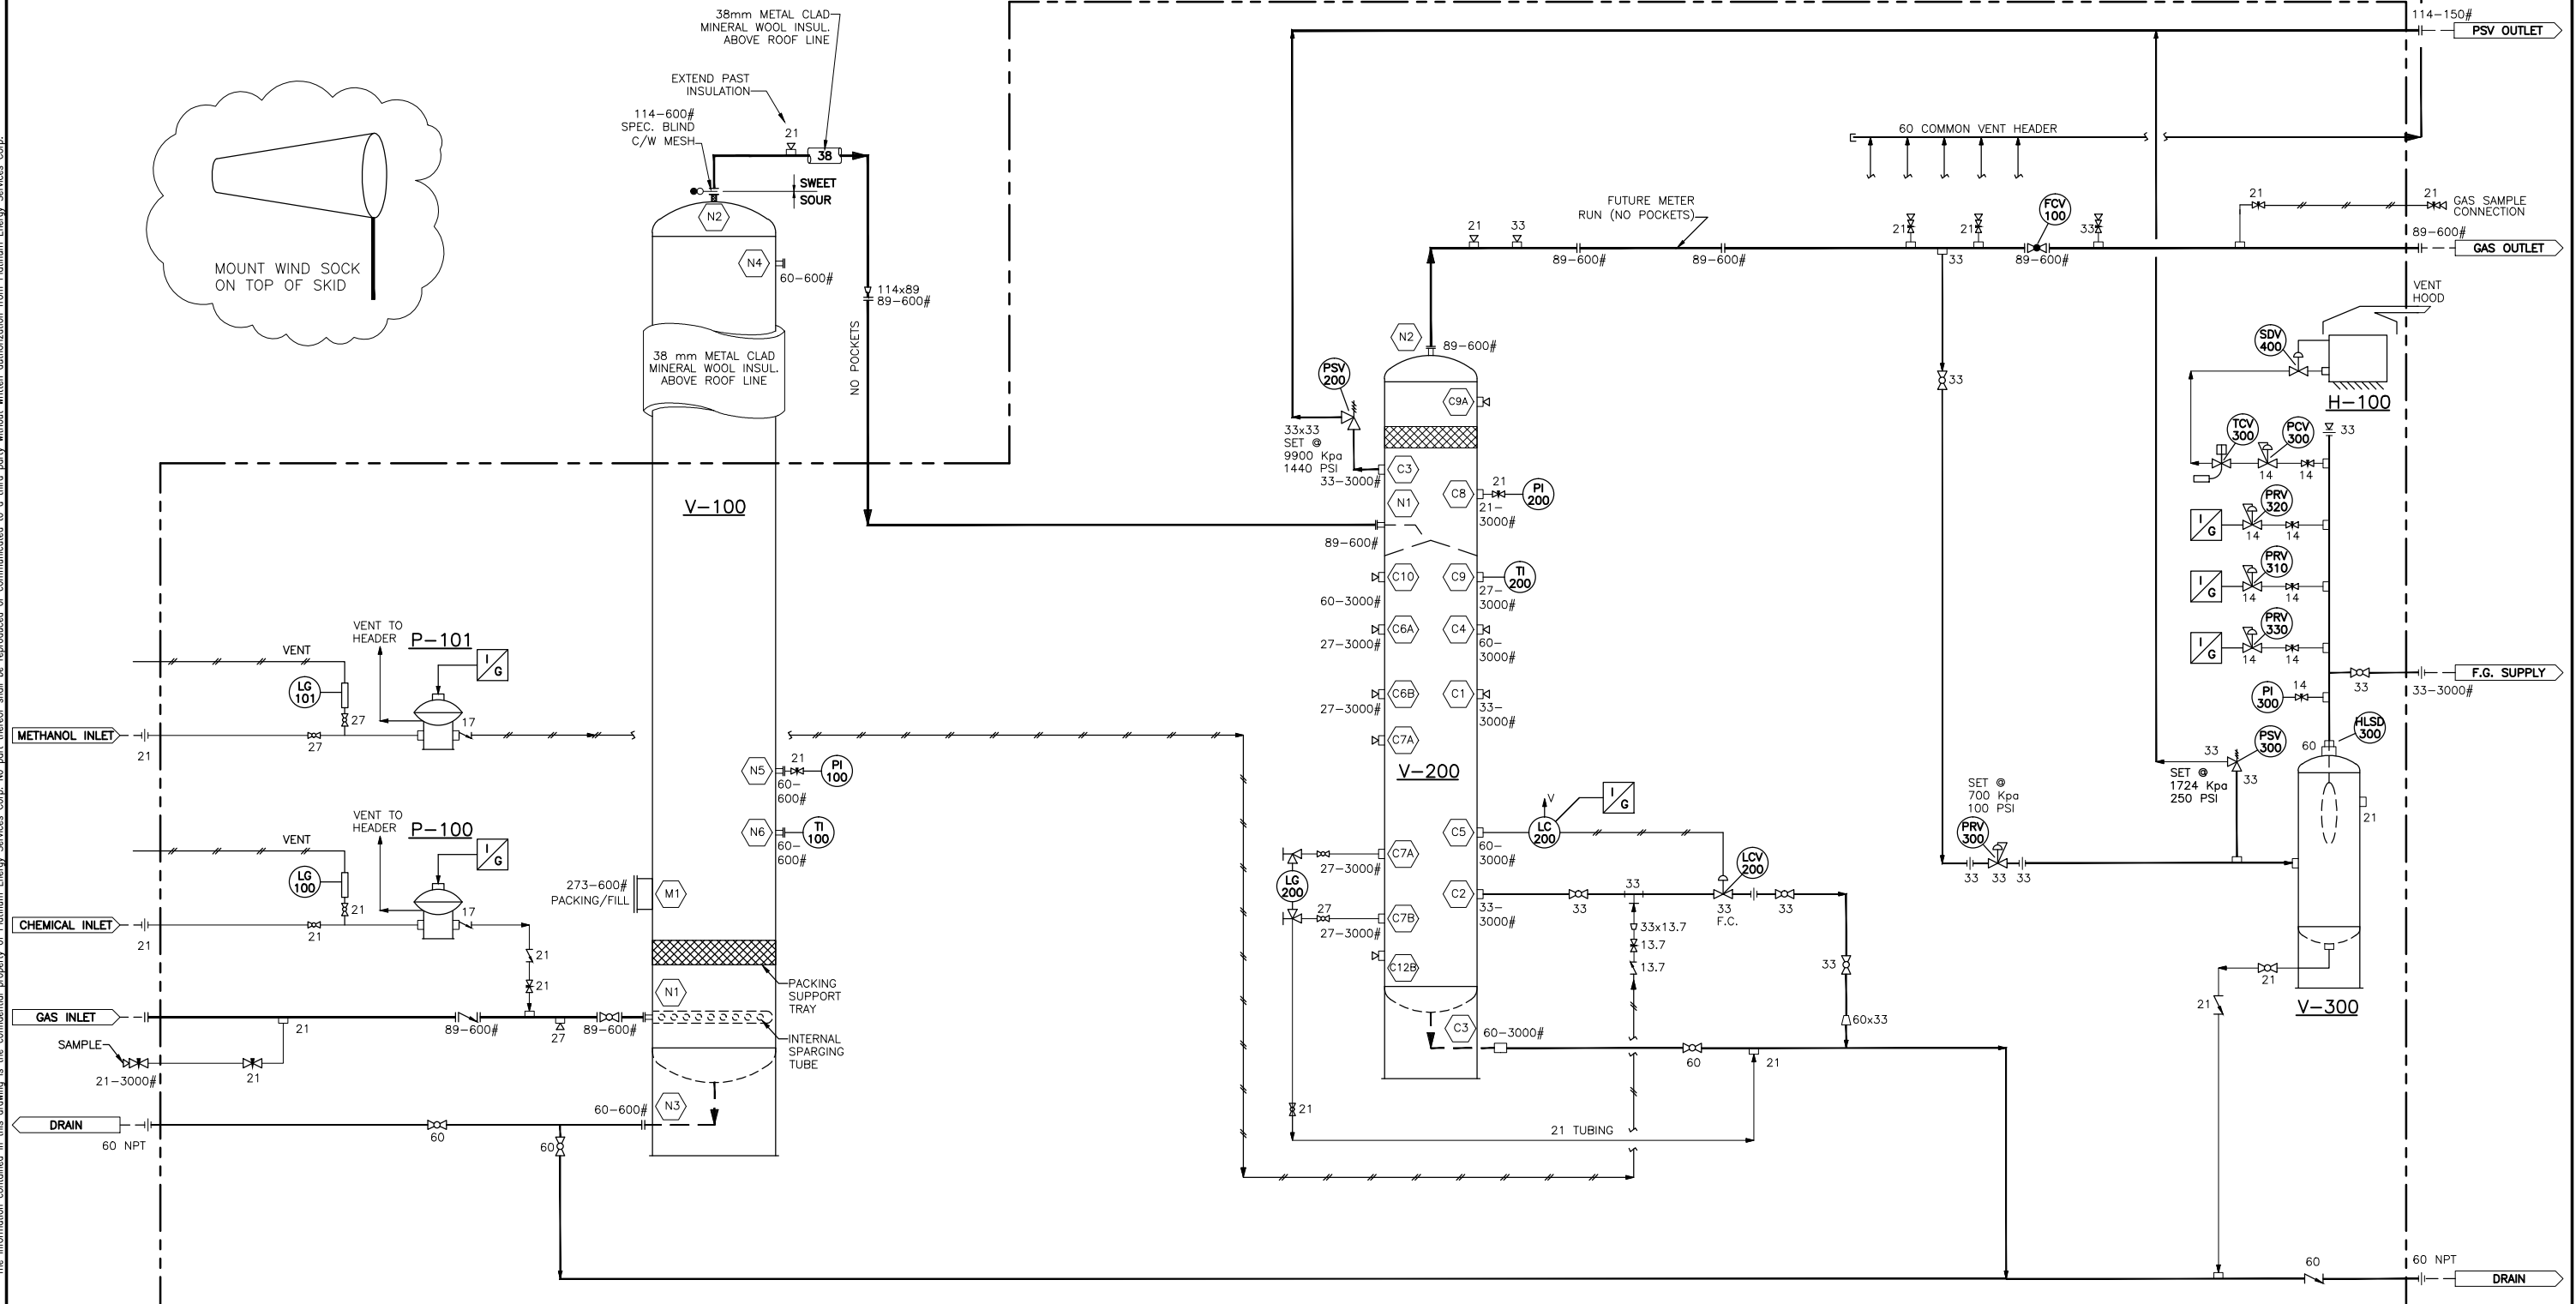

The information contained in this drawing is the confidential property of Platinum Energy Services Corp. No part thereof shall be reproduced or communicated to a third party without written authorization from Platinum Energy Services Corp.

PRINTED SEPT.21,2004

REFERENCE DWG. NO.	REFERENCE DWG. DESCRIPTION	REV.	REVISION DESCRIPTION	DATE	BY	CHK'D	APP'D	ENGINEER AND APPROVAL STAMPS			DESIGNED		DRAWN		CHECKED		APPROVED		STOCK		
D-STKSWEET-GA-01	PIPING PLAN										PLF	04-04-08	PLF	04-04-08					PIPING & INSTRUMENT DIAGRAM		
D-STKSWEET-GA-02	GENERAL ARRANGEMENT ELEVATIONS												JP						SEPARATOR / SWEETENING SKID		
D-STKSWEET-SKD-01	SKID PLAN VIEW	C	REVISED AS MARKED, ADDED WIND SOCK	04-09-21	WW	BS													L.S.D.: T.B.A.		
D-STKSWEET-SKD-02, 03	SKID ELEVATION VIEWS	B	REVISED AS MARKED ISSUED FOR REVIEW	04-09-13	WW	BS													JOB NO [J-110]		
		A	ISSUED FOR CONSTRUCTION		PLF	JP													SCALE NONE		
		A	ISSUED FOR APPROVAL		PLF	JP													D.W.G. NO. D-STKSWEET-PID-01		