
 
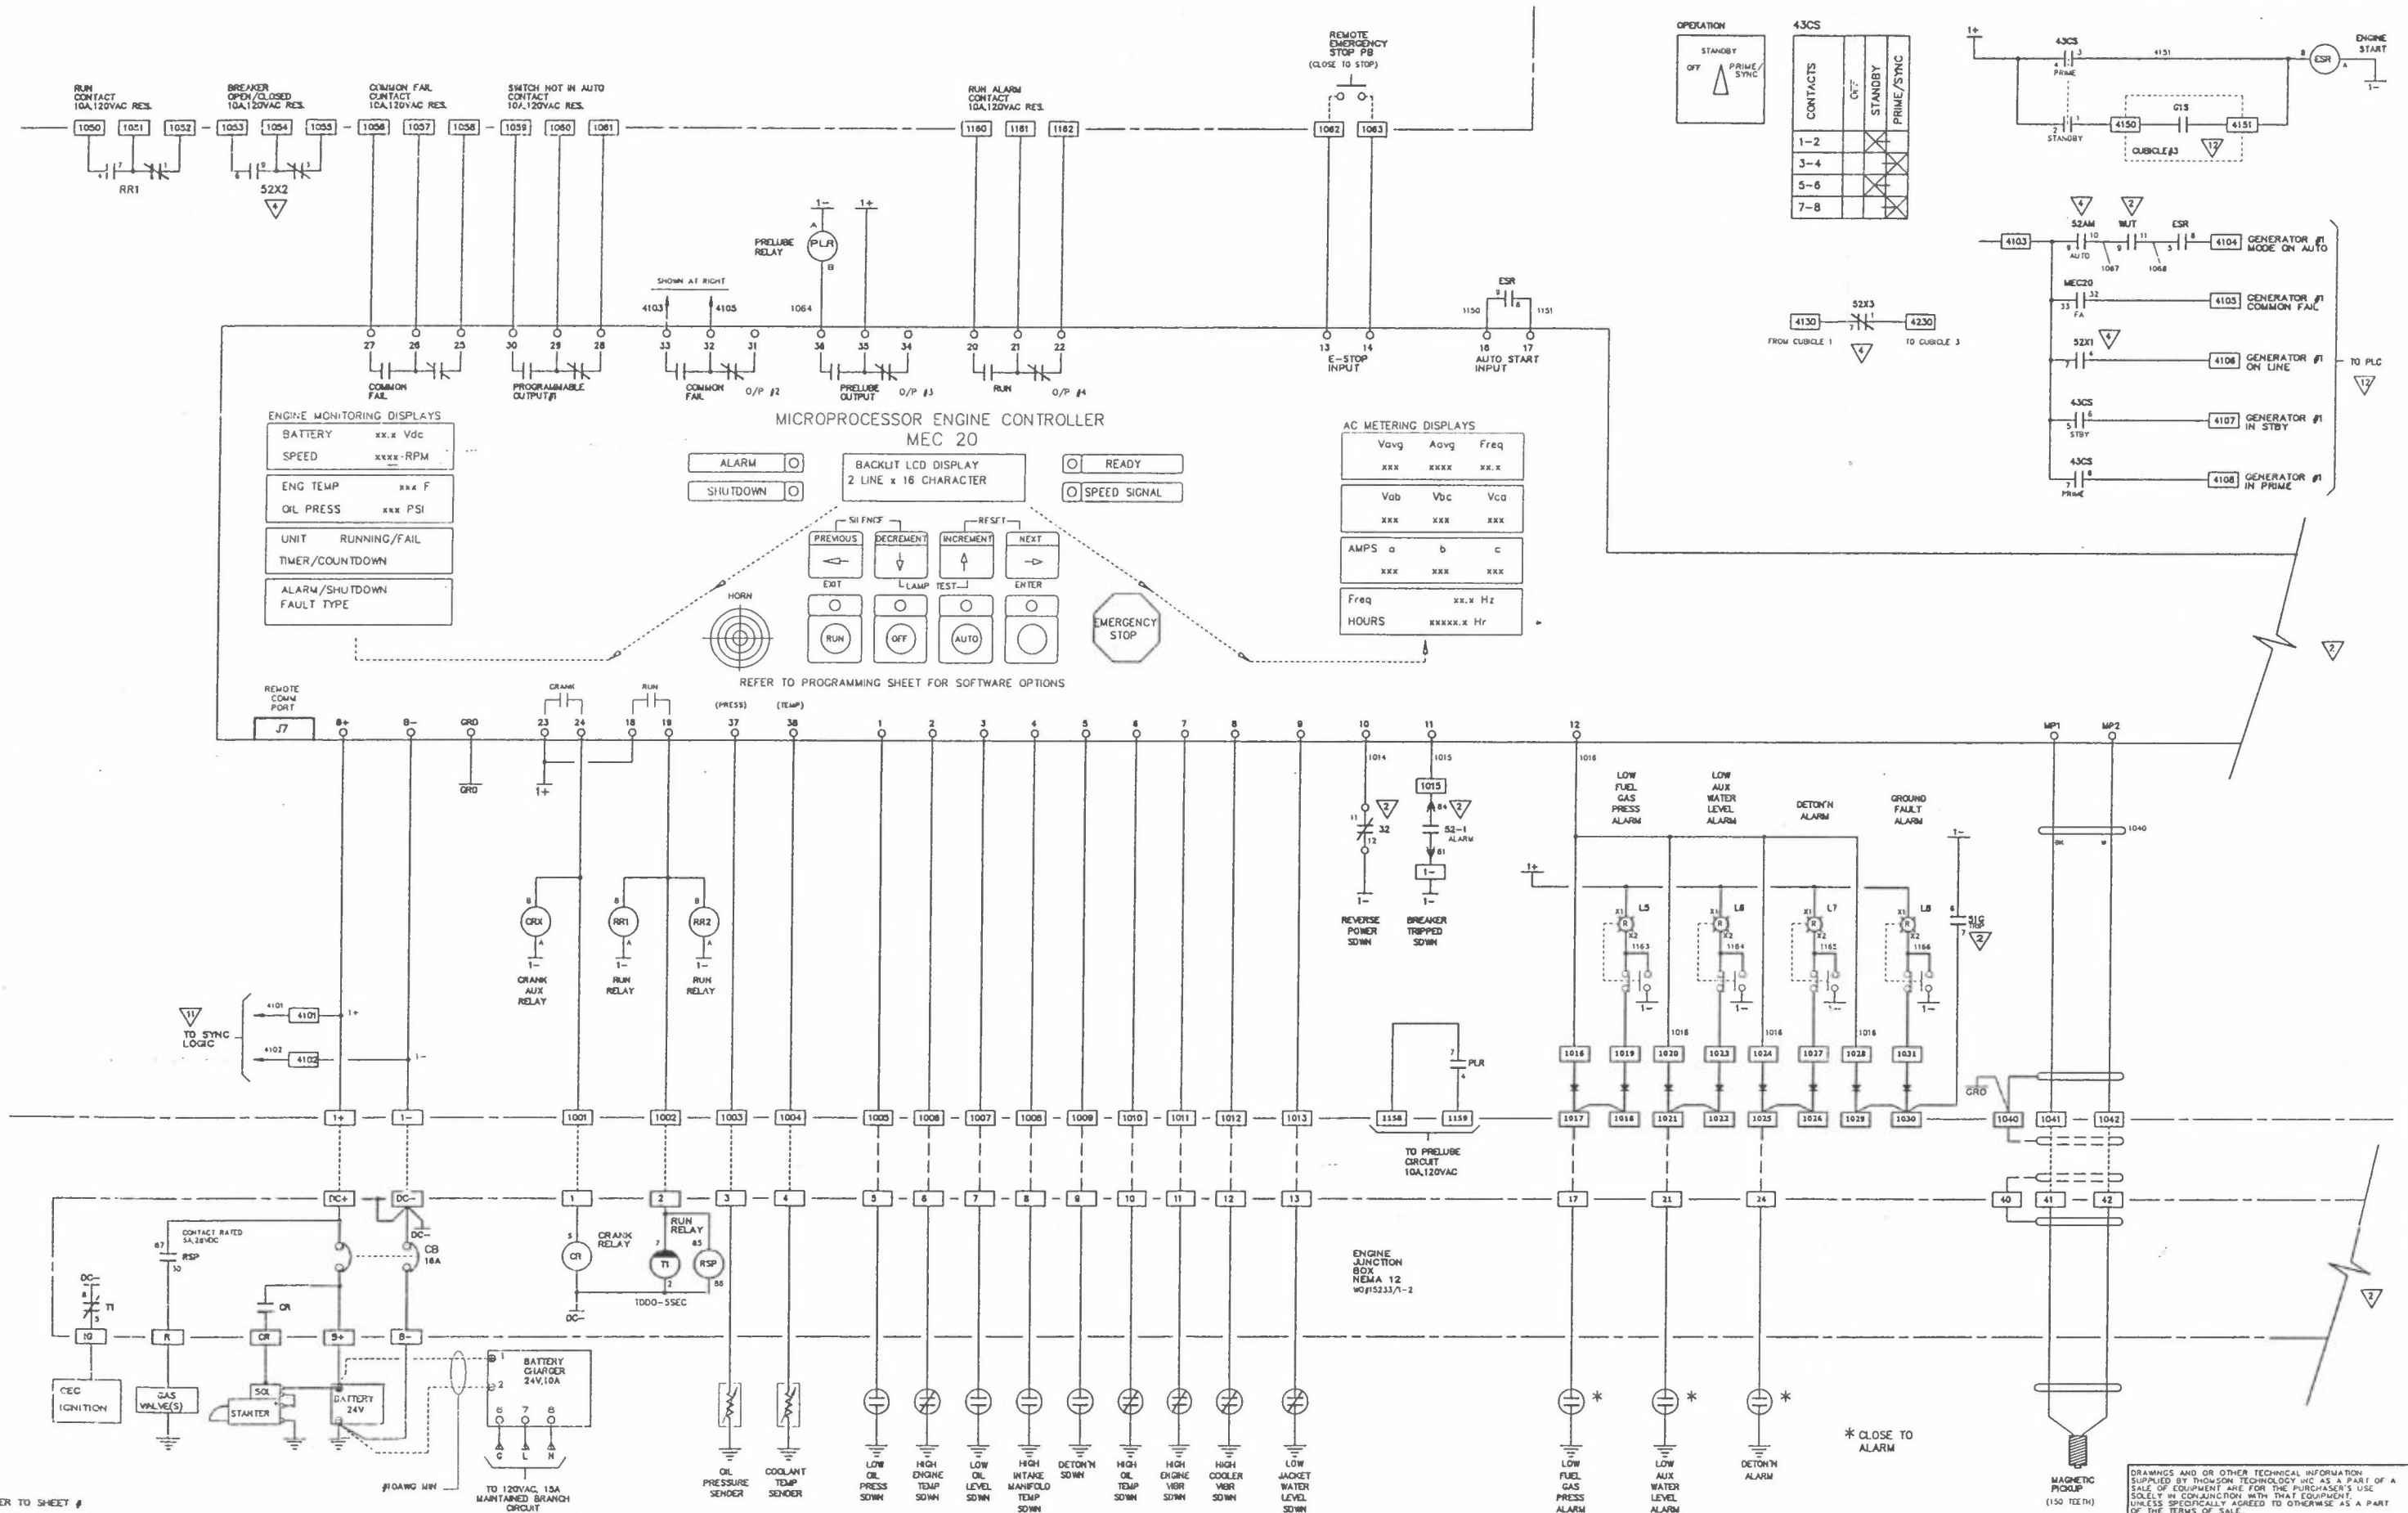



CONTACTS		OFF	PRIME/SYNC
1-2	3-4		
5-6	7-8		

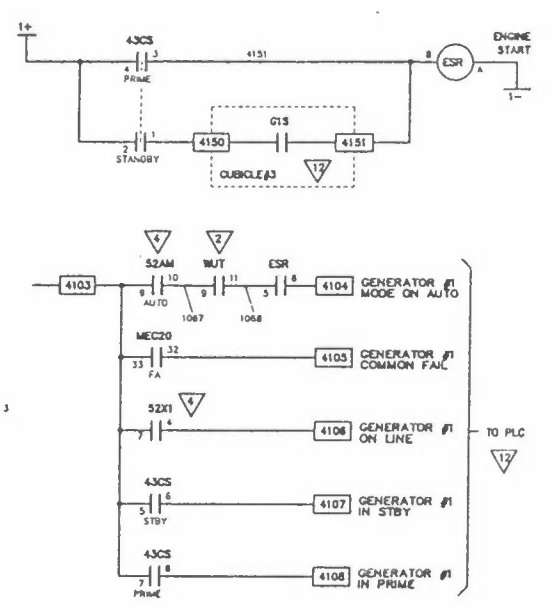

- ENGINE MONITORING DISPLAYS
- BATTERY xx.x Vdc
 - SPEED xxx.x RPM
 - ENG TEMP xxx F
 - OIL PRESS xxx PSI
 - UNIT RUNNING/FAIL
 - TIMER/COUNTDOWN
 - ALARM/SHUTDOWN FAULT TYPE

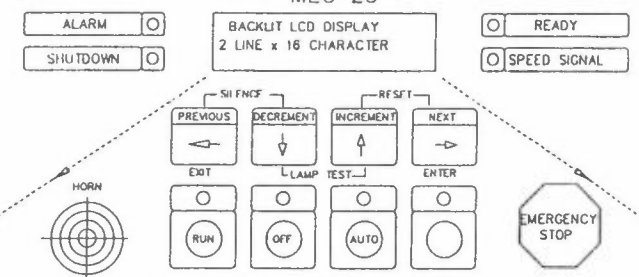

- AC METERING DISPLAYS
- | | | |
|------|------|------|
| Vavg | Aavg | Freq |
| xxx | xxx | xx.x |
- | | | |
|-----|-----|-----|
| Vab | Vbc | Vca |
| xxx | xxx | xxx |
- | | | |
|--------|-----|-----|
| AMPS a | b | c |
| xxx | xxx | xxx |
- | | |
|-------|----------|
| Freq | xx.x Hz |
| HOURS | xxxxx Hr |

APPROVED FOR CONSTRUCTION

MASTER COPY REFERENCE COPY OF

MULTIPLE UNIT WORK ORDER

RELEASED FOR INFORMATION



AUTH. BY: DATE:

DRAWING No.	REFERENCE DRAWINGS	REVISIONS	BY	DATE
1	AS BUILT		RR	01-07-13



GENERATOR CONTROL SYSTEM
MODEL GCS2200
GEN #1 DC SCHEMATIC
ANDERSON RYCROFT PROJECT

CUSTOMER			
ENERFLEX POWER SYSTEMS			
DRAWN BY	AUTH BY	DATE	REV
RR	BD	01-05-17	1
DRAWING No.			SHEET
ELB15233_01_01_03			3

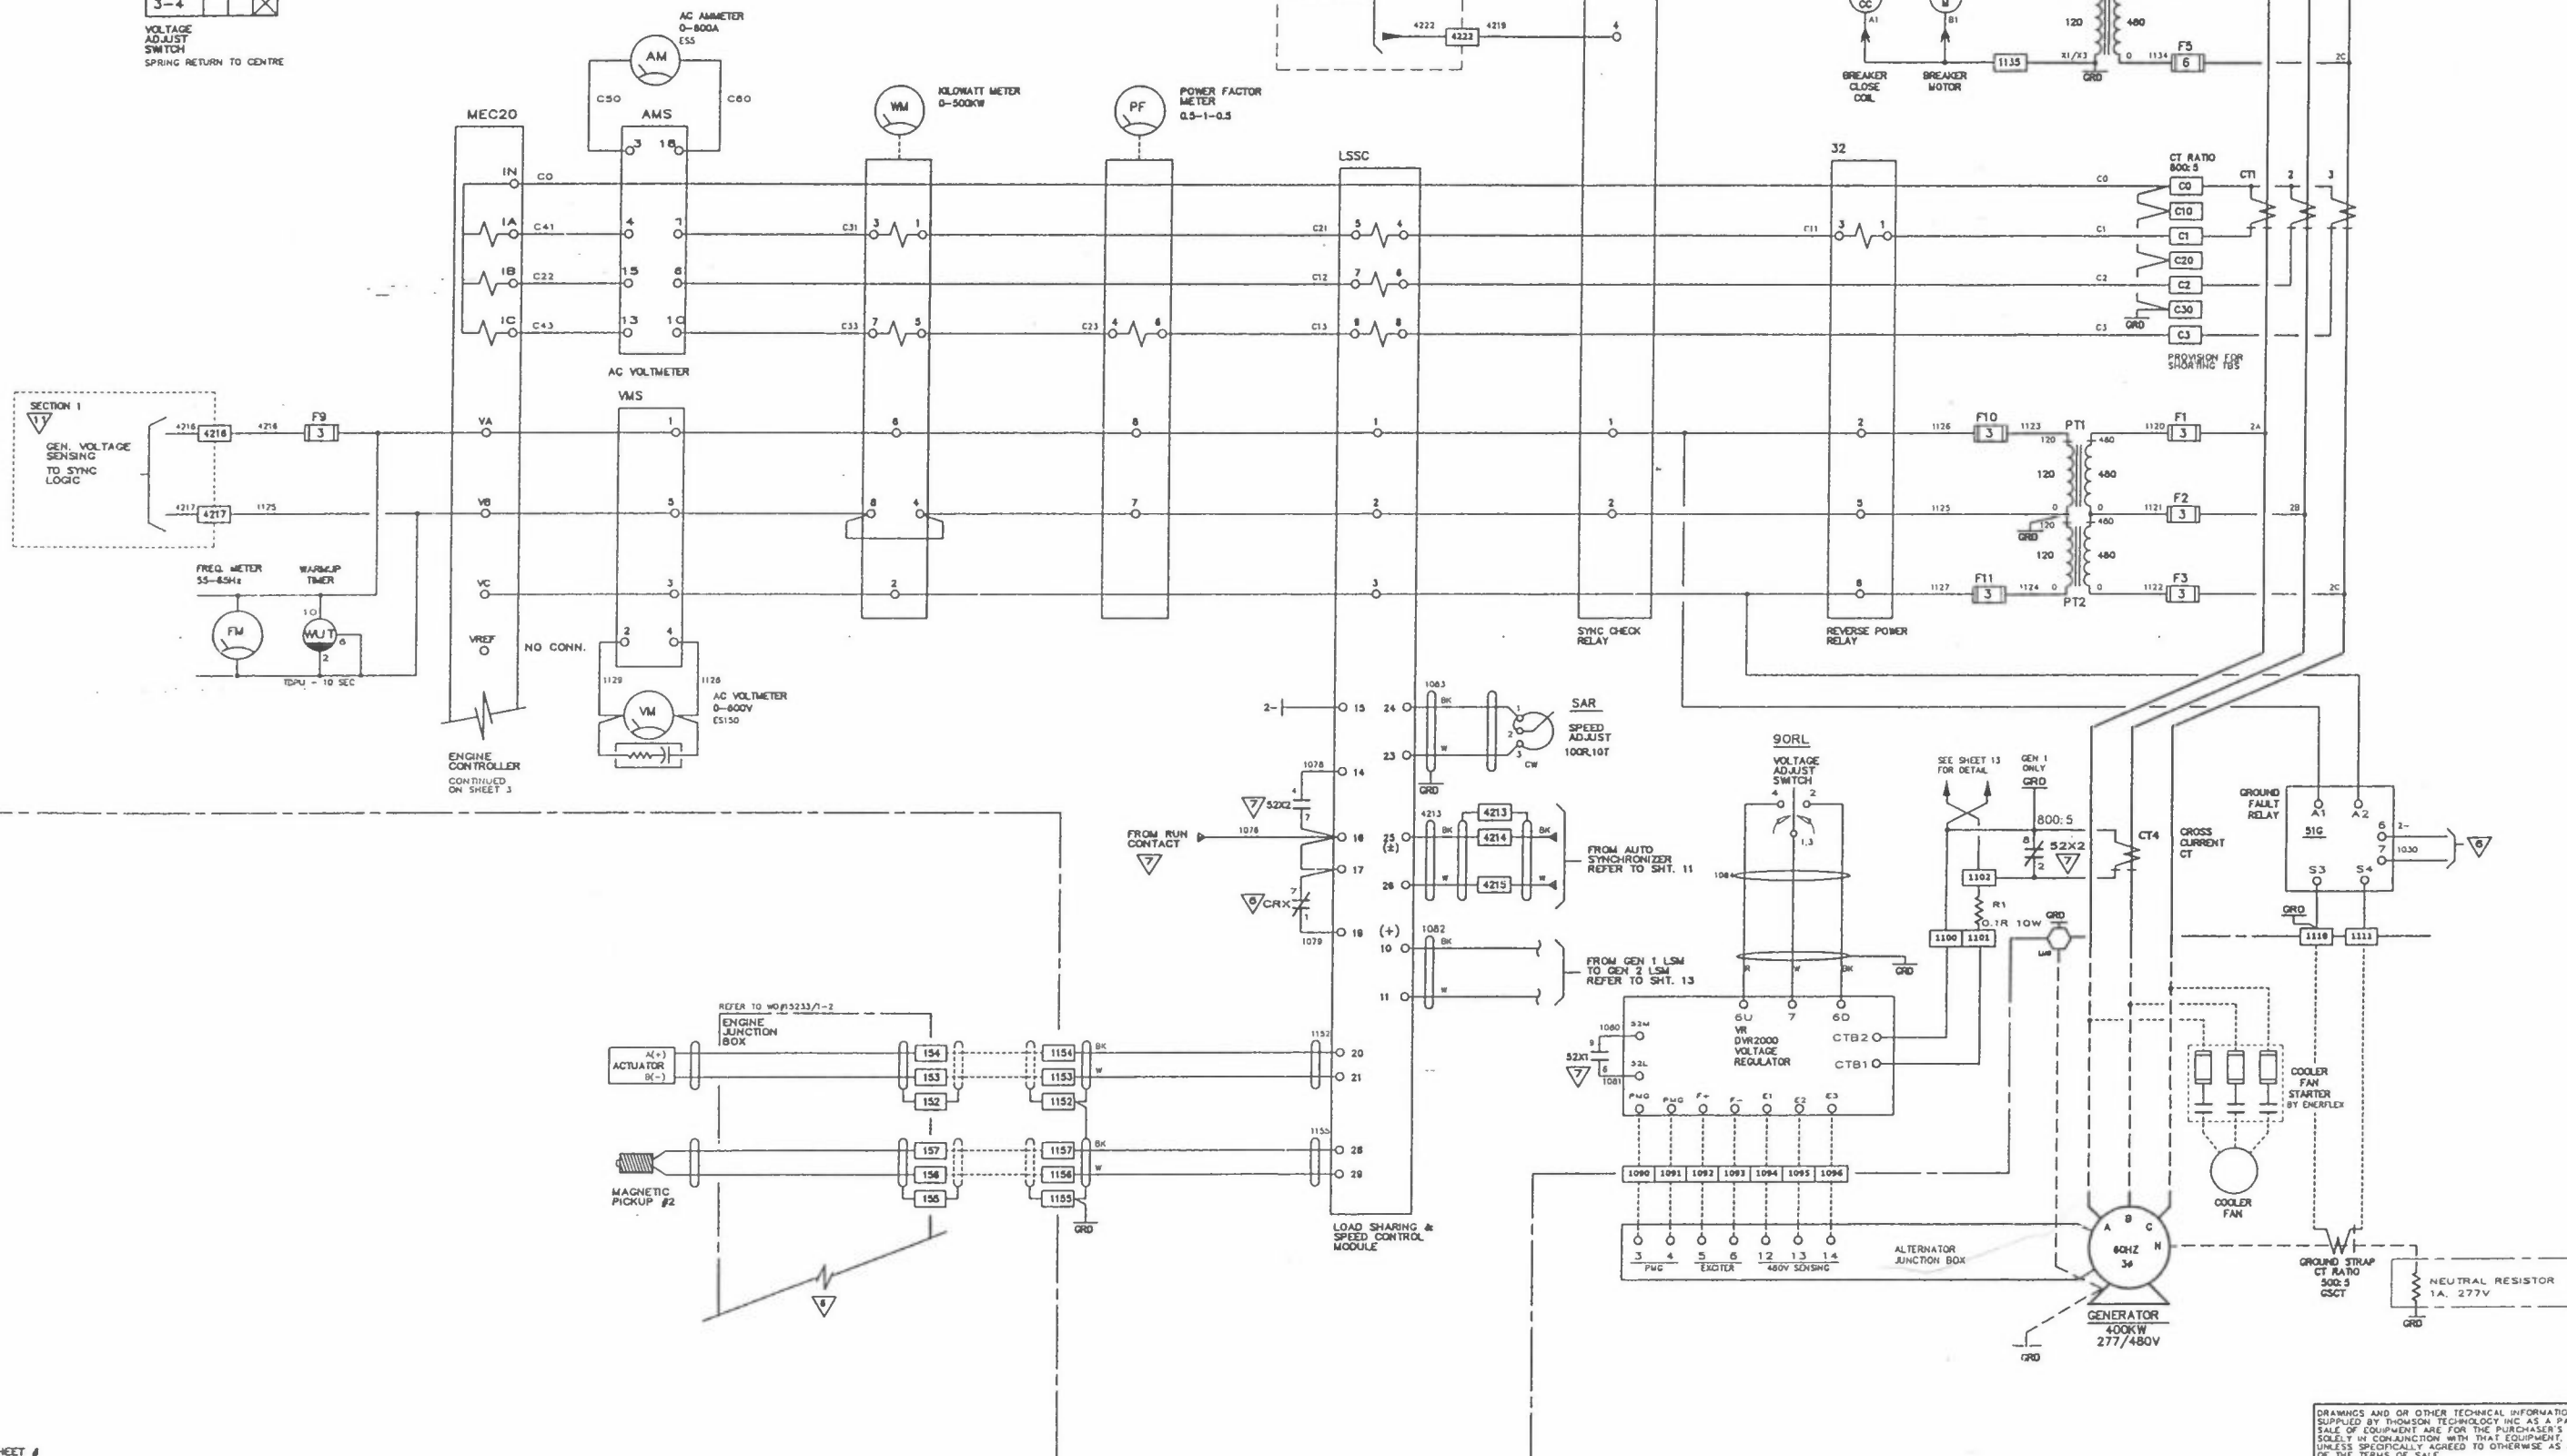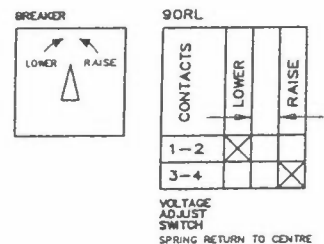

REFER TO SHEET 0

☐ APPROVED FOR CONSTRUCTION
☐ MASTER COPY ☐ REFERENCE COPY ☐ OF
☐ MULTIPLE UNIT WORK ORDER
☐ RELEASED FOR INFORMATION
AUTH. BY: _____ DATE: _____

DRAWING No.

REFERENCE DRAWINGS

No.

REVISIONS

BY

AUTH


DATE


THOMSON TECHNOLOGY
POWER & CONTROL

GENERATOR CONTROL SYSTEM
MODEL GCS2200
GEN #2 AC SCHEMATIC
ANDERSON RYCROFT PROJECT

DRAWINGS AND/OR OTHER TECHNICAL INFORMATION
SUPPLIED BY THOMSON TECHNOLOGY INC. AS A PART OF A
SALE OF EQUIPMENT ARE FOR THE PURCHASER'S USE
SOLELY IN CONNECTION WITH THAT EQUIPMENT.
UNLESS SPECIFICALLY AGREED TO OTHERWISE AS A PART
OF THE TERMS OF SALE.


CUSTOMER
ENERFLEX POWER SYSTEMS
DRAWN BY: RR AUTH BY: BD DATE: 01-05-17 REV: 1
DRAWING No.: ELB15233_01_01_05 SHEET: 5

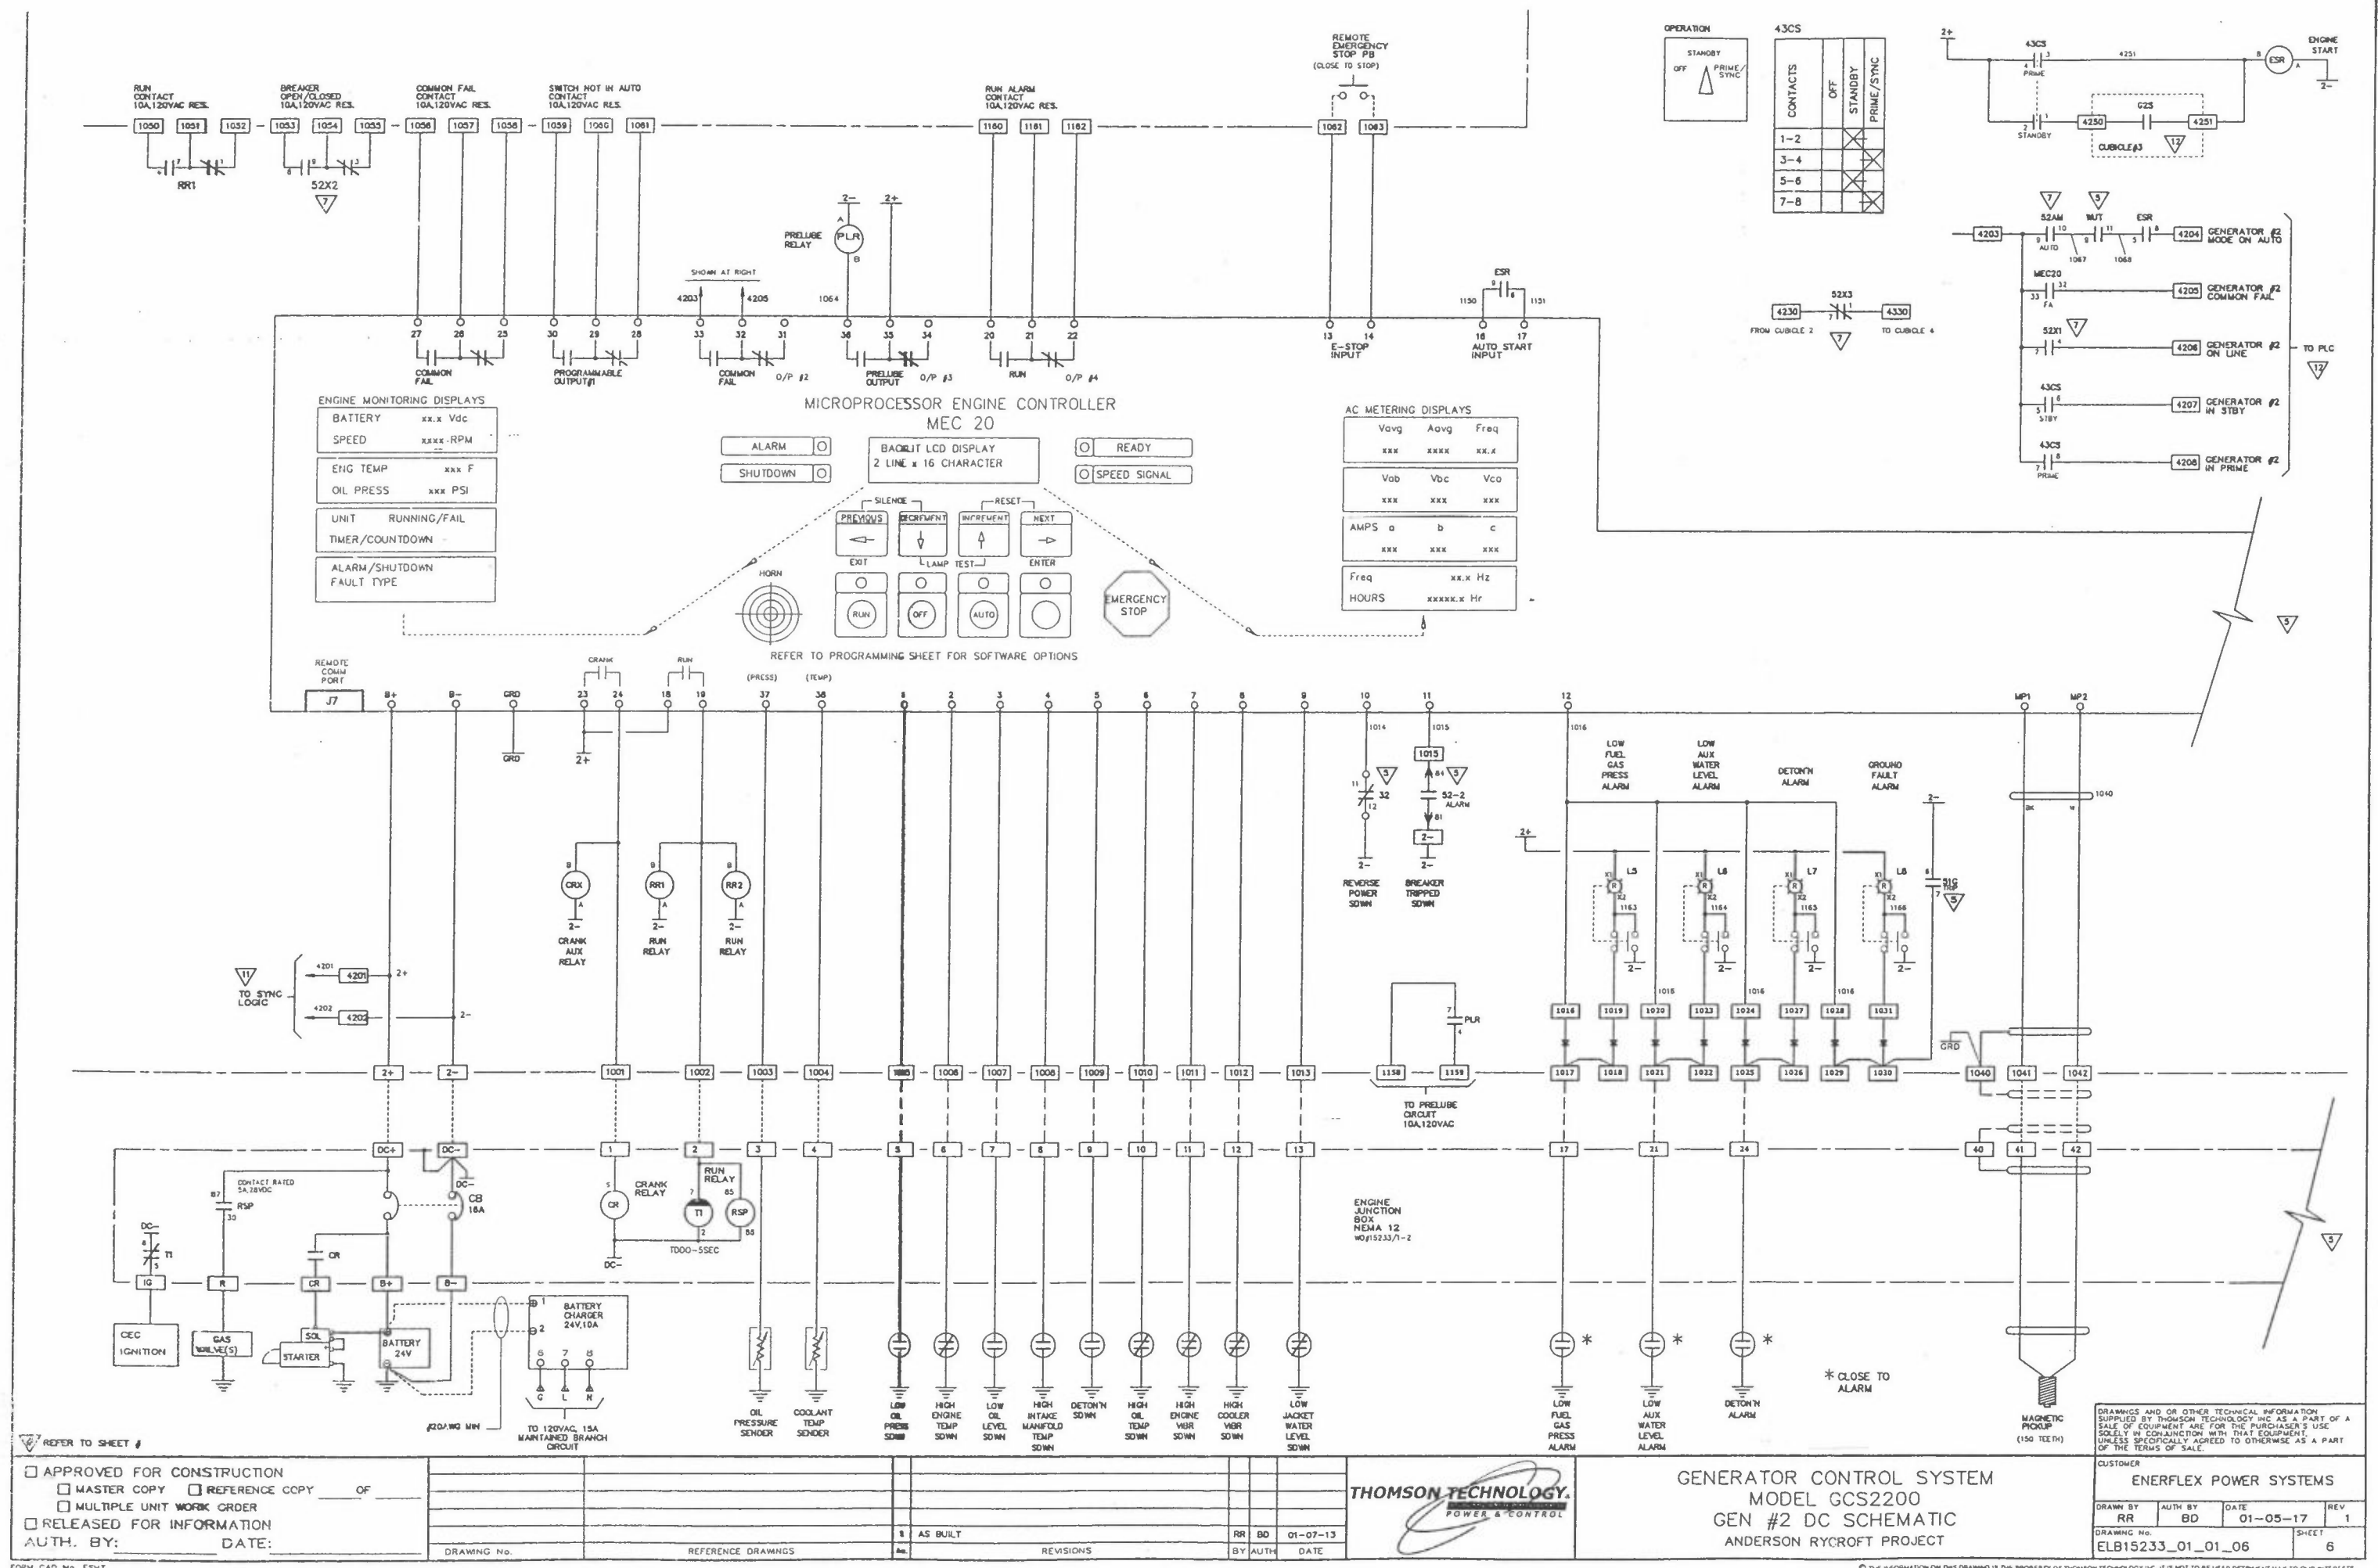


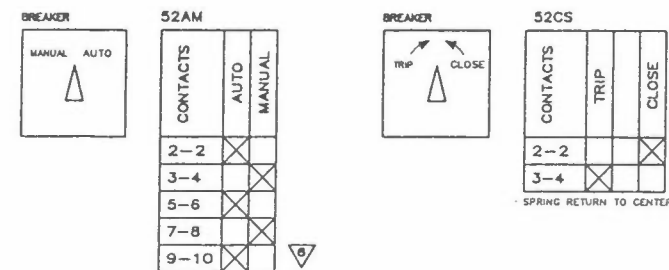



DRAWINGS AND OR OTHER TECHNICAL INFORMATION SUPPLIED BY THOMSON TECHNOLOGY INC AS A PART OF A SALE OF EQUIPMENT ARE FOR THE PURCHASER'S USE SOLELY IN CONJUNCTION WITH THAT EQUIPMENT UNLESS SPECIFICALLY AGREED TO OTHERWISE AS A PART OF THE TERMS OF SALE				
CUSTOMER				
ENERFLEX POWER SYSTEMS				
DRAWN BY	AUTH BY	DATE	REV	
RR	BD	01-05-17	1	
DRAWING No			Sheet	
E1815233 01 01 08			8	

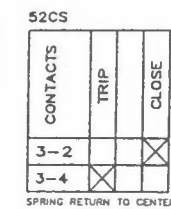

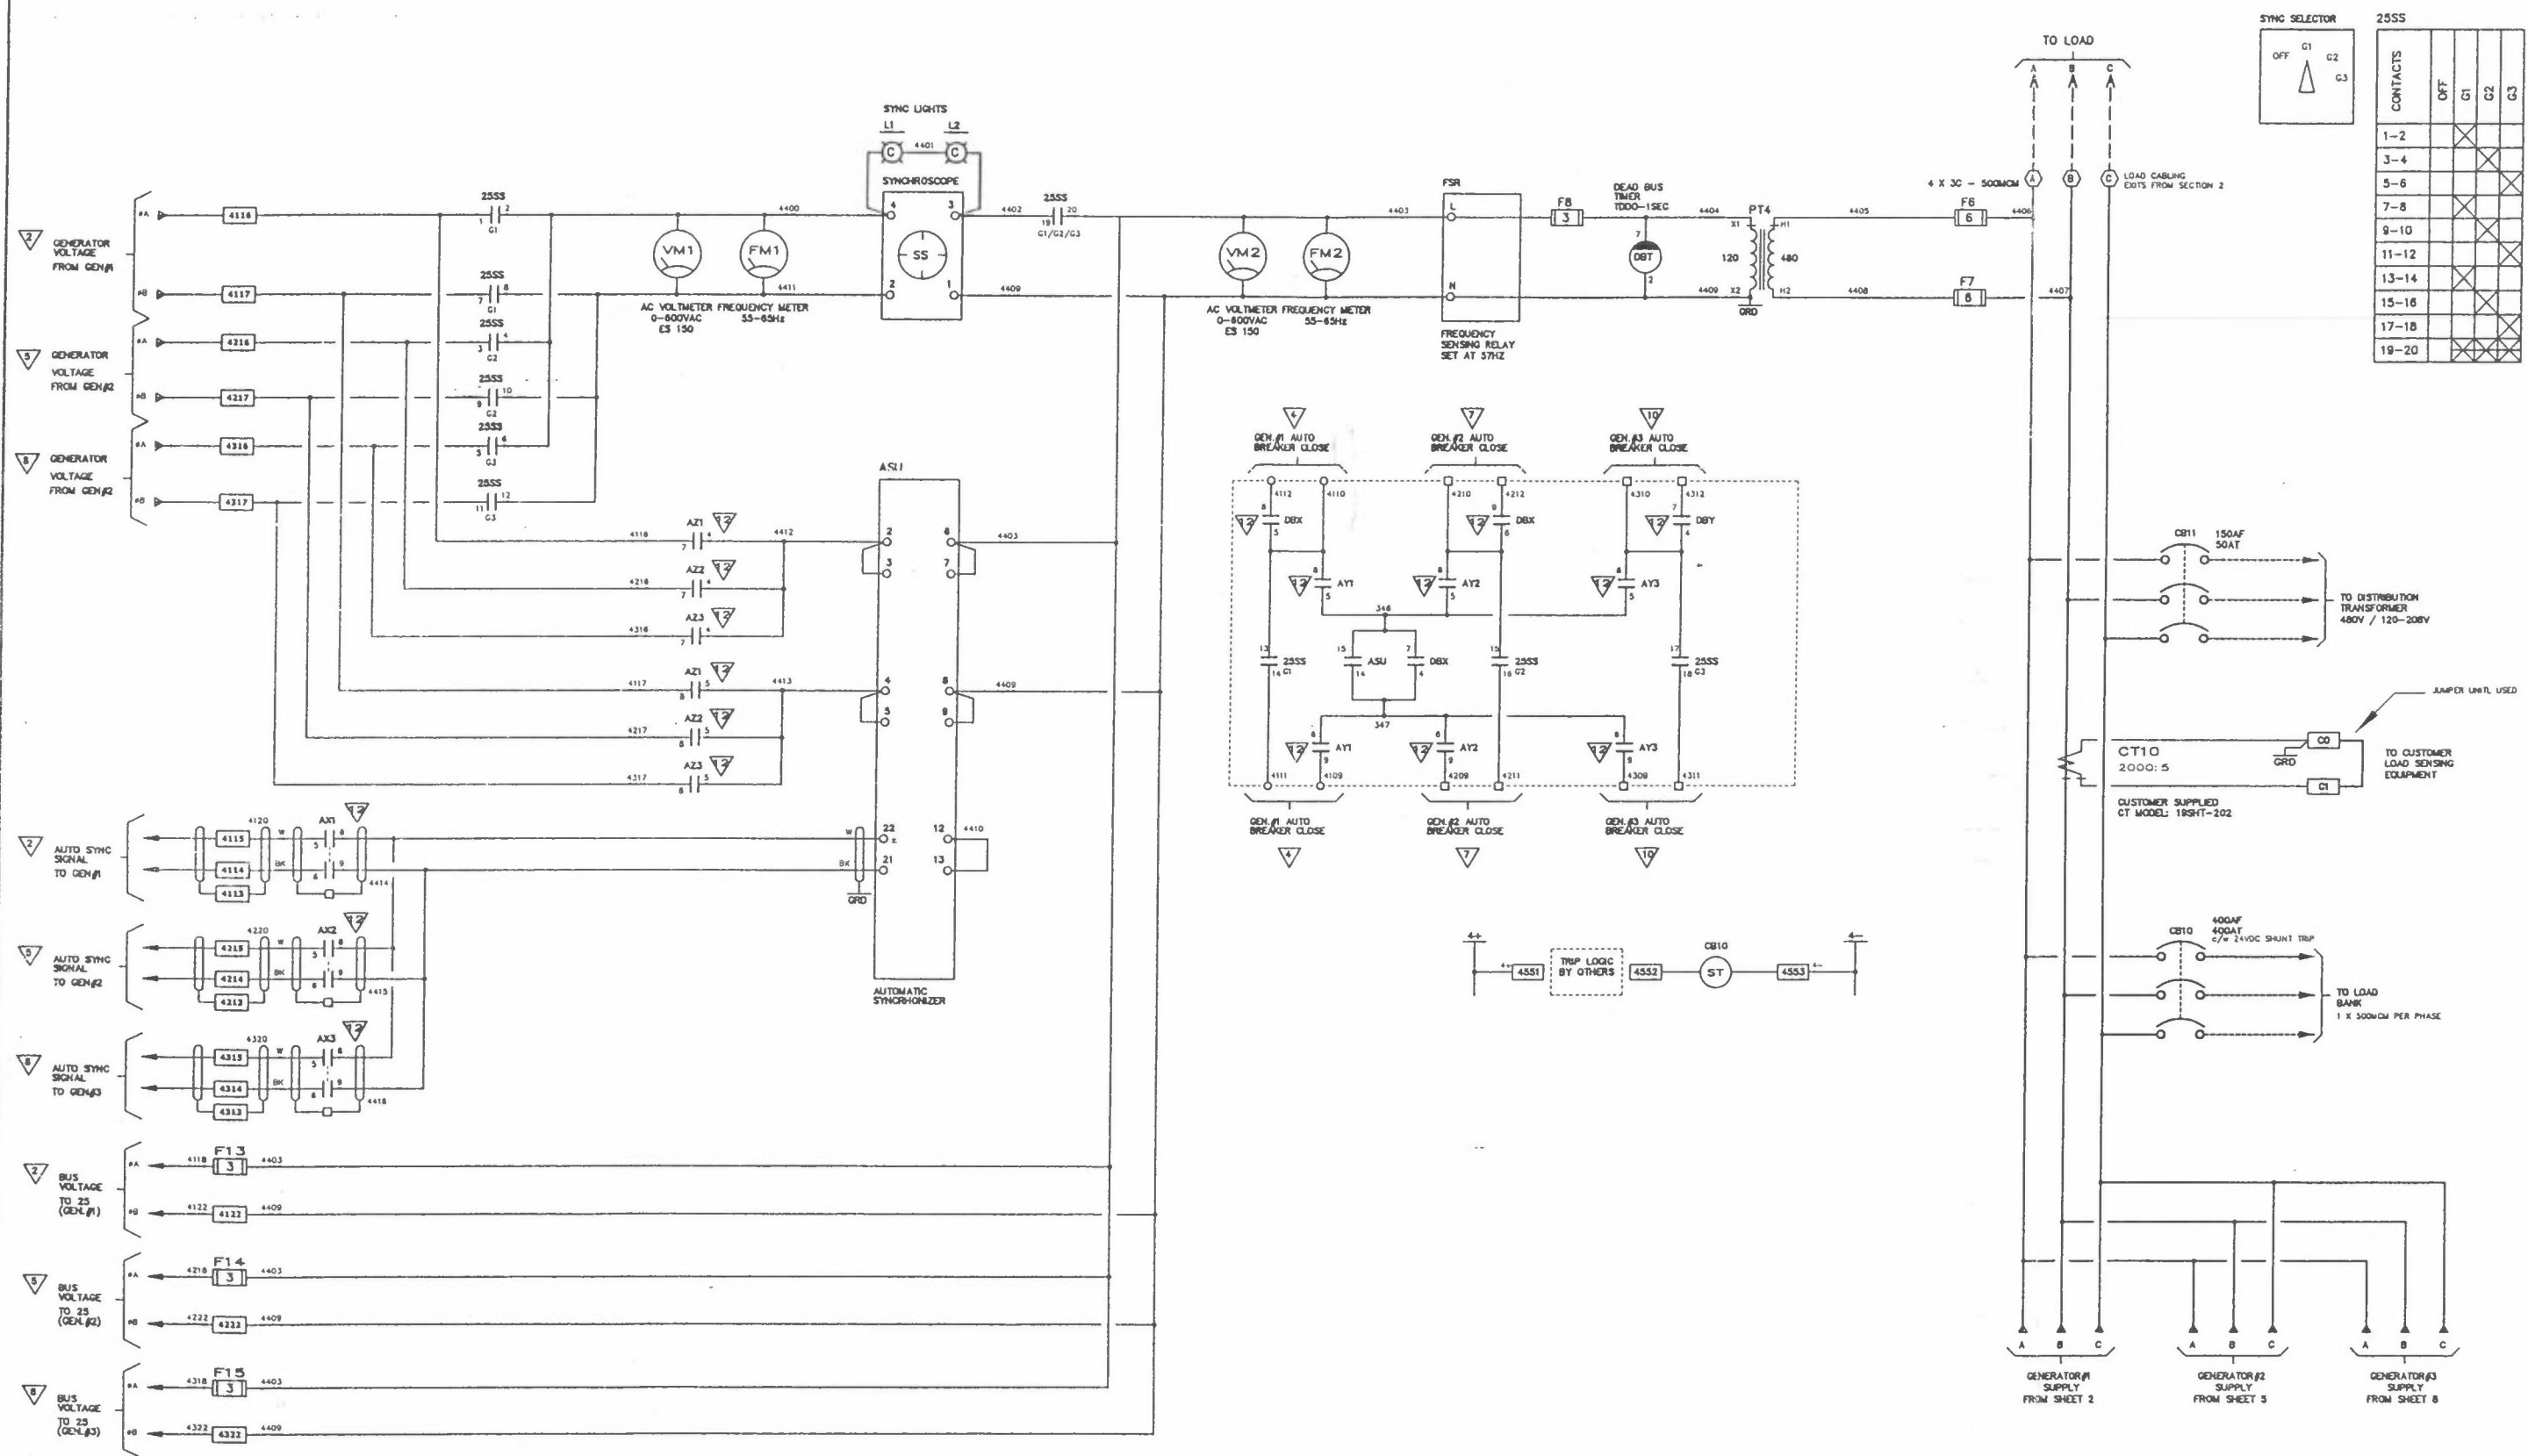

SYNC SELECTOR

OFF G1 G2 G3

CONTACTS

CONTACTS	OFF	G1	G2	G3
1-2				
3-4				
5-6				
7-8				
9-10				
11-12				
13-14				
15-16				
17-18				
19-20				

REFER TO SHEET #

☐ APPROVED FOR CONSTRUCTION

☐ MASTER COPY ☐ REFERENCE COPY OF

☐ MULTIPLE UNIT WORK ORDER

☐ RELEASED FOR INFORMATION

AUTH. BY: DATE:

DRAWING No.	REFERENCE DRAWINGS	No	AS BUILT	RR	BO	01-07-13
REVISIONS		BY	DATE			






GENERATOR CONTROL SYSTEM
MODEL GCS2200
SYNC SCHEMATIC
ANDERSON RYCROFT PROJECT

DRAWINGS AND/OR OTHER TECHNICAL INFORMATION
SUPPLIED BY THOMSON TECHNOLOGY INC. AS A PART OF A
SALE OF EQUIPMENT ARE FOR THE PURCHASER'S USE
SOLELY IN CONJUNCTION WITH THAT EQUIPMENT
UNLESS SPECIFICALLY AGREED TO OTHERWISE AS A PART
OF THE TERMS OF SALE.

CUSTOMER

ENERFLEX POWER SYSTEMS

DRAWN BY	RR	AUTH BY	BD	DATE	01-05-17	REV	1
DRAWING No.	ELB15233_01_01_11	SHEET	11				

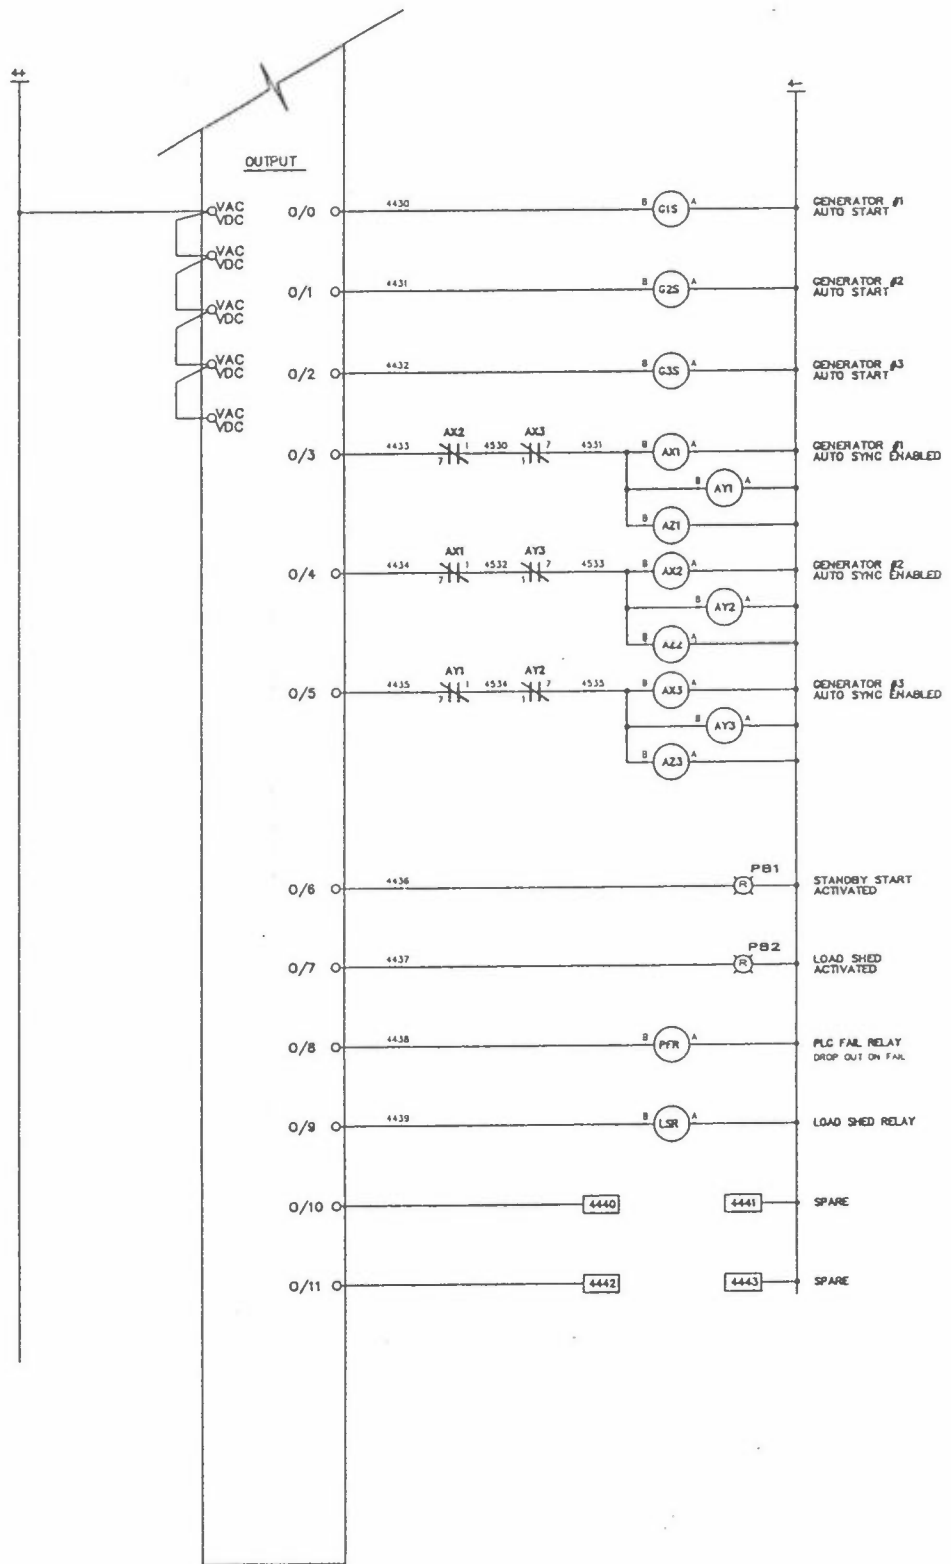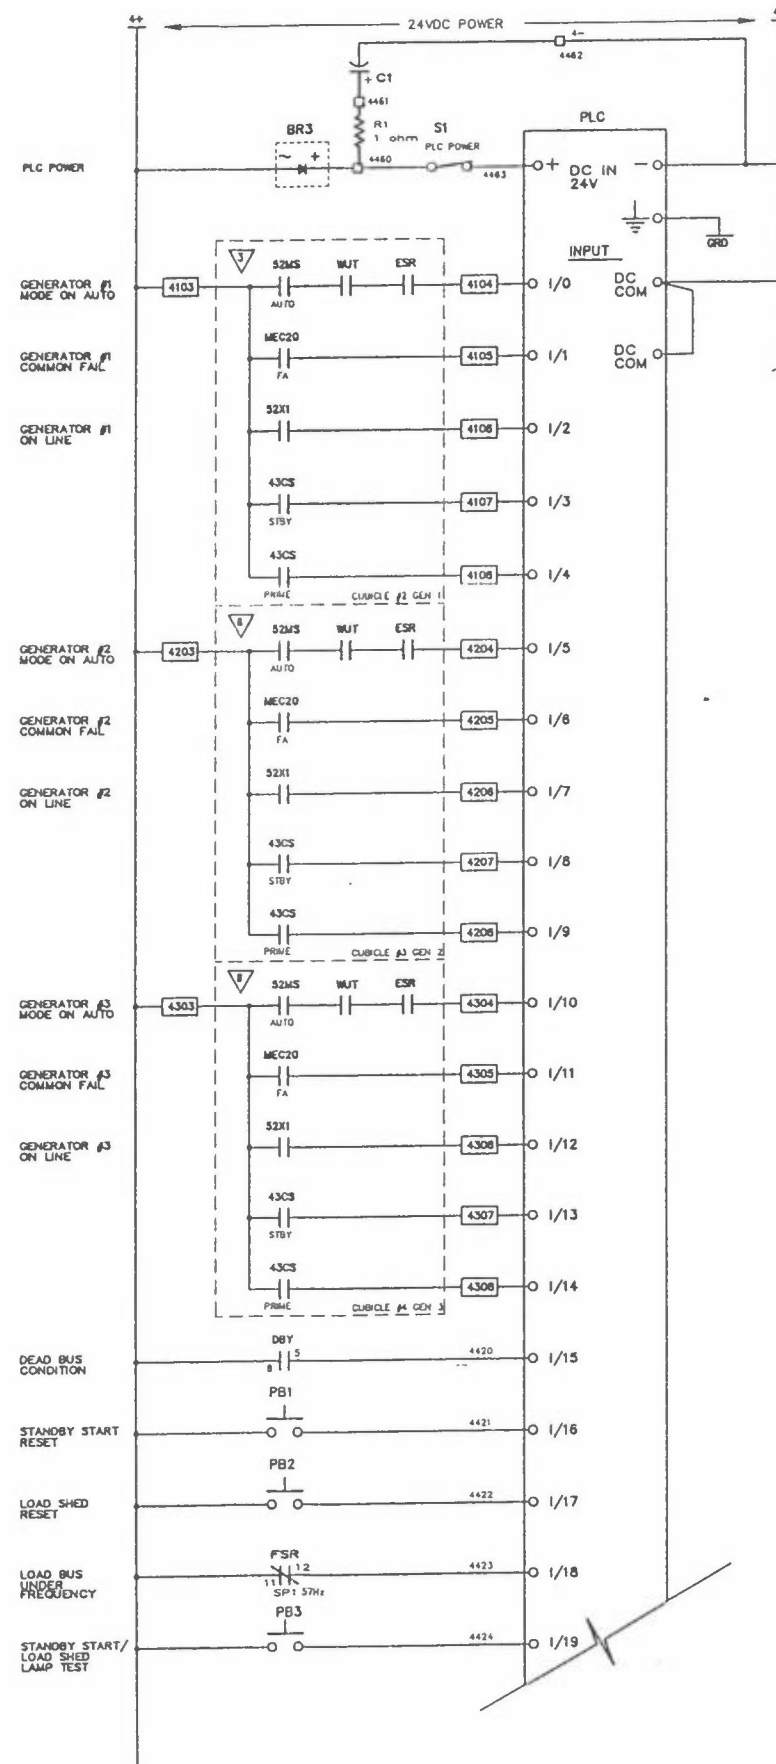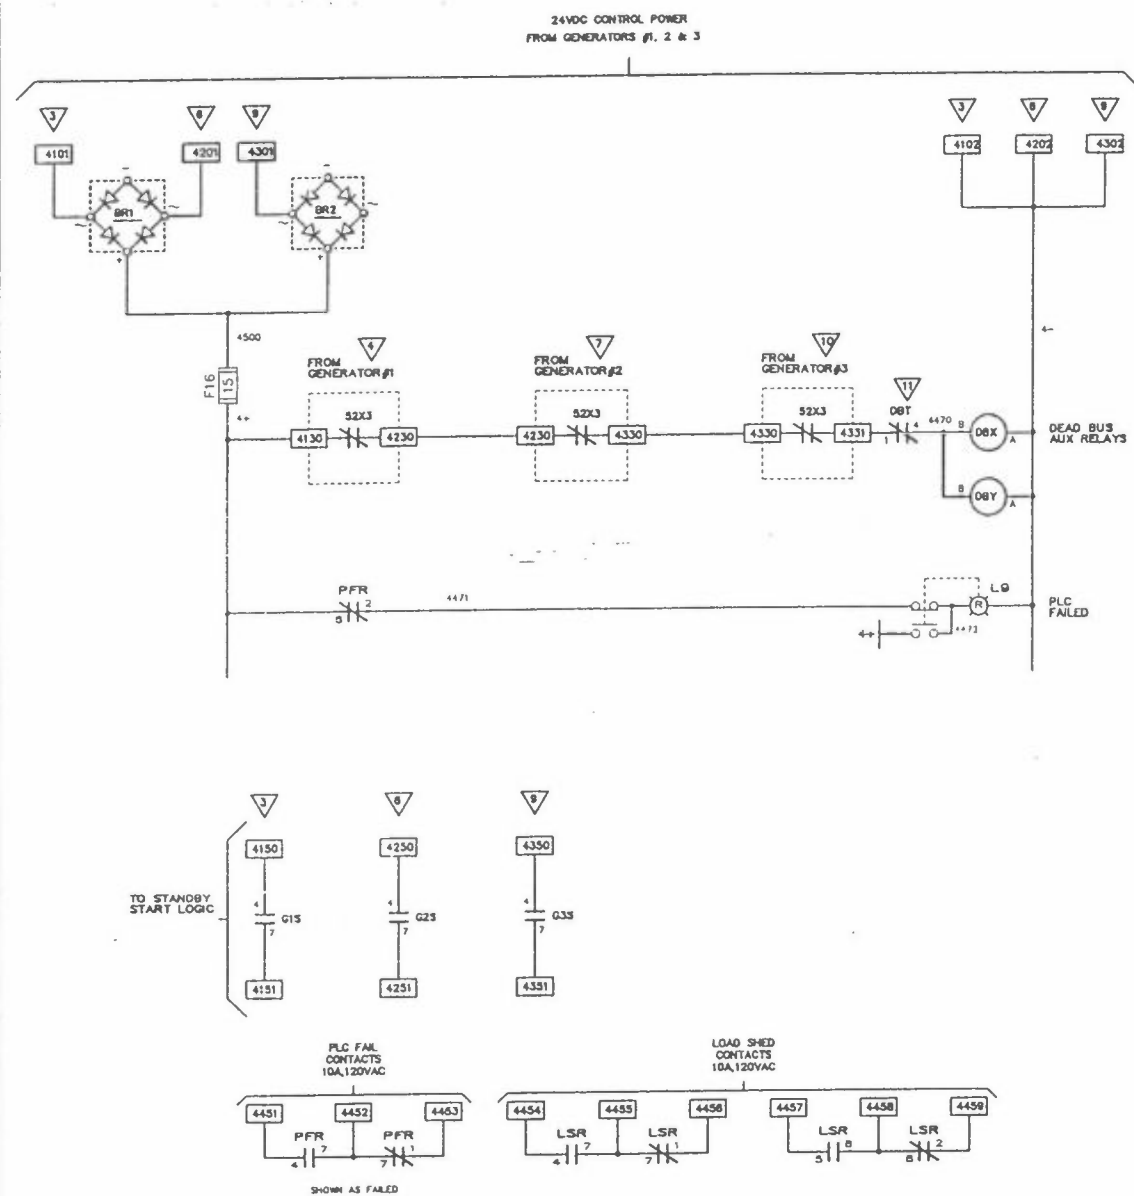

ALLEN BRADLEY
MICROLOGIX
1781-L32BWB

REFER TO SHEET #

APPROVED FOR CONSTRUCTION
☐ MASTER COPY ☐ REFERENCE COPY OF
☐ MULTIPLE UNIT WORK ORDER
☐ RELEASED FOR INFORMATION
 AUTH. BY: DATE:

DRAWING No.	REFERENCE DRAWINGS	No.	AS BUILT	REVISIONS	BY	DATE
1					RR	01-07-13

THOMSON TECHNOLOGY
POWER & CONTROL

GENERATOR CONTROL SYSTEM
 MODEL GCS2200
 PLC & COMMON CONTROL SCHEMATIC
 ANDERSON RYCROFT PROJECT

CUSTOMER			
ENERFLEX POWER SYSTEMS			
DRAWN BY	AUTH BY	DATE	REV
RR	BD	01-05-17	1
DRAWING No.			SHEET
ELB15233_01_01_12			12

THE INFORMATION ON THIS DRAWING IS THE PROPERTY OF THOMSON TECHNOLOGY INC. IT IS NOT TO BE USED DETRIMENTALLY TO OUR INTERESTS.

GEN #1

AVR

CTB2

CTB1

52X1

GRD

1100

1102

B

1102

GEN #2

AVR

CTB2

CTB1

52X1

1100

1102

B

2100

GEN #3

AVR

CTB2

CTB1

52X1

1100

1102

B




3100

Diagram of a three-generator power system. The system is divided into three sections by dashed lines, each containing a generator and its associated busbar and circuit breaker.

- Section 1 (Left):** Labeled "2 GEN #1 LSSC". It shows a busbar with a circuit breaker. Two lines, labeled "10" and "11", connect this busbar to the next section. A ground symbol is shown below the busbar, with the text "GROUNDED AT GEN #1 ONLY".
- Section 2 (Middle):** Labeled "5 GEN #2 LSM". It shows a busbar with a circuit breaker. Two lines, labeled "10" and "11", connect this busbar to the next section. A ground symbol is shown below the busbar.
- Section 3 (Right):** Labeled "8 GEN #3 LSM". It shows a busbar with a circuit breaker. Two lines, labeled "10" and "11", connect this busbar to the next section. A ground symbol is shown below the busbar.

The lines "10" and "11" represent the main power lines connecting the three generators in series.

FORM CAD No. ESHT

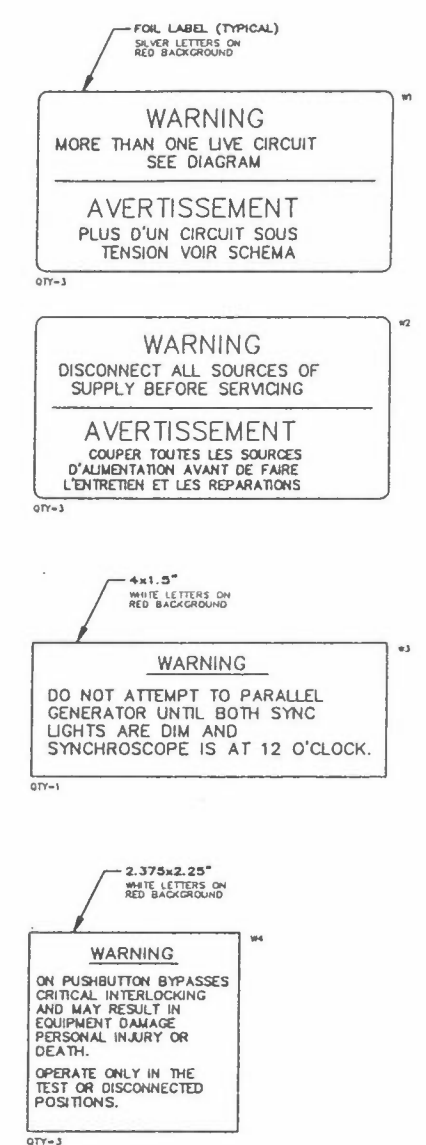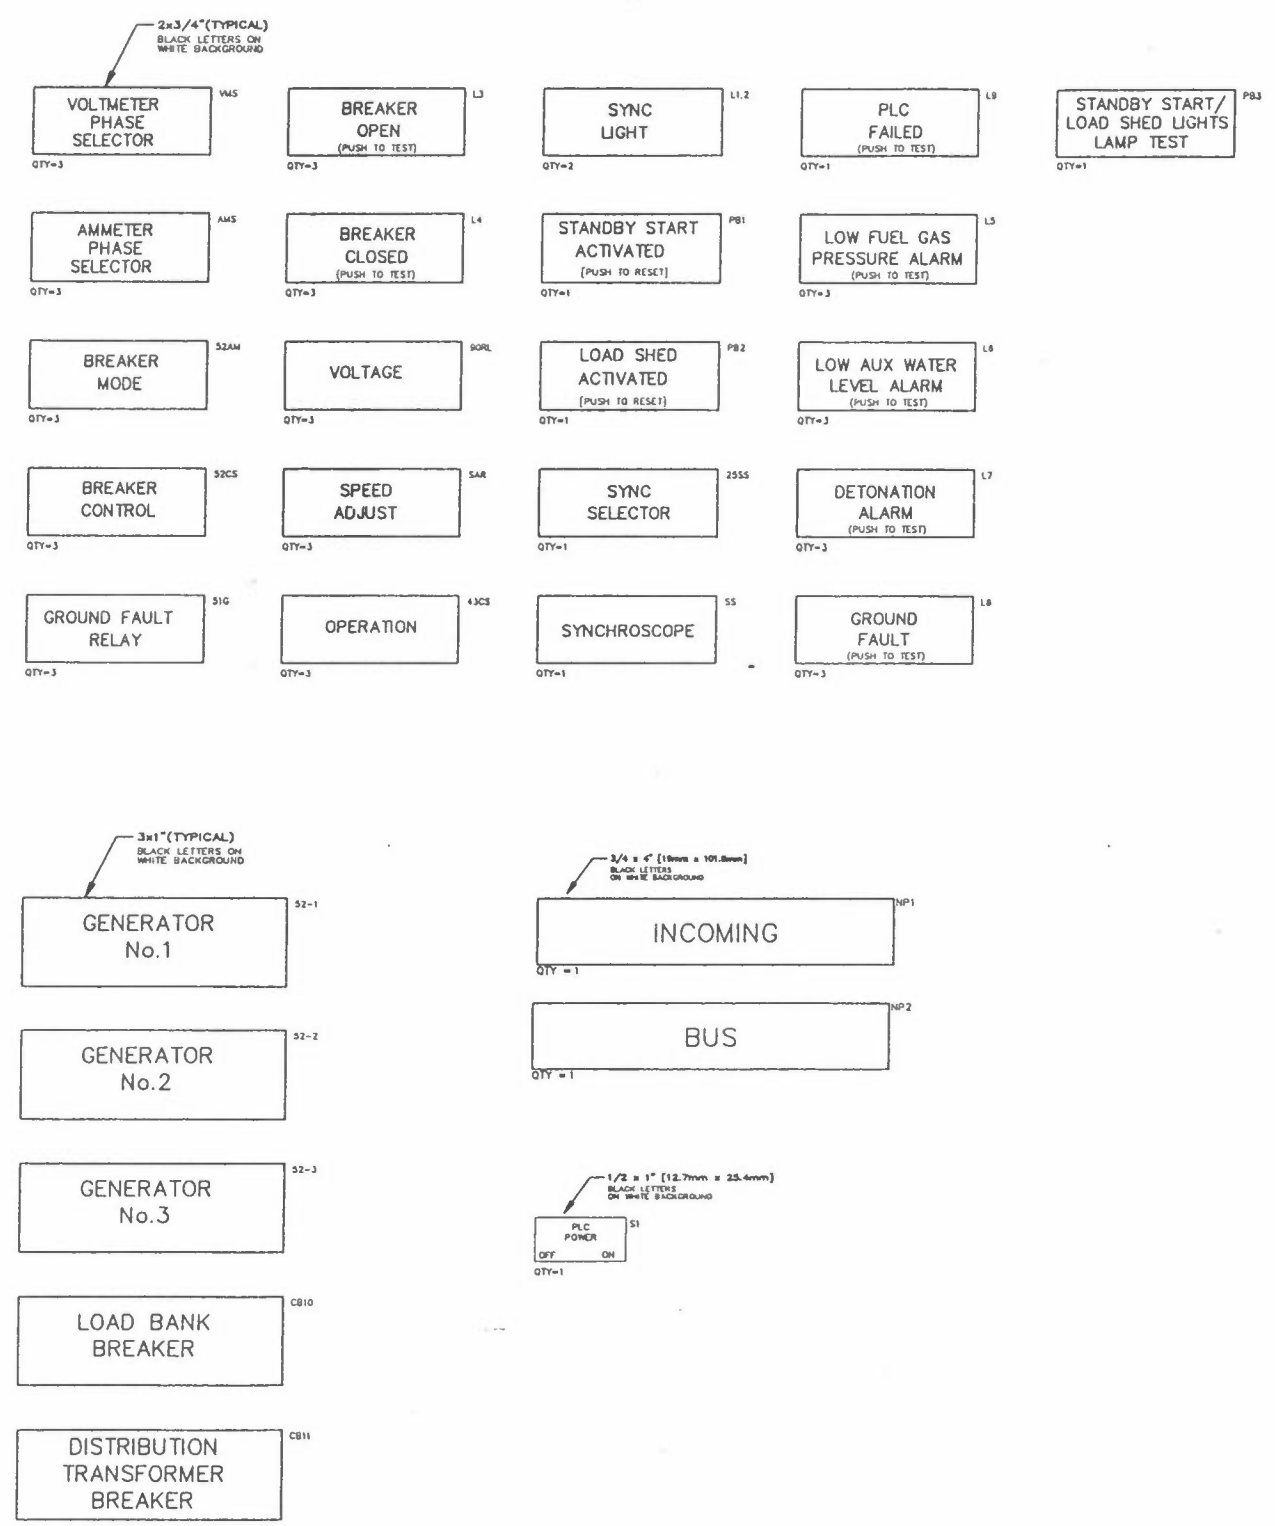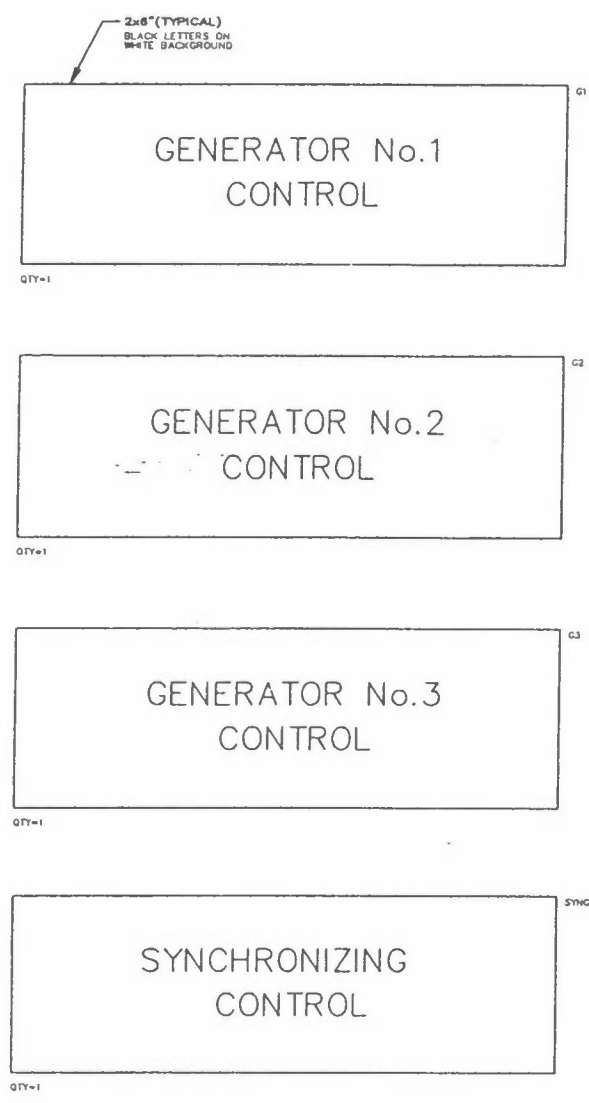

NOTE:
THE BREAKERS ARE PROVIDED
WITH PAD LOCKABLE COVERS
TO PREVENT ACCESS
TO THESE PUSHBUTTONS.

REFER TO SHEET #		DRAWING No.		REFERENCE DRAWINGS		No.		AS BUILT		REVISIONS		RR		BD		01-07-13		BY		AUTH		DATE		THOMSON TECHNOLOGY POWER & CONTROL		GENERATOR CONTROL SYSTEM MODEL GCS2200 LAMICOID DETAIL ANDERSON RYCROFT PROJECT		DRAWINGS AND/OR OTHER TECHNICAL INFORMATION SUPPLIED BY THOMSON TECHNOLOGY INC. AS A PART OF A SALE OF EQUIPMENT ARE FOR THE PURCHASER'S USE SOLELY IN CONJUNCTION WITH THAT EQUIPMENT. UNLESS SPECIFICALLY AGREED TO OTHERWISE AS A PART OF THE TERMS OF SALE.		CUSTOMER ENERFLEX POWER SYSTEMS		DRAWN BY RR		AUTH BY BD		DATE 01-05-17		REV 1		SHEET 14	
☐ APPROVED FOR CONSTRUCTION ☐ MASTER COPY ☐ REFERENCE COPY OF ☐ MULTIPLE UNIT WORK ORDER ☐ RELEASED FOR INFORMATION AUTH. BY: DATE:																																									

FORM CAD No. ESHT

© THE INFORMATION ON THIS DRAWING IS THE PROPERTY OF THOMSON TECHNOLOGY INC. IT IS NOT TO BE USED DETRIMENTALLY TO OUR INTERESTS.

