


BY ENERFLEX POWER SYSTEMS

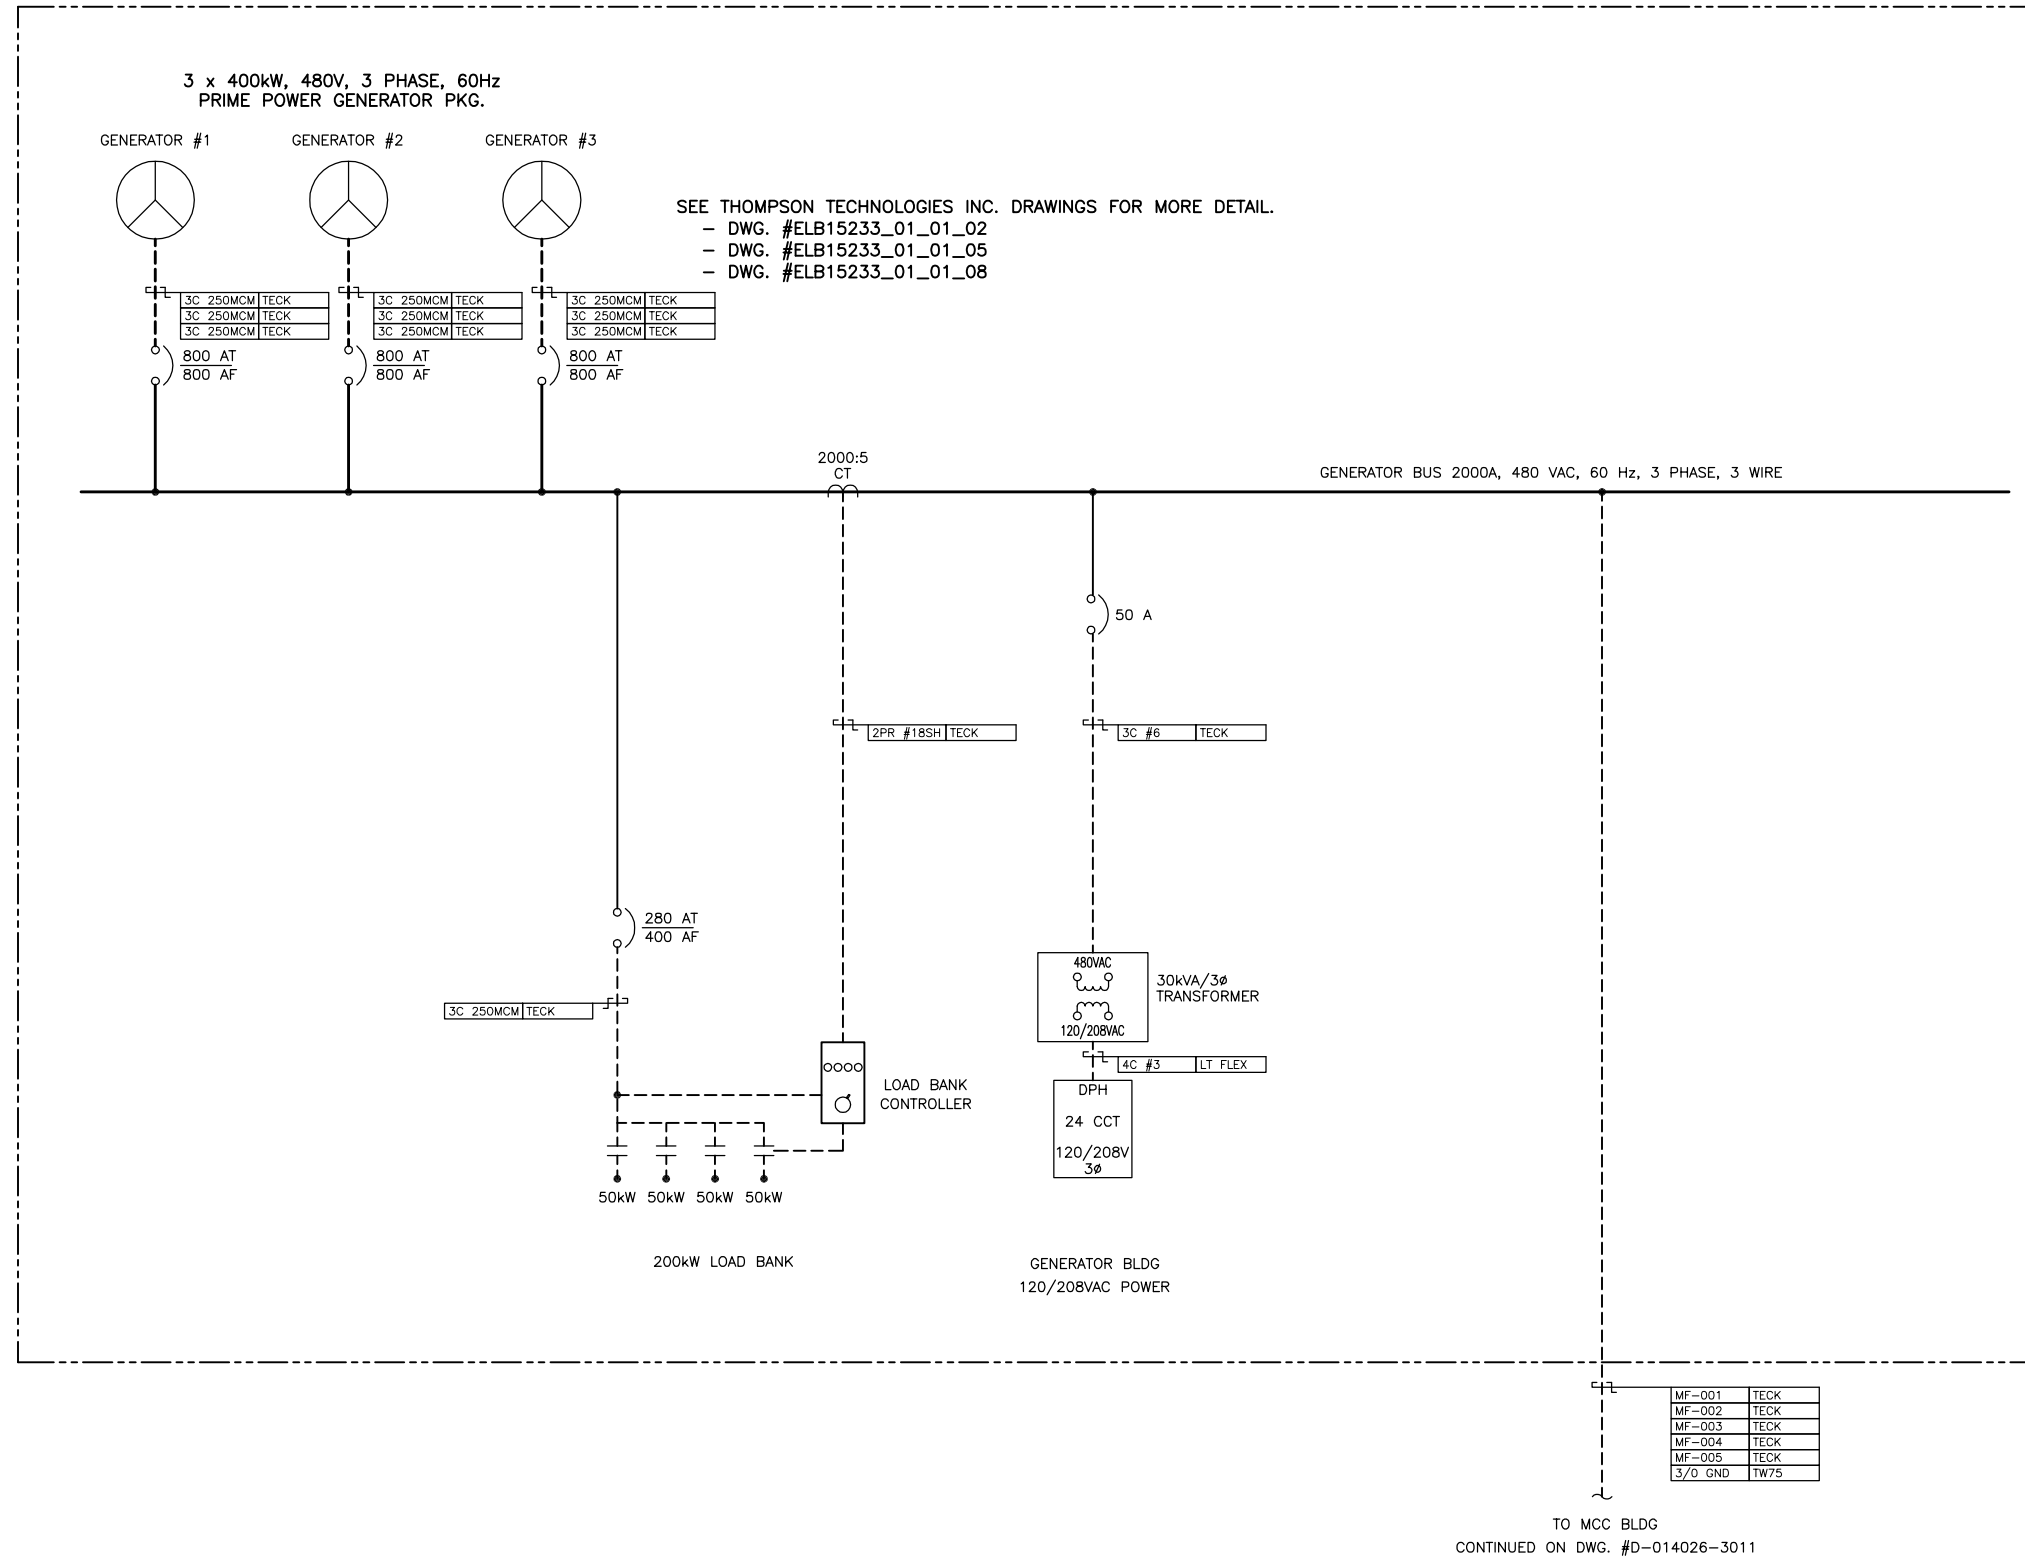

SEE THOMPSON TECHNOLOGIES INC. DRAWINGS FOR MORE DETAIL.
 - DWG. #ELB15233_01_01_02
 - DWG. #ELB15233_01_01_05
 - DWG. #ELB15233_01_01_08

3 x 400kW, 480V, 3 PHASE, 60Hz
 PRIME POWER GENERATOR PKG.

GENERATOR #1 GENERATOR #2 GENERATOR #3

3C 250MCM TECK
 3C 250MCM TECK
 3C 250MCM TECK

800 AT
 800 AF

2000:5
 CT

GENERATOR BUS 2000A, 480 VAC, 60 Hz, 3 PHASE, 3 WIRE

50 A

2PR #18SH TECK

3C #6 TECK

280 AT
 400 AF

3C 250MCM TECK

LOAD BANK
 CONTROLLER

480VAC
 30kVA/3φ
 TRANSFORMER
 120/208VAC

4C #3 LT FLEX

DPH
 24 CCT
 120/208V
 3φ

50kW 50kW 50kW 50kW

200kW LOAD BANK

GENERATOR BLDG
 120/208VAC POWER

MF-001	TECK
MF-002	TECK
MF-003	TECK
MF-004	TECK
MF-005	TECK
3/G GND	TW75

TO MCC BLDG
 CONTINUED ON DWG. #D-014026-3011

DWG. NO.	REFERENCE DRAWINGS	REV	REVISIONS	DATE	BY	CHK'D	APP'D	OWNR APP'D	ENGINEER AND PERMIT STAMPS	DESIGNED	DJH	01.06.04	ANDERSON EXPLORATION CALGARY, ALBERTA, CANADA			
		1	AS BUILT	02.01.21	DJH	MPB				DRAWN	DJH	01.06.04		RYCROFT GAS PLANT SINGLE LINE DIAGRAM SHEET 1 LSD 7-2-77-4 W6M		
		0	ISSUED FOR FIELD CONSTRUCTION	01.10.08	DJH	MPB				CHECKED	MPB	01.06.26				
		D	ISSUED FOR FIELD BID	01.09.10	DJH	MPB				PROCESS CK.						
		C	RE-ISSUED FOR MCC BLDG CONSTRUCTION	01.08.29	IRH	MPB				STRUCT. CK.						
		B	ISSUED FOR MCC BLDG CONSTRUCTION	01.08.10	IRH	MPB				ELECT. CK.						
		A	ISSUED FOR MCC BUILDING BID	01.07.17	IRH	GMH				OWNER APP.			CONTR JOB NO	SCALE	DWG. NO.	AXP PROJ NO
										OWNER APP.			2001-172	N.T.S.	D-014026-3010	014026




CADD FILE: 014026-3010.DWG

CONTINUED FROM DWG. #D-014026-3010


MF-001	TECK
MF-002	TECK
MF-003	TECK
MF-004	TECK
MF-005	TECK
3/O GND	TW75

SECTION 13	SECTION 12	SECTION 11	SECTION 10	SECTION 9	SECTION 8	SECTION 7	SECTION 6	SECTION 5	SECTION 4	SECTION 3	SECTION 2	SECTION 1
SPACE	SPARE SIZE 1	K-1340A 30HP	P-200 3HP	P-1150 3HP	P-1620A 5HP	HM BLDG HTR#1	E-1300A 30A	K-6000 ACID GAS COMPRESSOR 400A	HARMONIC FILTER 150A	KD-1560 350HP REFRIGERANT COMP BENSCHAW MICRO RSM6-350-4-C	KD-1560 BYPASS CONTACTOR	PQM
SPACE	SPACE	K-1340B 30HP	P-210 3HP	P-1190 3HP	P-1620B 5HP	MCC BLDG HTR#1	E-1310A 20A	112.5kVA DIST. XFRMR 150A	SPACE			SPACE
SPACE	SPACE	P-5500 40HP	CF-6000 2HP	P-2670 3HP	P-1260B 10HP	VRU BLDG HTR#3	E-6700 30A	P-1240A 150A	SPACE	SPACE	SPACE	SPACE
SPACE	SPACE	P-5510 40HP	P-6111 1HP	AC-1510 25HP	P-1370 3HP	P-1320A 1.5HP	M-3550 70A	P-1240B 150A	SPACE	SPACE	SPACE	SPACE
SPACE	SPACE	SPACE	SPARE SIZE 1	AC-1680 25HP	P-2170 3HP	P-1320B 1.5HP	M-3200 5A	SPACE	SPACE	SPACE	SPACE	SPACE

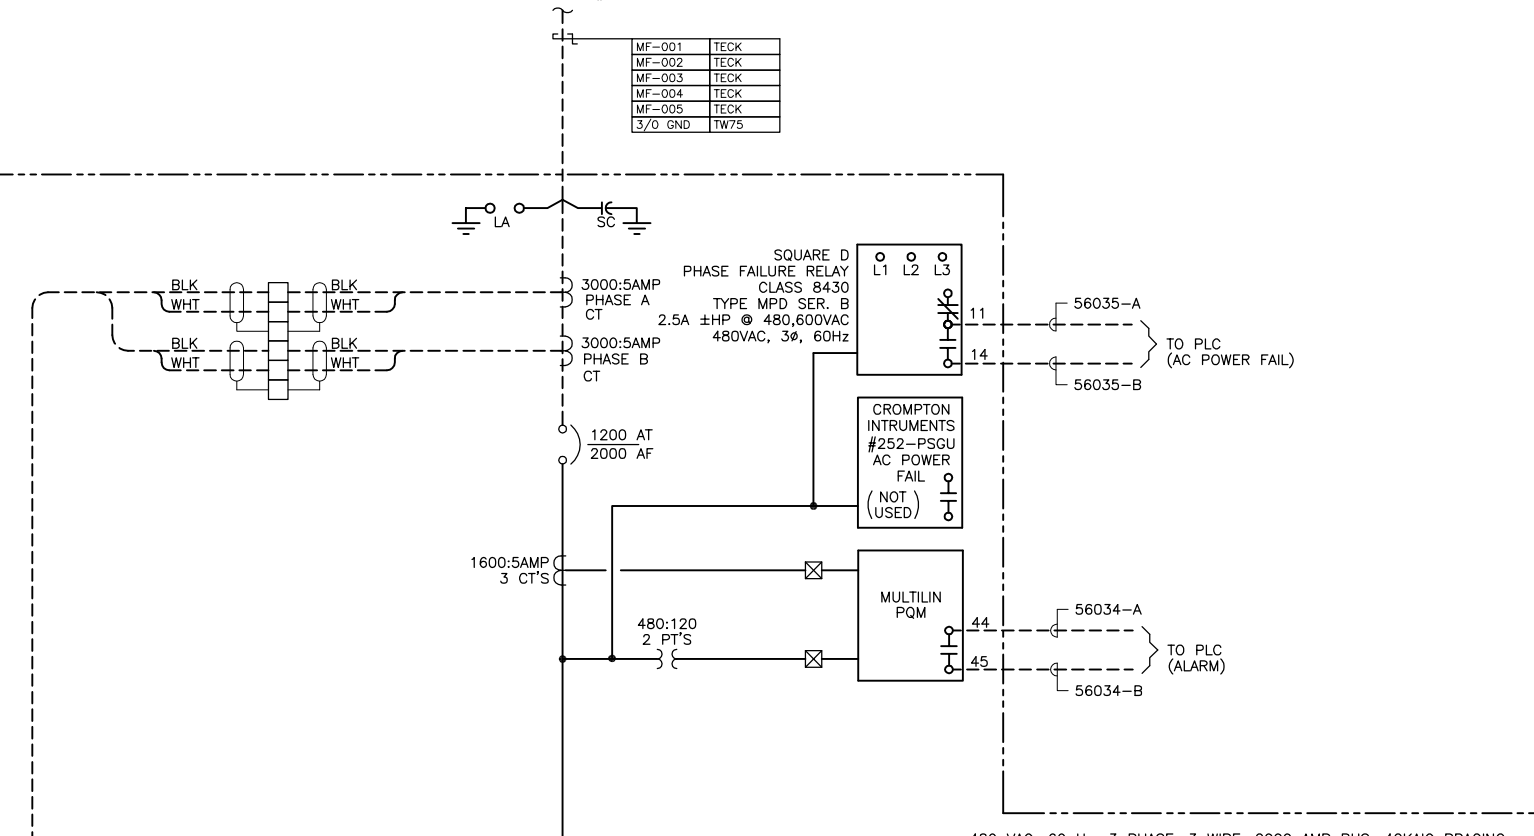

480V MOTOR CONTROL CENTER

480 VAC, 60 Hz, 3 PHASE, 3 WIRE, 2000 AMP BUS, 42KAIC BRACING

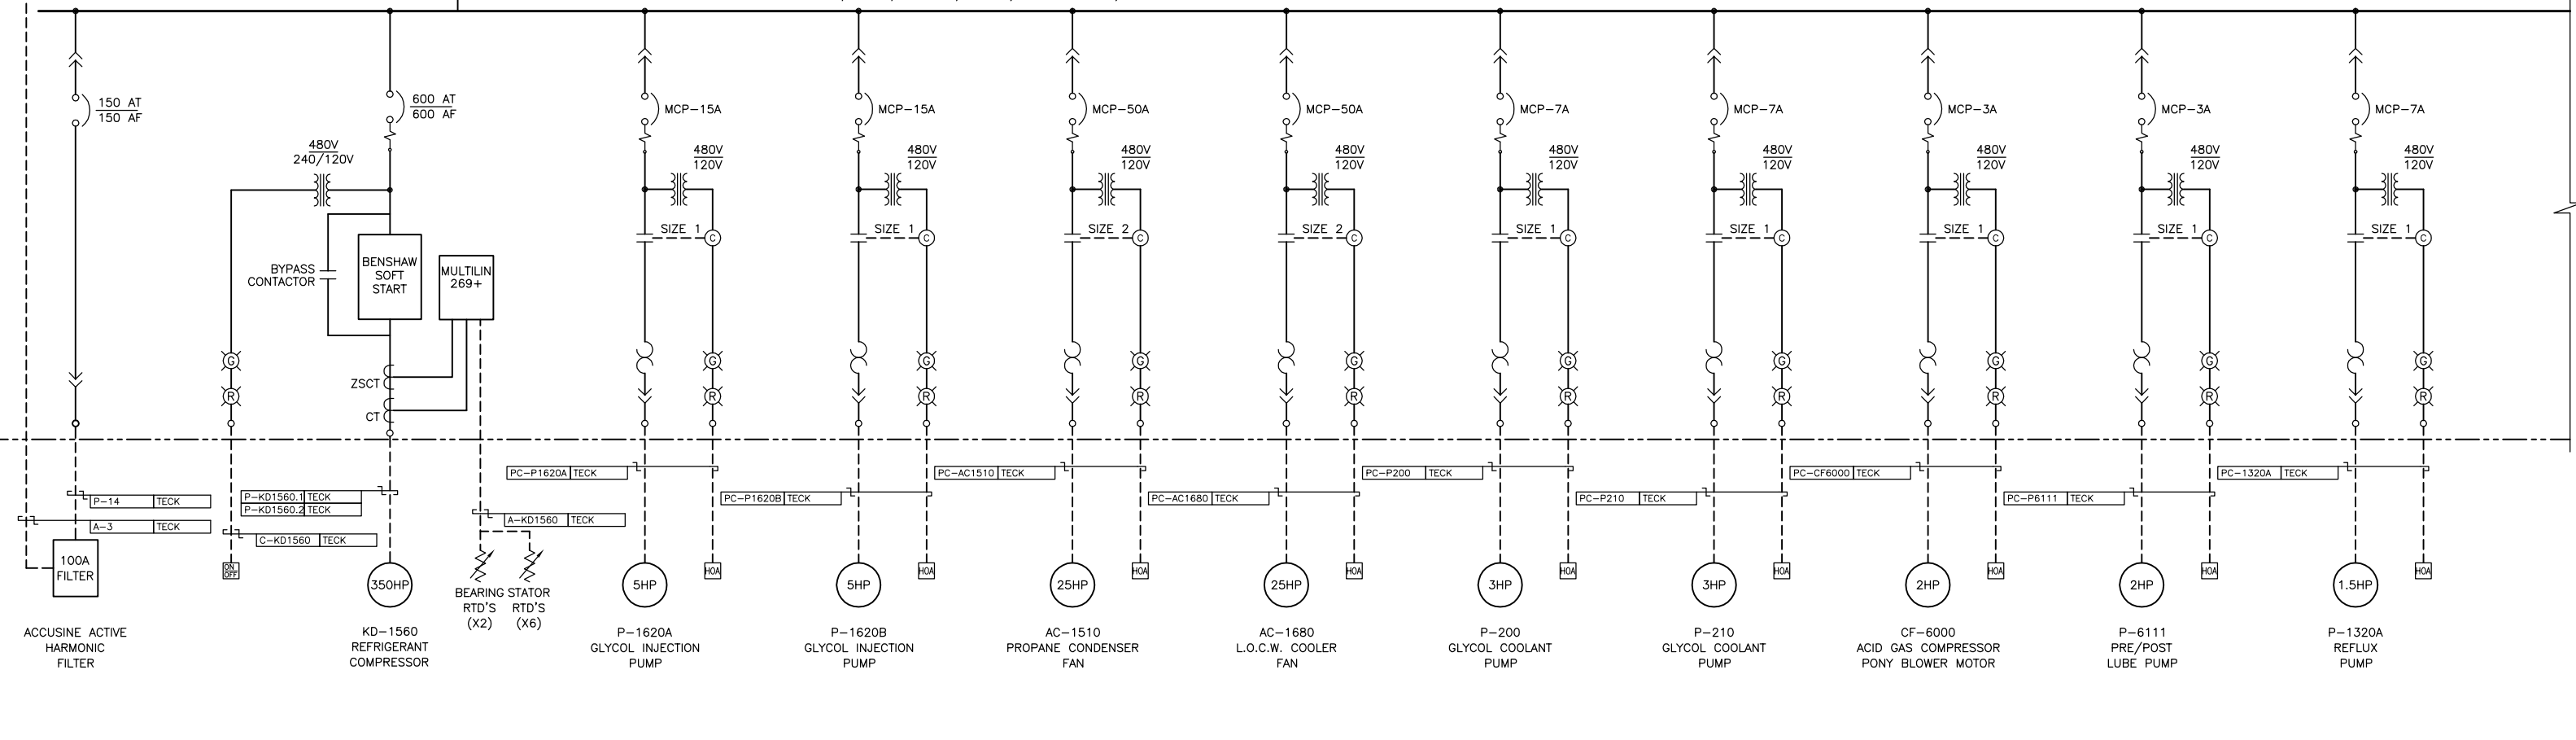


CONTINUED ON DWG # D-014026-3012

DWG. NO.	REFERENCE DRAWINGS	REV	REVISIONS	DATE	BY	CHK'D	APP'D	OWNR APP'D	ENGINEER AND PERMIT STAMPS	DESIGNED	SCALE	DWG. NO.	CONTR JOB NO	SCALE	DWG. NO.	AMP PROJ NO						
		F	ISSUED FOR FIELD BID	01.09.10	DJH	MPB			<div style="display: flex; justify-content: space-between;"> <div style="width: 40%;"> <p>ANDERSON EXPLORATION CALGARY, ALBERTA, CANADA</p> <p>RYCROFT GAS PLANT</p> <p>SINGLE LINE DIAGRAM SHEET 2 LSD 7-2-77-4 W6M</p> </div> <div style="width: 40%; text-align: right;"> <p>AXP</p> <p>2001-172</p> <p>N.T.S.</p> <p>D-014026-3011</p> <p>014026</p> </div> </div>													
		E	RE-ISSUED FOR MCC BLDG CONSTRUCTION	01.08.29	IRH	MPB																
		D	ISSUED FOR MCC BLDG CONSTRUCTION	01.08.10	IRH	MPB																
		C	ISSUED FOR MCC BUILDING BID	01.07.17	IRH	GMH																
		1	AS BUILT	02.01.21	DJH	MPB																
		0	ISSUED FOR FIELD CONSTRUCTION	01.10.08	DJH	MPB																



CADD FILE: 014026-3011.DWG

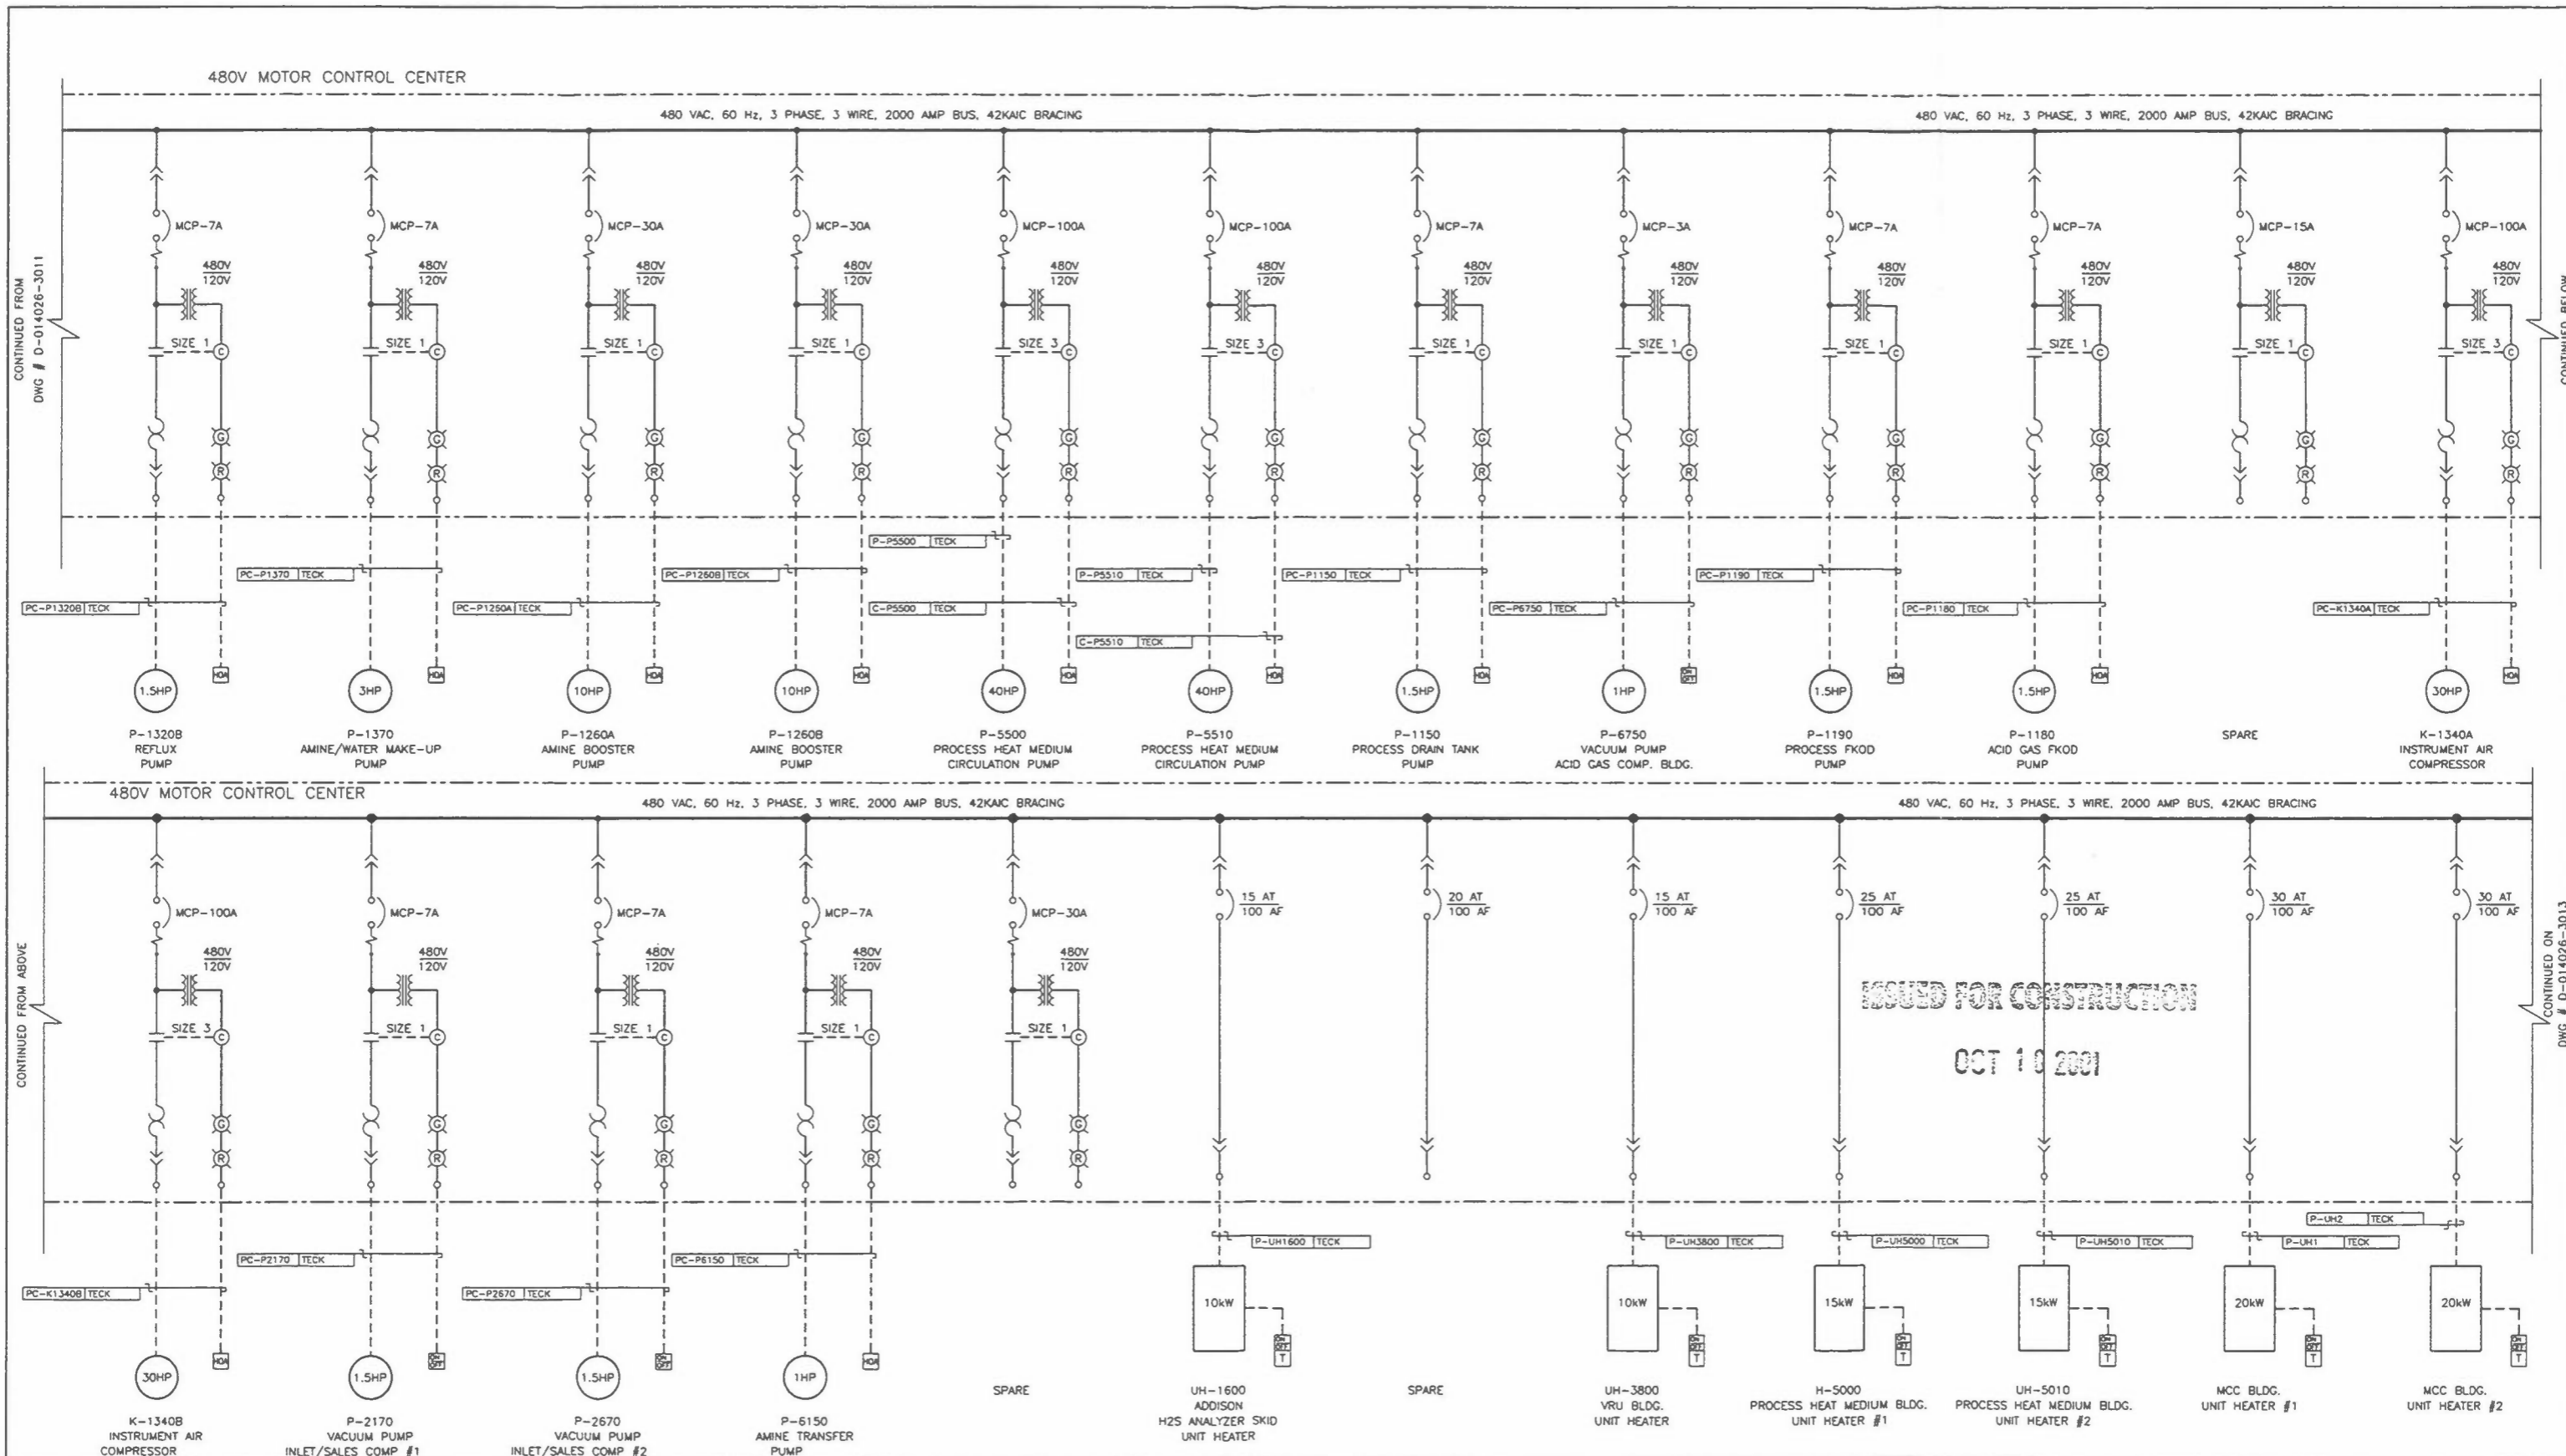

DWG. NO.	REFERENCE DRAWINGS	REV	REVISIONS	DATE	BY	CHK'D	APP'D	OWNER APP'D	ENGINEER AND PERMIT STAMPS			DESIGNED	DJH	01.06.11	AXP	ANDERSON EXPLORATION CALGARY, ALBERTA, CANADA	
		F	ISSUED FOR FIELD BID	01.09.10	DJH	MPB						DRAWN	DJH	01.06.11			
		E	RE-ISSUED FOR MCC BLDG CONSTRUCTION	01.08.29	IRH	MPB						CHECKED	MPB	01.06.11		SINGLE LINE DIAGRAM SHEET 3 LSD 7-2-77-4 WGM	
		D	ISSUED FOR MCC BLDG CONSTRUCTION	01.08.10	IRH	MPB						PROCESS CK.					
		C	ISSUED FOR MCC BUILDING BID	01.07.17	IRH	GMB						MECH. CK.					
		B	ISSUED FOR VFD BID	01.06.15	DJH	MB						STRUCT. CK.					
		O	ISSUED FOR FIELD CONSTRUCTION	01.10.08	DJH	MPB						ELECT. CK.					
									OWNER APP. _____ OWNER APP. _____			COVER JOB NO 2001-172 SCALE N.T.S.		DWG. NO. D-014026-3012		AXP PROJ NO 014026	


CADD FILE: 014026-3012.DWG

480V MOTOR CONTROL CENTER

480 VAC, 60 Hz, 3 PHASE, 3 WIRE, 2000 AMP BUS, 42KAC BRACING

CONTINUED FROM
DWG # D-014026-3012

CONTINUED BELOW


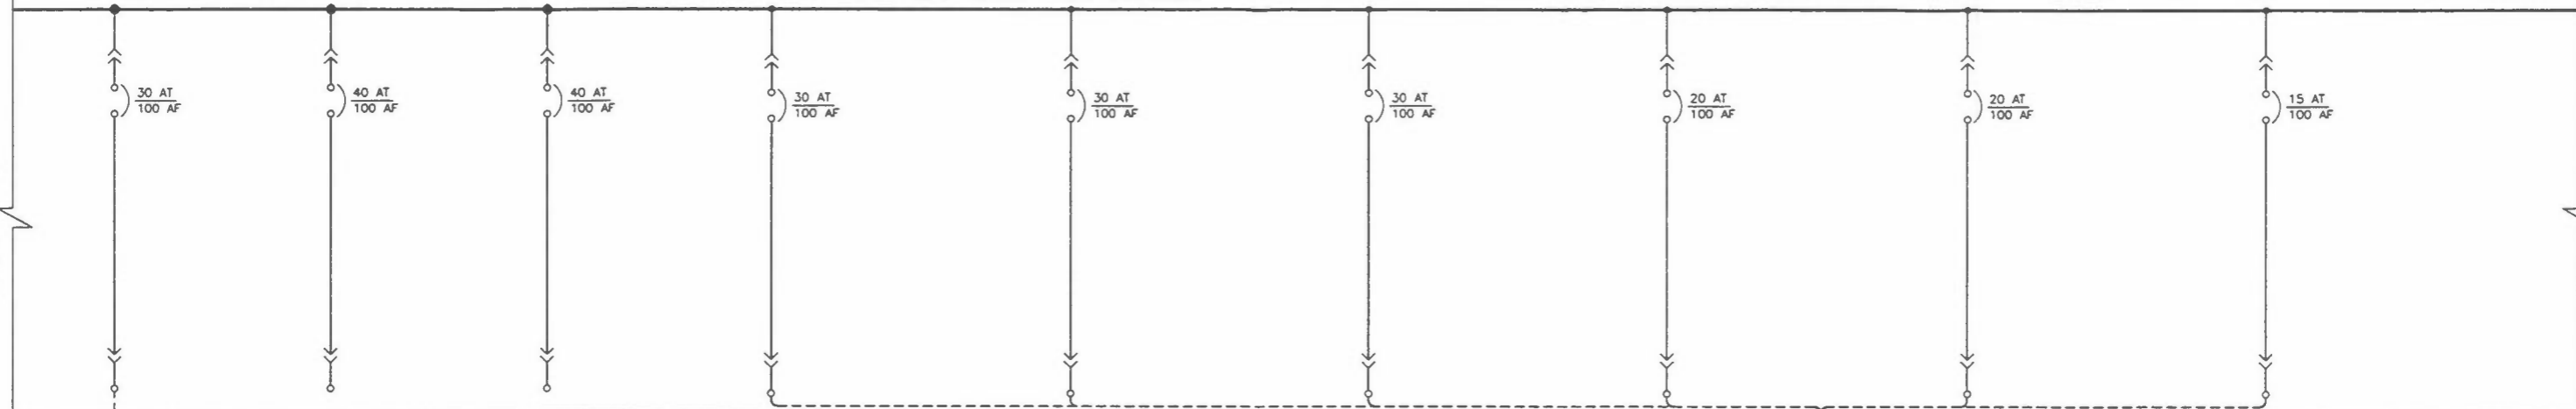


480V MOTOR CONTROL CENTER

ISSUED FOR CONSTRUCTION

OCT 18 2001

CONTINUED FROM ABOVE

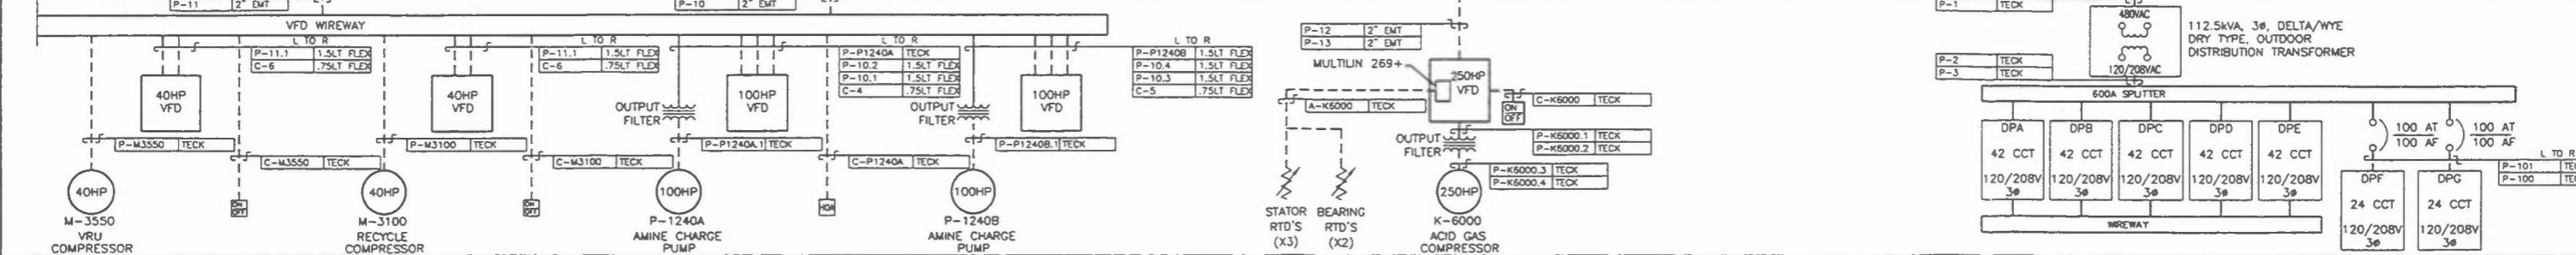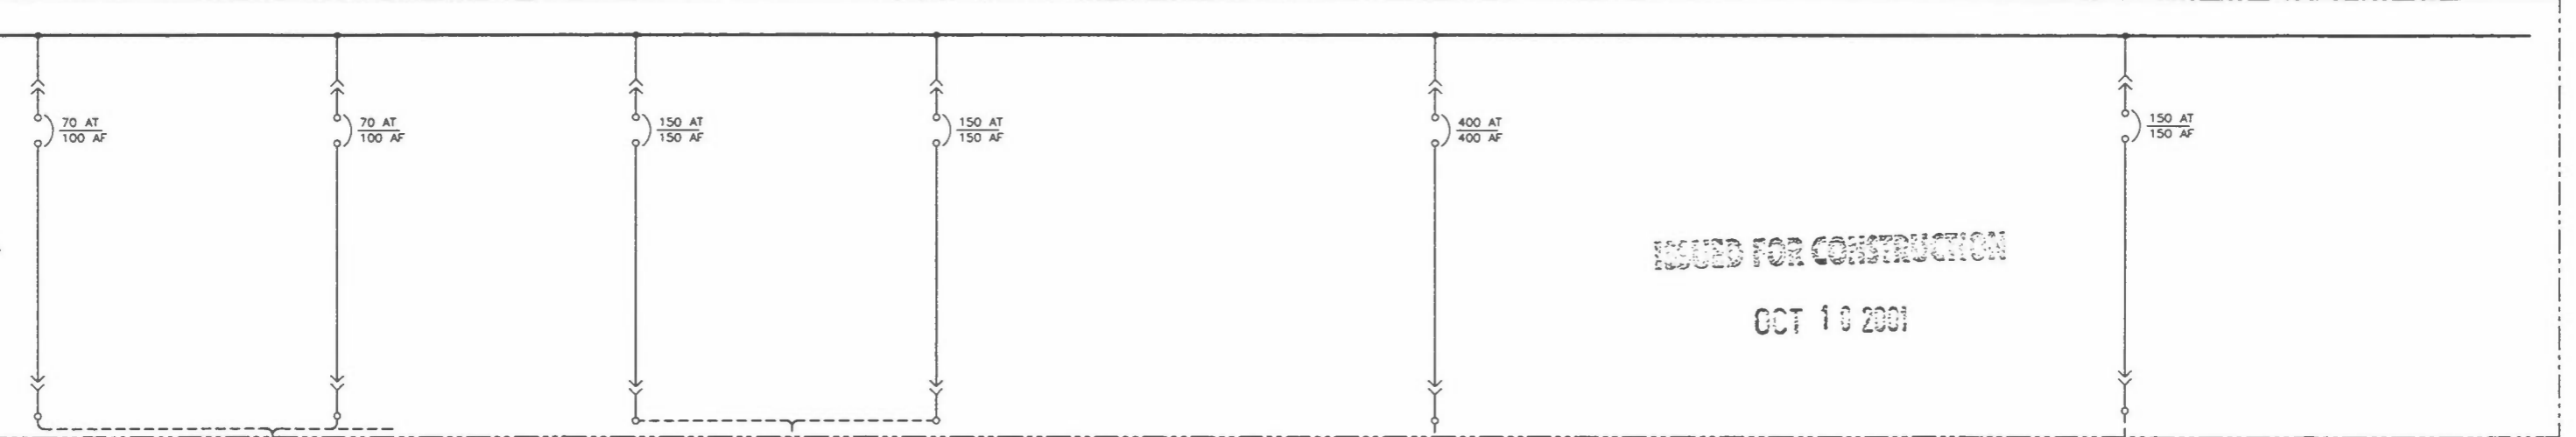

DWG. NO.	REFERENCE DRAWINGS	REV	REVISIONS	DATE	BY	CHK'D	APP'D	OWNER APP'D	ENGINEER AND PERMIT STAMPS	DESIGNED	DWG. NO.	CONTR. JOB NO.	SCALE	AXP PROJ. NO.
		F	ISSUED FOR FIELD BID	01.09.10	DJM	MPB				DJM	D-014026-3013	2001-172	N.T.S.	014026
		E	RE-ISSUED FOR MCC BLDG CONSTRUCTION	01.08.29	IRH	MPB								
		D	ISSUED FOR MCC BLDG CONSTRUCTION	01.08.10	IRH	MPB								
		C	ISSUED FOR MCC BUILDING BID	01.07.17	IRH	GMH								
		B	ISSUED FOR VFD BID	01.06.15	DJM	MB								
		O	ISSUED FOR FIELD CONSTRUCTION	01.10.08	DJM	MPB								



CADD FILE: 014026-3013.DWG