

V-365
PROPANE TANK
 CAPACITY: 1000 gal


V-360
BUTANE BULLET
 SIZE: 3277mm I.D. X 22352mm S/S
 CAPACITY: 1724m³ (64600 S/WG)
 D.P.: 1724m³ @ 66°C
 C.A. No. 9
 CR No. A7564.2

P-360
BUTANE PUMP
 MODEL: GORLEN FT2 CD2A TURBINE
 MOTOR: 5 HP 3600 RPM 3/60/600V X.P.
 CAPACITY: 1.8m³/HR D.P. 730 kPa (106 PSIG)

P-361
CRUDE TRANSFER PUMP
 MODEL: GOULDS 3196 STX 1.5X3-6
 MOTOR: 5 HP 3600 RPM 3/60/600V X.P.
 CAPACITY: 25m³/HR D.P. 205 kPa (30 PSIG)

BH-100
BUILDING HEATER
 MODEL: RUFFNECK
 DUTY: 3 kW
 MOTOR: 3/60/600V X.P.

BF-100
BUILDING FAN
 CAPACITY: 6 ACPH
 MOTOR: 120/1/60 X.P.

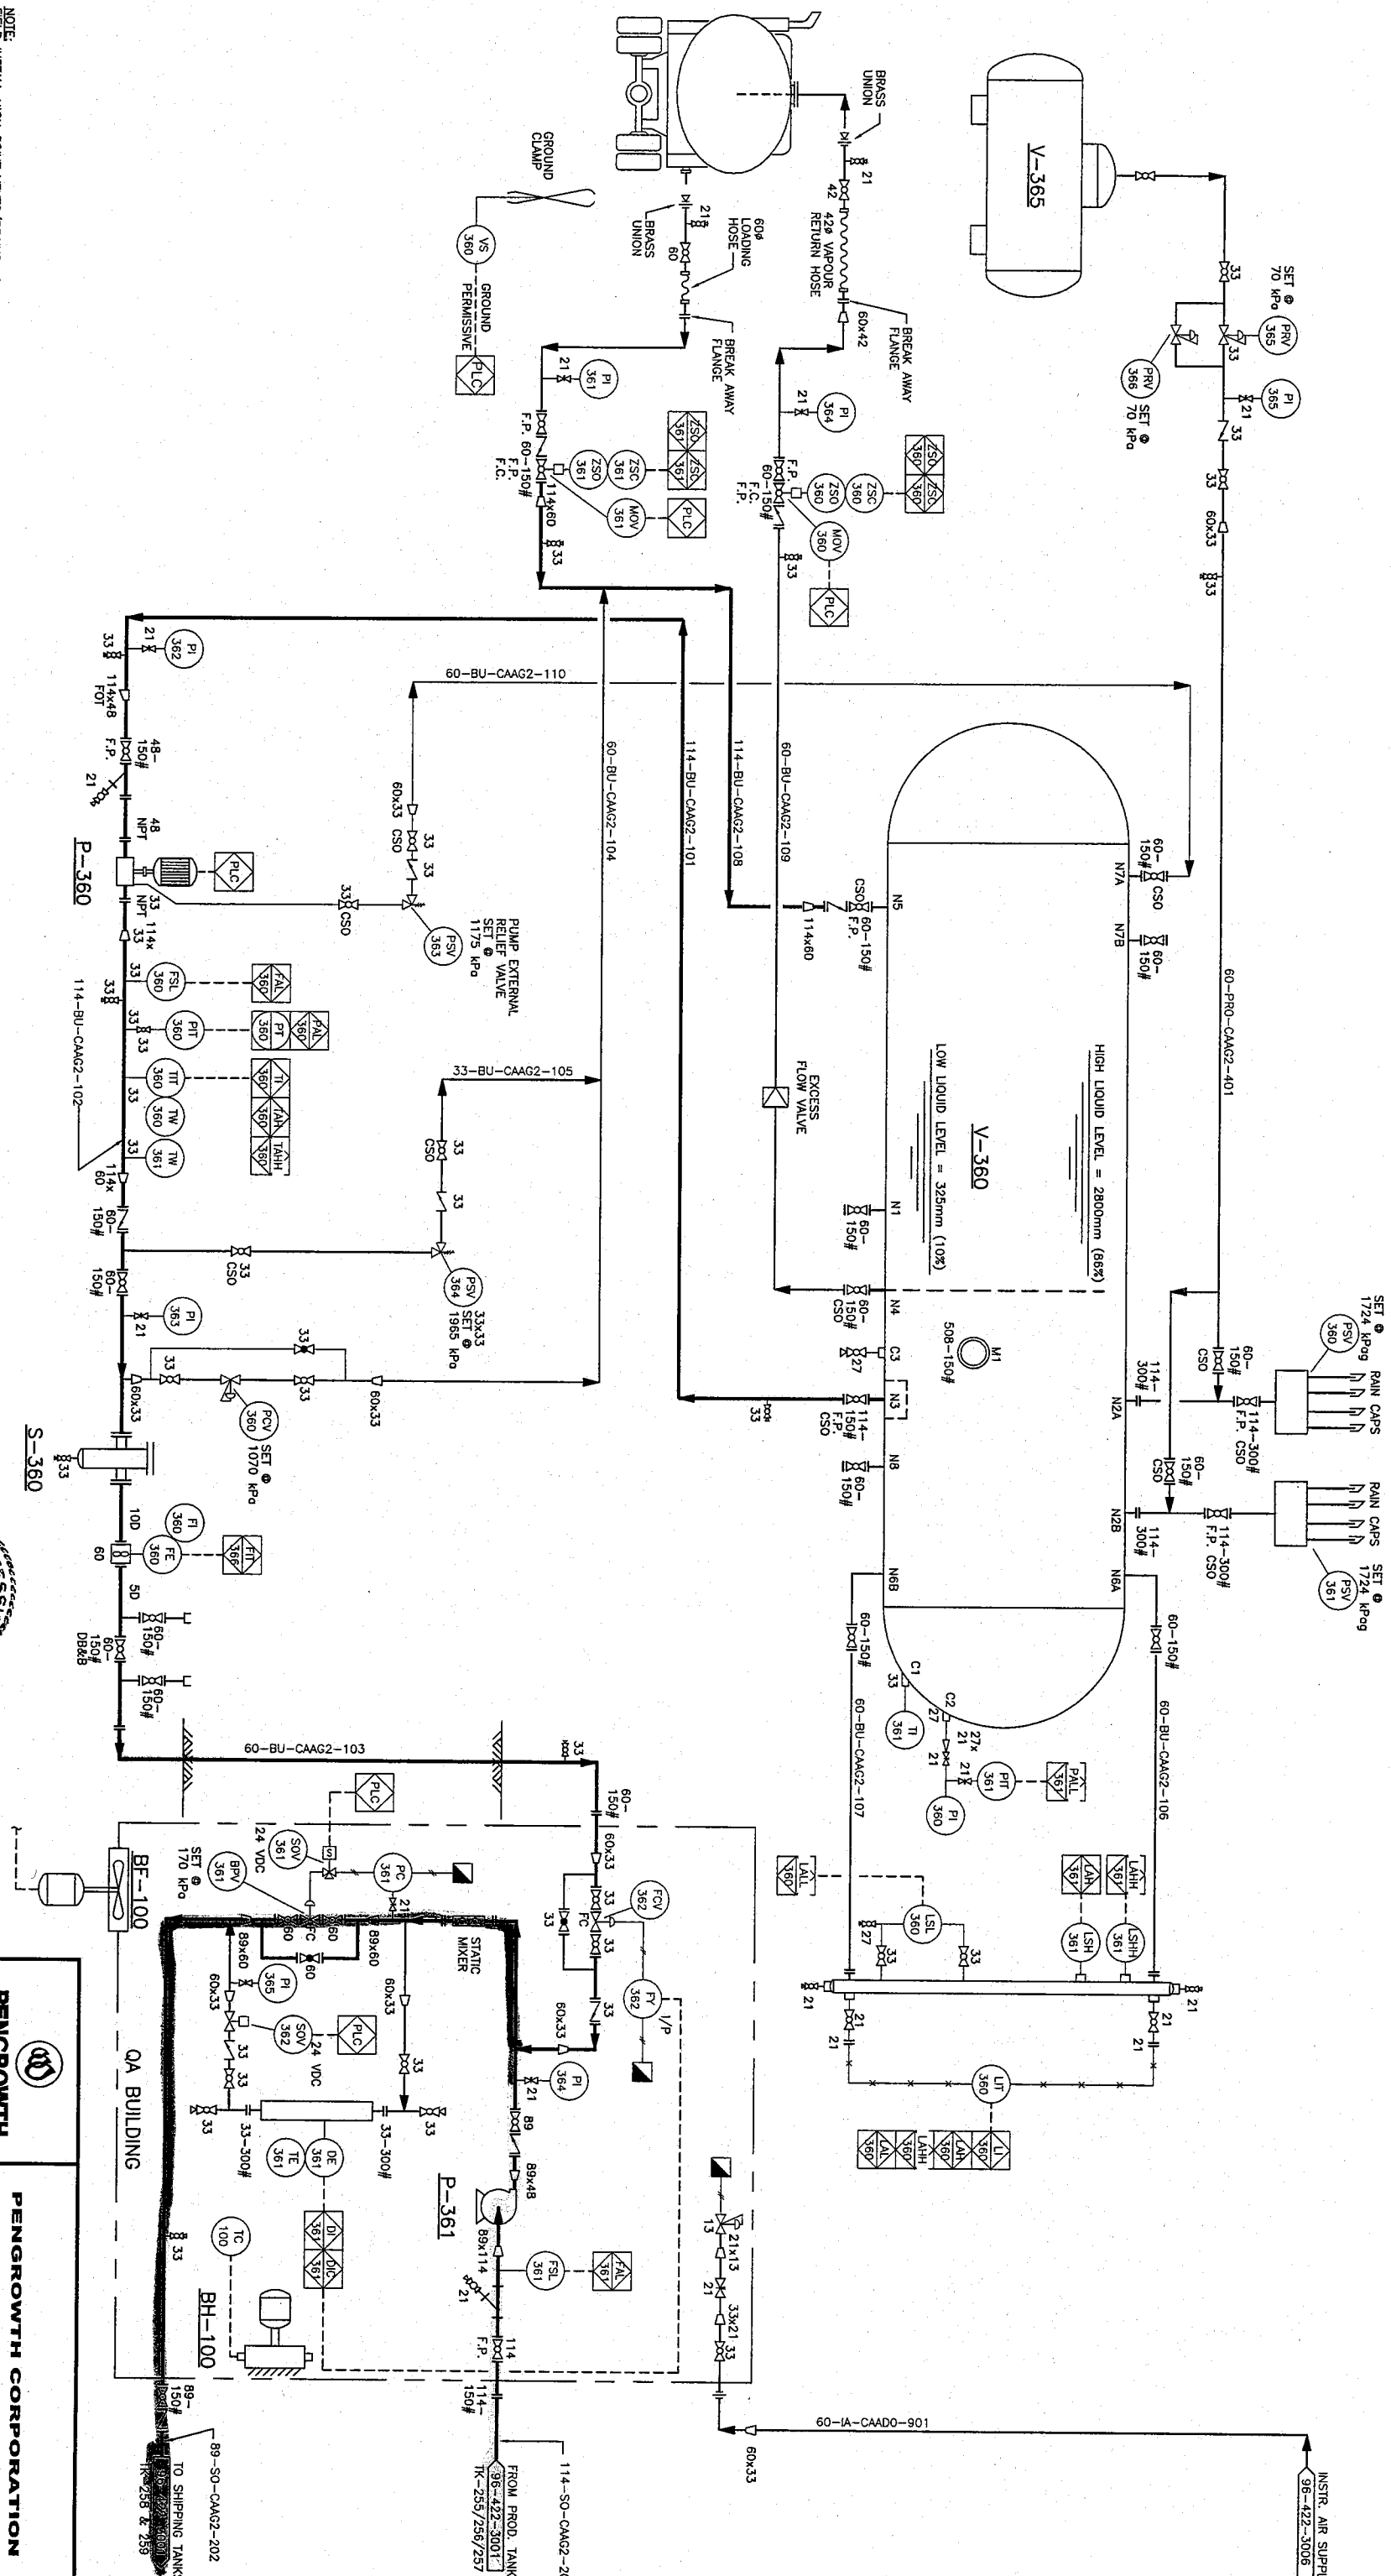

NOTE:
 FIELD INSTALL HIGH POINT VENTS/DRAINS AS REQUIRED

NO.	DATE	REVISIONS	DRAWN	CHECK	DESIGN	APPR	NO.	TITLE
0	04-11-08	ISSUED FOR CONSTRUCTION	ME	AB				
B	04-11-04	ISSUED FOR O&G APPLICATION	ME					
A	04-09-17	ISSUED FOR CLIENT APPROVAL	E.D.					

NO.	DATE	REVISIONS	DRAWN	CHECK	DESIGN	APPR	NO.	TITLE

NO.	DATE	REVISIONS	DRAWN	CHECK	DESIGN	APPR	NO.	TITLE

NO.	DATE	REVISIONS	DRAWN	CHECK	DESIGN	APPR	NO.	TITLE

PENGROWTH CORPORATION

RIGEL BATTERY

BUTANE BULLET & PUMP ADDITION

P & ID

CONTRACTOR NAME: CONCISE DESIGN
 CONTRACTOR DRAWING NUMBER: 422-24-3001

SCALE: PENGROWTH DRAWING NUMBER
 SHEET: XXX-XXXX-XXX-XXX