


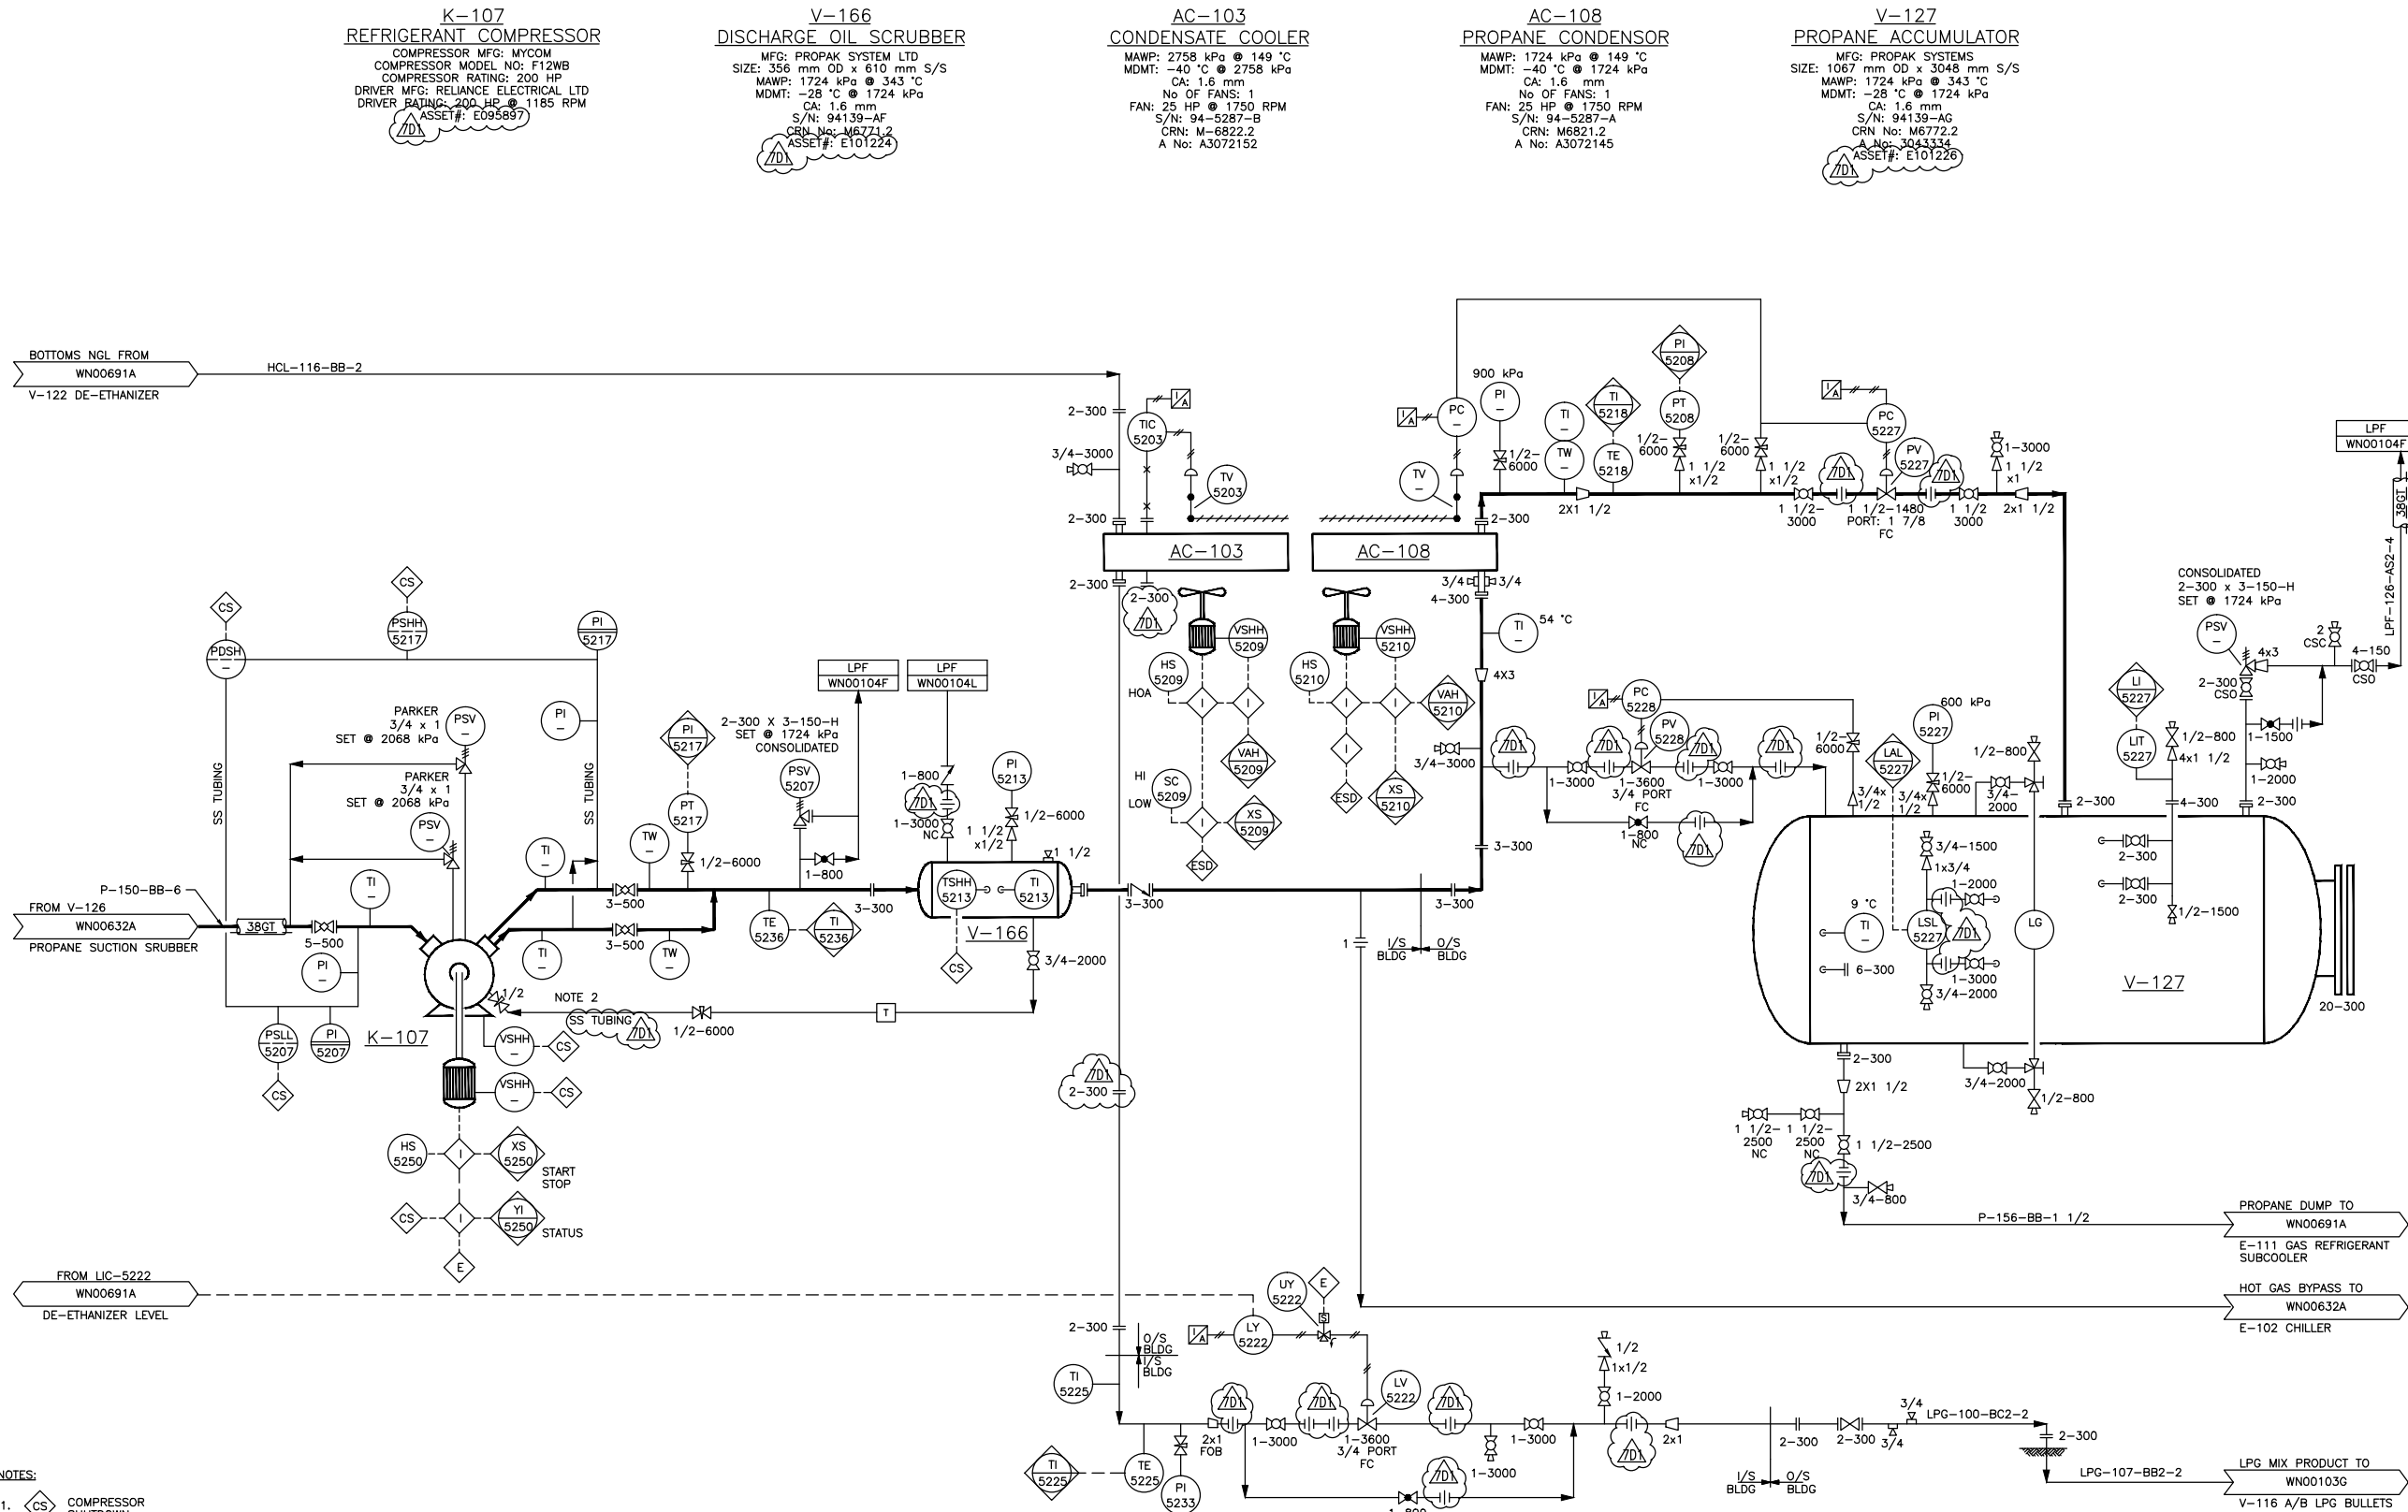

- NOTES:
1. CS COMPRESSOR SHUTDOWN
 2. K-107 PRESSURE SENSING LINES HAVE A BLEED VENT.

REFERENCE DRAWINGS	DWG. NO.
DEWPOINT CONTROL	WN00632A
DE-ETHANIZER-V-122	WN00691A
LPG BULLETS	WN00103G
CAUTION : READ BEFORE EXCAVATION	
ALL EXCAVATIONS MUST BE CARRIED OUT AS PER "ENCANA'S GROUND DISTURBANCE PRACTICE"	

NO.	DATE	PROJECT DESCRIPTION	PROJ.	AFE	EPCM Co.	EPCM No.	APPD.
1	NOV/94	ISSUED FOR CONSTRUCTION	-	-	PROPAK	-	-
2	JAN/95	GENERAL REVISIONS	-	-	PROPAK	-	-
3	98.09.18	"AS-IS" (CS108201/DLP)	-	X020097	CRIMTECH	2108201	-
4	06.10.18	UPDATED AS PER FIELD MARK UP	-	-	CRIMTECH	2273500	-
5	02.04.15	DRAWING UPGRADE (PETERSON DRAFTING SERVICES)	-	-	PDS	0021	AS
6	2011-12-08	AS-BUILT	-	-	CABER ENG	CE11EC0075	-
7	2013-10-31	AS-BUILT AS PER FIELD VERIFIED MARK-UPS	-	13175071	BRT	BRT-13-480	-

ISSUE STAGE	DATE	BY	CHKD.	APPD.
Prelim. (A)	-	-	-	-
Bld (B)	-	-	-	-
Constr. (C)	-	-	-	-
As-built (D)	2013-12-12	CLK	RH	-

PERMIT STAMP	ENGINEER'S STAMP
PERMIT STAMP AND PROFESSIONAL STAMP AFFIXED ABOVE SHALL APPLY ONLY TO REV(S)	-

MAN. FAC. BTRY. & GAS PLANT

MAN. LBL. 01-20-028-21 W4M

FAC. TYPE BATTERY

LBL. 01-20-028-21 W4M

SCALE NTS (A1 Size)

SPC No. BRT-13-480

ENCANA CO. BRT CONSULTING LTD.

TITLE PIPING AND INSTRUMENTATION DIAGRAM REFRIGERATION SYSTEM/K-107

AREA WAYNE

CLASS FILE NO. A WN00632B