


**DIMENSION TOLERANCES**

THE DIMENSIONS SHOWN FOR LOCATION OF PROCESS/SERVICE CONNECTIONS ARE 1/8" UNLESS OTHERWISE NOTED.

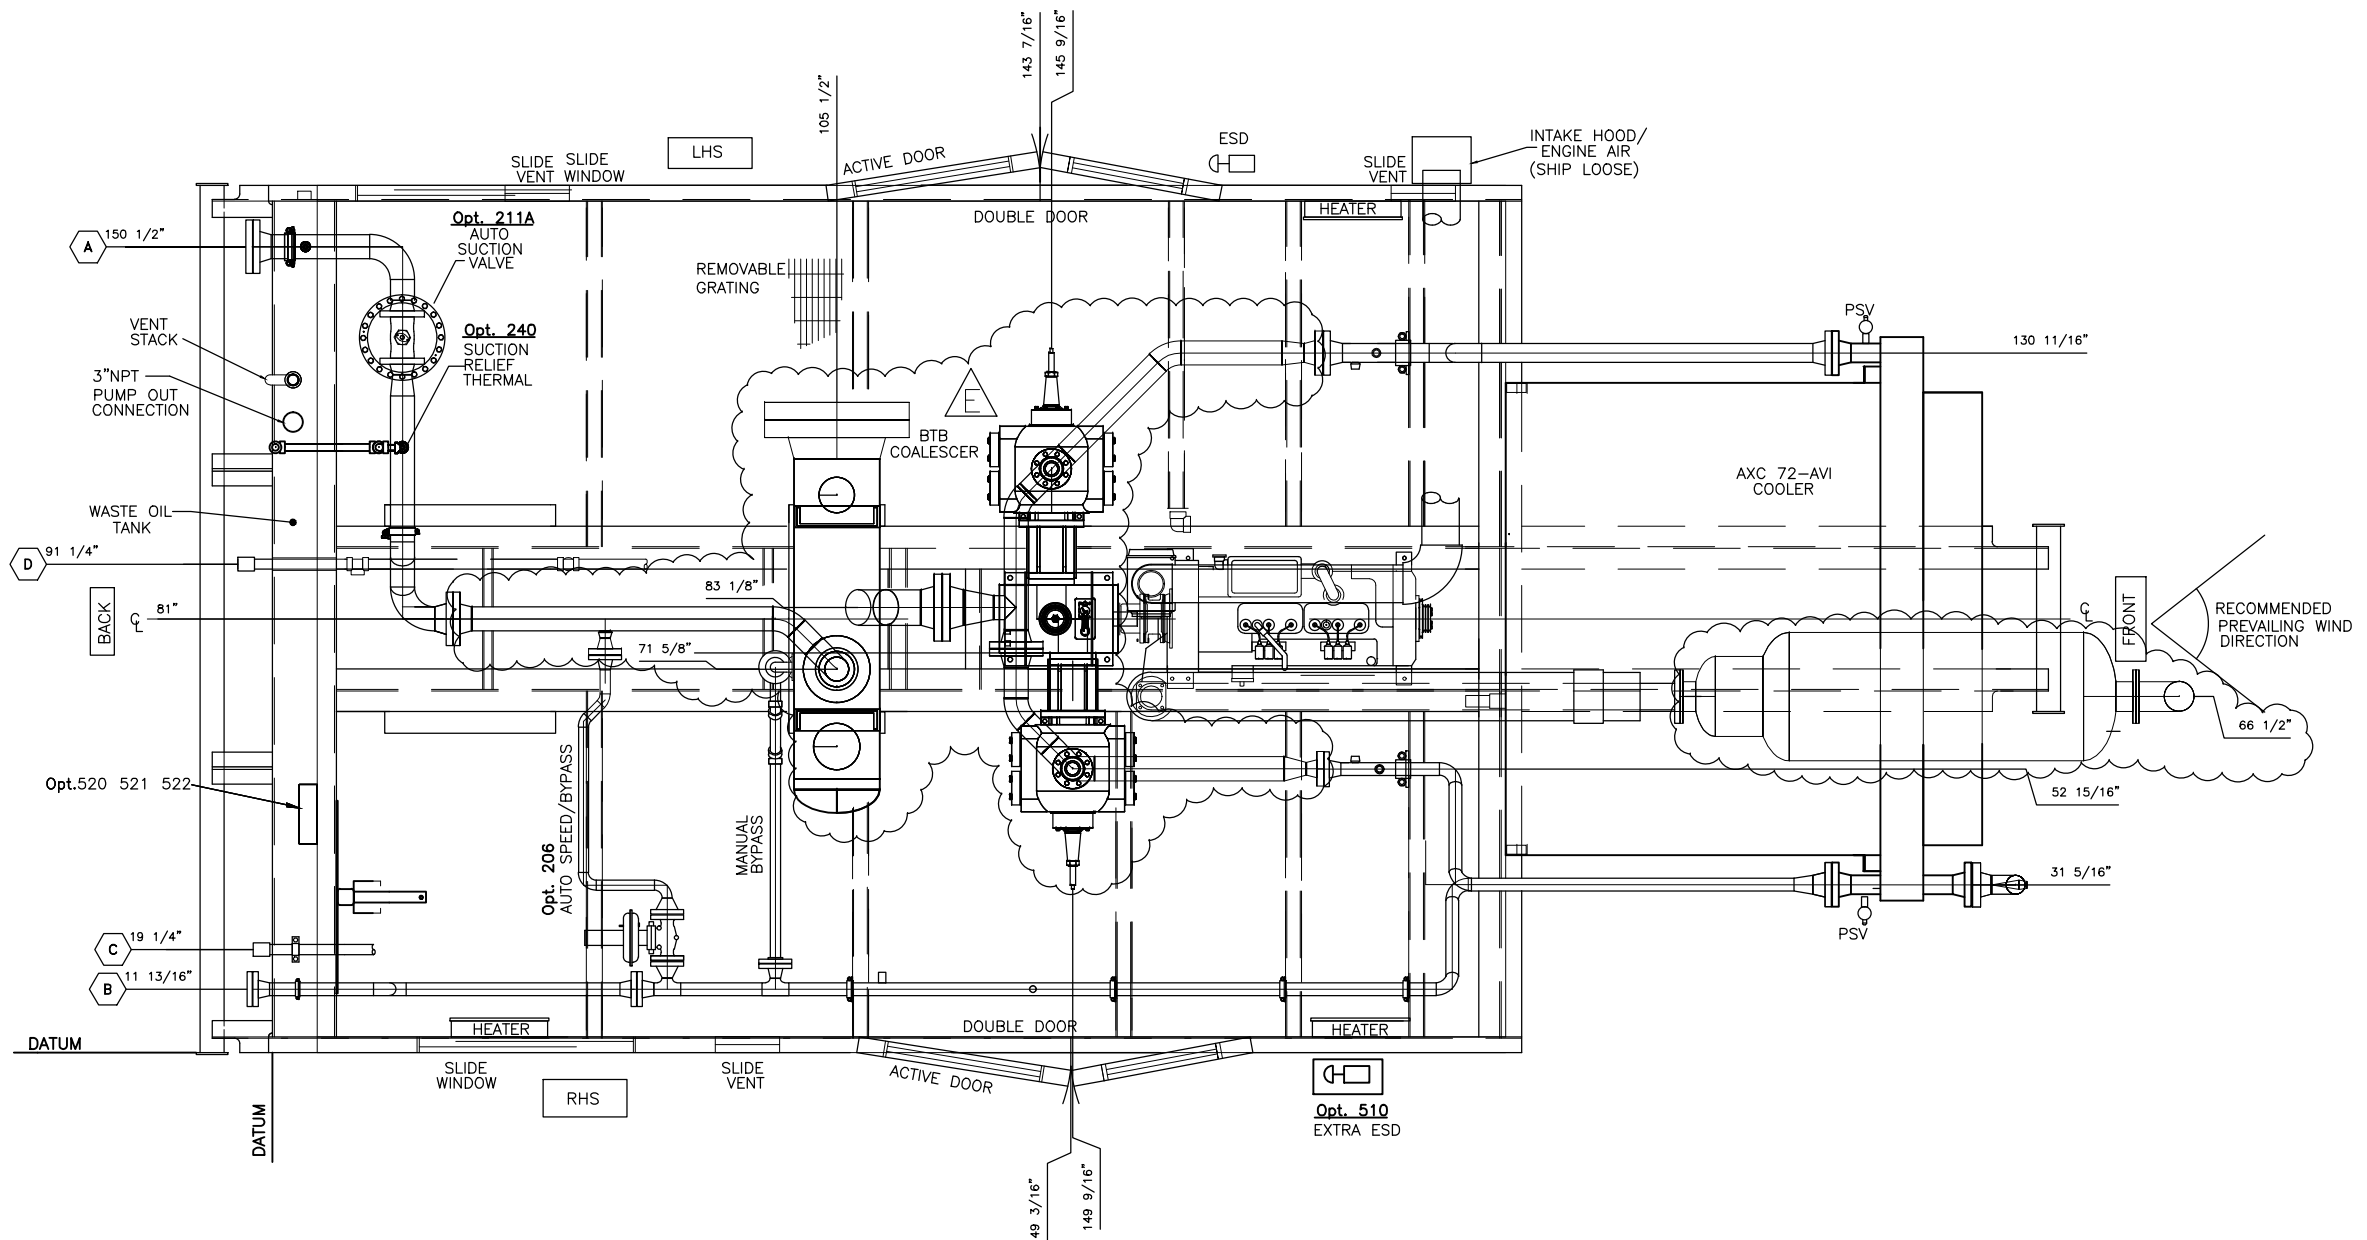

- NOTES:**
1. ALL DIMENSIONS ARE IN mm UNLESS OTHERWISE NOTED.
  2. NOZZLE LOCATIONS ARE SUBJECT TO COMPOUND TOLERANCES.

B200 FIELD CONNECTIONS				OPTIONS			
ITEM	CONNECTION	SIZE	RATING	OPT#	DESCRIPTION	OPT#	DESCRIPTION
A	SUCTION	4"	600#RF	206	AUTO SPEED/BYPASS	510	EXTRA ESD
B	DISCHARGE	2"	600#RF	210A	AUTO SUCTION VALVE	523	ADDITIONAL HEATER
C	UTILITY GAS INLET	1 1/2"	NPT	240	SUCTION RELIEF - THERMAL PORT		
D	COALESCER DRAIN	1 1/2"	NPT				

DRAWING NO	REFERENCE DRAWINGS	REV	REVISION DESCRIPTION	BY	DATE	CHKD	APPD
		E	PIPING LAYOUT CHANGED/IFC	LJ	11/30/12	DM	
		D	AS PER SCOPE OF SUPPLY/IFC	LJ	11/29/12	DM	
		C	PRELIMINARY ISSUE FOR COMPLETION	GRT	2001-11-16	MH	
		B	PRELIMINARY	WAT	2001-09-17	MH	
		A	NEW DRAWING FOR 010201	HL	04/09/01	MH	

ENGINEERING RECORD	
DRAWN BY GRTAYLARAN	DATE 1998-08-21
CHKD BY	
ENGINEER ANWAR BASHIR	
SHEET 5 of 6	
APPD	

**ISSUED FOR CONSTRUCTION**  
NAME: L. JORJAN/STON. DATE: 12/03/12

**ENERFLEX**

AREA/PROJECT -  
CONSULTANT -  
TITLE  
**GENERAL ARRANGEMENT (PLAN)  
B200 - SINGLE STAGE**

SCALE: 1:1  
CONTR DWG NO: -  
DWG NO: GA-010201-C-PLAN  
REV: E