


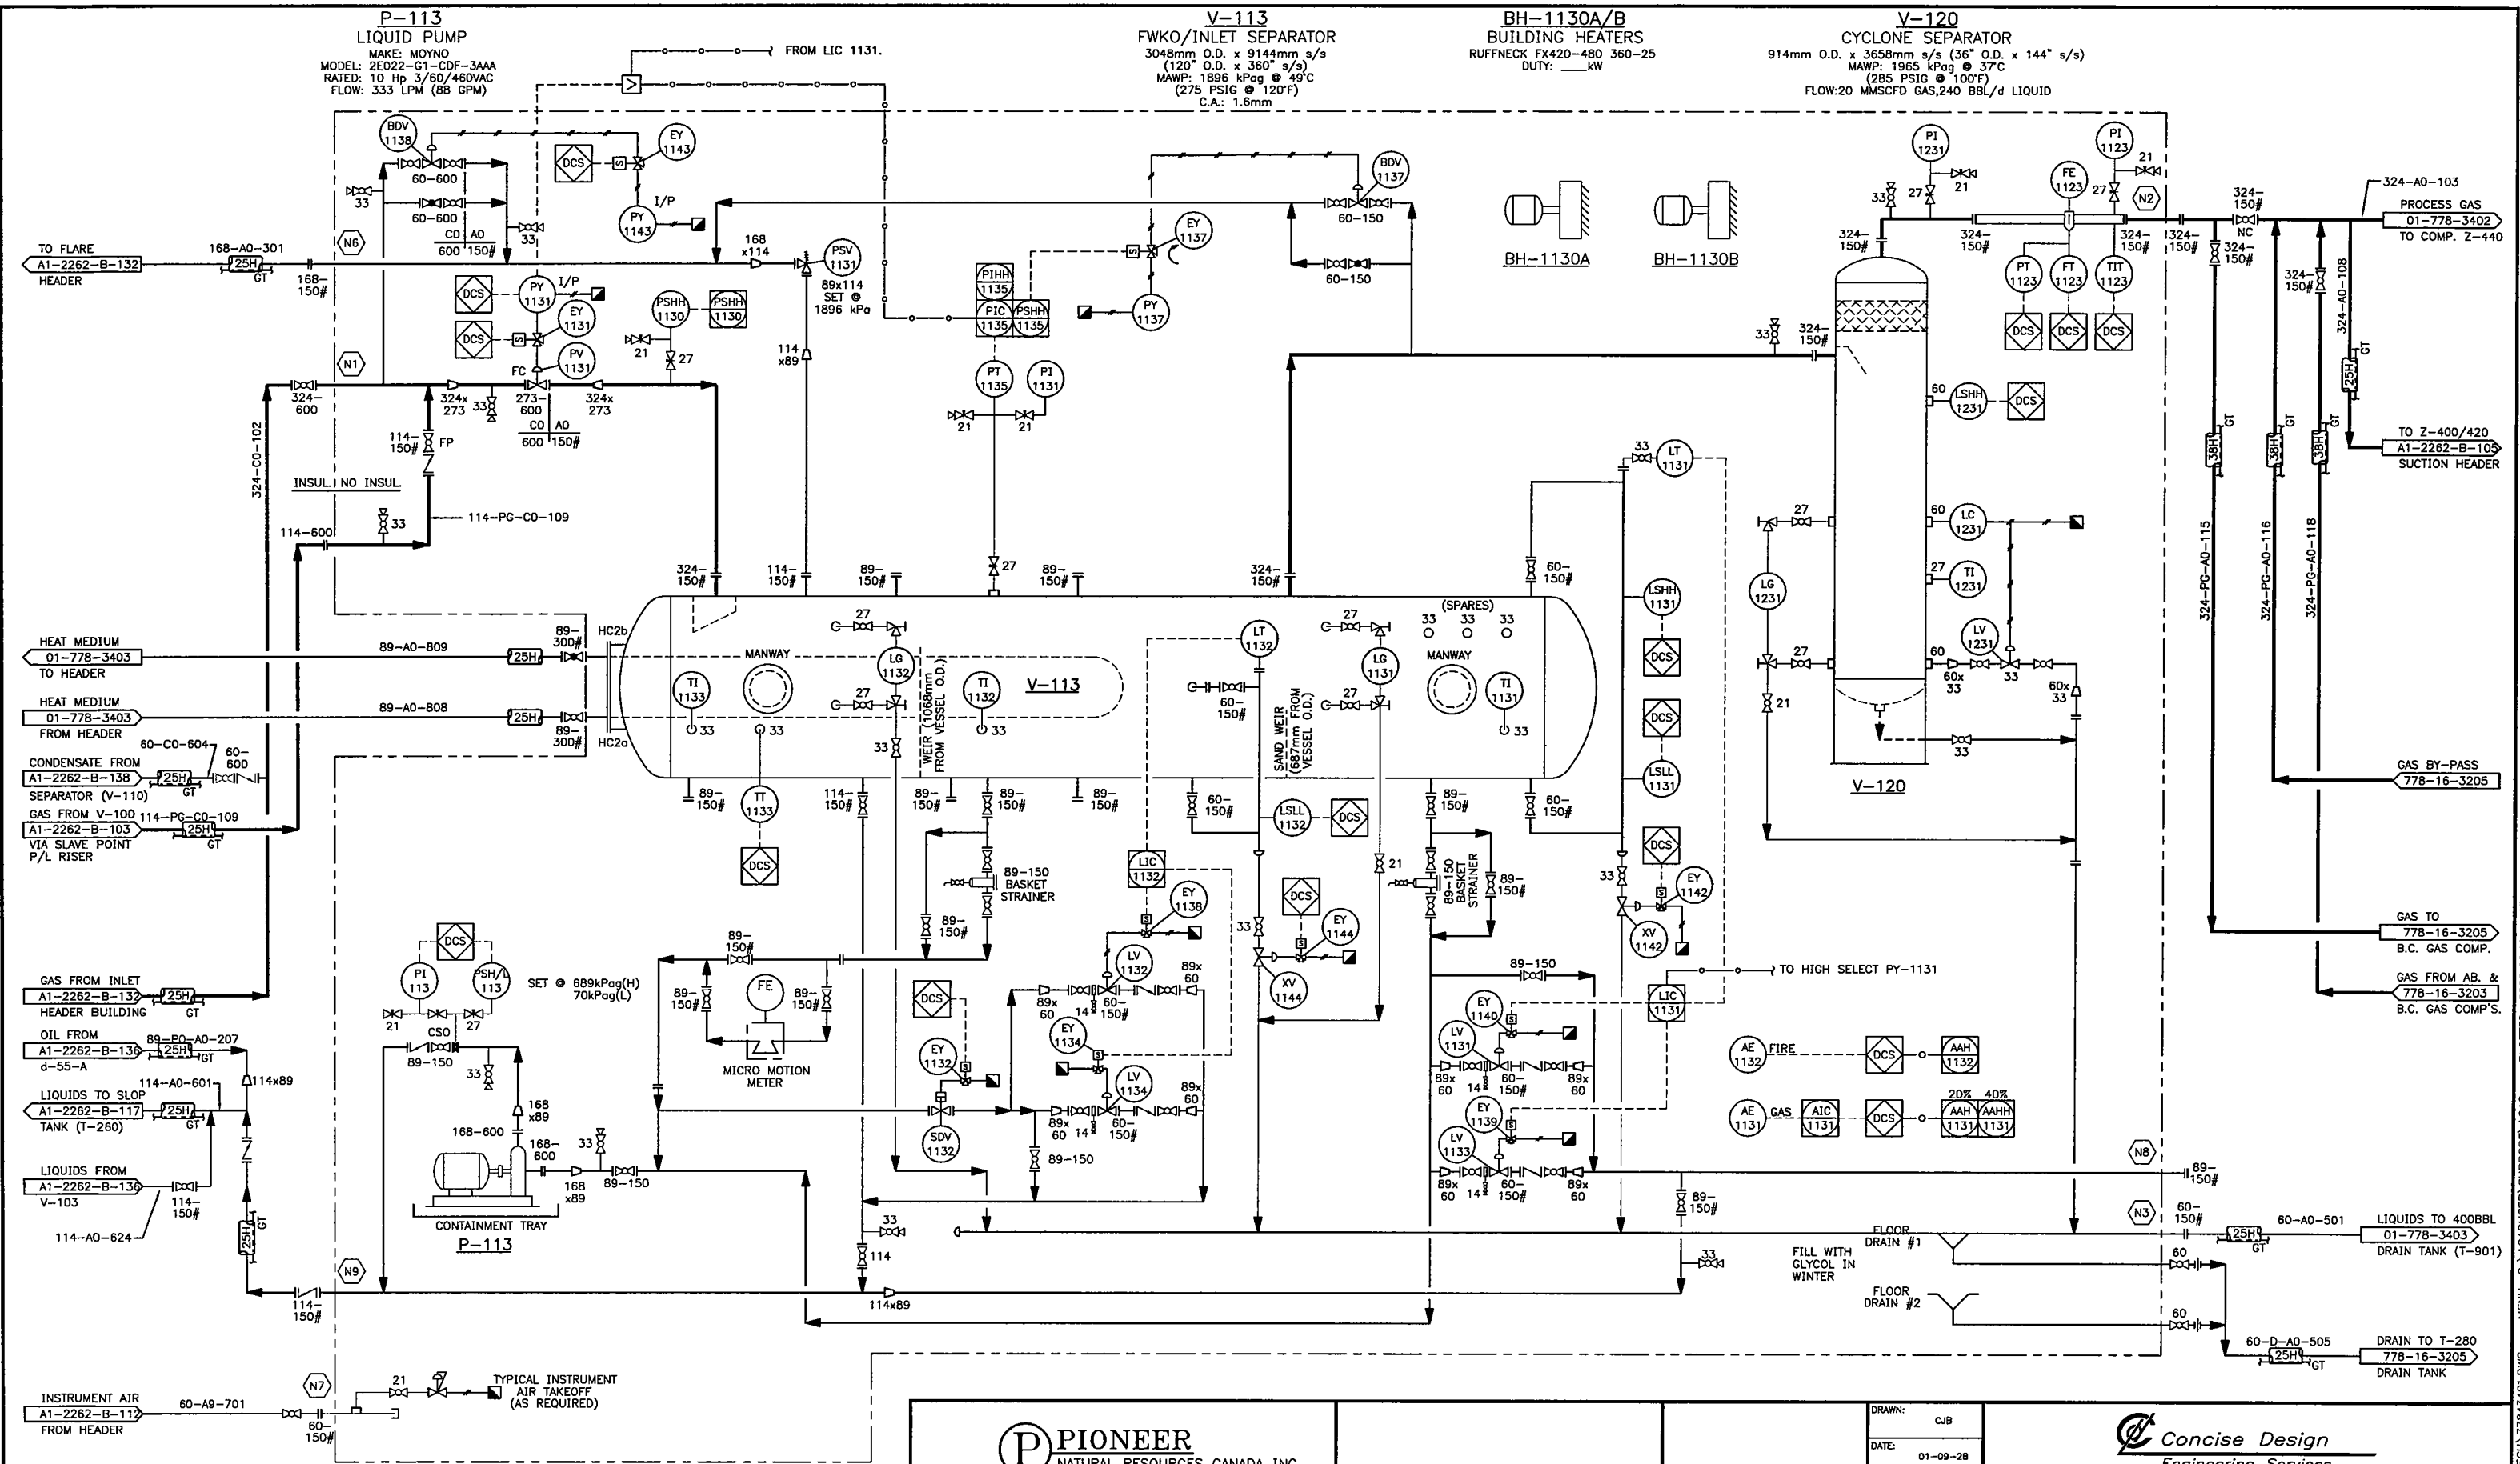

NOTES:
 THIS DRAWING IS OF A CONFIDENTIAL NATURE AND SHALL NOT BE REPRODUCED IN ANY MANNER, NOR USED FOR ANY PURPOSE WHATSOEVER EXCEPT BY WRITTEN PERMISSION OF CONCISE DESIGN.
 THIS DRAWING IS NOT APPROVED FOR CONSTRUCTION UNLESS SIGNED AND DATED. DESTROY ALL DRAWINGS BEARING EARLIER DATE AND/OR REVISION NUMBER.

NO.	DATE	REVISIONS	DRAWN	CHK.	APPD.
12	05-12-23	GAS PLANT EXPANSION (778.16) - ISSUED FOR CONSTRUCTION	ME		
11	05-11-18	GAS PLANT EXPANSION (778.16) - ISSUED FOR OGC PERMIT	ME		
10	05-03-15	CNRL TIE-IN (02-778.08) - AS BUILT	KMM		
9	04-10-23	CNRL TIE-IN (ISSUED FOR CONSTRUCTION) (CONCISE PRJ# 778.08)	PS		
13	06-03-31	2006 AS-BUILT (778.16)	GX		

PIONEER
NATURAL RESOURCES CANADA INC.

DRAWN: CJB
DATE: 01-09-28

CHK'D:

APPR'D:

SCALE: NONE

CONCISE PROJ. No. 01-778.04

CONCISE FILE No. 77843401

CLIENT DWG. No.

CONCISE DWG. No. 01-778-3401

REV. 13

Concise Design
Engineering Services

300, 736 - 6 Avenue S.W. Calgary, Alberta T2P 3W1 Telephone: (403) 237-7160 Fax: (403) 237-7166

PIONEER NATURAL RESOURCES CANADA INC

CHINCHAGA c-32-H, 94-H-8 GAS PLANT EXPANSION


FWKO/SEPARATOR V-113

PROCESS & INSTRUMENTATION DIAGRAM

FILE NAME: G:\778.04\MECH\77843401.DWG --- MENU: C:\ACADUSER\SUPPORT\ACAD --- PLOTTED: 2006.06.19 11:27am --- jndling

REF. DATUM ELEVATION AT
T.O.S. PIPERACK N 1+16 600, W 0+07 865
PLANT ELEV. 101.313 = GEODETIC ELEV. 787.23m

PIPE SHOES & GUIDES	
STD PIPE SHOE w/o GUIDES	
STD PIPE SHOE c/w GUIDES	
HEAVY DUTY CLAMP GUIDES FOR LINES w/o SHOES	
STD PIPE ANCHOR c/w SHOE	
CLAMP TYPE PIPE SHOE w/o GUIDES	
CLAMP TYPE PIPE SHOE c/w GUIDES	
SEE DWG A1-2262-F-001 & F-002 FOR DETAILS	

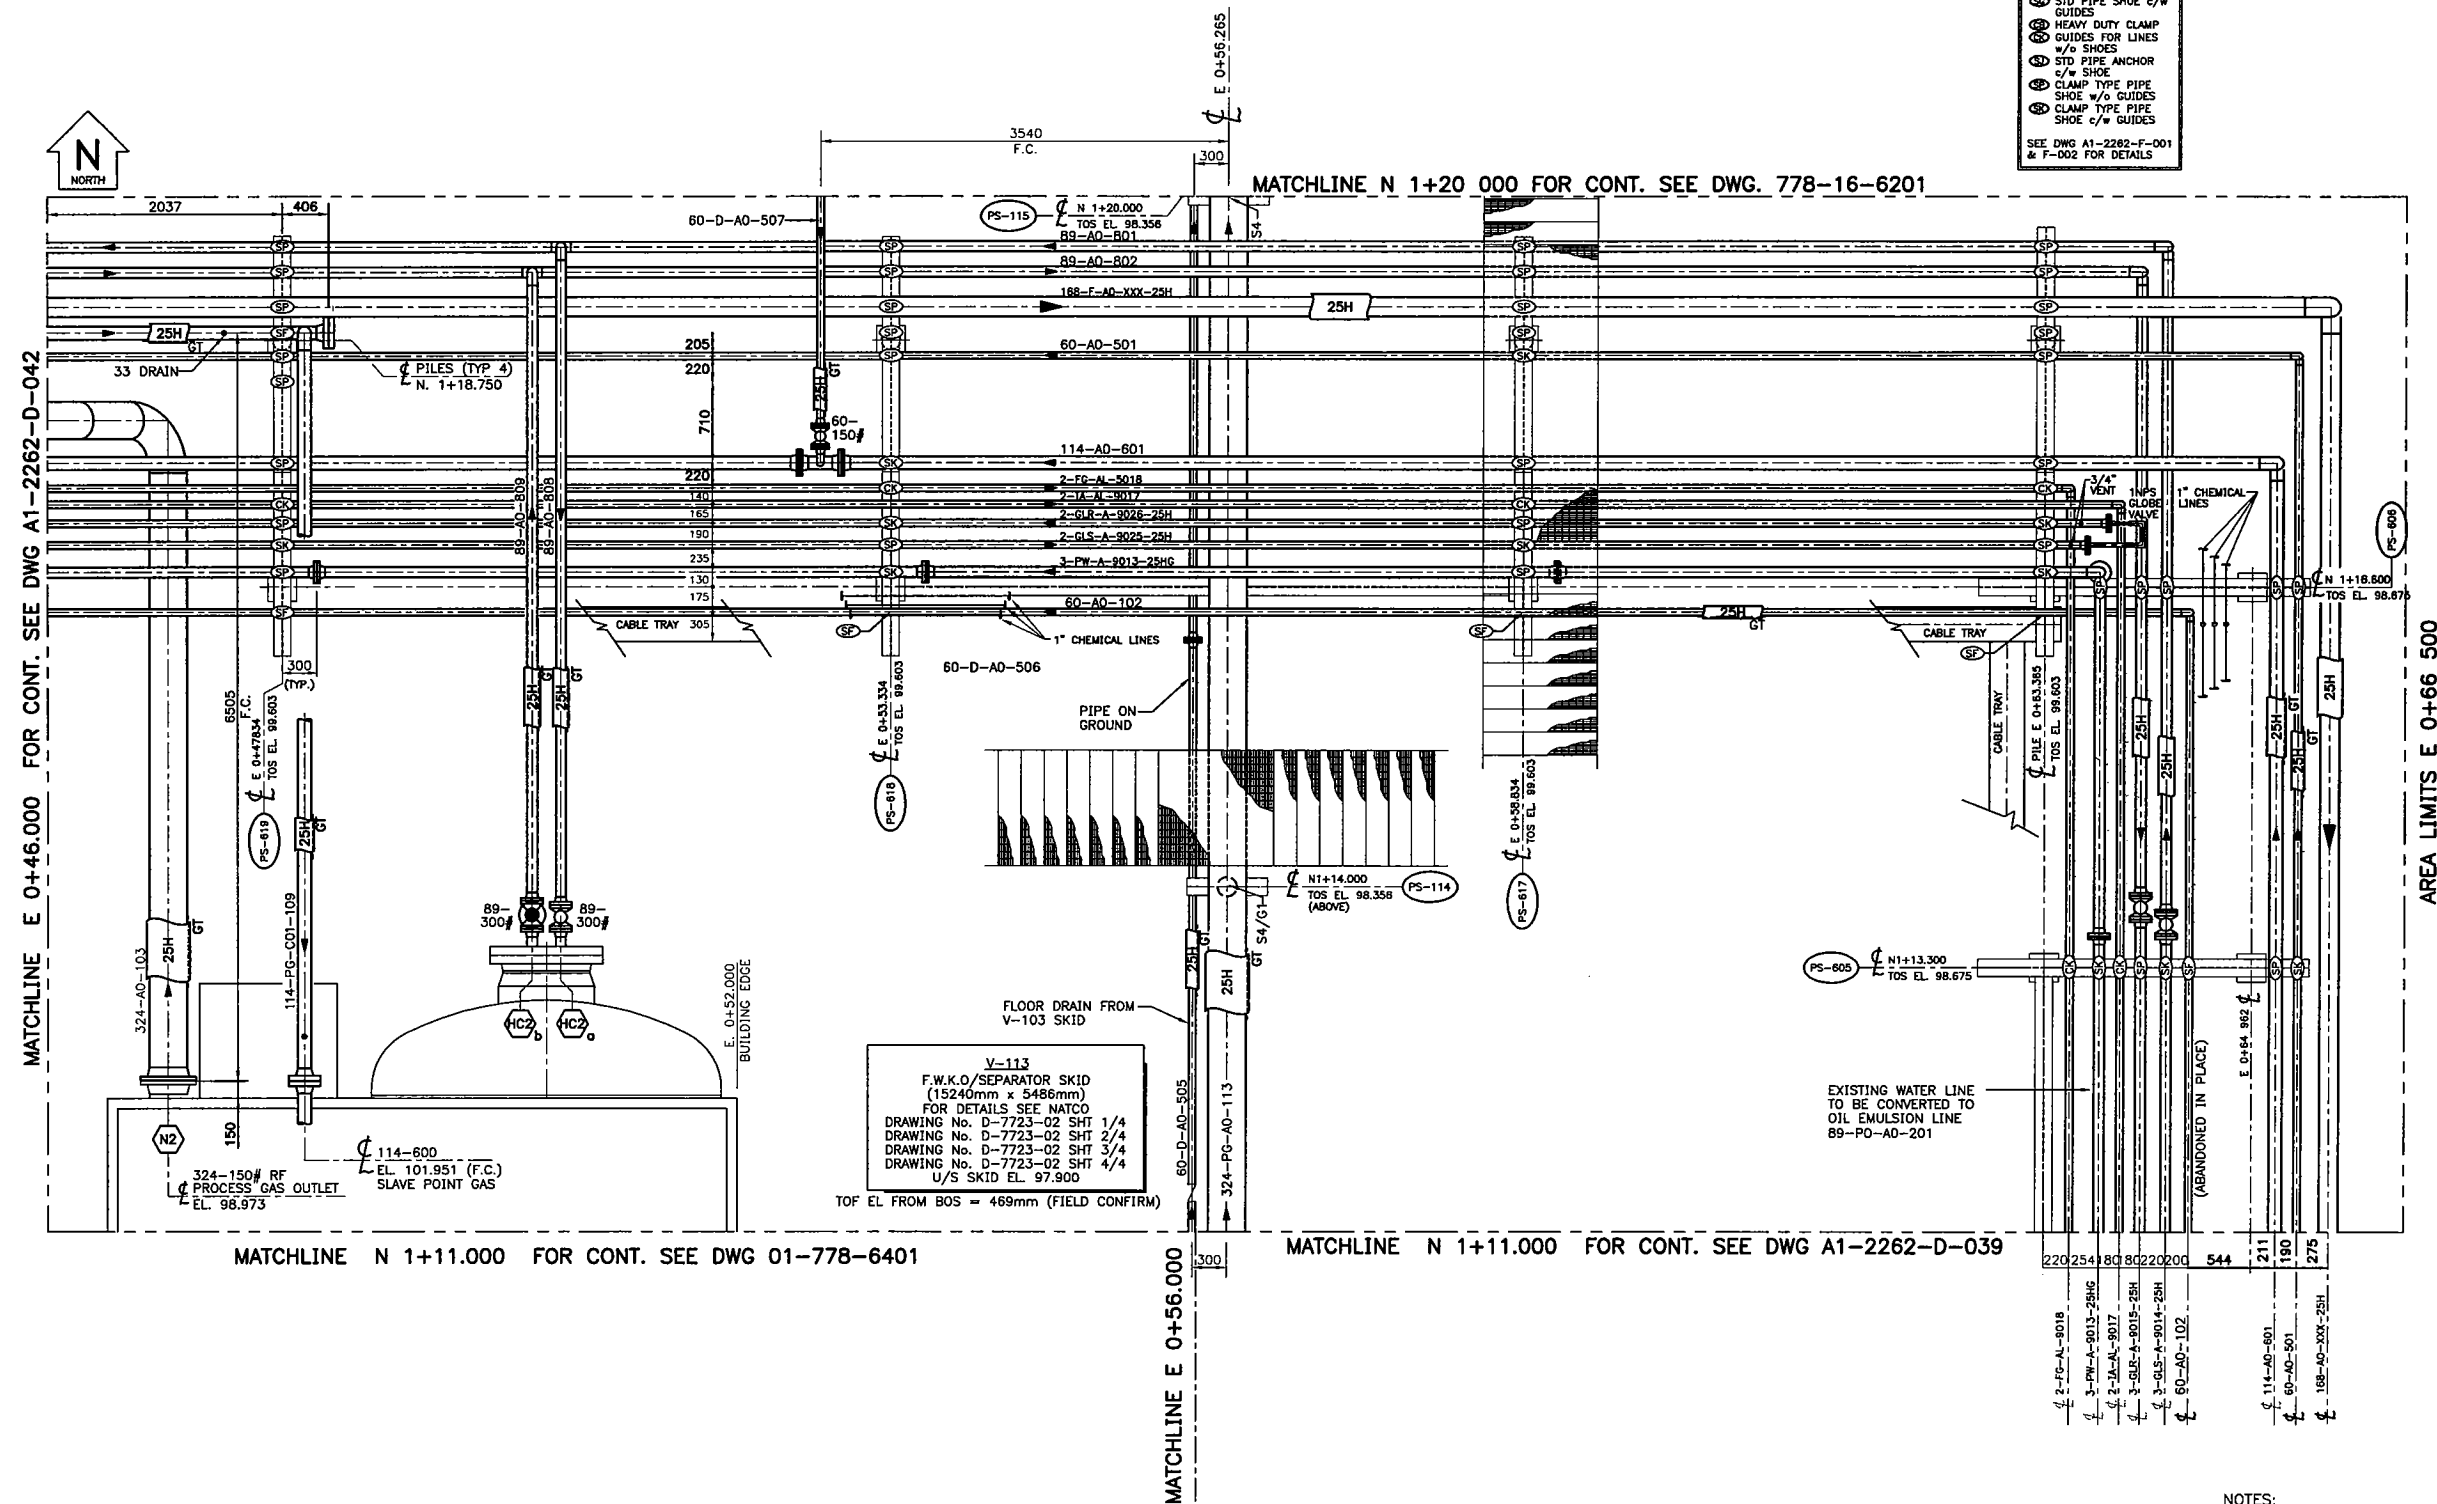

REFERENCE DRAWINGS

DRAWING NUMBER	DRAWING NAME
A1-2262-C-001	PLOT PLAN
A1-2262-C-002	KEY PLAN
PNR1.8-A1-J-101-01	STRUCTURAL STEEL PLAN

Concise Design
Engineering Services

300, 736 - 6 Avenue S.W. Calgary, Alberta T2P 3W1 Telephone: (403) 237-7160 Fax: (403) 237-7166

CIMARRON Engineering Ltd.
Calgary Alberta


REV	REVISION DESCRIPTION	DATE	BY	APPROV
8	CNRL TIE-IN (ISSUED FOR APPROVAL) (CONCISE PRJ# 778.08)	04-10-23	PS	
7	CNRL TIE-IN (ISSUED FOR APPROVAL) (CONCISE PRJ# 778.08)	04-10-18	PS	
6	2001/2002 PLANT EXPANSION (01-778.04) - AS BUILT	02-03-13	GK	
5	2001/2002 PLANT EXPANSION (01-778.04) - ISSUED FOR CONSTRUCTION	01-11-30	CJB	
4	2001/2002 PLANT EXPANSION (01-778.04) - ISSUED FOR BID	01-11-01	CJB	
12	2006 AS-BUILT (778.16)	06-03-31	GK	
11	2006 AS-BUILT (778.16)	06-03-31	GK	
10	GAS PLANT EXPANSION (778.16) - ISSUED FOR CONSTRUCTION	05-12-23	ME	
9	CNRL TIE-IN (02-778.08) - AS BUILT	05-03-15	KMM	

1998/99 BC CHINCHAGA GAS DEVELOPMENT
CHINCHAGA GAS PLANT
c-32-H/94-H-8
PIPE RACK - PIPING PLAN

DRN BY	DATE	CHD BY	DATE
RBB	99/01/28	RGC	99/02/16
APRD BY	DATE	SCALE	PROJECT NO
GG	99/02/16	1:30	PNR101-8

PIONEER
NATURAL RESOURCES CANADA INC.

DRAWING NO	REV
A1-2262-D-041	12

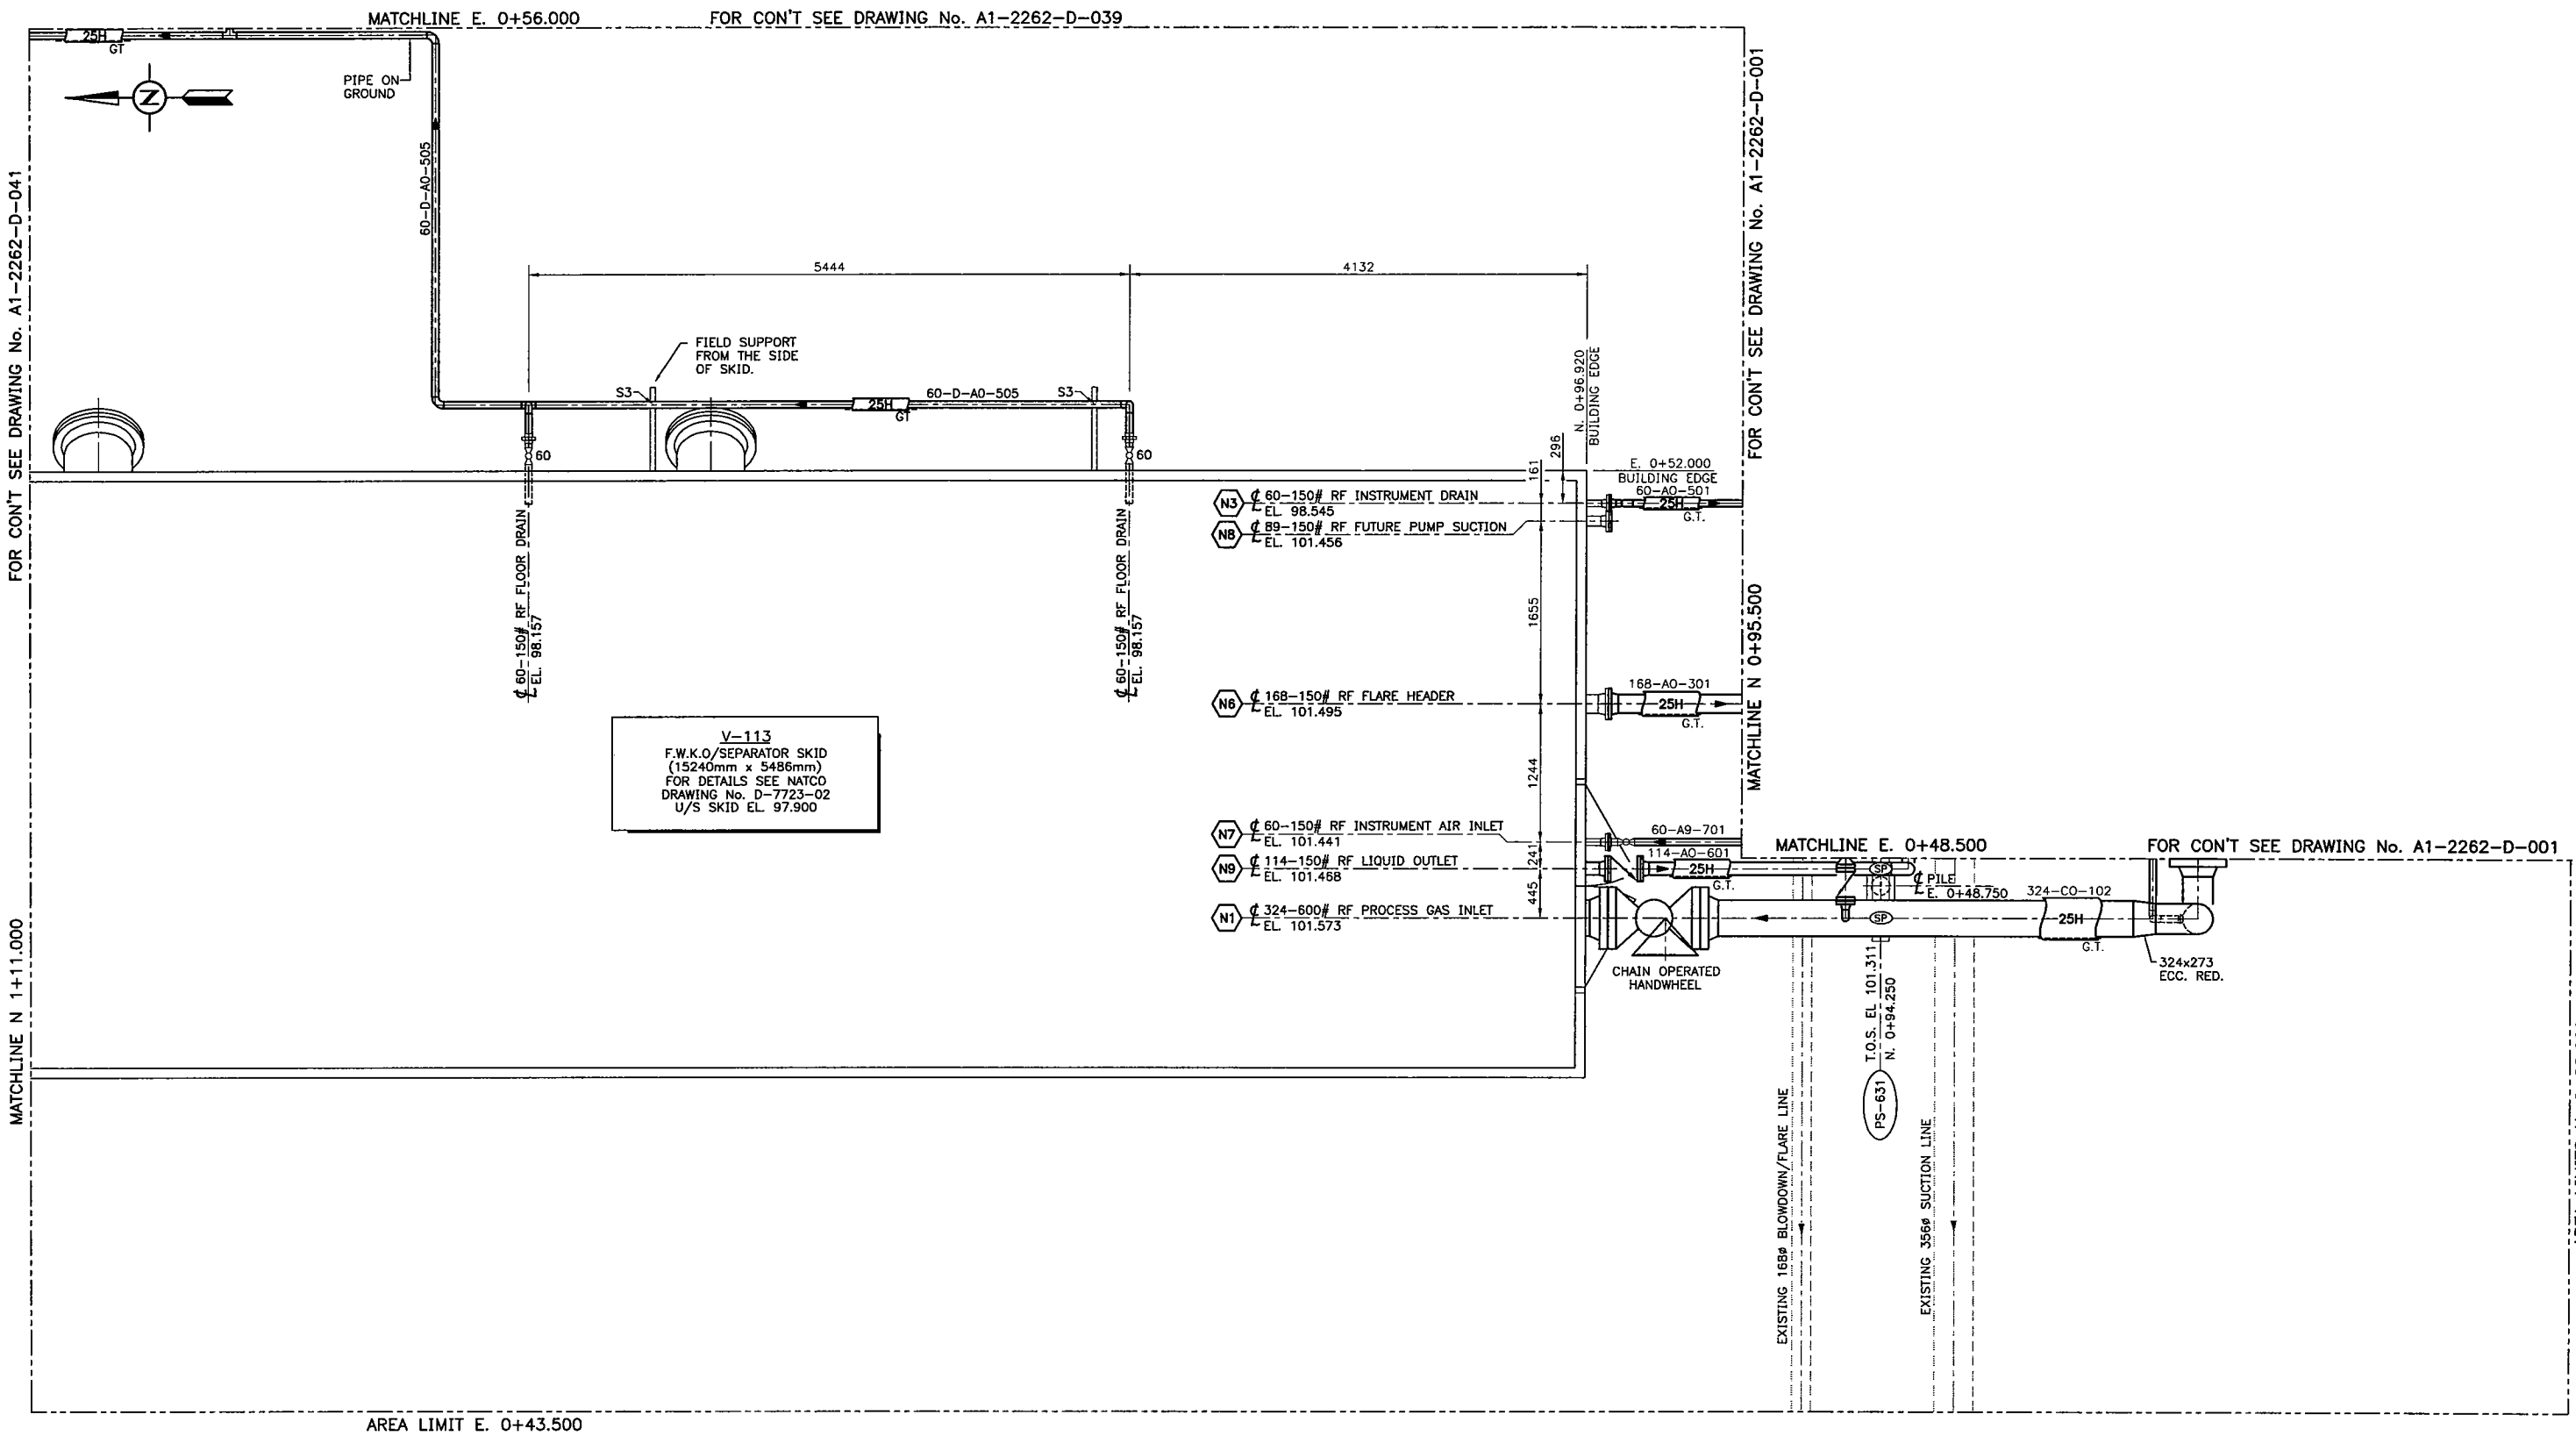

NOTES:

THIS DRAWING IS OF A CONFIDENTIAL NATURE AND SHALL NOT BE REPRODUCED IN ANY MANNER, NOR USED FOR ANY PURPOSE WHATSOEVER EXCEPT BY WRITTEN PERMISSION OF CONCISE DESIGN.

THIS DRAWING IS NOT APPROVED FOR CONSTRUCTION UNLESS SIGNED AND DATED. DESTROY ALL DRAWINGS BEARING EARLIER DATE AND/OR REVISION NUMBER.

2	05-12-23	GAS PLANT EXPANSION (778.16) - ISSUED FOR CONSTRUCTION	ME		
1	02-03-13	AS BUILT	GX		
0	01-11-30	ISSUED FOR CONSTRUCTION	CJB		
B	01-11-01	ISSUED FOR BID	CJB		
3	06-03-31	2008 AS-BUILT (778.16)	GX		
No	DATE	REVISIONS	DRAWN	CHK.	APPD.

PIONEER
NATURAL RESOURCES CANADA INC.

DRAWN:	CJB
DATE:	01-10-29
CHK'D:	
APPR'D:	
SCALE:	1:30
CONCISE PROJ. No.	01-778.04

CONCISE FILE No.	77846401
CLIENT DWG. No.	
CONCISE DWG. No.	01-778-6401
REV.	3

Concise Design
Engineering Services

300, 736 - 6 Avenue S.W. Calgary, Alberta T2P 3W1 Telephone: (403) 237-7160 Fax: (403) 237-7166

PIONEER NATURAL RESOURCES CANADA INC.

CHINCHAGA c-32-H, 94-H-8 GAS PLANT EXPANSION
F.W.K.O./INLET SEPARATOR V-113
PIPING PLAN

FILE NAME: C:\ACADUSER\MECH\77846401.DWG --- MENU: C:\ACADUSER\SUPPORT\ACAD --- PLOTTED: 2006.06.19 1:20pm --- jmolina

