
 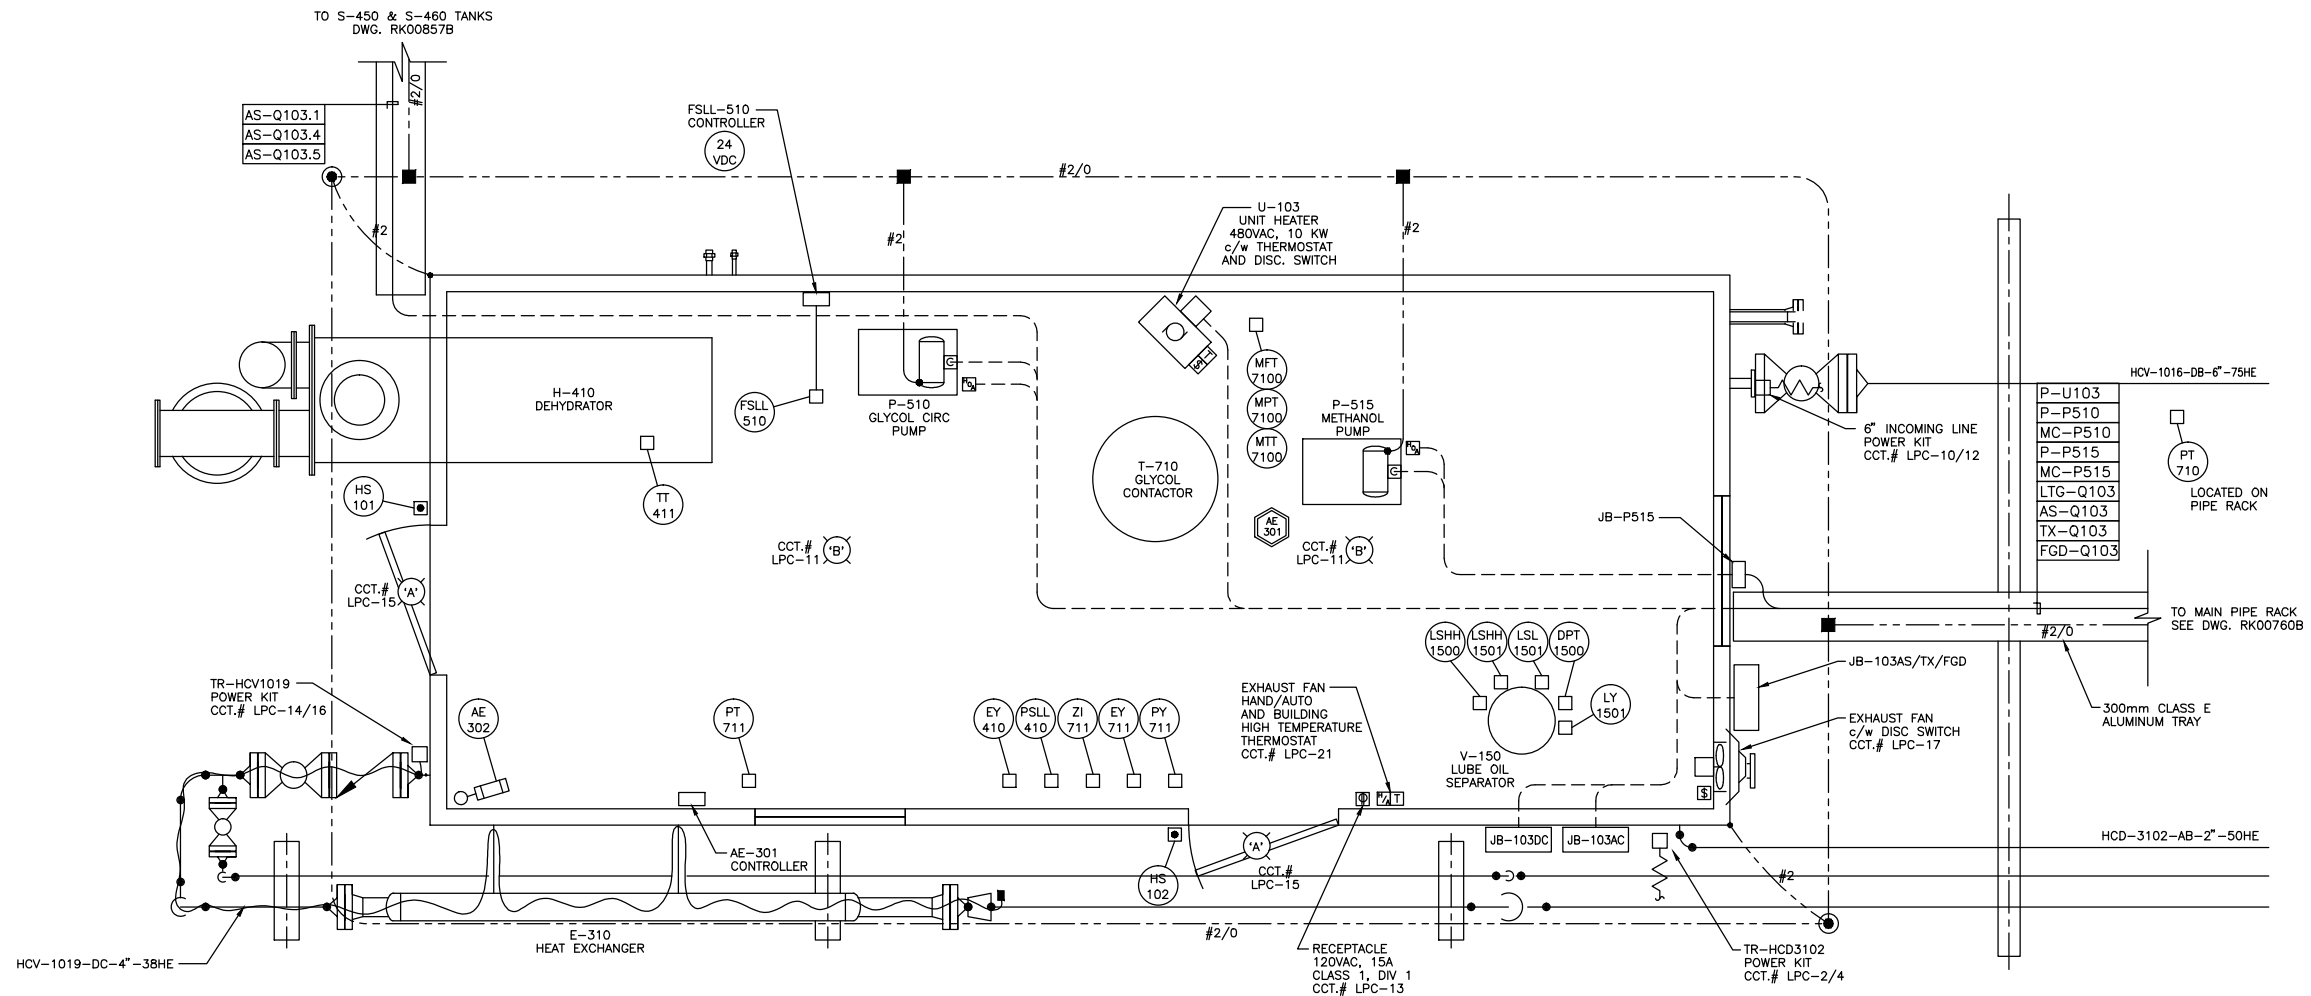


Q-103
GLYCOL DEHYDRATOR
(7925l x 3353w x ____eave)
(26' x 11' x ____)

LIGHTING FIXTURE LIST		
LIGHT I.D.	DESCRIPTION	FIXTURE MAKE & MODEL
(A)	70W, 120VAC, HPS, WALL MOUNTED FIXTURE c/w BALLAST, GLOBE, GUARD AND ANGLE REFLECTOR CLASS 1, DIVISION 2, GROUP D, TEMP CODE T2A	CROUSE-HINDS LMVSTW070GP/120 c/w RA636
(B)	175W, 120VAC, METAL HALIDE, CEILING MOUNT FIXTURE c/w BALLAST, GLOBE, GUARD & DOME REFLECTOR CLASS 1, DIVISION 1, T-CODE T3C	CROUSE-HINDS EVLPCX192171/120 c/w RD739



T-40224000 (ENCANA AT Site) Rev 03

REFERENCE DRAWINGS		DWG. NO.	NO.	DATE	PROJECT DESCRIPTION	PROJ.	AFE	EPCM Co.	EPCM No.	APPD.	ISSUE STAGE	DATE	BY	CHKD.	APPD.	PERMIT STAMP	ENGINEER'S STAMP
Q-105 COMPRESSOR & Q-103 DEHY ADDITION - AS BUILT	-	-	1	2003-06-19	Q-105 COMPRESSOR & Q-103 DEHY ADDITION - AS BUILT	-	-	TARTAN	285400	-	Bld	2004-01-14	CPW	-	-		
Q-103 DEHY METERING RETROFITS	-	-	2	2003-12-03	Q-103 DEHY METERING RETROFITS	-	-	TARTAN	295000	-	Constr.	2004-02-04	CPW	-	-		
Q-106 COMPRESSOR & Q-107 SEPARATOR ADDITION - AS BUILT	-	-	3	2004-01-14	Q-106 COMPRESSOR & Q-107 SEPARATOR ADDITION - AS BUILT	WHED003	0318355	TARTAN	295000	-	As Built	2004-04-28	CPW	-	-		
-	-	-	-	-	-	-	-	-	-	-	-	-	-	-	-		
-	-	-	-	-	-	-	-	-	-	-	-	-	-	-	-		
-	-	-	-	-	-	-	-	-	-	-	-	-	-	-	-		
-	-	-	-	-	-	-	-	-	-	-	-	-	-	-	-		
-	-	-	-	-	-	-	-	-	-	-	-	-	-	-	-		
-	-	-	-	-	-	-	-	-	-	-	-	-	-	-	-		
-	-	-	-	-	-	-	-	-	-	-	-	-	-	-	-		
-	-	-	-	-	-	-	-	-	-	-	-	-	-	-	-		
REV. NUMBER 3C											PERMIT STAMP AND PROFESSIONAL STAMP AFFIXED ABOVE SHALL APPLY ONLY TO REV(s)						-
TARTAN ENGINEERING LTD.																	
ELECTRICAL LAYOUT DEHY BUILDING (Q-103)																	
ROCKYFORD																	