



PRINTED: Monday, January 20, 2014 9:17:34 AM DWG NAME: H:\PROJECTS New NOS\Design Drafting\General\DFR\VID\DFR-52-PR-PI-0006 Rev 0A.dwg  
 UPDATED: Friday, November 15, 2013 3:15:04 PM BY: Manual

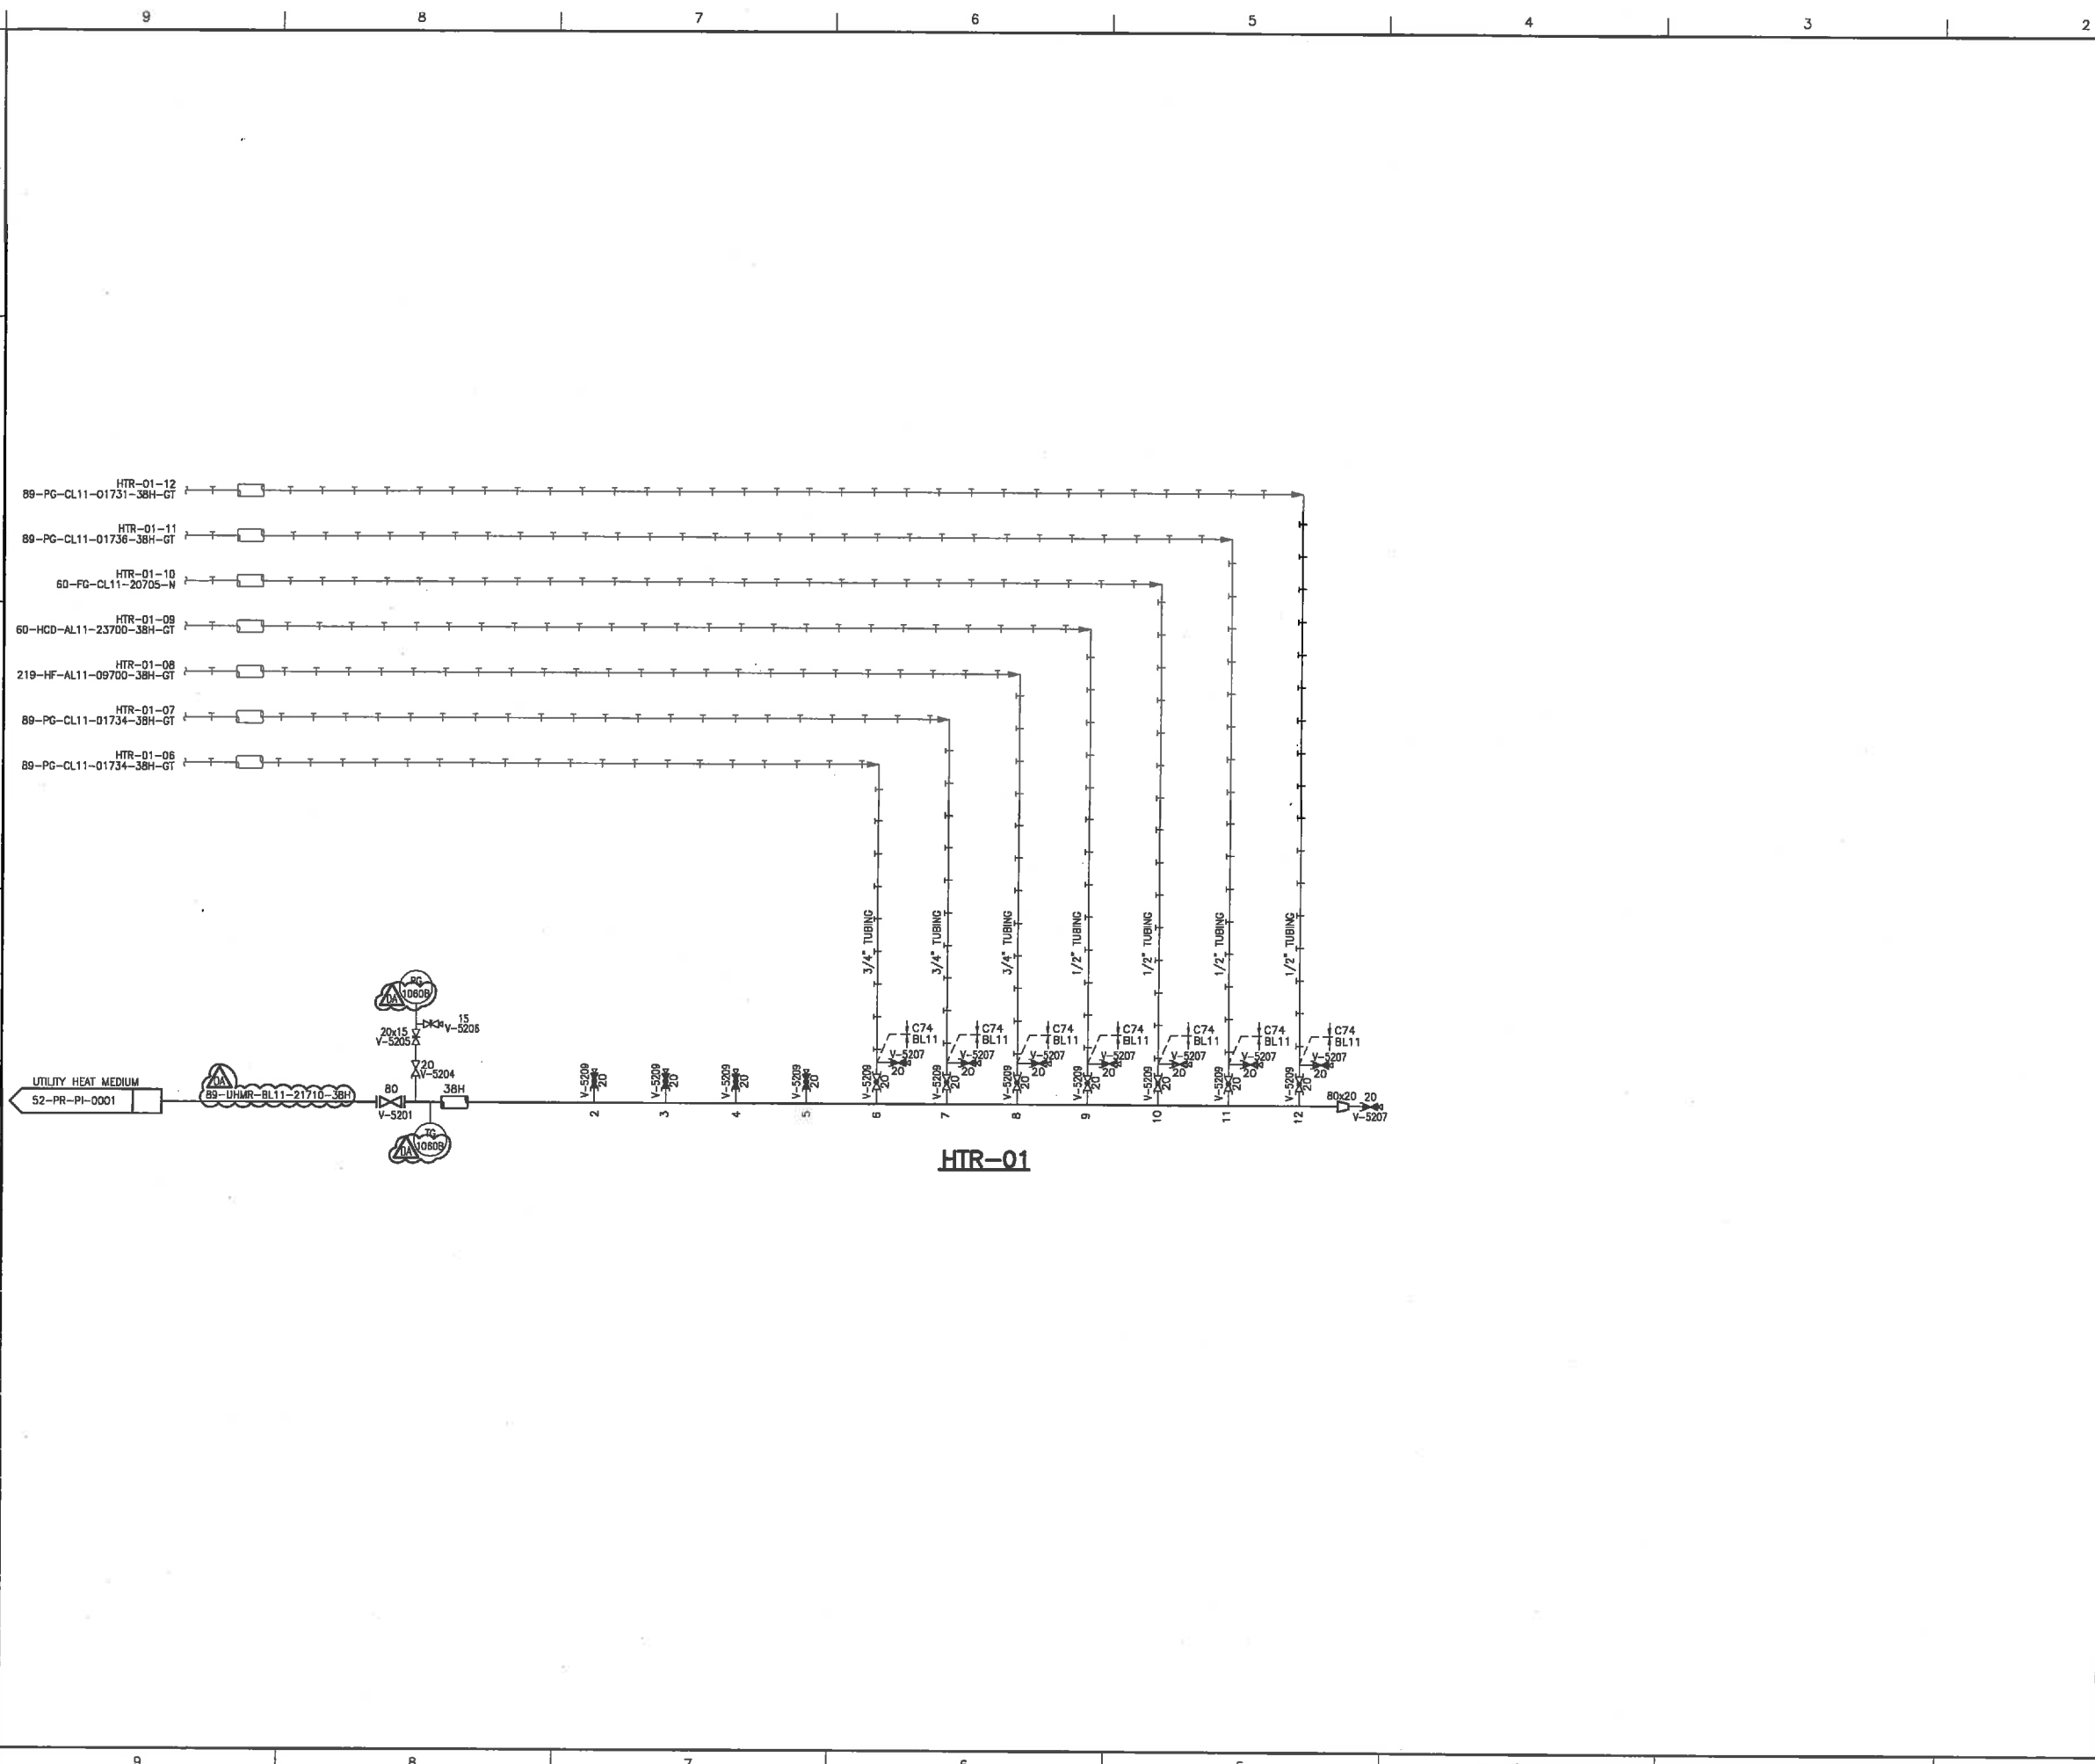

**GENERAL NOTES:**  
 1. PREINSULATED TUBING TO BE USED FOR ALL TRACER CIRCUITS.

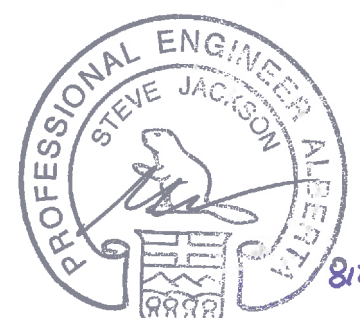

JAN 20, 2014

0A	REVISED AS MARKED	NOV.12/13	MFF
0	RELEASED FOR FABRICATION	OCT.02/13	SSE
NO.	REVISION	DATE	BY
PROJECT NAME: FERRIER CENTRAL PROCESSING FACILITY			
CLIENT: DEVON CANADA c/o WORLEY PARSONS			
DOCUMENT NAME: HEAT TRACING RETURN MANIFOLD #1 PIPING AND INSTRUMENTATION DIAGRAM			
<b>THERMO DESIGN ENGINEERING LTD.</b> DE. & DEV. PRODUCTION EQUIPMENT DESIGN • FABRICATION • INSTALLATION EDMONTON, ALBERTA, CANADA APERGA PERMIT NUMBER: P2800			P. ENG. STAMP: 
<small>THIS DRAWING IS THE CONFIDENTIAL PROPERTY OF TDE AND IS ISSUED ON THE UNDERSTANDING THAT IT IS TO BE USED ONLY FOR THE PROJECT AND NOT TO BE REPRODUCED OR TRANSMITTED TO A THIRD PARTY WITHOUT THE WRITTEN AUTHORIZATION OF TDE.</small>			
TDE JOB NUMBER: 12-118		SHEET: . . . OF . . .	
DOCUMENT NUMBER: DFR-52-PR-PI-0006		REV: . . .	