


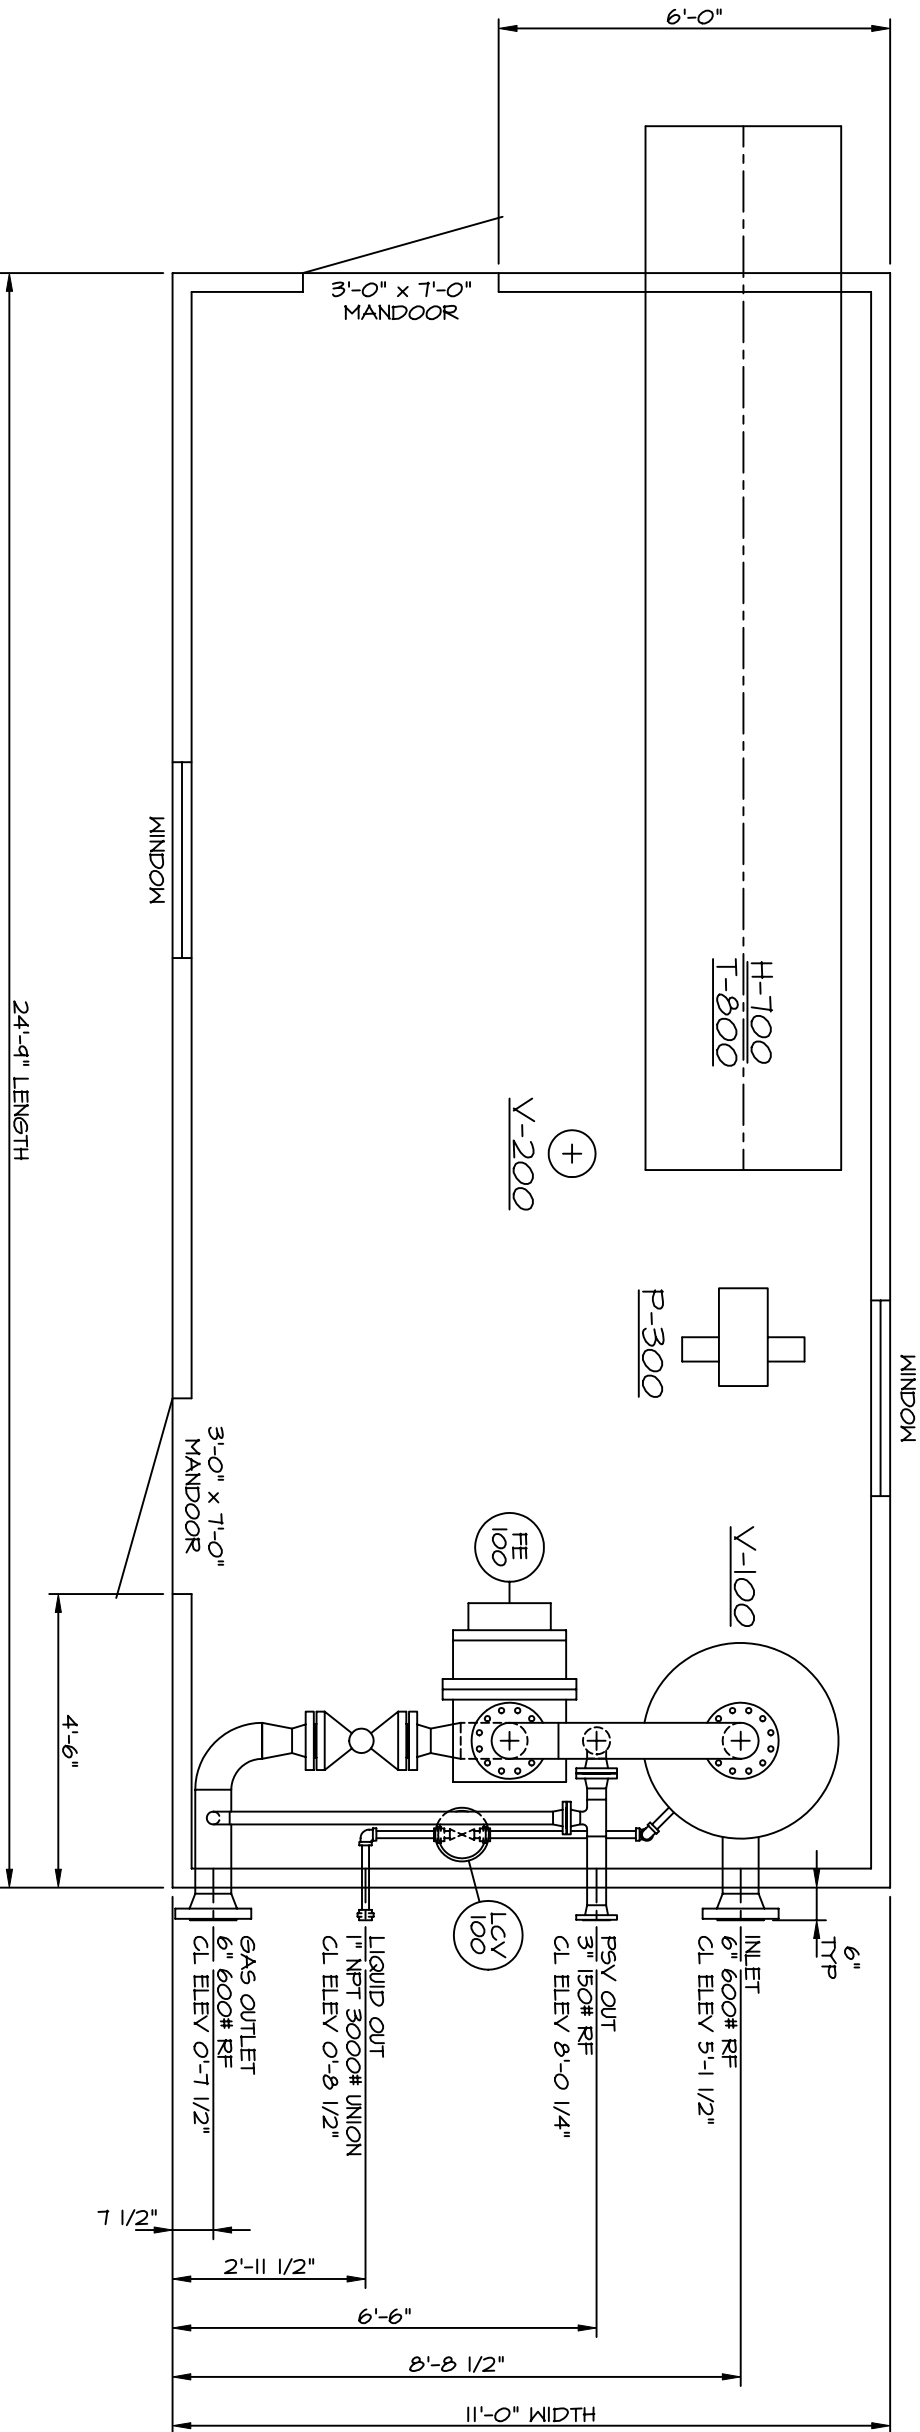

PIPING PLAN VIEW

JOB NO. 2310

- GENERAL NOTES:
- 1. TOP OF SKID, ELEVATION 0'-0"
 - 2. REFERENCE DRAWING: 1440-01 P&ID 1440-03 SKID

O	03-02-14	ISSUED FOR APPROVAL	PJD...	MS	
NO.	DATE	REVISION	BY	APP	
ASPIRE ENERGY RESOURCES LTD.					
4304, 39139 HIGHWAY 2A					
RED DEER, AB T4S 2A8					
TELEPHONE: (403) 314-5422 FAX: (403) 314-1823					
CLIENT:					
DATE:	03-02-14	DEHYDRATION PACKAGE			
BDD NO.:	1490	PIPING PLAN VIEW			
CUST. NO.:	2310	11'-0" WIDE x 24'-9" LG			
SCALE:	NTS				
DRAWN BY:	PJD...				
CHECKED BY:	MS				
APP BY:		DWG NO.:	1490-02	REV.	O