


THIS DRAWING AND THE DESIGN IT COVERS ARE CONFIDENTIAL AND THE PROPERTY OF PROPAC SYSTEMS LTD., AND SHALL NOT BE DISCLOSED TO OTHERS OR REPRODUCED IN ANY MANNER OR USED FOR ANY PURPOSE WHATSOEVER EXCEPT BY WRITTEN CONSENT OF PROPAC.

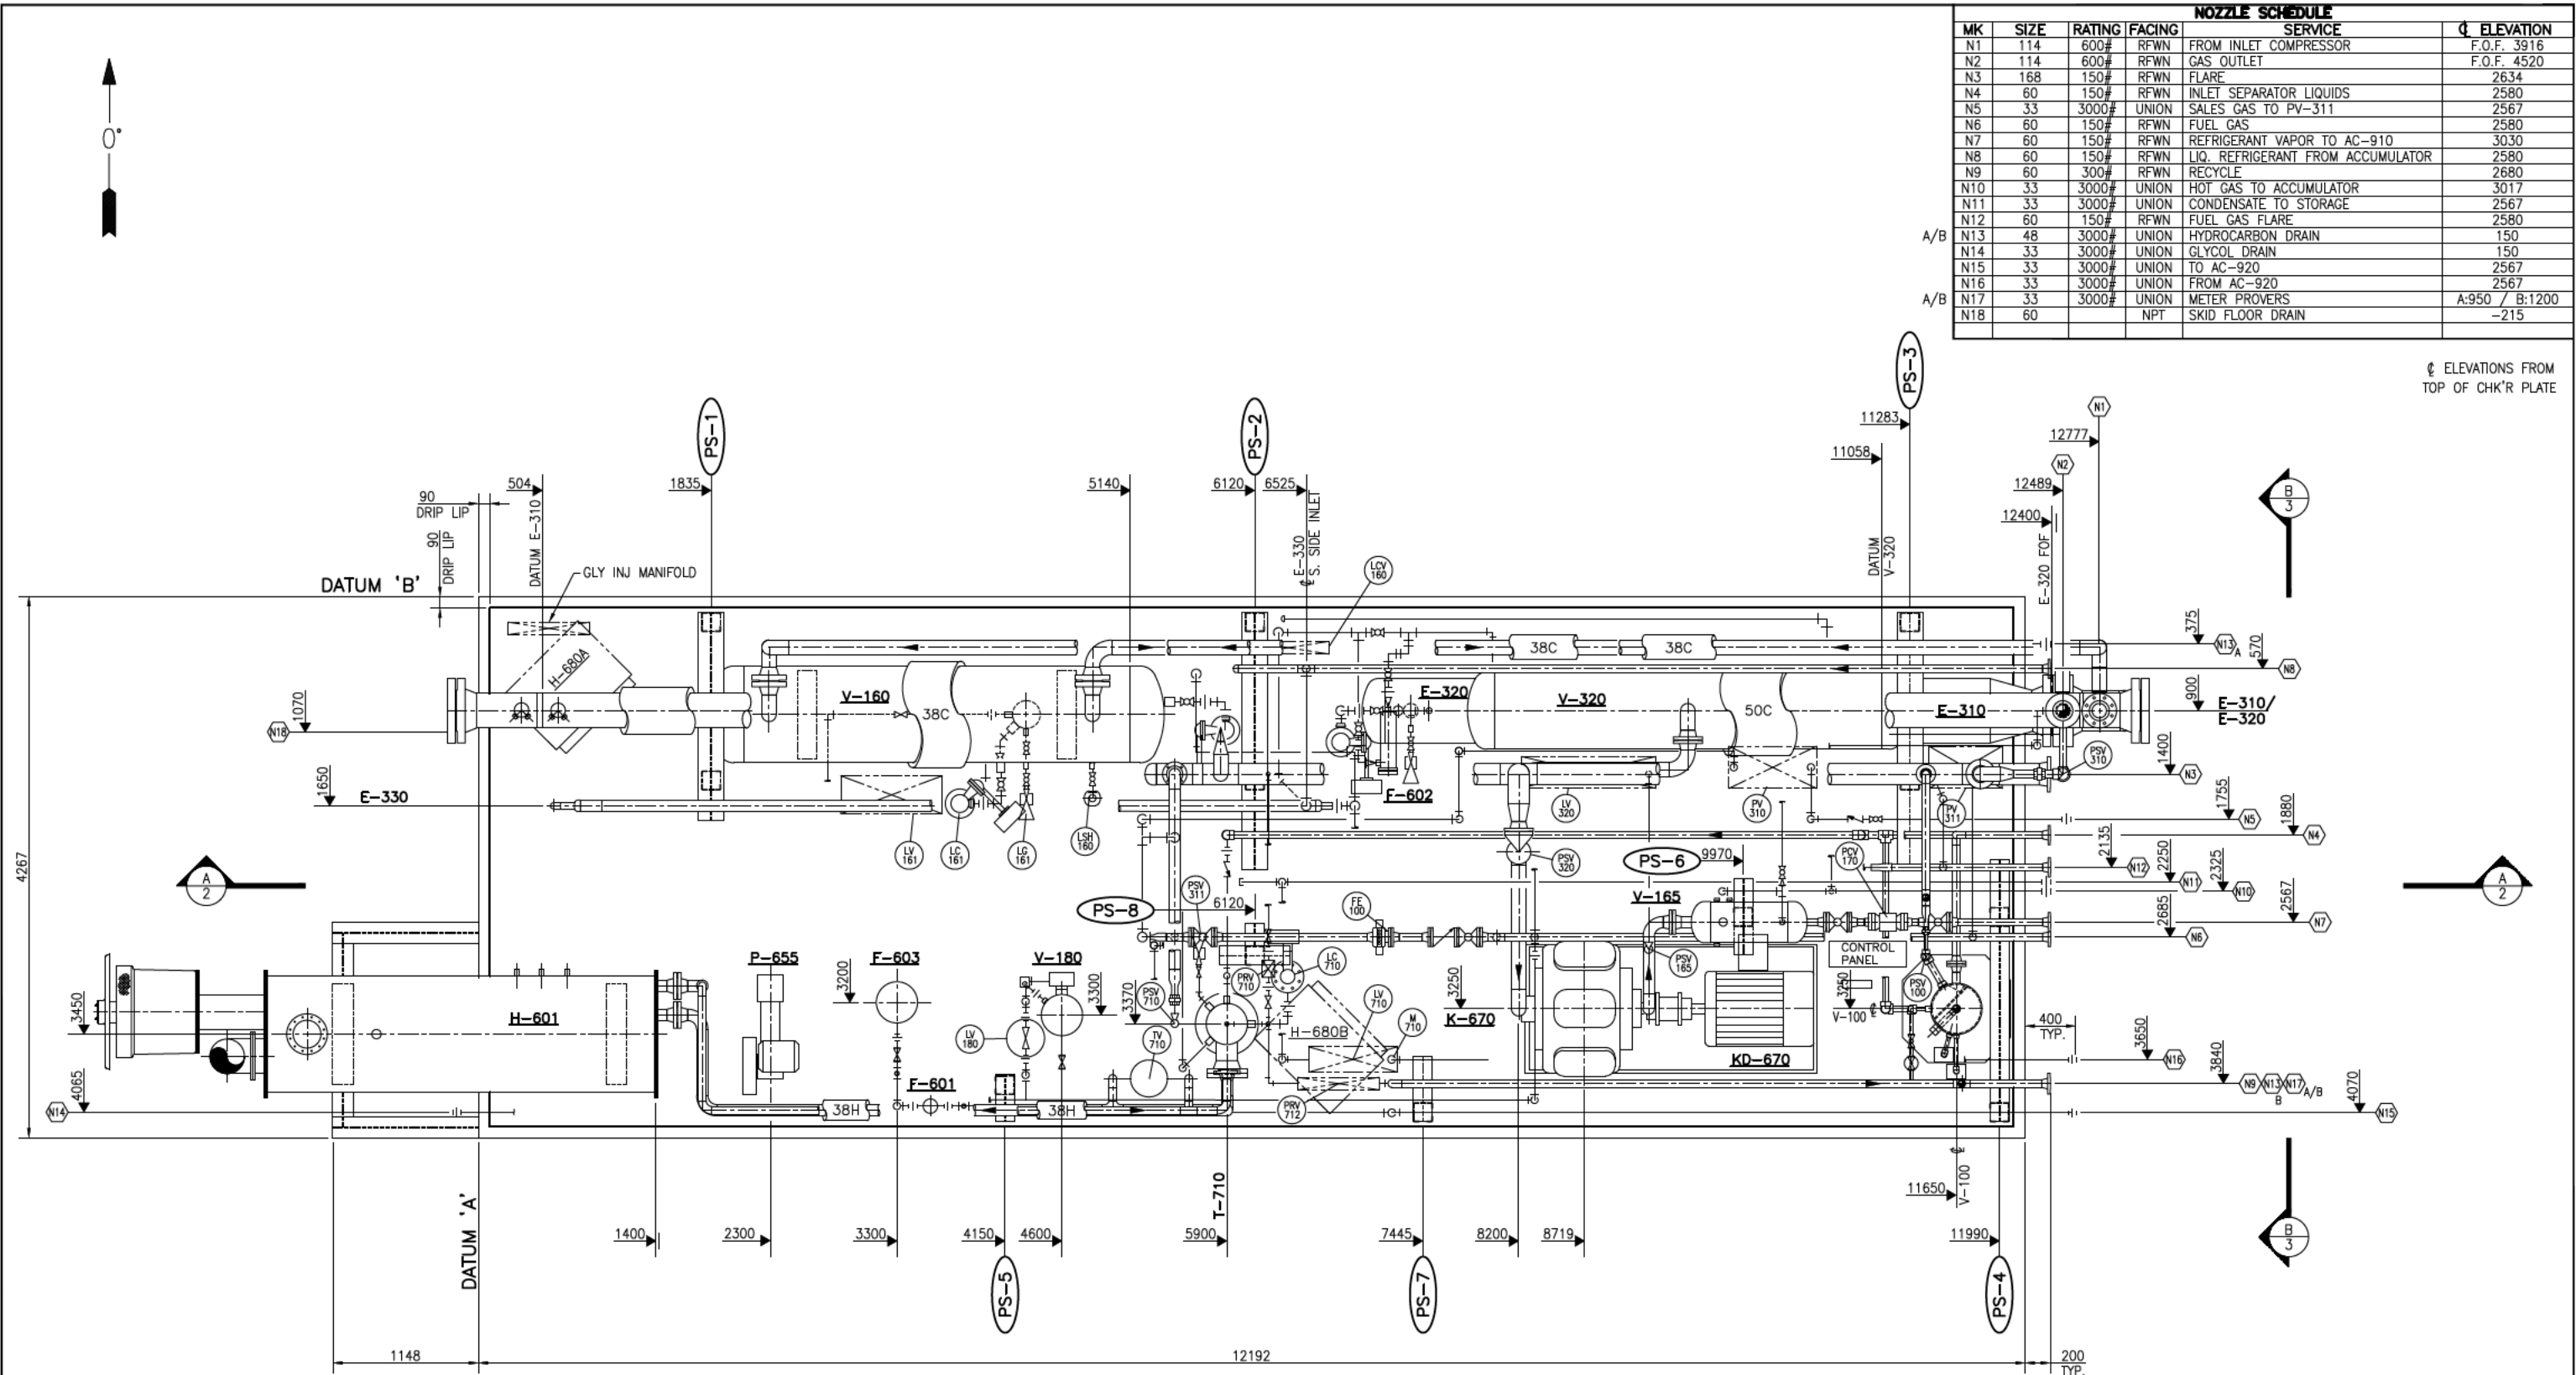

NOZZLE SCHEDULE					
MK	SIZE	RATING	FACING	SERVICE	ELEVATION
N1	114	600#	RFWN	FROM INLET COMPRESSOR	F.O.F. 3916
N2	114	600#	RFWN	GAS OUTLET	F.O.F. 4520
N3	168	150#	RFWN	FLARE	2634
N4	60	150#	RFWN	INLET SEPARATOR LIQUIDS	2580
N5	33	3000#	UNION	SALES GAS TO PV-311	2567
N6	60	150#	RFWN	FUEL GAS	2580
N7	60	150#	RFWN	REFRIGERANT VAPOR TO AC-910	3030
N8	60	150#	RFWN	LIQ. REFRIGERANT FROM ACCUMULATOR	2580
N9	60	300#	RFWN	RECYCLE	2680
N10	33	3000#	UNION	HOT GAS TO ACCUMULATOR	3017
N11	33	3000#	UNION	CONDENSATE TO STORAGE	2567
N12	60	150#	RFWN	FUEL GAS FLARE	2580
N13	48	3000#	UNION	HYDROCARBON DRAIN	150
N14	33	3000#	UNION	GLYCOL DRAIN	150
N15	33	3000#	UNION	TO AC-920	2567
N16	33	3000#	UNION	FROM AC-920	2567
N17	33	3000#	UNION	METER PROVERS	A:950 / B:1200
N18	60		NPT	SKID FLOOR DRAIN	-215

ELEVATIONS FROM
TOP OF CHK'R PLATE


GENERAL NOTES		GENERAL NOTES	
1	ISSUED FOR CONSTRUCTION	1	ISSUED FOR CONSTRUCTION
2	ADDED CLIENT'S NAME AND V-100, DELETED BUILDING, HEATERS, N6, & N12, ELEV. OF N2 WAS 3916 F.O.F., RELOCATED PSV-310, N4 WAS 300#	2	ADDED CLIENT'S NAME AND V-100, DELETED BUILDING, HEATERS, N6, & N12, ELEV. OF N2 WAS 3916 F.O.F., RELOCATED PSV-310, N4 WAS 300#
3	ADDED N6 AND N12	3	ADDED N6 AND N12
4	AS BUILT	4	AS BUILT
DATE: 2004/10/27 01:10 PM J:\JOBS\04\043167\20-DRAWINGS\FAB\ASY\ASY-043167-152.DWG quentins		DATE: 2004/10/27 01:10 PM J:\JOBS\04\043167\20-DRAWINGS\FAB\ASY\ASY-043167-152.DWG quentins	
No.	REVISION	BY	DATE
		CKD	ENG
		AL	RT
		BLANMERS	04/07/22

APPROVED		DRAWN	
MECH./STRUCT.	BY	PSC	DATE
DATE	03/10/07	CHECKED	DATE
ELECTRICAL	BY	JLS	DATE
PROJECT	RT	DATE	03/10/07
DATE	03/10/07	SCALE	1:25

DWG. No.: D-ASY-043167-152		SHT 1 OF 3	REV. 4
----------------------------	--	------------	--------

PROPAC
440 East Lake Road,
Airdrie, Alberta
Canada T4A 2J8

THIS DRAWING AND THE DESIGN IT COVERS ARE CONFIDENTIAL AND THE PROPERTY OF PROPAK SYSTEMS LTD., AND SHALL NOT BE DISCLOSED TO OTHERS OR REPRODUCED IN ANY MANNER OR USED FOR ANY PURPOSE WHATSOEVER EXCEPT BY WRITTEN CONSENT OF PROPAK.

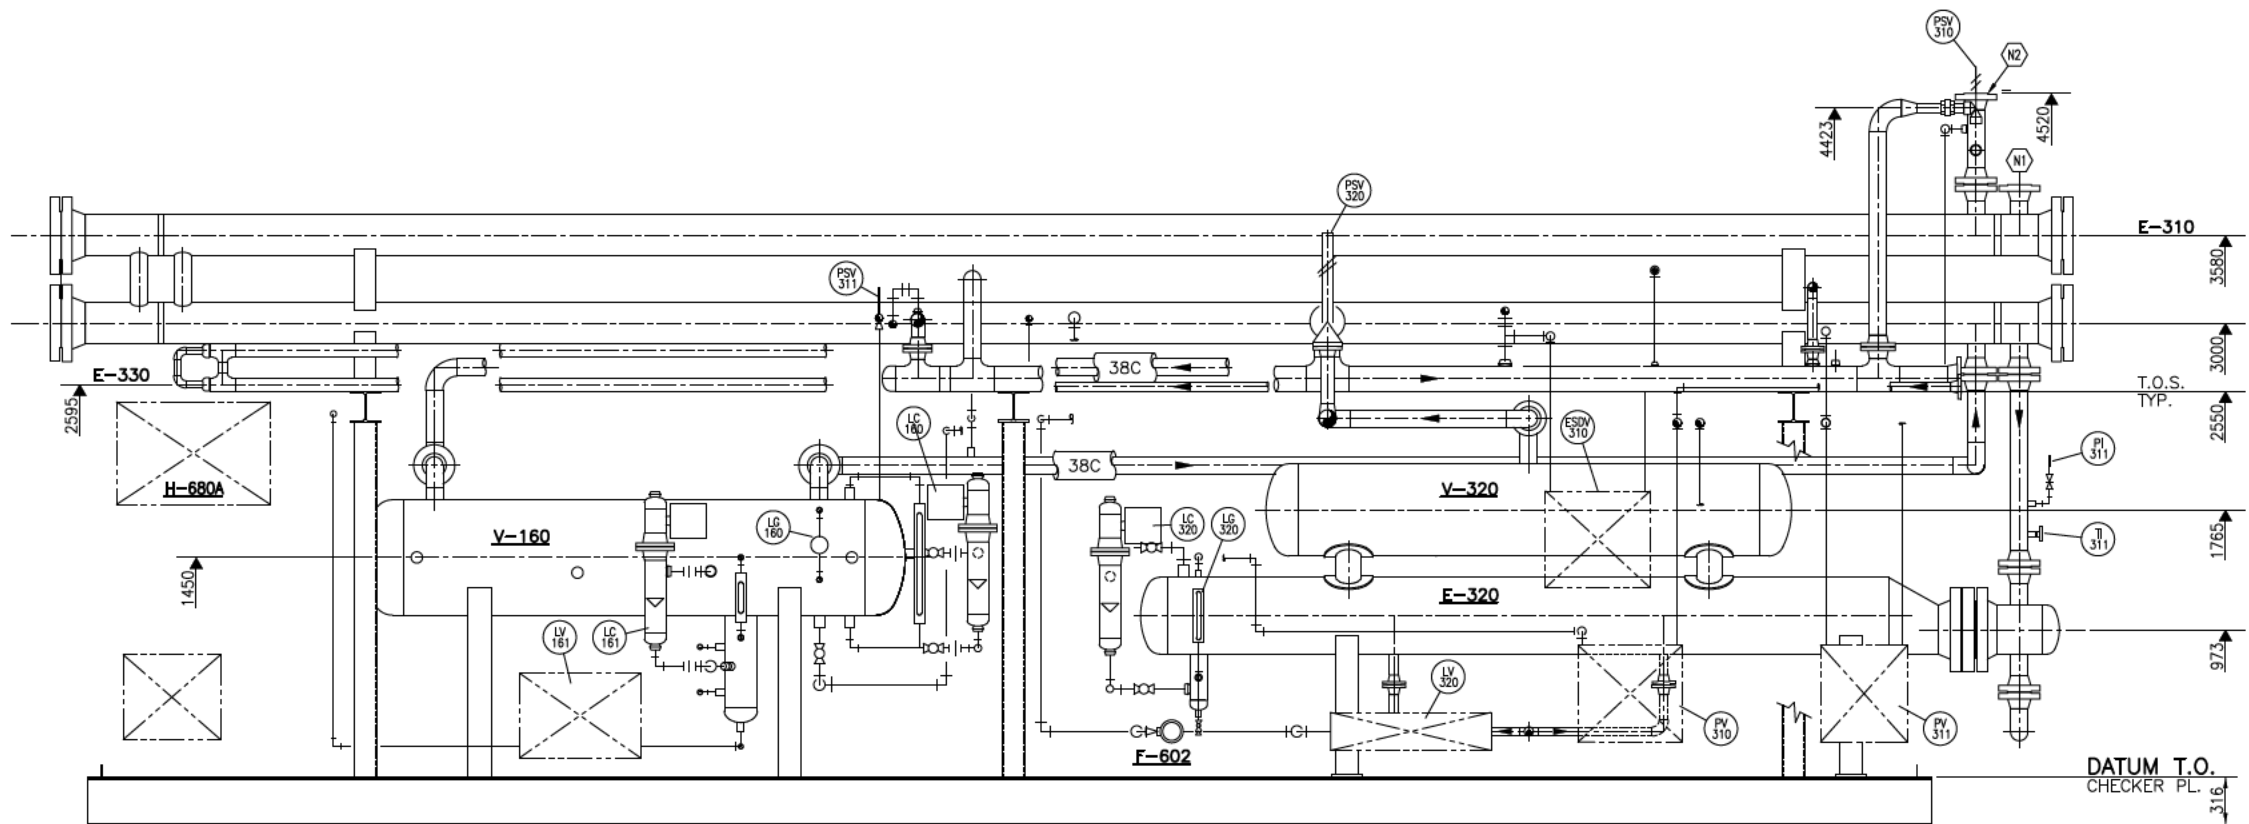


SECTION 'A-A'

GENERAL NOTES		GENERAL NOTES		REVISION		BY		DATE		CKD		ENG	
1		ISSUED FOR CONSTRUCTION		1		BLAMMERS		04/07/22		AL		RT	
2		ESDV-310 AND RELOCATED PSV-310		2		QLS		04/09/10		M.L		F.P.	
3		AS BUILT		3		QLS		04/10/27		QLS		C.daS	


APPROVED		DRAWN	
MECH./STRUCT.	BY	DATE	PSC
DATE	03/10/07	DATE	03/10/07
ELECTRICAL	BY	DATE	JLS
DATE	03/10/07	DATE	03/10/07
PROJECT	RT	DATE	03/10/07
DATE	03/10/07	SCALE	1:25

REFRIGERATION UNIT 6B		DWG. No.: D-ASY-043167-152		SHT 2 OF 3		REV. 3	
PIPING LAYOUT							

PROPAK
440 East Lake Road,
Airdrie, Alberta
Canada T4A 2J8

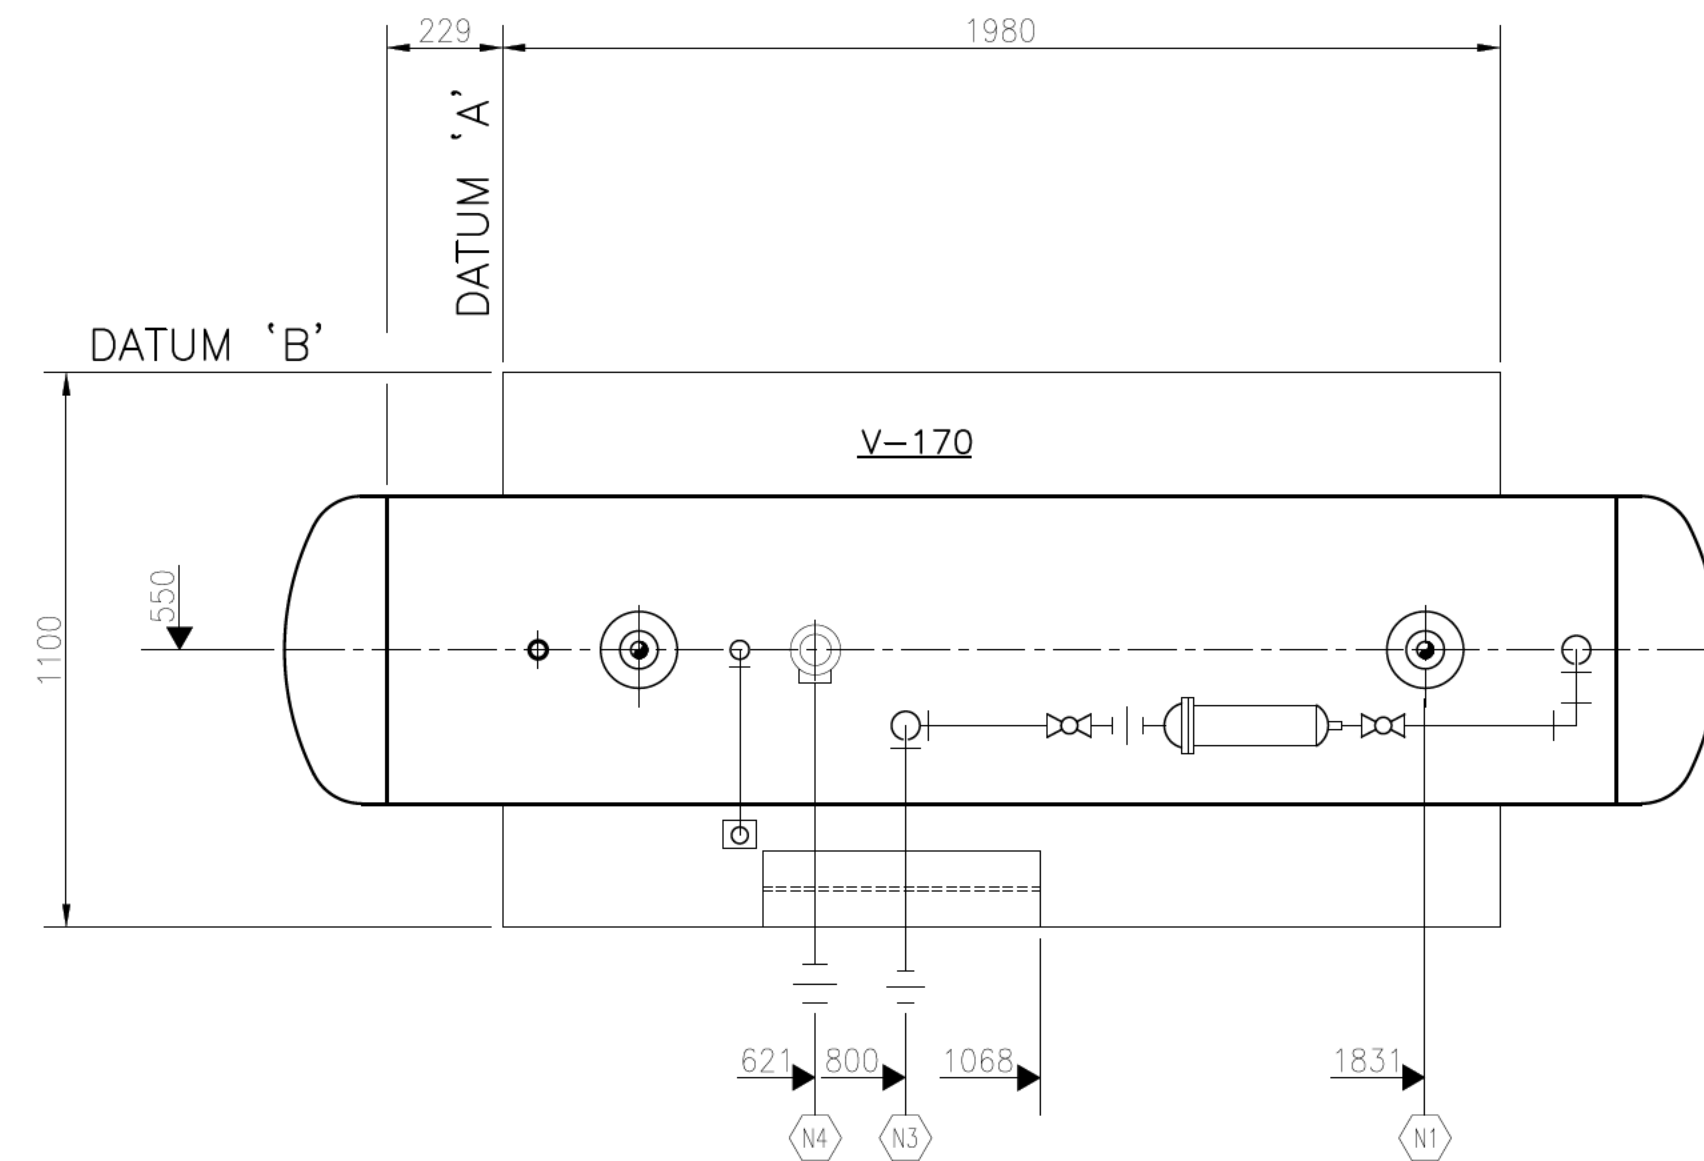


PLAN VIEW

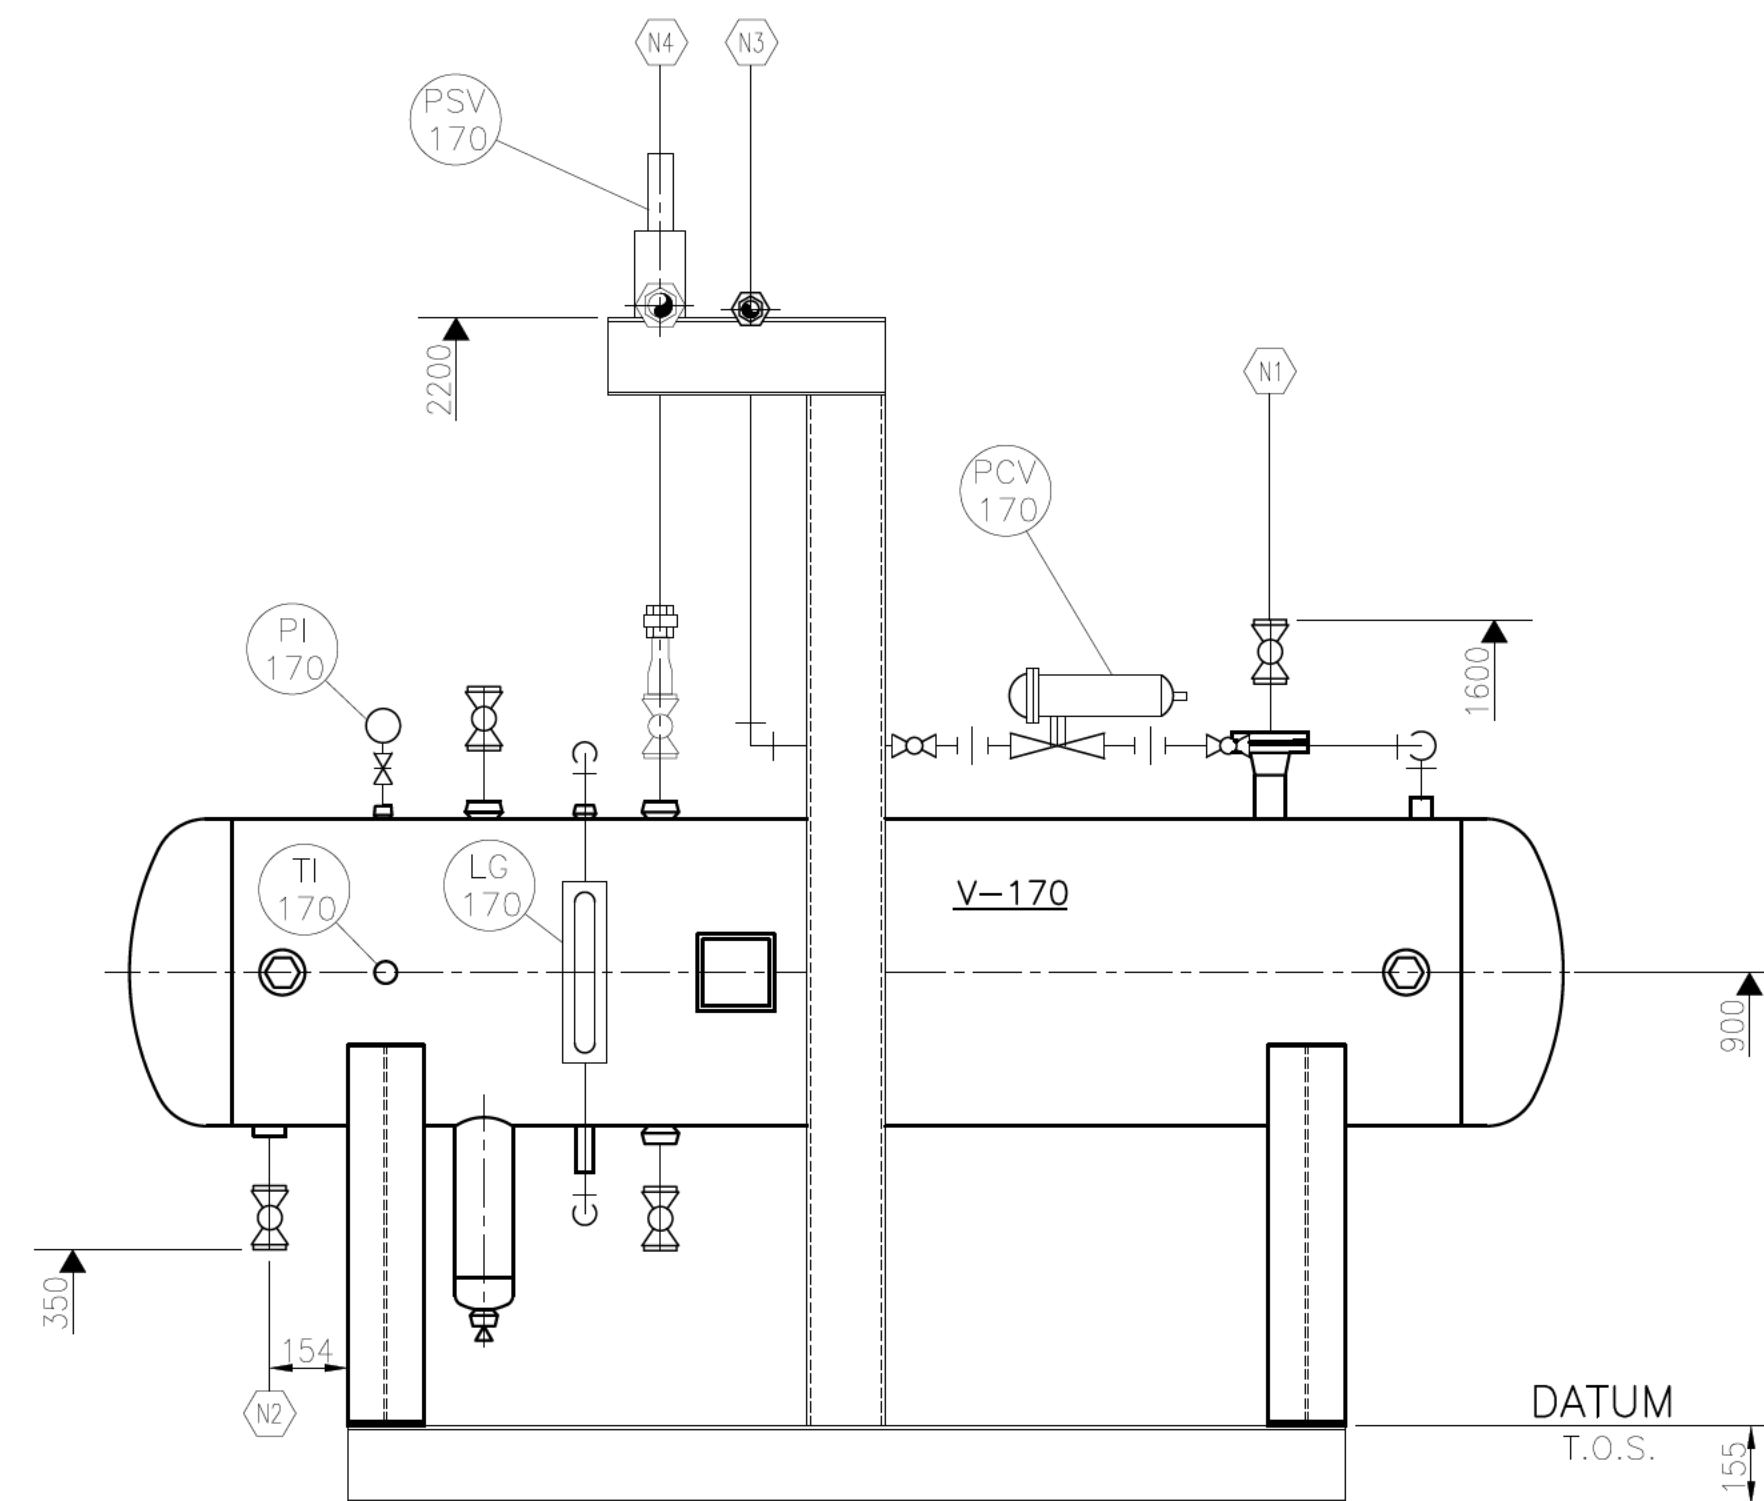

SECTION 'A-A'


NOZZLE SCHEDULE					
MK	SIZE	RATING	FACING	SERVICE	¢ ELEVATION
N1	48	3000#	NPT	LIQUID REFRIGERANT INLET	—
N2	48	3000#	NPT	LIQUID REFRIGERANT OUTLET	—
N3	33	3000#	NPT	HOT GAS INLET	2213
N4	48	3000#	NPT	FLARE	2224

[illegible]

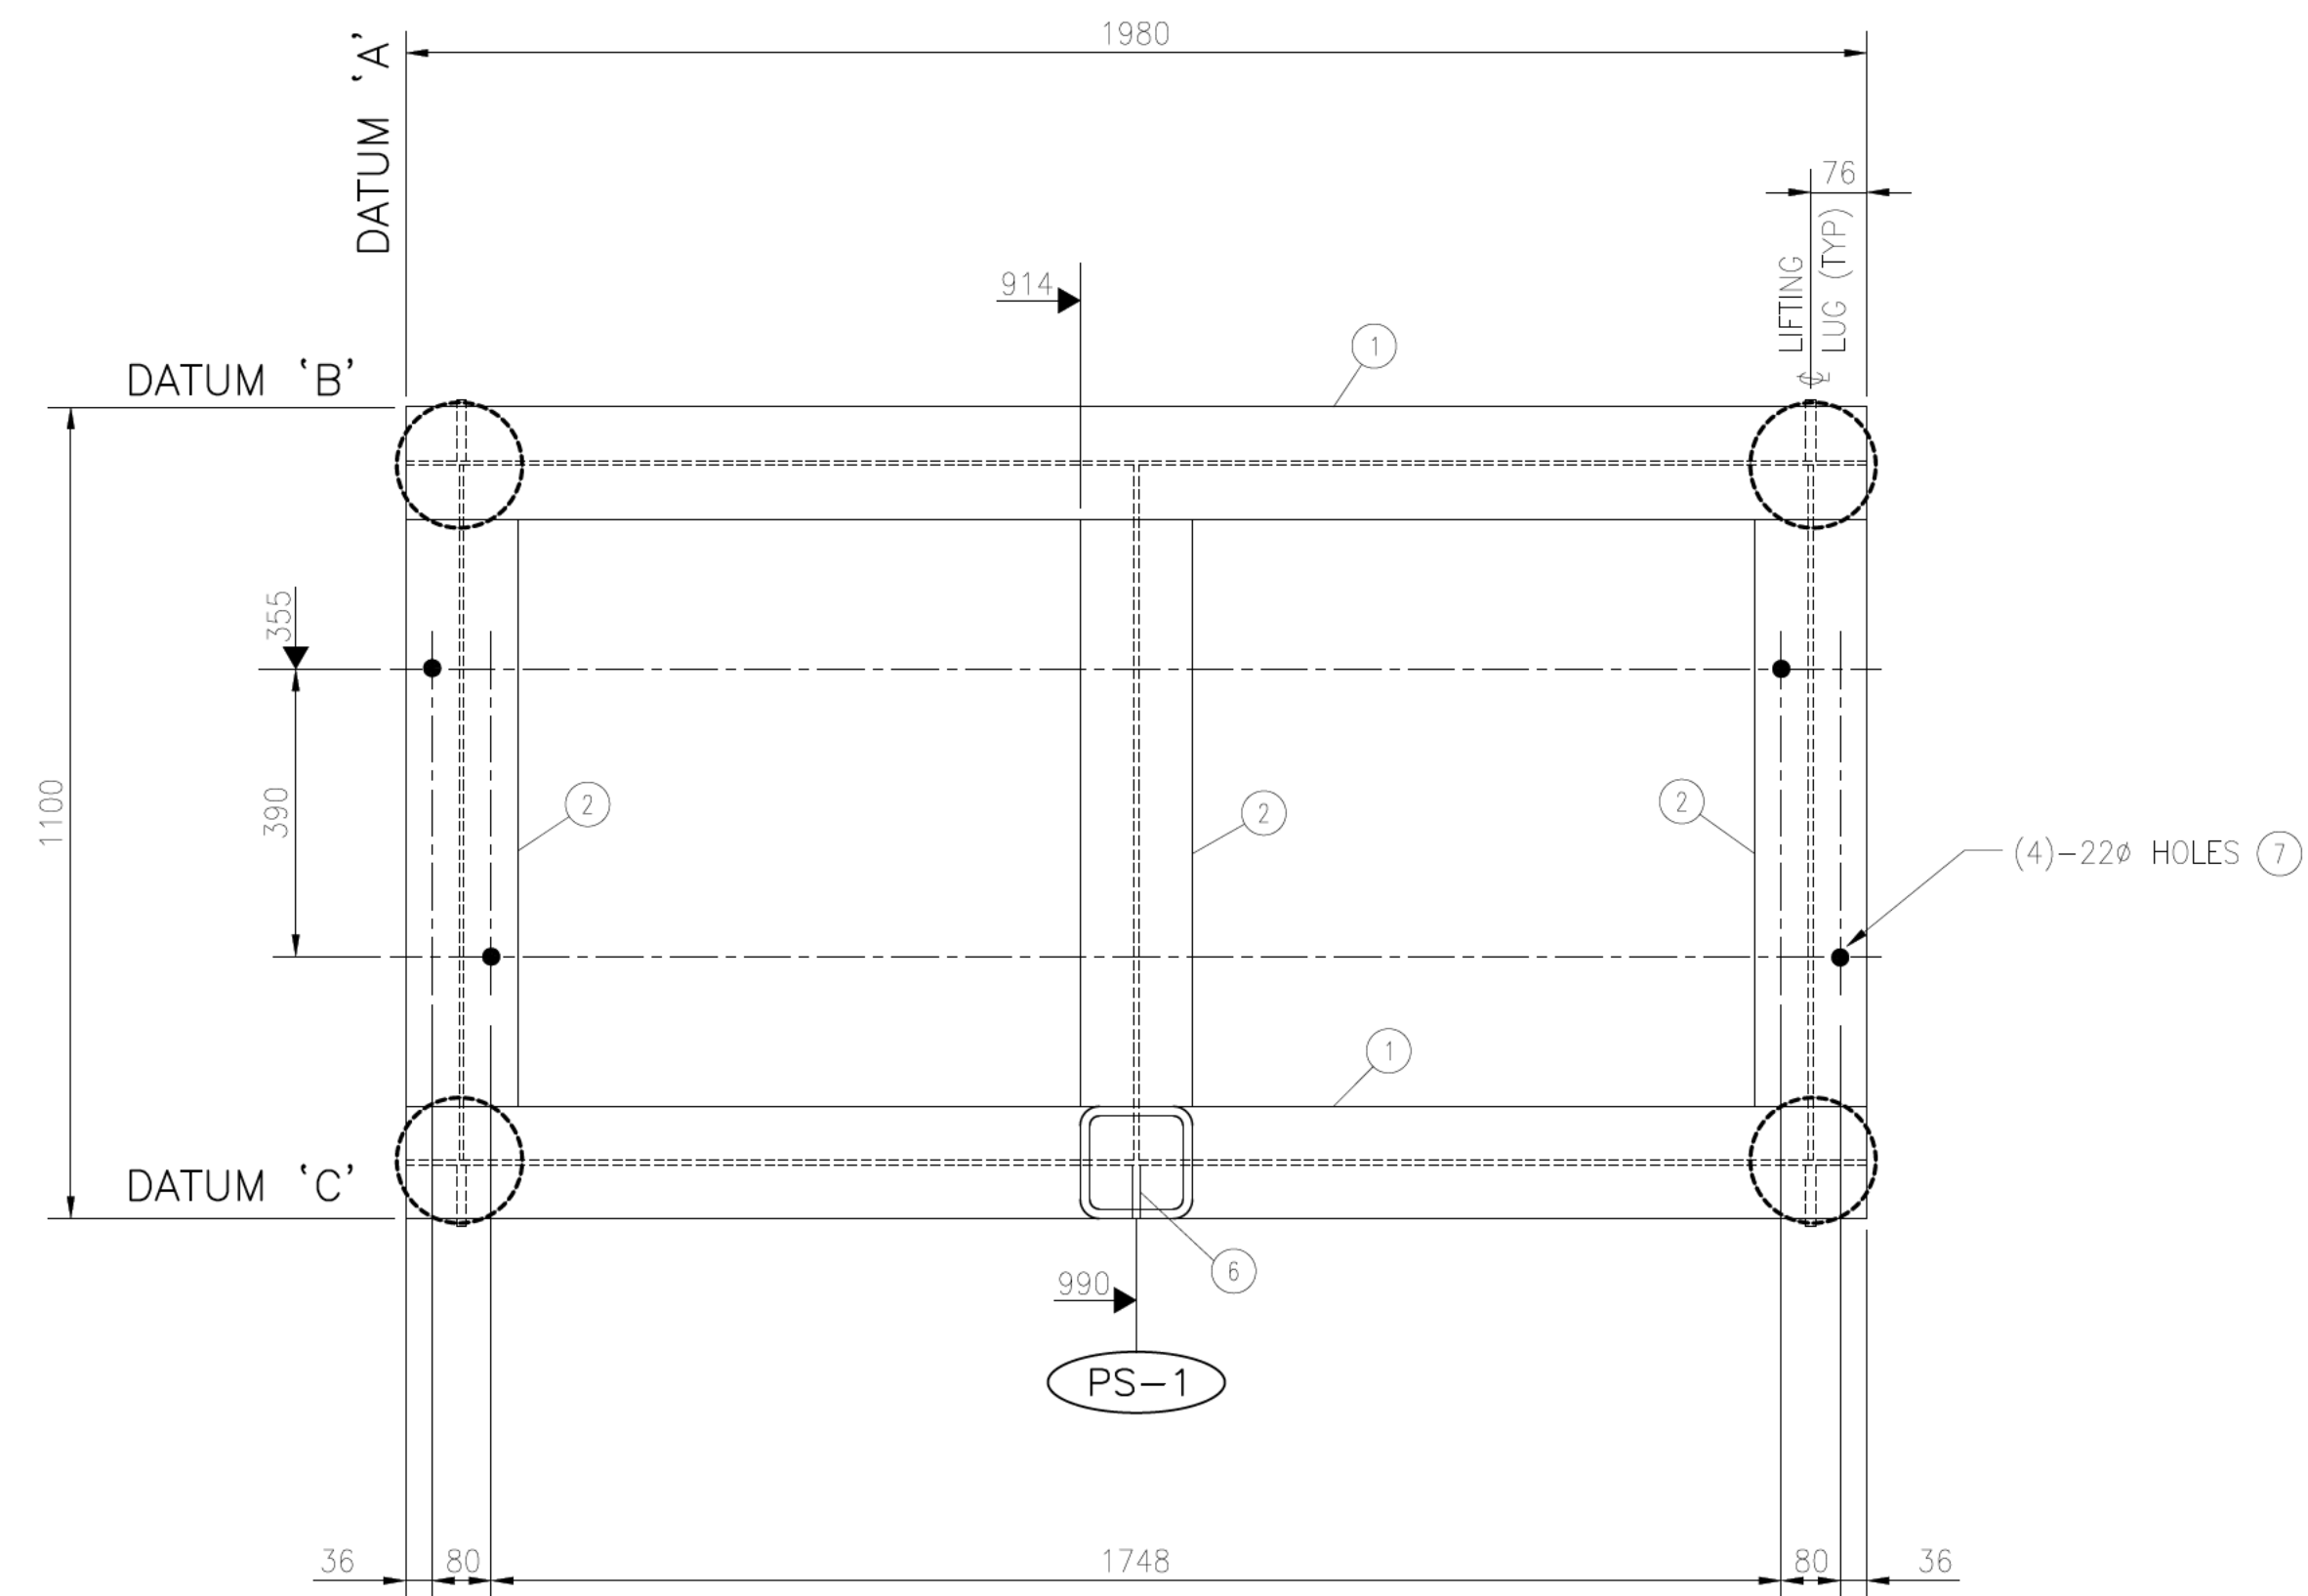


PLAN VIEW

SCALE 1:10

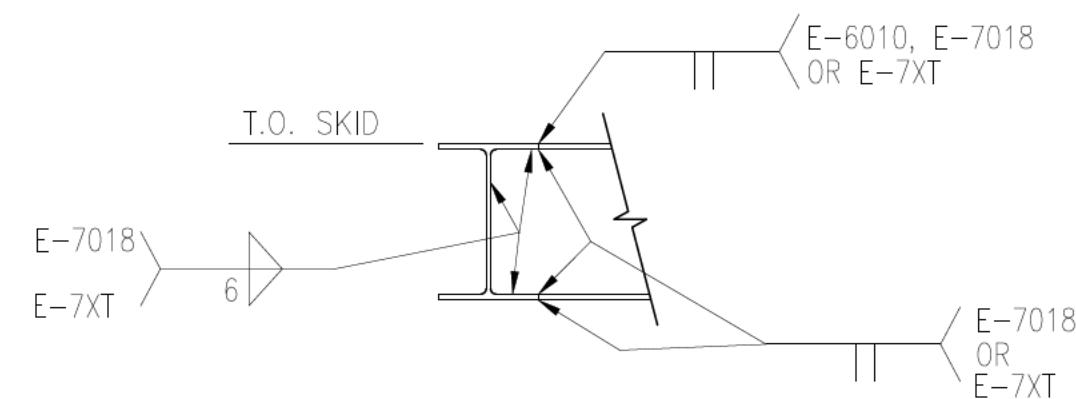


TYPICAL WELD DETAIL

SCALE 1:10

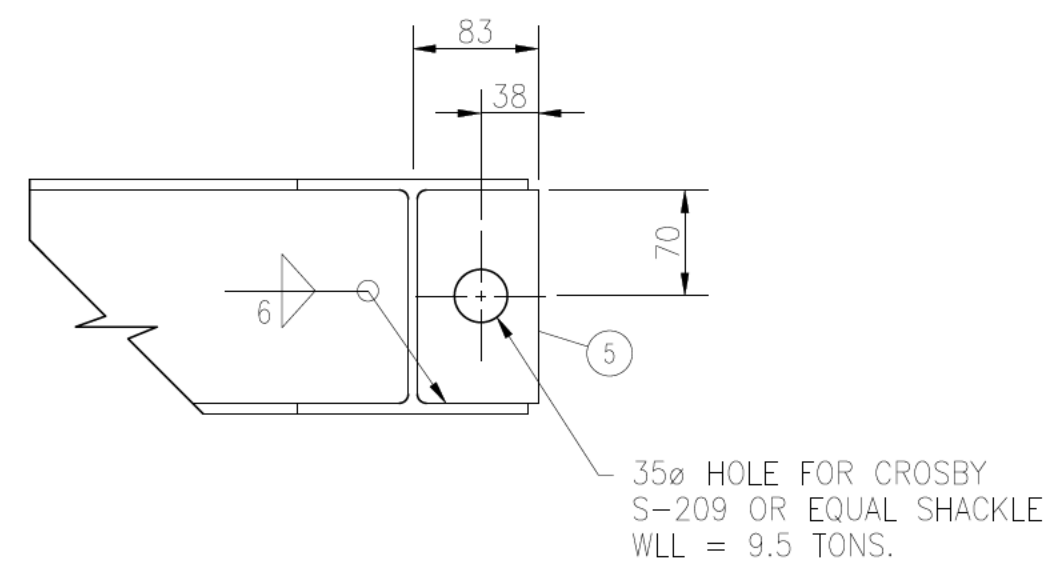

LIFTING LUG DETAIL

(SCALE 1:5)
(4) REQ'D

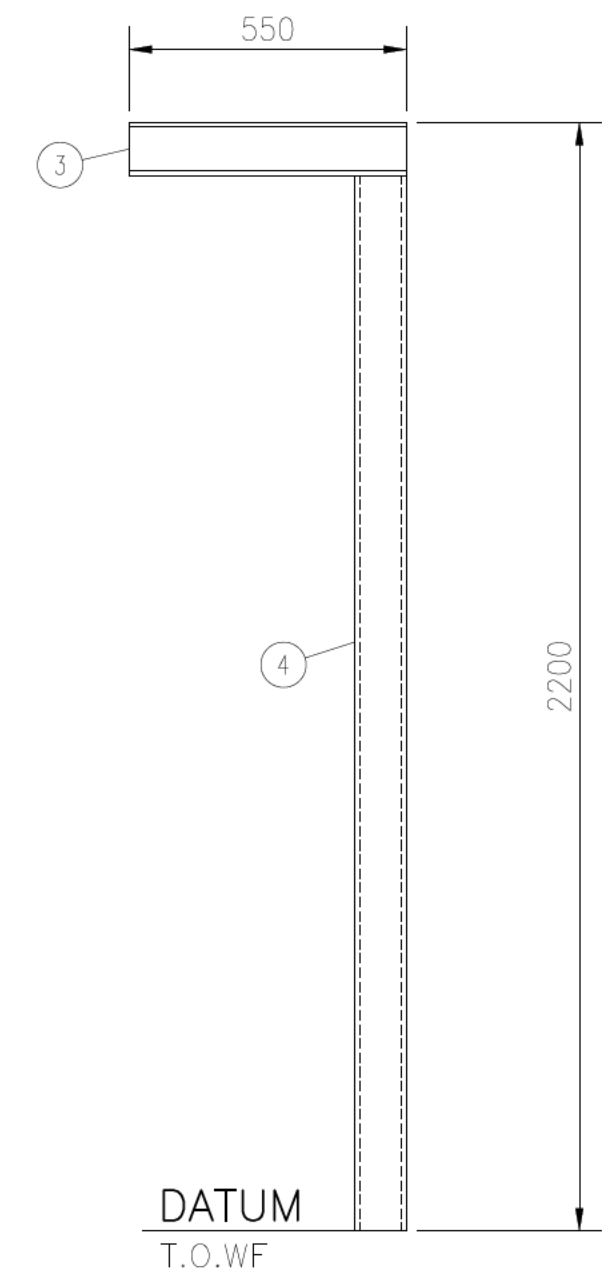

PS-1

(SCALE 1:15)
(LOOKING FROM DATUM 'C')

BILL OF MATERIAL			
ITEM	QUA	PART NO.	DESCRIPTION
1	2	330001	W150 x 22 x 1980 LG G40.21M-300W
2	3	330001	W150 x 22 x 942 LG G40.21M-300W
3	1	330001	W150 x 22 x 550 LG G40.21M-300W
4	1	332017	HSS: 152 x 152 x 6 THK x 2045 LG G40.21M-350W
5	4	327002	PLATE: 12.7 THK x 80 x 141 LG SA-36
6	1	370012	FLAT BAR: 6 THK x 76 x 141 LG CTS SA-36
7	4	200179	M/C BOLTS: 19# x 51 LG UNC c/w NUT AND WASHER SA-325


SHOP NOTES:

1. APPROX. WEIGHT OF SKID : 250 kg
2. COPE ALL MEMBERS TO SUIT.
3. CUT LENGTHS ARE EXACT WITH TOLERANCE OF $\pm 0/-3$
4. ALL WELDS TO BE 6 mm CONTINUOUS FILLET USING E-7018-1 (SMAW) E-7XT-X (FCAW) ELECTRODES UNLESS NOTED OTHERWISE.
5. REMOVE ALL SHARP EDGES AND BURRS.
6. DRILL ALL HOLES, DO NOT FLAME CUT.
7. PAINT SPECS. PNT-11
8.  SUGGESTED PILE LOCATION - 'SUGGESTED PILE LOCATIONS ASSUME RIGID COLUMNS AND ARE BASED ON STATIC LOADS ONLY. PROPAC ASSUMES NO RESPONSIBILITY FOR OFF-SKID FOUNDATION DESIGN AND REQUIRED PILE LOCATIONS. SITE GEOTECHNICAL DATA SHOULD BE REVIEWED BY A QUALIFIED CIVIL ENGINEER PRIOR TO CONSTRUCTION OR INSTALLATION.'

PILE LOAD SCHEDULE


PILE	MAX. SHEAR FORCE (kN)	MAX. AXIAL FORCE (kN)	MAX. UPLIFT FORCE (kN)
1	2.686	38.248	0
2	2.112	32.738	0
3	4.350	52.415	0
4	3.607	47.936	0

[illegible]

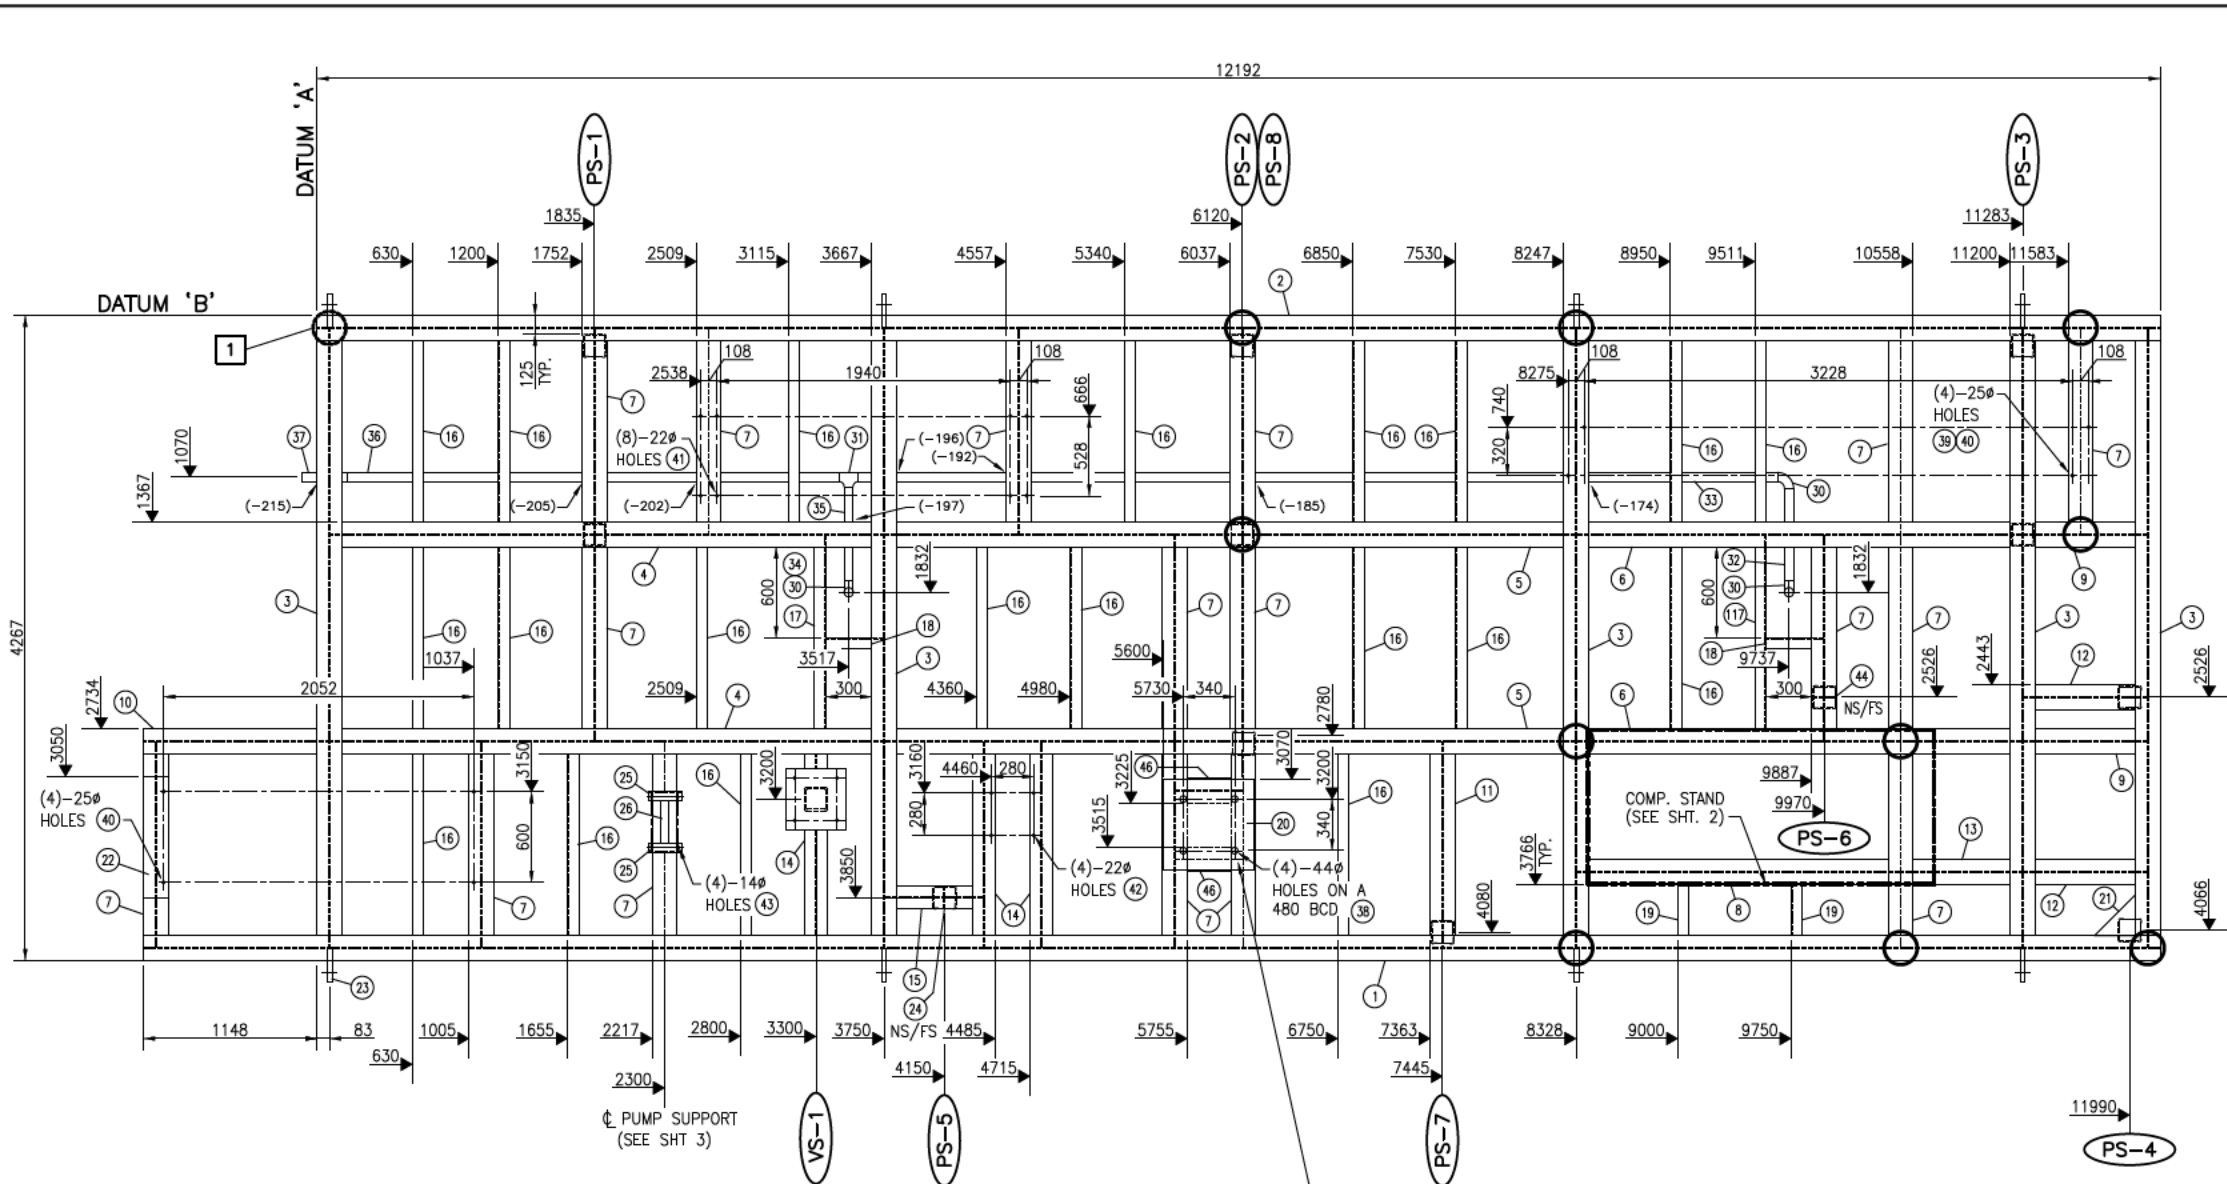


PLAN
(SCALE 1:25)


NOTE:
WELD SKID PLATE TO BEAMS WHERE
EVER POSSIBLE. NUTS TO BE WELDED
TO U/S OF SKID PLATE. NOTCH
FLANGE TO ACCOMMODATE NUTS.

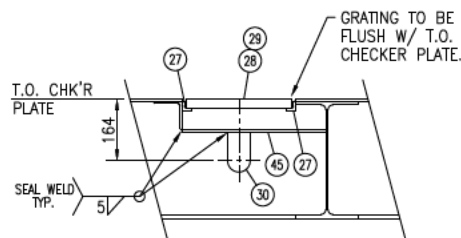


FLOOR DRAIN DETAIL
(SCALE 1:10)

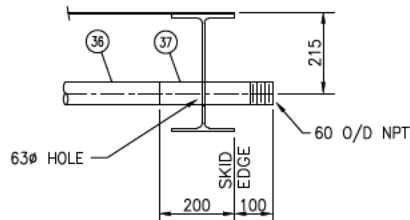

**FLOOR DRAIN AT
SKID EDGE DETAIL**
(SCALE 1:10)

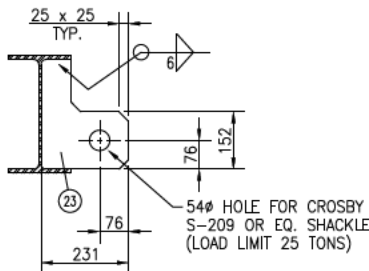

LIFTING LUG DETAIL
(SCALE 1:10)
(8 REQUIRED)

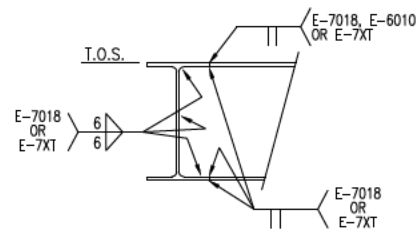

TYPICAL WELD DETAIL

BILL OF MATERIAL			
ITEM	QUA	PART NO.	DESCRIPTION
1	1	330016	W310 x 39 x 13340 LG G40.21M-300W
2	1	330016	W310 x 39 x 12192 LG G40.21M-300W
3	5	330016	W310 x 39 x 4096 LG G40.21M-300W
4	2	330016	W310 x 39 x 3661 LG G40.21M-300W
5	2	330016	W310 x 39 x 4572 LG G40.21M-300W
6	2	330016	W310 x 39 x 2949 LG G40.21M-300W
7	17	330016	W310 x 39 x 1361 LG G40.21M-300W
8	1	330016	W310 x 39 x 2142 LG G40.21M-300W
9	2	330016	W310 x 39 x 820 LG G40.21M-300W
10	1	330016	W310 x 39 x 1228 LG G40.21M-300W
11	1	330006	W200 x 36 x 1361 LG G40.21M-300W
12	2	330006	W200 x 36 x 820 LG G40.21M-300W
13	1	330006	W200 x 36 x 801 LG G40.21M-300W
14	3	330001	W150 x 22 x 1361 LG G40.21M-300W
15	1	330001	W150 x 22 x 653 LG G40.21M-300W
16	20	315013	ANGLE: 6 THK x 76 x 76 x 1202 LG G40.21M-300W
17	2	315013	ANGLE: 6 THK x 76 x 76 x 1282 LG G40.21M-300W
18	2	315013	ANGLE: 6 THK x 76 x 76 x 380 LG G40.21M-300W
19	2	315013	ANGLE: 6 THK x 76 x 76 x 336 LG G40.21M-300W
20	1	327004	PLATE: 19.05 THK x 600 SQ. SA-36
21	1	327001	PLATE: 9.53 THK x 270 SQ. CUT DIAGONALLY SA-36
22	1	327000	PLATE: 6.35 THK x 165 x 800 LG SA-36
23	8	327009	PLATE: 38.1 THK x 231 x 287 LG SA-36
24	2	327001	PLATE: 9.53 THK x 76 x 135 LG SA-36
25	2	320014	C200 x 17 x 220 LG G40.21M-300W
26	1	320014	C200 x 17 x 387 LG G40.21M-300W
27	4	315028	ANGLE: 6 THK x 25 x 25 x 600 LG (CTS) G40.21M-300W
28	4	315028	ANGLE: 6 THK x 25 x 25 x 300 LG (CTS) G40.21M-300W
29	2	374002	GRATING: W102-30 x (25 x 5) x 280 x 580 LG CS
30	3	033025	ELBOW: 60 x 90°-LR XH BW SMLS SA-234-WPB
31	1	065078	TEE: 60 x XH BW SMLS SA-234-WPB
32	1	001036	PIPE: 60 O/D x 3.91 WT x 604 LG SMLS SA-106-B
33	1	001036	PIPE: 60 O/D x 3.91 WT x 6074 LG SMLS SA-106-B
34	1	001036	PIPE: 60 O/D x 3.91 WT x 30 LG SMLS SA-106-B
35	1	001036	PIPE: 60 O/D x 3.91 WT x 616 LG SMLS SA-106-B
36	1	001036	PIPE: 60 O/D x 3.91 WT x 3247 LG SMLS SA-106-B
37	1	001038	PIPE: 60 O/D x 5.54 WT x 300 LG SMLS SA-106-B
38	4	232424	STUDS: 418 x 178 LG c/w (2) NUTS EA. SA-193-B7/SA-194-2H
39	2	200235	M/C BOLTS: 228 x 70 LG UNC c/w NUT & WASHER SA-325
40	6	200227	M/C BOLTS: 228 x 57 LG UNC c/w NUT & WASHER SA-325
41	8	200183	M/C BOLTS: 198 x 57 LG UNC c/w NUT & WASHER SA-325
42	4	200179	M/C BOLTS: 198 x 51 LG UNC c/w NUT & WASHER SA-325
43	4	200079	M/C BOLTS: 138 x 44 LG UNC c/w NUT & WASHER SA-325
44	2	370023	FLAT BAR: 10 THK x 76 x 279 LG SA-36
45	2	327000	PLATE: 6.35THK x 373 x 674 LG SA-36
46	2	330016	W310 x 39 x 449 LG G40.21M-300W

NOTES:

- APPROX. WEIGHT OF SKID : 9700 kg (13000 kg w/ CONCRETE)
- COPE ALL MEMBERS TO SUIT.
- CUT LENGTHS ARE EXACT WITH TOLERANCE OF +0/-3
- ALL WELDS TO BE 6 mm CONTINUOUS FILLET USING E-7018-1 (SMAW) E-7XT-X (FCAW) ELECTRODES UNLESS NOTED OTHERWISE.
- REMOVE ALL SHARP EDGES AND BURRS.
- DRILL ALL HOLES, DO NOT FLAME CUT.
- PAINT SPEC.: PNT-11
- SUGGESTED PILE LOCATION - 'SUGGESTED PILE LOCATIONS ASSUME RIGID COLUMNS AND ARE BASED ON STATIC LOADS ONLY. PROPAC ASSUMES NO RESPONSIBILITY FOR OFF-SKID FOUNDATION DESIGN AND REQUIRED PILE LOCATIONS. SITE GEOTECHNICAL DATA SHOULD BE REVIEWED BY A QUALIFIED CIVIL ENGINEER PRIOR TO CONSTRUCTION OR INSTALLATION.'


PILE LOAD SCHEDULE

PILE	MAX. SHEAR FORCE (kN)	MAX. AXIAL FORCE (kN)	MAX. UPLIFT FORCE (kN)
1	-	-	-
2	-	-	-
3	-	-	-
4	-	-	-
5	-	-	-
6	-	-	-
7	-	-	-
8	-	-	-
9	-	-	-
10	-	-	-
11	-	-	-
12	-	-	-
13	-	-	-
14	-	-	-
15	-	-	-
16	-	-	-

GENERAL NOTES		GENERAL NOTES		REVISION		BY		DATE		CKD		ENG	
DATE: 2004/09/09 11:25 AM J:\JOBS\04\043167\20-DRAWINGS\FAB\SKD\SKD-043167-113.DWG quentins		2		ADDED CLIENT'S NAME AND LOCATION		QLS		04/09/08		M.L.		F.P.	
1		ISSUED FOR CONSTRUCTION		BLANMERS		04/07/22		AL		RT			

APPROVED		DRAWN	
MECH./STRUCT. JR	BY	PSC	
DATE 03/10/06	DATE	03/10/06	
ELECTRICAL	BY	JLS	
DATE	DATE	03/10/06	
PROJECT	DATE	03/10/06	
DATE	SCALE	AS NOTED	

DWG. No.:		SHT 1 OF 3		REV.
D-SKD-043167-113				2

 

(SCALE 1:25)



1) JACK SCREWS, SHIMS, & HOLES
FOR MOTORS & COMPRESSORS TO
BE LOCATED, TAPPED & WELDED IN
PLACE ON ASS'Y


[illegible]

APPROVED		DRAWN	
MECH./STRUCT.	JR	BY	PSC
DATE	03/10/06	DATE	03/10/06
ELECTRICAL		CHECKED	
DATE		BY	JLS
PROJECT	RT	DATE	03/10/06
DATE	03/10/06		
		SCALE	AS NOTED


				
				
REFRIGE SKID STEEL				
DWG. No.:	D-SKD-043167-113	SHT	2 OF 3	REV 2

PROPAK 
440 East Lake Road,
Airdrie, Alberta
Canada T4A 2J8


THIS DRAWING AND THE DESIGN IT COVERS ARE CONFIDENTIAL AND THE PROPERTY OF PROPAG SYSTEMS LTD., AND SHALL NOT BE DISCLOSED TO OTHERS OR REPRODUCED IN ANY MANNER OR USED FOR ANY PURPOSE WHATSOEVER EXCEPT BY WRITTEN CONSENT OF PROPAG.

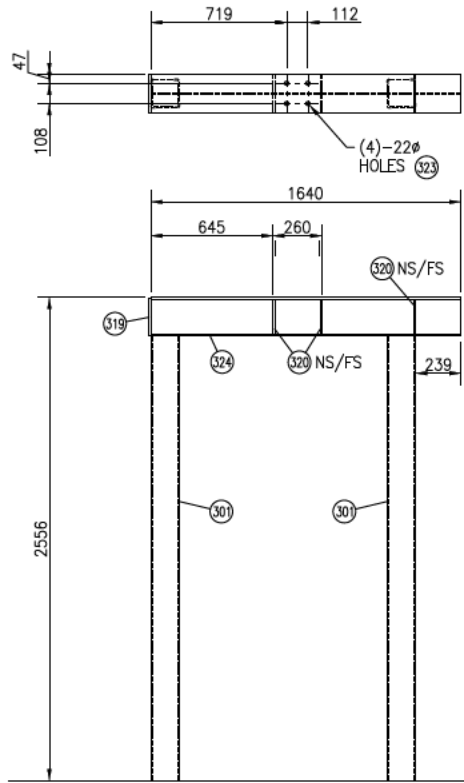


PS-1
(VIEWED FROM DATUM 'A')
(SCALE 1:20)

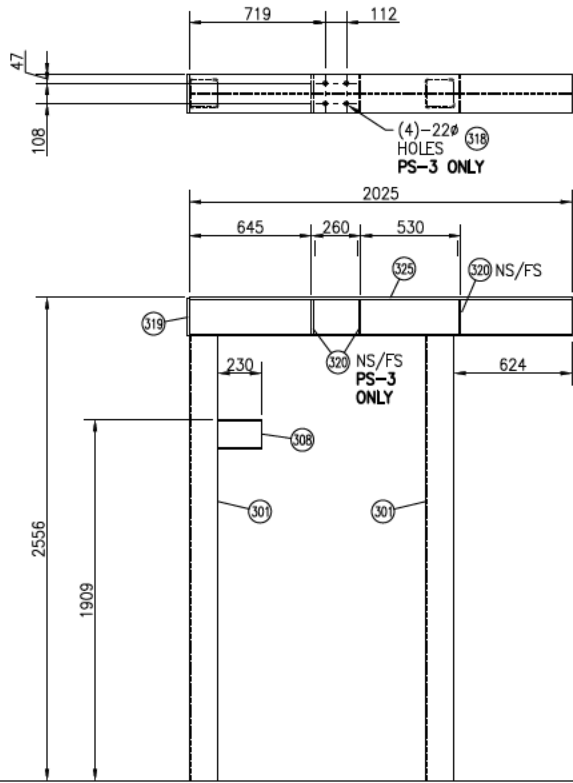


PS-2 & PS-3
(VIEWED FROM DATUM 'A')
(SCALE 1:20)

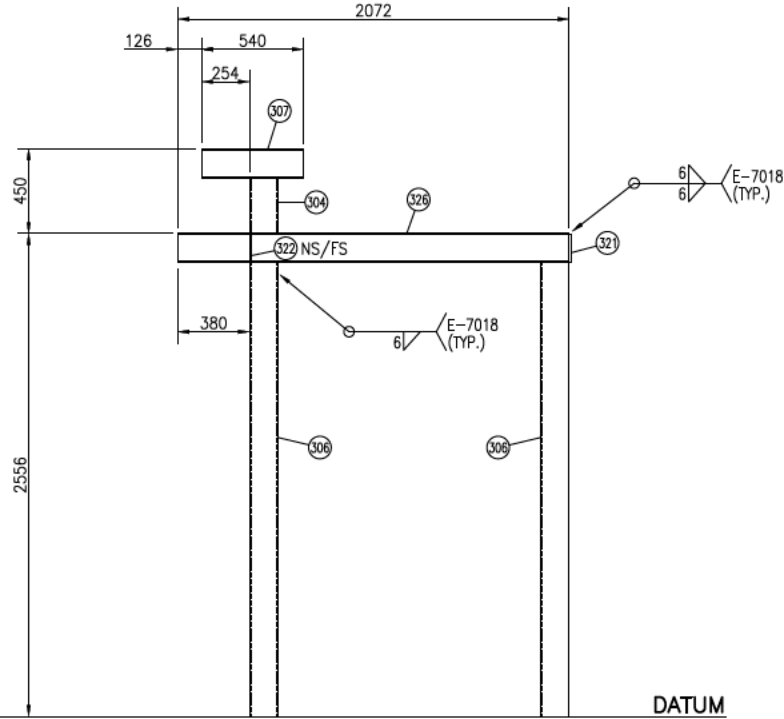


PS-4
(VIEWED FROM DATUM 'A')
(SCALE 1:20)

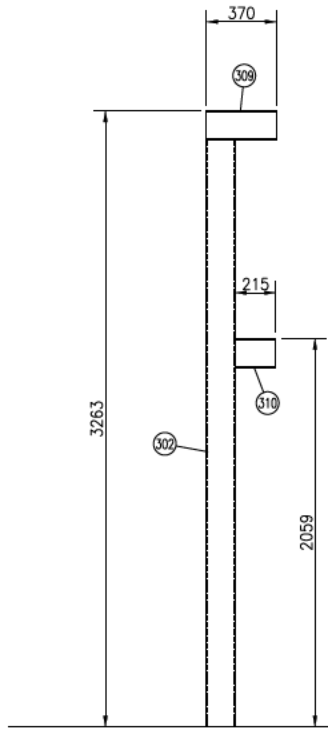


PS-5
(VIEWED FROM DATUM 'A')
(SCALE 1:20)

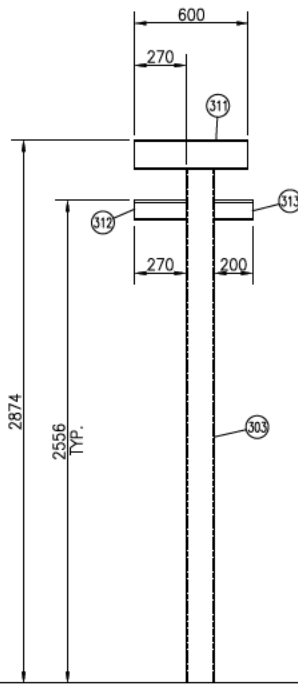


PS-6
(VIEWED FROM DATUM 'A')
(SCALE 1:20)

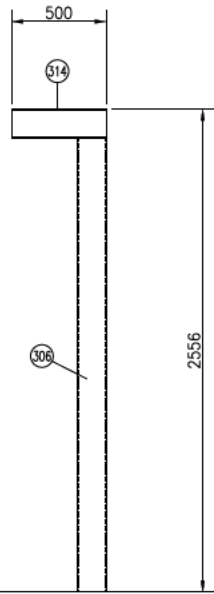


PS-7
(VIEWED FROM DATUM 'A')
(SCALE 1:20)

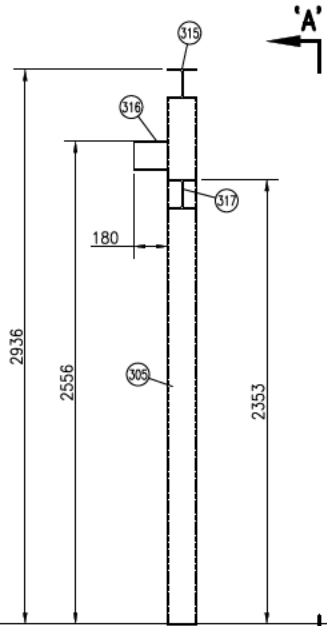


PS-8
(VIEWED FROM DATUM 'A')
(SCALE 1:20)

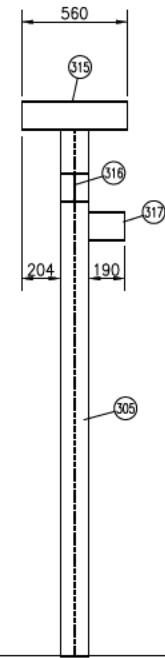

SECTION 'A-A'
(VIEWED FROM DATUM 'B')
(SCALE 1:20)

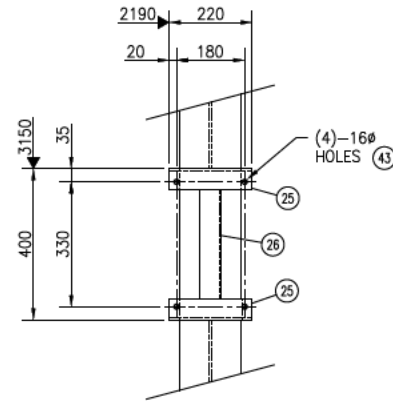

PUMP SUP'T DETAIL
(SCALE 1:10)

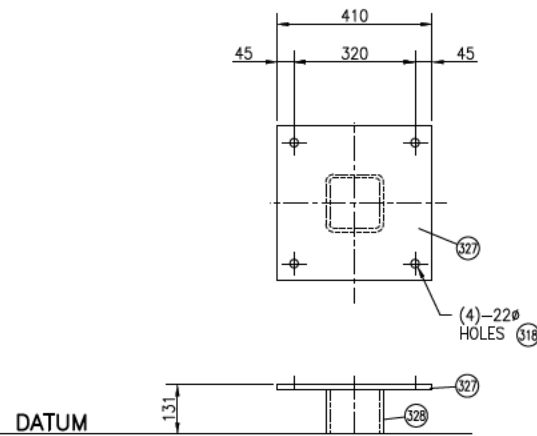

VS-1
(VIEWED FROM DATUM 'A')
(SCALE 1:10)

BILL OF MATERIAL				
ITEM	QUA	PART NO.	DESCRIPTION	
301	6	332017	HSS: 152 x 152 x 6 THK x 2352 LG	G40.21M-350W
302	1	332017	HSS: 152 x 152 x 6 THK x 3108 LG	G40.21M-350W
303	1	332017	HSS: 152 x 152 x 6 THK x 2719 LG	G40.21M-350W
304	1	332017	HSS: 152 x 152 x 6 THK x 295 LG	G40.21M-350W
305	1	332017	HSS: 152 x 152 x 6 THK x 2781 LG	G40.21M-350W
306	3	332017	HSS: 152 x 152 x 6 THK x 2401 LG	G40.21M-350W
307	1	330001	W150 x 22 x 540 LG	G40.21M-300W
308	2	330001	W150 x 22 x 230 LG	G40.21M-300W
309	1	330001	W150 x 22 x 370 LG	G40.21M-300W
310	1	330001	W150 x 22 x 215 LG	G40.21M-300W
311	1	330001	W150 x 22 x 600 LG	G40.21M-300W
312	1	330000	W100 x 19 x 270 LG	G40.21M-300W
313	1	330000	W100 x 19 x 200 LG	G40.21M-300W
314	1	330001	W150 x 22 x 500 LG	G40.21M-300W
315	1	330001	W150 x 22 x 560 LG	G40.21M-300W
316	1	330001	W150 x 22 x 180 LG	G40.21M-300W
317	1	330001	W150 x 22 x 190 LG	G40.21M-300W
318	8	200903	M/C BOLTS: 19Ø x 64 LG UNC c/w NUT AND WASHER	SA-325
319	3	370030	FLAT BAR: 10 THK x 203 x 190 LG	G40.21M-300W
320	18	370025	FLAT BAR: 10 THK x 102 x 179 LG	G40.21M-300W
321	1	370028	FLAT BAR: 10 THK x 152 SQ.	G40.21M-300W
322	2	370023	FLAT BAR: 10 THK x 76 x 141 LG	G40.21M-300W
323	4	200179	M/C BOLTS: 19Ø x 51 LG UNC c/w NUT AND WASHER	SA-325
324	1	330007	W200 x 46 x 1640 LG	G40.21M-300W
325	2	330007	W200 x 46 x 2025 LG	G40.21M-300W
326	1	330001	W150 x 22 x 2072 LG	G40.21M-300W
327	1	327002	PLATE: 12.7 THK x 400 SQ.	SA-36
328	1	332017	HSS: 152 x 152 x 6 THK x 118 LG	G40.21M-350W

THE DESIGN IT COVERS ARE CONFIDENTIAL AND THE PROPERTY OF PROPAG SYSTEMS LTD., AND SHALL NOT BE DISCLOSED TO OTHERS OR REPRODUCED IN ANY MANNER OR USED FOR ANY PURPOSE WHATSOEVER EXCEPT BY WRITTEN CONSENT OF PROPAG.

GENERAL NOTES		GENERAL NOTES		REVISION		BY		DATE		CKD		ENG	
DATE: 2004/09/07 01:28 PM J:\JOBS04\043167\20-DRAWINGS\FAB\SKD\SKD-043167-113.DWG quentins		2		ADDED CLIENT'S NAME AND LOCATION		QLS		04/09/07					
		1		ISSUED FOR CONSTRUCTION		BLAMMERS		04/07/22		AL		RT	

APPROVED		DRAWN	
MECH./STRUCT. JR	BY	PSC	DATE
DATE	03/10/06	CHECKED	DATE
ELECTRICAL	BY	JLS	DATE
PROJECT	RT	DATE	03/10/06
DATE	03/10/06	SCALE	AS NOTED

REFRIGERA ON UN		6B	
SKID STEEL			
DWG. No.: D-SKD-043167-113		SHT 3 OF 3	
		REV. 2	

PROPAG
440 East Lake Road,
Airdrie, Alberta
Canada T4A 2J8