


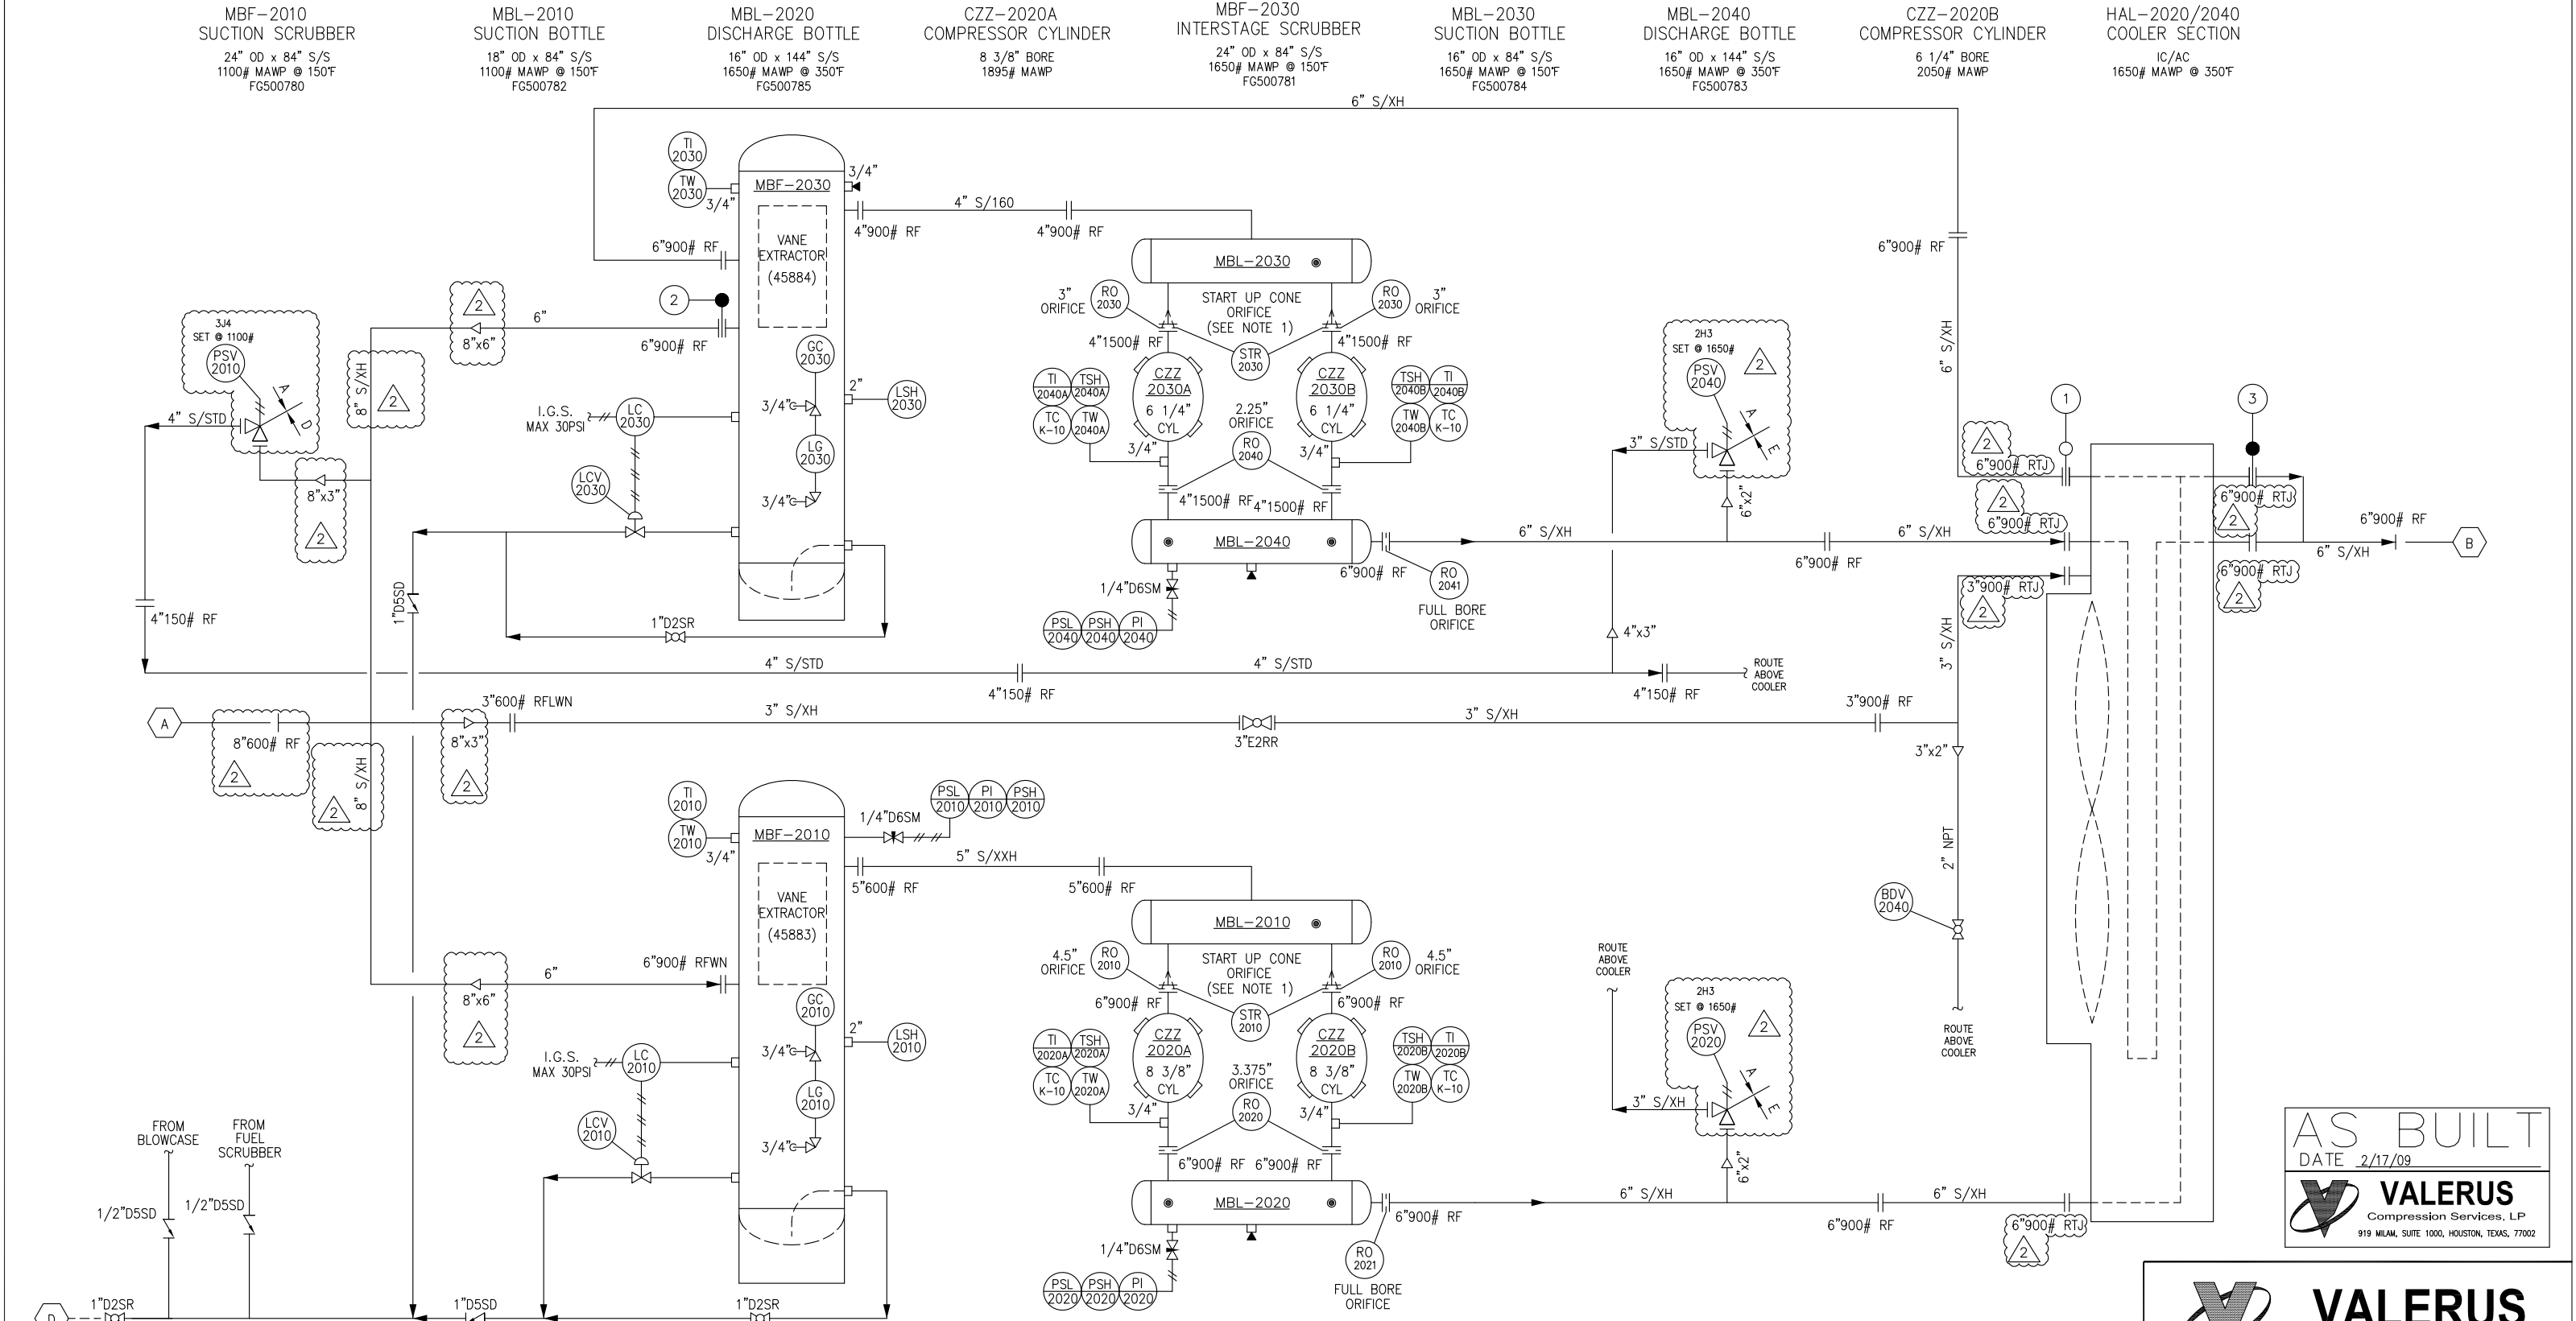

L	FOUR	2"	3000 LB.	FNPT	SKID DRAINS
K	ONE	1"	3000 LB.	FNPT	LUBE OIL MAKEUP
H	ONE	1"	3000 LB.	FNPT	EJW LOW POINT DRAIN / TAW DRAIN
G	ONE	2"	3000 LB.	FNPT	ENGINE AND COMPRESSOR OIL DRAIN
F	ONE	2"	3000 LB.	FNPT	FUEL GAS INLET
E	-	-	-	-	-
D	ONE	1"	3000 LB.	FNPT	SCRUBBER DRAINS
C	-	-	-	-	-
B	ONE	6"	900 LB.	RFWN	UNIT DISCHARGE
A	ONE	8"	600 LB.	RFWN	UNIT SUCTION
MK	QTY	SIZE	RATING	TYPE	SERVICE
CONNECTION SCHEDULE					STAGE CONFIGURATION
					FIG. 8 BLIND No.
					SINGLE STAGE
					TWO STAGE

COMPRESSOR	ARIEL JGK/4	SHIMS	ENGINE	(10) SM-20
CYLINDERS	(2) 8 3/8" (2) 6 1/4"		COMPRESSOR	(6) SM-30
ENGINE	WAUKESHA 7044		DIST/PC SUPPORT	(8) SM-16 ID28
COUPLING	FSH 70-28	BOLTING	ENGINE	(10) CAPSCREW, 3/4"
COOLER	AIR-X-CHANGERS 156 EH		COMPRESSOR	ALL THRD, 1-1/8", 8TPI
PANEL	MURPHY		DIST/PC SUPPORT	(8) CAPSCREW, 1"
MUFFLER	MAXIM EAC-67-14	SHEAVES	COOLER	SHV,6C,36.4",3-1/2" E
			ENGINE	SHV,6C,8.9",3-7/16" J
			IDLER	SHV,12.4",2-7/16" F
MAJOR COMPONENTS		MOUNTING & COOLER COMPONENTS		

NOTE 1: SUCTION ORIFICE PLATES SHIPPED LOOSE.

THIS DRAWING AND ITS CONTENTS ARE THE PROPERTY OF VALERUS COMPRESSION SERVICES AND SHALL NOT BE USED, REPRODUCED OR DISCLOSED EXCEPT IN ACCORDANCE WITH ITS WRITTEN PERMISSION.

AS BUILT

DATE 2/17/09

VALERUS

Compression Services, LP

919 MILAM, SUITE 1000, HOUSTON, TEXAS, 77002

VALERUS

Compression Services, LP

919 Milam, Ste. 1000, Houston, TX, 77002

DATE	DRAWN	CHECKED	APPROVED
7/7/08	RB		

CLIENT

PEMEX (B)


TITLE

COMPRESSOR PACKAGE

PROCESS P & ID

SCALE:	FG#	JOB#
NONE	FG501025	

DRAWING NUMBER	SHEETS	REV
V35010100-01-02	SHT# 1 OF 3	2

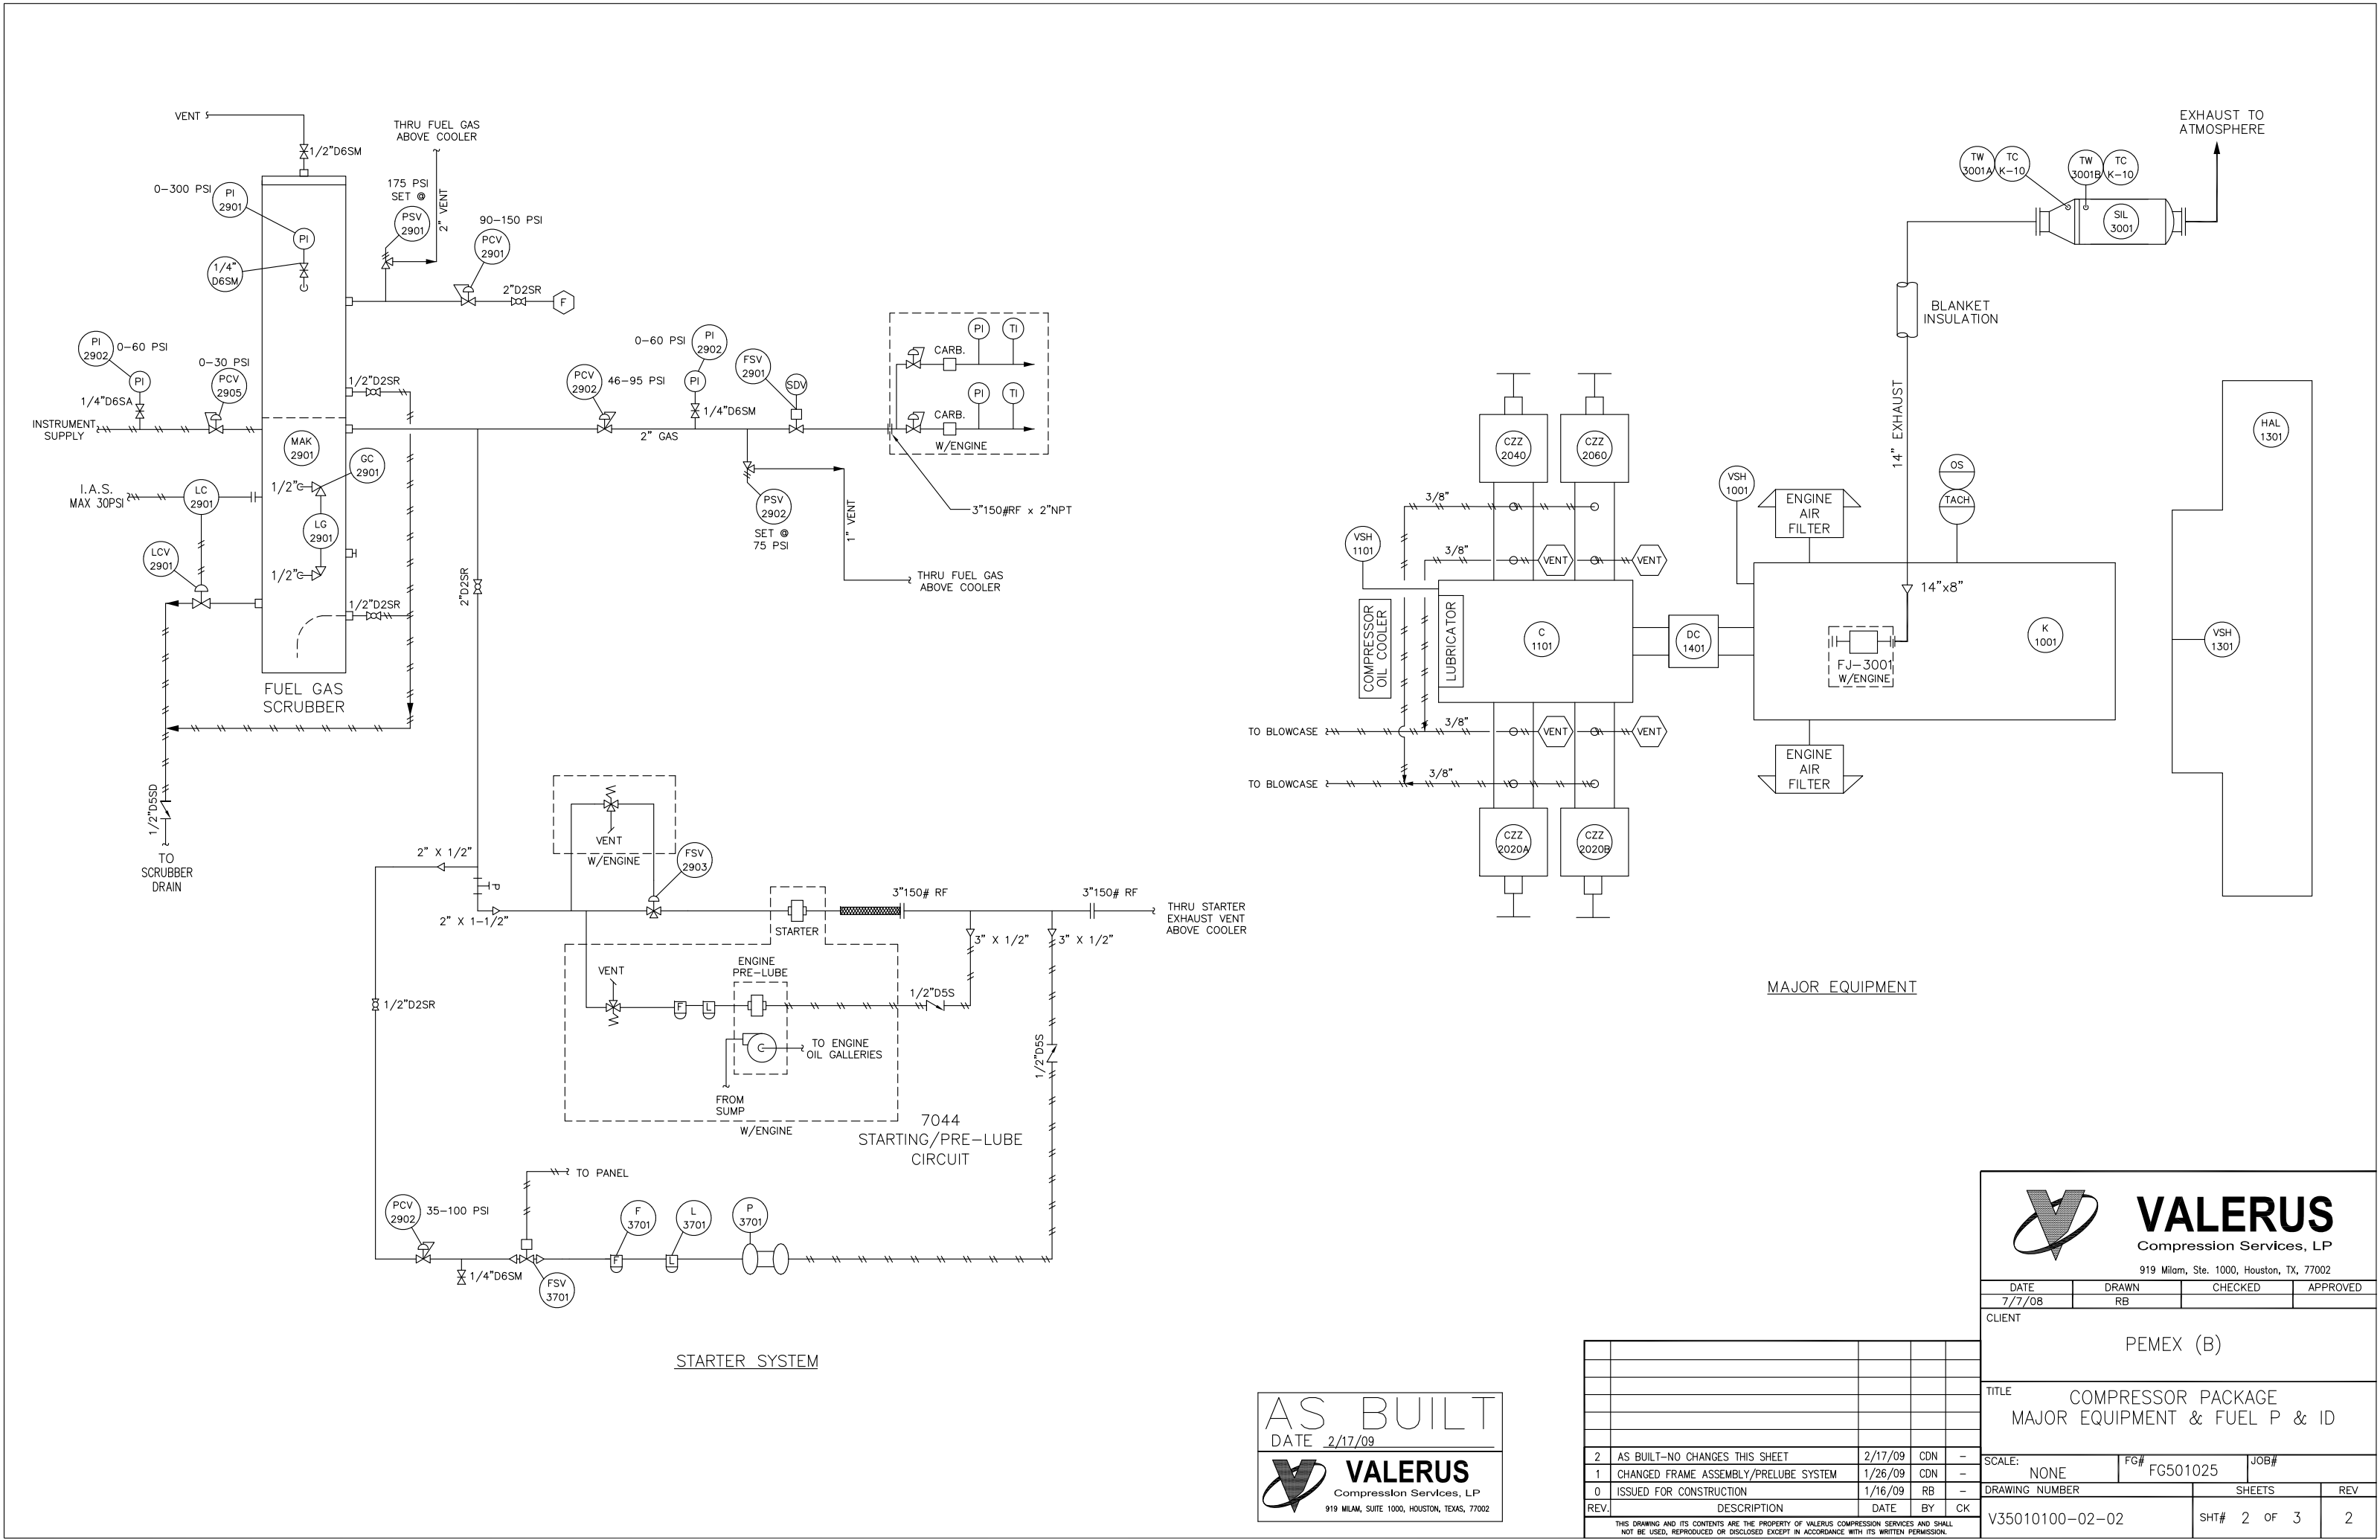

AS BUILT

DATE 2/17/09

 **VALERUS**
Compression Services, LP
919 MILAM, SUITE 1000, HOUSTON, TEXAS, 77002

2	AS BUILT-NO CHANGES THIS SHEET	2/17/09	CDN	-	
1	CHANGED FRAME ASSEMBLY/PRELUBE SYSTEM	1/26/09	CDN	-	
0	ISSUED FOR CONSTRUCTION	1/16/09	RB	-	
REV.	DESCRIPTION	DATE	BY	CK	
THIS DRAWING AND ITS CONTENTS ARE THE PROPERTY OF VALERUS COMPRESSION SERVICES AND SHALL NOT BE USED, REPRODUCED OR DISCLOSED EXCEPT IN ACCORDANCE WITH ITS WRITTEN PERMISSION.					

 **VALERUS**
Compression Services, LP
919 Milam, Ste. 1000, Houston, TX, 77002

DATE	DRAWN	CHECKED	APPROVED
7/7/08	RB		
CLIENT			
PEMEX (B)			
TITLE			
COMPRESSOR PACKAGE MAJOR EQUIPMENT & FUEL P & ID			
SCALE:		FG#	JOB#
NONE		FG501025	
DRAWING NUMBER		SHEETS	REV
V35010100-02-02		SHT# 2 OF 3	2



2	AS BUILT--NO CHANGES THIS SHEET	2/17/09	CDN	-
1	CHANGED FRAME ASSEMBLY	1/26/09	CDN	-
0	ISSUED FOR CONSTRUCTION	1/10/09	RB	-
REV.	DESCRIPTION	DATE	BY	CK
THIS DRAWING AND ITS CONTENTS ARE THE PROPERTY OF VALERUS COMPRESSION SERVICES AND SHALL NOT BE USED, REPRODUCED OR DISCLOSED EXCEPT IN ACCORDANCE WITH ITS WRITTEN PERMISSION.				

		VALERUS Compression Services, LP	
919 Milam, Ste. 1000, Houston, TX, 77002			
DATE	DRAWN	CHECKED	APPROVED
7/7/08	RB		
CLIENT			
PEMEX (B)			
TITLE			
COMPRESSOR PACKAGE WATER & OIL P & ID			
SCALE:	FIG#	JOB#	
NONE	FG501025		
DRAWING NUMBER	SHEETS		REV
V35010100-03-02	SHT# 3 OF 3		2