


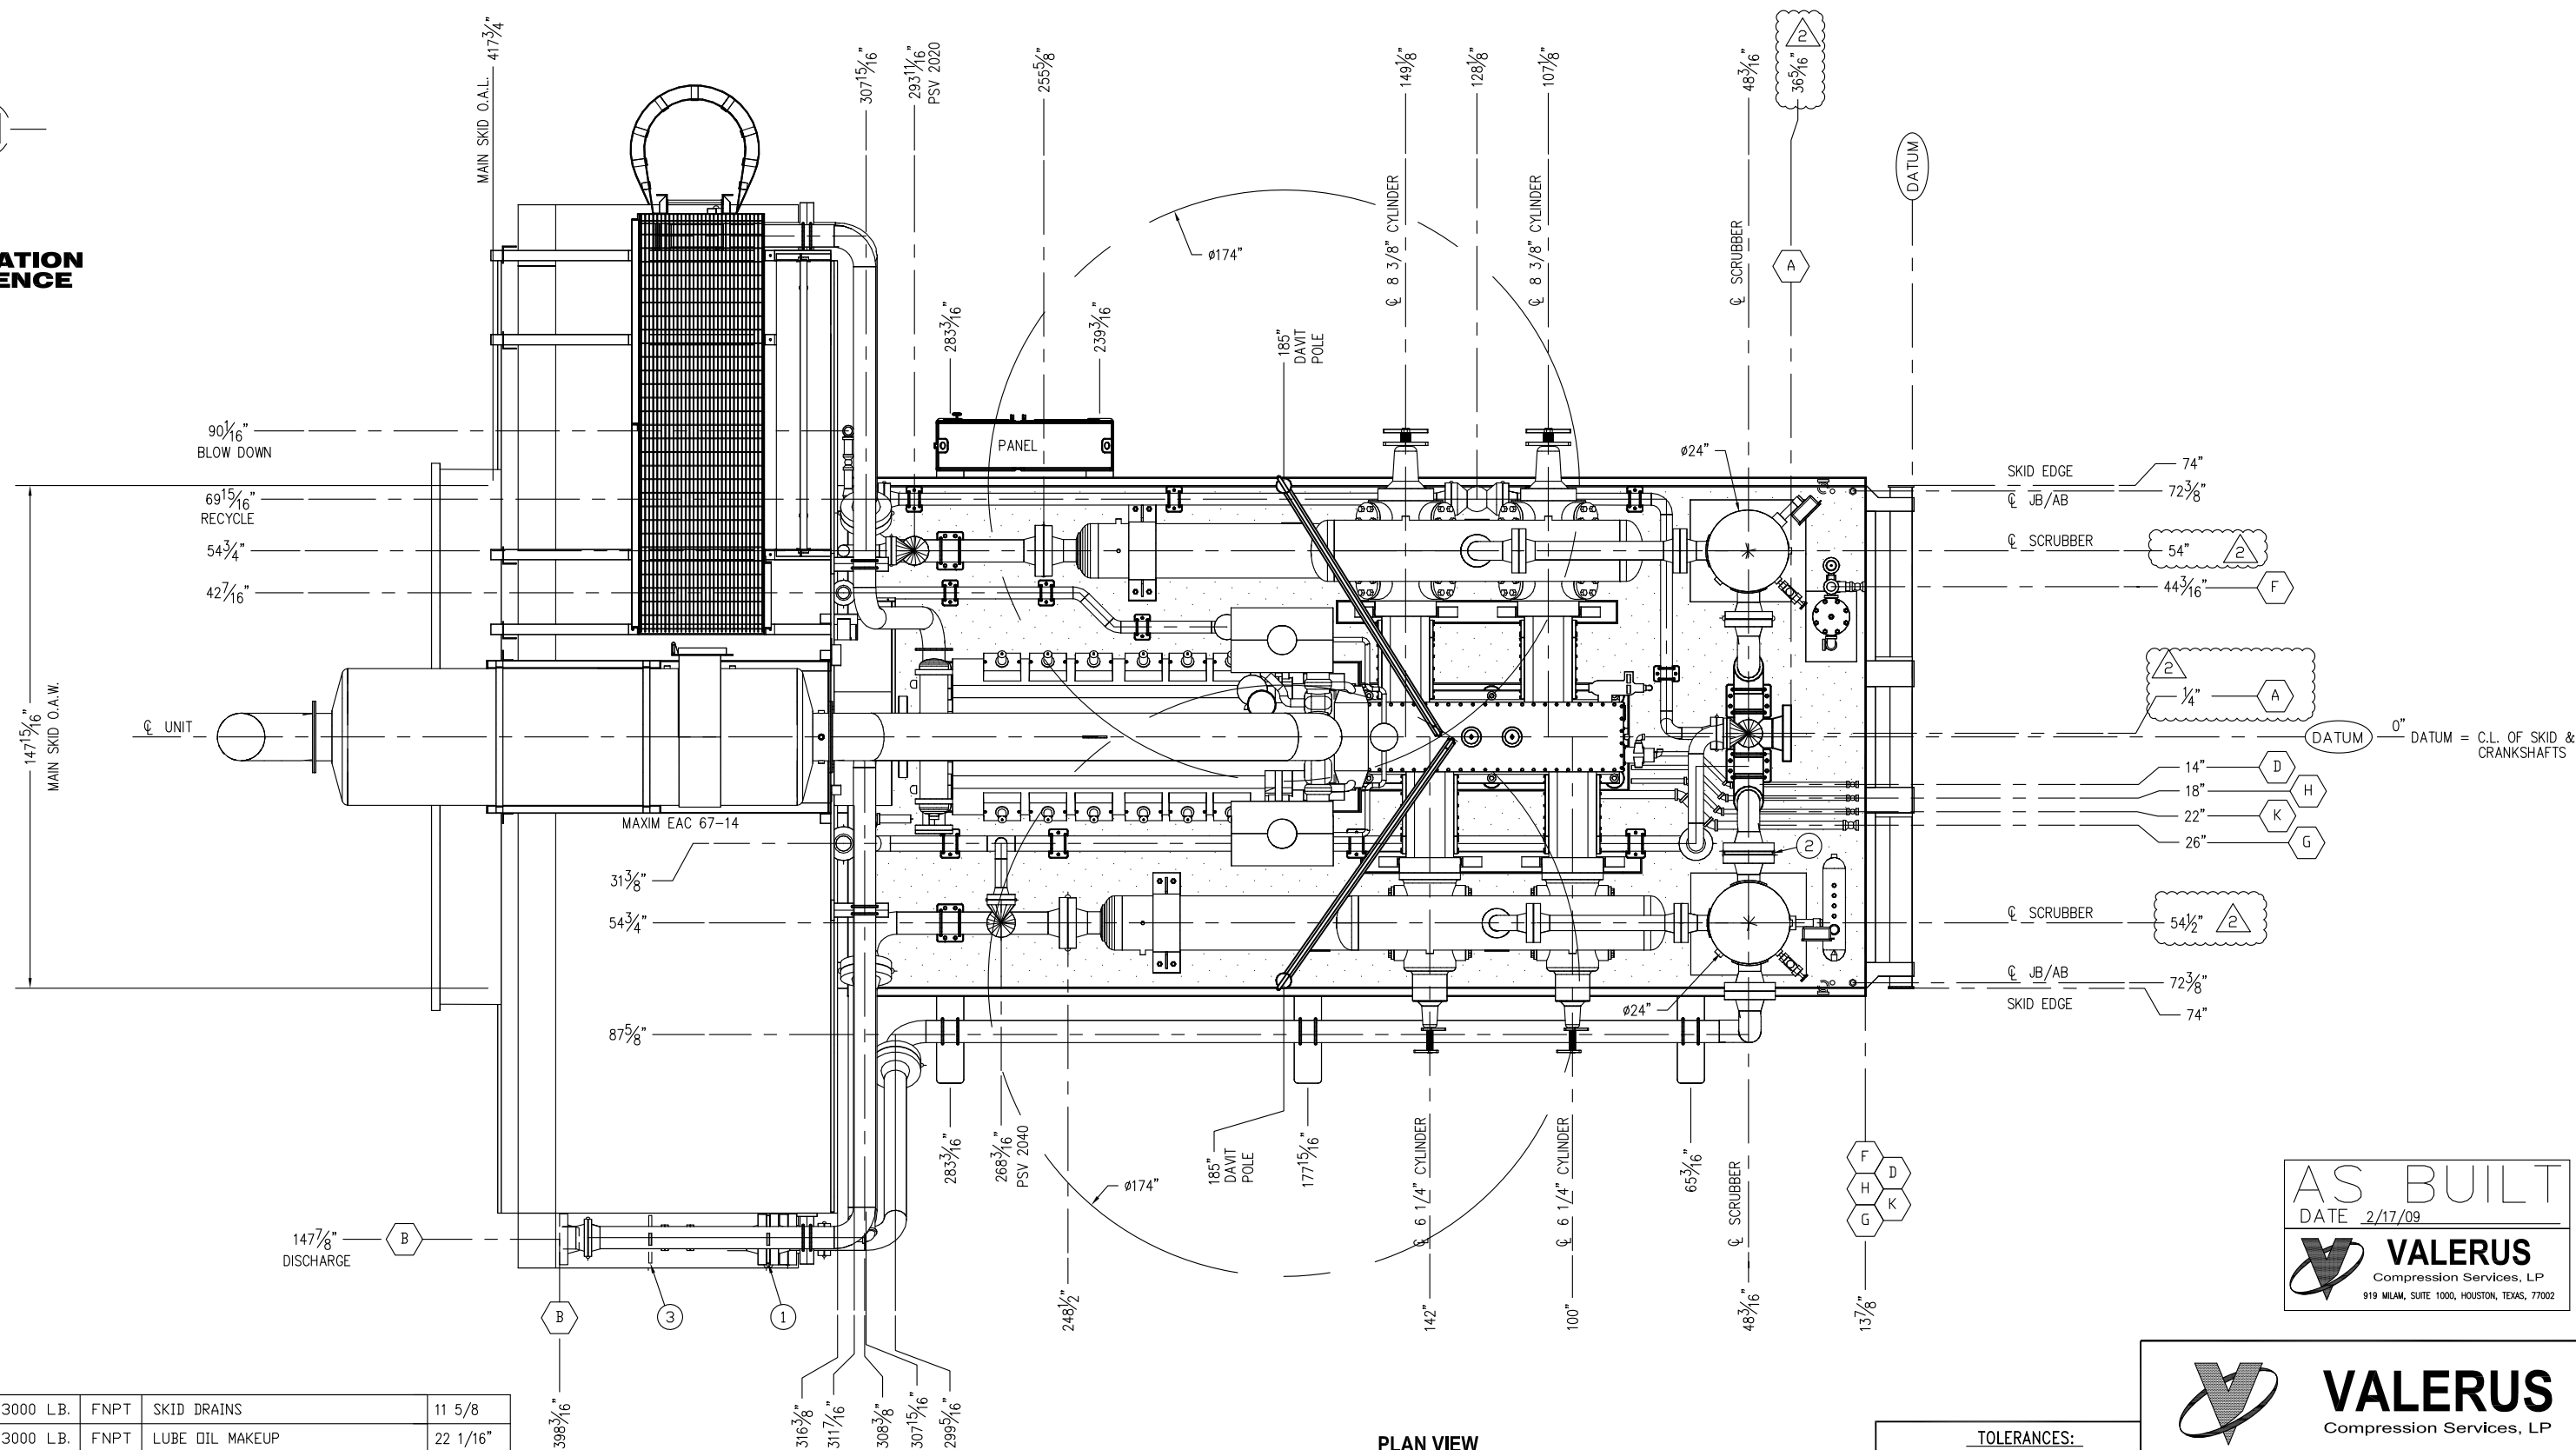


TOLERANCES:

PROCESS CONNECTIONS..... $\pm 1/2"$
UTILITY CONNECTIONS..... $\pm 1"$
STRUCTURAL..... $\pm 1/4"$
ANCHOR BOLTS..... $\pm 1/16"$

 VALERUS Compression Services, LP 919 Milam, Ste. 1000, Houston, TX, 77002			
DATE	DRAWN	CHECKED	APPROVED
7/7/08	RB	-	-
CLIENT			
PEMEX (B)			
TITLE			
COMPRESSOR PACKAGE			
GENERAL ARRANGEMENT PLAN VIEW			
REFERENCE: MD-V3501 (AS BUILT)			
SCALE:	FIG#	JOB#	
1/2"=1'-0	FG501025		
DRAWING NUMBER	SHEETS		REV
V35010200-01-02	SHT# 1 OF 7		2

(L)	FOUR	2'	3000 L.B.	FNPT	SKID DRAINS	11 5/8"	308 3/16"		316 3/8"	311 7/16"
(K)	ONE	1'	3000 L.B.	FNPT	LUBE OIL MAKEUP	22 1/16"				
(J)	-	-	-	-	-	-				
(H)	ONE	1'	3000 L.B.	FNPT	EJW LOW POINT DRAIN / TAW DRAIN	22 1/16"				
(G)	ONE	2'	3000 L.B.	FNPT	ENGINE AND COMPRESSOR OIL DRAIN	22 5/8"				
(F)	ONE	2'	3000 L.B.	FNPT	FUEL GAS INLET	22 5/8"				
(E)	-	-	-	-	-	-				
(D)	ONE	1'	3000 L.B.	FNPT	SCRUBBER DRAINS	22 1/16"				
(C)	-	-	-	-	-	-		(3)	○ OPEN	● CLOSED
(B)	ONE	6'	900 L.B.	RFWN	UNIT DISCHARGE	30"		(2)	○ OPEN	● CLOSED
(A)	ONE	8'	600 L.B.	RFWN	UNIT SUCTION	29"		(1)	● CLOSED	○ OPEN
MK	QTY	SIZE	RATING	TYPE	SERVICE		FIG. 8 BLIND No.	SINGLE STAGE	TWO STAGE	
CONNECTION SCHEDULE							STAGE CONFIGURATION			

COMPRESSOR	ARIEL JGK/4	SHIMS	ENGINE	(10) SM-20
CYLINDERS	(2) 8 3/8" (2) 6 1/4"		COMPRESSOR	(6) SM-30
ENGINE	WAKUESHA 7044		DIST/PC SUPPORT	(8) SM-16 ID28
COUPLING	FSH 70-28	BOLTING	ENGINE	(10) CAPSCREW, 3/4"
COOLER	AIR-X-CHANGERS 156 EH		COMPRESSOR	ALLTHRD, 1-1/8", 8TPI
PANEL	MURPHY		DIST/PC SUPPORT	(8) CAPSCREW, 1"
MUFFLER	MAXIM EAC-67-14	SHEAVES	COOLER	SHV, 6C, 36.4", 3-1/2" E
			ENGINE	SHV, 6C, 8.9", 3-7/16" J
			IDLER	SHV, 12.4", 2-7/16" F
MAJOR COMPONENTS		MOUNTING AND COOLER COMPONENTS		

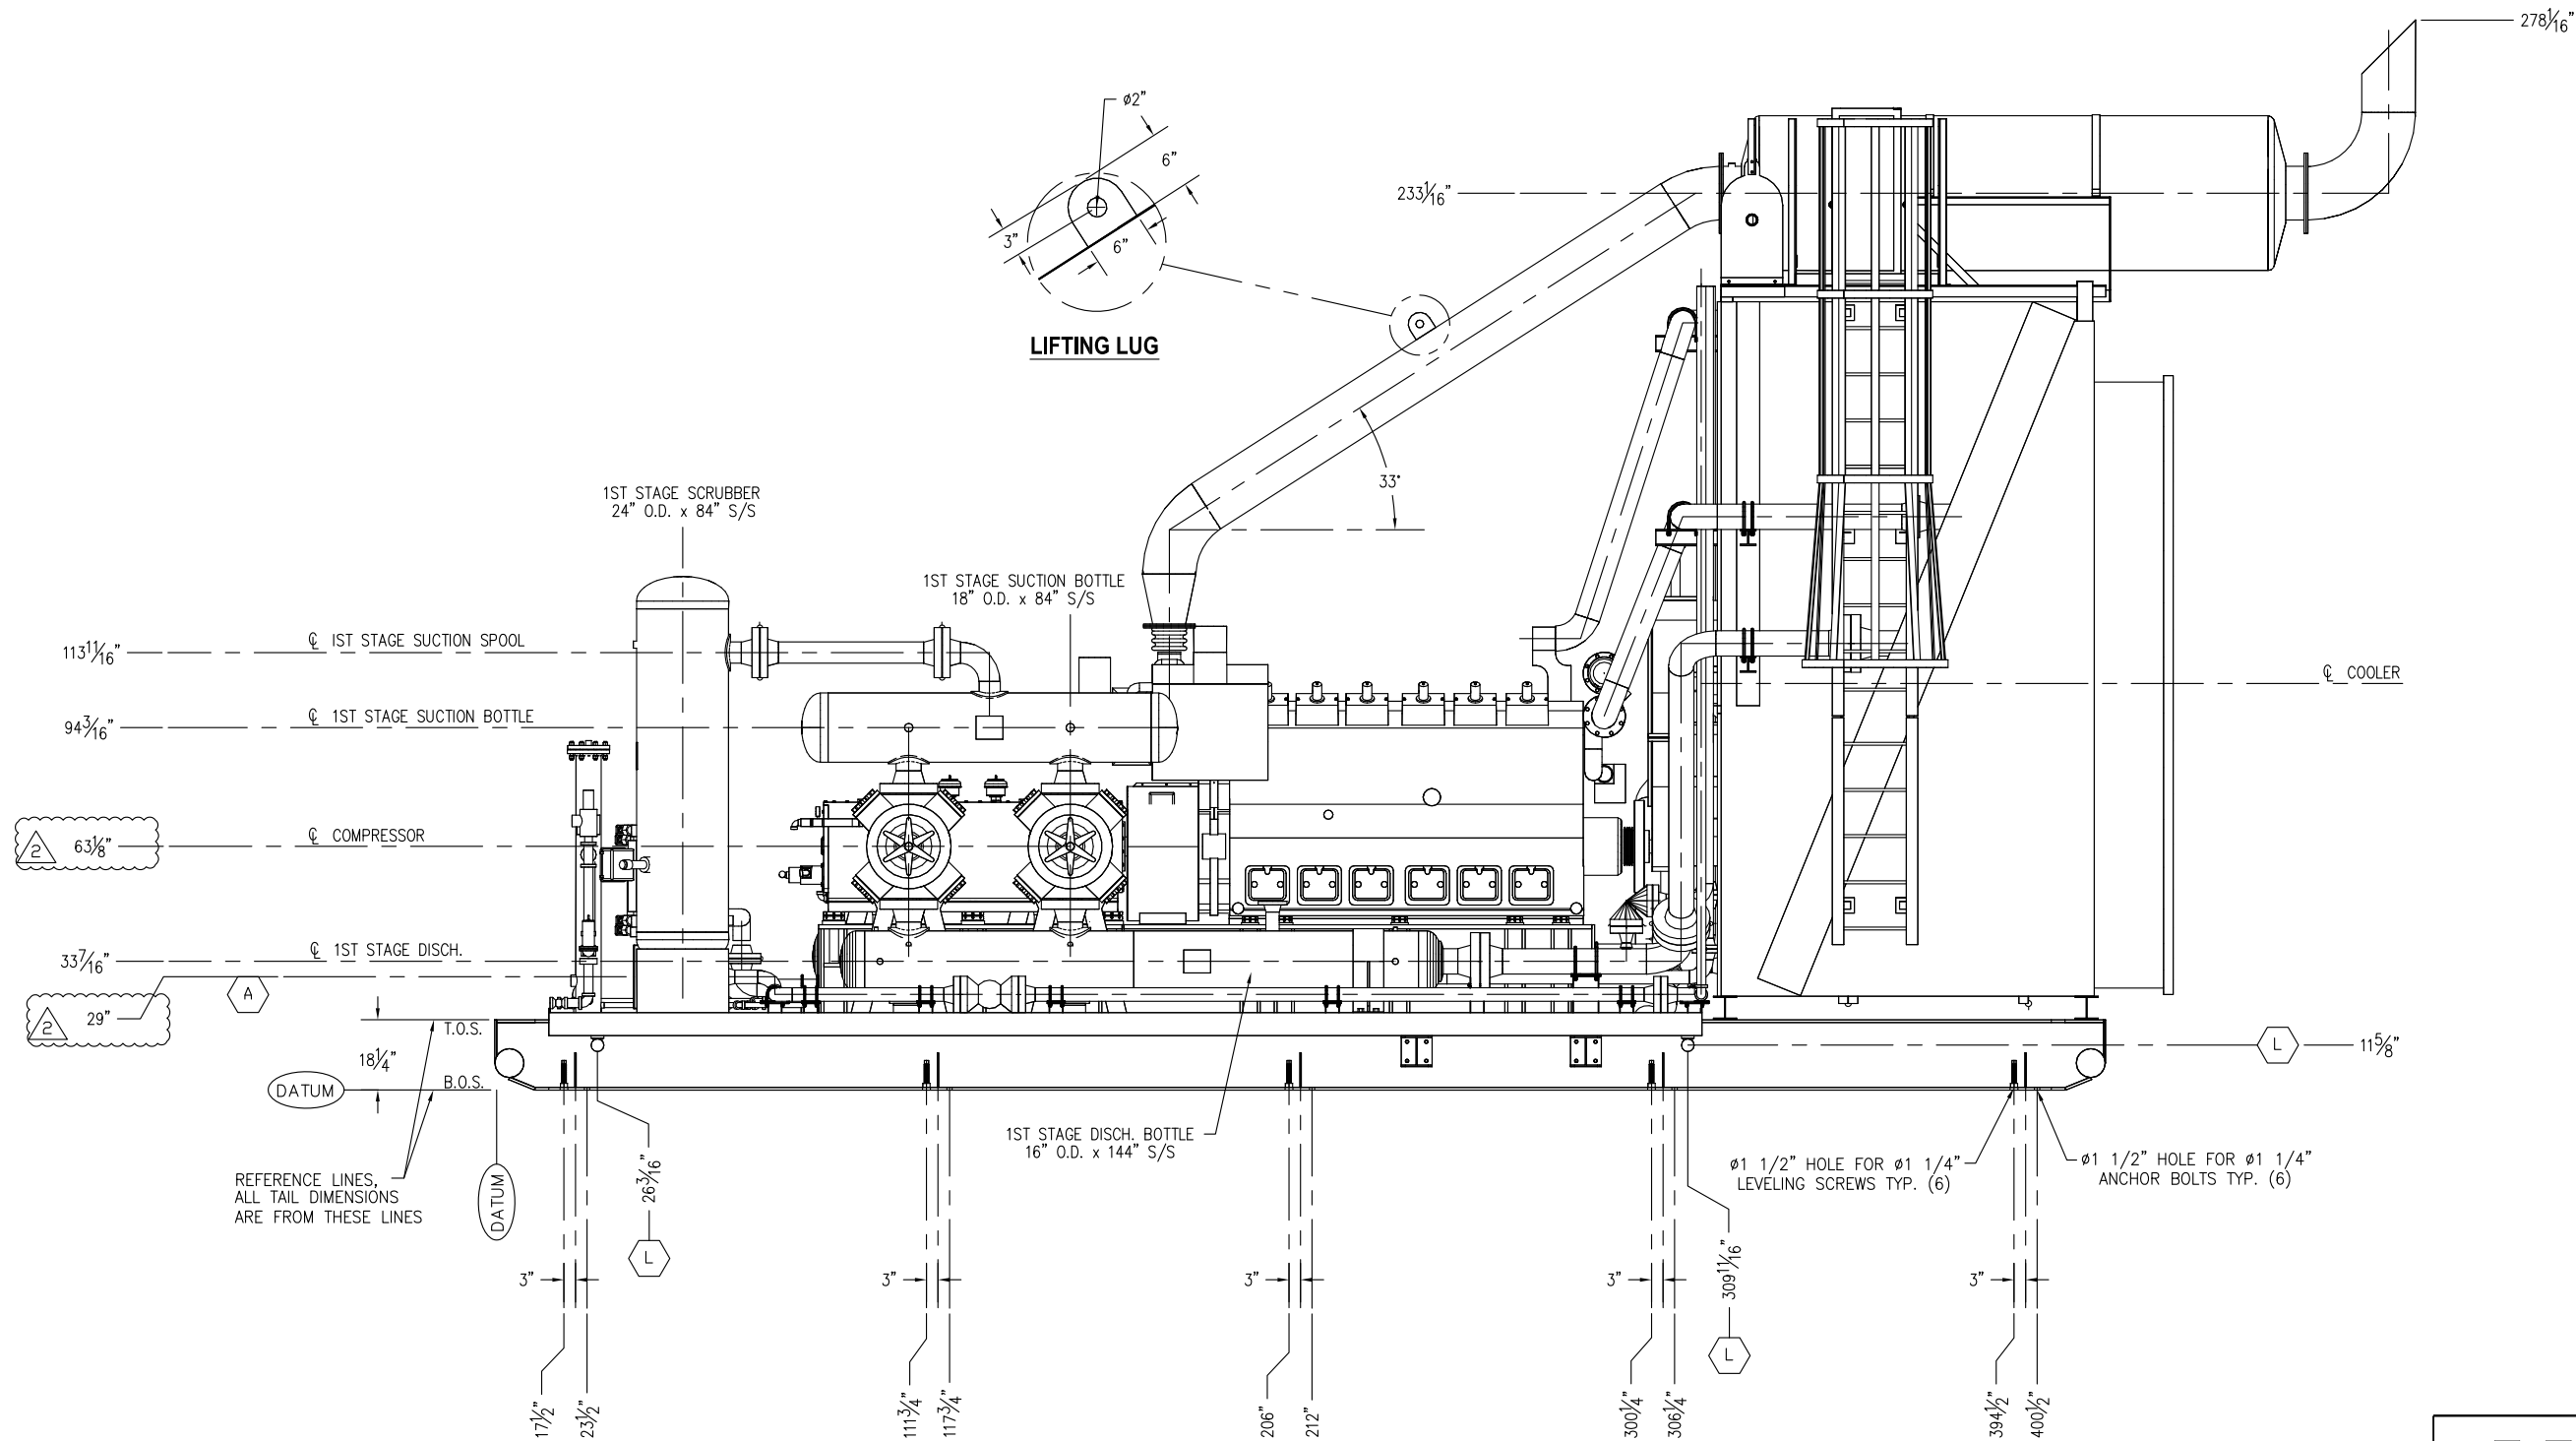

NORTH ELEVATION

AS BUILT
DATE 2/17/09


VALERUS
Compression Services, LP
919 MILAM, SUITE 1000, HOUSTON, TEXAS, 77002

REV.	DESCRIPTION	DATE	BY	CK
2	AS BUILT-COMPRESSOR	2/17/09	CDN	-
1	CHANGED FRAME ASSEMBLY	1/26/09	CDN	-
0	ISSUED FOR CONSTRUCTION	1/16/09	RB	-



VALERUS
Compression Services, LP
919 Milam, Ste. 1000, Houston, TX, 77002

DATE 7/7/08	DRAWN RB	CHECKED -	APPROVED -
CLIENT PEMEX (B)			
TITLE COMPRESSOR PACKAGE GENERAL ARRANGEMENT NORTH ELEVATION			
SCALE: 1/2"=1'-0	FG# FG501025	JOB#	
DRAWING NUMBER V35010200-03-02		SHEETS 3 OF 7	REV 2

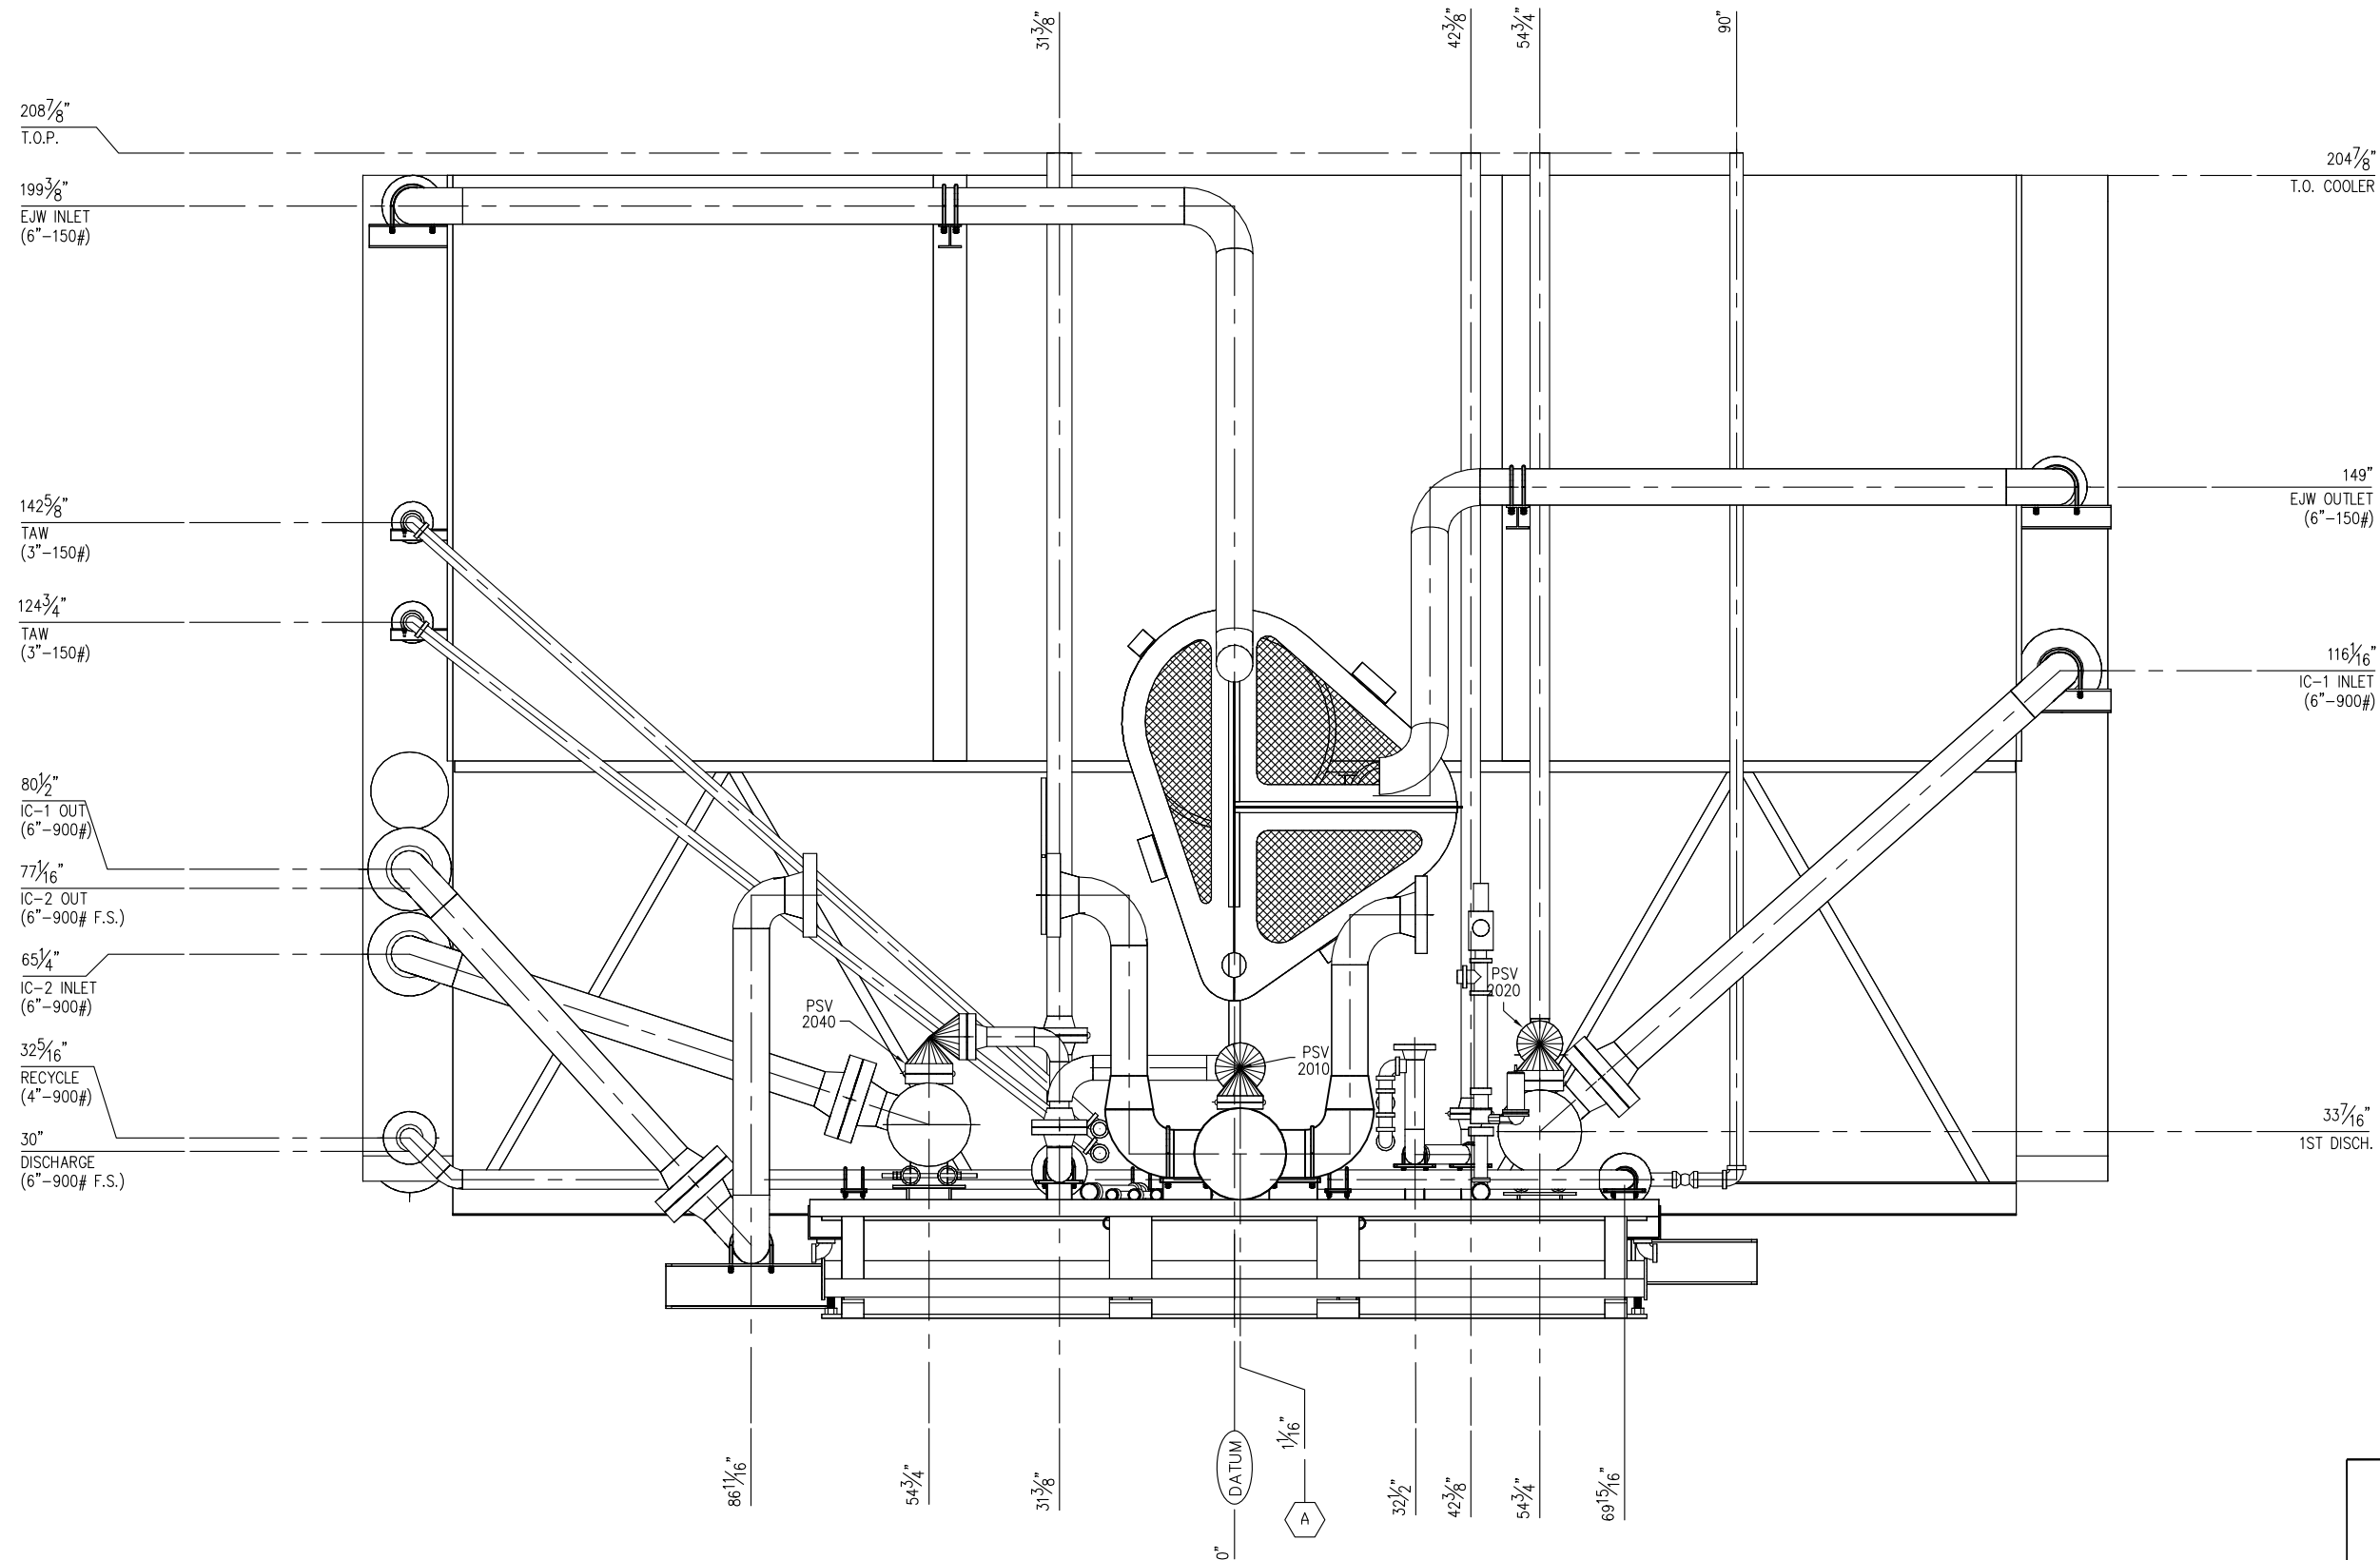

COOLER ELEVATION

AS BUILT


DATE 2/17/09

**VALERUS**
Compression Services, LP
919 MILAM, SUITE 1000, HOUSTON, TEXAS, 77002

2	AS BUILT-NO CHANGES THIS SHEET	2/17/09	CDN	-
1	CHANGED FRAME ASSEMBLY	1/26/09	CDN	-
0	ISSUED FOR CONSTRUCTION	1/16/09	RB	-
REV.	DESCRIPTION	DATE	BY	CK
THIS DRAWING AND ITS CONTENTS ARE THE PROPERTY OF VALERUS COMPRESSION SERVICES AND SHALL NOT BE USED, REPRODUCED OR DISCLOSED EXCEPT IN ACCORDANCE WITH ITS WRITTEN PERMISSION.				

**VALERUS**
Compression Services, LP
919 Milam, Ste. 1000, Houston, TX, 77002

DATE 7/7/08	DRAWN RB	CHECKED -	APPROVED -
CLIENT PEMEX (B)			
TITLE COMPRESSOR PACKAGE GENERAL ARRANGEMENT COOLER ELEVATION			
SCALE: 1/2"=1'-0	FG# FG501025	JOB#	
DRAWING NUMBER V35010200-04-02		SHEETS SHT# 4 OF 7	REV 2

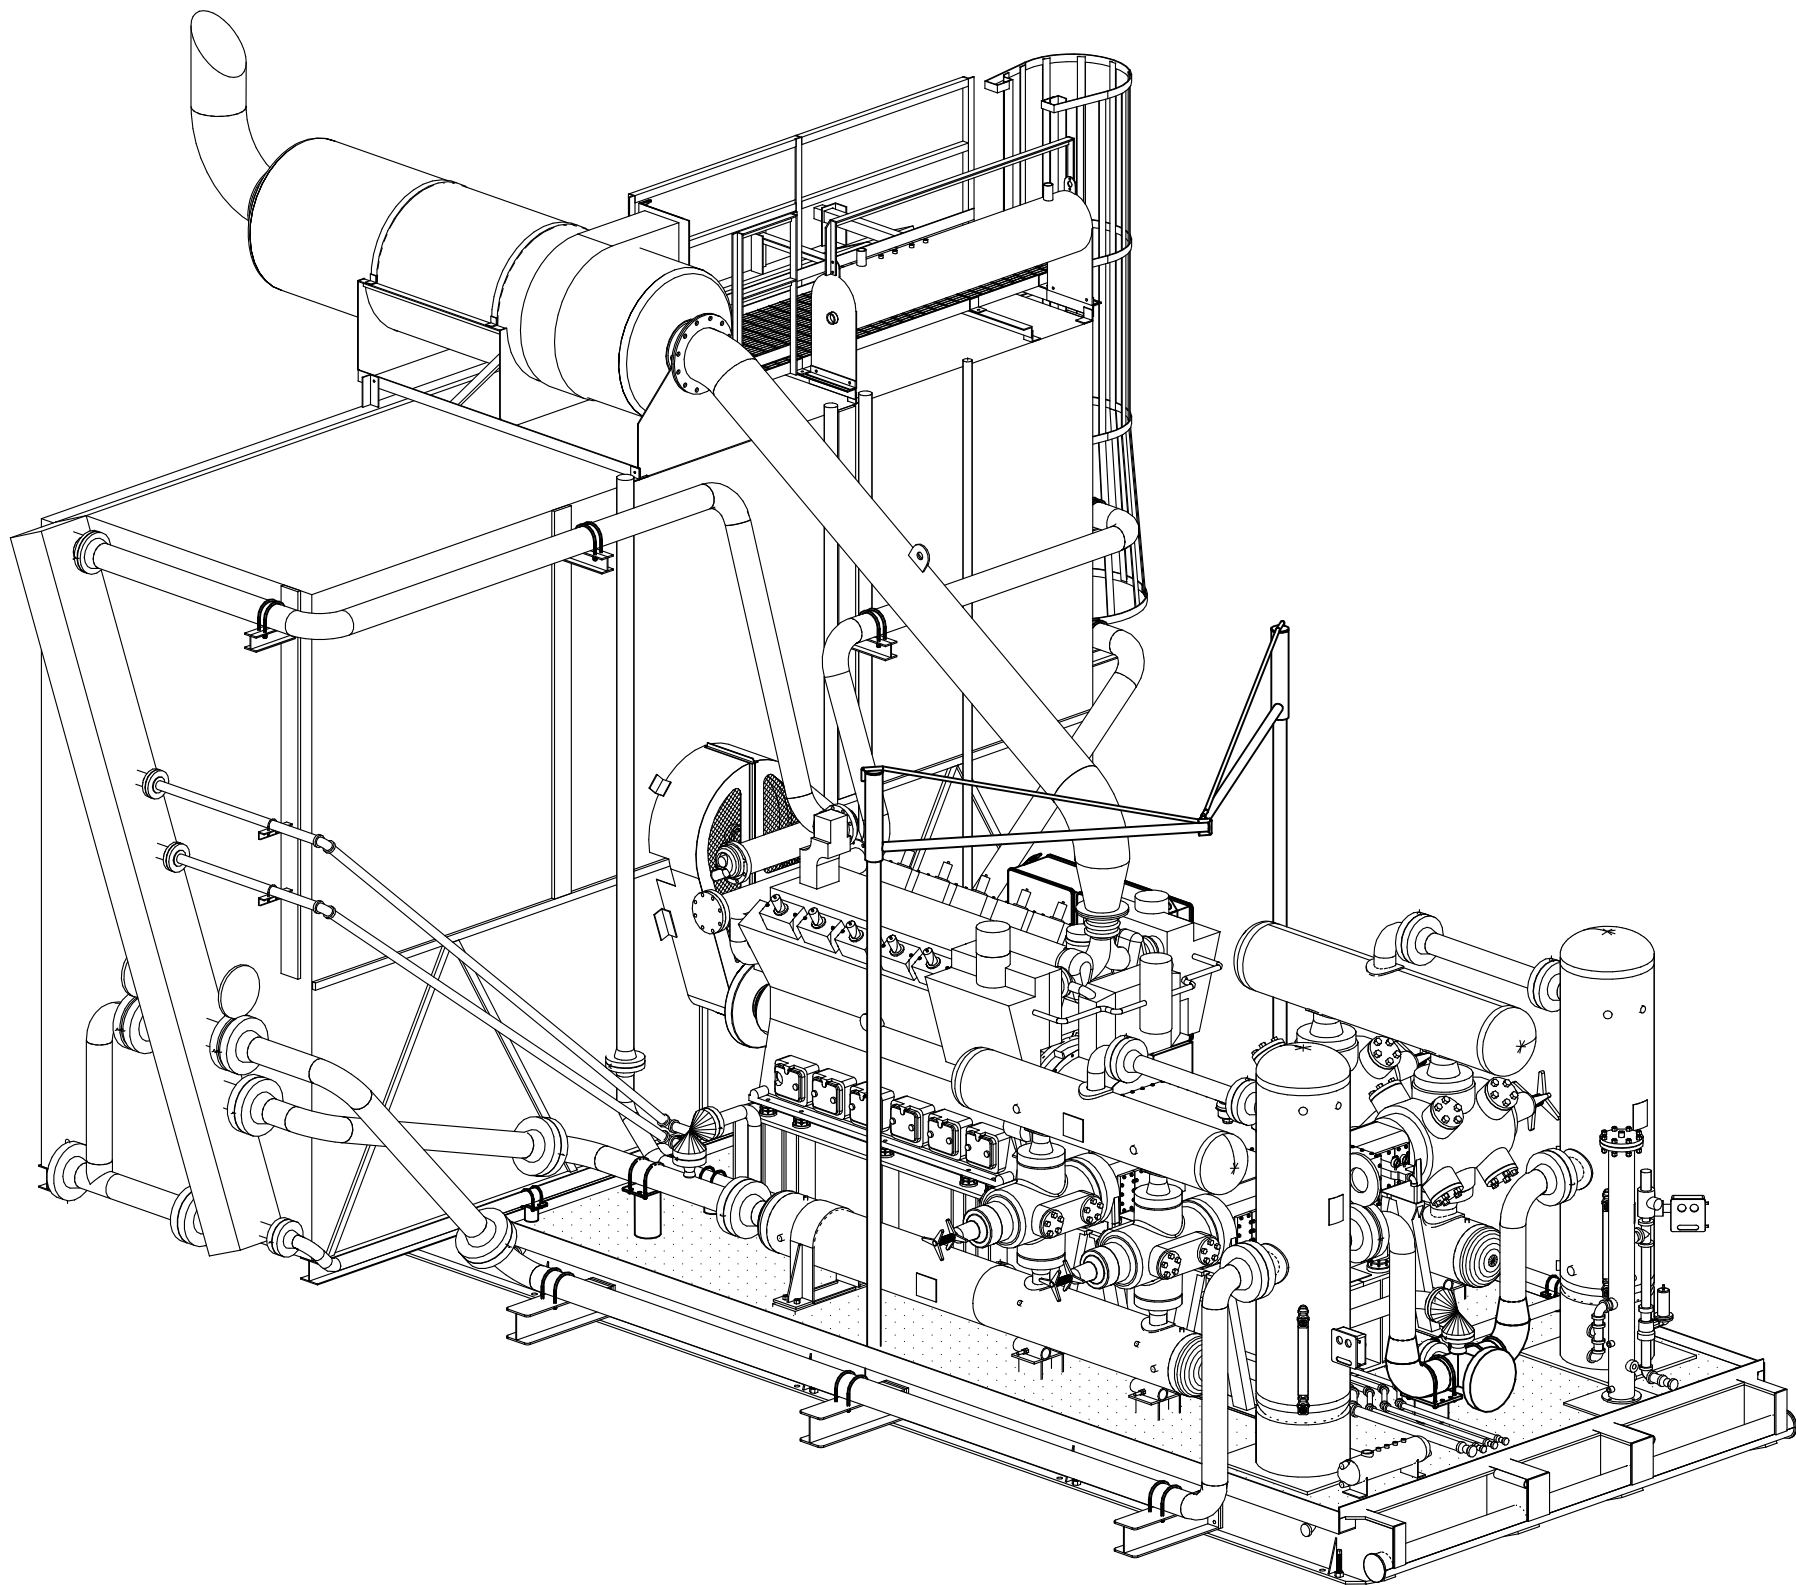

SOUTHEAST ISOMETRIC VIEW

AS BUILT


DATE 2/17/09

 **VALERUS**
Compression Services, LP
919 MILAM, SUITE 1000, HOUSTON, TEXAS, 77002

2	AS BUILT-NO CHANGES THIS SHEET	2/17/09	CDN	-
1	CHANGED FRAME ASSEMBLY	1/26/09	CDN	-
0	ISSUED FOR CONSTRUCTION	1/16/09	RB	-
REV.	DESCRIPTION	DATE	BY	CK
THIS DRAWING AND ITS CONTENTS ARE THE PROPERTY OF VALERUS COMPRESSION SERVICES AND SHALL NOT BE USED, REPRODUCED OR DISCLOSED EXCEPT IN ACCORDANCE WITH ITS WRITTEN PERMISSION.				

 **VALERUS**
Compression Services, LP
919 Milam, Ste. 1000, Houston, TX, 77002

DATE	DRAWN	CHECKED	APPROVED
7/7/08	RB	-	-
CLIENT			
PEMEX (B)			
TITLE			
COMPRESSOR PACKAGE GENERAL ARRANGEMENT ISO VIEW 01			
SCALE:	FG#	JOB#	
1/2"=1'-0	FG501025		
DRAWING NUMBER		SHEETS	REV
V35010200-05-02		SHT# 5 OF 7	2

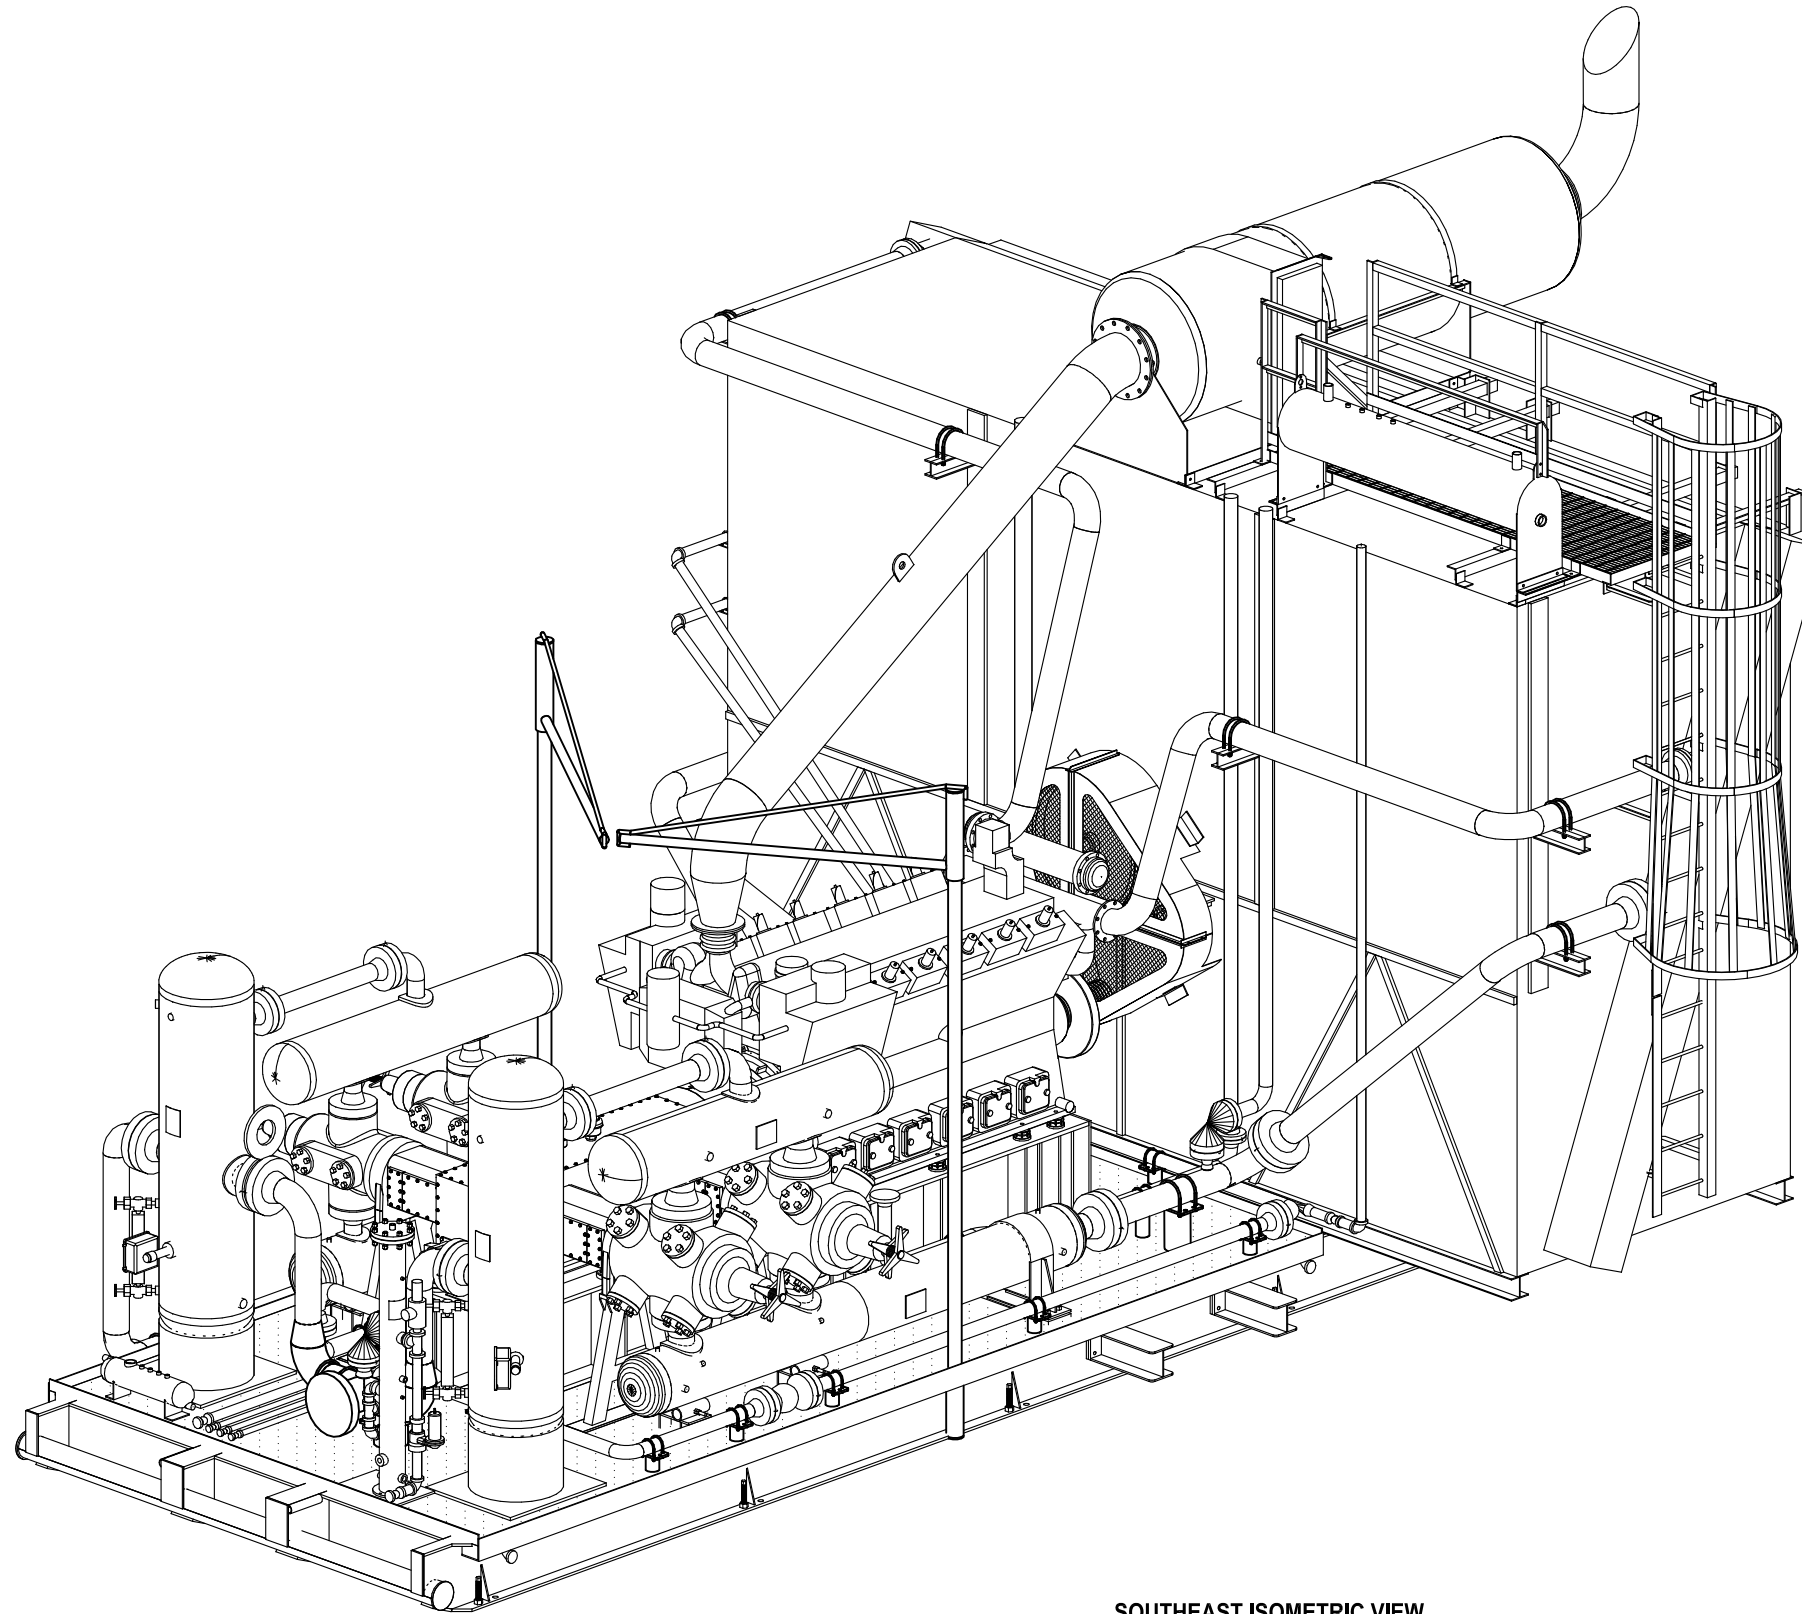

SOUTHEAST ISOMETRIC VIEW

AS BUILT


DATE 2/17/09

 **VALERUS**
Compression Services, LP
919 MILAM, SUITE 1000, HOUSTON, TEXAS, 77002

2	AS BUILT-NO CHANGES THIS SHEET	2/17/09	CDN	-
1	CHANGED FRAME ASSEMBLY	1/26/09	CDN	-
0	ISSUED FOR CONSTRUCTION	1/16/09	RB	-
REV.	DESCRIPTION	DATE	BY	CK
THIS DRAWING AND ITS CONTENTS ARE THE PROPERTY OF VALERUS COMPRESSION SERVICES AND SHALL NOT BE USED, REPRODUCED OR DISCLOSED EXCEPT IN ACCORDANCE WITH ITS WRITTEN PERMISSION.				

 **VALERUS**
Compression Services, LP
919 Milam, Ste. 1000, Houston, TX, 77002

DATE 7/7/08	DRAWN RB	CHECKED -	APPROVED -
CLIENT PEMEX (B)			
TITLE COMPRESSOR PACKAGE GENERAL ARRANGEMENT ISO VIEW 02			
SCALE: 1/2"=1'-0	FG# FG501025	JOB#	
DRAWING NUMBER V35010200-06-02		SHEETS 6 OF 7	REV 2

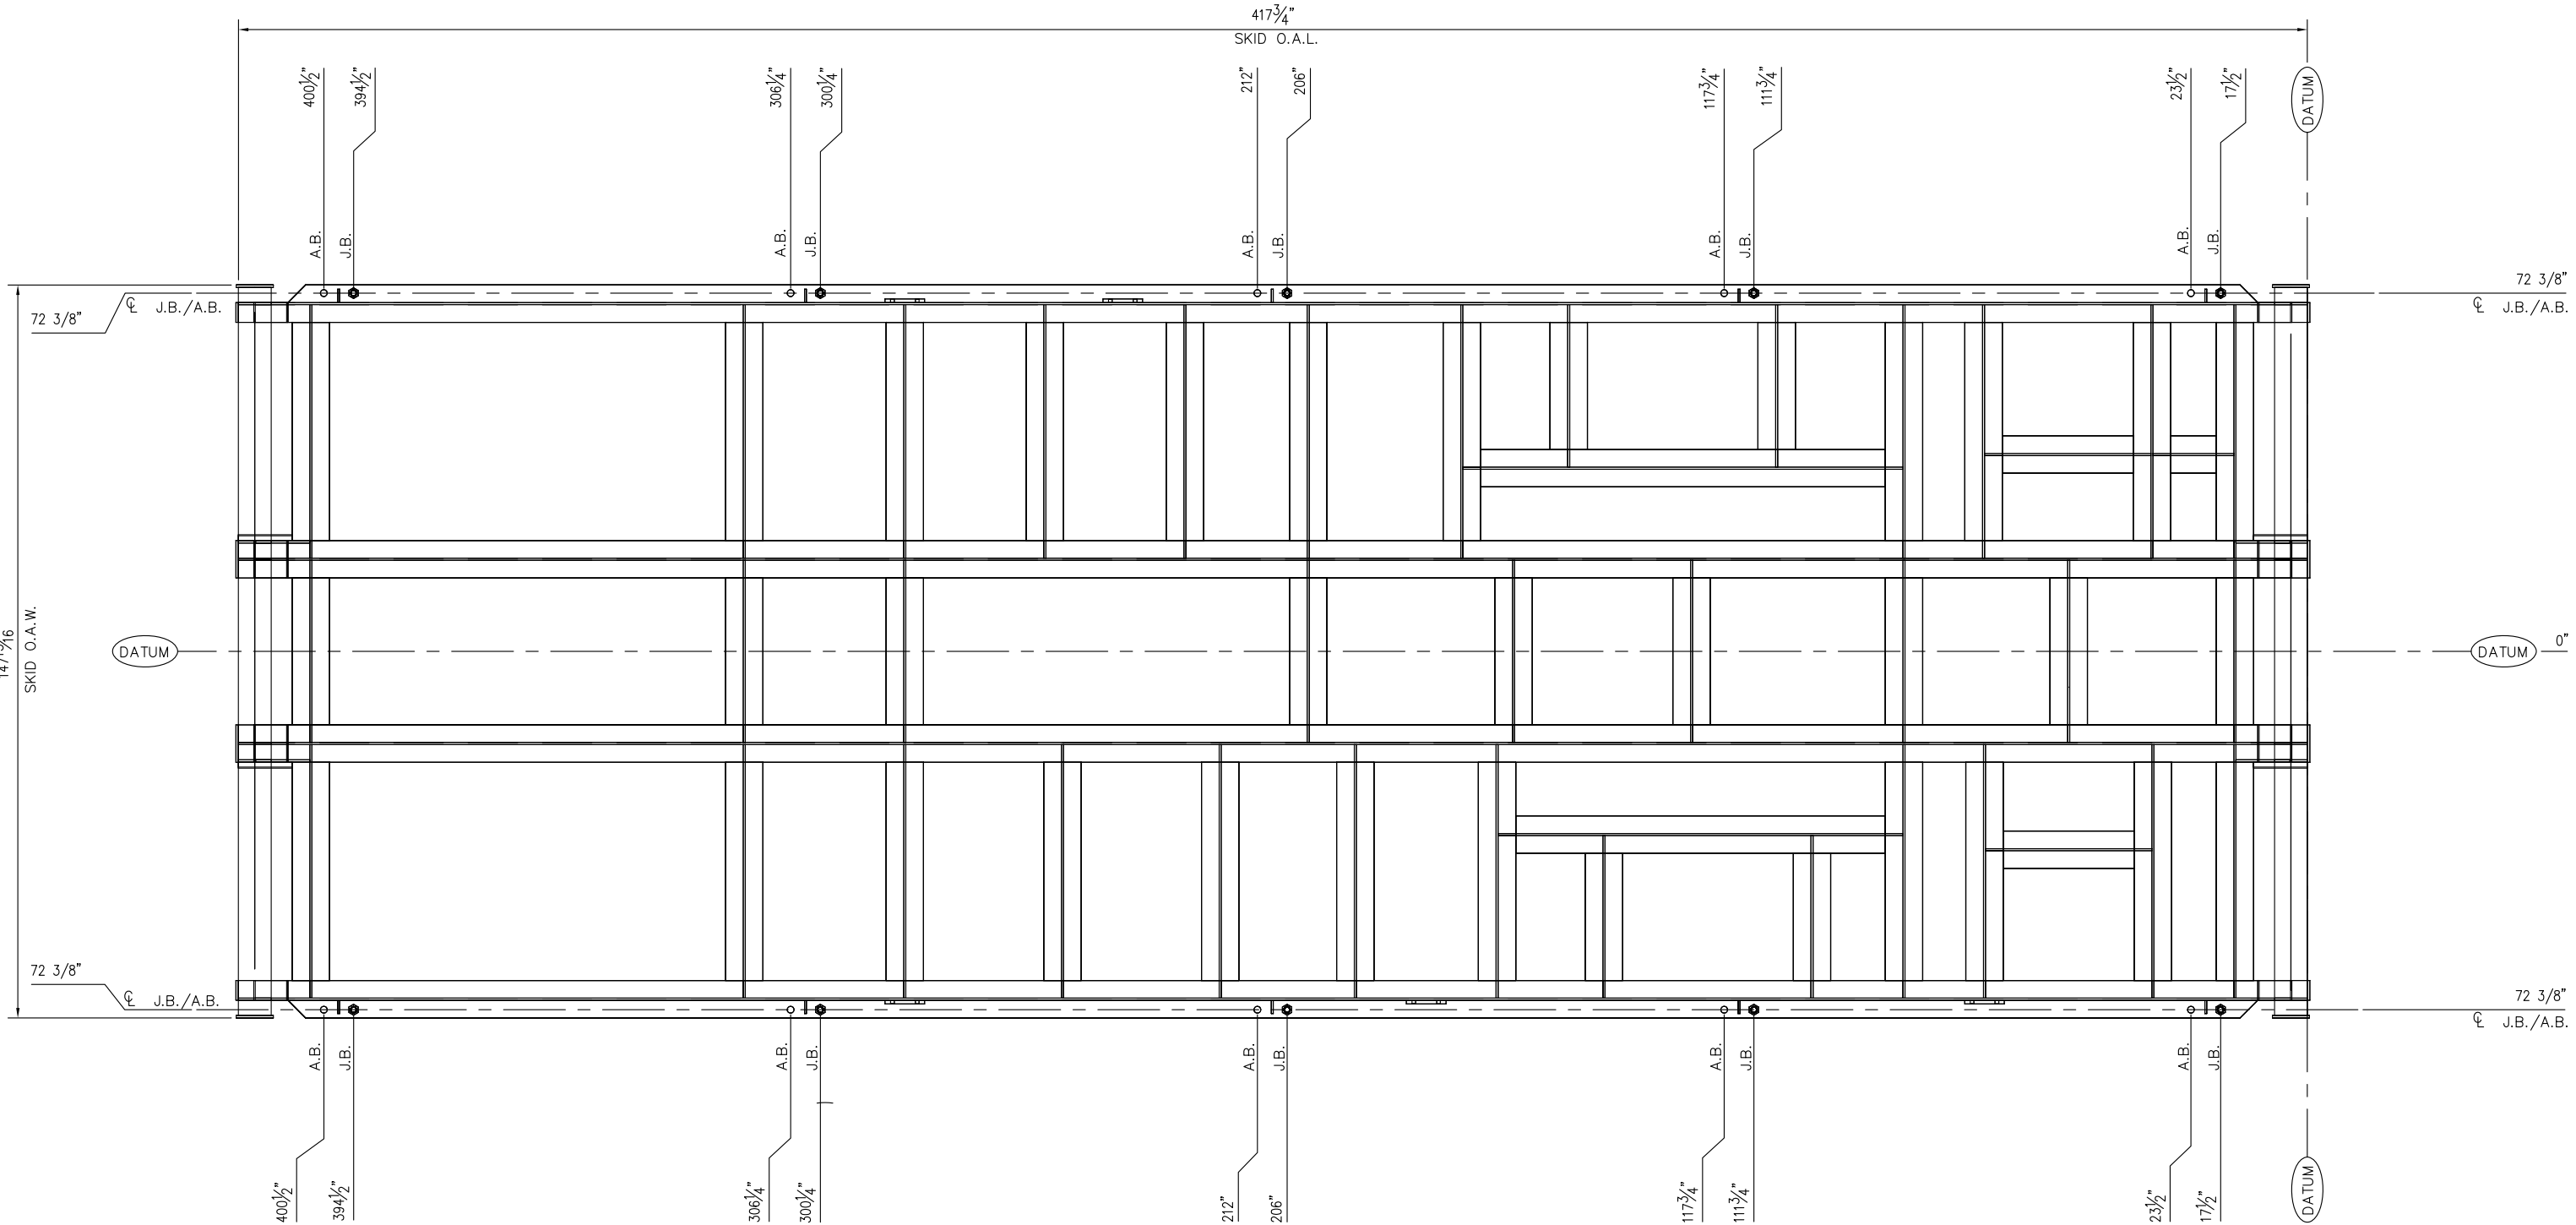

ANCHOR BOLT FOOTPRINT

AS BUILT

DATE 2/17/09



VALERUS
Compression Services, LP
919 MILAM, SUITE 1000, HOUSTON, TEXAS, 77002

2	AS BUILT-NO CHANGES THIS SHEET	2/17/09	CDN	-
1	CHANGED FRAME ASSEMBLY	1/26/09	CDN	-
0	ISSUED FOR CONSTRUCTION	1/16/09	RB	-
REV.	DESCRIPTION	DATE	BY	CK
THIS DRAWING AND ITS CONTENTS ARE THE PROPERTY OF VALERUS COMPRESSION SERVICES AND SHALL NOT BE USED, REPRODUCED OR DISCLOSED EXCEPT IN ACCORDANCE WITH ITS WRITTEN PERMISSION.				



VALERUS
Compression Services, LP
919 Milam, Ste. 1000, Houston, TX, 77002

DATE 7/7/08	DRAWN RB	CHECKED -	APPROVED -
CLIENT PEMEX (B)			
TITLE COMPRESSOR PACKAGE GENERAL ARRANGEMENT ANCHOR BOLT LAYOUT			
SCALE: 3/4"=1'-0	FG# FG501025	JOB#	
DRAWING NUMBER V35010200-06-02		SHEETS 7 OF 7	REV 2