


V-1100 GROUP SEPARATOR
SIZE: 1829mm (72")ID x 6096mm (20")S/S
MAWP: 99.30 kPag(1440 PSIG) @ 54°C(130°F)
MDMT: 99.30 kPag(1440 PSIG) @ -28°C(20°F)
C.A.: 3.2mm (1/8")
RT-1 RADIOGRAPHY, PWHT

FE-1100
MFR: CANALTA
SIZE: 10" CL600 RF S/80

V-1120 BRIDLE
SIZE: 4" CL600 RF S/160
MAWP: 99.30 kPag(1440 PSIG) @ 54°C(130°F)
MDMT: 99.30 kPag(1440 PSIG) @ -28°C(20°F)
C.A.: 3.2mm (1/8")
10% RADIOGRAPHY

FC-1101 & FC-1102
Murphy Float Chamber
Series100
1"x1/2" FNPT
2000# WCB Body
CRN: DFO8387.2

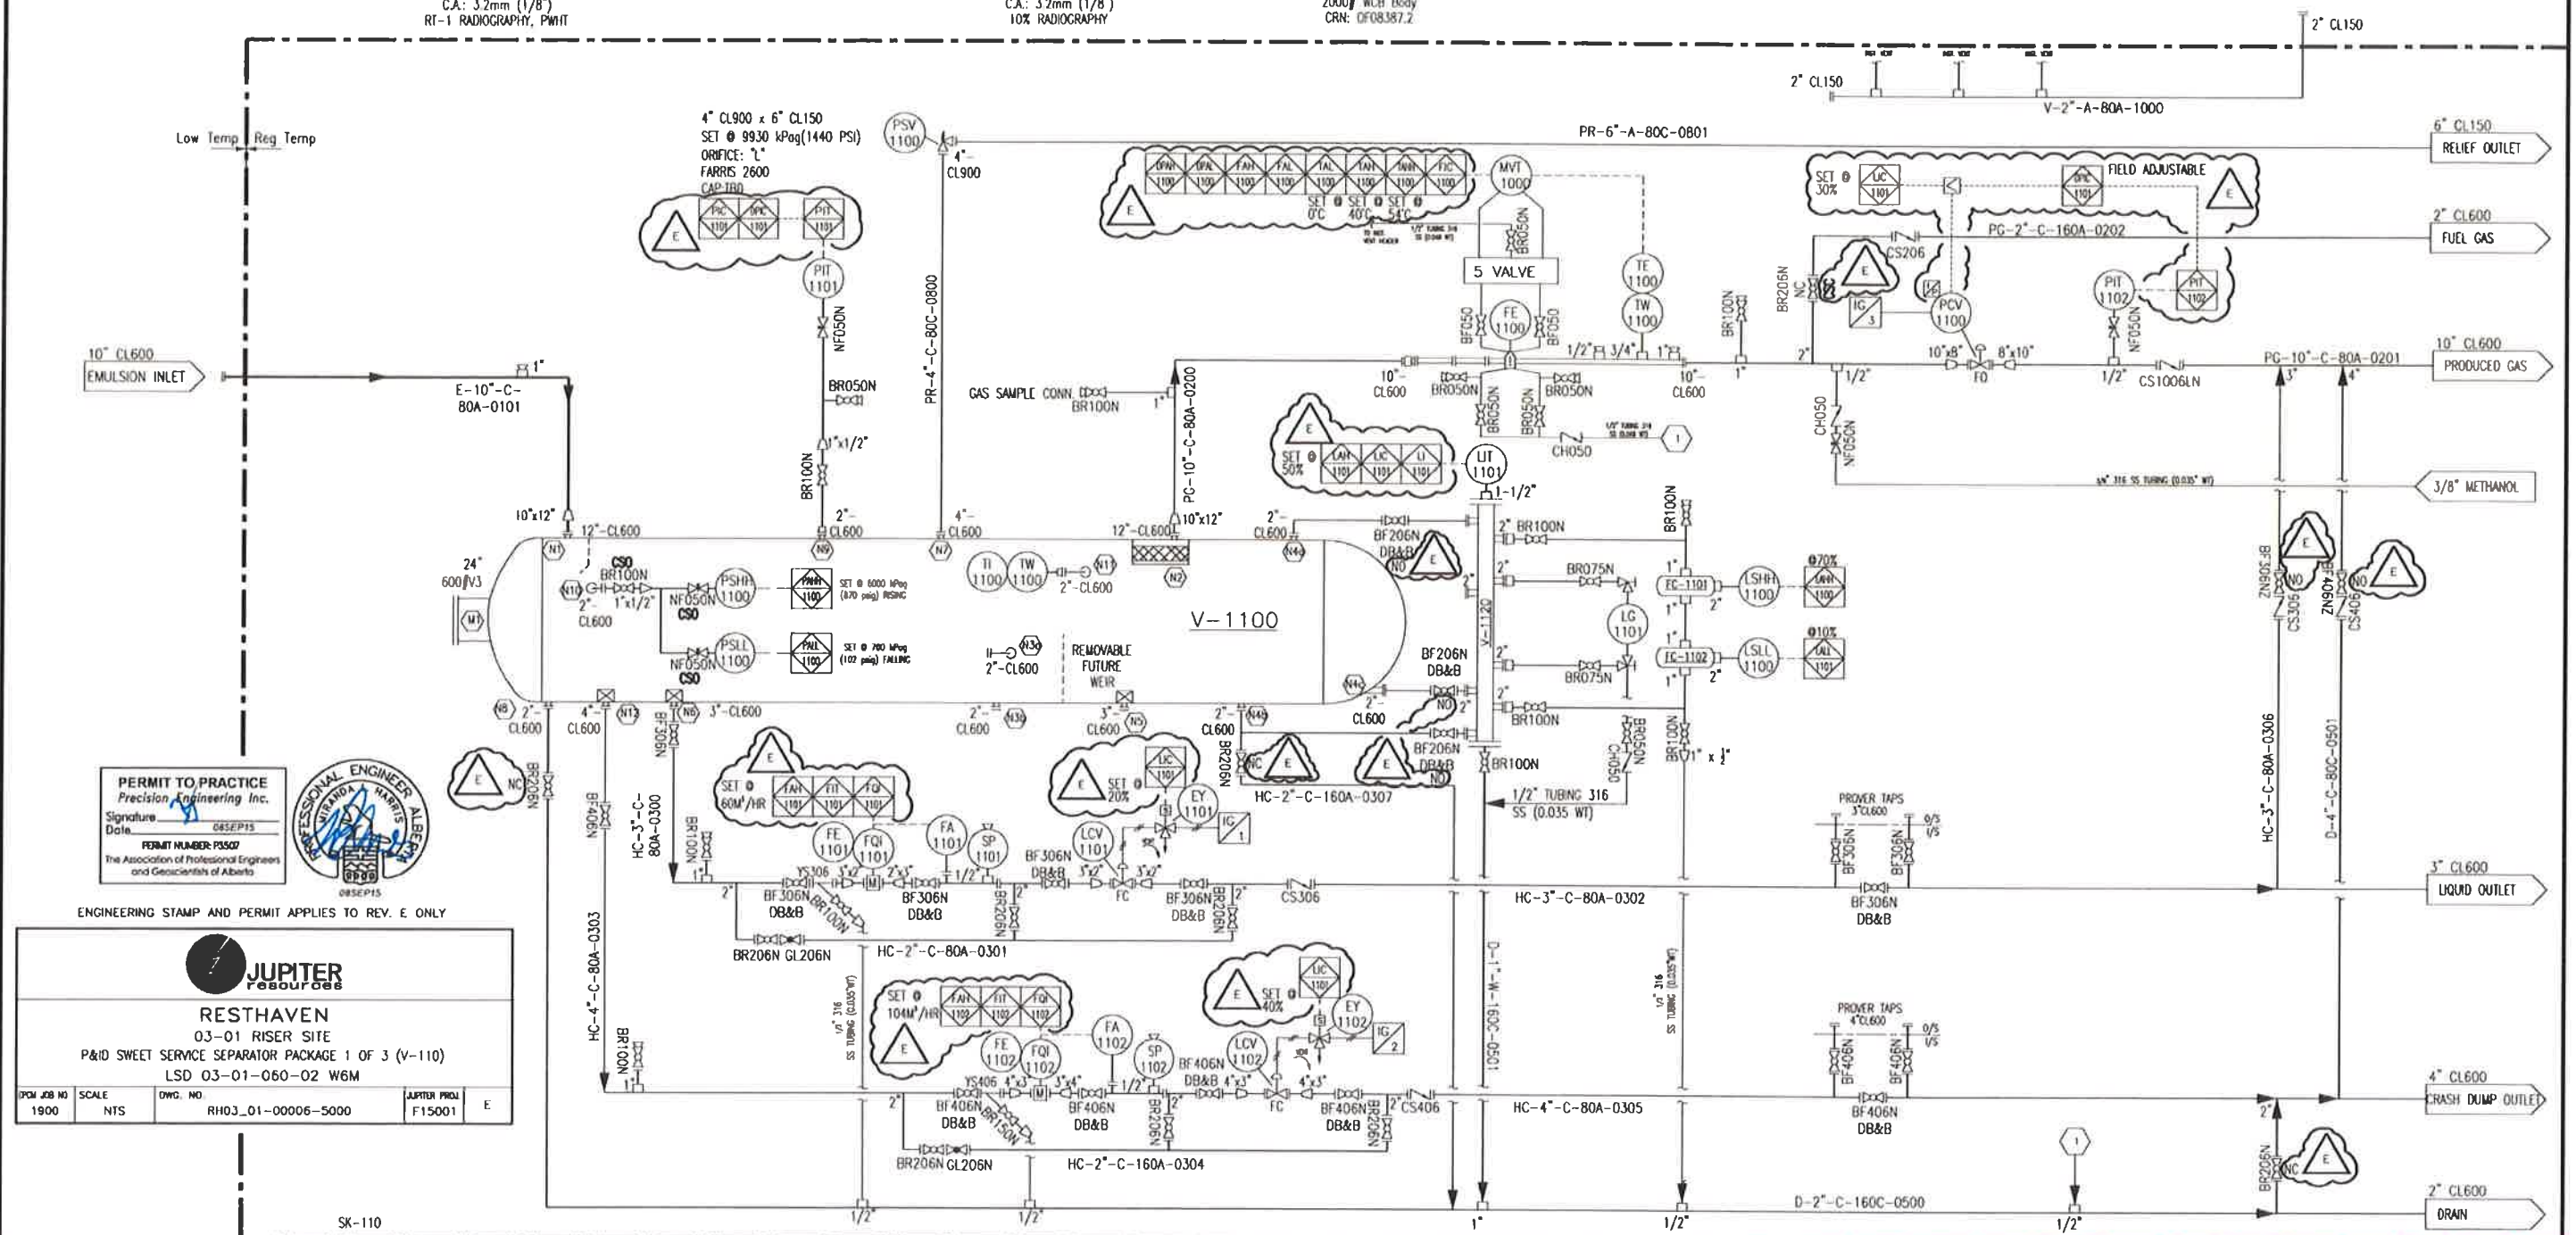

PERMIT TO PRACTICE
Precision Engineering Inc.
Signature: [Signature]
Date: 08SEP15
PERMIT NUMBER: P5007
The Association of Professional Engineers
and Geoscientists of Alberta



ENGINEERING STAMP AND PERMIT APPLIES TO REV. E ONLY



RESTHAVEN

03-01 RISER SITE
P&ID SWEET SERVICE SEPARATOR PACKAGE 1 OF 3 (V-110)
LSD 03-01-060-02 W6M

POW JOB NO	SCALE	DWG. NO.	JUPITER PROJ.	E
1900	NTS	RH03_01-00006-5000	F15001	

JUPITER RESOURCES PO#-

NWP JOB#	LSD
09418-001	03-01-060-02 W6M

REV	DATE	BY	CHK	APP	DESCRIPTION
E	AUG 28/15	JHL			03-01 EXPANSION V-110 & H-110 INSTALL (PEI)
D	JUL 30/15	SF			RELEASED FOR PRODUCTION
C	JUL 10/15	SF			RELEASED FOR PRODUCTION
B	JUN 26/15	SF			ISSUED FOR APPROVAL
A	MAY 06/15	EB			ISSUED FOR APPROVAL

DRAWING REVISIONS

RELEASED FOR
PRODUCTION

SUBSEQUENT CHANGES/
REQUESTS MAY AFFECT
PRICE AND DELIVERY

ALL DIMENSIONS IN INCHES



P.O. BOX 6280, INNISFAIR, AB T4G 1S9
PH: (403) 227-4100 FAX: (403) 227-4102

JUPITER RESOURCES
c/o PRECISION ENGINEERING INC.
SWEET SERVICE, SEPARATOR PKG.

PIPING AND INSTRUMENTATION DIAGRAM

EB
JUL 30/15

1 OF 3


09418-001-P-001

E

P-1170
METHANOL PUMP
MAKE: BROWN
MODEL: BR5103-LP-1511
3/8" PLUNGER, 3000psi MAX DISCHARGE PRESSURE
c/w FORMED DRIP TRAY

BH-1140/50/60/70 BUILDING HEATER
MAKE: CATADYNE
MODEL: CCI THERMAL TECHNOLOGIES
120 VOLT AC START, PROPANE FUEL SUPPLY
c/w SAFETY SHUT OFF, 912 REG. GRILL GUARD.
GAS PERMIT pulled per B149

V-1110
FUEL GAS SCRUBBER
SIZE: 12" OD x 36" S/S
MAWP: 1965kpa (285 psig) @ 38°C (100°F)
MDMT: -29°C (-20°F) @ 1965kpa (285 psig)
CA: 3.2mm (1/8"), CRN: "

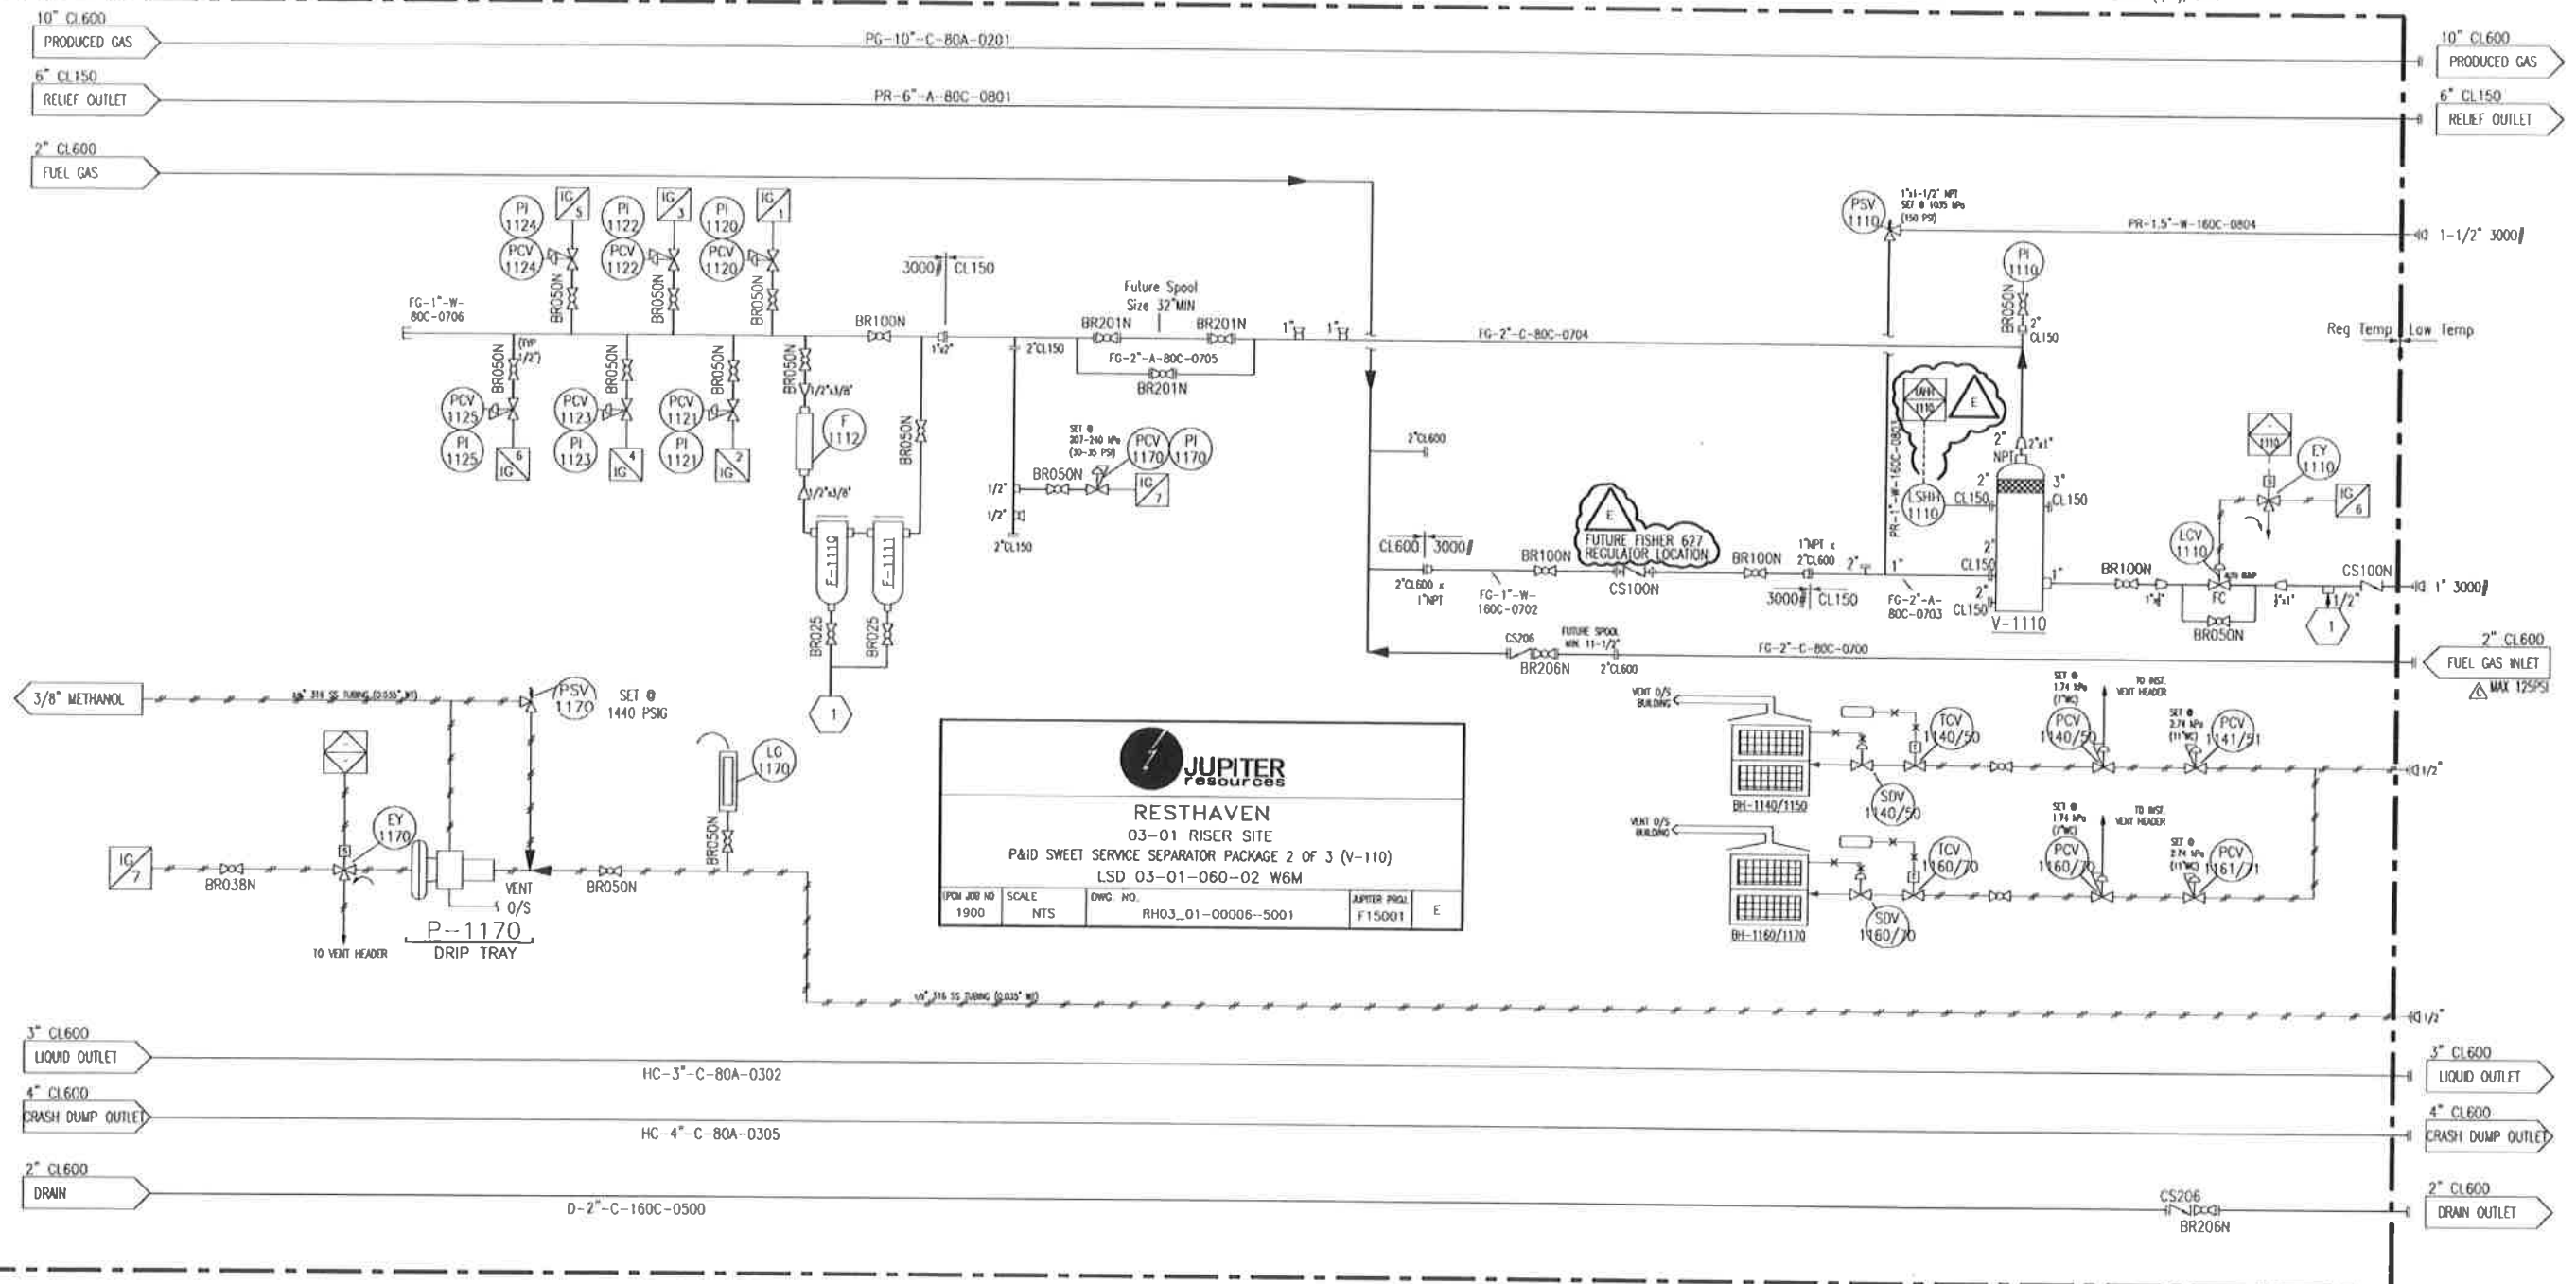

JUPITER
resources

RESTHAVEN
03-01 RISER SITE
P&ID SWEET SERVICE SEPARATOR PACKAGE 2 OF 3 (V-110)
LSD 03-01-060-02 W6M

IPM JOB NO	SCALE	NTS	DWG. NO.	RH03_01-00006-5001	APIER PROJ.	F15001	E
------------	-------	-----	----------	--------------------	-------------	--------	---

JUPITER RESOURCES PO#--	
NWP JOB#	LSD
09418-001	03-01-060-02 W6M

E	AUG 28/15	JHL			03-01 EXPANSION V-110 & H-110 INSTALL (PEI)
D	JUL 30/15	SF			RELEASED FOR PRODUCTION
C	JUL 10/15	SF			RELEASED FOR PRODUCTION
B	JUN 26/15	SF			ISSUED FOR APPROVAL
A	MAY 06/15	EB			ISSUED FOR APPROVAL
REV	DATE	BY	CHK	APP	DESCRIPTION

DRAWING REVISIONS

RELEASED FOR
PRODUCTION

SUBSEQUENT CHANGES /
REQUESTS MAY AFFECT
PRICE AND DELIVERY

ALL DIMENSIONS IN INCHES



P.O. BOX 6280, INNISFAIR, AB T4G 1S9
PH: (403) 227-4100 FAX: (403) 227-4102

JUPITER RESOURCES
c/o PRECISION ENGINEERING INC.
SWEET SERVICE, SEPARATOR PKG.

PIPING AND INSTRUMENTATION DIAGRAM

EB
JUL 30/15

2 OF 3

09418-001-P-001

E