
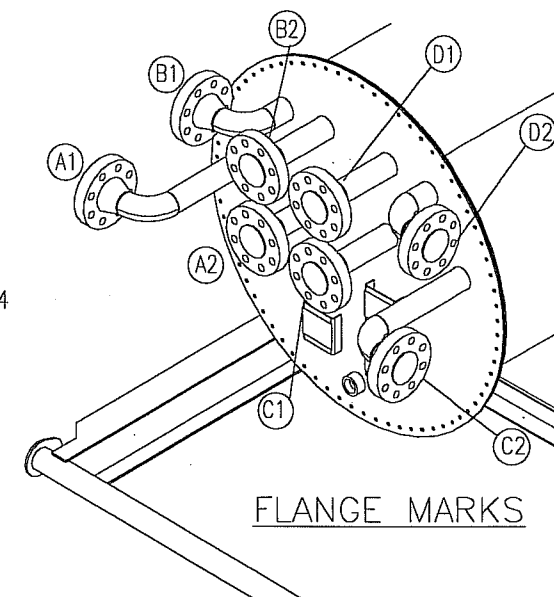


GENERAL NOTES:

1. ALL DIMENSIONS ARE IN INCHES UNLESS OTHERWISE SPECIFIED
2. ALL DIMENSIONS TO HAVE A TOLERANCE OF $\pm \frac{1}{8}$ " UNLESS OTHERWISE SPECIFIED
3. FLANGE BOLT HOLES TO STRADDLE CENTER LINES
4. COIL END PEDESTAL WELDED TO SKID AND OTHER IS BOLTED.
5. APPROXIMATE WEIGHT:
 - COIL: 4383 lb
 - SKID: 1156 lb
 - SCRUBBER: 120 lb
 - LINEHEATER: 5427

TOTAL DRY WEIGHT (APROX.): 11885 lb

6. APPROXIMATE SHIPPING DIMENSIONS: 21'L X 9'W X 10'H

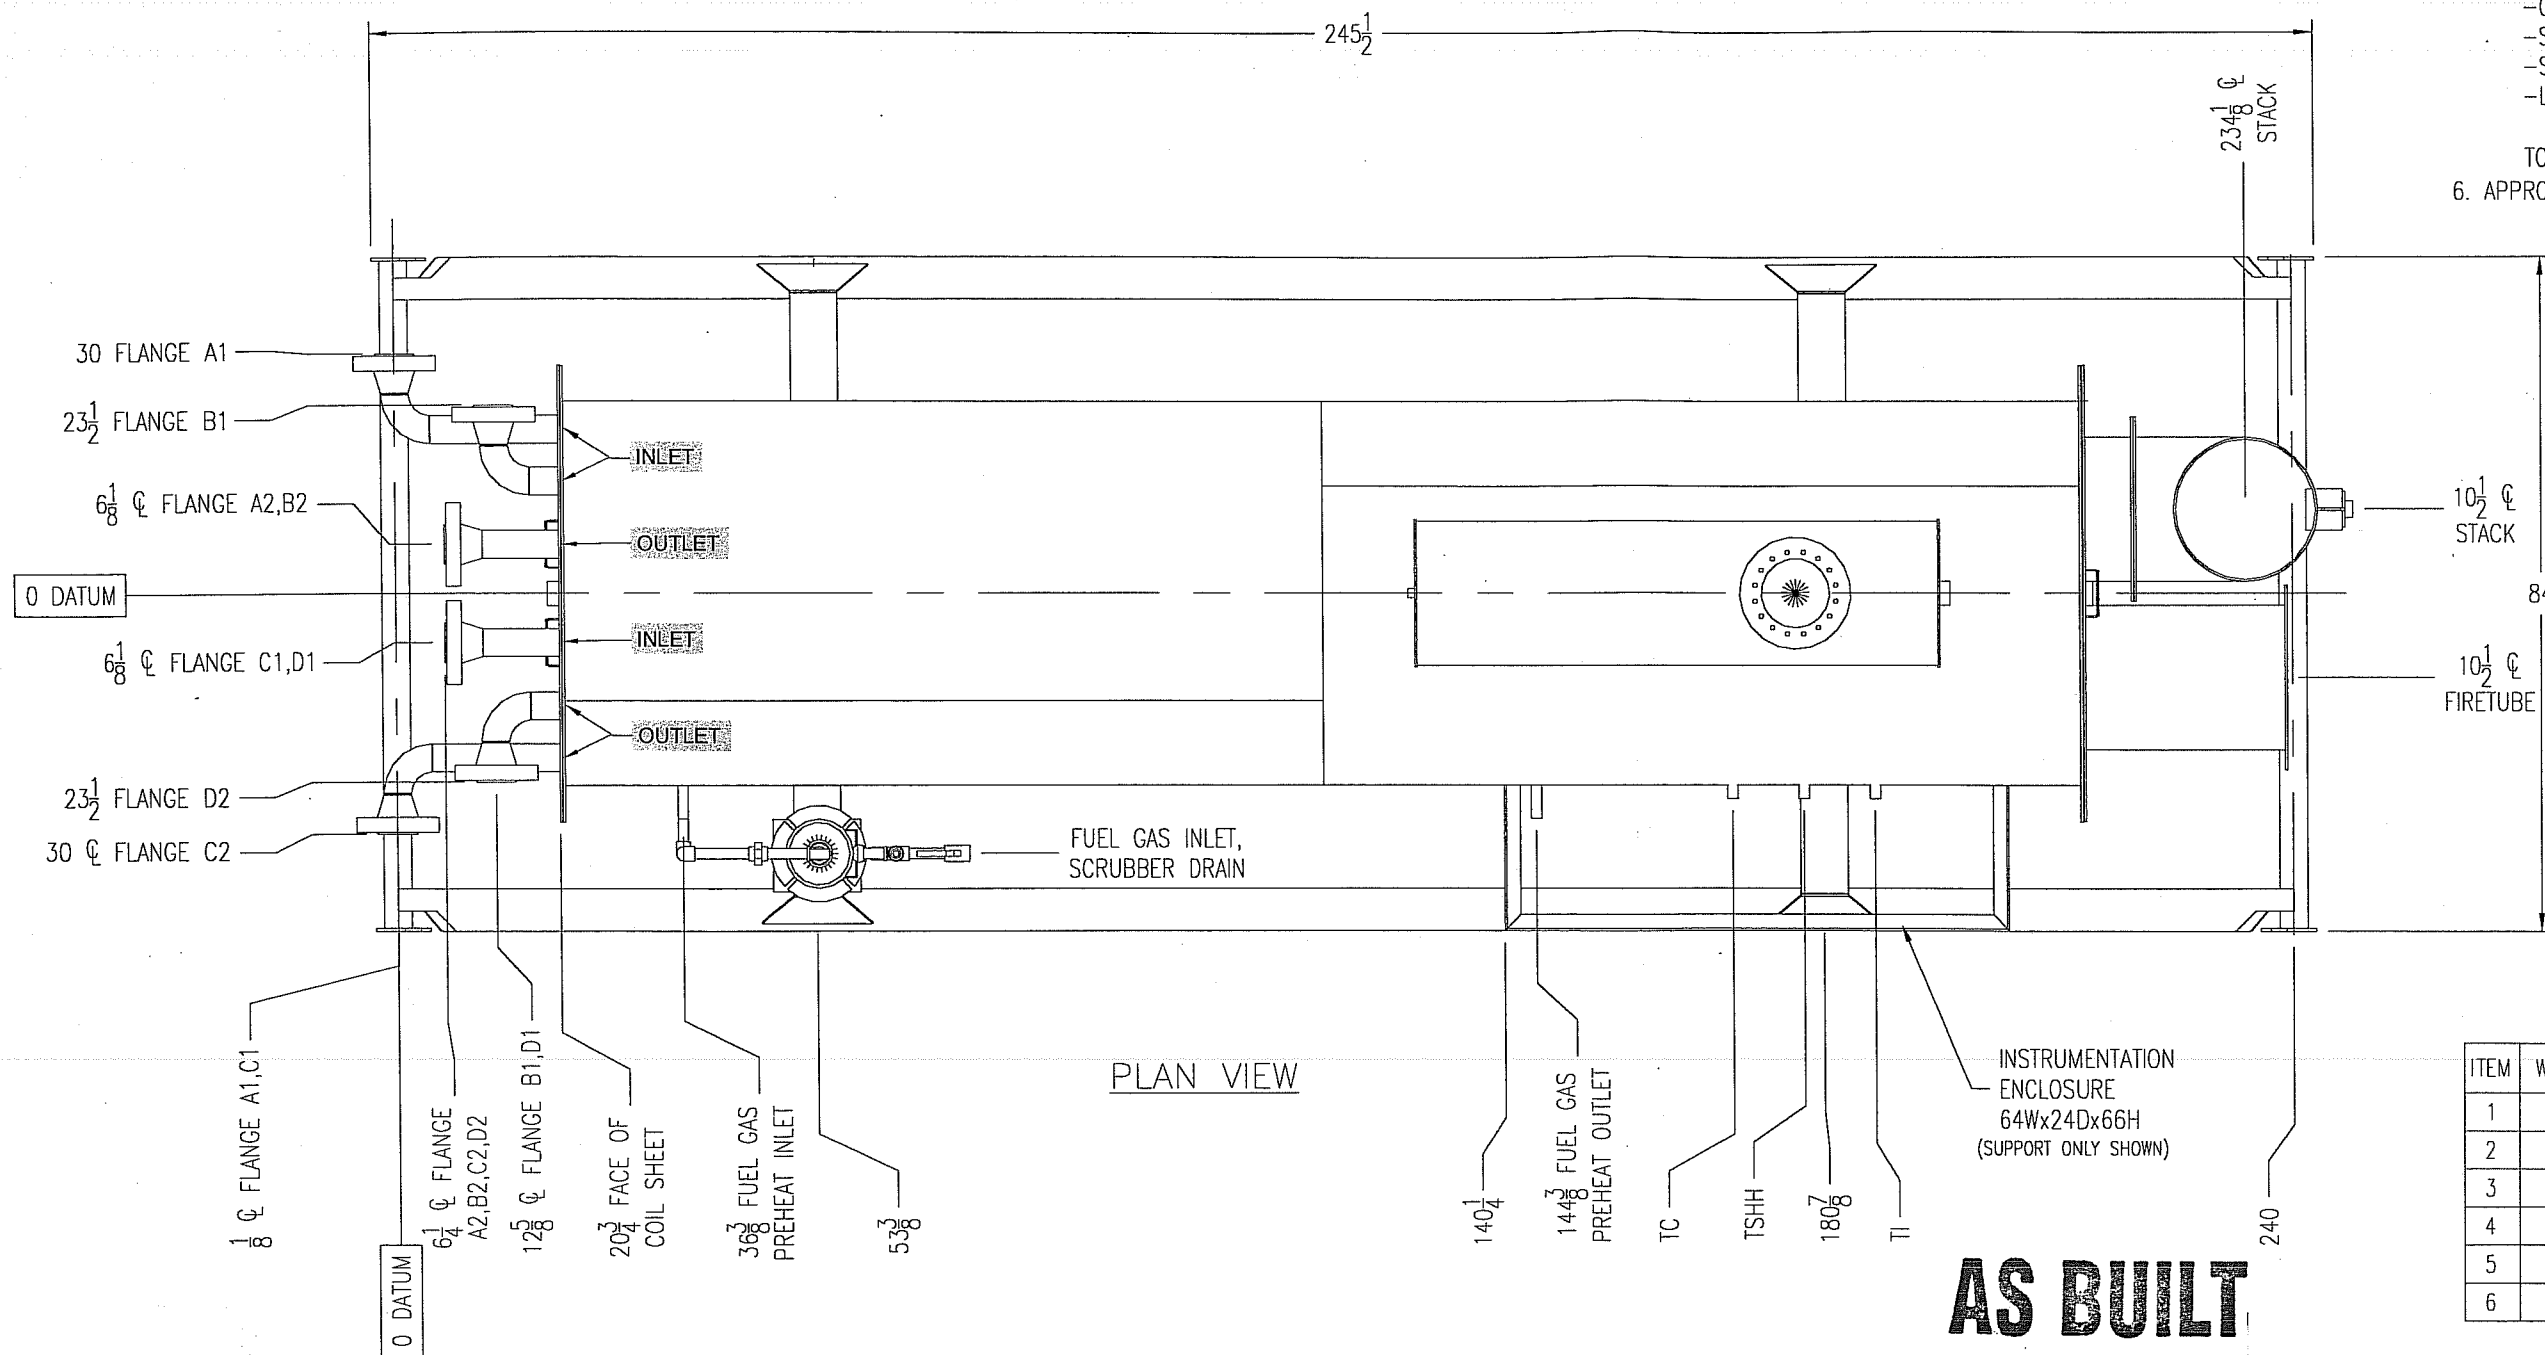

TAGGING DETAILS

ITEM	WO NUMBER	SERIAL NUMBER	WELL SITE LSD
1	06276	NWP-1559	b-43-B/93-P-9
2	06277	NWP-1560	a-3-A/93-P-9
3	06278	NWP-1561	c-3-H/93-P-9
4	06279	NWP-1562	d-40-A/93-P-9
5	06280	NWP-1563	d-11-B/93-P-9
6	06281	NWP-1564	b-93-A/93-P-9

AS BUILT

JWP-1559-41	PREHEAT LINE						
VWP-1559-4	LINE HEATER						
VWP-1559-3	SKID						
VWP-1559-2	COIL						
3NWP-1559-1	BILL OF MATERIALS	1	2008.11.14.	KD	ETB	GH	ISSUED FOR CONSTRUCTION (ADDED TAGGING DETAILS)
NWP-1559-1	P&ID	0	2008.10.21.	KD	ETB	GH	ISSUED FOR CONSTRUCTION
DOCUMENT NO.	DESCRIPTION	REV	DATE	BY	CHK	APP	



P.O. BOX 6280, INNISFAIL, AB T4G 1S9
 PH (403) 227-4100 FAX (403) 227-4102
 www.nwp.ca


THIS DRAWING IS PROPERTY OF NWP INDUSTRIES INC. AND MAY NOT BE REPRODUCED
 WITHOUT PERMISSION. THIS DRAWING MUST BE RETURNED UPON REQUEST.

GENERAL ARRANGEMENT
 Ø48" x 16' LINE HEATER
 1,500,000 BTU/HR ; W/18" FIRETUBE
 Tupper Field Gathering System

SCALE 1/2" = 1'

DWG NWP-1559

REV 1

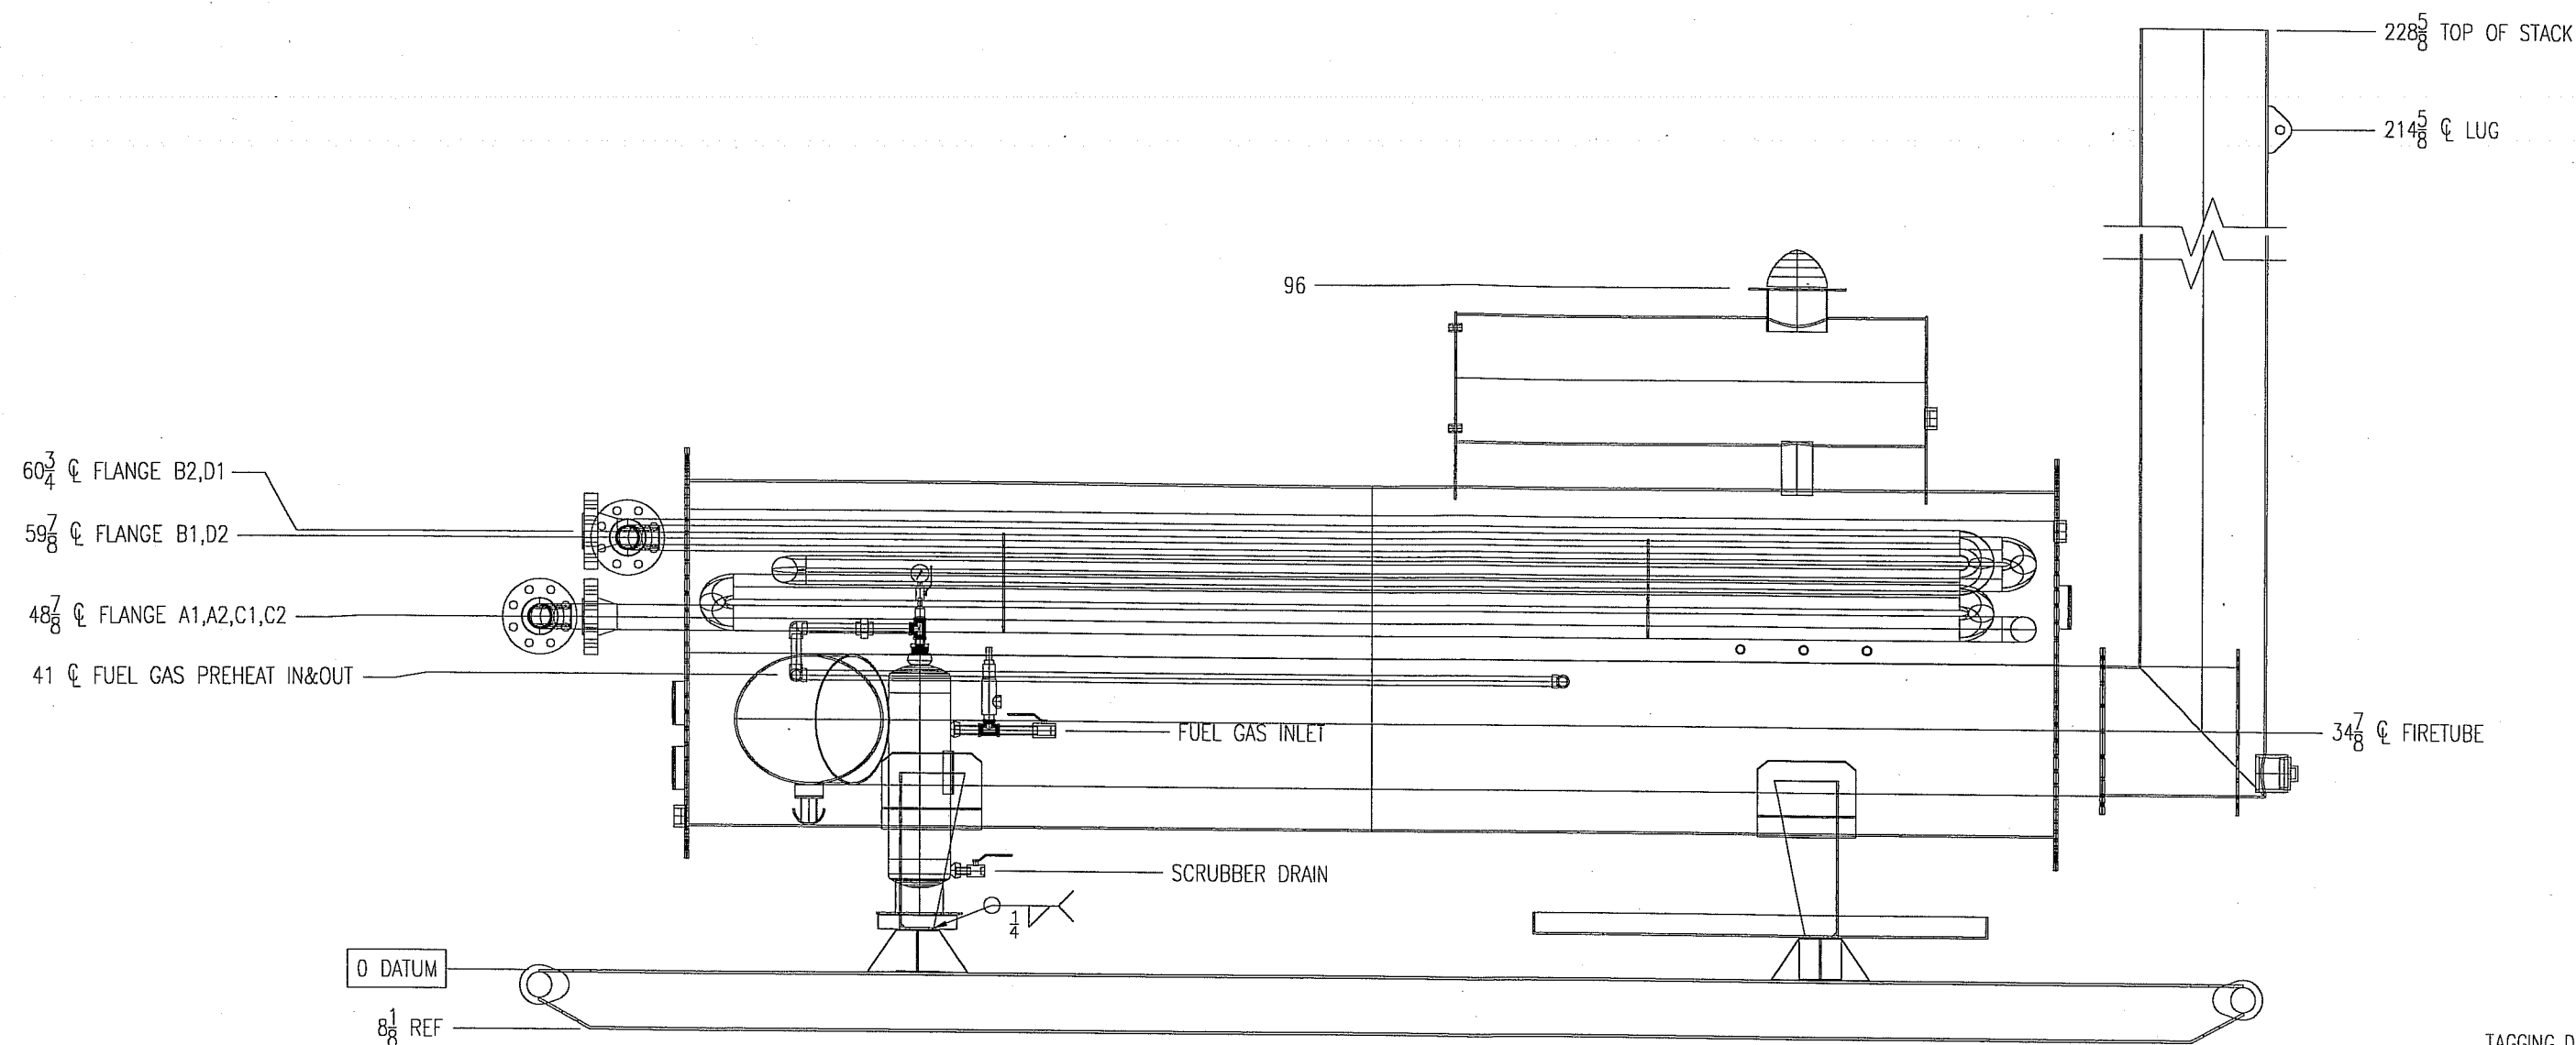

ELEVATION VIEW

AS BUILT

TAGGING DETAILS

ITEM	WO NUMBER	SERIAL NUMBER	WELL SITE LSD
1	06276	NWP-1559	b-43-B/93-P-9
2	06277	NWP-1560	a-3-A/93-P-9
3	06278	NWP-1561	c-3-H/93-P-9
4	06279	NWP-1562	d-40-A/93-P-9
5	06280	NWP-1563	d-11-B/93-P-9
6	06281	NWP-1564	b-93-A/93-P-9


NWP-1559-41	PREHEAT LINE						
NWP-1559-4	LINE HEATER						
NWP-1559-3	SKID						
NWP-1559-2	COIL						
BNWP-1559-1	BILL OF MATERIALS	1	2008.11.14.	KD	EB	SA	ISSUED FOR CONSTRUCTION (ADDED TAGGING DETAILS)
NWP-1559-1	P&ID	0	2008.10.21.	KD	ETB	GH	ISSUED FOR CONSTRUCTION
DOCUMENT NO.	DESCRIPTION	REV	DATE	BY	CHK	APP	
REFERENCE DRAWINGS		DRAWING REVISIONS					


NWP
 INDUSTRIES INC.
 Total outfield supply
 P.O. BOX 6280, INNISFAIR, AB T4G 1S9
 PH (403) 227-4100 FAX (403) 227-4102
 www.nwp.ca

THIS DRAWING IS PROPERTY OF NWP INDUSTRIES INC. AND MAY NOT BE REPRODUCED WITHOUT PERMISSION. THIS DRAWING MUST BE RETURNED UPON REQUEST.

GENERAL ARRANGEMENT
 Ø48" x 16' LINE HEATER
 1,500,000 BTU/HR ; W/18" FIRETUBE
 Tupper Field Gathering System

SCALE 1/2" = 1'	DWG NWP-1559	REV 1
SHEET 2/4		

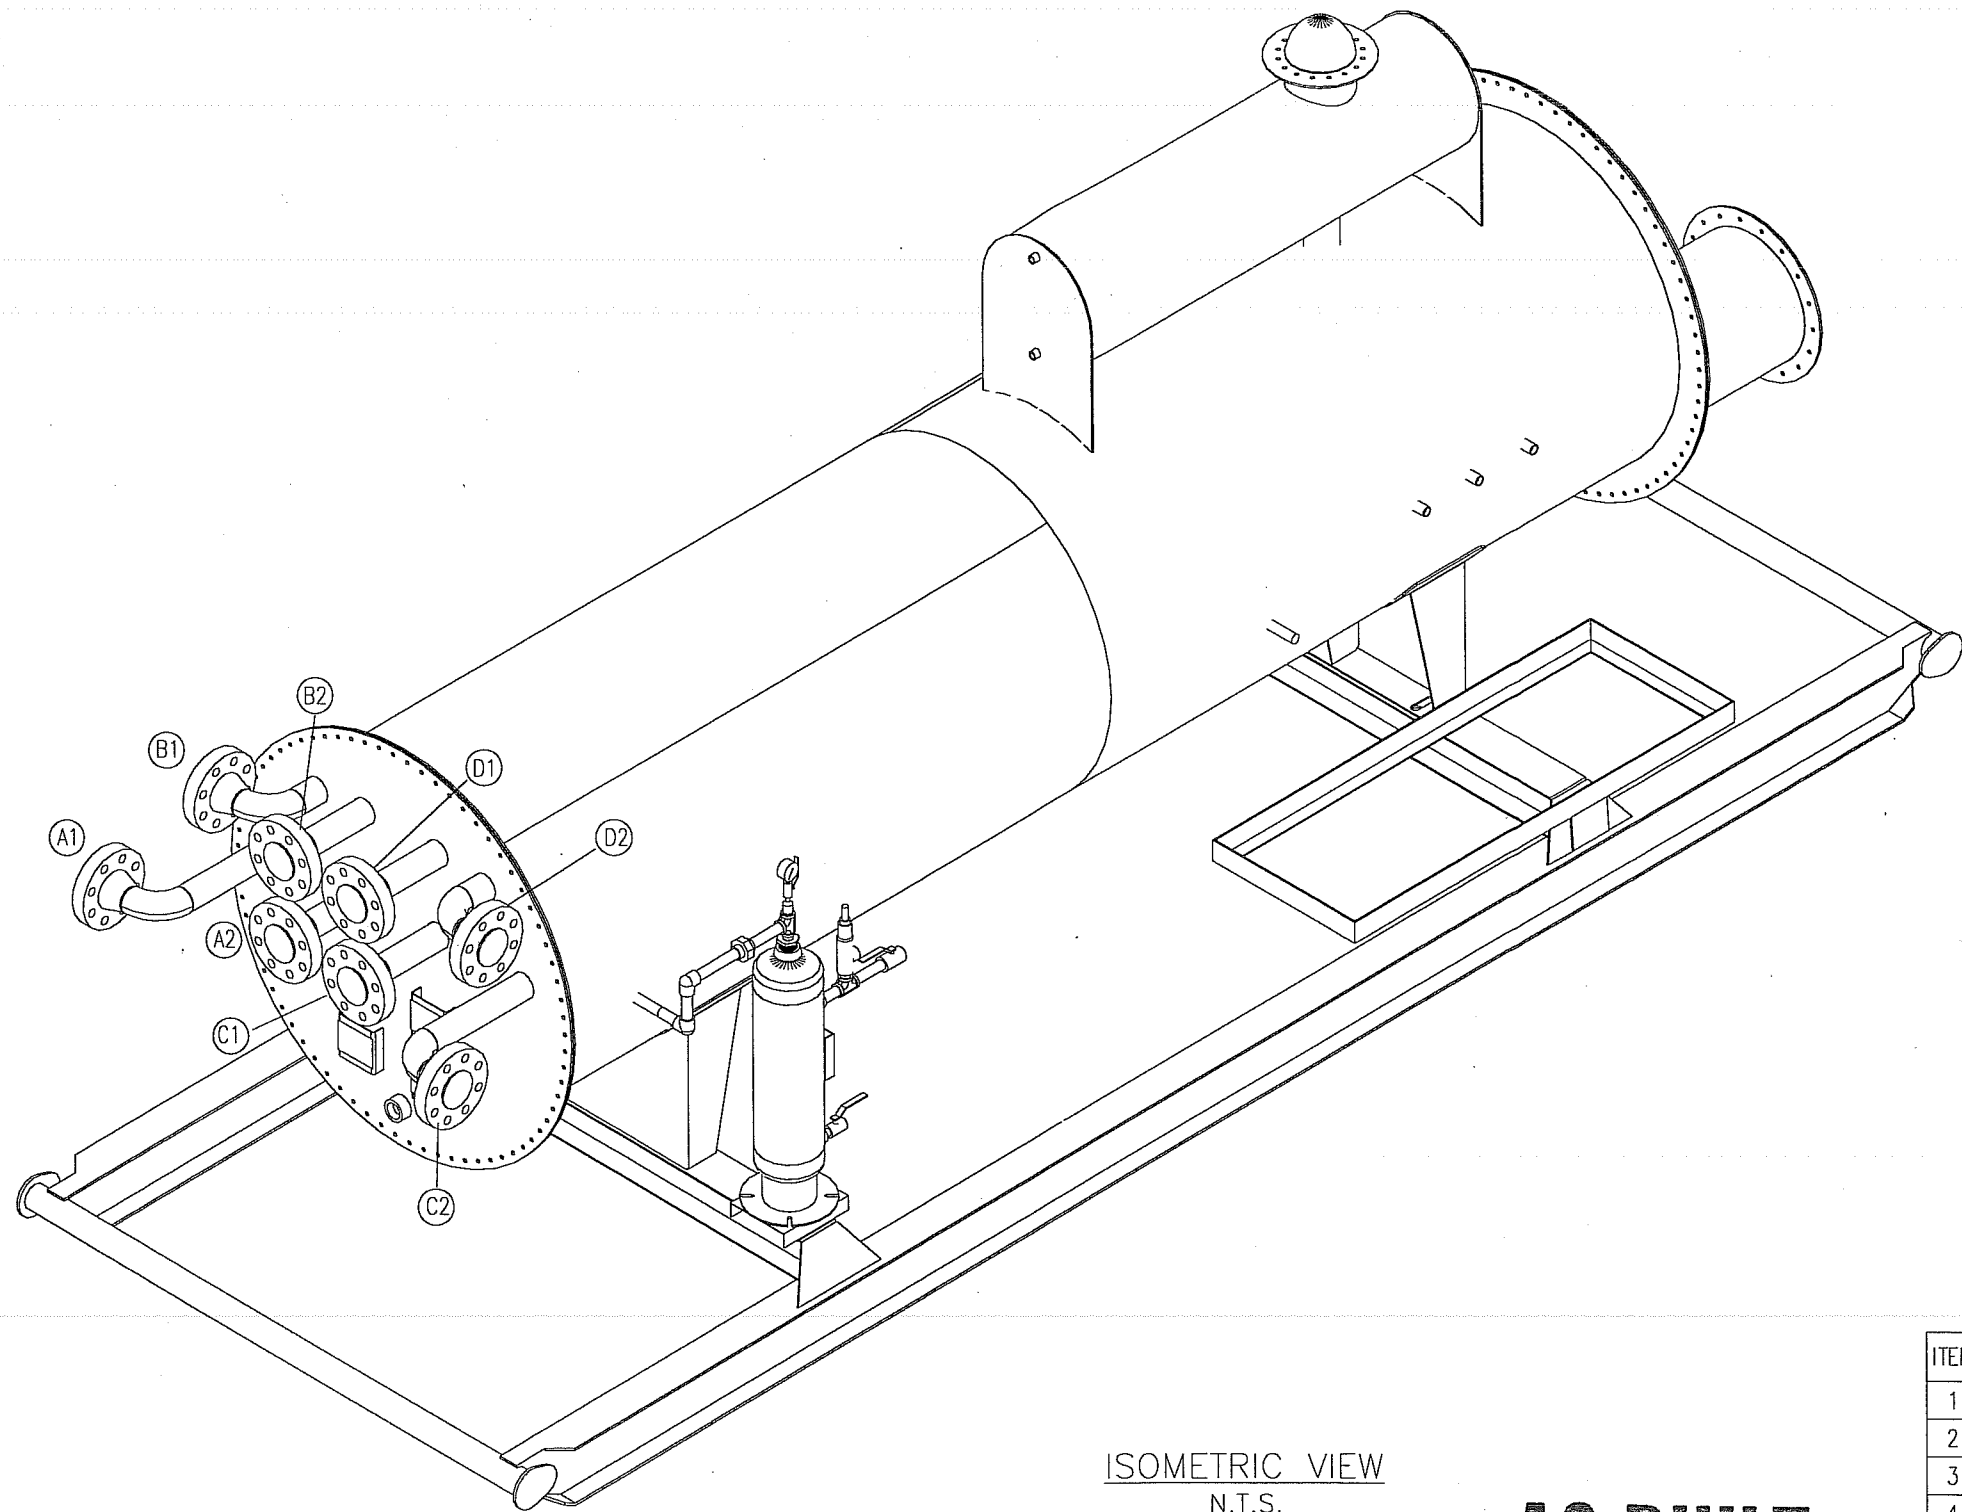

ISOMETRIC VIEW
N.T.S.
STACK REMOVED FOR CLARITY

AS BUILT

TAGGING DETAILS


ITEM	WO NUMBER	SERIAL NUMBER	WELL SITE LSD
1	06276	NWP-1559	b-43-B/93-P-9
2	06277	NWP-1560	a-3-A/93-P-9
3	06278	NWP-1561	c-3-H/93-P-9
4	06279	NWP-1562	d-40-A/93-P-9
5	06280	NWP-1563	d-11-B/93-P-9
6	06281	NWP-1564	b-93-A/93-P-9

NWP-1559-41	PREHEAT LINE						
NWP-1559-4	LINE HEATER						
NWP-1559-3	SKID						
NWP-1559-2	COIL						
BNWP-1559-1	BILL OF MATERIALS	1	2008.11.14.	KD	EB	GH	ISSUED FOR CONSTRUCTION (ADDED TAGGING DETAILS)
NWP-1559-1	P&ID	0	2008.10.21.	KD	ETB	GH	ISSUED FOR CONSTRUCTION
DOCUMENT NO.	DESCRIPTION	REV	DATE	BY	CHK	APP	
REFERENCE DRAWINGS		DRAWING REVISIONS					


NWP
 INDUSTRIES INC.
 Total oilfield supply.
 P.O. BOX 6280, INNISFAIL, AB T4G 1S9
 PH (403) 227-4100 FAX (403) 227-4102
 www.nwp.ca

THIS DRAWING IS PROPERTY OF NWP INDUSTRIES INC. AND MAY NOT BE REPRODUCED WITHOUT PERMISSION. THIS DRAWING MUST BE RETURNED UPON REQUEST.

GENERAL ARRANGEMENT Ø48" x 16' LINE HEATER 1,500,000 BTU/HR ; W/18" FIRETUBE Tupper Field Gathering System	
SCALE NTS SHEET 3/4	DWG NWP-1559 REV 1

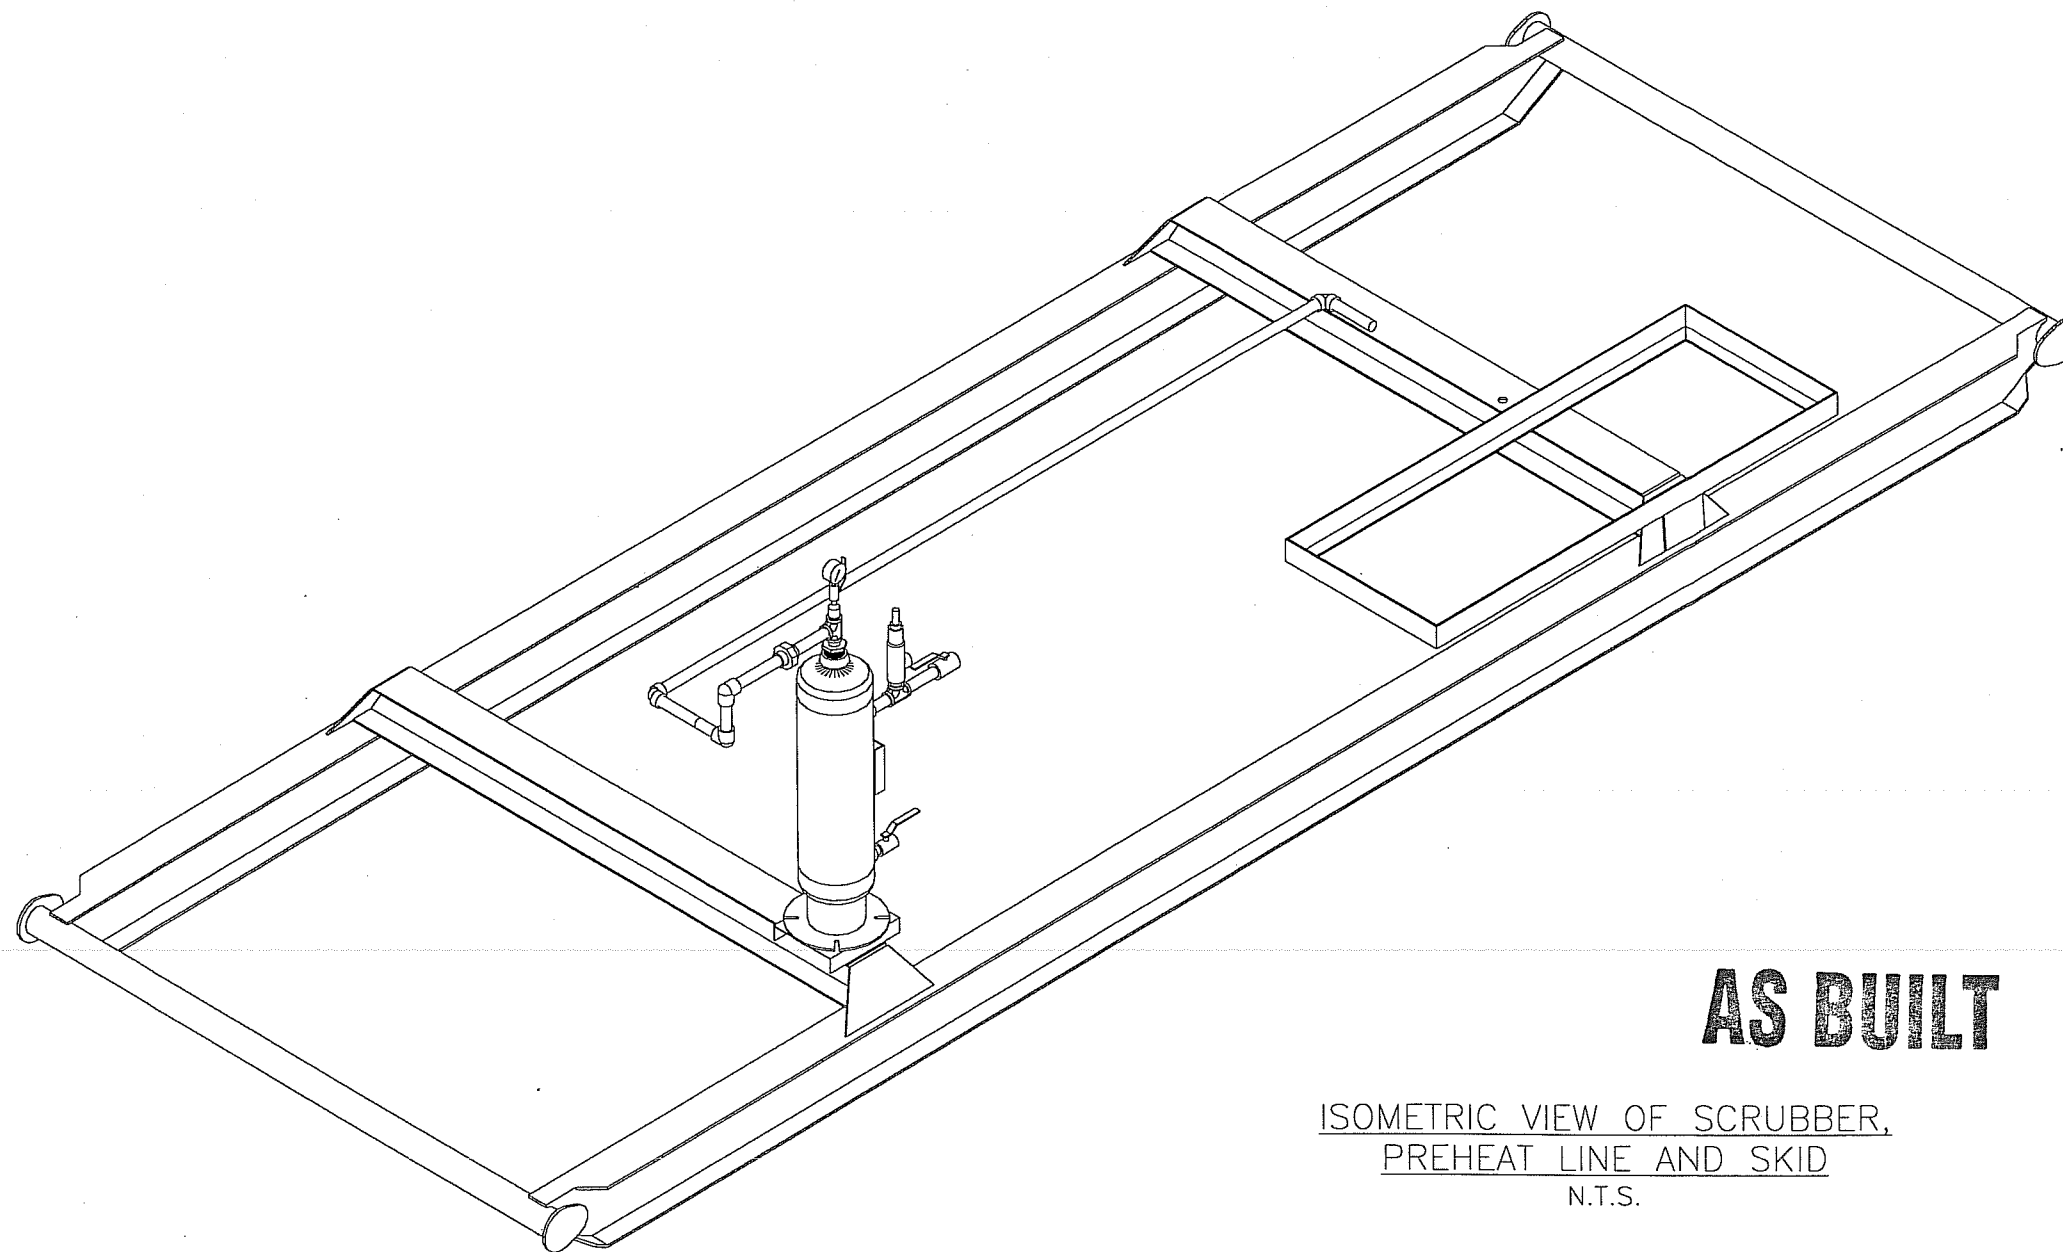


AS BUILT

ISOMETRIC VIEW OF SCRUBBER,
PREHEAT LINE AND SKID
N.T.S.

TAGGING DETAILS

ITEM	WO NUMBER	SERIAL NUMBER	WELL SITE LSD
1	06276	NWP-1559	b-43-B/93-P-9
2	06277	NWP-1560	a-3-A/93-P-9
3	06278	NWP-1561	c-3-H/93-P-9
4	06279	NWP-1562	d-40-A/93-P-9
5	06280	NWP-1563	d-11-B/93-P-9
6	06281	NWP-1564	b-93-A/93-P-9

VWP-1559-41	PREHEAT LINE						
NWP-1559-4	LINE HEATER						
NWP-1559-3	SKID						
NWP-1559-2	COIL						
BNWP-1559-1	BILL OF MATERIALS	1	2008.11.14.	KD	ETB	GH	ISSUED FOR CONSTRUCTION (ADDED TAGGING DETAILS)
NWP-1559-1	P&ID	0	2008.10.21.	KD	ETB	GH	ISSUED FOR CONSTRUCTION
DOCUMENT NO.	DESCRIPTION	REV	DATE	BY	CHK	APP	

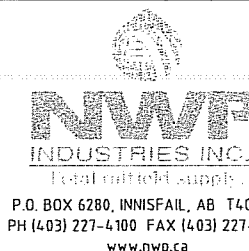

GENERAL ARRANGEMENT
Ø48" x 16' LINE HEATER
1,500,000 BTU/HR ; W/18" FIRETUBE
Tupper Field Gathering System

THIS DRAWING IS PROPERTY OF NWP INDUSTRIES INC. AND MAY NOT BE REPRODUCED
WITHOUT PERMISSION. THIS DRAWING MUST BE RETURNED UPON REQUEST.

SCALE NTS
SHEET 4 / 4

DWG NWP-1559 REV 1