


13'w 19'L 13'3" HT

SKID LIMITS

1- Enviro save

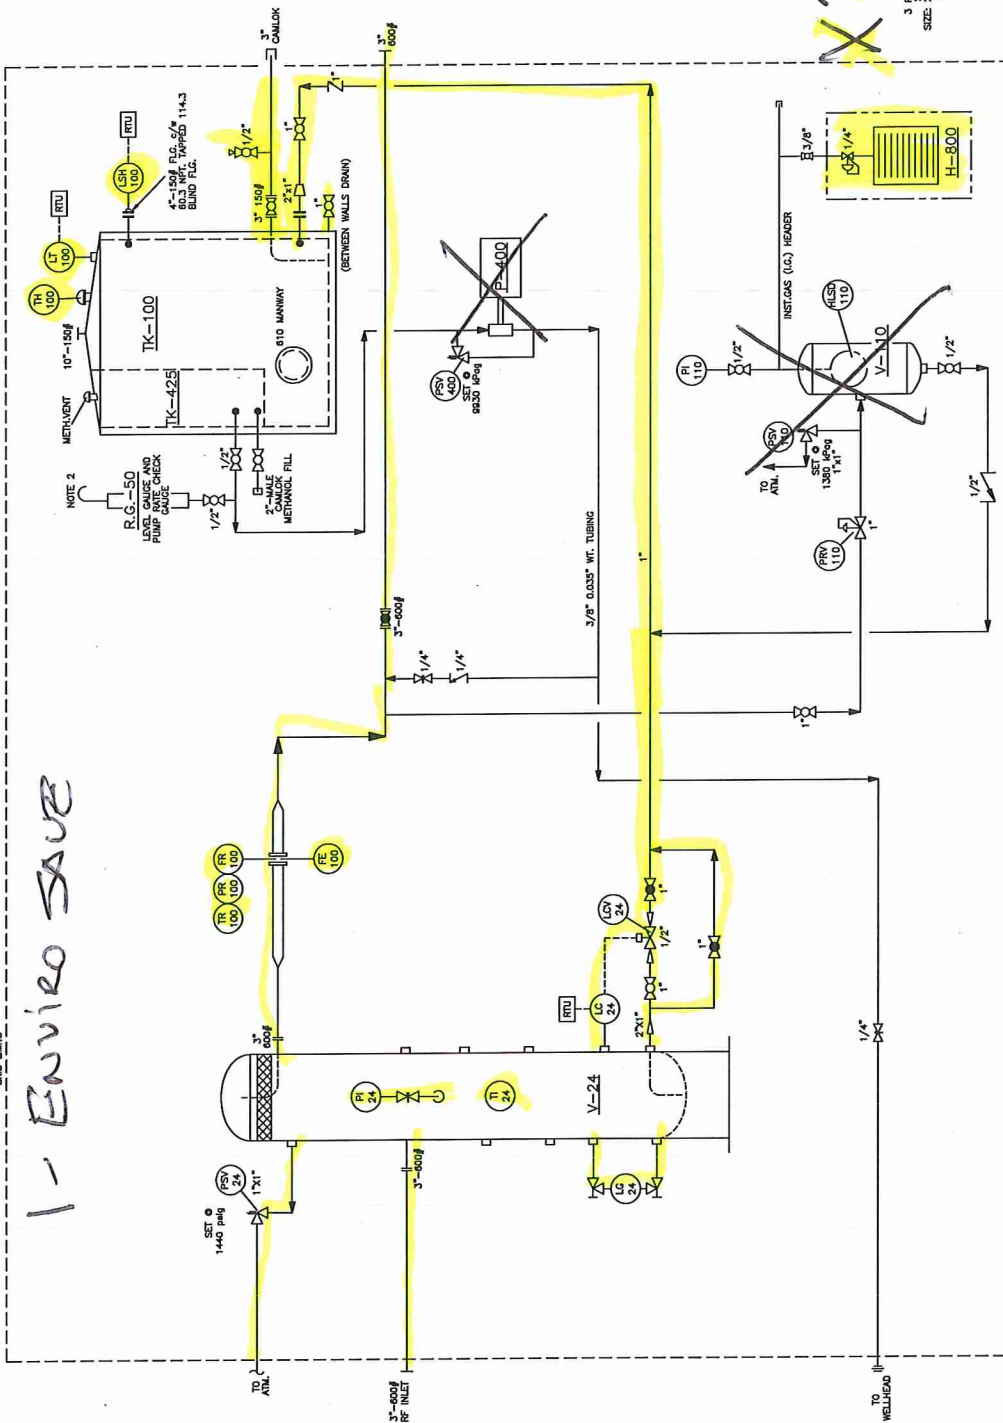

BILL OF MATERIAL			SHEET SERVICE	
ITEM	QTY	DESCRIPTION	MODEL #	MANUFACT.
FE-100	1	3" - 600# RF DIA. CHAMBER METER RUN, FLANGED BOTH ENDS, SCH 80 BORE.		DANIEL
RP/PT-100	1	RECOMMENDED 3 IN. RECORDER, 0-1500 #/sq. INCH, 0-100" W.C. c/w 3 VALVE MANIFOLD & 1/2" 5/8" TUBING	202E	BARTON
LC-24	1	2" NPT LEVEL CONTROLLER, DIRECT/INVERT ACTION, VERTICAL FLOAT, DUAL PILE ELECTRIC OUTPUT.	1001	NORSEAL
LV-24	1	1/2" NPT BALL VALVE, 3000# WOG c/w	46PV-SE	WORCESTER
LG-24A	1	LEVEL GAUGE (RETRACTED)	10-100-100	ELGIN
LG-24	1	6" DANIEL GAUGE COOKS	91TL	DANIEL
PSV-24	1	1" x 1" NPT RELIEF VALVE, SET @ 1440 #/sq. IN.	IS	DANIEL
PI-24	1	1/2" NPT BOTTOM MOUNT x 4" DIA. LIQUID FILLED PRESSURE GAUGE, 0 - 2000 #/sq. IN.	8200	TAYLOR
TI-24	1	1/2" NPT BOTTOM MOUNT x 4" DIA. LIQUID FILLED PRESSURE GAUGE, 0 - 2000 #/sq. IN.	8200	TAYLOR
PSV-100	1	1" NPT RELIEF VALVE, SET @ 1440 #/sq. IN.	SS-463AS	WILLMARK
TI-100	1	2" NPT LEVEL SWITCH, ELECTRIC	527TE	WILLMARK
LG-100	1	LEVEL GAUGE - STANDARD PULLEY ASSEMBLY		WILLMARK
PI-110	1	1/2" NPT BOTTOM MOUNT x 4" DIA. LIQUID FILLED PRESSURE GAUGE, 0 - 160 #/sq. IN.	FSV-12	WILLMARK
PSV-110	1	1" x 1" NPT RELIEF VALVE SET @ 150 #/sq. IN.	8200	TAYLOR
PRV-110	1	1" NPT REGULATOR, STEEL BODY, 1000# #/sq. IN. INLET PRESS. 75-150 #/sq. IN. SPRING, 45-50 #/sq. IN.	2022PR	WILLMARK

VALVES			MANUFACT.	
QTY	DESCRIPTION	MODEL #		
1	3" - 1500# NPT. RF. BALL VALVE, LEVER OPERATED.	380-CH-100		ENTON
1	2" - 2000# NPT. RF. BALL VALVE, LEVER OPERATED.	H-1		NAVCO
1	1" - 2000# NPT. RF. BALL VALVE, LEVER OPERATED.	H-1		NAVCO
1	1" - 2000# NPT. RF. BALL VALVE, LEVER OPERATED.	H-1		NAVCO
1	1/2" - 2000# NPT. RF. BALL VALVE, LEVER OPERATED.	H-1		NAVCO
2	1/2" - 2000# NPT. RF. BALL VALVE, LEVER OPERATED.	H-1		NAVCO
1	1/4" - 2000# NPT. RF. BALL VALVE, LEVER OPERATED.	H-1		NAVCO
1	2" - 600# RF. GLOBE VALVE			NAVCO
3	1" - 800# RF. GLOBE VALVE			NAVCO
1	1" - 800# NPT. CHECK VALVE			NAVCO
1	1/2" - 800# NPT. CHECK VALVE			NAVCO
1	1/4" - 800# NPT. CHECK VALVE			NAVCO
2	1/2" - 6000# NPT. MF. NEEDLE VALVE	1634P		WGI
1	1/4" - 6000# NPT. MF. NEEDLE VALVE	1612P		WGI

V-110
3 PHASE SEPARATOR
SIZE: 24" OD x 7'-6" s/s
DP: 1400 #/sq. IN.

P-400
METHANOL PUMP
SIZE: 1" x 1/2" x 1/2" s/s
DP: 1400 #/sq. IN.

H-800
CATALYTIC HEATER
SIZE: 12" x 12" x 12" s/s
DP: 1400 #/sq. IN.

TK-100
DOUBLE WALLED
STORAGE TANK
100 BBL

GENERAL NOTES: -
1.) TUBING, TO BE STAINLESS STEEL, WITH O.D. PLATED FITTINGS.
2.) VENT TO ABOVE TOP OF TANK (TK-100)

TANK REF.No. UF 73-008
(1 UNIT)

ULTRAFAB INDUSTRIES LTD.

CLIENT: ULTRAFAB STANDARD

TANK 100 BBL DOUBLE WALL TANK c/w 24" DIA x 7'-6" s/s 'BARN' STYLE SEPARATOR - P&ID

SCALE: N.T.S. DRAWING No. PD73-008 DATE: 07-08-79

QUOTE REF: - PROJECT: 73-008 Drawing: PD73-008

REV.	DATE	DESCRIPTION	DRAWN	CHECK	DESIGN	APPR.
0	29-MAY-07	ISSUED FOR CONSTRUCTION	CB		LM	

THIS DRAWING AND THE DESIGN IT CONTAINS ARE CONFIDENTIAL AND SHALL NOT BE DISCLOSED TO OTHERS OR REPRODUCED IN ANY MANNER OR USED FOR ANY PURPOSE WHATSOEVER EXCEPT BY WRITTEN CONSENT OF ULTRAFAB.