


FILE PATH: C:\USERS\MOWER\DESKTOP\PCD BOREAS 4-25-19\EAST-OTF-PID-3000-021.DWG BY:MOWER DATE:Apr 25, 2019 9:29am

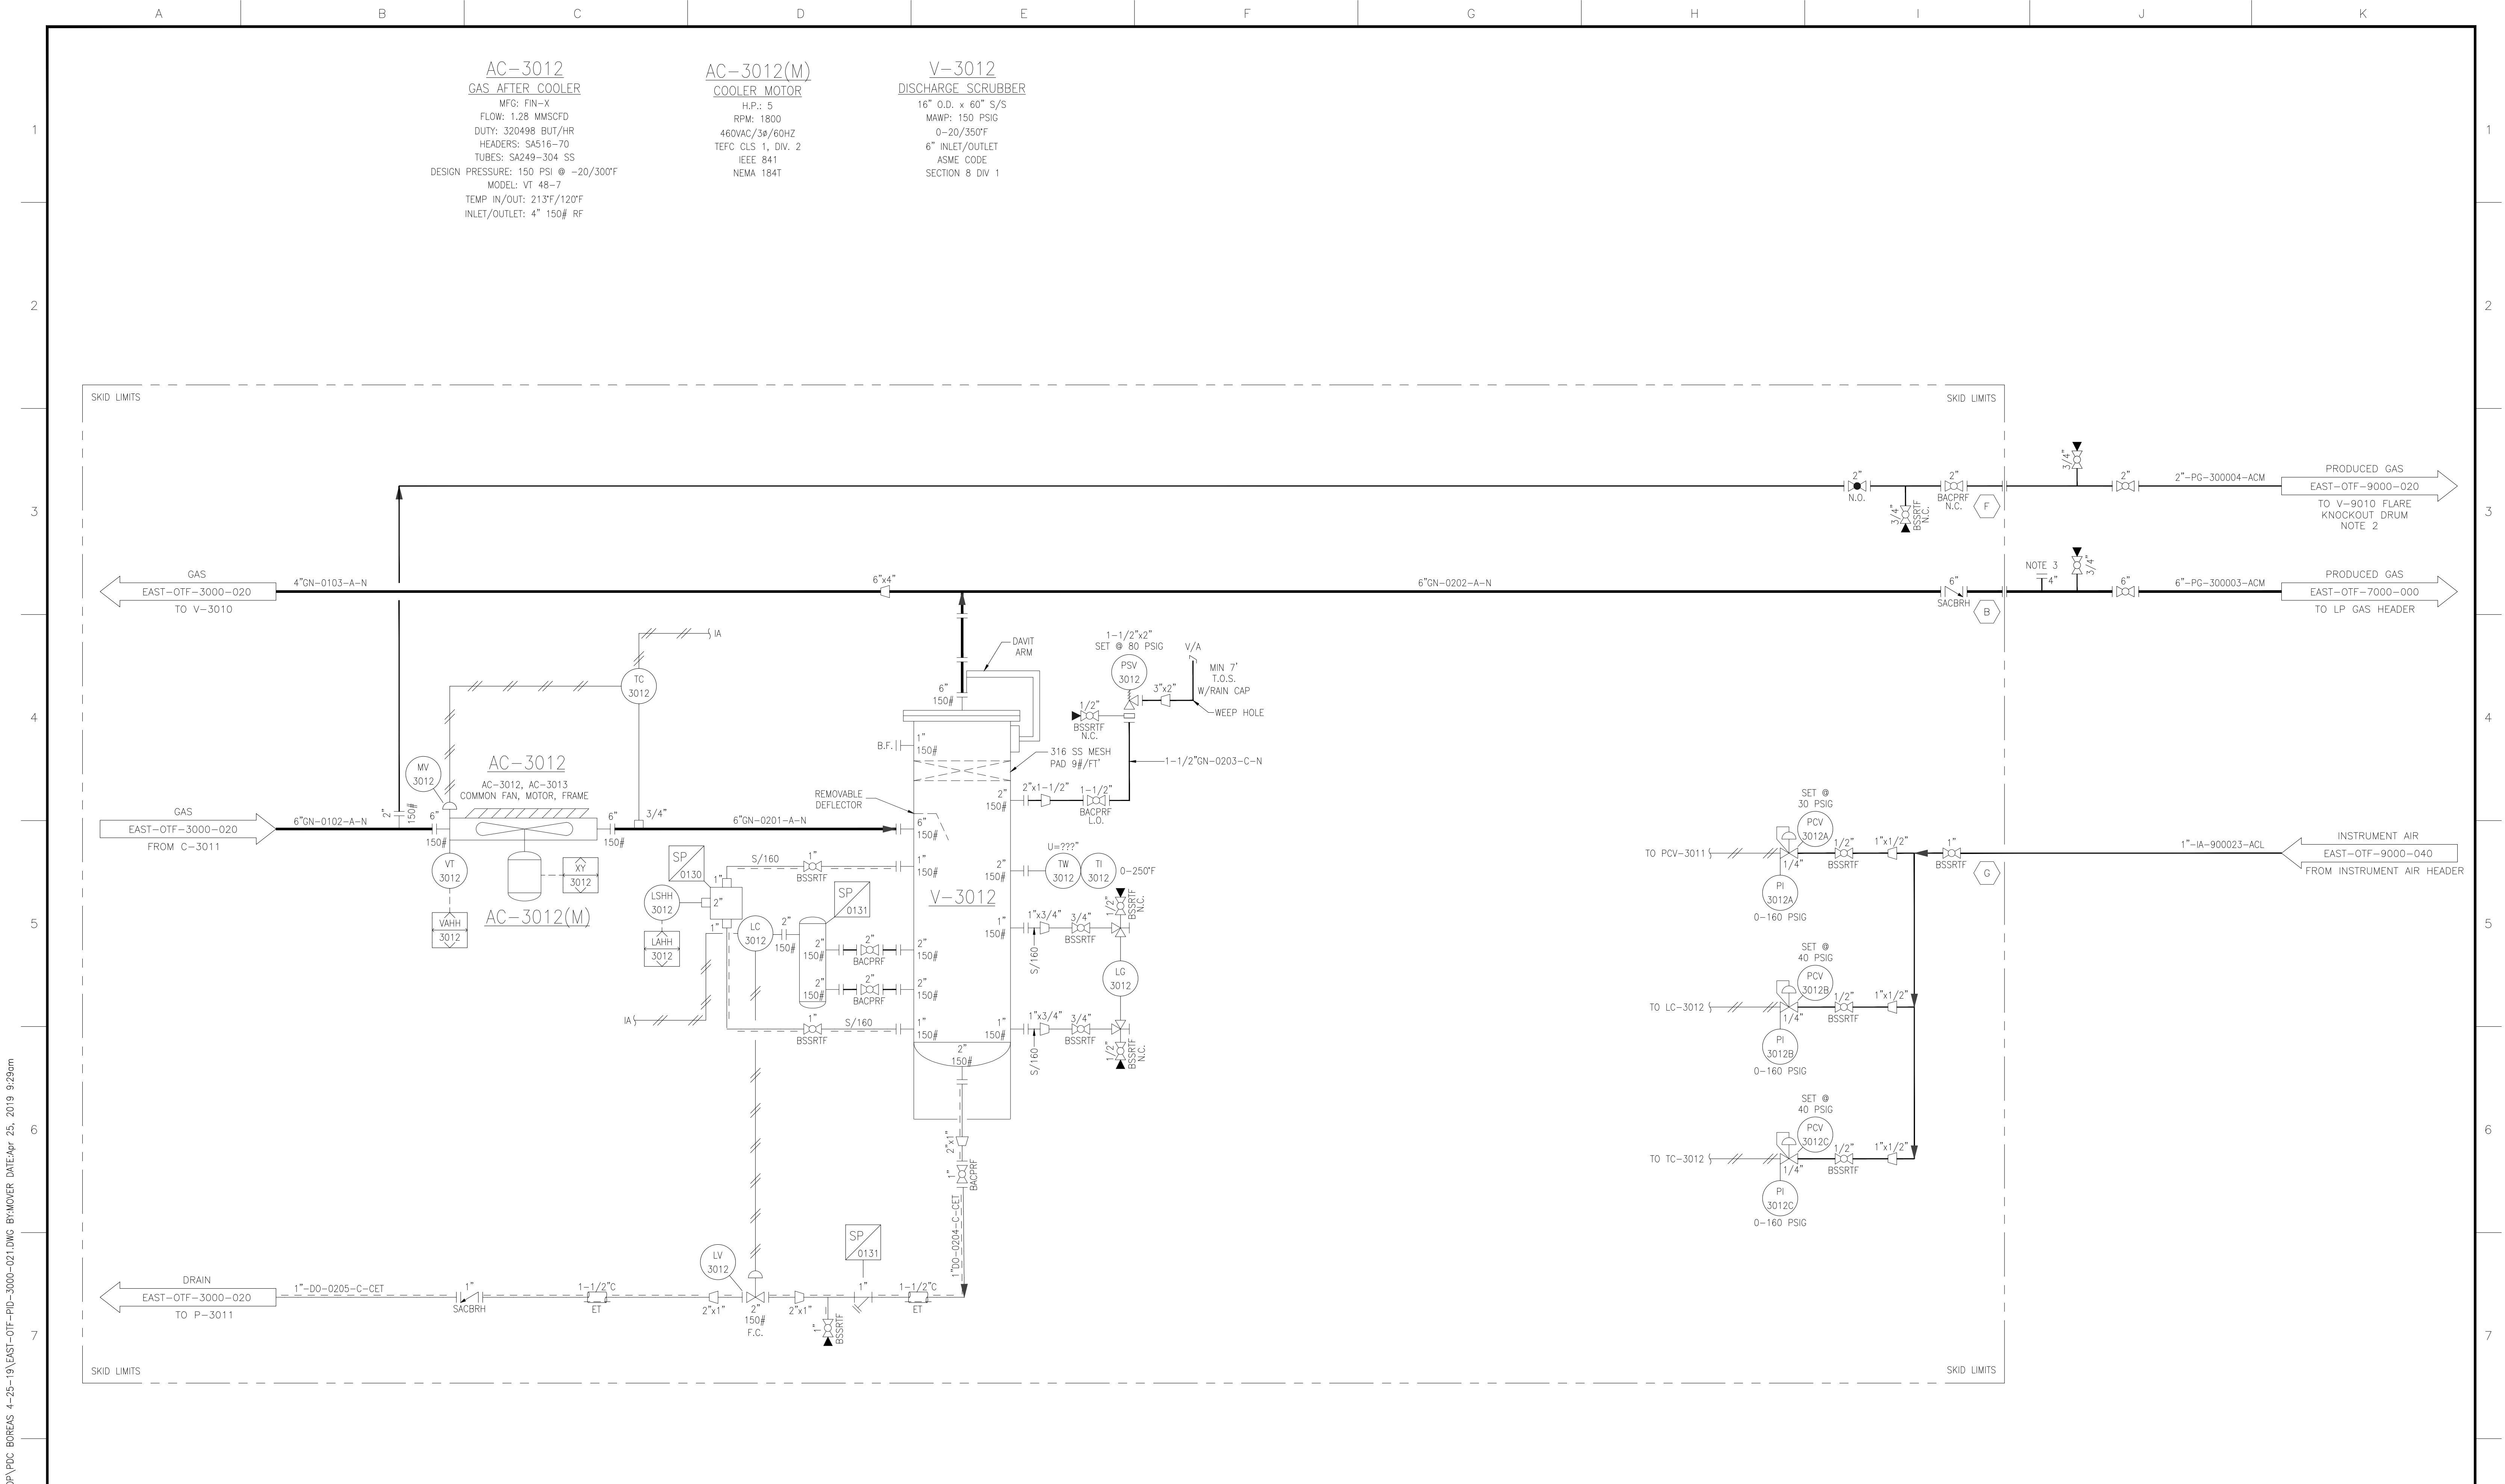

NOTES: 1. SEE EAST-OTF-3000-023. 2. COMPRESSOR BLOWDOWN. 3. PSV CONNECTION.	DESIGN CONDITIONS: P1 = 0.5-2.0 PSIG P2 = 30 PSIG T1 = 120°F T2 = 120°F TA = 100°F SG = 1.83 N = 1.11 EL = 2600 FASL Q = 1.04-1.28 MMSCFD	REFERENCE DRAWINGS		REVISIONS						APPROVALS		 PIPING & INSTRUMENTATION DIAGRAM NEAST BOREAS OTF REEVES COUNTY, TEXAS VRU COMPRESSOR DISCHARGE		
		DWG NO.	TITLE	REV	DESCRIPTION	MAO BY	04/25/19 DATE	TBM CHK BY	04/25/19 CHK DATE	TBM APR BY	04/25/19 APR DATE		OPERATIONS ENGINEERING PROJ. MGR.	SIGNATURE DATE