


SLP#7	SLP#5	LDY#3	SLP#1
SLP#8	SLP#6	SLP#4	SLP#2

CAMP KEYPLAN

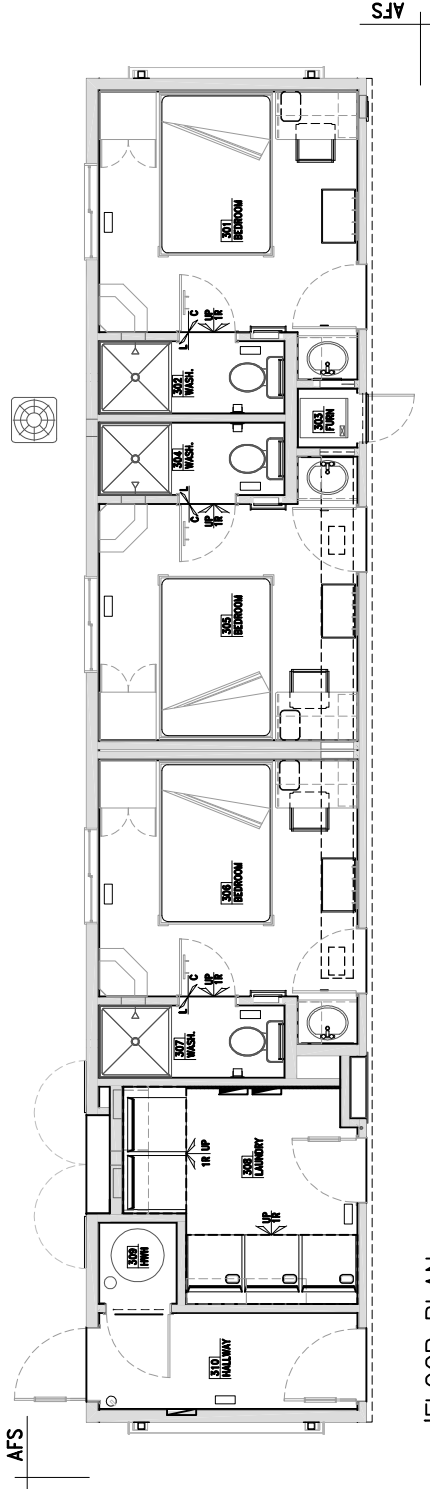

FLOOR PLAN
NOT TO SCALE

11'-8" x 56'-0" (skid) "3-BED LAUNDRY"
REFERENCE #: SE(30SBED)

Copyrighted Material. No Reproduction of any kind of this document and associated herein. © 2009 Alta-Fab Structures Ltd.

Client:	
Plan:	TITLE SHEET
ALTA-FAB The Ultimate in Transportable Buildings ... 504-13th Avenue, Niasa AB, Canada T0E7P6 Telephone: 780.955.7733 Fax: 780.955.7851 Toll Free: 1.800.252.7990	
Date:	CAD File:
AUG. 26, 2010	SE(30SBED)
Drawn:	Template File:
	101256-3BEDLDYa.R001
Sales Person:	Department:
Checked:	
Approved:	
	30
	54

GENERAL NOTES

- See Exterior Elevations for Complex Wall Finishes.
- "HWI and Furnace Room" to be c/w 1 1/2" x 1 1/2" "Bone White" metal moldings.
- Gas feeds to furnace & hot water heater room to run along roof of unit & painted yellow, see dorm roof layout.
- A/C to be installed on site, ship loose.
- All water interconnects to be "Quick Connect" run from Client Supply/Install Main feed to unit HWI, then to fixtures via Hallway.
- Unit-Unit Sat. and Fire Alarm Interconnects, to be "Quick Connects" run in Hallway from Unit Furnace Room to Mech in Laundry.
- Use 16" "ROXUL-SAFE N' SOUND" Wall Insulation to HALLWAY & PARTY WALLS - SEE SECTION "A & D".
- Use R20 Batt Insulation for Exterior "LONG & END" Walls.
- See Section "D" for securing walls against sound penetration.
- All water lines to be "pex", except Furnace Rooms are copper.
- Add Access Panels where applicable for plumbing.
- Use "White" Baseboard for shower trim.