


CONTINUED FROM
Dwg No E-0201

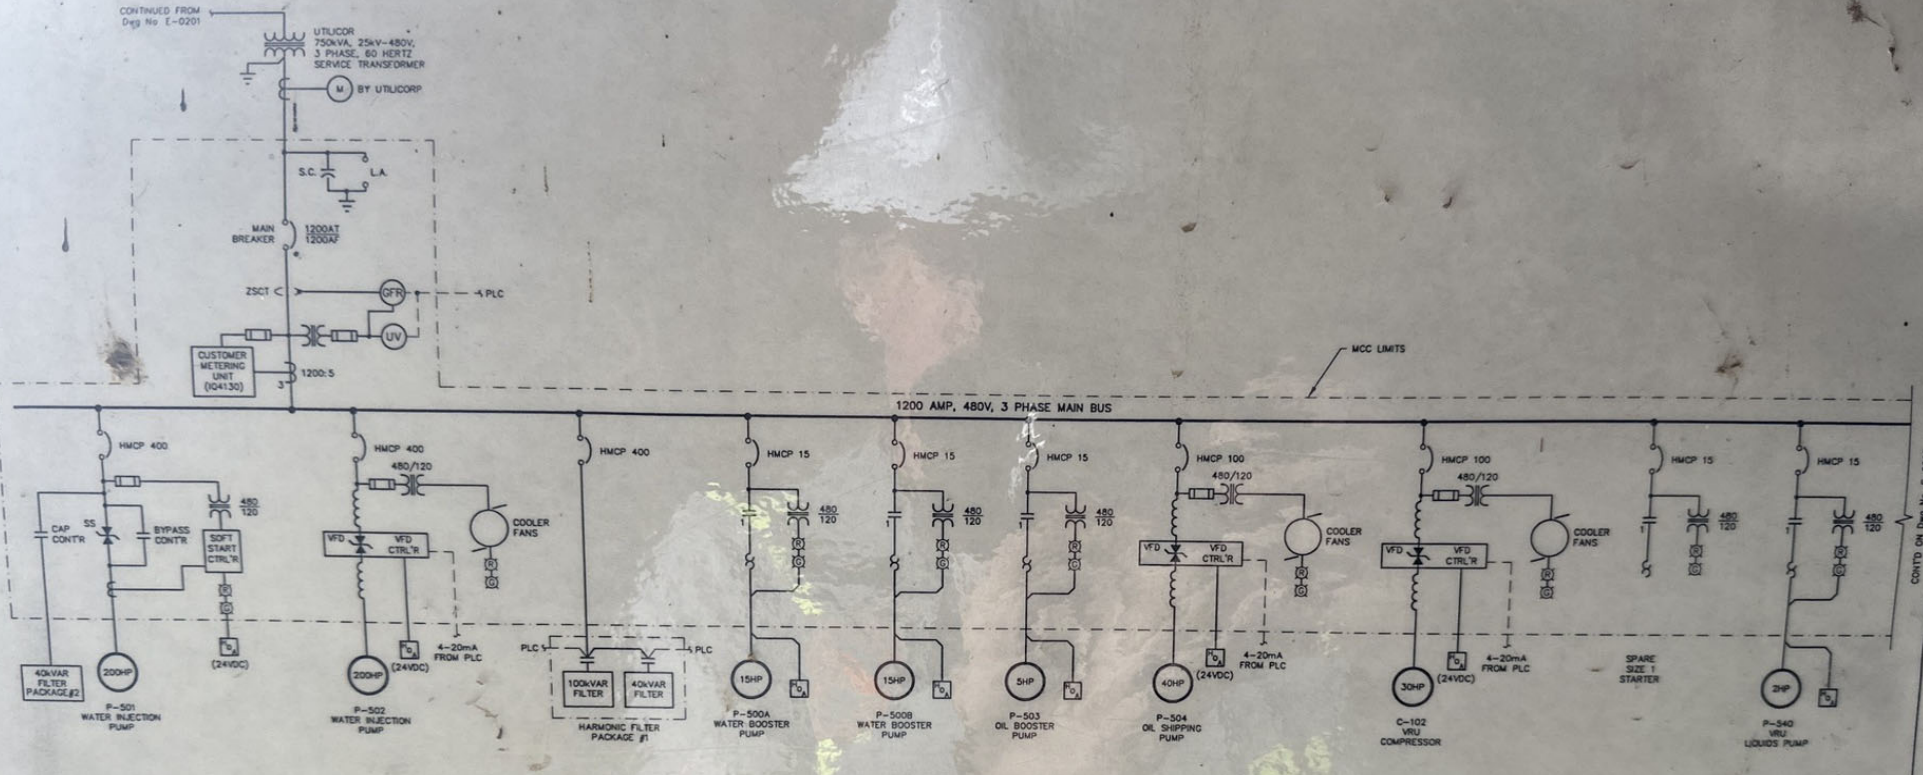

CONTD ON DWG No. E-0203

PREPARED BY SUTTON, THOMAS ENG. LTD.
PROJECT No. 01-036
FILE No. 01026-E0202

GENERAL NOTES		REFERENCE DRAWINGS		REVISIONS				PERMIT	SEAL
NUMBER	DATE	NO.	DESCRIPTION	BY	DATE	CHK.			
1		1	ISSUED FOR CONSTRUCTION	HT	08.02.22	C.T.			
2		2	AS BUILT	HT	08.13	C.D.			


NOV 05 2002
AS BUILT

Textla GAS ENGINEERING

EnerMark Inc.

DRAWN: MARS DE NOVA
DATE: 02.02.22
DWG: C. THOMAS
APP'D: C. THOMAS

JOARCAM 11-13 BATTERY
LSD 11-13-50-22 W4M
480V SINGLE LINE DIAGRAM
DWG # E-0202 1 of 2 RY 2

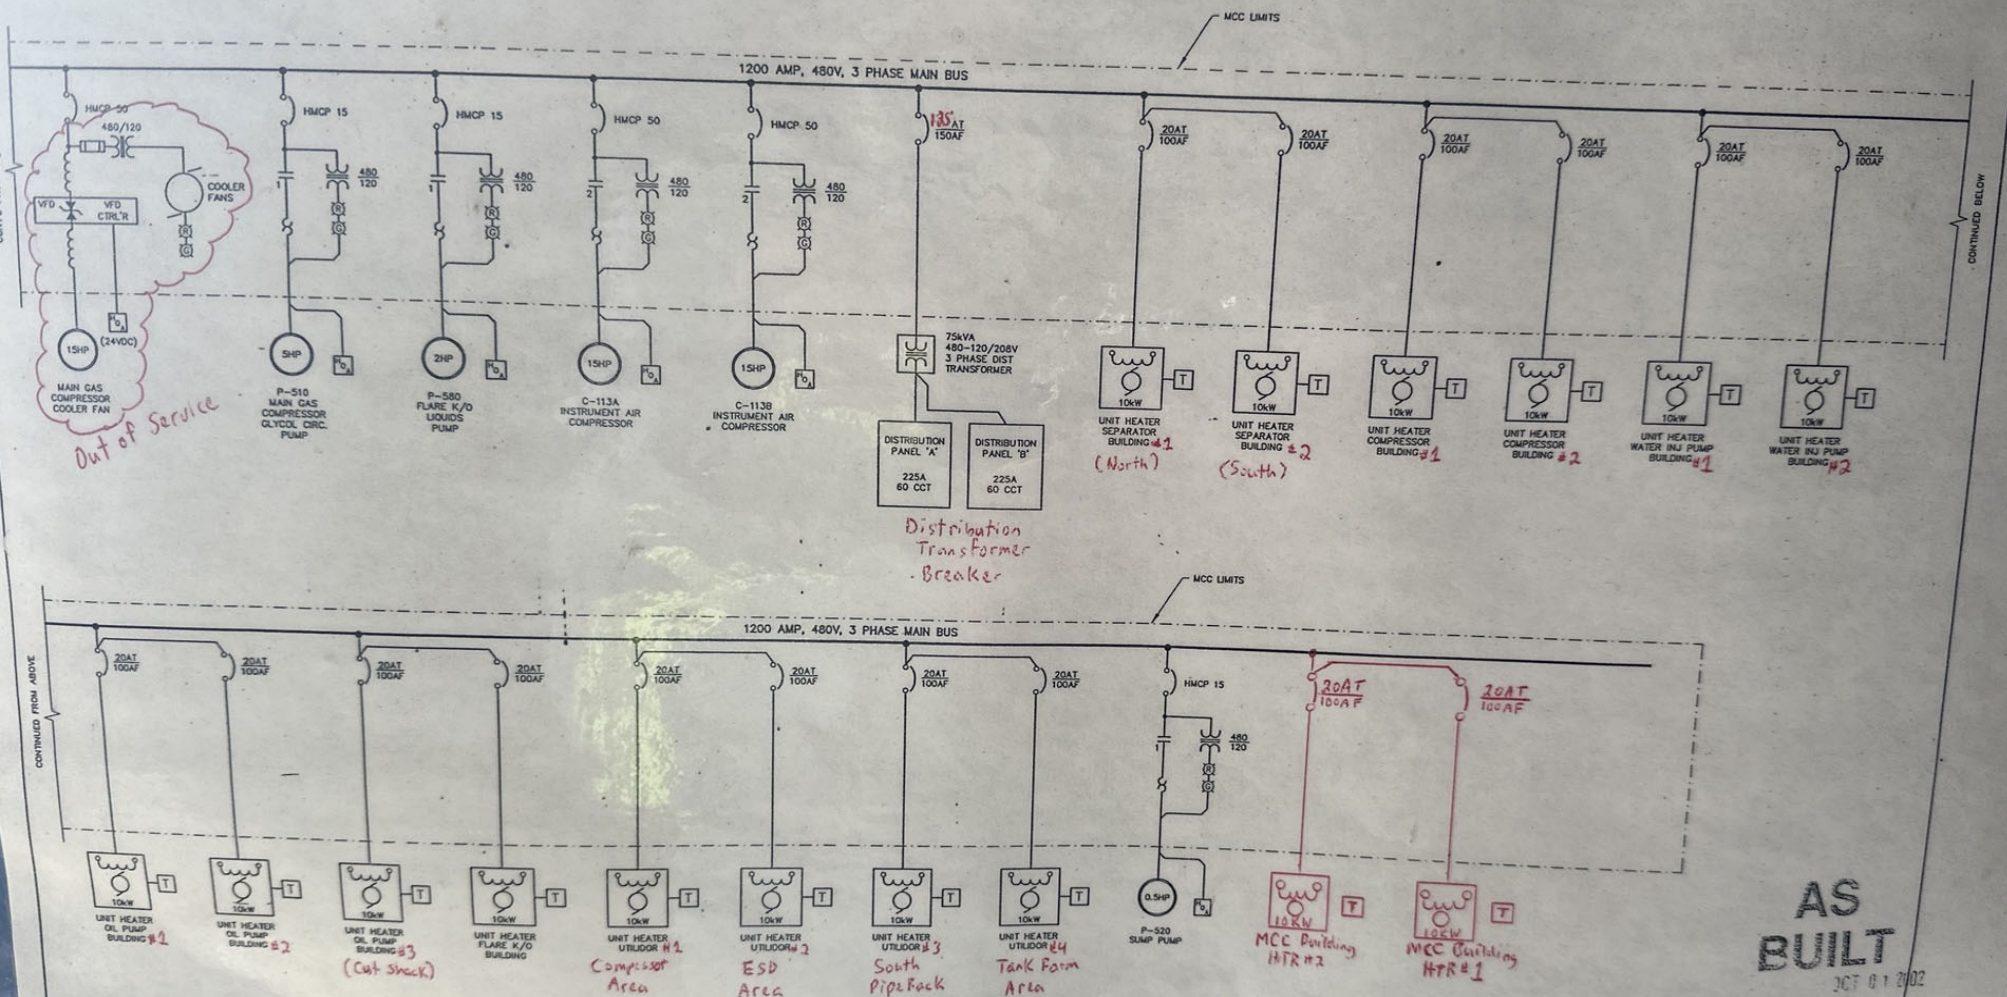

Out of Service

Distribution Transformer Breaker

Compressor Area

ESD Area

South Pipe Rack

Tank Farm Area

AS BUILT
JCT 01 2002

GENERAL NOTES

REFERENCE DRAWINGS		REVISIONS				PERMIT	SEAL
NUMBER	TITLE	NO.	DESCRIPTION	BY	DATE	CHK.	
1		1	ISSUED FOR CONSTRUCTION	MM	02.02.22	C.T.	
2		2	AS BUILT	MM	02.02.22	C.T.	

Tux GAS ENGINEERING LTD.

M EnerMark Inc.

DRW: Marc de Hoos
DATE: 02.02.22
CHK: C. THOMAS

JOARCAM 11-13 BATTERY
LSD 11-13-30-22 W4M
480V SINGLE LINE DIAGRAM
SCALE: N/A
REV: E-0203 2 of 2

PREPARED BY SUTON, DENNIS INC. LTD.
PROJECT NO. 01-054
FILE NO. 01050-01003