
 
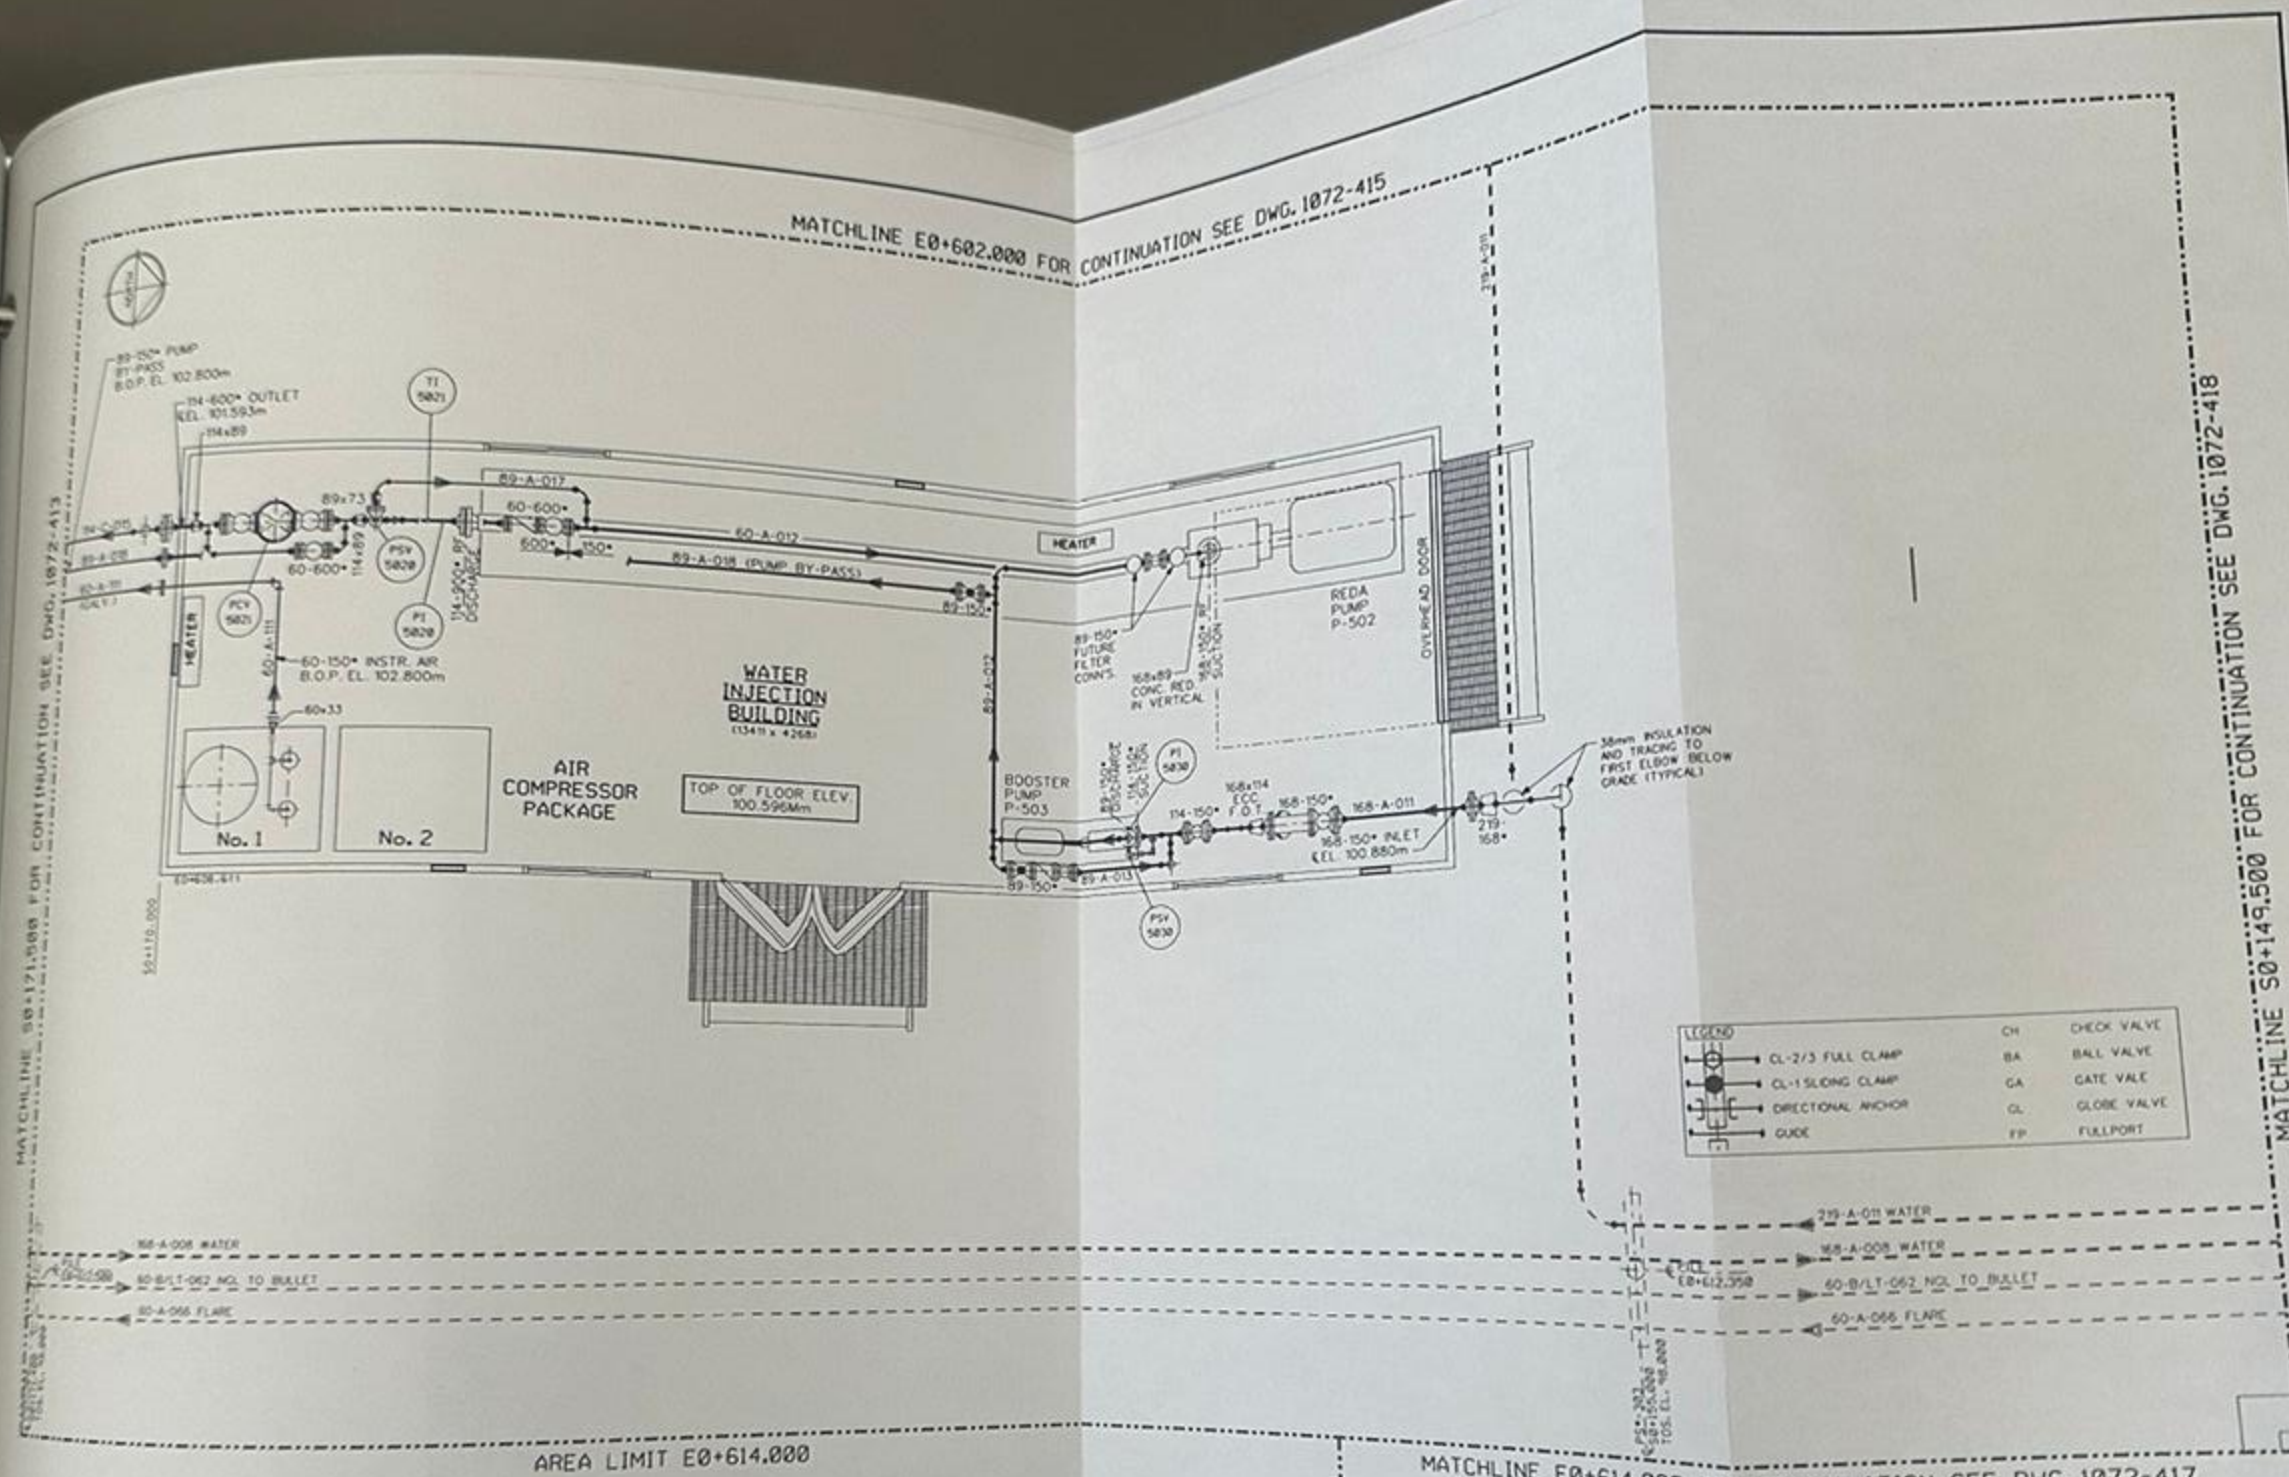




GENERAL NOTES		REFERENCE DRAWINGS		REVISIONS			
NUMBER	TITLE	NO	DESCRIPTION	BY	DATE	CHK	
		A	ISSUED FOR APPROVAL	RJB	000921		
		1	ISSUED FOR CONSTRUCTION	RJB	001002		
		2	AS-BUILT AS PER FIELD MARK-UPS	RJB	010209		

		 CABRE EXPLORATION LTD. CALGARY, ALBERTA	
DRAWN RJB	DATE 000921	JOARCAM OIL BATTERY AND GAS PLANT LSD 6-29-49-21 W4M WATER INJECTION BLDG. AREA PIPING PLAN	
CHK'D	DATE		
APPROVED:		SCALE B'-1:60 D'-1:30	DWG # 1072-416
TUXILA	CABRE		
DATE	DATE	REV. 2	

MATCHLINE E0+602.000 FOR CONTINUATION SEE DWG. 1072-415

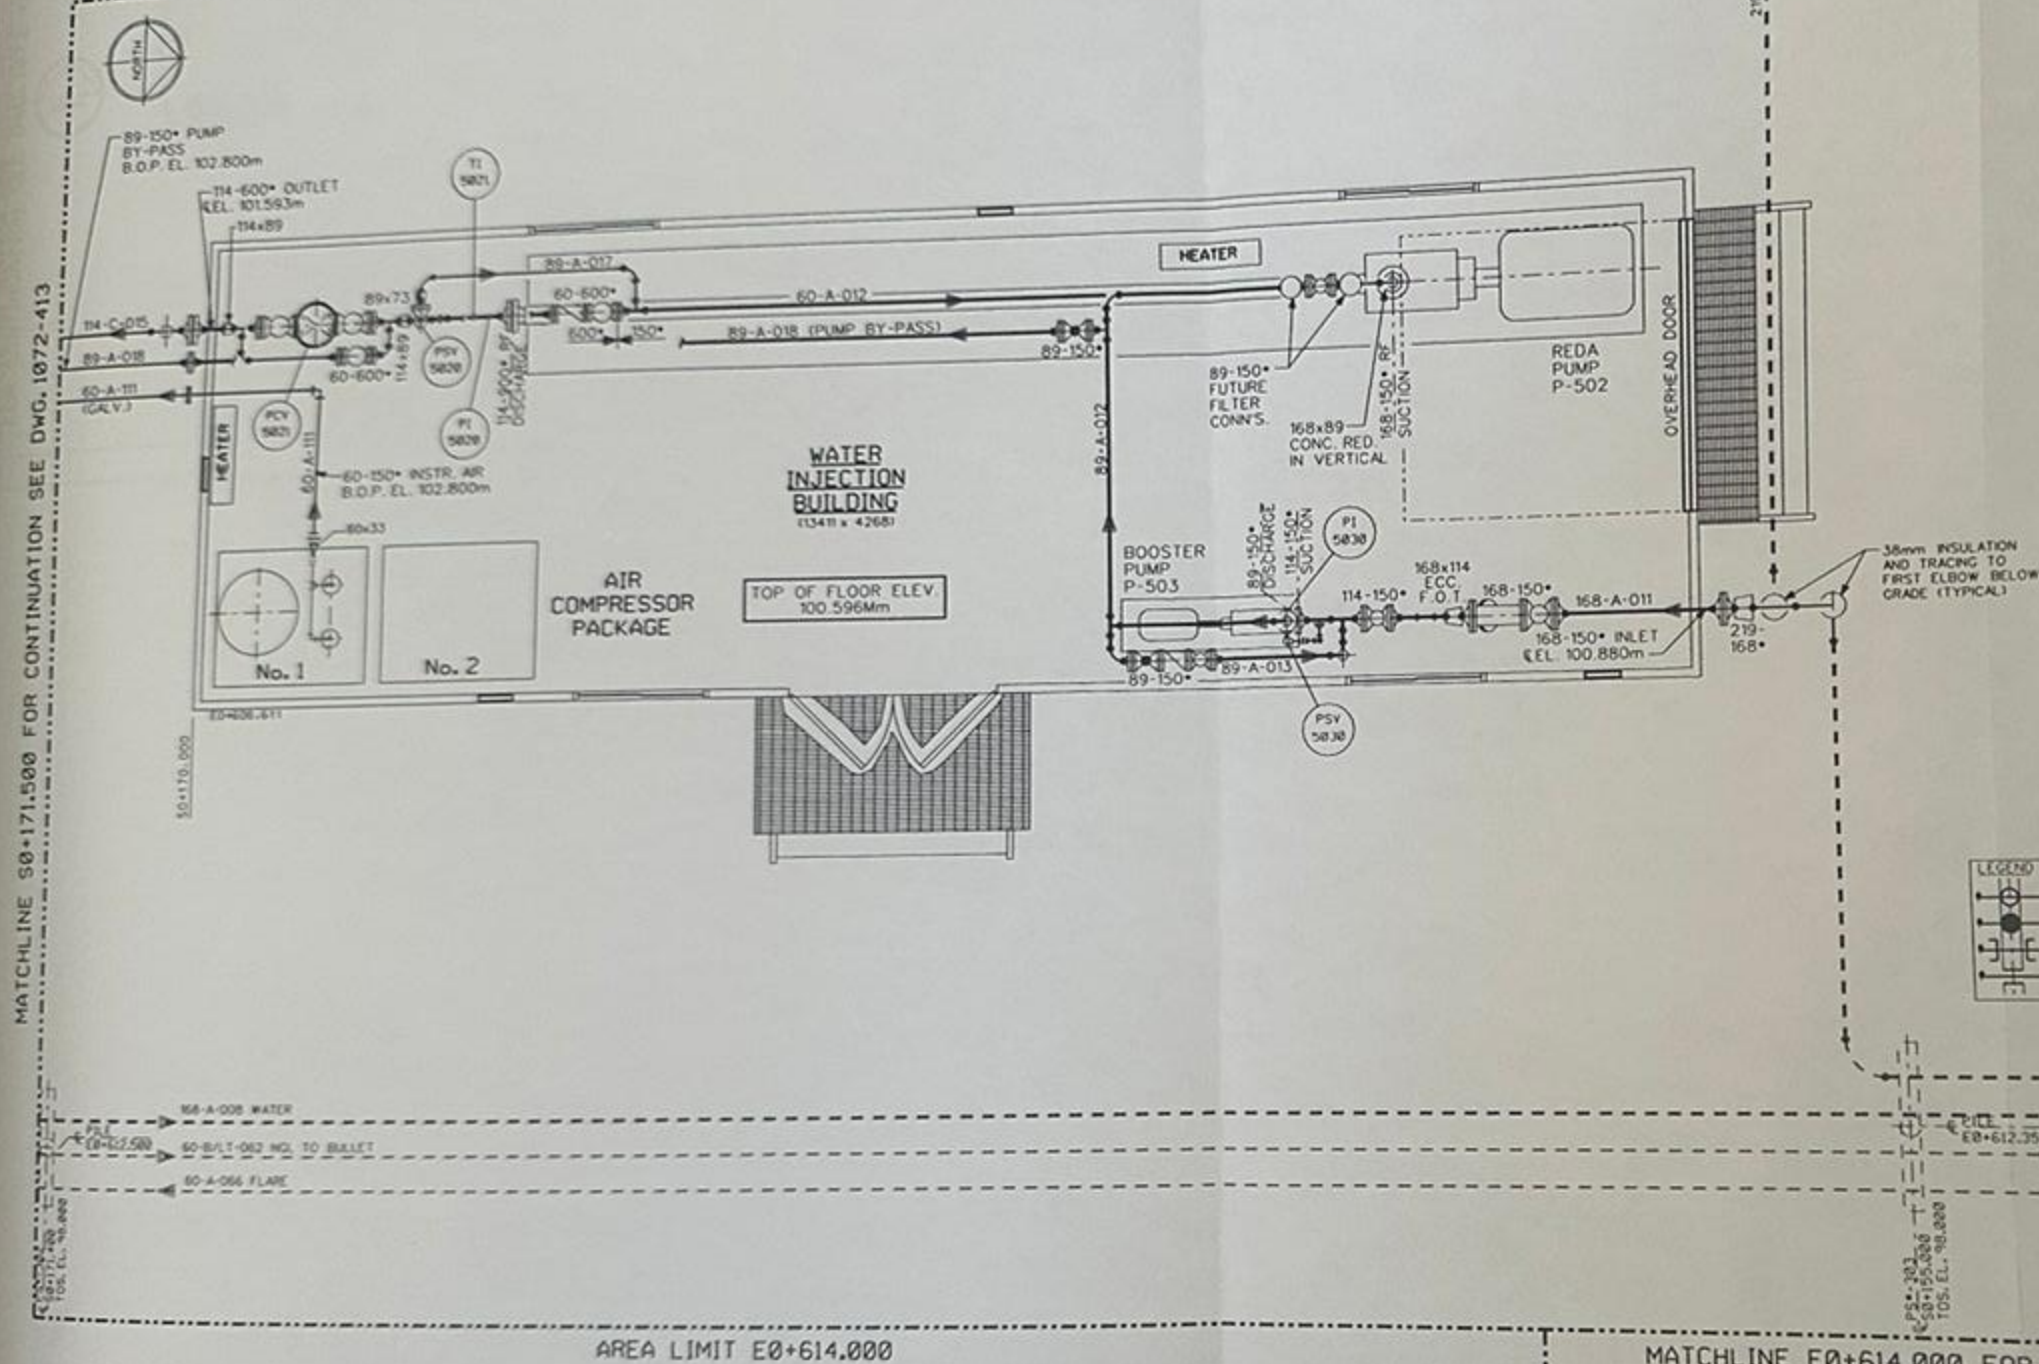

MATCHLINE S0+149.500 FOR CONTINUATION SEE DWG. 1072-418

GENERAL NOTES

REFERENCE DRAWINGS

REVISIONS

NUMBER	TITLE	NO.	DESCRIPTION	BY	DATE	CHK.
A		1	ISSUED FOR APPROVAL	RJB	000925	
		1	ISSUED FOR CONSTRUCTION	RJB	001002	
		2	AS-BUILT AS PER FIELD MARK-UPS	RJB	010209	

Tuxtle GAS ENGINEERING LTD.


CABRE EXPLORATION LTD.

CALGARY, ALBERTA

DRAWN	RJB	DATE	000921
CHK'D		DATE	
APPROVED:			
TUXTLA	CABRE		
DATE	DATE		

JOARCAM OIL BATTERY AND GAS PLANT
LSD 6-29-49-21 W4M
WATER INJECTION BLDG. AREA
PIPING PLAN

SCALE 'B'-1:60
'D'-1:30
DWG. 1072-416
REV. 2

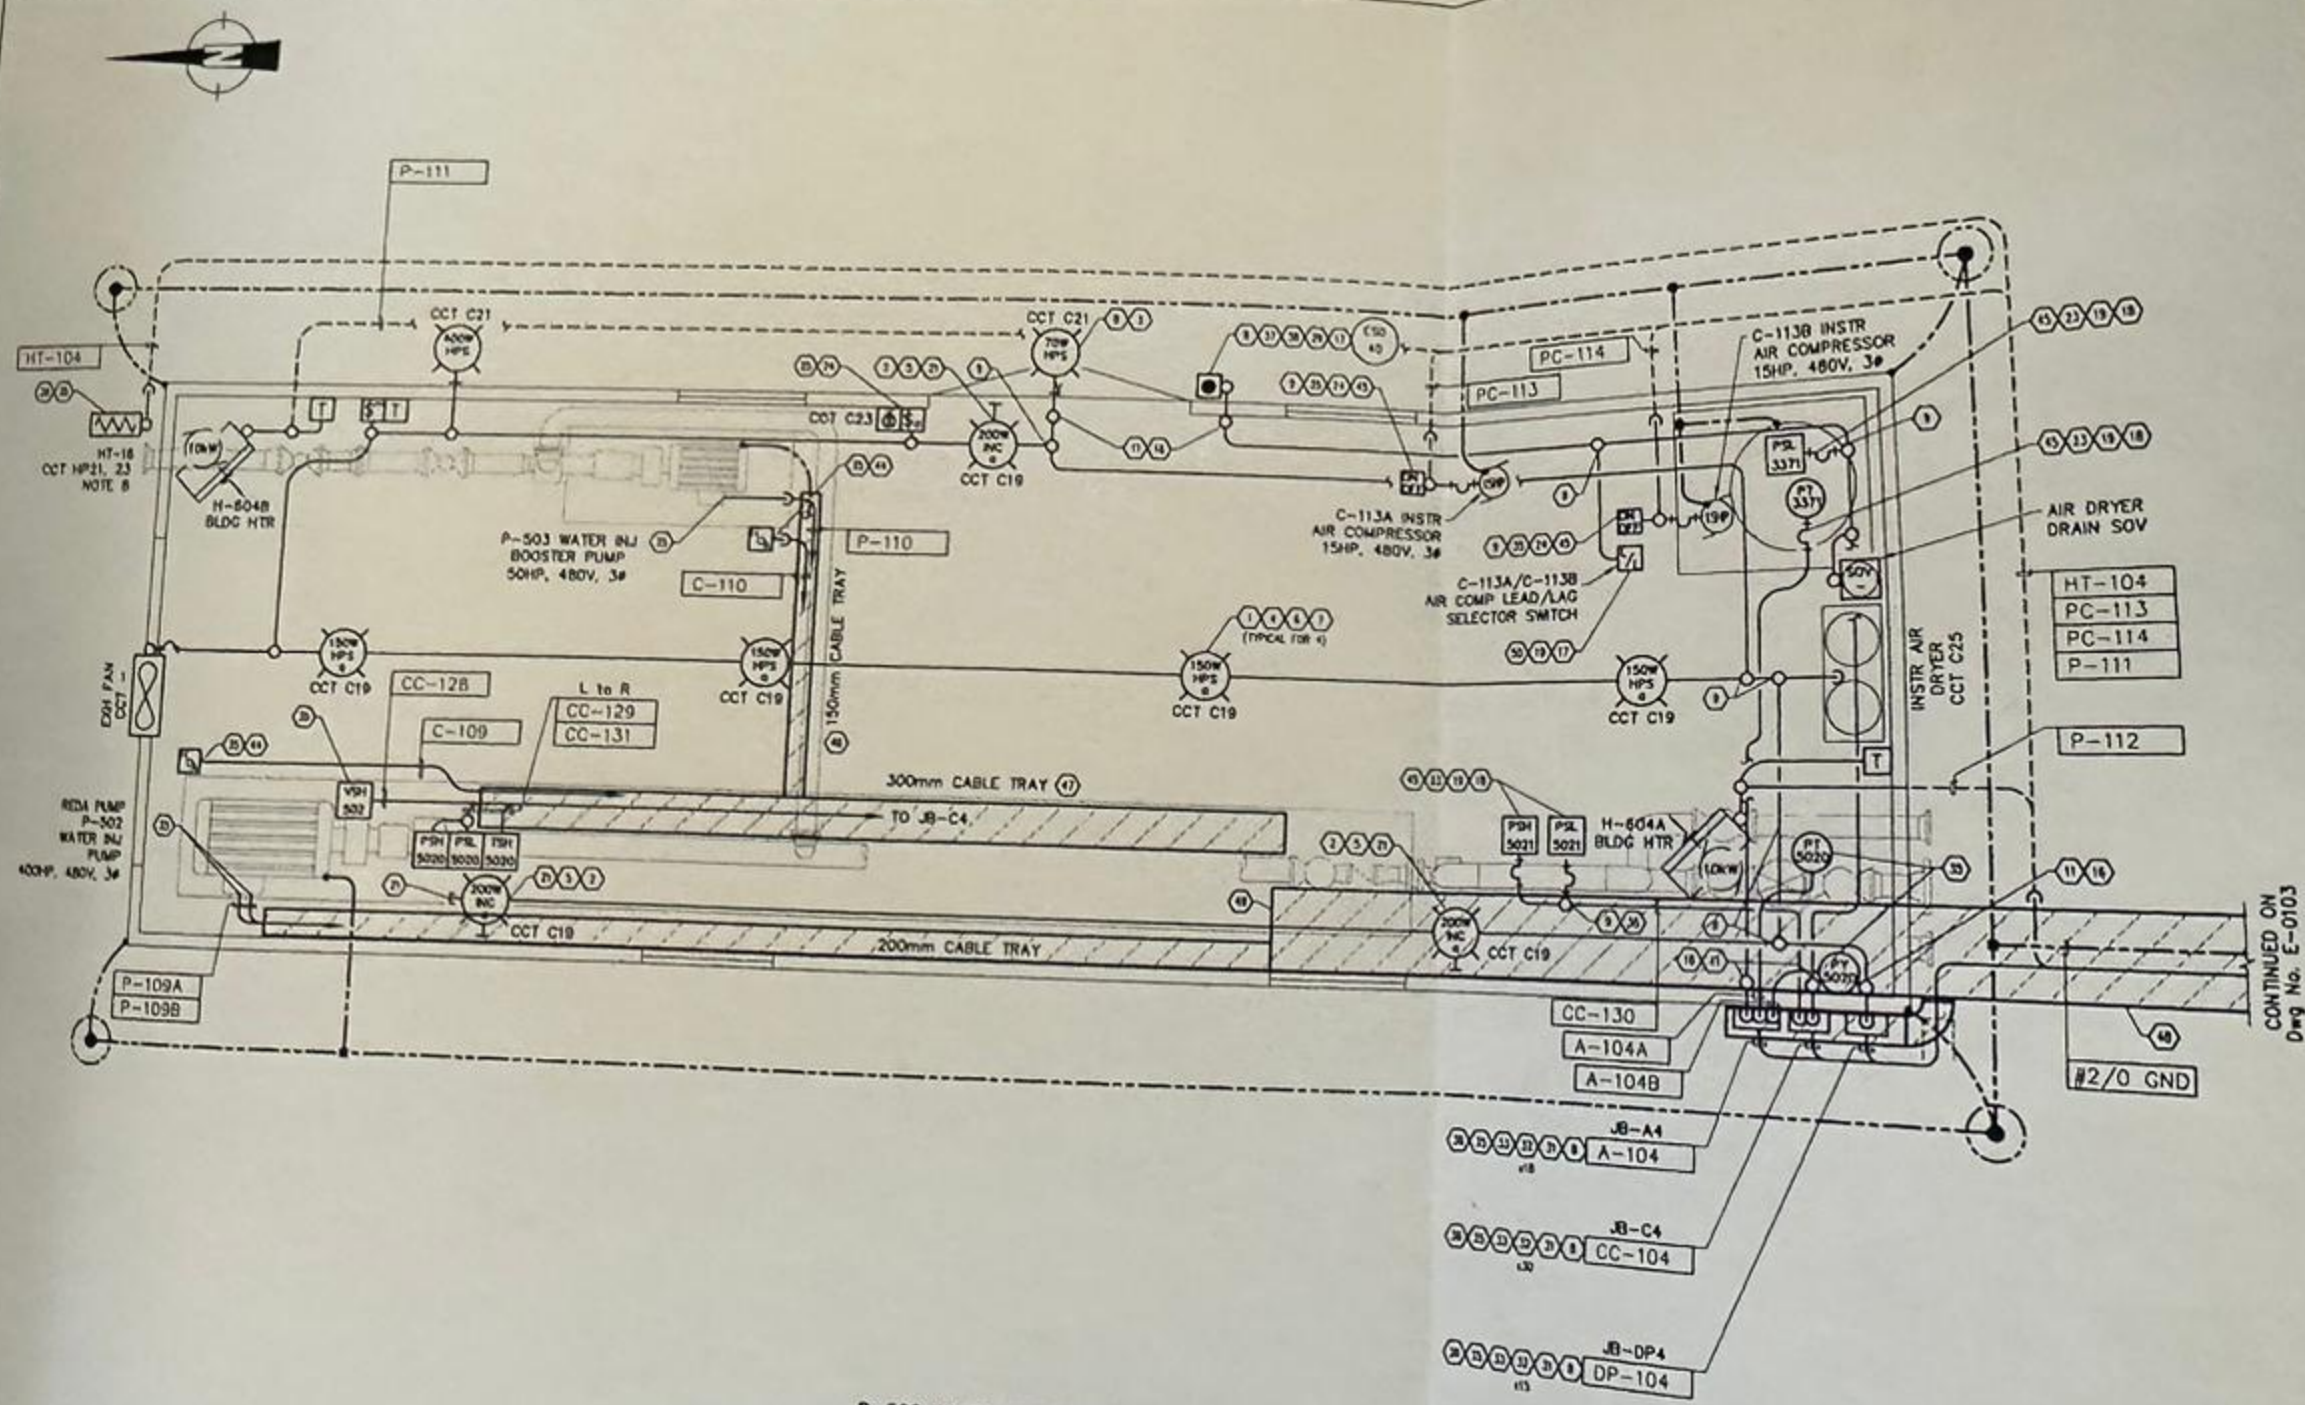

P-502 WATER INJECTION BUILDING
13411L x 4268W

ITEM No.	QTY.	DESCRIPTION
1	AS REQ'D	LIGHT FIXTURE (HPS)
2	-	LIGHT FIXTURE (INC)
3	-	LIGHT FIXTURE c/w LAMP
4	-	LAMP (HPS)
5	-	LAMP (INC)
6	-	FIXTURE HANGER
7	-	FIXTURE FLEX
8	-	OUTLET BOX/COVER/GA
9	-	OUTLET BOX/COVER/GA
10	-	OUTLET BOX
11	-	OUTLET BOX
12	-	OUTLET BOX
13	-	OUTLET BOX
14	-	OUTLET BOX
15	-	SEALING COVER
16	-	CONDUIT SEAL
17	-	CONDUIT SEAL
18	-	CONDUIT UNION
19	-	CONDUIT ELBOW
20	-	CONDUIT PLUG
21	-	CONDUIT REDUCER
22	-	CONDUIT REDUCER
23	-	TUMBLER SWITCH (F
24	-	RECEPTACLE (FACT
25	-	MANUAL MOTOR SW
26	-	MANUAL MOTOR SW
27	-	HEAT TRACE C/W
28	-	THERMOSTAT
29	-	TUMBLER SWITCH
30	-	JUNCTION BOX (C
31	-	TERMINAL BLOCK
32	-	TERMINAL MOUNT
33	-	JUNCTION BOX (C
34	-	HL TECK CONNEC
35	-	WEATHERPROOF
36	-	ESD PUSHBUTTON
37	-	ESD PUSHBUTTON
38	-	ENCLOSURE
39	-	FLEXIBLE COUPL
40	-	FLEXIBLE COUPL
41	-	FLEXIBLE COUPL
42	-	PILOT LIGHT
43	-	H-O-A SWITCH
44	-	LIQUID TIGHT C
45	-	ALUMINUM CAB
46	-	ALUMINUM CAB
47	AS REQ'D	ALUMINUM CAB
48	3	BURNER CONT
49	1	LEAD/LAG SE
50		
51		
52		

CONTINUED ON
Dwg No. E-0103

GENERAL NOTES

REFERENCE DRAWINGS		REVISIONS	
NUMBER	TITLE	NO.	DESCRIPTION

MAY 07 2001

AS

NOTE: A. ALL MATERIALS TO BE SUPPLIED BY CONTRACTOR.
B. CONTRACTOR TO BE RESPONSIBLE FOR OBTAINING ALL NECESSARY PERMITS AND APPROVALS.
CONSTRUCTION NOTES:
1. ALL CONDUIT OF ALUMINUM I.D. 1/2" OR LARGER TO BE INSTALLED IN ACCORDANCE WITH THE NATIONAL ELECTRICAL CODE (NEC) AND THE MANUFACTURER'S INSTRUCTIONS.
2. ALL CONDUIT TO BE INSTALLED IN A MANNER THAT WILL PROTECT IT FROM PHYSICAL DAMAGE AND FROM EXCESSIVE BENDING.
3. ALL CONDUIT TO BE INSTALLED IN A MANNER THAT WILL PROTECT IT FROM EXCESSIVE BENDING.
4. ALL CONDUIT TO BE INSTALLED IN A MANNER THAT WILL PROTECT IT FROM EXCESSIVE BENDING.
5. ALL CONDUIT TO BE INSTALLED IN A MANNER THAT WILL PROTECT IT FROM EXCESSIVE BENDING.
6. ALL CONDUIT TO BE INSTALLED IN A MANNER THAT WILL PROTECT IT FROM EXCESSIVE BENDING.

