


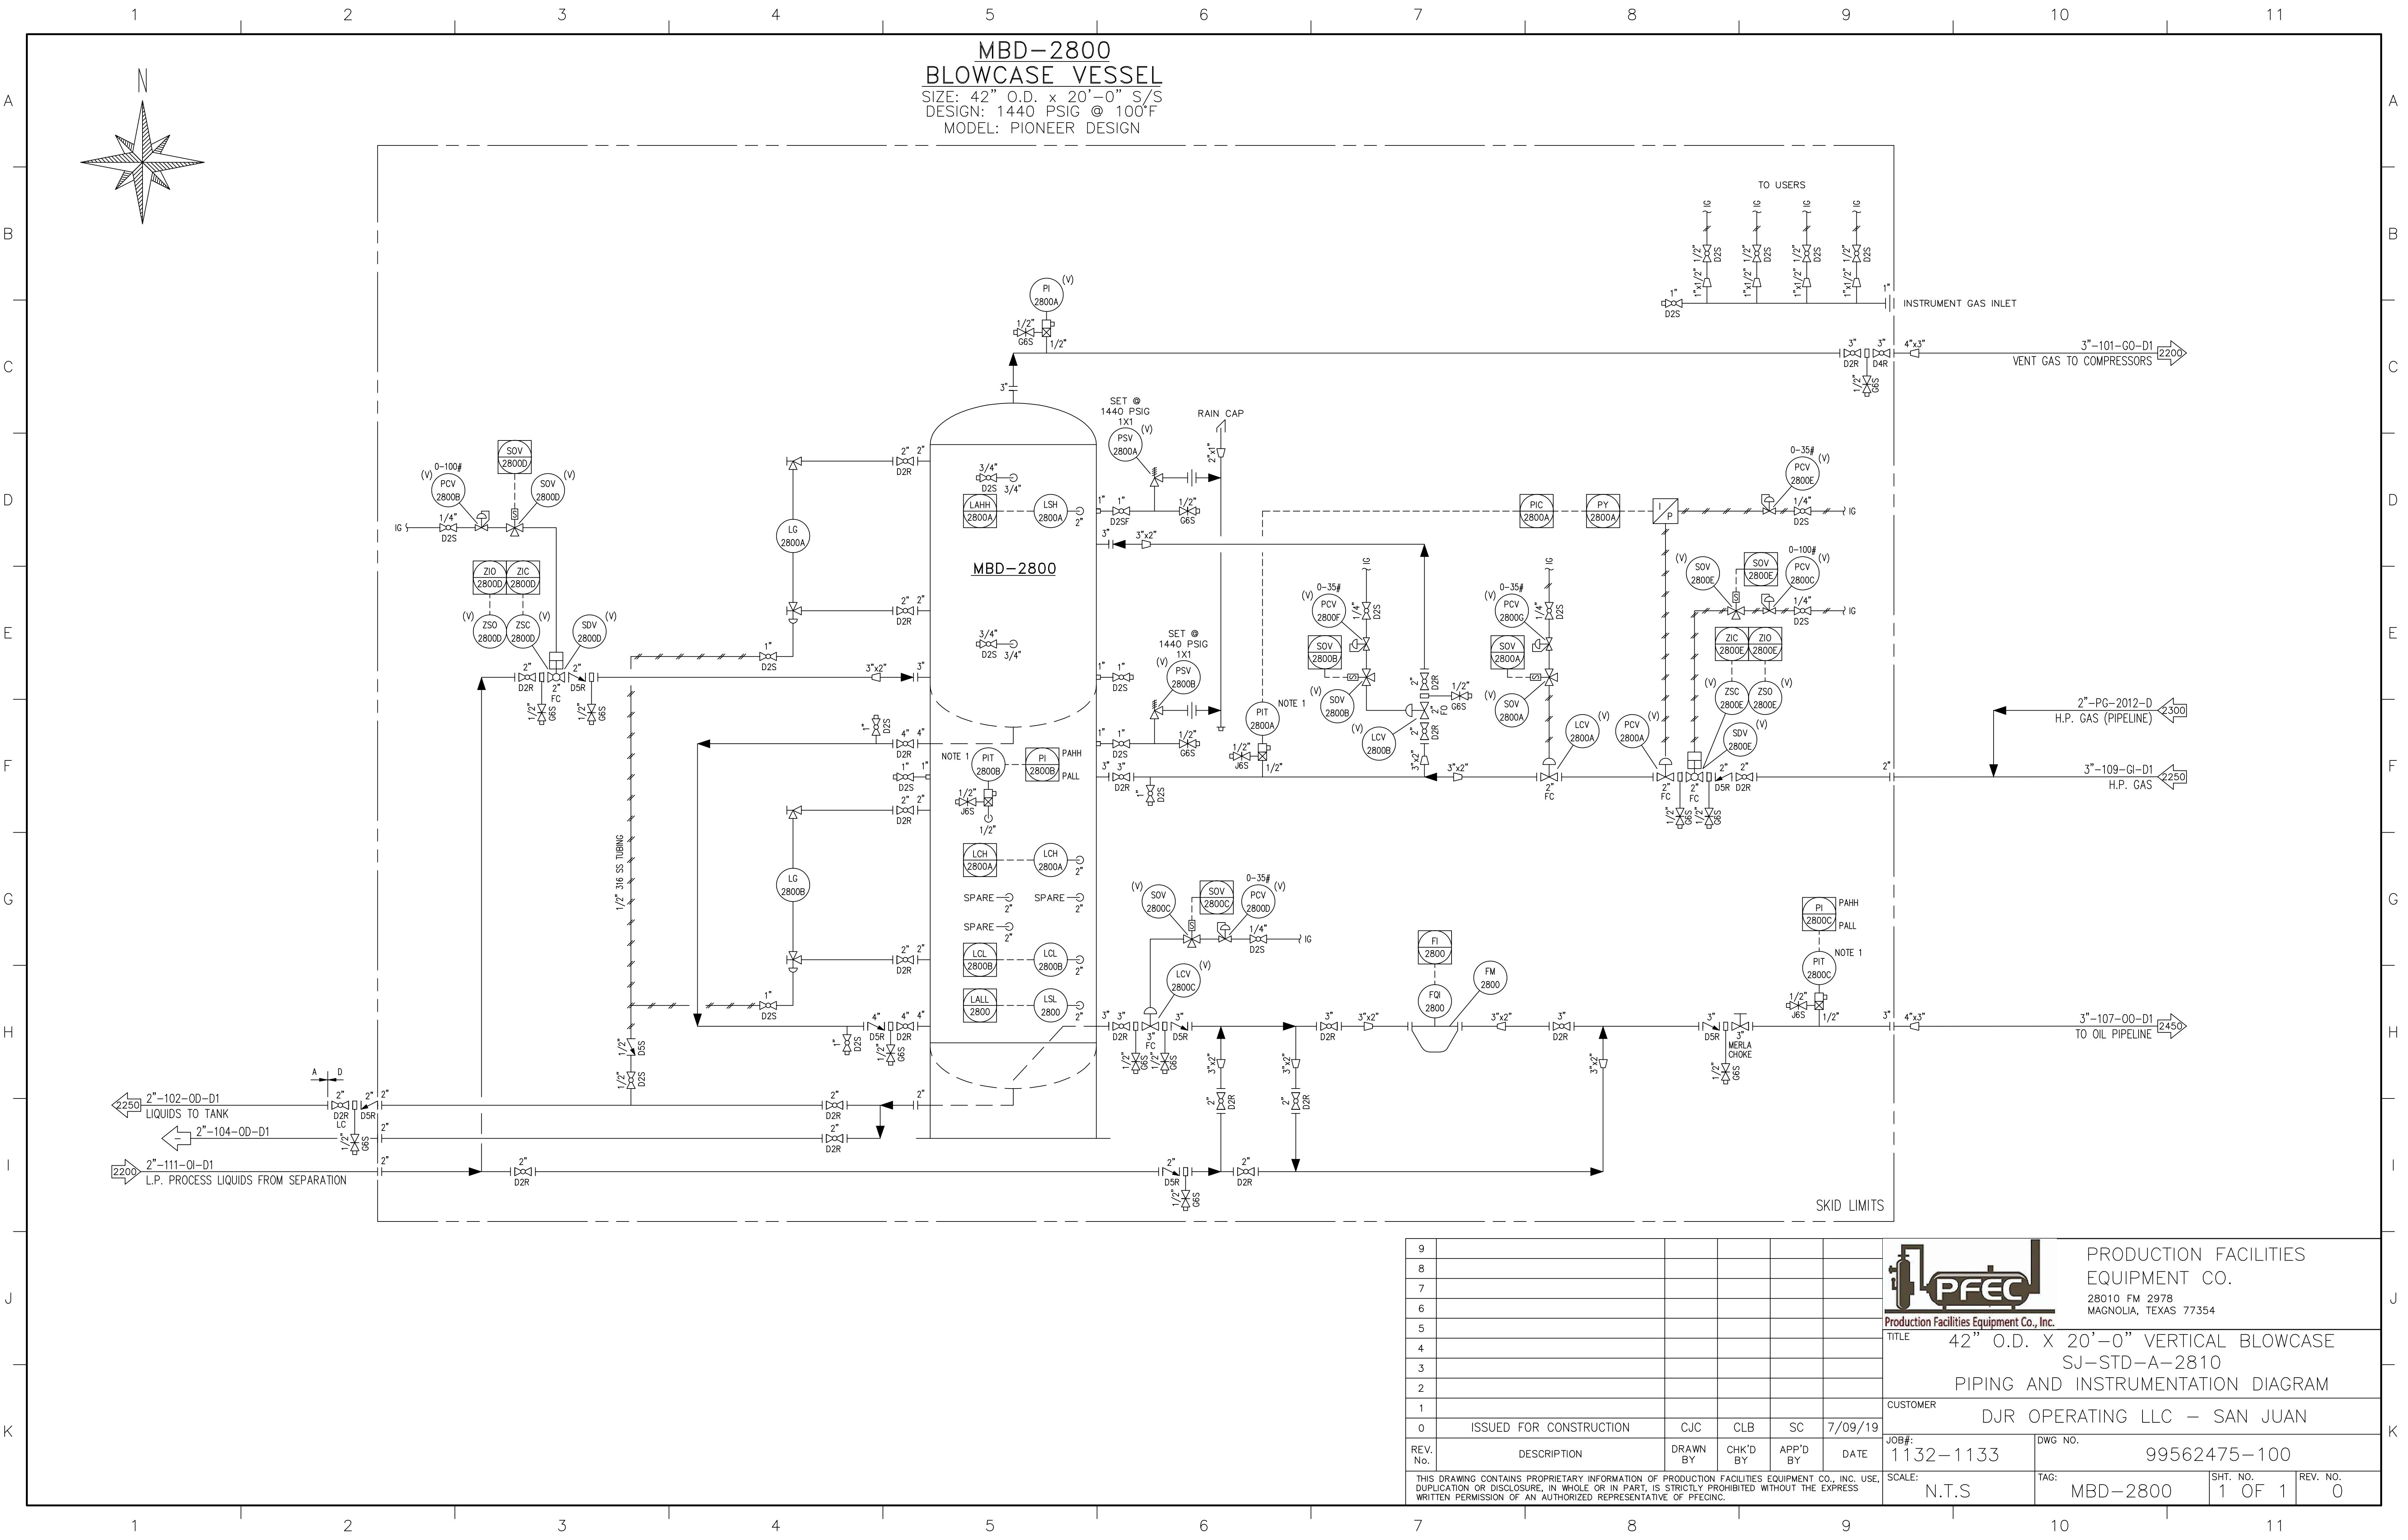

9					
8					
7					
6					
5					
4					
3					
2					
1					
0	ISSUED FOR CONSTRUCTION	CJC	CLB	SC	7/09/19
REV. No.	DESCRIPTION	DRAWN BY	CHK'D BY	APP'D BY	DATE
THIS DRAWING CONTAINS PROPRIETARY INFORMATION OF PRODUCTION FACILITIES EQUIPMENT CO., INC. USE, DUPLICATION OR DISCLOSURE, IN WHOLE OR IN PART, IS STRICTLY PROHIBITED WITHOUT THE EXPRESS WRITTEN PERMISSION OF AN AUTHORIZED REPRESENTATIVE OF PFEC INC.					



PRODUCTION FACILITIES
EQUIPMENT CO.
28010 FM 2978
MAGNOLIA, TEXAS 77354

TITLE 42" O.D. X 20'-0" VERTICAL BLOWCASE SJ-STD-A-2810 PIPING AND INSTRUMENTATION DIAGRAM			
CUSTOMER DJR OPERATING LLC – SAN JUAN			
JOB#: 1132-1133	DWG. NO. 99562475-100		
SCALE: N.T.S	TAG: MBD-2800	SHT. NO. 1 OF 1	REV. NO. 0