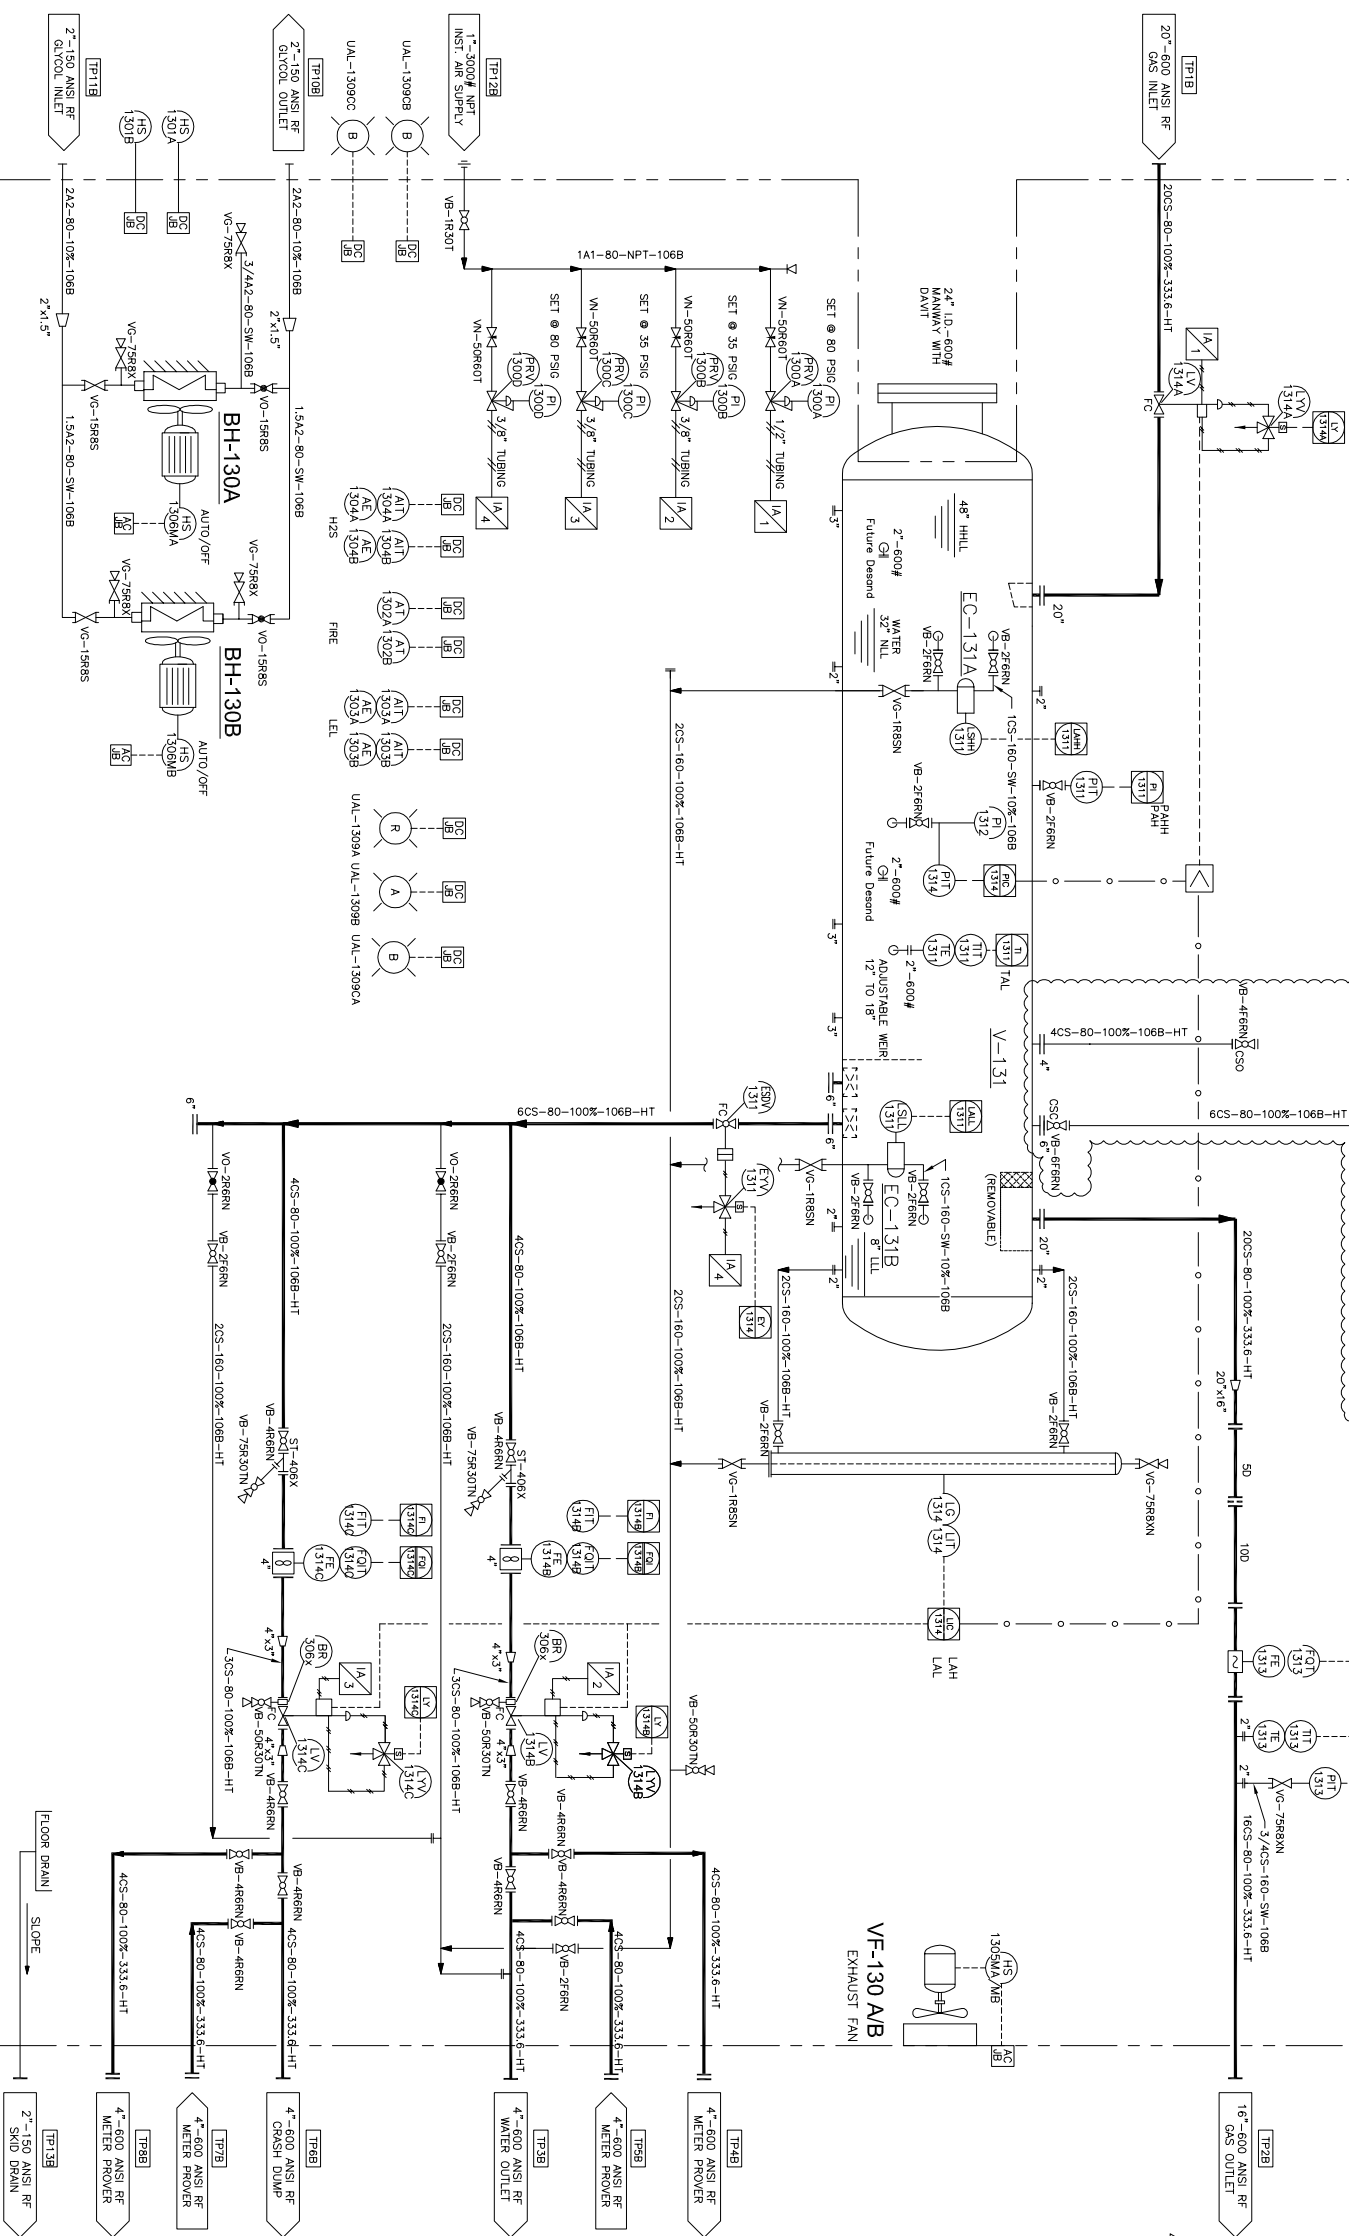
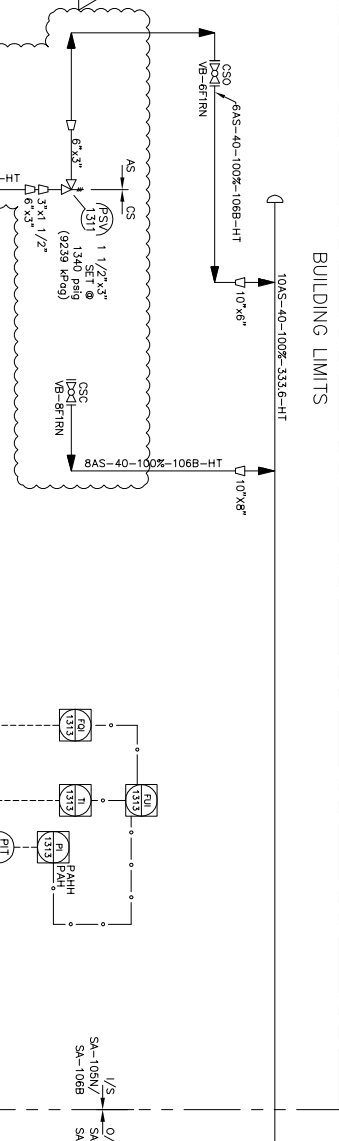
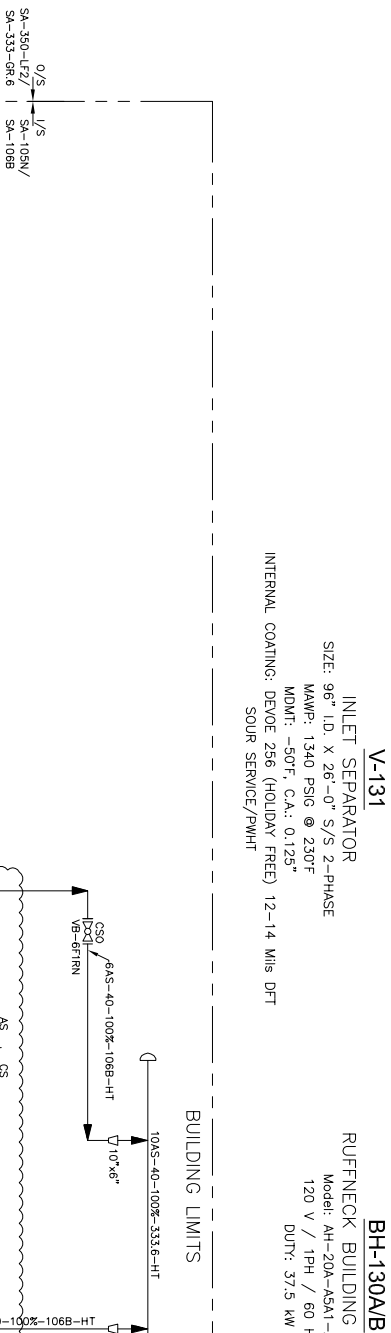


[illegible]

GENERAL NOTES:

1. No of Units req'd: One (1)
2. Materials shown for one Unit only
3. Welded piping to be: See Line Specs. on P&ID
4. All Threaded Piping to be: See Table below
5. All Welded Fittings to be: See Line Specs. on P&ID
6. All Forged Steel fittings to be: See Table below
7. Unit to be designed / pressure tested as follows:

7. Unit to be designed / pressure tested as follows:

SPEC.	SERVICE	DESIGN	NPT PIPING	F.S. FITTINGS	STRESS RELIEF	PRESSURE TEST @ ROOM TEMP.	C.A.
A1	SWEET	150 PSIG @ 150° F	SEE LINE SPEC.	SA-105N, 3000#	SEE LINE SPEC.	165 PSIG (AIRTEST)	0.0625"
A2	SWEET	245 PSIG @ 250° F	SEE LINE SPEC.	SA-105N, 3000#	SEE LINE SPEC.	360 PSIG (HYDROTEST)	0.0625"
AS	SOUR	275 PSIG @ 150° F	SEE LINE SPEC.	SA-105N, 3000#	SEE LINE SPEC.	410 PSIG (HYDROTEST)	0.125"
CS	SOUR	1340 PSIG @ 230° F	SEE LINE SPEC.	SA-105N, 6000#	SEE LINE SPEC.	2010 PSIG (HYDROTEST)	0.125"

* Use SA-350-LF2 for Low Temp F.S. Fittings & SA-



TAG #	MAMP	HYDROTEST @ ROOM TEMP.	STRESS RELIEF	C.A.
V-131	1340 PSIG @ 230° F	2010 PSIG	YES	0.125"
EC-131A	1629 PSIG @ 400° F	2444 PSIG	YES	0.125"

All Natural Gas bleeding type of instruments with bleed ports (including diaphragms & regulator bonnets)

- Sluice, Nuts & Gaskets Details:
- | SIZE | TUBE | WT | FITTINGS | FERROLES |
|------|------|--------|----------|----------|
| 3/8" | SS | 0.049" | SS | SS |
| 1/2" | SS | 0.049" | SS | SS |
- Sluice, Nuts & Gaskets Details:
- | SIZE | TUBE | WT | FITTINGS | FERROLES |
|------|------|--------|----------|----------|
| 3/8" | SS | 0.049" | SS | SS |
| 1/2" | SS | 0.049" | SS | SS |

SERVICE		SIZE		TUBE		WT		FITTINGS		FERROUS	
SOAR/ NACG/ TEMP	LOW TEMP. / REB.	ALL TUBING	3/8" 1/2"	SS	0.049"					SS	
STUDS, NUTS & GASKETS Details: Total piping volume is > 0.5 cuin.											
SERVICE		STUDS		NUTS		GASKETS					
		SA-193-B7M		SA-194-M		316SS		FLXMETALIC			

[illegible]

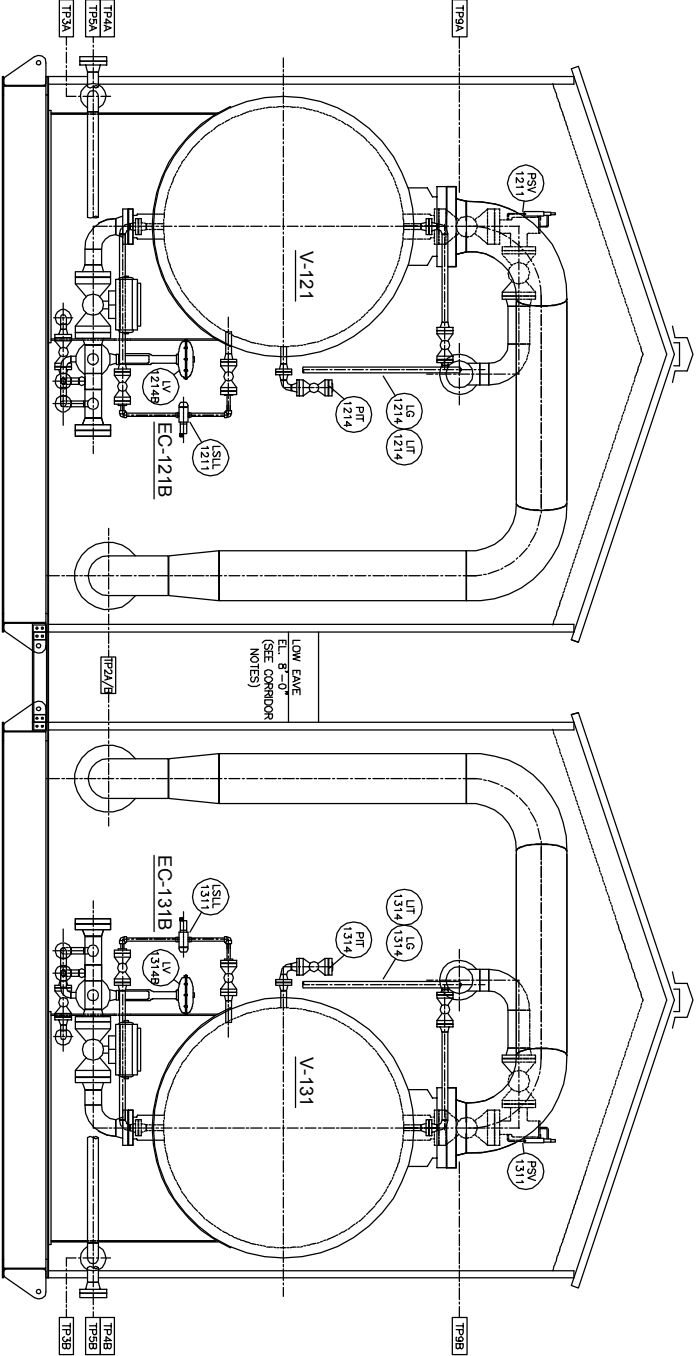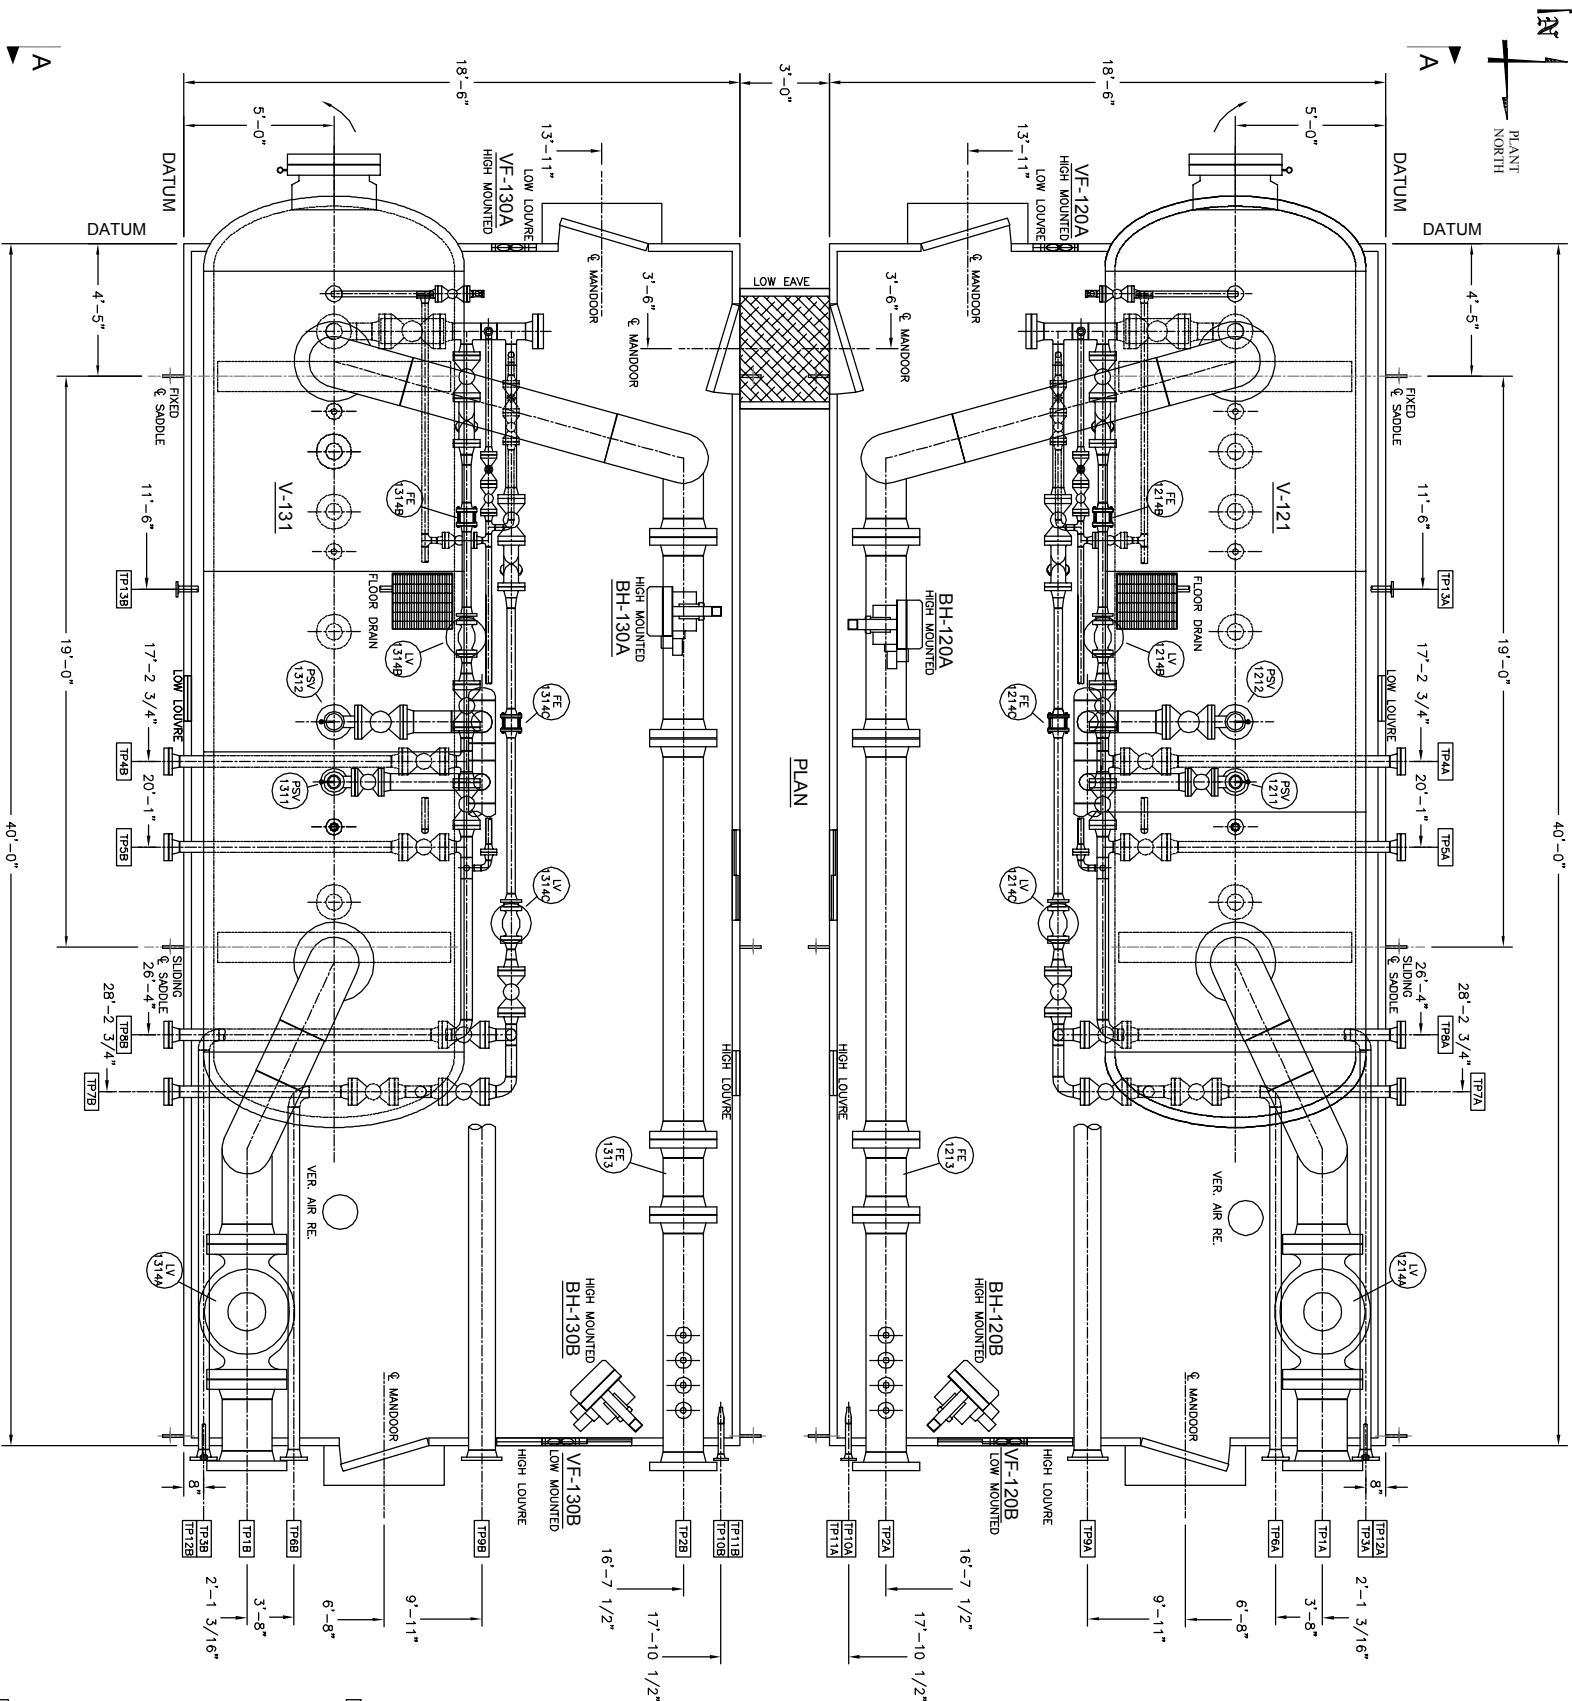

- GENERAL NOTES:
- No. of Units req'd: ONE (1)
 - Unit to be commercially sandblasted to SSPC-SP-6 and shop-primed with: ONE (1) coat ZINC PHOSPHATE
 - Finish Point: ONE (1) coat INDUSTRIAL ENAMEL (TAUPE)
 - Underskid Insulation: 2" Thk. Fire Retardant Industrial grade urethane foam on underside of floor within building limits.
 - Radiography on Piping welding to be: See Line Specs on P&ID
 - Unless specified otherwise, all projections beyond building wall to be: 6"
 - Dimensions may change to reflect customer requests, layout changes, accessibility and non-conformity of OEM supplied components.
 - Stress Relieving Details: See Line Specs on P&ID
 - Electrical Work: By Tarpon.

CORRIDOR NOTES:

4'-0" Wide x 3'-0" Long Field Constructed SELF FRAMING corridor with:

ROOF TYPE : SHED

ROOF PITCH: 4:12

EXTERIOR : 22 g. Pre-painted steel




INTERIOR : 24 g Aluminum (White)

INSULATION: R12 Batt type f/glass for Walls (R35 for roof)

VAPOR BARRIER: 6 MIL

VIEW A-A

THIS DRAWING IS THE PROPERTY OF OPSCO INDUSTRIES LTD. AND LOANED TO THE RECIPIENT FOR HIS CONFIDENTIAL USE ONLY. IN CONSIDERATION OF THE LOAN OF THIS DRAWING, THE RECIPIENT AGREES TO MAINTAIN THE DRAWING IN CONFIDENTIALITY AND TO RETURN IT TO OPSCO INDUSTRIES LTD. UPON REQUEST AND THAT IT SHALL NOT BE REPRODUCED, COPIED, OR USED FOR ANY PURPOSE OTHER THAN THAT INTENDED WITHOUT THE WRITTEN PERMISSION OF OPSCO INDUSTRIES LTD.																					
No.	DATE	REVISIONS			BY	CHK	REW	APP	No.	DATE	REVISIONS			BY	CHK	REW	APP	ENGINEERS RECORD			DATE
0	19/09/09	ISSUED FOR APPROVAL			J.C.													DRAWN BY Chandra Thambi			Oct. 19, 2009
1	20/09/09	ISSUED FOR CONSTRUCTION			J.C.													CHECKED BY			
																		REVIEWED BY			
																		APPROVED BY			
																		O.C. APPD.			

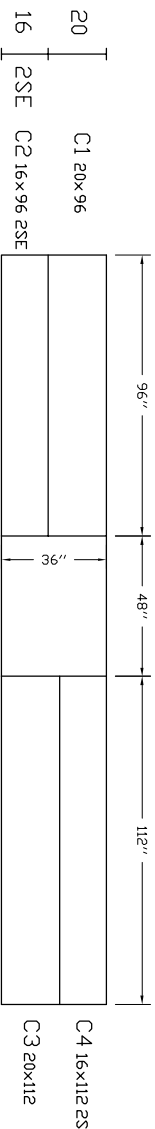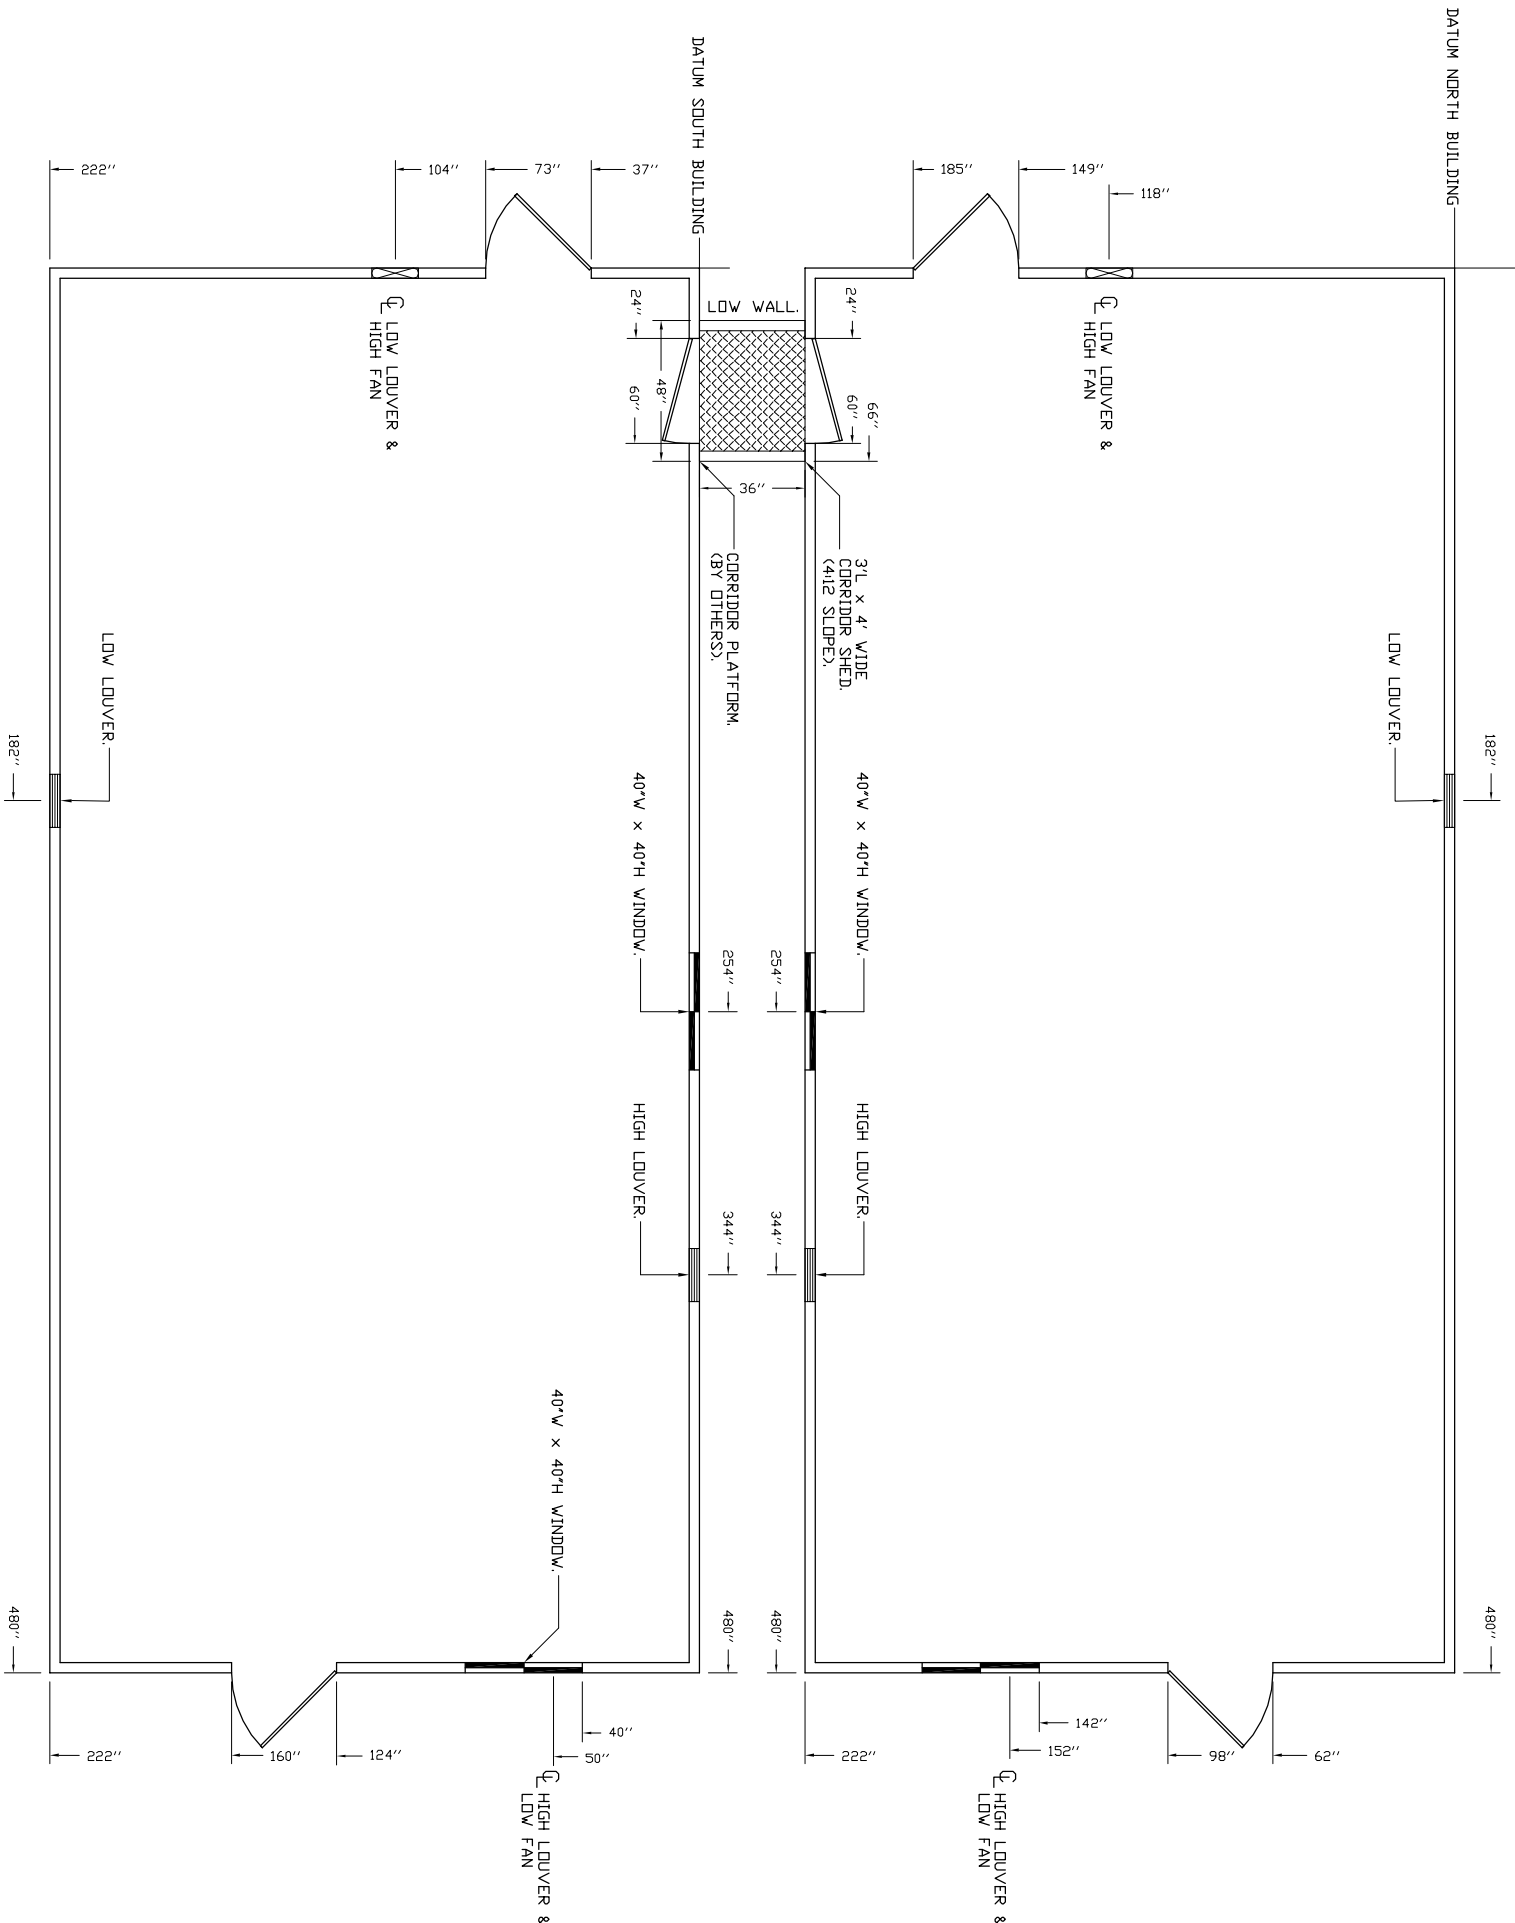 

PANEL LAYOUT,
CORRIDOR.

BUILDING COMPONENTS CORRIDOR									
1 @ 10' Bottom Channel									
1 @ 10' Top Channel (4:12 Slope)									
Wall Panels C1-C4, 181									
1 @ 20'x54' 100' Roof Panel									
1 @ 20'x54' 125' 100' Roof Panel									
10 @ 60'x30' 100' Roof Panel									
1 @ 42'x6' of 12" Insulation C1b (R36 Roof Insulation)									
1 @ 42'x6' of 12" Insulation C1b (R36 Roof Insulation)									
3 @ 3'x10' of White Flashed Aluminum Liner									
1 Box of R12 Insulation (120)									
1 @ 36" of Metal Brown Front Shed Flashing									
5 @ 10' of 100' Outside Gutter Flashing (Steel Outside Corners & Roof)									
1 @ 10' of 100' Outside Gutter Flashing (Steel Outside Corners & Roof)									
30 @ 100' 100' Screws (Climoseal)									
94 @ 100' 100' Screws (Climoseal)									
228 @ 100' 100' Screws (Climoseal)									
50 @ 100' 100' Screws (Climoseal)									
20 @ 100' 100' Screws (Climoseal)									
0.1 Roll of 60mil Poly Vapor Barrier									

CLIENT: ENSIGN-OPSCO MANUFACTURING

PROJECT: INLET 2-PHASE SEPARATOR PACKAGE

TITLE: PLAN VIEW 2 BUILDINGS & CORRIDOR

SIZE: W 18'6" L 40'0" H 17'0" 4.0:12

Sq. FT. W 1989' G 57' R 780' T 2826'

Perimeter 117'0" Weight 10,563 lb

Quote: 091002R1 Unit:

Drawn by: M.FORSBERG Date: NOV 20/09

Checked by: Date:

PAGE: 2 of 3 Date:

Job: 09-1765 Drawing: 09-1765

PLAN VIEW 2
BUILDINGS & CORRIDOR