


V-500 GLYCOL CONTACTOR SIZE: 914mm O.D. x 7925mm S/S D.P.: 9308 kPa @ 66°C M.A.W.P.: 9273 kPa @ 8 TRAYS TYPE: (2) PHASE V-570	E-510 GAS/GLYCOL EXCHANGER SIZE: 219mm O.D. (SCH.80) SHELL D.P.: 168mm O.D. (SCH.80) TUBING D.P.: 9308 kPa @ 66°C MFG: PECCO MODEL: SS-1-336	V-520 FUEL GAS SCRUBBER SIZE: 324mm O.D. x 991mm S/S D.P.: 1034 kPa @ 66°C MODEL: SMF-639 C.A.: 1.6mm	P-530A/B GLYCOL PUMP UNION SX-3 ELECTRIC PUMP D-500 DEHIDRATOR SKID LIMITS 3-R-A-5012	E-540 PARTICULATE FILTER MFG: PECCO MODEL: SS-1-336	H-580 CATADYNE HEATER 22,000 BTU, 120V START SIZE: 914mm O.D. x 4267mm LG DUTY: 75000 BTU/HR STILL/REFLUX COLUMN: 356mm O.D. x 2896mm LG	H-550 GLYCOL REGENERATOR B-570A/B AIR/GLYCOL EXCHANGER EXHAUST FAN 120V/1/60Hz
--	---	---	--	---	--	--

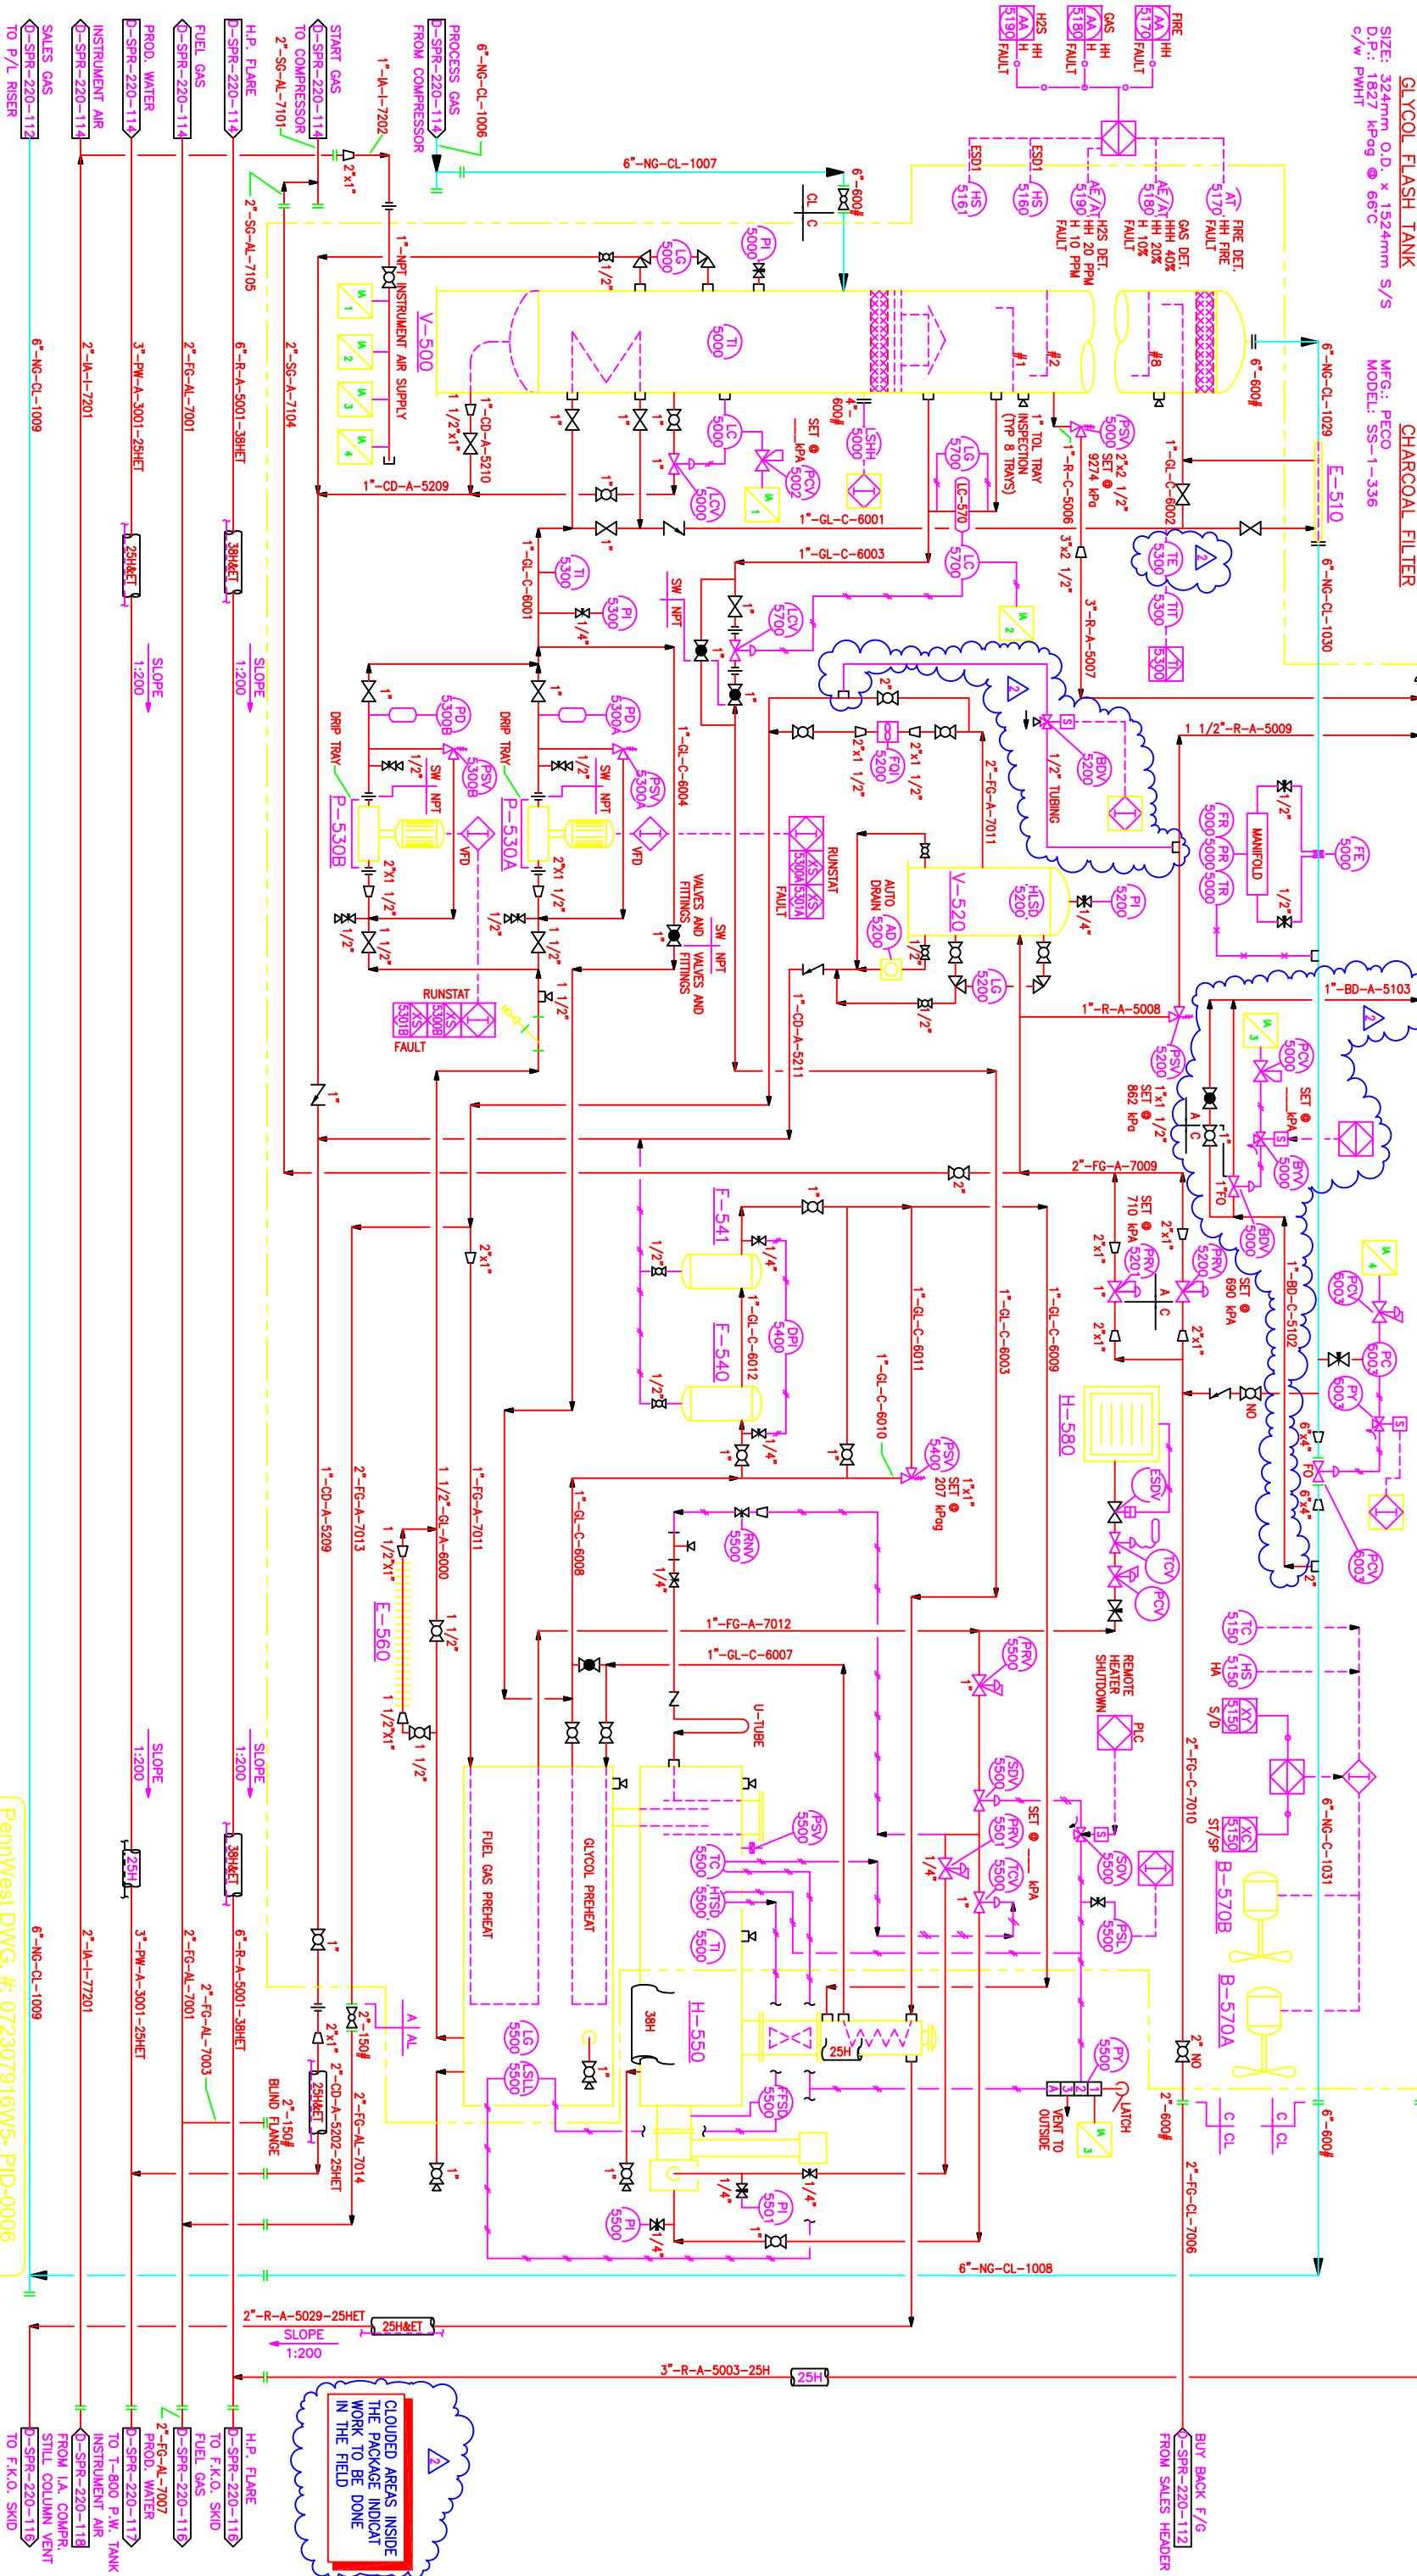

REFERENCE DRAWINGS		REVISIONS		NOTES:	
		CONSULTANTS LOGO		PERMIT	
		SEAL			

NUMBER	TITLE	NO.	BY	DATE	ISSUE	CHK'D
10-101	PLOT PLAN	A	AG	03.02.07	ISSUED FOR REVIEW	
20-101	PROCESS FLOW DIAGRAM	0	JGP	03.02.21	ISSUED FOR CONSTRUCTION	
30-101/107	PIPING PLANS	1	JGP	03.04.21	REVISED AS NOTED	
33-101/102	PIPING SECTIONS	2	AG	03.05.14	INDICATED WORK TO BE DONE IN THE FIELD	

1. VENT OUTSIDE TO A CATCH BUCKET.

							
CADFILE D-SPR-220-115.dwg						07-23-79-16 WSM	
						SPRINGBURN COMPRESSOR STATION	
						D-500 DEHYDRATION BUILDING	
						PROCESS AND INSTRUMENTATION DIAGRAM	
PROJ. NO.	DRAWN BY	CHECKED BY	APPROVED BY	DATE	SCALE	PWP PROJ. NO.	DRAWING NO.
						D-SPR-220-115	2
		</					