

03-248 motivRCS-204 COMPRESSOR CONTROL PANEL

ELECTRICAL DRAWINGS



PROJECT No. 70081

2004

REGISTERED COPY
ISSUED FOR REVIEW

ISSUED TO: Long To
COMPANY: Bidell Equipment, Inc.
DATE ISSUED: 05 MAY 2004
ISSUING DEPT.: MOTIV SYSTEMS, INC.

THIS DOCUMENT CONTAINS PROPRIETARY INFORMATION
AND MAY NOT BE REPRODUCED OR DISTRIBUTED TO
ANY OTHER PARTIES IN WHOLE OR IN PART. THIS
DOCUMENT IS NOT TO BE USED FOR INSPECTION,
MANUFACTURE, OR ACCEPTANCE OF PRODUCTS. THIS
DOCUMENT MUST BE RETURNED TO THE ISSUING
DEPARTMENT FOR OFFICIAL DISPOSAL OR REISSUE.

DRAWING LIST

[illegible]

This drawing and its design are the exclusive property of Motiv and shall not be disclosed or reproduced in any manner without the permission of Motiv. Motiv assumes no liability to any other party for any representations contained in this drawing.

REGISTERED COPY
ISSUED FOR REVIEW

ISSUED TO: Long Ta
COMPANY: Bidell Equipment Inc.
DATE ISSUED: 05 MAY 2004
ISSUING DEPT.: MOTIV SYSTEMS INC.

THIS DOCUMENT CONTAINS PROPRIETARY INFORMATION
AND MAY NOT BE REPRODUCED OR DISTRIBUTED TO
ANY OTHER PARTIES IN WHOLE OR IN PART. THIS
DOCUMENT IS NOT TO BE USED FOR INSPECTION,
MANUFACTURE, OR ACCEPTANCE OF PRODUCTS. THIS
DOCUMENT MUST BE RETURNED TO THE ISSUING
DEPARTMENT FOR OFFICIAL DISPOSAL OR REISSUE.

A	04.05.05	ISSUED FOR REVIEW				JZH	D8G	D8C	LT	LT
REV	DATE	REVISION DESCRIPTION				BY	DSGN	CHKD	APPD	CLNT

motiv™
www.motiv-systems.com


CALGARY, ALBERTA, CANADA, PHONE: (403) 265-0955, FAX: (403) 265-0966

CONTROL PANEL DRAWING LIST

DRAWN: S. YUN		DATE: 03.01.07		CUST./PROJ.: BIDE/L/03-248	
DESIGNED: B. EBELHER		DATE: 03.01.08		DESCRIPTION: motivRCS-204	
CHECKED: B. EBELHER		DATE: 03.01.08		TYPE:	
DRAWING NUMBER: 70081-E00000				SHEET: 1 OF 1	
				SCALE: NTS	
				REV: A	

	BUS--BAR
	EXPOSED CONDUIT, OR CABLE, OR CONDUCTOR
	PANEL WIRING (UNLESS OTHERWISE NOTED)
	FIELD WIRING, UNDERGROUND, UNDERSLAB, OR CONCEALED CONDUIT OR CABLE
	EQUIPMENT OUTLINE, OR HEAT TRACING LINE, OR GROUNDING CONDUCTOR
	SWITCHED HOT WIRE
	HOT WIRE
	NEUTRAL WIRE
	CONDUIT TURNING UP
	CONDUIT TURNING DOWN
	LINE BREAK or CONTINUATION LINE
	SPARE, COILED & TAPED
	CONDUIT FITTING
	CONDUIT BREATHER / DRAIN
	CONDUIT SEAL
	CONDUIT DRAIN SEAL
	CONDUIT CAP
	CONDUIT UNION
	CONDUIT EXPANSION JOINT
	FLEXIBLE CONNECTION

	ELECTRIC MOTOR C/W KW or HP RATING
	UNFUSED DISCONNECT SWITCH
	FUSED DISCONNECT SWITCH or FUSED ISOLATED SWITCH
	LOAD INTERRUPT NON-ISOLATING
	TRANSFER SWITCH
	CIRCUIT BREAKER
	FUSE
	DISCONNECT DEVICE (DRAW-OUT, STAB, PLUG-IN)
	THERMAL OVERLOAD DEVICE
	MAGNETIC OVERLOAD DEVICE
	CONTACTOR C/W EEMAC SIZE
	SURGE SUPPRESSOR
	THERMISTOR
	3 PHASE GENERATOR
	KEY INTERLOCK
	CABLE TERMINATION
	WEATHERHEAD
	PILOT LIGHT WHERE X: R = RED, G = GREEN, ETC.
	DELTA
	WYE or STAR
	DISCONNECT SWITCH

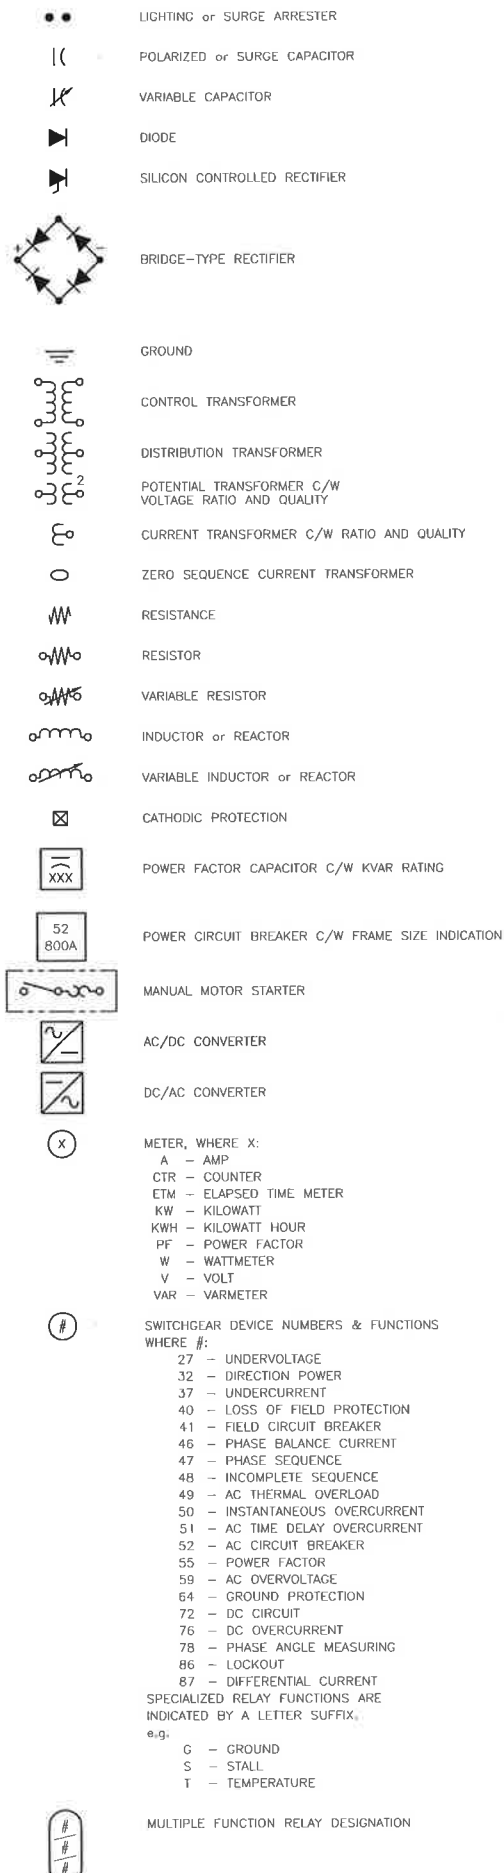

	FLOW SWITCH (NORMALLY OPEN)
	FLOW SWITCH (NORMALLY CLOSE)
	LIMIT SWITCH (NORMALLY OPEN)
	LIMIT SWITCH (NORMALLY CLOSE)
	LEVEL SWITCH (NORMALLY OPEN)
	LEVEL SWITCH (NORMALLY CLOSE)
	PRESSURE SWITCH (NORMALLY OPEN)
	PRESSURE SWITCH (NORMALLY CLOSE)
	TEMPERATURE SWITCH (NORMALLY OPEN)
	TEMPERATURE SWITCH (NORMALLY CLOSE)
	VIBRATION SWITCH (NORMALLY OPEN)
	VIBRATION SWITCH (NORMALLY CLOSE)
	TDCE NORMALLY OPEN (TIME DELAY CLOSE ON ENERGIZATION)
	TDCE NORMALLY CLOSED (TIME DELAY OPEN ON ENERGIZATION)
	TDODE NORMALLY OPEN (TIME DELAY CLOSE ON DE-ENERGIZATION)
	TDODE NORMALLY CLOSED (TIME DELAY CLOSES ON DE-ENERGIZATION)
	PLC INPUT CONTACT
	PLC OUTPUT CONTACT
	FORM "C" CONTACTS
	OVERLOAD'S
	SOLENOID (VALVES ETC.)
	COIL
	TORQUE SWITCH (NORMALLY OPEN)
	TORQUE SWITCH (NORMALLY CLOSE)
	SPST SWITCH (SINGLE POLE SINGLE THROW)
	SPDT SWITCH (SINGLE POLE DOUBLE THROW)
	N.O. PUSHBUTTON WITH SPRING RETURN TO OPEN POSITION
	N.C. PUSHBUTTON WITH SPRING RETURN TO CLOSE POSITION
	PUSHBUTTON WITH N.O. & N.C. CONTACTS WITH SPRING RETURN
	RELAY COIL
	CONTACTOR COIL
	MOTOR CONTROL RELAY COIL
	TIME-DELAY RELAY COIL
	GENERAL RELAY COIL
	NORMALLY OPEN CONTACT
	NORMALLY CLOSE CONTACT

SWITCH FUNCTION		DESCRIPTOR, PLACED BELOW SWITCH SYMBOL:
1ST LETTER	-	"C" (CLOSE) or "O" (OPEN)
2ND LETTER	-	"O" (ON)
3RD LETTER	-	"H" (HIGH) or "L" (LOW) OPTIONAL
4TH LETTER	-	VARIABLE, e.g., "L" (LEVEL), "P" (PRESSURE), ETC.

TD0E	-	TIME DELAY ON ENERGIZE	} USED IN CONJUNCTION WITH COIL
TD0E	-	TIME DELAY ON DE-ENERGIZE	
T.O.	-	TIME TO OPEN	} USED IN CONJUNCTION WITH CONTACTS
T.C.	-	TIME TO CLOSE	
INST.	-	INSTANTANEOUS	
XXX	-	REFERS TO THE SCHEMATIC GRID THE RELAY IS ON	
*	-	USER DEFINED (R-RELAY, C-CONTACT, ETC.)	

X WHERE X:

- A = START-STOP
- B = ON-OFF
- C = FAST-SLOW OR FAST-SLOW-STOP
- D = HAND-OFF-AUTO
- F = FORWARD
- R = REVERSE
- S = ALL OTHERS (SEE BILL OF MATERIAL)
- AS = AMMETER SWITCH
- KI = KEY INTERLOCK
- SP = STOP SWITCH
- ST = START SWITCH
- VS = VOLTMETER SWITCH
- VSD = VARIABLE SPEED DRIVE

☐

MANUAL DISCONNECT

WHERE X:

FSR - FORWARD-STOP-REVERSE
FSS - FAST-SLOW-STOP
HOA - HAND-OFF-AUTO SWITCH
HTR - HEATER
LOS - LOCKOUT-STOP
O/O - ON-OFF
RES - RESISTOR
RTO - RESISTANCE-TEMP. DETECTOR
S/S - START-STOP SWITCH
TH - THERMISTOR


	CONTROL PANEL (FEED TERMINAL)
	CONTROL PANEL (DISCONNECT TERMINAL)
	CONTROL PANEL (NON-INCENDIVE BARRIER)
	VENDOR
	MCC (MOTOR CONTROL CENTRE)
	SKID JUNCTION BOX TERMINAL
	FIELD JUNCTION BOX TERMINAL
	BUS-BAR CONNECTION
	WIRE CONNECTION
	GROUND CONNECTION WELDED, BRAZED OR COMPRESSION TYPE
	GROUND ROD W/O WELL BOLTED OR CLAMPED
	GROUND ROD C/W WELL

	SINGLE RECEPTACLE
	DUAL RECEPTACLE
	SPLIT RECEPTACLE
	GROUND FAULT RECEPTACLE
	SPECIAL RECEPTACLE
	TELEPHONE OUTLET
	TELEPHONE JACK
	THERMOSTAT

SWITCHES, WHERE X:

- 1 - SINGLE-POLE SWITCH
- 2 - DOUBLE-POLE SWITCH
- 3 - THREE-WAY SWITCH
- 4 - FOUR-WAY SWITCH
- K - KEY-OPERATED SWITCH

	LIGHTING FIXTURE, TYPE "X" (PENDANT/CEILING MOUNTED)
	LIGHTING FIXTURE, TYPE "X" (WALL MOUNTED)
	BEACON LIGHT (TYPE "X")
	STROBE LIGHT (TYPE "X")
	EXIT LIGHT

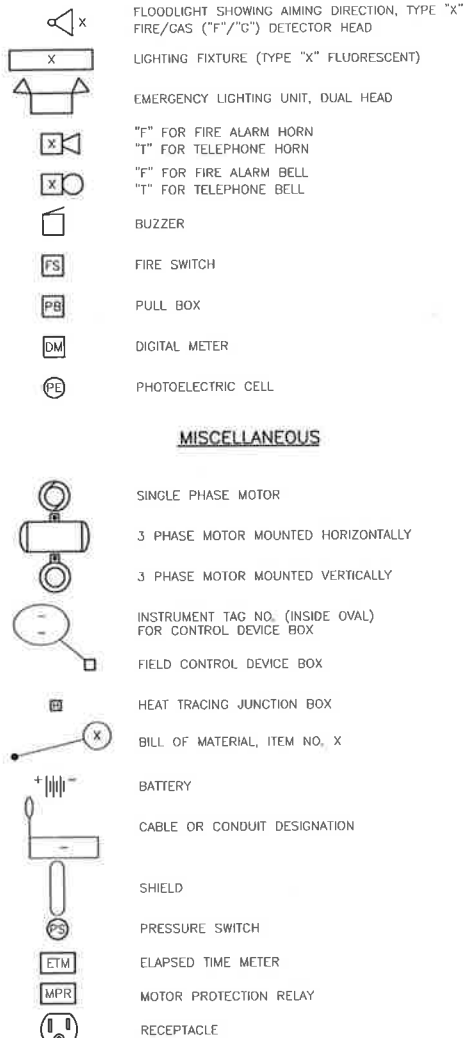

REGISTERED COPY
ISSUED FOR REVIEW

ISSUED TO: Long Ta
COMPANY: Bidell Equipment Inc.
DATE ISSUED: 05 MAY 2004
ISSUING DEPT.: MOTIV SYSTEMS INC.

THIS DOCUMENT CONTAINS PROPRIETARY INFORMATION
AND MAY NOT BE REPRODUCED OR DISTRIBUTED TO
ANY OTHER PARTIES IN WHOLE OR IN PART. THIS
DOCUMENT IS NOT TO BE USED FOR INSPECTION,
MANUFACTURE, OR ACCEPTANCE OF PRODUCTS. THIS
DOCUMENT MUST BE RETURNED TO THE ISSUING
DEPARTMENT FOR OFFICIAL DISPOSAL OR REISSUE.


A	04.05.05	ISSUED FOR REVIEW	JZH	DBG	DBG		LT		
REV	DATE	REVISION DESCRIPTION	BY	DSON	CHKD	APPD	CLEN		



CALGARY, ALBERTA, CANADA, PHONE: (403) 265-0955, FAX: (403) 265-0966

CONTROL PANEL ELECTRICAL STANDARD SYMBOLS

DRAWN: S. YUN	DATE: 03.01.07	CUST./PROJ: BIDELL/03-248
DESIGNED: B. EBELHER	DATE: 03.01.08	DESCRIPTION: motivRCS-204
CHECKED: B. EBELHER	DATE: 03.01.08	TYPE:
DRAWING NUMBER: 70081-E00001	SHEET: 1 OF 1	SCALE: NTS

 

- ## NOTES:
1. ALL COMPONENTS AND WORKMANSHIP MUST MEET CLASS I, ZONE 2, GROUP C & D SPECIFICATIONS.
 2. ALL WIRING TO BE TINNED AND NACE COMPLIANT.
 3. ALL WIRING SHALL BE ARRANGED (DRIP LOOP) AS TO REDUCE ANY UNDUE STRESS TO TERMINATION POINTS.
 4. ALL NON-INCUVATIVE WIRING SHALL COMPLY TO CANADIAN ELECTRICAL CODE APPENDIX F.
 5. PANEL TO BE MOUNTED WITH VIBRATION ISOLATORS AND BONDED TO GROUND.
 6. ALL CONDUIT ENTRIES SHALL BE FLEXIBLE WHERE POSSIBLE TO REDUCE VIBRATIONS.
 7. ALL COMPONENTS AND TERMINATIONS MUST BE CHECKED FOR VIBRATION EFFECTS AND DAMAGE DUE TO SHIPPING.
 8. CABINET MUST BE GROUNDED.

REGISTERED COPY
ISSUED FOR REVIEW

ISSUED TO: Long Ta
COMPANY: Bidell Equipment Inc.
DATE ISSUED: 05 MAY 2004
ISSUING DEPT.: MOTIV SYSTEMS INC.

THIS DOCUMENT CONTAINS PROPRIETARY INFORMATION
AND MAY NOT BE REPRODUCED OR DISTRIBUTED TO
ANY OTHER PARTIES IN WHOLE OR IN PART. THIS
DOCUMENT IS NOT TO BE USED FOR INSPECTION,
MANUFACTURE, OR ACCEPTANCE OF PRODUCTS. THIS
DOCUMENT MUST BE RETURNED TO THE ISSUING
DEPARTMENT FOR OFFICIAL DISPOSAL OR REISSUE.

[illegible]

motiv
Photo: motivation.com


CALGARY, ALBERTA, CANADA. PHONE: (403) 265-0955. FAX: (403) 265-0968

CONTROL PANEL
ENCLOSURE
GENERAL ASSEMBLY


DRAWN: D. TVADAR	DATE: 03.01.07	CUST./PROJ.: BIDEOL/03-248
DESIGNED: B. EBELHER	DATE: 03.01.08	DESCRIPTION: motivRCS-204
CHECKED: B. EBELHER	DATE: 03.01.08	TYPE:
DRAWING NUMBER: 70081-E02100	SHEET: 1 OF 1	SCALE: 1:5

This drawing and its design are the exclusive property of Motiv and shall not be disclosed or reproduced in any matter without the permission of Motiv. Motiv assumes no liability to any other party for any representations contained in this drawing.


This drawing and its design are the exclusive property of Motiv and shall not be disclosed or reproduced in any matter without the permission of Motiv. Motiv assumes no liability to any other party for any representations contained in this drawing.

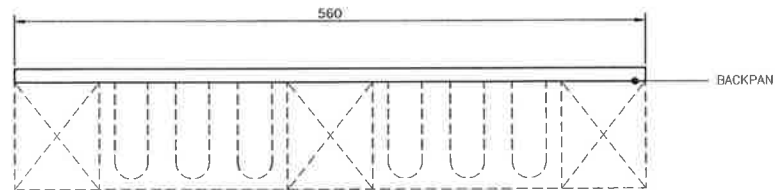

TOP VIEW

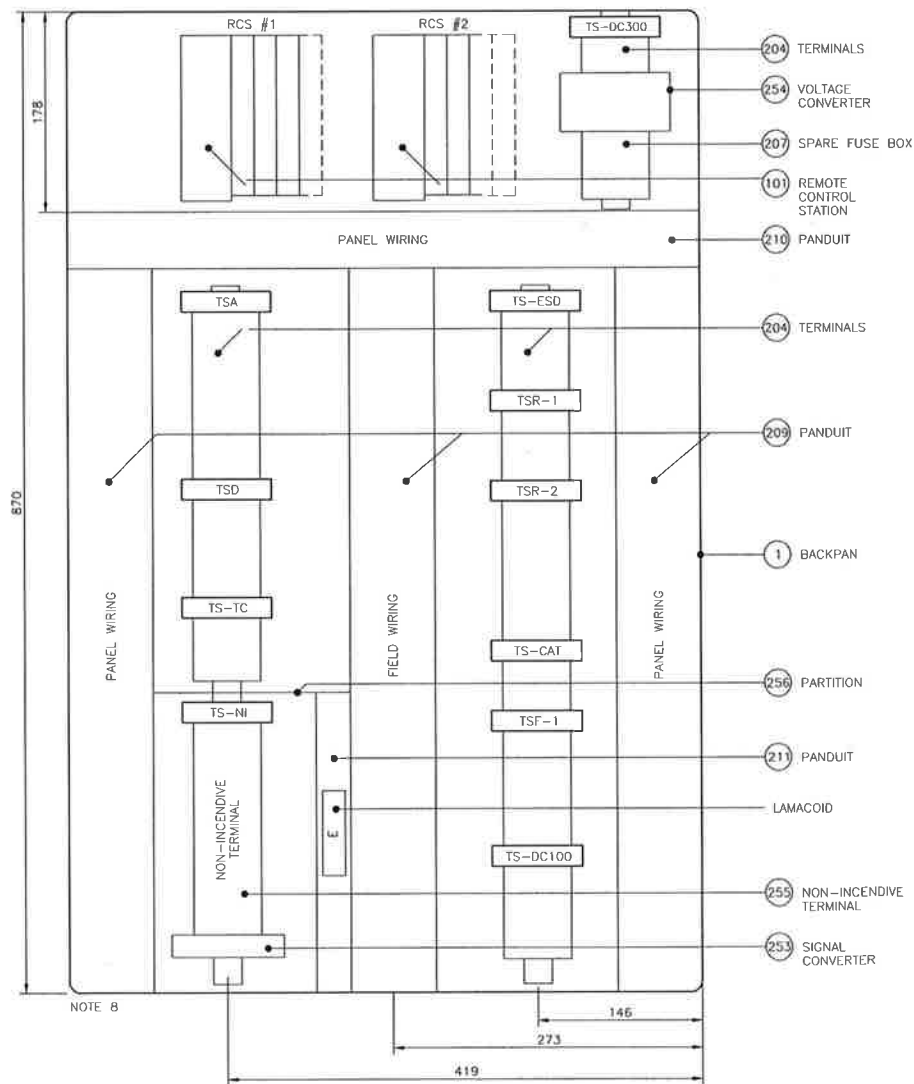

FRONT VIEW

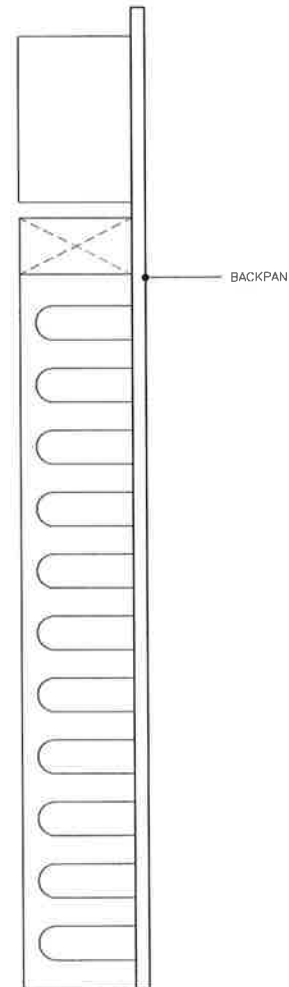

RIGHT SIDE VIEW

NOTES:

1. ALL COMPONENTS AND WORKMANSHIP MUST MEET CLASS I, ZONE 2, GROUP C & D SPECIFICATIONS.
2. ALL WIRING TO BE TINNED AND NACE COMPLIANT.
3. ALL WIRING SHALL BE ARRANGED (DRIP LOOP) AS TO REDUCE ANY UNDUE STRESS TO TERMINATION POINTS.
4. ALL NON-INCENDIVE WIRING SHALL COMPLY TO CANADIAN ELECTRICAL CODE APPENDIX F.
5. PANEL TO BE MOUNTED WITH VIBRATION ISOLATORS AND BONDED TO GROUND.
6. ALL CONDUIT ENTRIES SHALL BE FLEXIBLE WHERE POSSIBLE TO REDUCE VIBRATIONS.
7. ALL COMPONENTS AND TERMINATIONS MUST BE CHECKED FOR VIBRATION EFFECTS AND DAMAGE DUE TO SHIPPING.
8. CABINET MUST BE GROUNDED.

REGISTERED COPY
ISSUED FOR REVIEW

ISSUED TO: Long To
COMPANY: Bidell Equipment Inc.
DATE ISSUED: 05 MAY 2004
ISSUING DEPT.: MOTIV SYSTEMS INC.

THIS DOCUMENT CONTAINS PROPRIETARY INFORMATION AND MAY NOT BE REPRODUCED OR DISTRIBUTED TO ANY OTHER PARTIES IN WHOLE OR IN PART. THIS DOCUMENT IS NOT TO BE USED FOR INSPECTION, MANUFACTURE, OR ACCEPTANCE OF PRODUCTS. THIS DOCUMENT MUST BE RETURNED TO THE ISSUING DEPARTMENT FOR OFFICIAL DISPOSAL OR REISSUE.

REV	DATE	REVISION DESCRIPTION	BY	DSN	CHKD	APPD	CLNT
A	04.05.05	ISSUED FOR REVIEW	JZH	DBG	DBG	LT	LT

motiv
www.motivsystems.com


CALGARY, ALBERTA, CANADA, PHONE: (403) 265-0955, FAX: (403) 265-0966

CONTROL PANEL
BACKPAN
GENERAL ASSEMBLY

DRAWN: D. TIVADAR	DATE: 03.01.07	CUST./PROJ.: BIDELL/03-248
DESIGNED: B. EBELHER	DATE: 03.01.08	DESCRIPTION: motivRCS-204
CHECKED: B. EBELHER	DATE: 03.01.08	TYPE:
DRAWING NUMBER: 70081-E02200	SHEET: 1 OF 1	SCALE: 1:3
	REV: A	

This drawing and its design are the exclusive property of Motiv and shall not be disclosed or reproduced in any manner without the permission of Motiv. There is no liability for any error or omission in this drawing.


FROM LINE DC303
SEE DWG. NO.
E03300

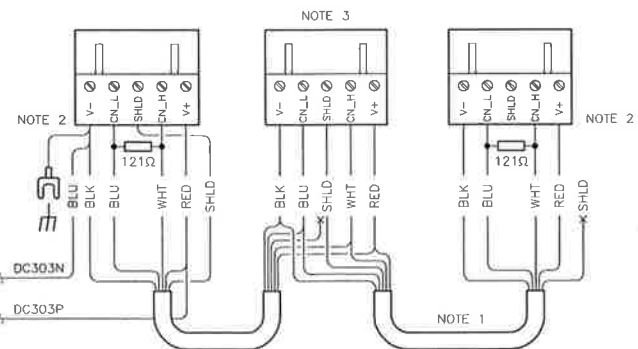

BUS COMMUNICATION CABLE

DETAIL 1
NTS

COMPRESSOR CONTROL PANEL

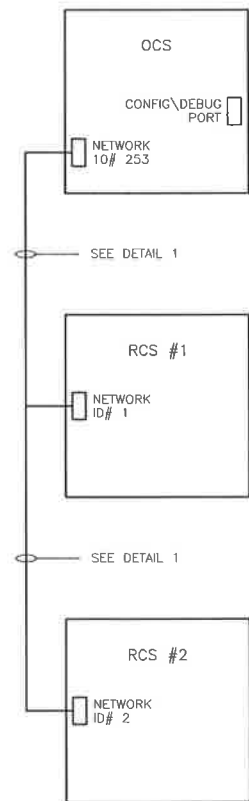

OVERALL LAYOUT

LEGEND:

- MOTIV CONTROL PANEL (FEED TERMINAL)
- MOTIV CONTROL PANEL (DISCONNECT TERMINAL)
- VENDOR TERMINAL
- MCC TERMINAL
- SKID JUNCTION BOX TERMINAL
- FIELD JUNCTION BOX TERMINAL
- FUSE TERMINAL
- CUSTOMER PANEL
- CUSTOMER JUNCTION BOX
- IN4934 DIODE
- PANEL/VENDOR WIRING
- FIELD WIRING
- MOTIV CONTROL PANEL DUAL LEVEL FEED THROUGH WDK 2,5
- MOTIV CONTROL PANEL NON INCENDIVE BARRIER
- MOTIV CONTROL PANEL DUAL LEVEL FUSED AND FEED THROUGH
- MOTIV CONTROL PANEL DUAL LEVEL FEED THROUGH WITH SHIELD

NOTES:

- BUS WIRING MUST BE BELDEN 3084A OR EQUIVALENT.
- BUS MUST BE TERMINATED AT BOTH ENDS WITH 121 OHMS, 1% TERMINATING RESISTORS.
- ONLY IF SECOND RCS IS REQUIRED.

REGISTERED COPY
ISSUED FOR REVIEW

ISSUED TO: Long Ta
COMPANY: Bidell Equipment Inc.
DATE ISSUED: 05 MAY 2004
ISSUING DEPT.: MOTIV SYSTEMS INC.

THIS DOCUMENT CONTAINS PROPRIETARY INFORMATION AND MAY NOT BE REPRODUCED OR DISTRIBUTED TO ANY OTHER PARTIES IN WHOLE OR IN PART. THIS DOCUMENT IS NOT TO BE USED FOR INSPECTION, MANUFACTURE, OR ACCEPTANCE OF PRODUCTS. THIS DOCUMENT MUST BE RETURNED TO THE ISSUING DEPARTMENT FOR OFFICIAL DISPOSAL OR REISSUE.



motiv
www.motivsystems.com


CALGARY, ALBERTA, CANADA, PHONE: (403) 265-0955, FAX: (403) 265-0966

CONTROL PANEL
COMMUNICATION
BLOCK DIAGRAM

DRAWN:	D. TIVADAR	DATE:	03.01.07	CUST./PROJ.:	BIDELL/03-248
DESIGNED:	B. EBELHER	DATE:	03.01.08	DESCRIPTION:	motivRCS-204
CHECKED:	B. EBELHER	DATE:	03.01.08	TYPE:	
DRAWING NUMBER:	70081-E02810				SHEET: 1 OF 1
					SCALE: NTS
					REV: A

 04-26-05-1 149mm/230

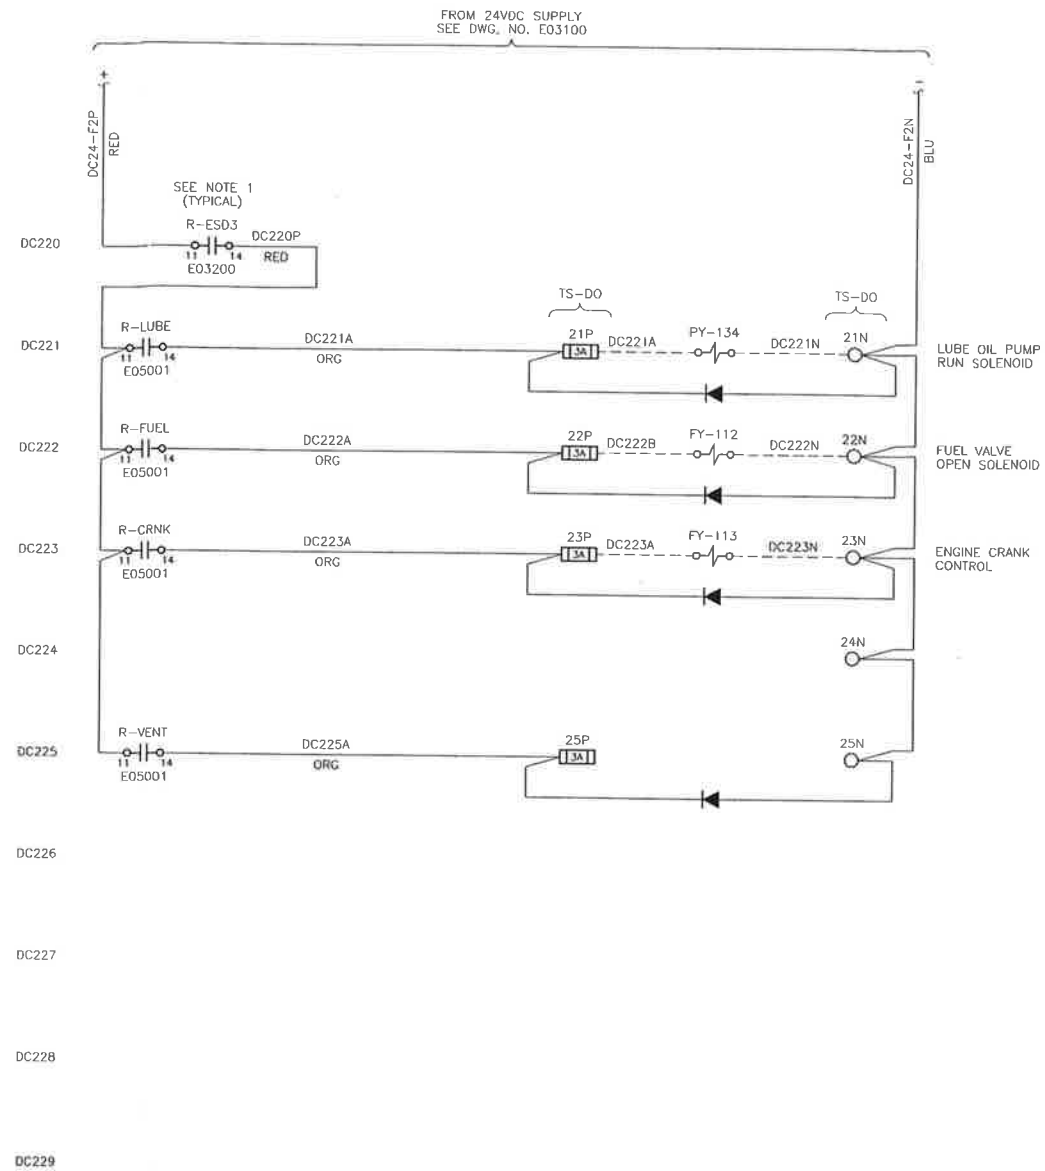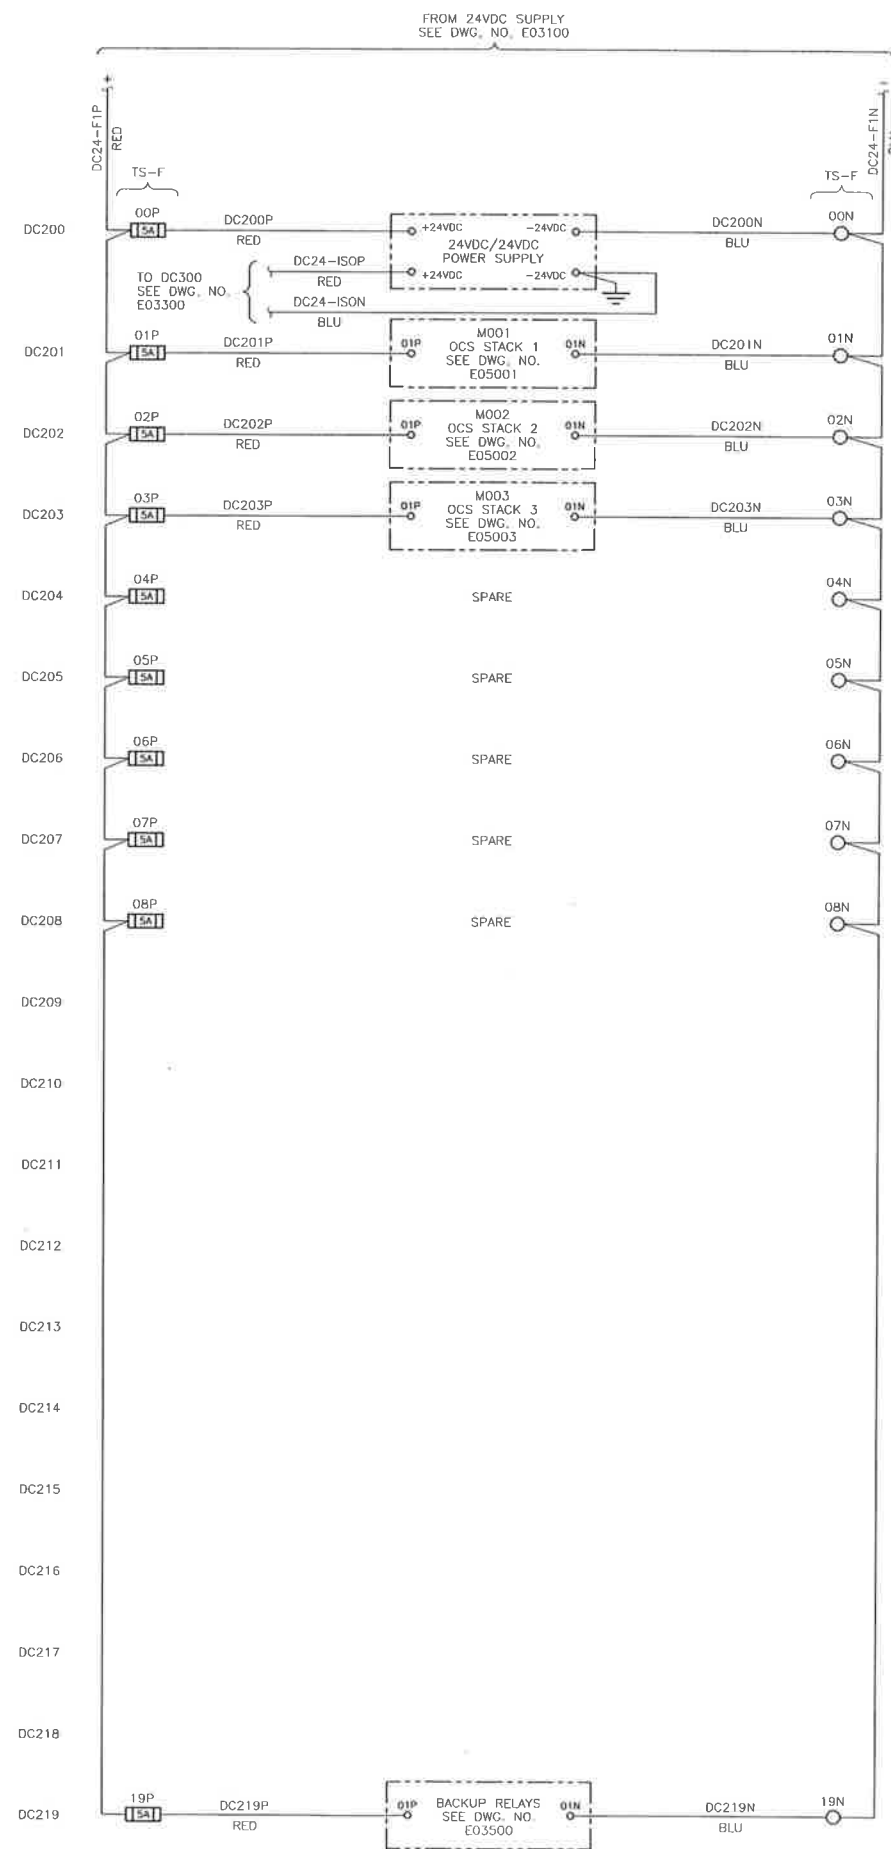



1. ALL FIELD WIRING TO BE WIRED FOR CLASS 1 ZONE 2, UNLESS SPECIFIED.
2. PANEL IS RATED FOR CLASS 1 ZONE 2.

REGISTERED COPY
ISSUED FOR REVIEW

ISSUED TO: Long Ta

COMPANY: Bidell Equipment Inc.

DATE ISSUED: 05 MAY 2004

ISSUING DEPT.: MOTIV SYSTEMS INC.

THIS DOCUMENT CONTAINS PROPRIETARY INFORMATION AND MAY NOT BE REPRODUCED OR DISTRIBUTED TO ANY OTHER PARTIES IN WHOLE OR IN PART. THIS DOCUMENT IS NOT TO BE USED FOR INSPECTION, MANUFACTURE, OR ACCEPTANCE OF PRODUCTS. THIS DOCUMENT MUST BE RETURNED TO THE ISSUING DEPARTMENT FOR OFFICIAL DISPOSAL OR REUSE.

A	04.05.05	ISSUED FOR REVIEW				JZH	DGC	DGC	LT	LT
REV	DATE	REVISION DESCRIPTION				BY	DSGN	CHKD	APPD	CLNT

motivTM
www.motivsystems.com


CALGARY, ALBERTA, CANADA. PHONE: (403) 265-0955, FAX: (403) 265-0966

CONTROL PANEL
ISOLATED 24VDC POWER DISTRIBUTION

DRAWN: D. TIVADAR	DATE: 03.01.07	CUST./PROJ.: BIDELL/03-248
DESIGNED: B. EBELHER	DATE: 03.01.08	DESCRIPTION: motivRCS-204
CHECKED: B. EBELHER	DATE: 03.01.08	TYPE:

DRAWING NUMBER	70081-E03300	SHEET	SCALE	REV
		1 OF 1	N.TS	A

This drawing and its design are the exclusive property of Motiv and shall not be duplicated or reproduced in any manner without the permission of Motiv. Motiv assumes no liability to any other party for any representations contained in this drawing.

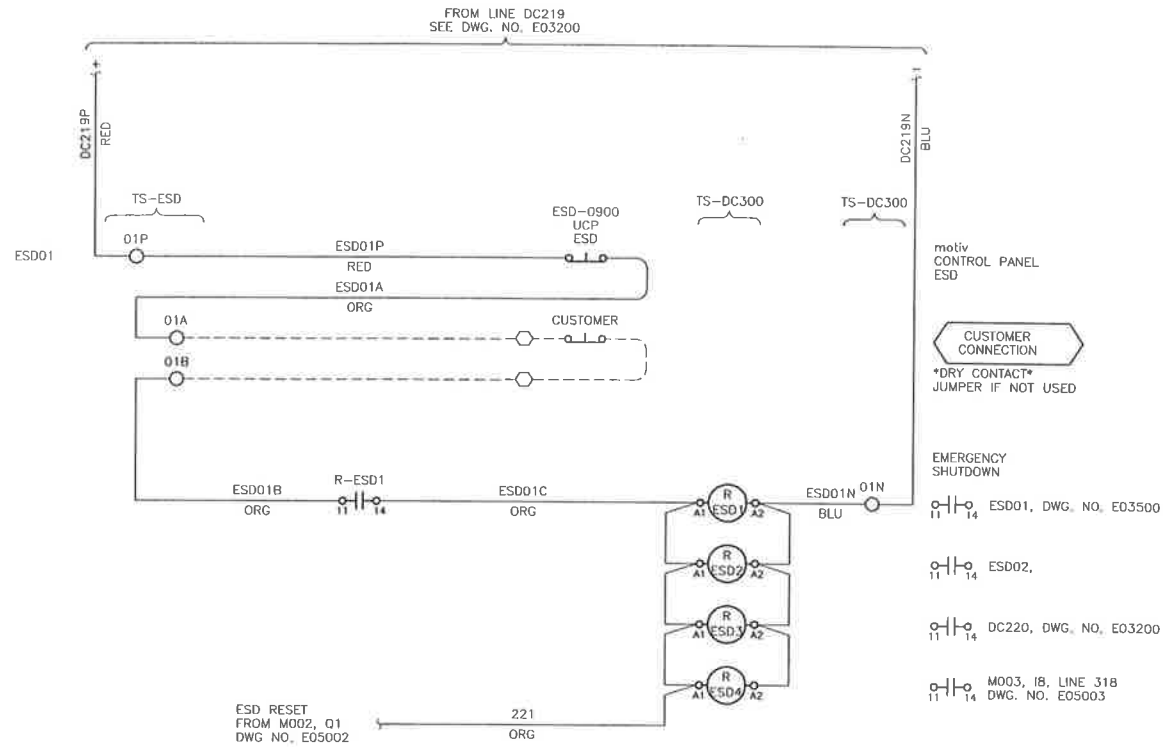

LEGEND:

- MOTIV CONTROL PANEL (FEED TERMINAL)
- ⊗ MOTIV CONTROL PANEL (DISCONNECT TERMINAL)
- VENDOR TERMINAL
- MCC TERMINAL
- ⊠ SKID JUNCTION BOX TERMINAL
- ⊡ FIELD JUNCTION BOX TERMINAL
- ⊞ FUSE TERMINAL
- CUSTOMER PANEL
- ⊗ CUSTOMER JUNCTION BOX
- ⊞ IN4934 DIODE
- PANEL/VENDOR WIRING
- - - - FIELD WIRING

REGISTERED COPY ISSUED FOR REVIEW

ISSUED TO: Long Ta
COMPANY: Bidell Equipment, Inc.
DATE ISSUED: 05 MAY 2004
ISSUING DEPT.: MOTIV SYSTEMS INC.

THIS DOCUMENT CONTAINS PROPRIETARY INFORMATION AND MAY NOT BE REPRODUCED OR DISTRIBUTED TO ANY OTHER PARTIES IN WHOLE OR IN PART. THIS DOCUMENT IS NOT TO BE USED FOR INSPECTION, MANUFACTURE, OR ACCEPTANCE OF PRODUCTS. THIS DOCUMENT MUST BE RETURNED TO THE ISSUING DEPARTMENT FOR OFFICIAL DISPOSAL OR REISSUE.

motiv
www.motivsystems.com



CALGARY, ALBERTA, CANADA, PHONE: (403) 265-0955, FAX: (403) 265-0966

CONTROL PANEL ESD BACK-UP RELAYS

DRAWN: D. TIVADAR DATE: 03.01.07 CUST./PROJ.: BIDELL/03-248
DESIGNED: B. EBELHER DATE: 03.01.08 DESCRIPTION: motivRCS-204
CHECKED: B. EBELHER DATE: 03.01.08 TYPE:


DRAWING NUMBER: 70081-E03500 SHEET: 1 OF 1 SCALE: NTS REV: A

This drawing and its design are the exclusive property of Motiv and shall not be duplicated or reproduced in any manner without the permission of Motiv. Motiv assumes no liability to any other party for any representations contained in this drawing.

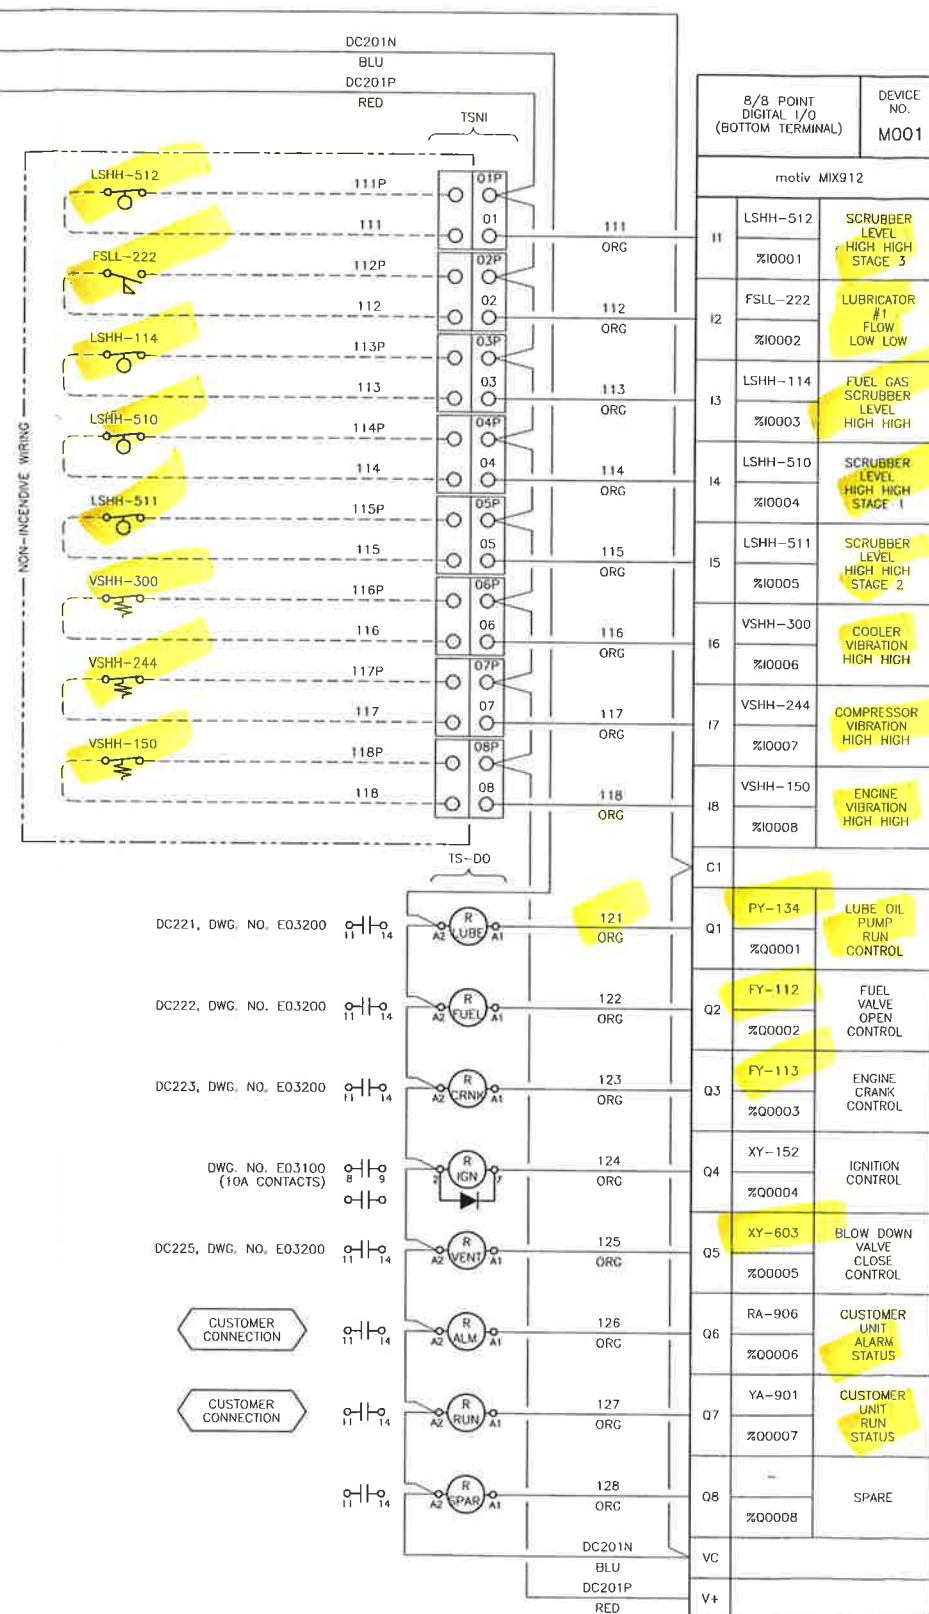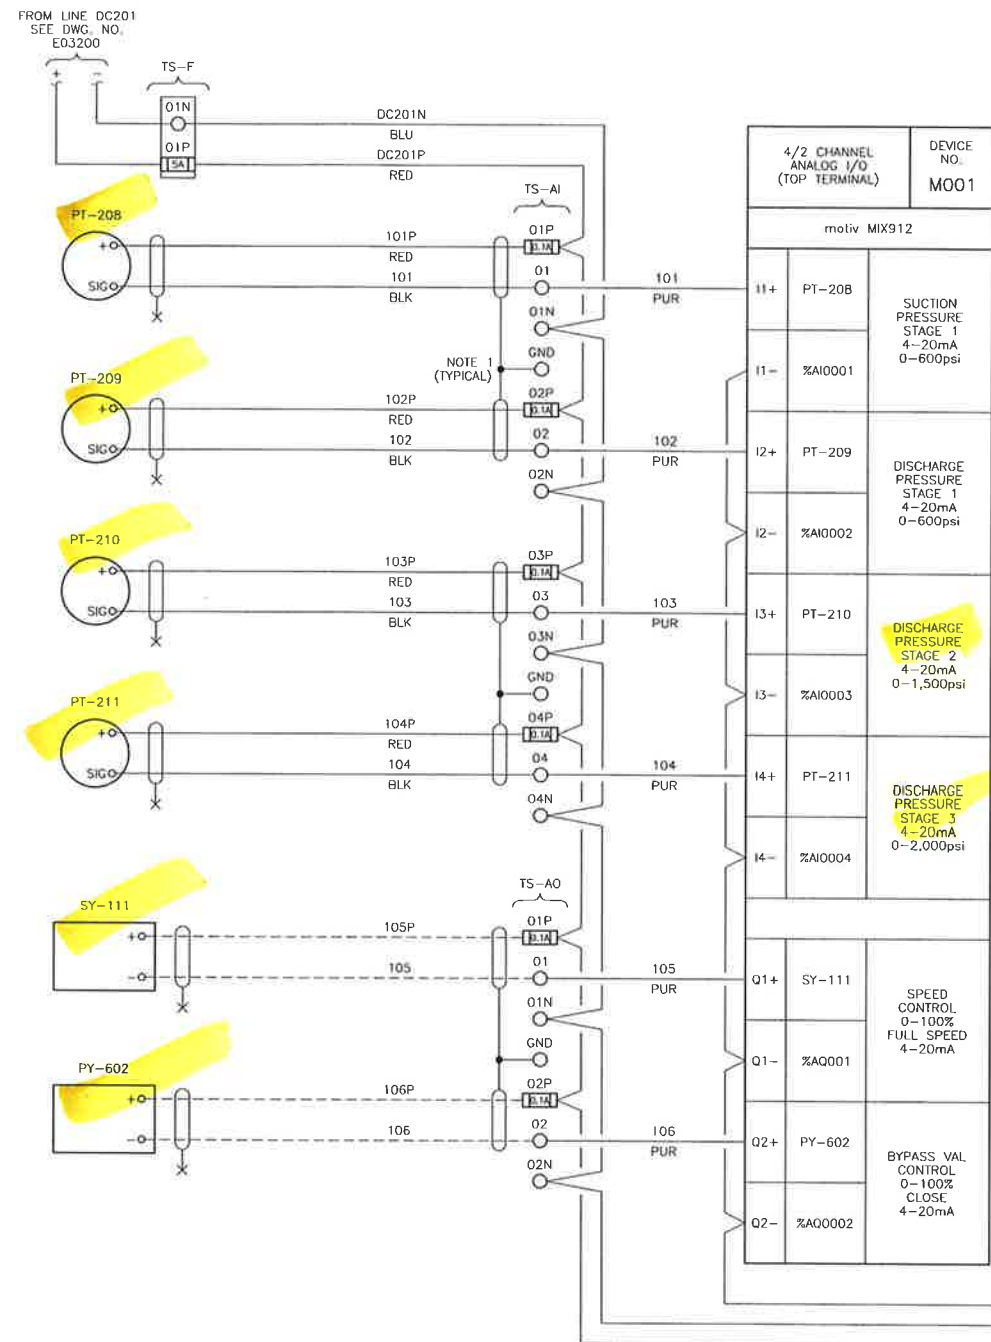

LEGEND:

- MOTIV CONTROL PANEL (FEED TERMINAL)
 - MOTIV CONTROL PANEL (DISCONNECT TERMINAL)
 - VENDOR TERMINAL
 - MCC TERMINAL
 - SKID JUNCTION BOX TERMINAL
 - FIELD JUNCTION BOX TERMINAL
 - FUSE TERMINAL
 - CUSTOMER PANEL
 - CUSTOMER JUNCTION BOX
 - IN4934 DIODE
 - PANEL/VENDOR WIRING
 - FIELD WIRING
- MOTIV CONTROL PANEL
NON INCENDIVE
BARRIER

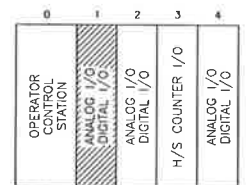

NOTES:

- ALL SHIELD WIRES TO BE TERMINATED AT SHIELD GROUND BUS.
- ALL FIELD WIRING TO BE WIRED FOR CLASS 1 ZONE 2, UNLESS SPECIFIED.
- PANEL IS RATED FOR CLASS 1 ZONE 2 ONLY.

REGISTERED COPY ISSUED FOR REVIEW

ISSUED TO: Long To

COMPANY: Bidell Equipment Inc.

DATE ISSUED: 05 MAY 2004

ISSUING DEPT.: MOTIV SYSTEMS INC.

THIS DOCUMENT CONTAINS PROPRIETARY INFORMATION AND MAY NOT BE REPRODUCED OR DISTRIBUTED TO ANY OTHER PARTIES IN WHOLE OR IN PART. THIS DOCUMENT IS NOT TO BE USED FOR INSPECTION, MANUFACTURE, OR ACCEPTANCE OF PRODUCTS. THIS DOCUMENT MUST BE RETURNED TO THE ISSUING DEPARTMENT FOR OFFICIAL DISPOSAL OR REISSUE.



motiv
CALGARY, ALBERTA, CANADA, PHONE: (403) 265-0955, FAX: (403) 265-0966

CONTROL PANEL PLC I/O SCHEMATIC ANALOG & DIGITAL MIXED OCS STACK 1


DRAWN: D. TIVADAR DATE: 03.01.07 CUST./PROJ.: BIDELL/03-248
DESIGNED: B. EBELHER DATE: 03.01.08 DESCRIPTION: motivRCS-204
CHECKED: B. EBELHER DATE: 03.01.08 TYPE:

DRAWING NUMBER: 70081-E05001 SHEET: 1 OF 1 SCALE: NTS REV: A

This drawing and its contents are the exclusive property of Motiv. It shall not be duplicated or reproduced in any manner without the permission of Motiv. Motiv assumes no liability to any other party for any representations contained in this drawing.

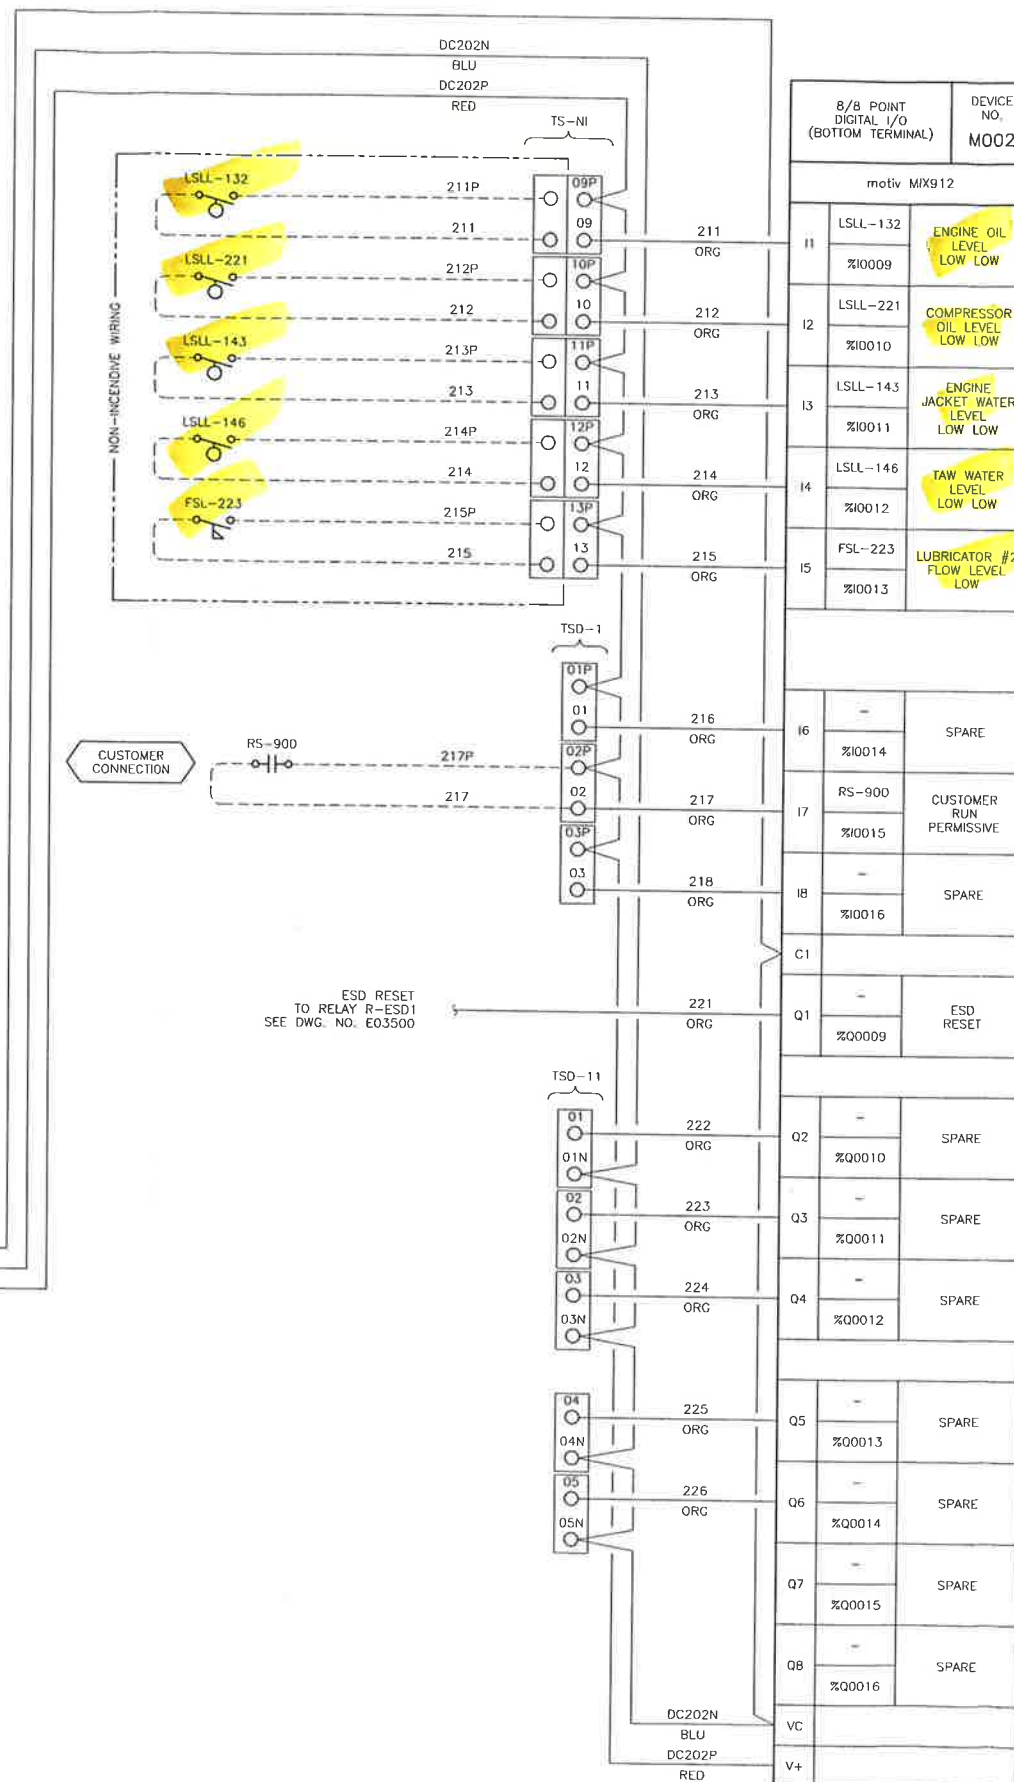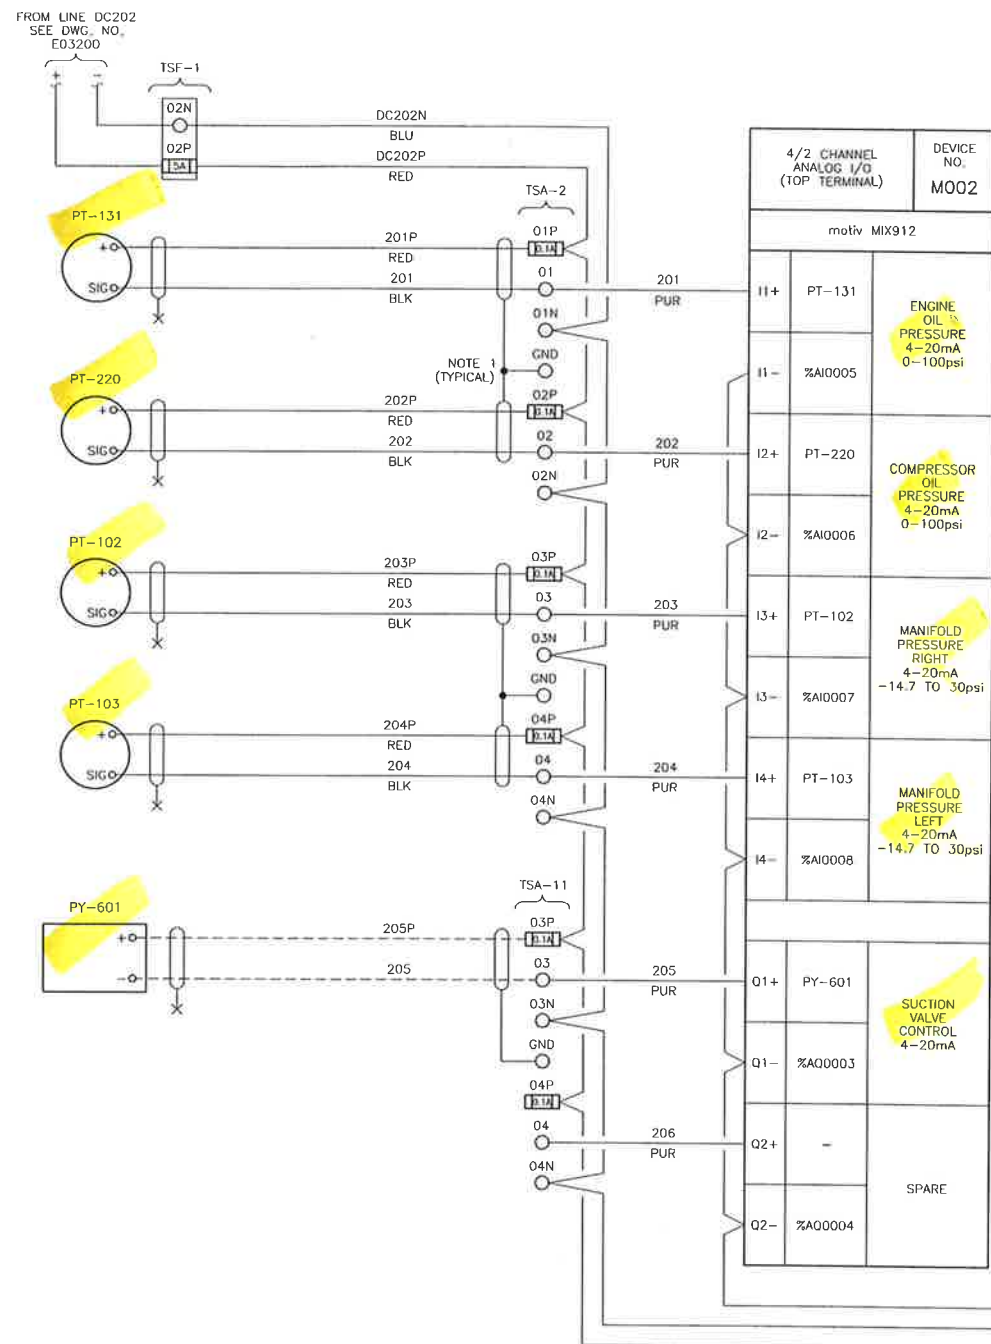


This drawing and its design are the exclusive property of Motiv and shall not be disclosed or reproduced in any manner without the permission of Motiv. Motiv assumes no liability to any other party for any representations contained in this drawing.

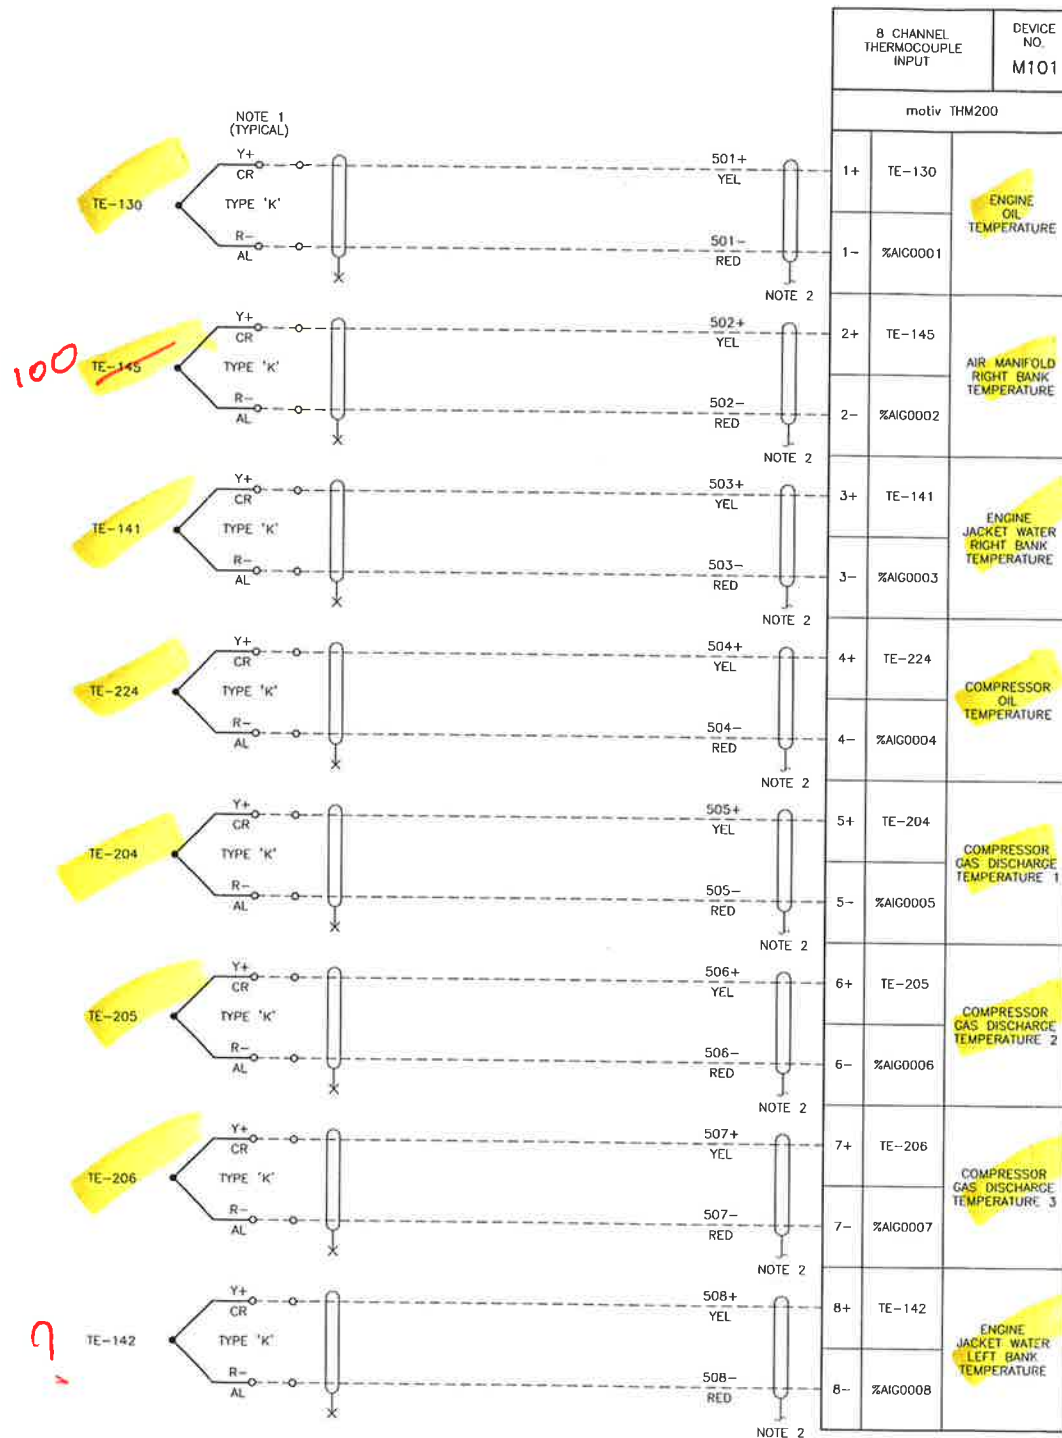

LEGEND:

- MOTIV CONTROL PANEL (FEED TERMINAL)
 - MOTIV CONTROL PANEL (DISCONNECT TERMINAL)
 - VENDOR TERMINAL
 - MCC TERMINAL
 - SKID JUNCTION BOX TERMINAL
 - FIELD JUNCTION BOX TERMINAL
 - FUSE TERMINAL
 - CUSTOMER PANEL
 - CUSTOMER JUNCTION BOX
 - IN4934 DIODE
 - PANEL/VENDOR WIRING
 - FIELD WIRING
- MOTIV CONTROL PANEL DUAL LEVEL FEED THROUGH WDK 2.5
- MOTIV CONTROL PANEL NON INCENDIVE BARRIER
- MOTIV CONTROL PANEL DUAL LEVEL FUSED AND FEED THROUGH
- MOTIV CONTROL PANEL DUAL LEVEL FEED THROUGH WITH SHIELD

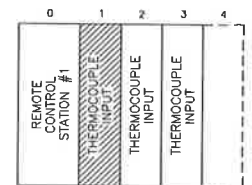

NOTES:

- ALL WIRING SHOWN ON THIS DRAWING MUST BE 'J' TYPE OR 'K' TYPE AS SPECIFIED ON THE DEVICE. THERMOCOUPLE, COPPER WIRE IS NOT ACCEPTABLE.
- ALL SHIELD WIRES TO BE TERMINATED AT SHIELD GROUND BUS.
- ALL FIELD WIRING TO BE WIRED FOR CLASS 1 ZONE 2, UNLESS SPECIFIED.
- PANEL IS RATED FOR CLASS 1 ZONE 2 ONLY.

REGISTERED COPY ISSUED FOR REVIEW

ISSUED TO: Long To

COMPANY: Bidell Equipment Inc.

DATE ISSUED: 05 MAY 2004

ISSUING DEPT.: MOTIV SYSTEMS INC.

THIS DOCUMENT CONTAINS PROPRIETARY INFORMATION AND MAY NOT BE REPRODUCED OR DISTRIBUTED TO ANY OTHER PARTIES IN WHOLE OR IN PART. THIS DOCUMENT IS NOT TO BE USED FOR INSPECTION, MANUFACTURE, OR ACCEPTANCE OF PRODUCTS. THIS DOCUMENT MUST BE RETURNED TO THE ISSUING DEPARTMENT FOR OFFICIAL DISPOSAL OR REISSUE.


motivTM

CALGARY, ALBERTA, CANADA, PHONE: (403) 265-0955, FAX: (403) 265-0966

CONTROL PANEL PLC I/O SCHEMATIC THERMOCOUPLE RCS 1 STACK 1

DRAWN: D. TIVADAR	DATE: 03.01.07	CUST./PROJ.: BIDELL/03-248
DESIGNED: B. EBELHER	DATE: 03.01.08	DESCRIPTION: motivRCS-204
CHECKED: B. EBELHER	DATE: 03.01.08	TYPE:
DRAWING NUMBER: 70081-E05101	SHEET: 1 OF 1	SCALE: NTS
		REV: A

This drawing and its design are the exclusive property of Motiv and shall not be disclosed or reproduced in any manner without the permission of Motiv. Motiv assumes no liability to any other party for any representations contained in this drawing.

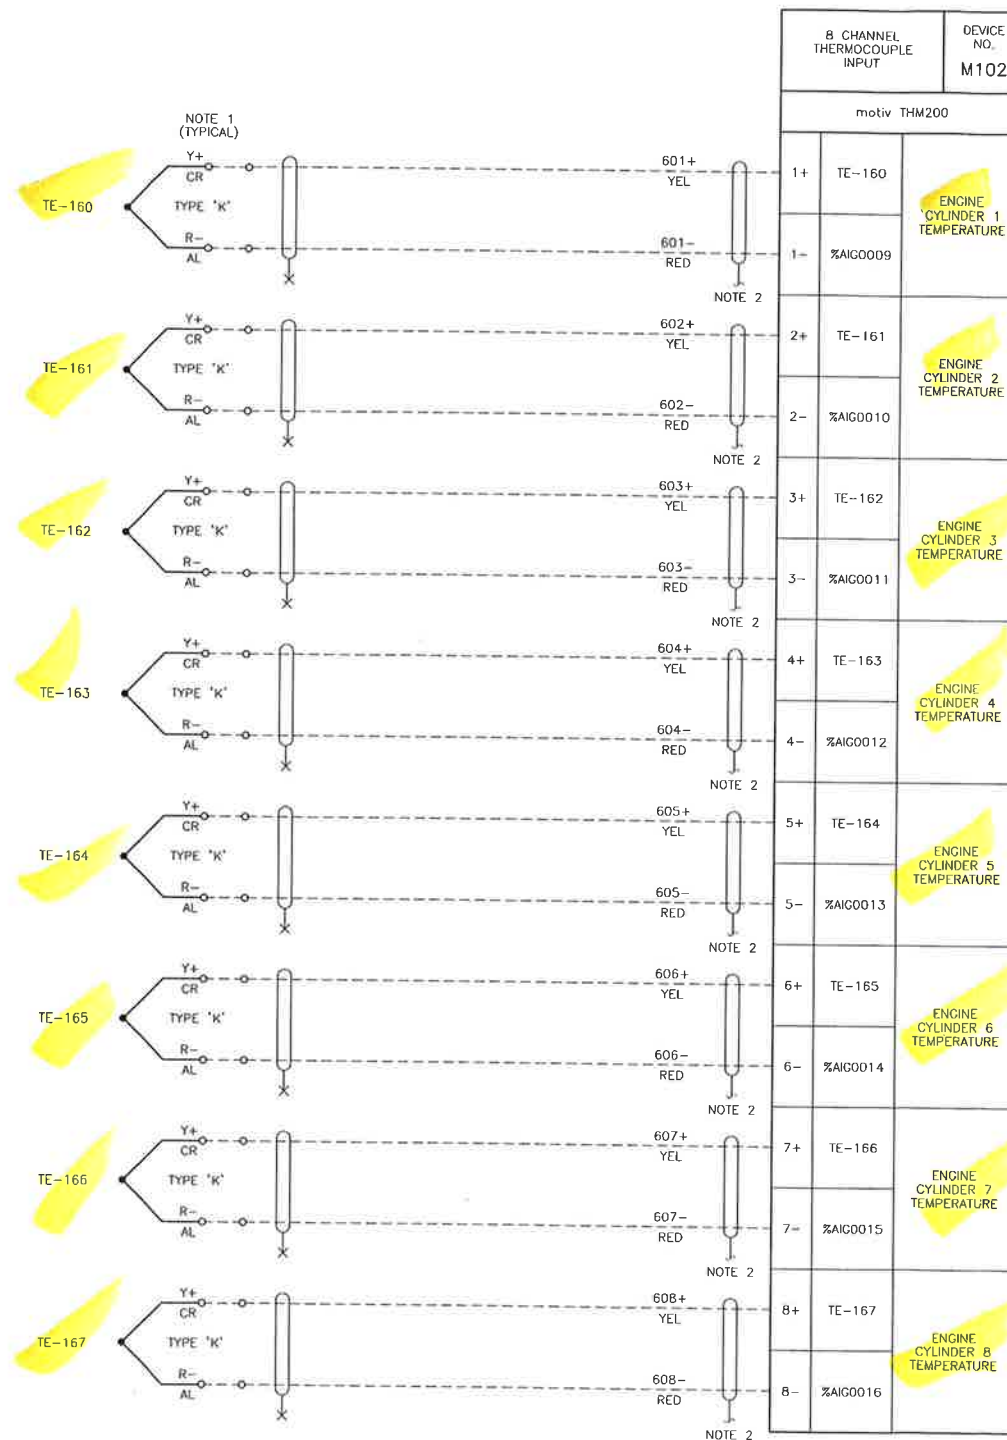

LEGEND:


- MOTIV CONTROL PANEL (FEED TERMINAL)
- MOTIV CONTROL PANEL (DISCONNECT TERMINAL)
- VENDOR TERMINAL
- MCC TERMINAL
- SKID JUNCTION BOX TERMINAL
- FIELD JUNCTION BOX TERMINAL
- FUSE TERMINAL
- CUSTOMER PANEL
- CUSTOMER JUNCTION BOX
- IN4934 DIODE
- PANEL/VENDOR WIRING
- FIELD WIRING

MOTIV CONTROL PANEL
DUAL LEVEL FEED THROUGH
WDK 2,5

MOTIV CONTROL PANEL
NON INCENDIVE
BARRIER

MOTIV CONTROL PANEL
DUAL LEVEL
FUSED AND FEED THROUGH

MOTIV CONTROL PANEL
DUAL LEVEL
FEED THROUGH
WITH SHIELD

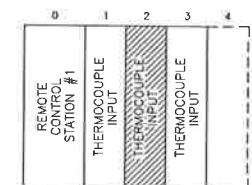

NOTES:

- ALL WIRING SHOWN ON THIS DRAWING MUST BE 'J' TYPE OR 'K' TYPE AS SPECIFIED ON THE DEVICE. THERMOCOUPLE COPPER WIRE IS NOT ACCEPTABLE.
- ALL SHIELD WIRES TO BE TERMINATED AT SHIELD GROUND BUS.
- ALL FIELD WIRING TO BE WIRED FOR CLASS 1 ZONE 2, UNLESS SPECIFIED.
- PANEL IS RATED FOR CLASS 1 ZONE 2 ONLY.

REGISTERED COPY ISSUED FOR REVIEW

ISSUED TO: Long To
COMPANY: Bidell Equipment Inc.
DATE ISSUED: 05 MAY 2004
ISSUING DEPT.: MOTIV SYSTEMS INC.

THIS DOCUMENT CONTAINS PROPRIETARY INFORMATION AND MAY NOT BE REPRODUCED OR DISTRIBUTED TO ANY OTHER PARTIES IN WHOLE OR IN PART. THIS DOCUMENT IS NOT TO BE USED FOR INSPECTION, MANUFACTURE, OR ACCEPTANCE OF PRODUCTS. THIS DOCUMENT MUST BE RETURNED TO THE ISSUING DEPARTMENT FOR OFFICIAL DISPOSAL OR REISSUE.

motiv
www.motiv-systems.com


CALGARY, ALBERTA, CANADA, PHONE: (403) 265-0955, FAX: (403) 265-0966

CONTROL PANEL PLC I/O SCHEMATIC THERMOCOUPLE RCS 1 STACK 2

DRAWN: D. TIVADAR DATE: 03.01.07 CUST./PROJ.: BIDELL/03-248
DESIGNED: B. EBELHER DATE: 03.01.08 DESCRIPTION: motivRCS-204
CHECKED: B. EBELHER DATE: 03.01.08 TYPE:

DRAWING NUMBER: 70081-E05102 SHEET: 1 OF 1 SCALE: NTS REV: A

This drawing and its design are the exclusive property of Motiv and shall not be disclosed or reproduced in any matter without the permission of Motiv. Motiv assumes no liability for any other party for any representations contained in this drawing.

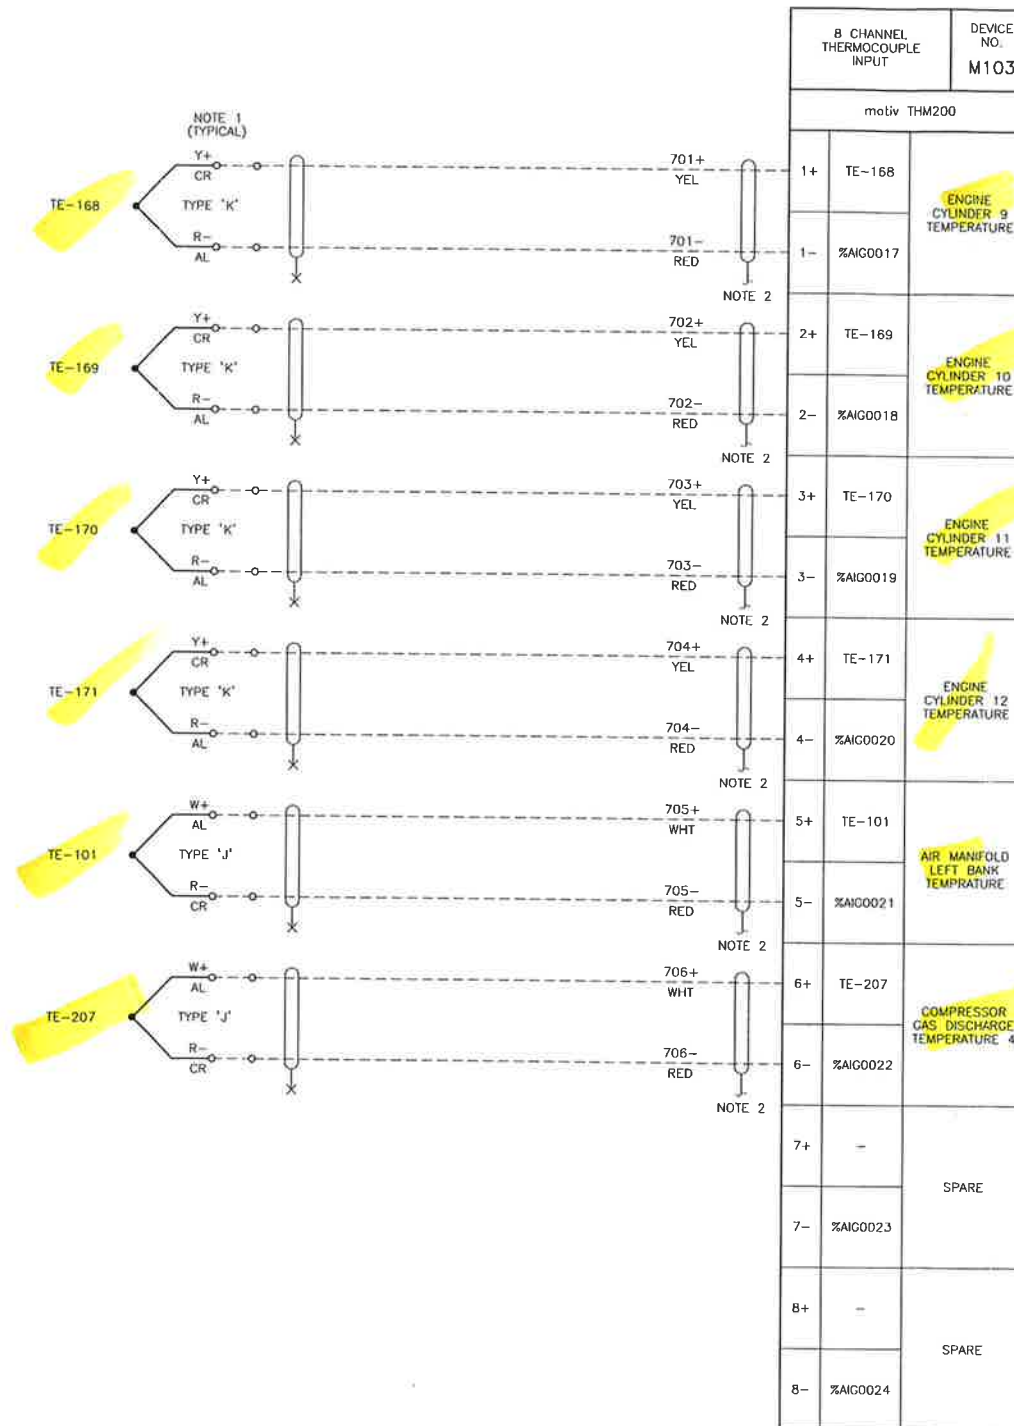

LEGEND:


- MOTIV CONTROL PANEL (FEED TERMINAL)
- MOTIV CONTROL PANEL (DISCONNECT TERMINAL)
- VENDOR TERMINAL
- MCC TERMINAL
- SKID JUNCTION BOX TERMINAL
- FIELD JUNCTION BOX TERMINAL
- FUSE TERMINAL
- CUSTOMER PANEL
- CUSTOMER JUNCTION BOX
- IN4934 DIODE
- PANEL/VENDOR WIRING
- FIELD WIRING

MOTIV CONTROL PANEL
DUAL LEVEL FEED THROUGH
WDK 2.5

MOTIV CONTROL PANEL
NON INCENDIVE
BARRIER

MOTIV CONTROL PANEL
DUAL LEVEL
FUSED AND FEED THROUGH

MOTIV CONTROL PANEL
DUAL LEVEL
FEED THROUGH
WITH SHIELD

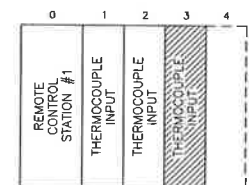

NOTES:

- ALL WIRING SHOWN ON THIS DRAWING MUST BE 'J' TYPE OR 'K' TYPE AS SPECIFIED ON THE DEVICE THERMOCOUPLE. COPPER WIRE IS NOT ACCEPTABLE.
- ALL SHIELD WIRES TO BE TERMINATED AT SHIELD GROUND BUS.
- ALL FIELD WIRING TO BE WIRED FOR CLASS 1 ZONE 2, UNLESS SPECIFIED.
- PANEL IS RATED FOR CLASS 1 ZONE 2 ONLY.

REGISTERED COPY ISSUED FOR REVIEW

ISSUED TO: Long To
COMPANY: Bidell Equipment Inc.
DATE ISSUED: 05 MAY 2004
ISSUING DEPT.: MOTIV SYSTEMS INC.

THIS DOCUMENT CONTAINS PROPRIETARY INFORMATION AND MAY NOT BE REPRODUCED OR DISTRIBUTED TO ANY OTHER PARTIES IN WHOLE OR IN PART. THIS DOCUMENT IS NOT TO BE USED FOR INSPECTION, MANUFACTURE, OR ACCEPTANCE OF PRODUCTS. THIS DOCUMENT MUST BE RETURNED TO THE ISSUING DEPARTMENT FOR OFFICIAL DISPOSAL OR REISSUE.

motiv
www.motiv-systems.com


CALGARY, ALBERTA, CANADA, PHONE: (403) 265-0955, FAX: (403) 265-0966

CONTROL PANEL PLC I/O SCHEMATIC THERMOCOUPLE RCS 1 STACK 3

DRAWN: D. TIVADAR DATE: 03.01.07 CUST./PROJ.: BIDELL/03-248
DESIGNED: B. EBELHER DATE: 03.01.08 DESCRIPTION: motivRCS-204
CHECKED: B. EBELHER DATE: 03.01.08 TYPE:

DRAWING NUMBER: 70081-E05103 SHEET: 1 OF 1 SCALE: NTS REV: A

This drawing and its details are the exclusive property of Motiv and shall not be disclosed or reproduced in any matter without the permission of Motiv. Motiv assumes no liability to any other party for any representations contained in this drawing.

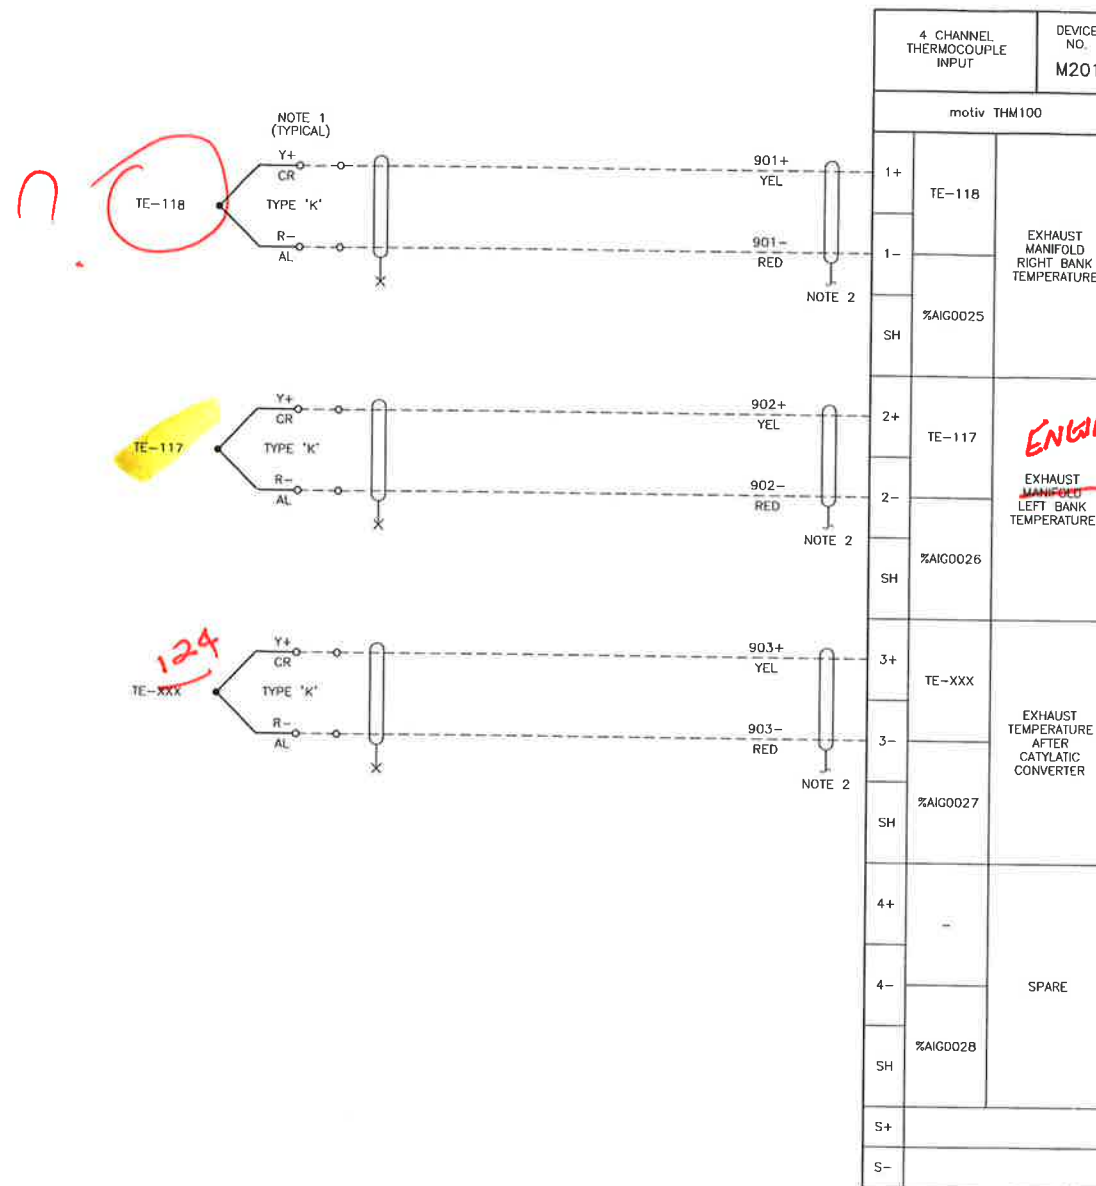

LEGEND:


- MOTIV CONTROL PANEL (FEED TERMINAL)
- MOTIV CONTROL PANEL (DISCONNECT TERMINAL)
- VENDOR TERMINAL
- MCC TERMINAL
- SKID JUNCTION BOX TERMINAL
- FIELD JUNCTION BOX TERMINAL
- FUSE TERMINAL
- CUSTOMER PANEL
- CUSTOMER JUNCTION BOX
- IN4934 DIODE
- PANEL/VENDOR WIRING
- FIELD WIRING

MOTIV CONTROL PANEL DUAL LEVEL FEED THROUGH WDK 2.5

MOTIV CONTROL PANEL NON INCENDIVE BARRIER

MOTIV CONTROL PANEL DUAL LEVEL FUSED AND FEED THROUGH

MOTIV CONTROL PANEL DUAL LEVEL FEED THROUGH WITH SHIELD

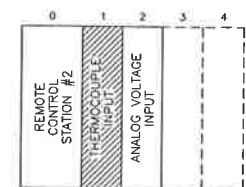

NOTES:

- ALL WIRING SHOWN ON THIS DRAWING MUST BE 'J' TYPE OR 'K' TYPE AS SPECIFIED ON THE DEVICE. THERMOCOUPLE COPPER WIRE IS NOT ACCEPTABLE.
- ALL SHIELD WIRES TO BE TERMINATED AT SHIELD GROUND BUS.
- ALL FIELD WIRING TO BE WIRED FOR CLASS 1 ZONE 2, UNLESS SPECIFIED.

REGISTERED COPY ISSUED FOR REVIEW

ISSUED TO: Long To

COMPANY: Bidell Equipment Inc.

DATE ISSUED: 05 MAY 2004

ISSUING DEPT.: MOTIV SYSTEMS INC.

THIS DOCUMENT CONTAINS PROPRIETARY INFORMATION AND MAY NOT BE REPRODUCED OR DISTRIBUTED TO ANY OTHER PARTIES IN WHOLE OR IN PART. THIS DOCUMENT IS NOT TO BE USED FOR INSPECTION, MANUFACTURE, OR ACCEPTANCE OF PRODUCTS. THIS DOCUMENT MUST BE RETURNED TO THE ISSUING DEPARTMENT FOR OFFICIAL DISPOSAL OR REISSUE.

motiv
www.motiv-systems.com

CALGARY, ALBERTA, CANADA, PHONE: (403) 265-0955, FAX: (403) 265-0966

CONTROL PANEL PLC I/O SCHEMATIC THERMOCOUPLE RCS 2 STACK 1


DRAWN: D. TIVADAR DATE: 03.01.07 CUST./PROJ.: BIDELL/03-248

DESIGNED: B. EBELHER DATE: 03.01.08 DESCRIPTION: motivRCS-204

CHECKED: B. EBELHER DATE: 03.01.08 TYPE:


DRAWING NUMBER: 70081-E05201 SHEET: 1 OF 1 SCALE: NTS REV: A

This drawing and its design are the exclusive property of Motiv and shall not be disclosed or reproduced in any manner without the permission of Motiv. Motiv assumes no liability to any other party for any representations contained in this drawing.

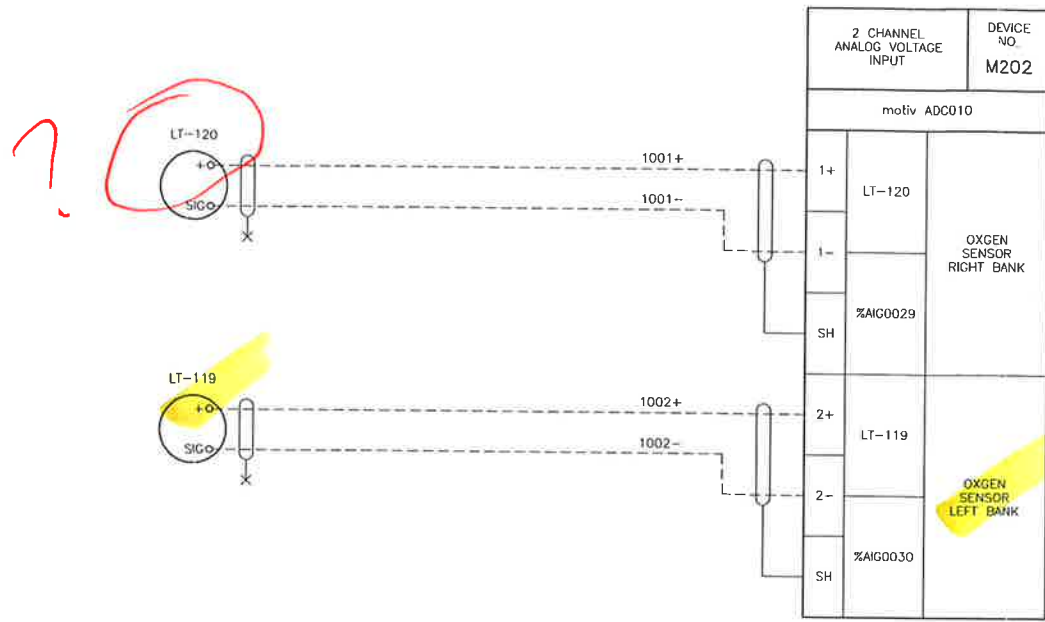

LEGEND:

- MOTIV CONTROL PANEL (FEED TERMINAL)
- MOTIV CONTROL PANEL (DISCONNECT TERMINAL)
- VENDOR TERMINAL
- MCC TERMINAL
- SKID JUNCTION BOX TERMINAL
- FIELD JUNCTION BOX TERMINAL
- FUSE TERMINAL
- CUSTOMER PANEL
- CUSTOMER JUNCTION BOX
- IN4934 DIODE
- PANEL/VENDOR WIRING
- FIELD WIRING
- MOTIV CONTROL PANEL DUAL LEVEL FEED THROUGH WDK 2.5
- MOTIV CONTROL PANEL NON INCENDIVE BARRIER
- MOTIV CONTROL PANEL DUAL LEVEL FUSED AND FEED THROUGH
- MOTIV CONTROL PANEL DUAL LEVEL FEED THROUGH WITH SHIELD

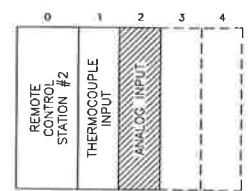

NOTES:

- ALL FIELD WIRING TO BE WIRED FOR CLASS 1 ZONE 2, UNLESS SPECIFIED.
- PANEL IS RATED FOR CLASS 1 ZONE 2 ONLY.

REGISTERED COPY
ISSUED FOR REVIEW

ISSUED TO: Long Ta
COMPANY: Bidell Equipment Inc.
DATE ISSUED: 05 MAY 2004
ISSUING DEPT.: MOTIV SYSTEMS INC.


THIS DOCUMENT CONTAINS PROPRIETARY INFORMATION AND MAY NOT BE REPRODUCED OR DISTRIBUTED TO ANY OTHER PARTIES IN WHOLE OR IN PART. THIS DOCUMENT IS NOT TO BE USED FOR INSPECTION, MANUFACTURE, OR ACCEPTANCE OF PRODUCTS. THIS DOCUMENT MUST BE RETURNED TO THE ISSUING DEPARTMENT FOR OFFICIAL DISPOSAL OR REISSUE.




CALGARY, ALBERTA, CANADA, PHONE: (403) 265-0955, FAX: (403) 265-0966

CONTROL PANEL
PLC I/O SCHEMATIC
ANALOG INPUT RCS 2 STACK 2



DRAWN:	D. TIVADAR	DATE:	03.01.07	CUST./PROJ.:	BIDELL/03-248
DESIGNED:	B. EBELHER	DATE:	03.01.08	DESCRIPTION:	motivRCS-204
CHECKED:	B. EBELHER	DATE:	03.01.08	TYPE:	
DRAWING NUMBER:	70081-E05202	SHEET:	1 OF 1	SCALE:	NTS
		REV:	A		

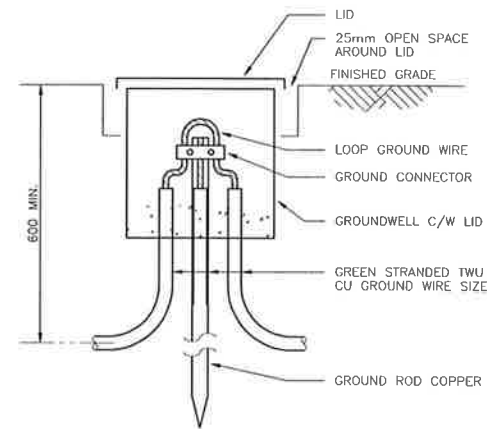

GROUNDWELL

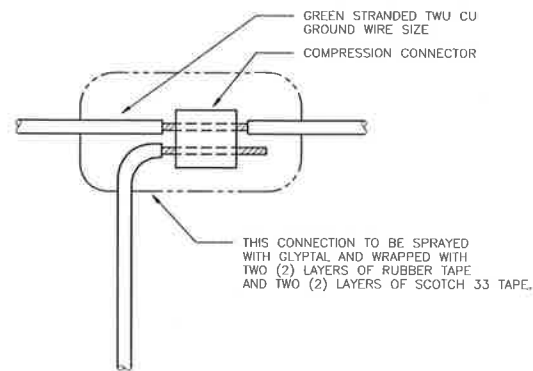

GROUND CONNECTION

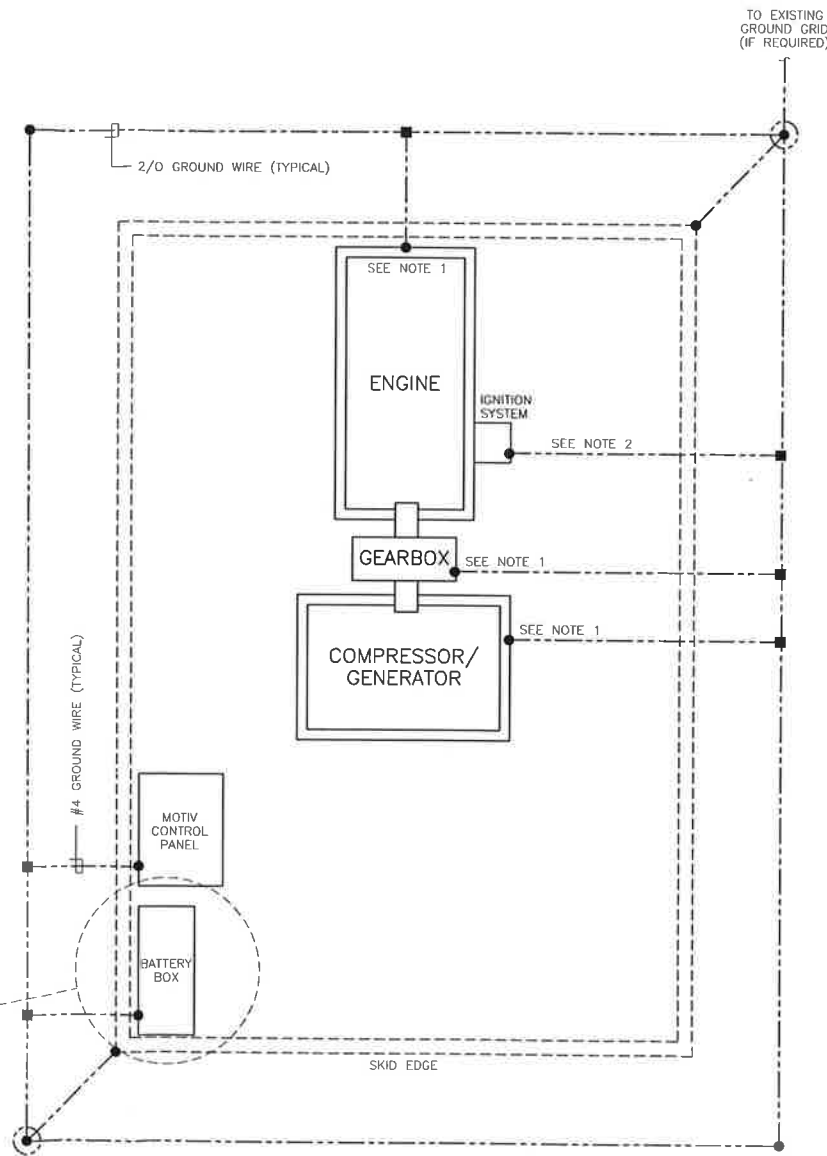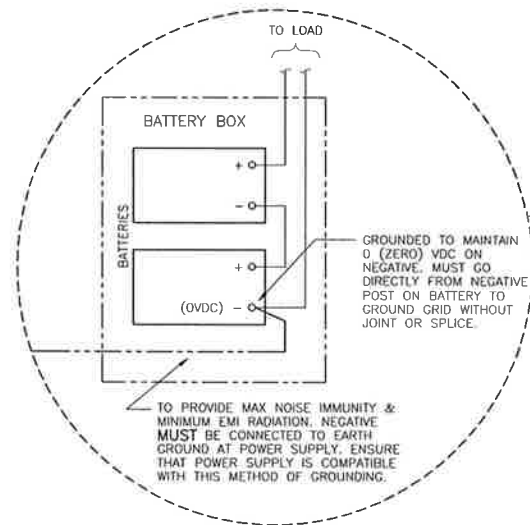

SKID GROUNDING LAYOUT
(GENERAL ONLY)

LEGEND:

- GROUND CONNECTION WELDED, BRAZED OR COMPRESSION TYPE
- GROUND ROD W/O WELL BOLTED OR CLAMPED
- GROUND ROD C/W WELL
- GROUNDING CONDUCTOR

NOTES:

1. DRILL AND TAP - 5/16" DRILL 3/8" N. C. TAP FOR SERVIT POST.
2. THE DEDICATED ENGINE GROUND TERMINAL SHOULD BE CONNECTED TO PACKAGE SKID AND THEN OUT TO GROUND ROD WITH 4AWG WIRE. DO NOT USE PACKAGE IRON FOR GROUND PATH AND DO NOT DAISSY CHAIN GROUND CONNECTIONS WITH OTHER DEVICES AS PER ENGINE/IGNITION MANUFACTURERS SPECIFICATION.

REGISTERED COPY
ISSUED FOR REVIEW

ISSUED TO: Long To
COMPANY: Bidell Equipment Inc.
DATE ISSUED: 05 MAY 2004
ISSUING DEPT.: MOTIV SYSTEMS INC.

THIS DOCUMENT CONTAINS PROPRIETARY INFORMATION AND MAY NOT BE REPRODUCED OR DISTRIBUTED TO ANY OTHER PARTIES IN WHOLE OR IN PART. THIS DOCUMENT IS NOT TO BE USED FOR INSPECTION, MANUFACTURE, OR ACCEPTANCE OF PRODUCTS. THIS DOCUMENT MUST BE RETURNED TO THE ISSUING DEPARTMENT FOR OFFICIAL DISPOSAL OR REISSUE.

A	04.05.05	ISSUED FOR REVIEW	JZH	DBG	DBG	LT	LT
REV	DATE	REVISION DESCRIPTION	BY	DSGN	CHKD	APPD	CLNT

motiv
CALGARY, ALBERTA, CANADA, PHONE: (403) 265-0955, FAX: (403) 265-0986

CONTROL PANEL
SUGGESTED GROUNDING

DRAWN:	W. CEMOTO	DATE: 04.01.06	CUST./PROJ.:	BIDELL/03-248
DESIGNED:	D. GREEN	DATE: 04.01.06	DESCRIPTION:	motivRCS-204
CHECKED:	D. GREEN	DATE: 04.01.06	TYPE:	

DRAWING NUMBER:	70081-E09000	SHEET:	1 OF 1	SCALE:	NTS	REV:	A
-----------------	--------------	--------	--------	--------	-----	------	---

This drawing and its design are the exclusive property of Motiv and shall not be disclosed or reproduced in any manner without the permission of Motiv. Motiv assumes no liability to any third party for any representations contained in this drawing.

