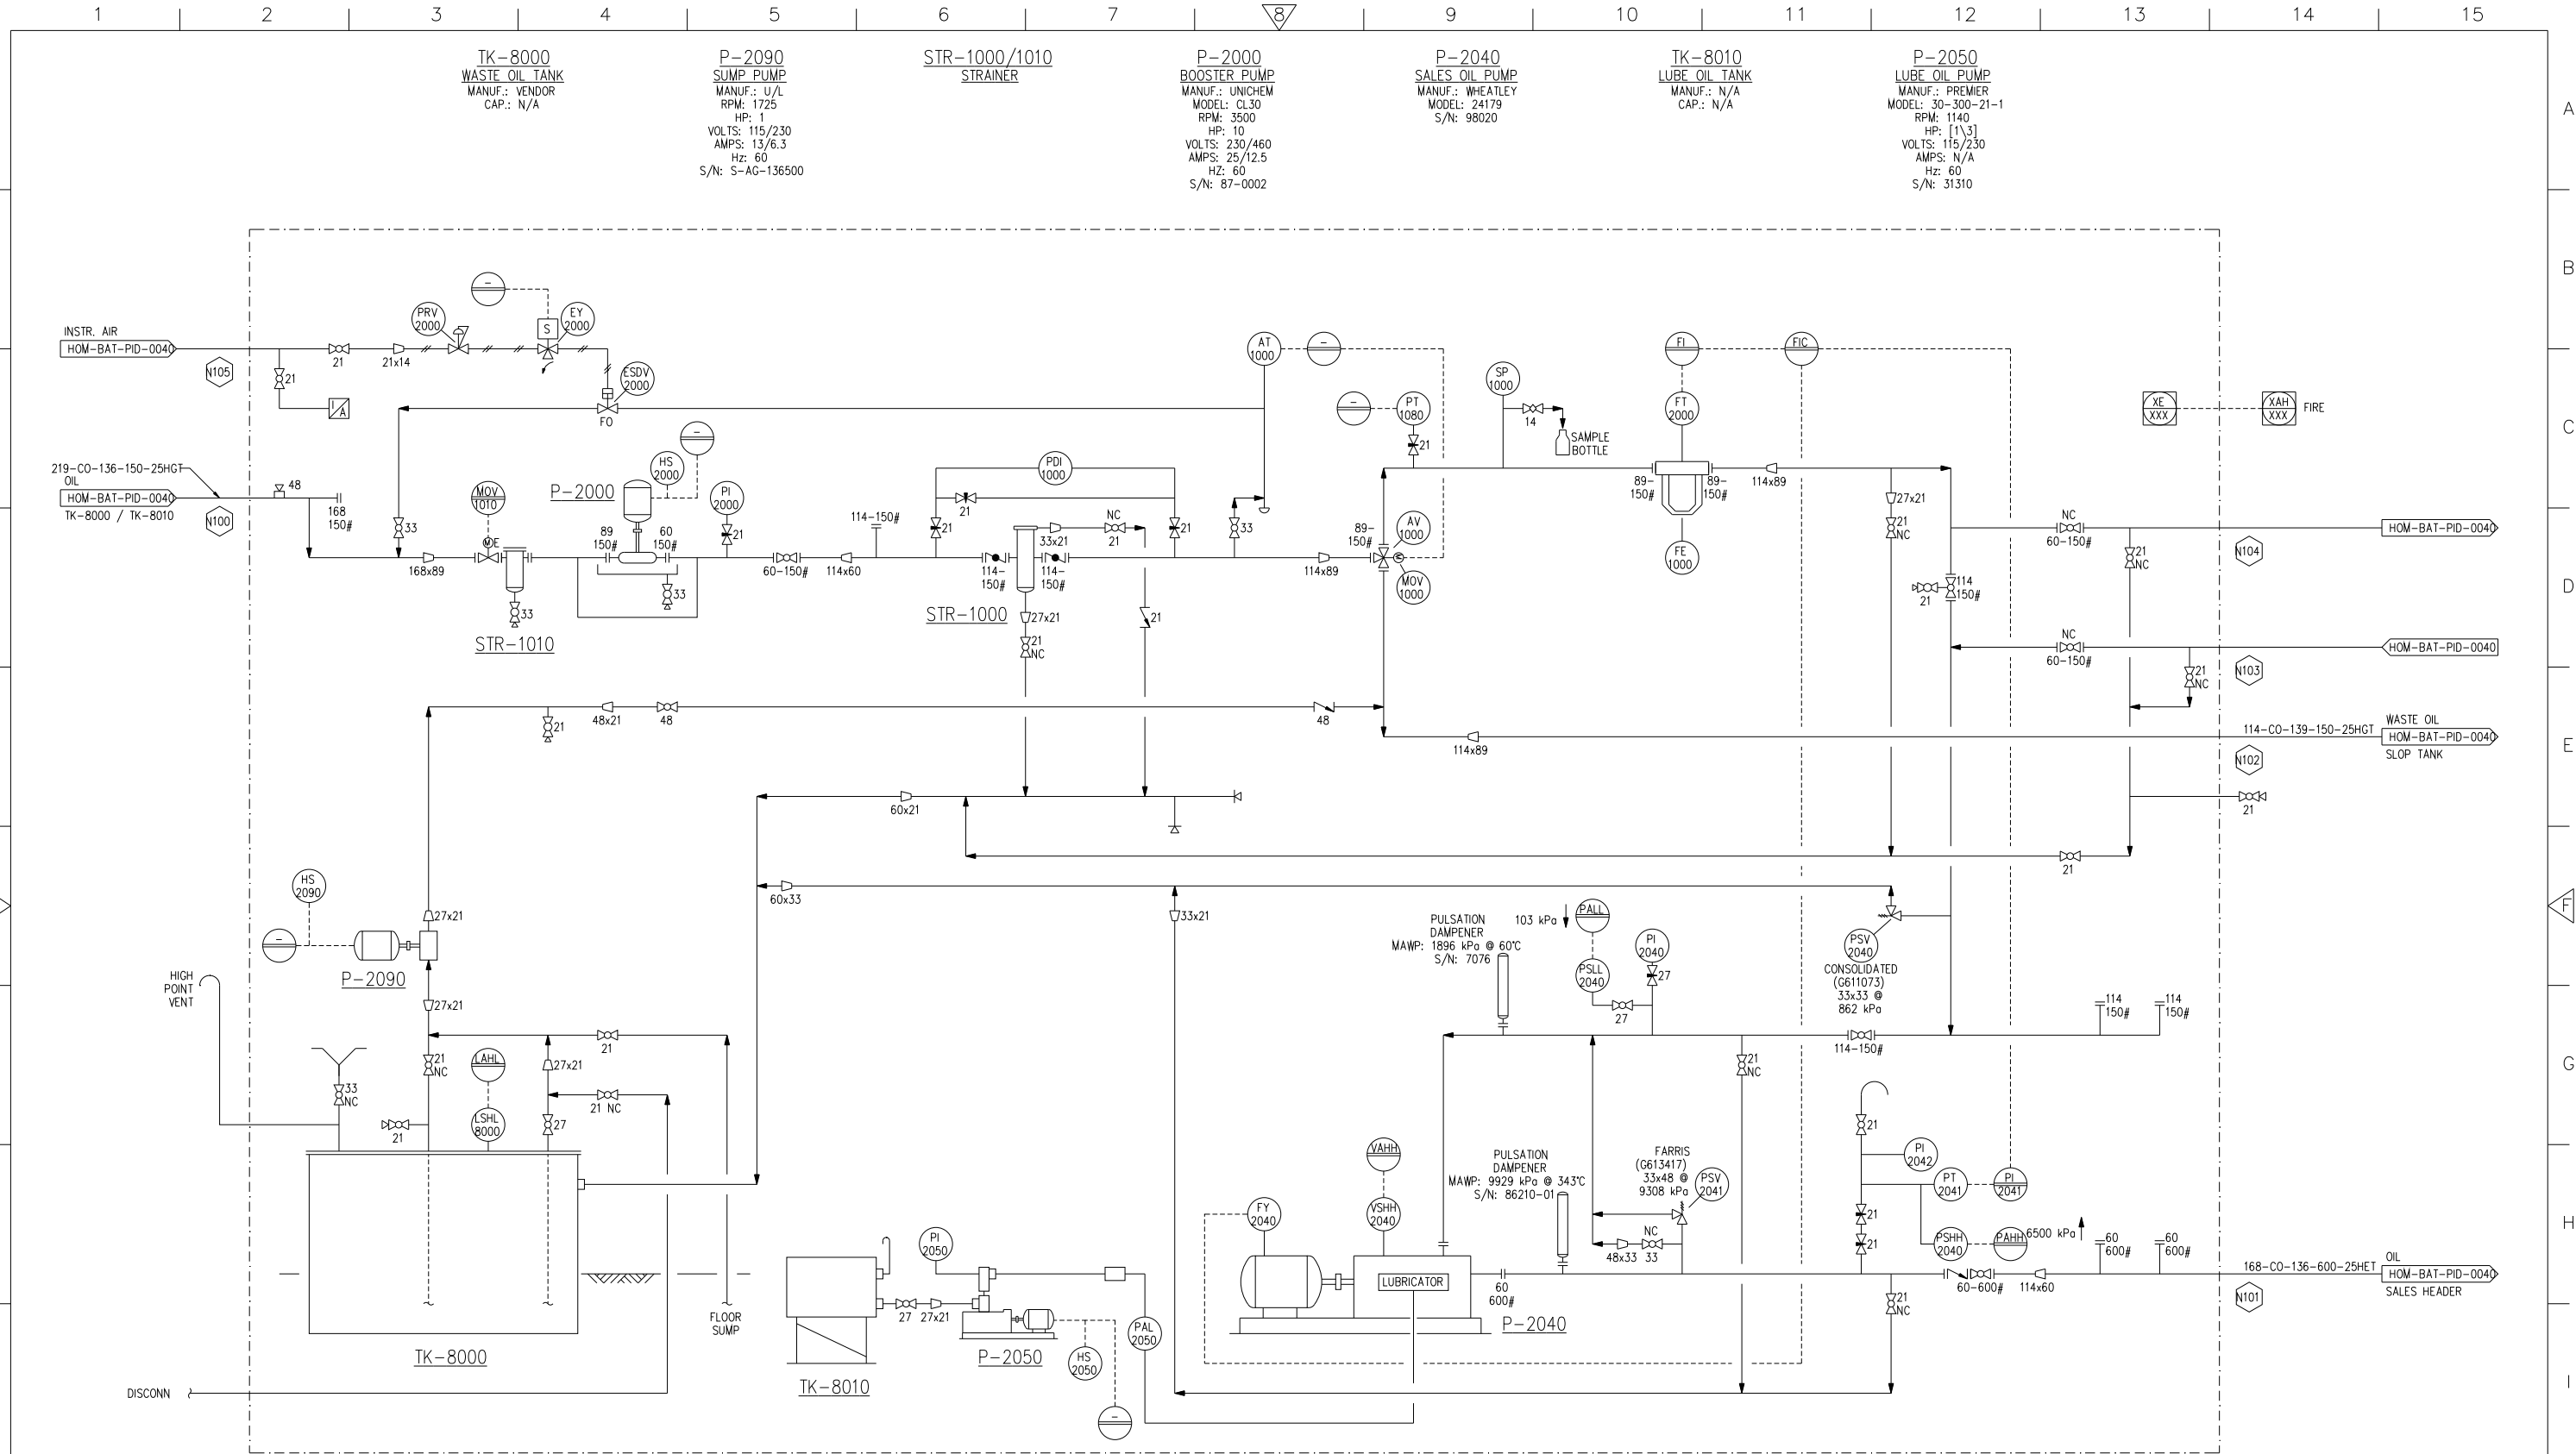


[illegible]

PREPARED BY:

 Canada Resources Corp.				
HAMBURG 15-21 BATTERY				
SALES OIL PUMP / METER SKID PIPING & INSTRUMENTATION DIAGRAM				
LEGAL DESC. FROM: 15-21-96-10 W6M			LEGAL DESC. TO (IF APPLICABLE):	
ENG. CD. PROJ. NO.: 06-135	SCALE: NTS	DESIGN: -	CPC DWG. NO.: HAM-BAT-PID-0041	REV.: 0
ENG. CD. DWG. NO.: -	DATE: 06/12/04	DRAWN: MJP		