


TAG. NO.	MAKE	DESCRIPTION
TS4-100	WIK-A-RTL-450C-4313-1	HIGH TEMP. DISCHARGE TEMP. CONTROL D-200 C

FC-100
FORCE AIR COOLER
 MODEL: CC-450-C
 MAWP: 100 PSI @ 300°F

M-100
COOLER MOTOR
 MODEL: A6C17XC22K
 HP: 1/2
 PHASE: 1
 RPM: 1725

ENCLOSURE: 34" x 54" x 36"

SERVICE: NORMAL
CODE: ASME B31.3, EDITION 2012
MAWP: 15 PSIG
TEMP: -29°C TO 150°C (-20°F TO 300°F)
PIPING ASSEMBLY: ASME B31.3

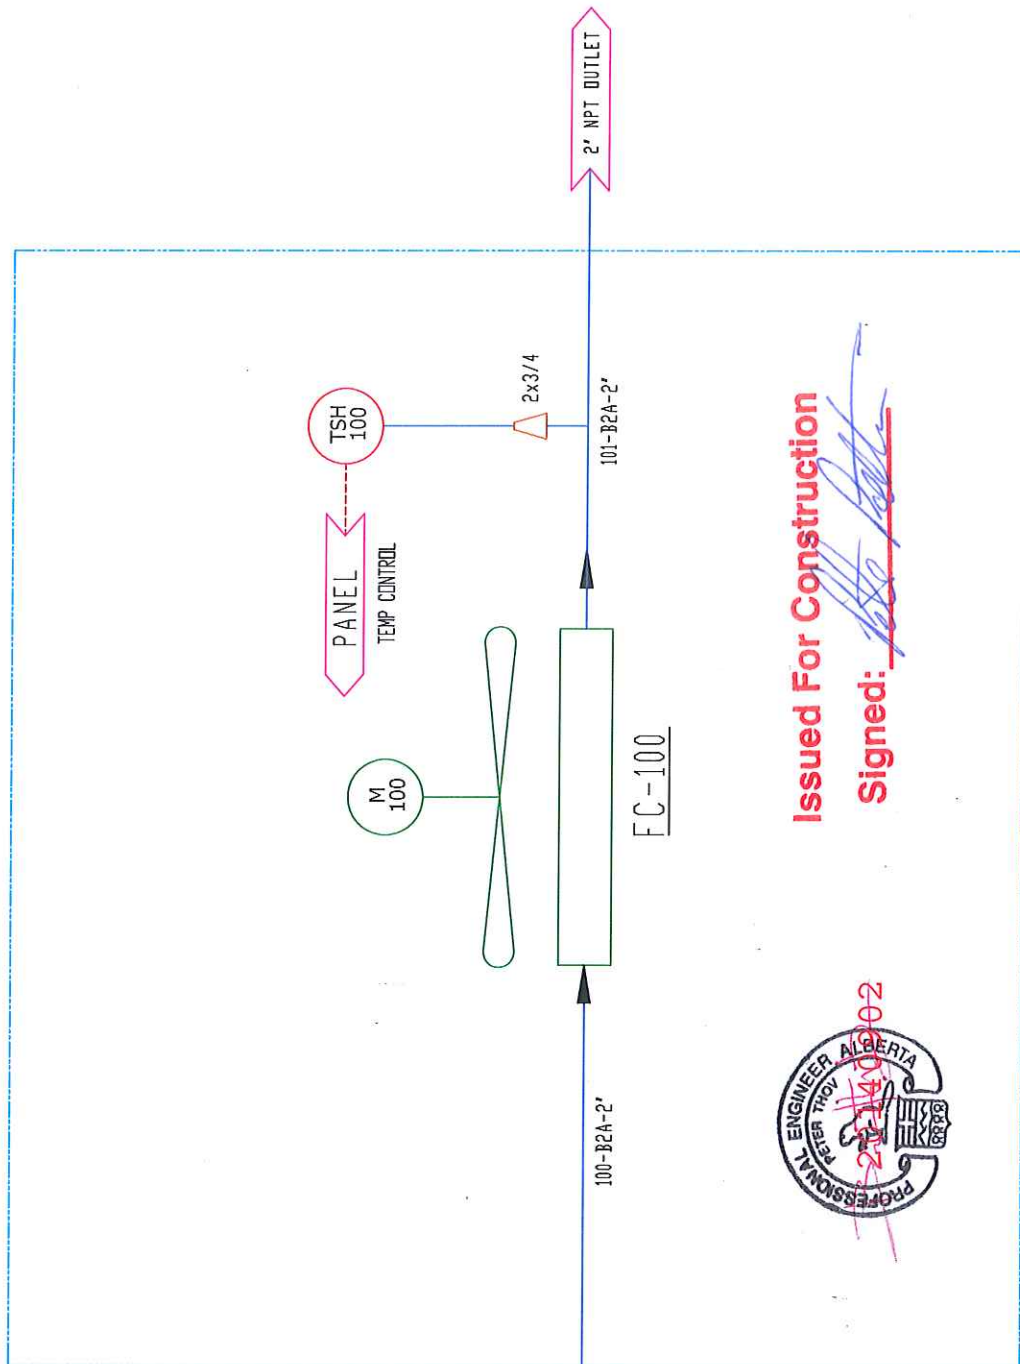

Issued For Construction
Signed: *[Signature]*

LINE SPEC.	SERVICE CODE	MAT. CODE
A = 150# B = 300# C = 400# D = 600# E = 900# F = 1500 #	2 = SWEET H.C 3 = SOUR H.C	A = CARBON K = STAINLESS N = CAST

DATE	REV	DESCRIPTION
20140902	01	ISSUED FOR APPROVAL

GASPRO
 CONFESION CORP.
 Box 24
 Three Hills, AB T0M 2A0
 Tel: (403) 443-3888
 Fax: (403) 443-5288

DRAWING REFERENCES	CLIENT
DRAWN: MS 20140902 CHECKED: TN 20140902 ENG APPR: BPT 20140902 DESIGNED & CONFESION CORP. ALL RIGHTS RESERVED NO PART OF THIS DOCUMENT MAY BE REPRODUCED OR TRANSMITTED IN ANY FORM OR BY ANY MEANS WITHOUT THE WRITTEN PERMISSION OF GASPRO CONFESION CORP.	INTERNAL ENGINEERING TITLE: BTEX COOLER (CC450C) PIPING & INSTRUMENTATION DIAGRAM PREL. NO: CCB013 JWG NO: CC450C-2IN-01 SIZE: B SCALE: NTS SHEET: 1 OF 1 REV: 01