
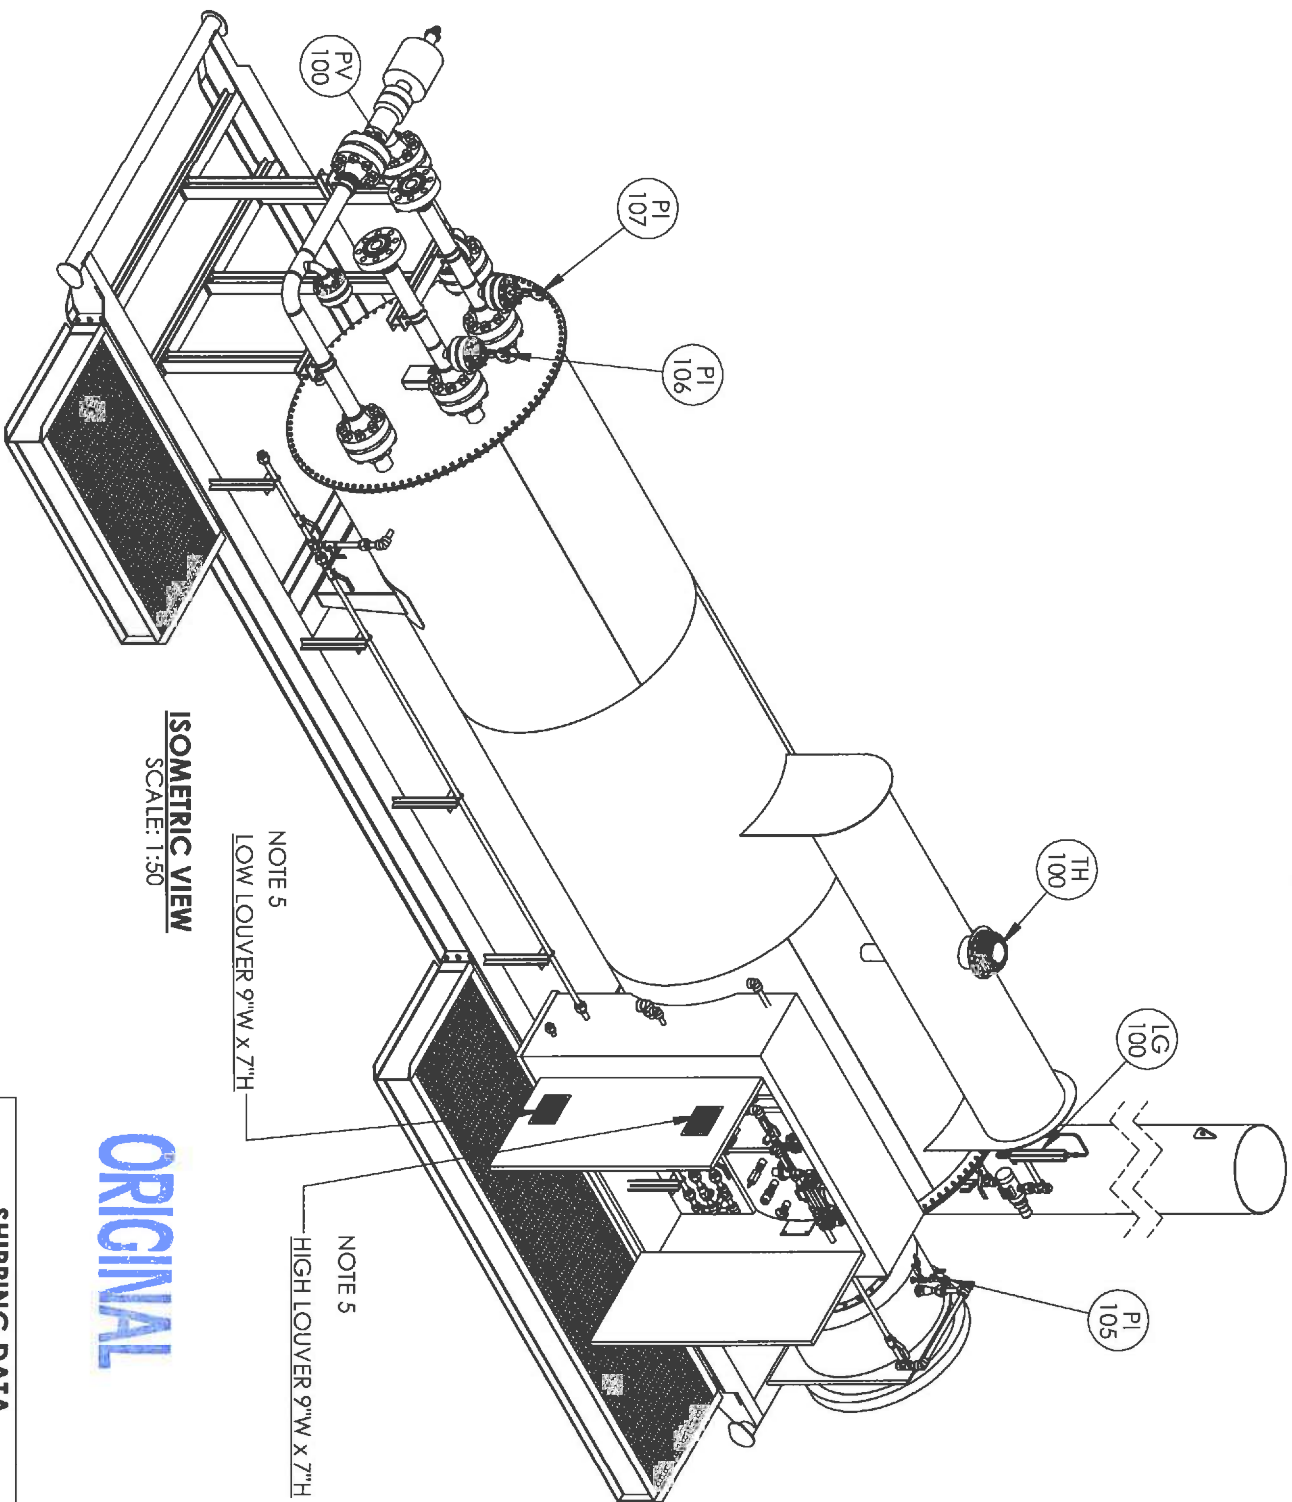


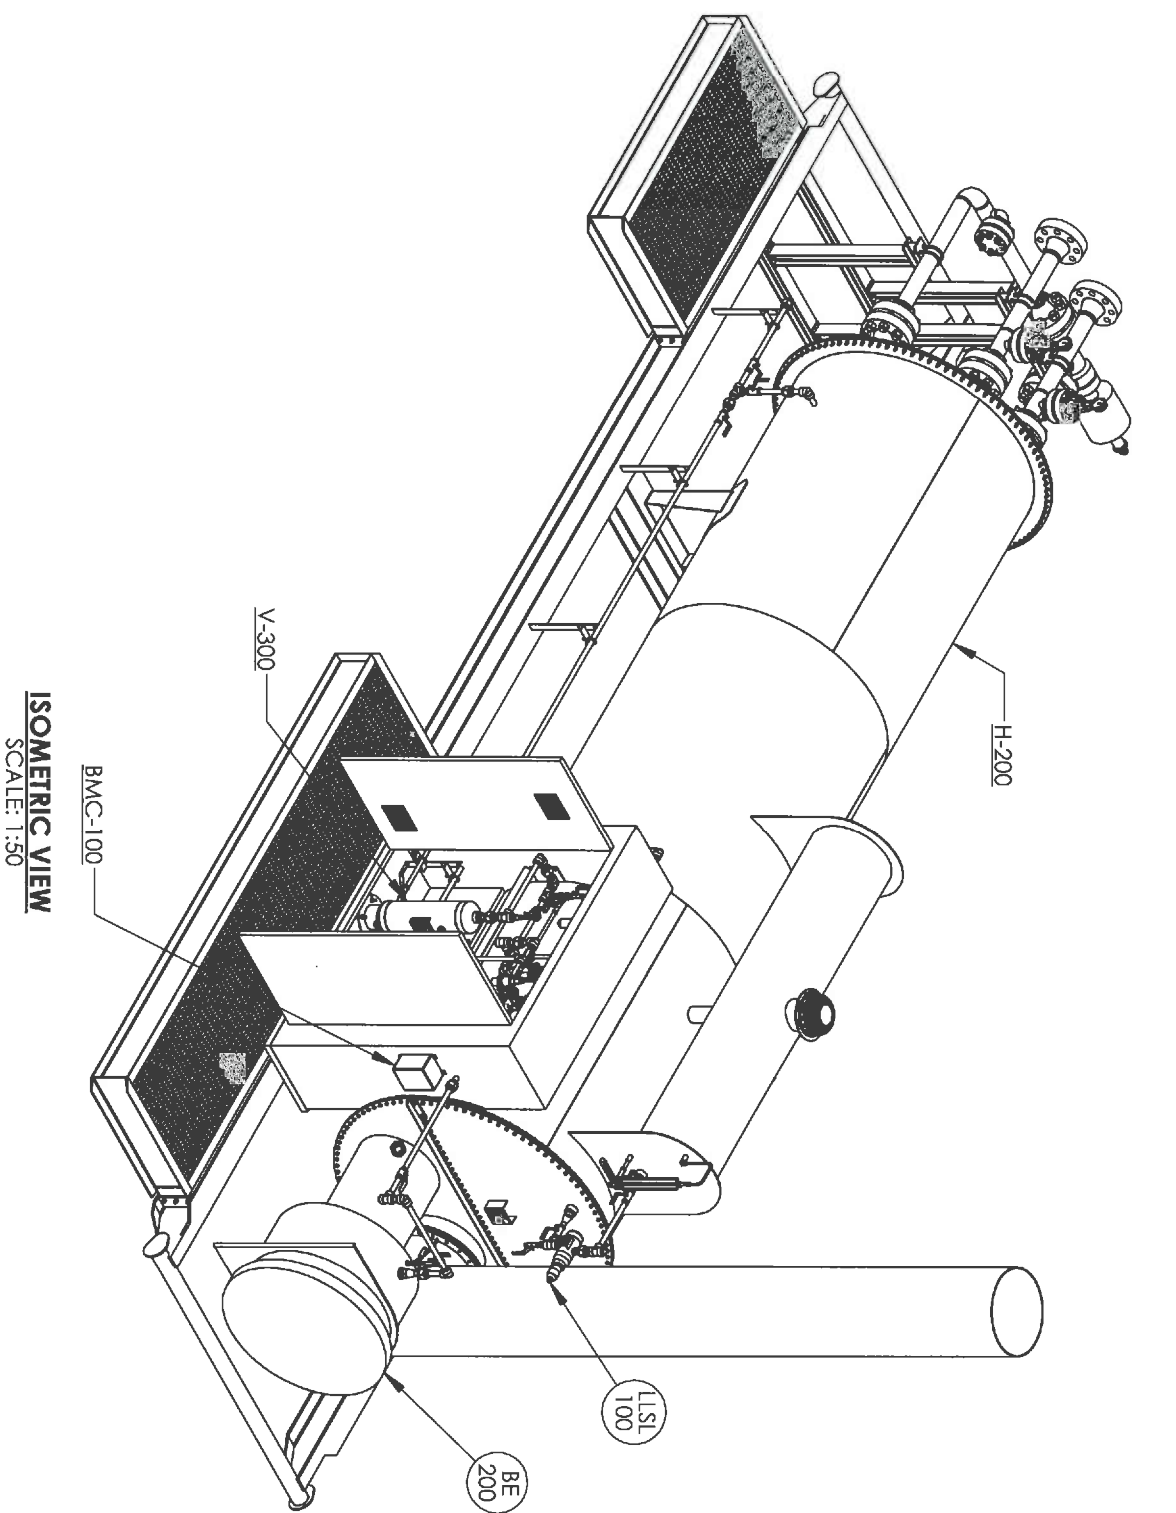

- NOTES**
1. 24 oz. PNEUMATIC TEST REQUIRED ON SHELL & FIRETUBE.
 2. PIPE SUPPORTS WHERE REQUIRED.
 3. SHIP LOOSE ITEMS TO BE BOXED AND SEALED PRIOR TO SHIPMENT.
 4. PLUG ALL OUTLETS PRIOR TO SHIPMENT.
 5. LOUVERS MUST BE LOCATED AS SHOWN IN THIS ORIENTATION.
 6. HEAT MEDIUM APPROXIMATE VOLUME IS 470 CU FT.

LH-7224-BARE	WELDED BATH ASSEMBLY								
LH-PH-7224-1	PREHEAT PIPING								
LH-LAD-72	LADDER ASSEMBLY								
LH-FIRSTK-24-2	WELDED FIRETUBE / STACK ASSEMBLY								
08562-6/08562-11	SKID,SHELL,LADDER,PREHEAT PIPING ASSE/ENCLOSURE DRAWING								
08562-3/08562-4	SKID ASSEMBLY / COIL ASSEMBLY	0	OCT 31/12	VW					
08562-1/08562-2	P&ID / PIPING ASSEMBLIES	A	OCT 01/12	VW					
DOCUMENT NO.	DESCRIPTION	REV	DATE	BY	CHK	APP			
DRAWING REVISIONS									

ISSUED FOR
CONSTRUCTION

SIGNED: _____
DATE: _____

W.O.: _____
S/N: _____

ALL DIMENSIONS IN INCHES



NWP
INDUSTRIES INC.
Total oilfield supply.

P.O. BOX 6280, INNISFAIL, AB T4G 1S9
PH: (403) 227-4100 FAX: (403) 227-4102

THIS DRAWING IS PROPERTY OF NWP INDUSTRIES INC.
AND MAY NOT BE REPRODUCED WITHOUT PERMISSION.
THIS DRAWING MUST BE RETURNED UPON REQUEST.

ENCANA PO # P041978
08562-001
08562-002

SHIPPING DATA		
OVERALL HEIGHT	11' - 6 7/8"	
OVERALL LENGTH	37' - 5"	
OVERALL WIDTH	10' - 5"	
APPROX. WEIGHT	33200 BLS	

ENCANA CORPORATION
LINEHEATER PACKAGE
3.0 MMBTU

C/W 4"-2500# RTJ SPLIT COILS

GENERAL ARRANGEMENT

DWN: VW CHK: APP:
DATE: OCT 01/12 DA **NOV 02 2012** DA **NOV 02 2012**

SCALE: 1:50 DWG: **08562** REV: **0**
SHEET: 1 OF 3

ORIGINAL

