


L:\032269\22269-6902-0001.dwg, 2/22/2005 7:35:16 PM, g\ofaa, STN-0431

LEGEND	
	POWER TRANSFORMER
	PLUG IN DEVICE
	CIRCUIT BREAKER AF - AMP FRAME AT - AMP TRIP
	FUSE
	CONTACTOR WITH 120V HOLDING COIL # INDICATES CONTACTOR SIZE
	THERMAL OVERLOADS
	POTENTIAL TRANSFORMER
	CURRENT TRANSFORMER
	AMMETER SWITCH
	AMMETER
	VOLTMETER SWITCH
	VOLTMETER
	MOTOR # INDICATES HORSEPOWER
	THERMOSTAT
	VARIABLE FREQUENCY DRIVE
	SPEED SELECT
	CONTROL STATION LETTER INDICATES CONTROL FUNCTION A - STOP/START B - ON/OFF C - FORWARD/STOP/REVERSE D - HAND/OFF/AUTO E - FAST/SLOW F - LOCKOUT STOP T - THERMISTOR

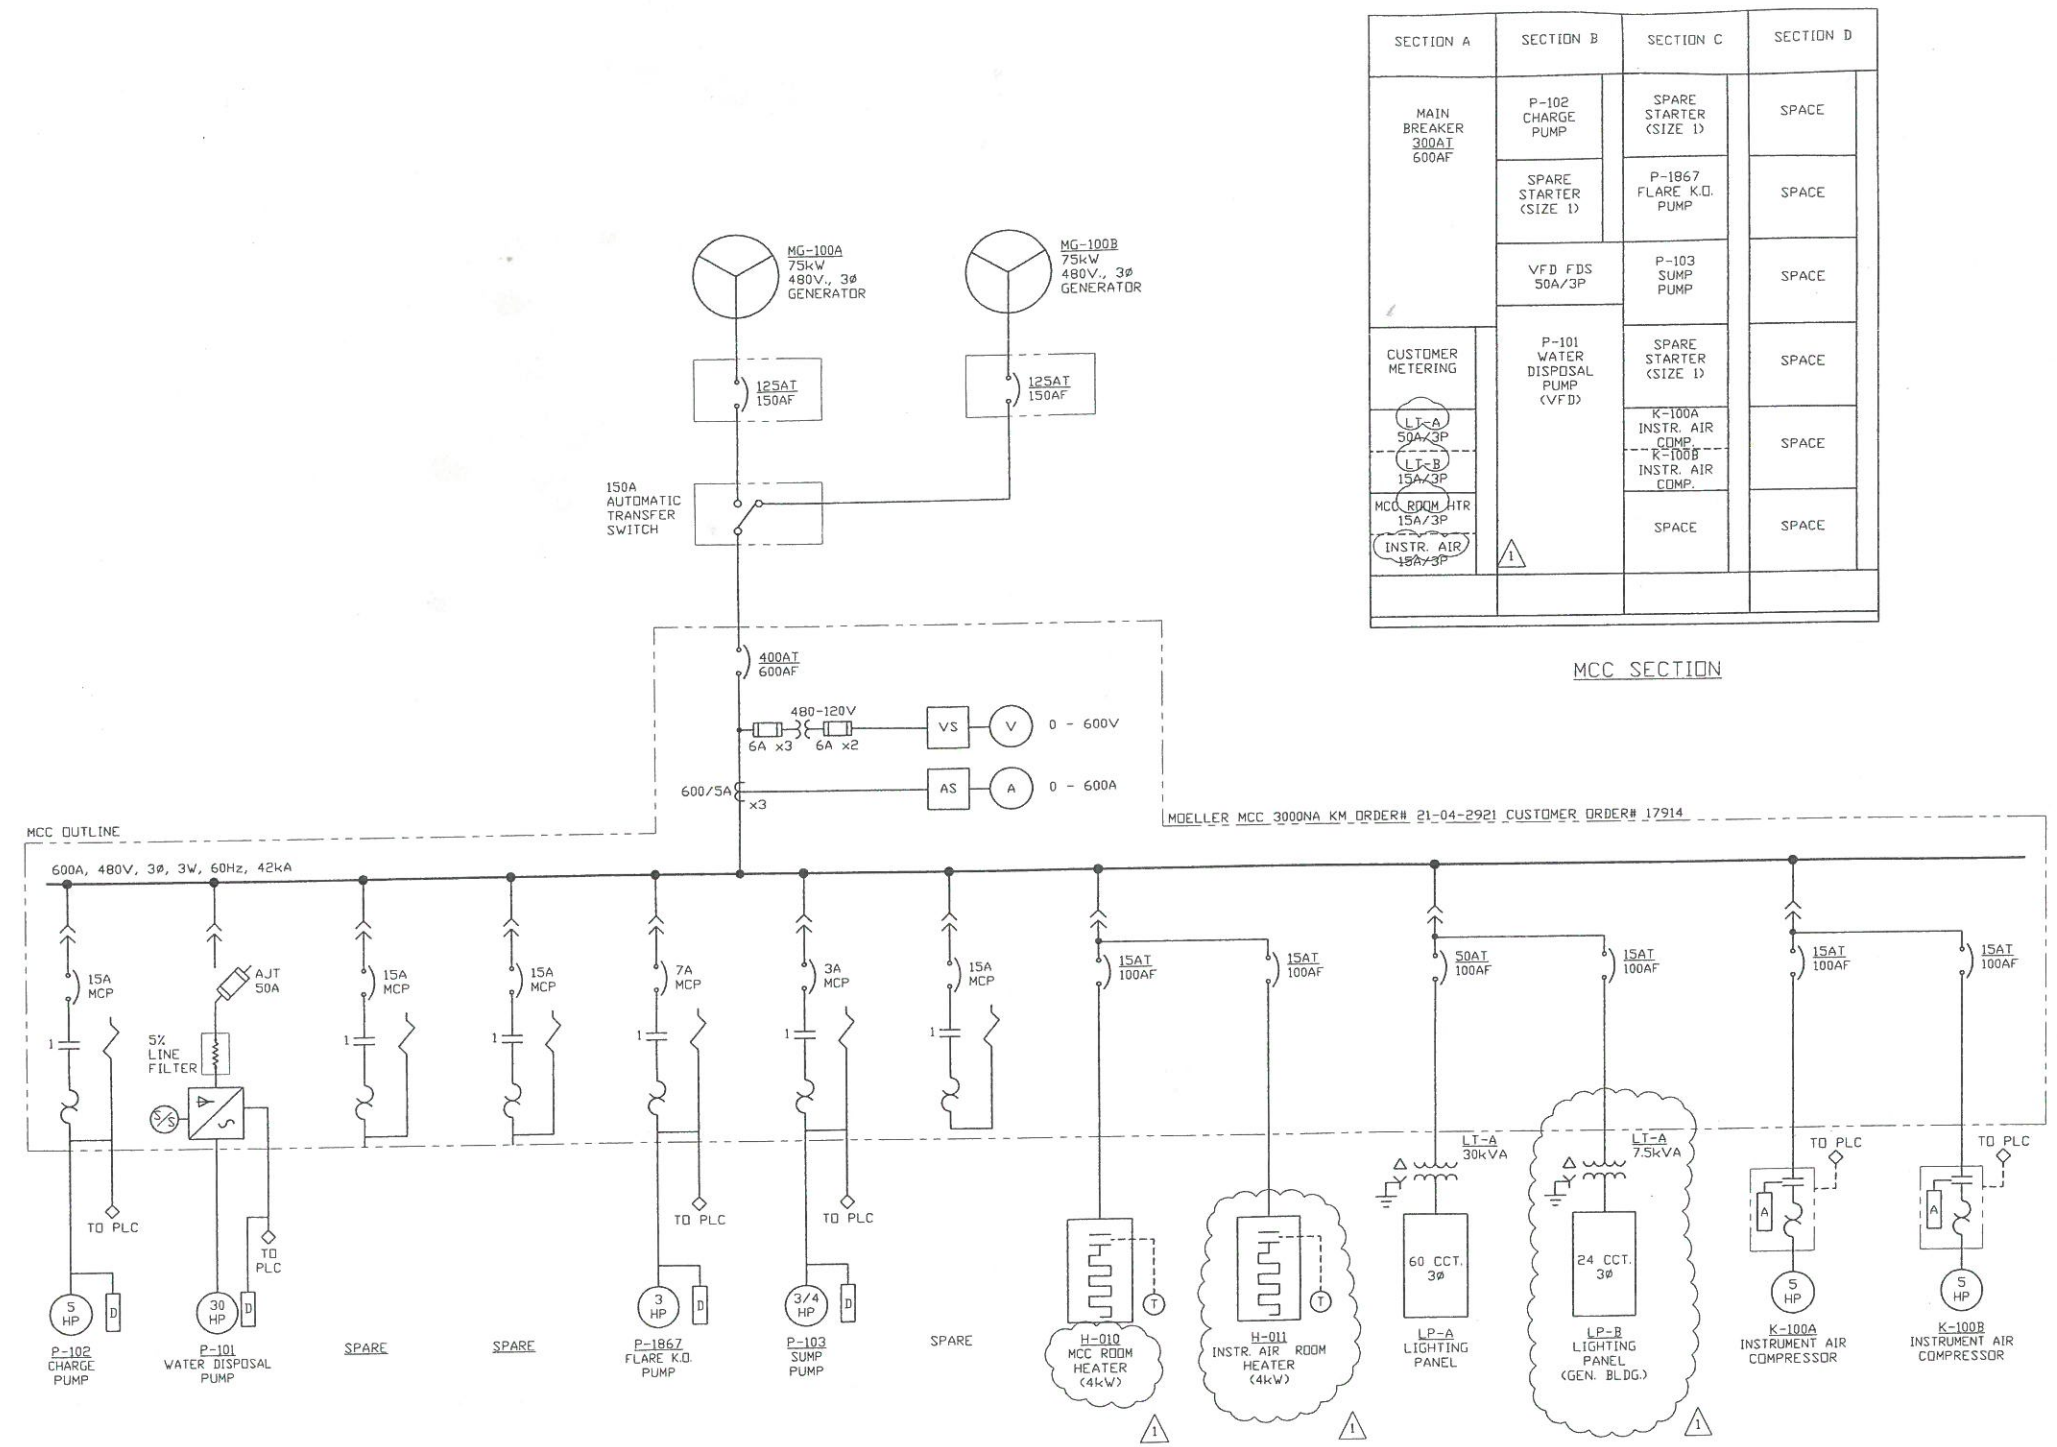

SECTION A	SECTION B	SECTION C	SECTION D
MAIN BREAKER 300AT 600AF	P-102 CHARGE PUMP	SPARE STARTER (SIZE 1)	SPACE
	SPARE STARTER (SIZE 1)	P-1867 FLARE K.O. PUMP	SPACE
	VFD FDS 50A/3P	P-103 SUMP PUMP	SPACE
CUSTOMER METERING	P-101 WATER DISPOSAL PUMP (VFD)	SPARE STARTER (SIZE 1)	SPACE
LT-A 50A/3P		K-100A INSTR. AIR COMP.	SPACE
LT-B 15A/3P		K-100B INSTR. AIR COMP.	SPACE
MCC ROOM HTR 15A/3P			SPACE
INSTR. AIR 15A/3P			SPACE

MCC SECTION

REFERENCE DRAWINGS		REVISION		BY DATE/CHK.	
NUMBER	TITLE	NO.	DESCRIPTION	CC	DD
		0	ISSUED FOR CONSTRUCTION	CC	DD
		1	REVISED AS NOTED	AG	DD

PERMIT TO PRACTICE DJA ENGINEERING SERVICES DATE: 2005-02-20 PERMIT NUMBER: P 5056 THE ASSOCIATION OF PROFESSIONAL ENGINEERS, GEOLOGISTS AND GEOPHYSICISTS OF ALBERTA		DJA ENGINEERING SERVICES CALGARY, ALBERTA	PARAMOUNT RESOURCES MARTEN COMPRESSOR LSD 03-01-79-06 W5M 480VAC SINGLE LINE DIAGRAM
--	--	--	---

DRAWN BY: C.CIOFFI	CHECKED BY: D.DAUD	APPROVED BY: D.ANDREWS	DATE: 2004-11-23	SCALE: N.T.S.	A1	D-MT0301-E-02.01	REV. 1
--------------------	--------------------	------------------------	------------------	---------------	----	------------------	--------

Drawing: 032269-6902-0001.dwg / Date: 2005-02-20 / Time: 20:06 / User ID: AG