


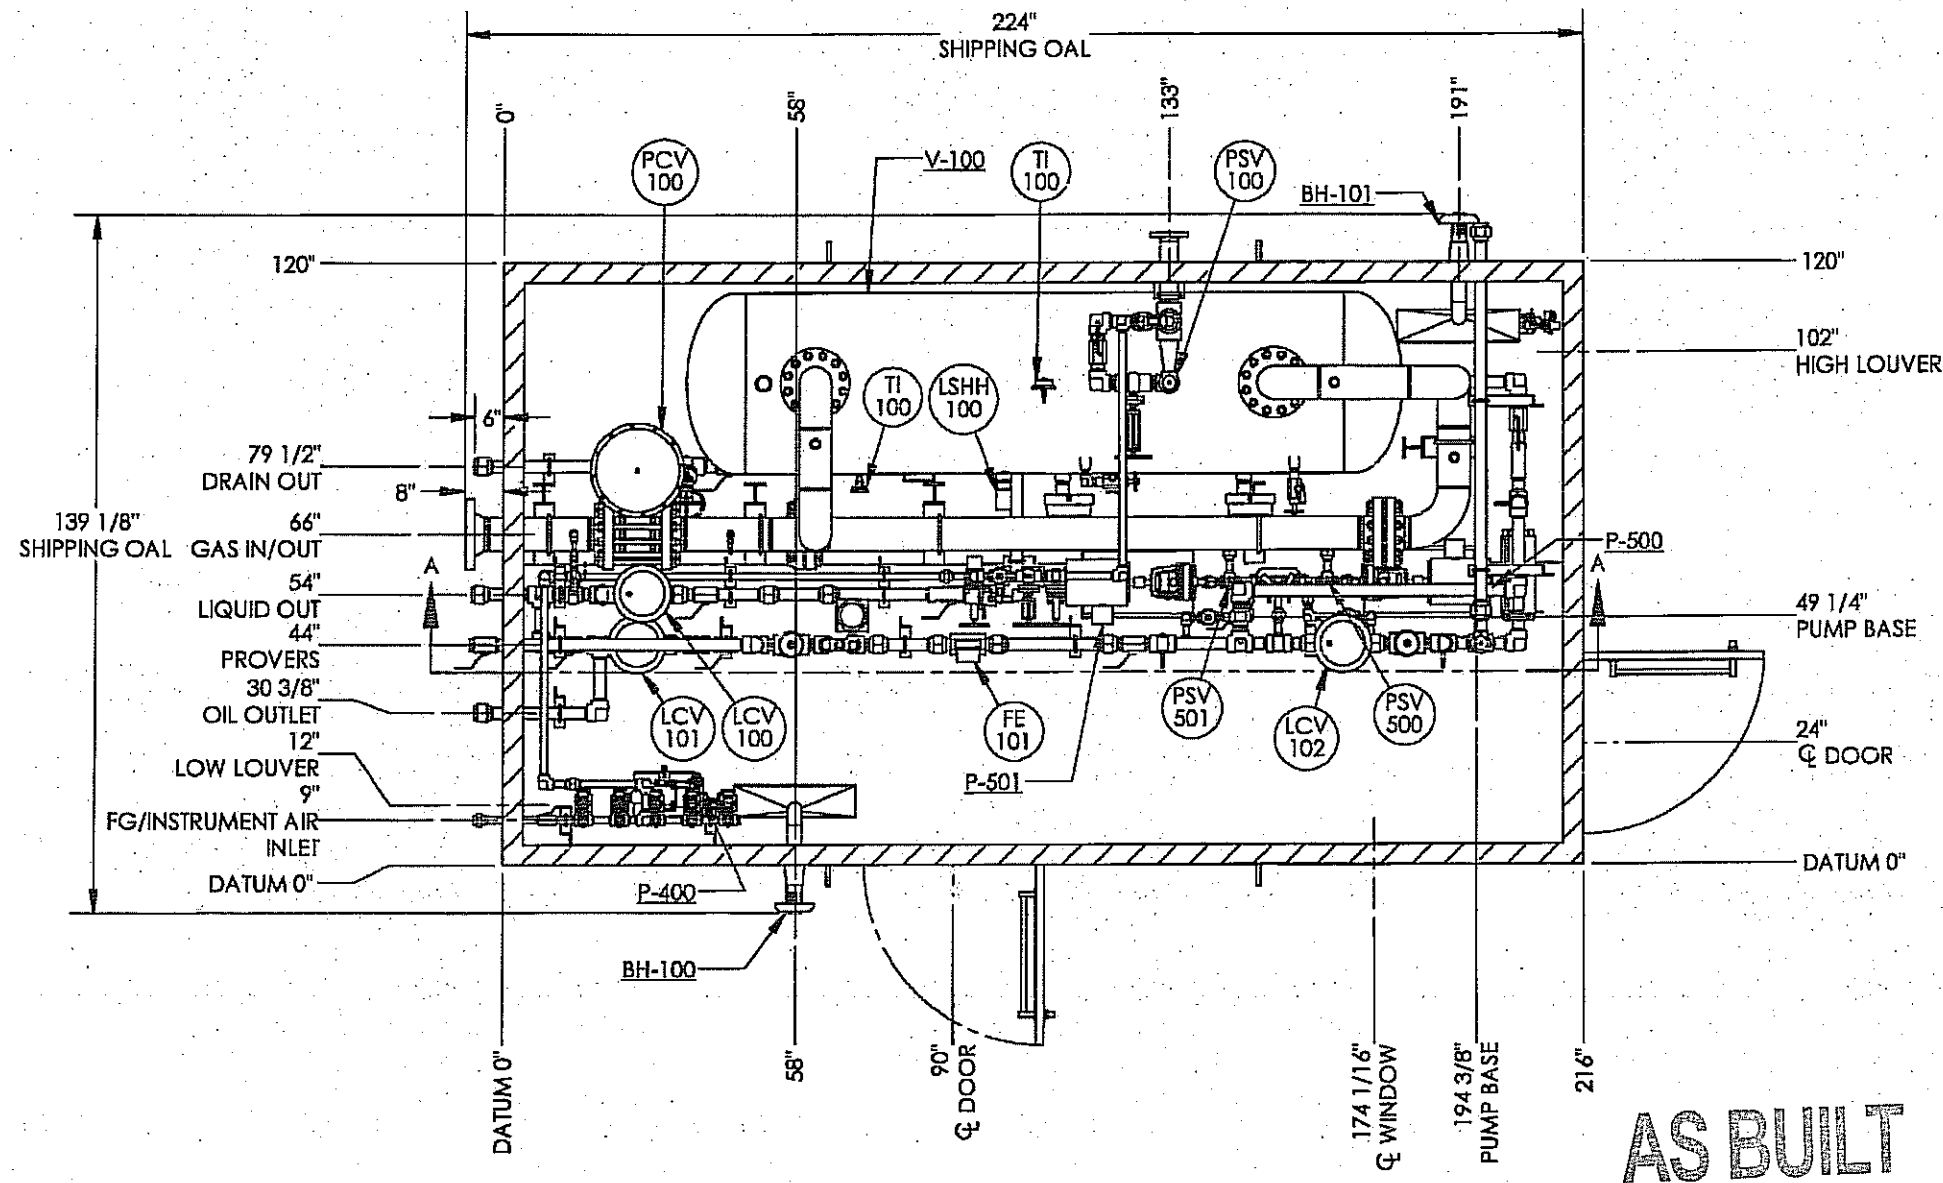

PLAN VIEW
SCALE: 1:36

AS BUILT

ORIGINAL

NOTES

1. PIPE SUPPORTS WHERE REQUIRED.
2. ALL PNEUMATIC VALVES AND INSTRUMENTS TO BE FUNCTIONED TESTED WITH 75 PSI SHOP AIR.
3. SHIP LOOSE ITEMS TO BE BOXED AND SEALED PRIOR TO SHIPMENT.
4. PLUG ALL OUTLETS PRIOR TO SHIPMENT.

SHIPPING DATA	
OVERALL HEIGHT	10' - 8 5/8"
OVERALL LENGTH	18' - 8"
OVERALL WIDTH	11' - 7 1/8"
APPROX. WEIGHT	18,000 LBS

DOCUMENT NO.	DESCRIPTION	REV	DATE	BY	CHK	APP	DRAWING REVISIONS
08246-3	SKID ASSEMBLY	2	2012.02.15	MSZ	GH	DF	RFDC #00774, CLIENT CHANGE ORDER
08246-2	PIPING ASSEMBLY	1	2012.02.06	JHK	GH	DF	RFDC #00774 AS PER CLIENT PIPING CHANGES
08246-1	PIPING AND INSTRUMENTATION DIAGRAM	0	2012.01.13	JHK	GH	DF	ISSUED FOR CONSTRUCTION
		A	2011.01.06	JHK	-	-	ISSUED FOR APPROVAL

ISSUED FOR CONSTRUCTION

SIGNED: _____

DATE: _____

W.O.: 08246

S.O.: _____


ALL DIMENSIONS IN INCHES

NWP
INDUSTRIES INC.
Total oilfield supply.


P.O. BOX 6280, INNISFAIL, AB T4G 1S9
PH: (403) 227-4100 FAX: (403) 227-4102

THIS DRAWING IS PROPERTY OF NWP INDUSTRIES INC.
AND MAY NOT BE REPRODUCED WITHOUT PERMISSION.
THIS DRAWING MUST BE RETURNED UPON REQUEST.

PERPETUAL ENERGY HORIZONTAL SEPARATOR PACKAGE 36" OD x 10' S/S 1440 PSI SWEET SERVICE GENERAL ARRANGEMENT		
DWN: JHK	CHK: GH	APP: DF
DATE: 2012.01.06	DATE: 2012.01.26	DATE: 2012.01.25
SCALE: 1:36	DWG: 08246	REV: 2
SHEET: 1 OF 3		

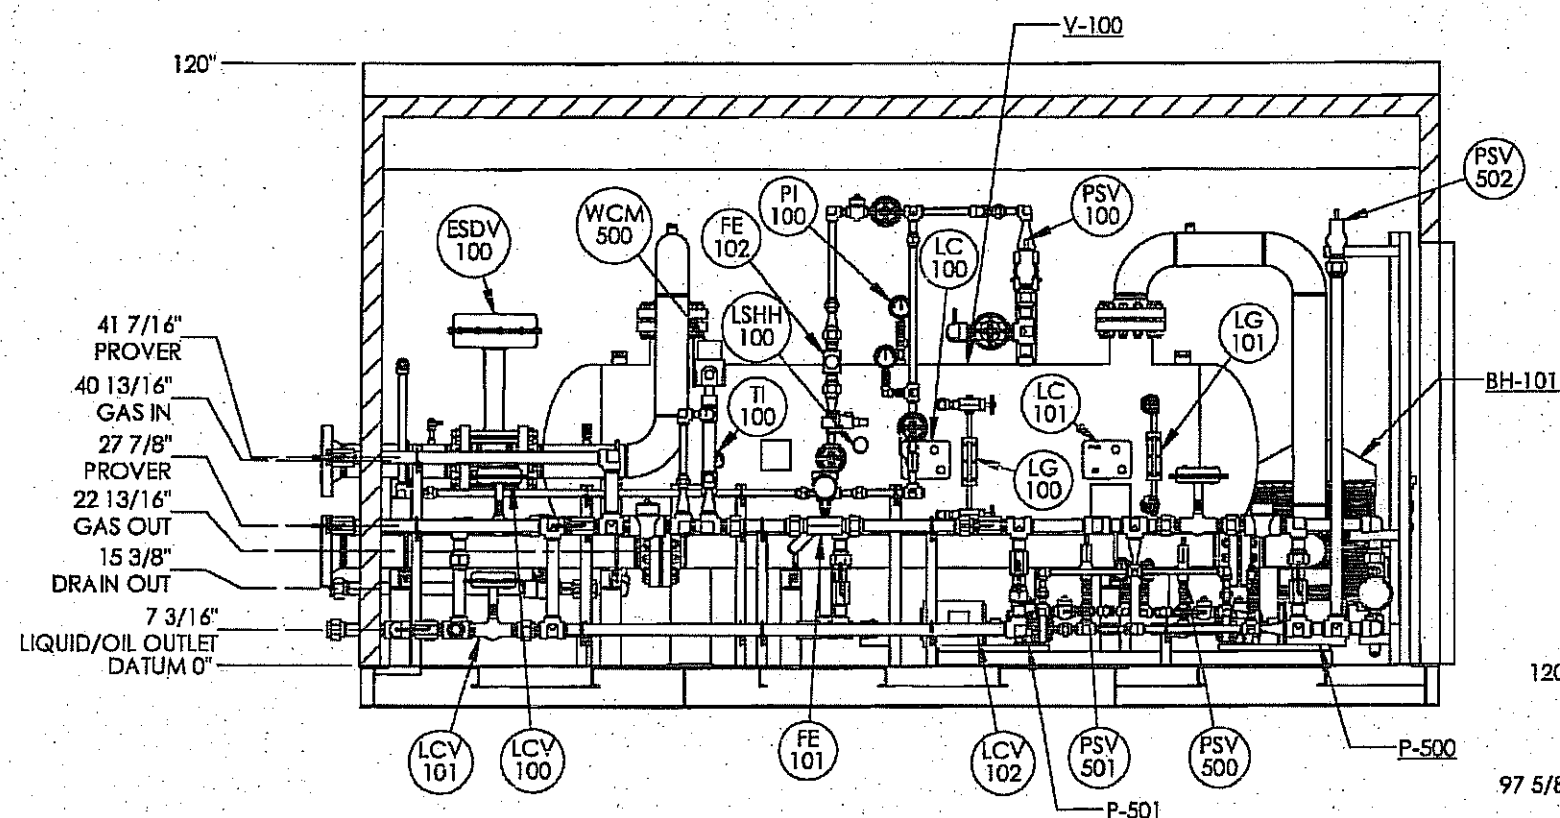

SECTION A-A
SCALE: 1:36

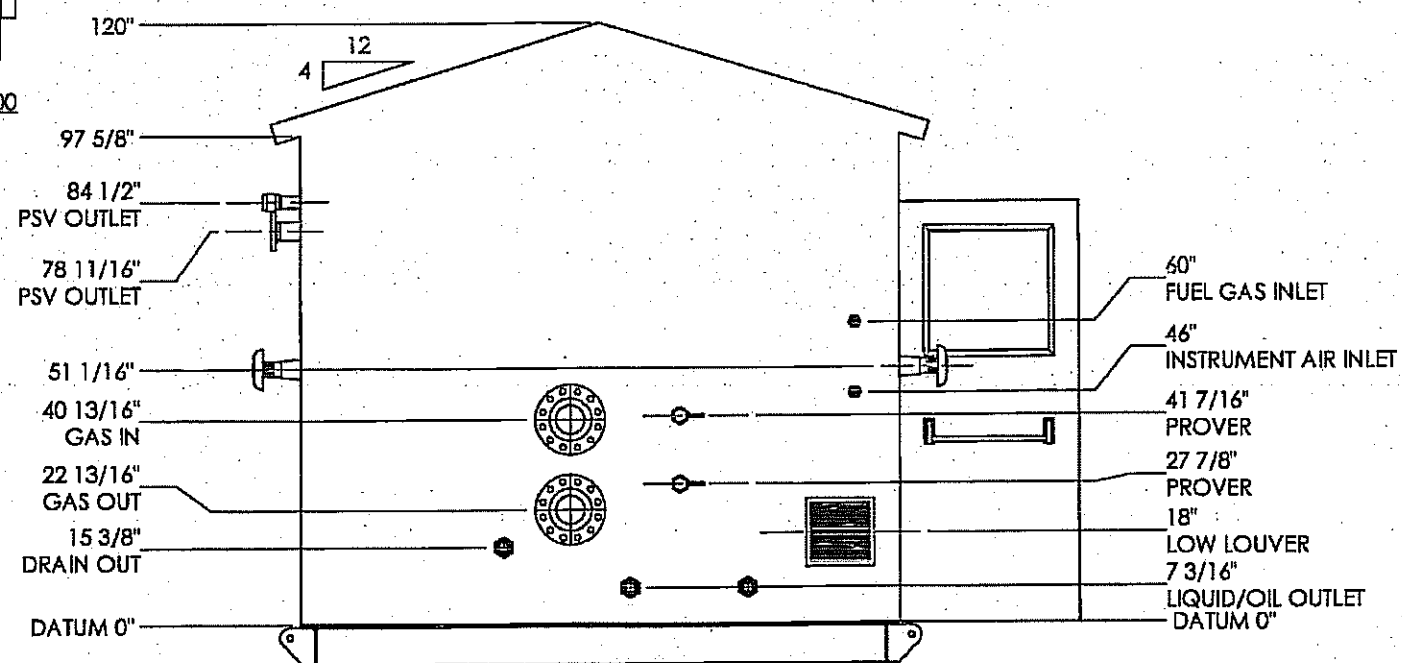

LEFT END VIEW
SCALE: 1:36

ORIGINAL
AS BUILT

DOCUMENT NO.	DESCRIPTION	REV	DATE	BY	CHK	APP	REFERENCE DRAWINGS
08246-3	SKID ASSEMBLY	2	2012.02.15	MSZ	JHK	DF	RFDC #00774, CLIENT CHANGE ORDER
08246-2	PIPING ASSEMBLY	1	2012.02.06	JHK	GH	DF	RFDC #00774 AS PER CLIENT PIPING CHANGES
08246-1	PIPING AND INSTRUMENTATION DIAGRAM	0	2012.01.13	JHK	GH	DF	ISSUED FOR CONSTRUCTION
		A	2011.01.06	JHK	-	-	ISSUED FOR APPROVAL

ISSUED FOR
CONSTRUCTION

SIGNED: _____

DATE: _____

W.O.: 08246

S.O.: _____

ALL DIMENSIONS IN INCHES




P.O. BOX 6280, INNISFAIR, AB T4G 1S9
PH: (403) 227-4100 FAX: (403) 227-4102


THIS DRAWING IS PROPERTY OF NWP INDUSTRIES INC.
AND MAY NOT BE REPRODUCED WITHOUT PERMISSION.
THIS DRAWING MUST BE RETURNED UPON REQUEST.

PERPETUAL ENERGY
HORIZONTAL SEPARATOR PACKAGE
36" OD x 10' S/S 1440 PSI
SWEET SERVICE
GENERAL ARRANGEMENT

DWN: JHK	CHK: GH	APP: DF
DATE: 2012.01.06	DATE: 2012.01.26	DATE: 2012.01.25
SCALE: 1:36	DWG: 08246	REV: 2
SHEET: 2 OF 3		

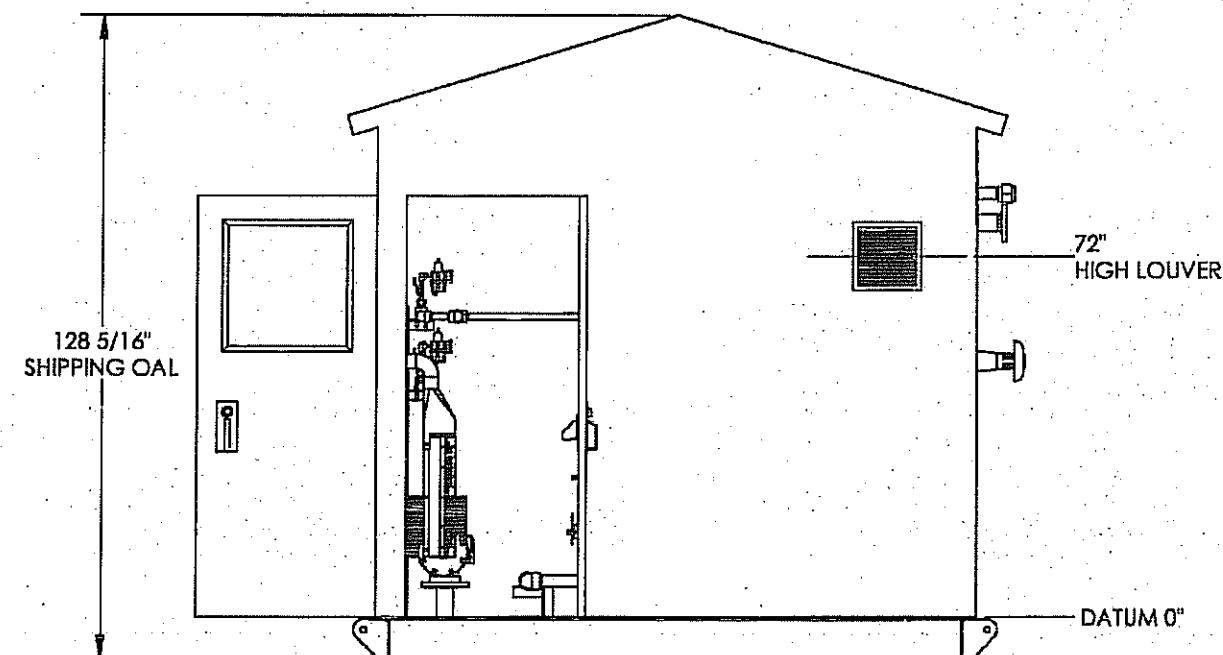

RIGHT END VIEW
SCALE: 1:36

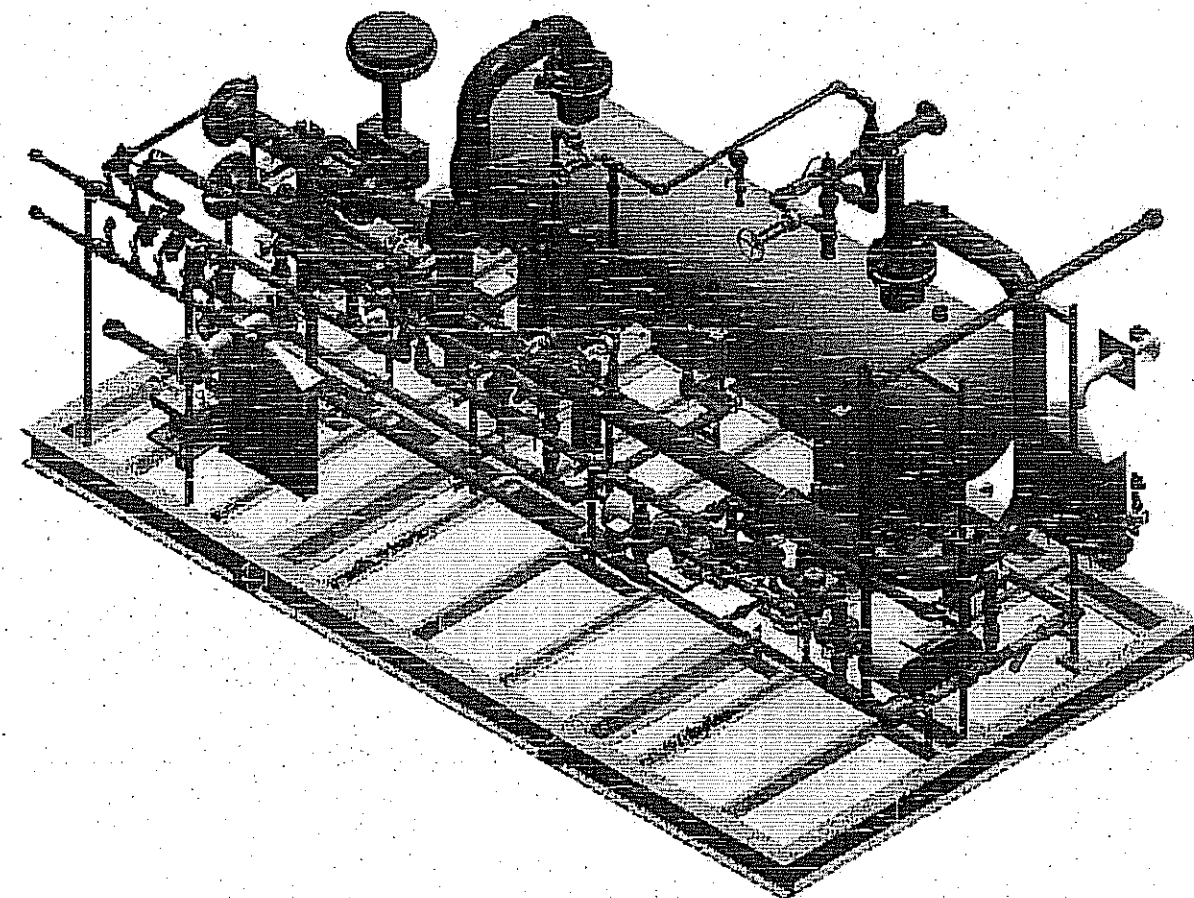

ISOMETRIC VIEW
w/o BUILDING
SCALE: 1:36

ORIGINAL
AS BUILT

DOCUMENT NO.	DESCRIPTION	REV	DATE	BY	CHK	APP
08246-3	SKID ASSEMBLY	2	2012.02.15	MSZ	MS	DF
08246-2	PIPING ASSEMBLY	1	2012.02.06	JHK	GH	DF
08246-1	PIPING AND INSTRUMENTATION DIAGRAM	0	2012.01.13	JHK	GH	DF
		A	2011.01.06	JHK	-	-

ISSUED FOR CONSTRUCTION

SIGNED: _____

DATE: _____

w.o.: 08246

S.O.: _____

ALL DIMENSIONS IN INCHES

NWP INDUSTRIES INC.
Total oilfield supply.

P.O. BOX 6280, INNISFAIL, AB T4G 1S9
PH: (403) 227-4100 FAX: (403) 227-4102

THIS DRAWING IS PROPERTY OF NWP INDUSTRIES INC.
AND MAY NOT BE REPRODUCED WITHOUT PERMISSION.
THIS DRAWING MUST BE RETURNED UPON REQUEST.

PERPETUAL ENERGY HORIZONTAL SEPARATOR PACKAGE 36" OD x 10' S/S 1440 PSI SWEET SERVICE GENERAL ARRANGEMENT		
DWN: JHK	CHK: GH	APP: DF
DATE: 2012.01.06	DATE: 2012.01.26	DATE: 2012.01.25
SCALE: 1:36	DWG: 08246	REV: 2
SHEET: 3 OF 3		