


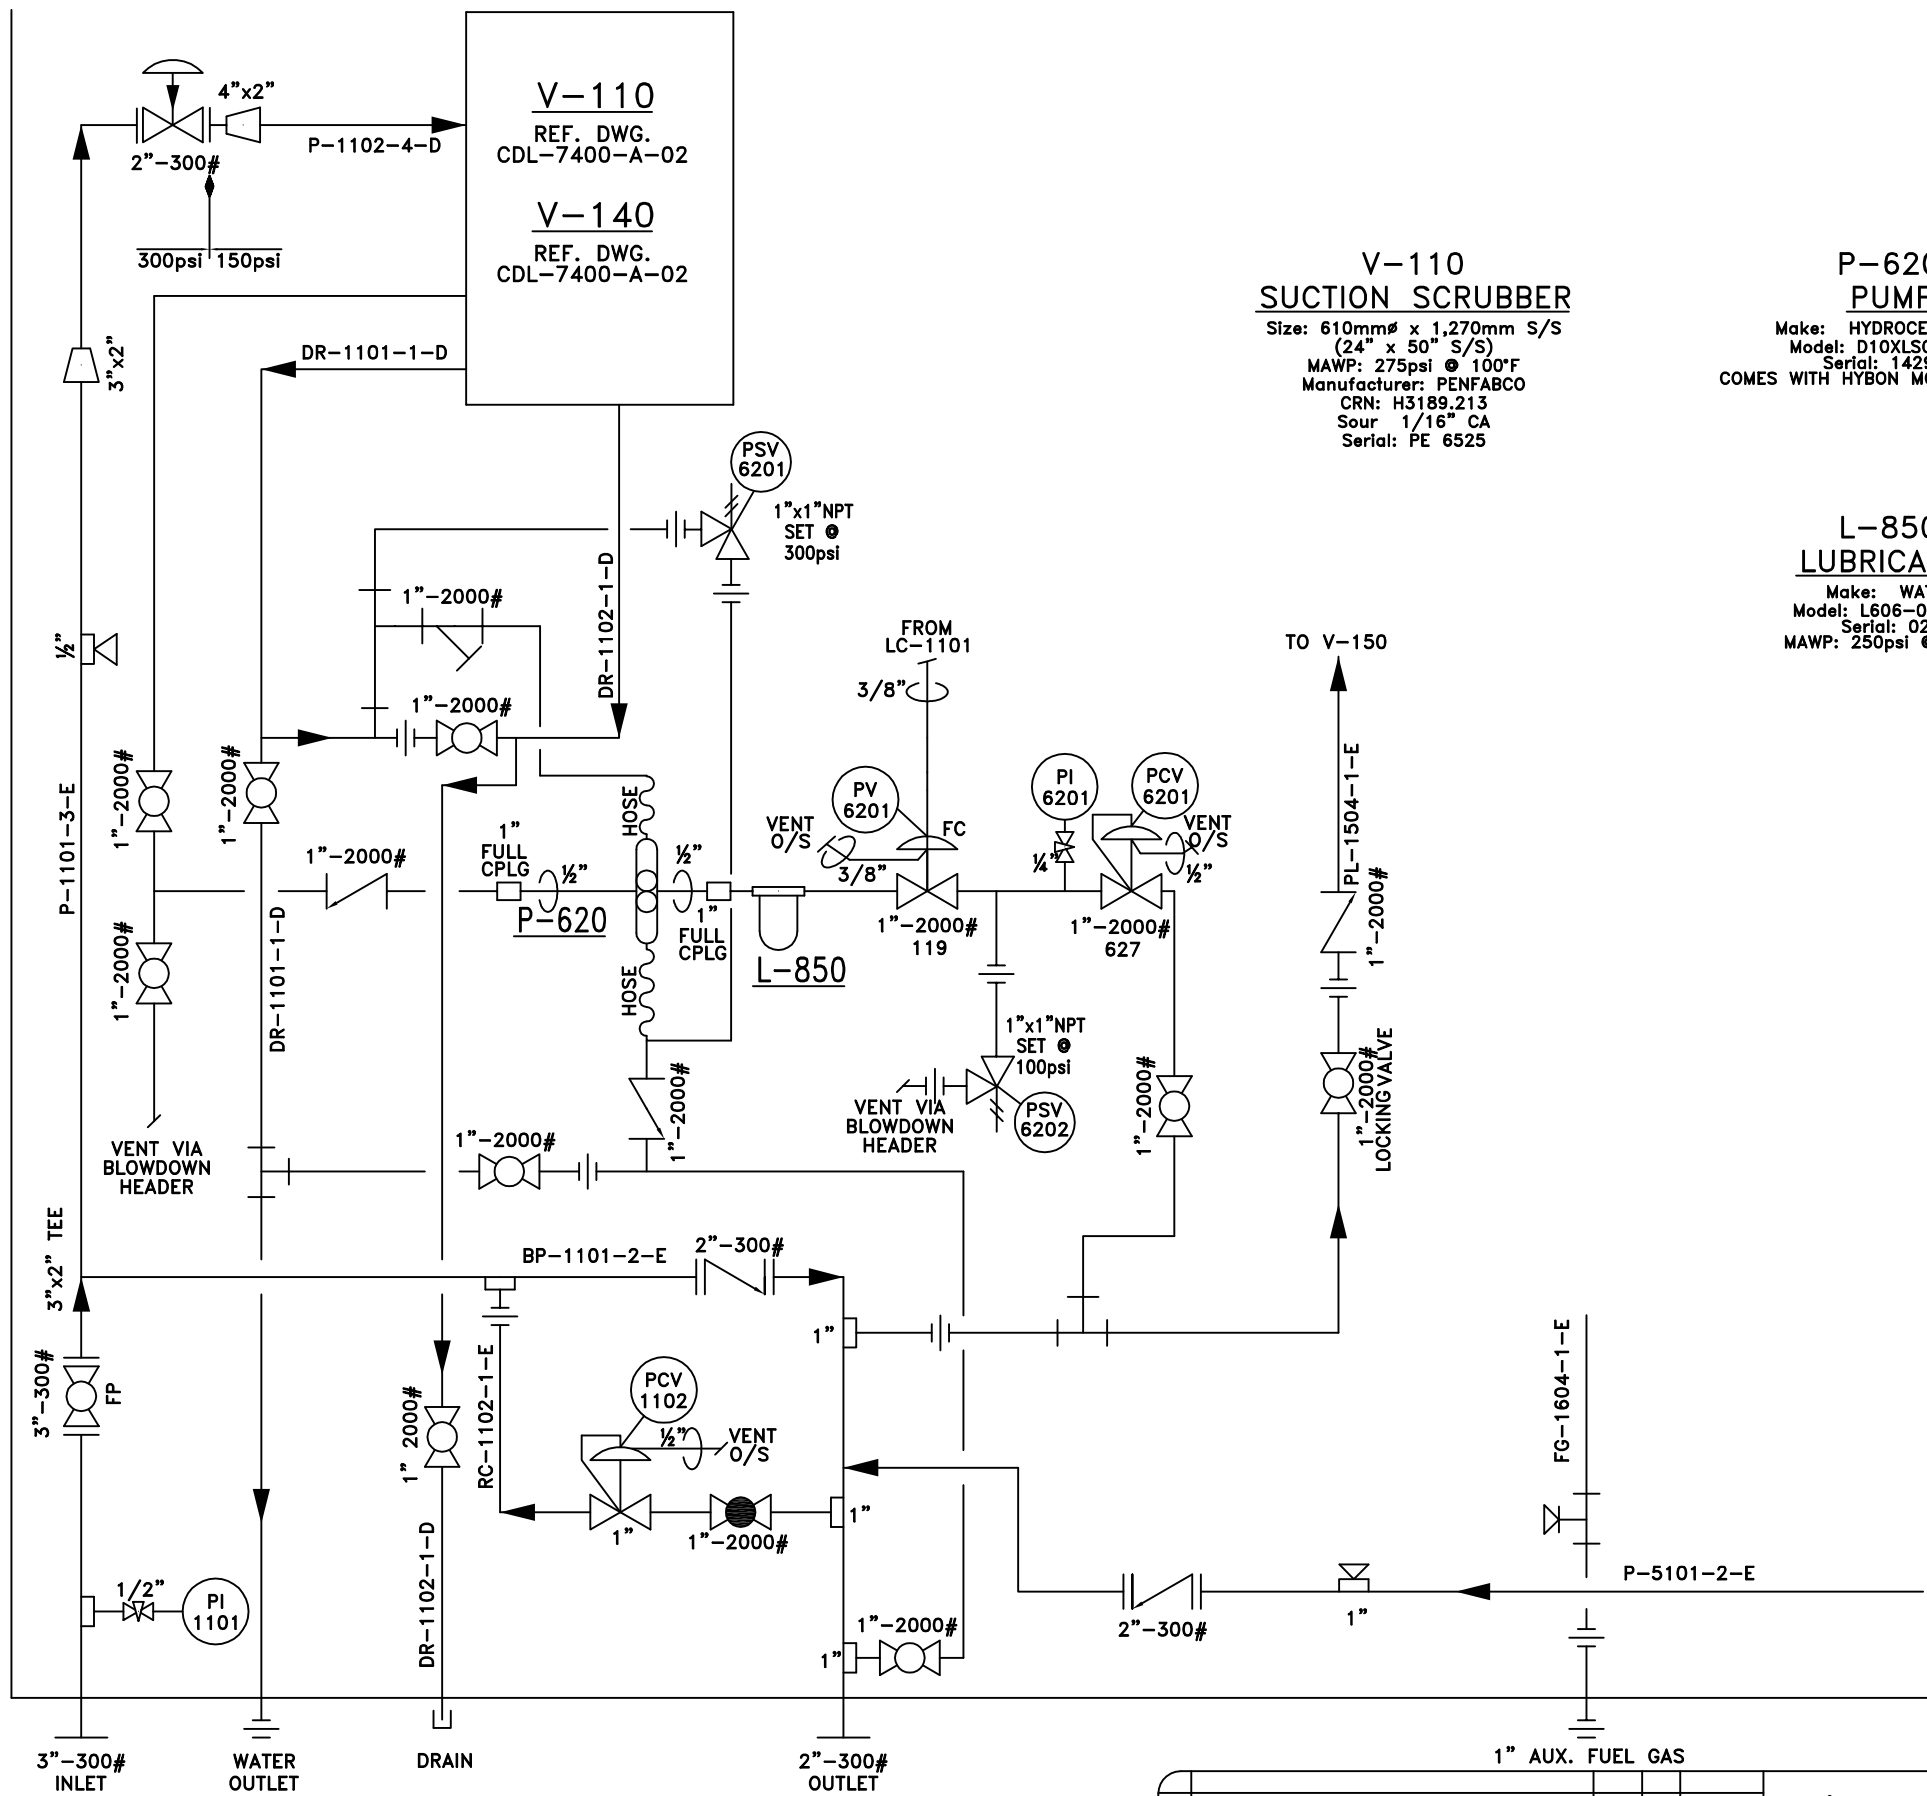

V-110
SUCTION SCRUBBER
Size: 610mmØ x 1,270mm S/S
(24" x 50" S/S)
MAWP: 275psi @ 100°F
Manufacturer: PENFABCO
CRN: H3189.213
Sour 1/16" CA
Serial: PE 6525

P-620
PUMP
Make: HYDROCELL PUMP
Model: D10XLGSHHBB
Serial: 142993
COMES WITH HYBON MODEL OF DRIVE

L-850
LUBRICATOR
Make: WATTS
Model: L606-08W M8
Serial: 021
MAWP: 250psi @ 150°F

MATERIAL LIST			
ITEM	DESCRIPTION	MAKE	MODEL
PSV-6201	PRESSURE SAFETY VALVE, SET @ 300psi, CAP 631	MERCER	91170511807ES
PV-6201	SWITCH VALVE, SET @ 5-35psi, 1/2" PORT	FISHER	119-N12
PCV-6201	PRESSURE CONTROL VALVE SET@70-150psi 1/2"PORT	FISHER	627-559
PI-6201	PRESSURE INDICATOR 1/4" LM x 2 1/2",0-300psi/0-2100KPA	WESTERN	SSLF
PSV-6202	PRESSURE SAFETY VALVE, SET @ 100 psi, CAP 228	MERCER	9117051W06E1S

RE-INJECTION PUMP OPTION #2

LINE TYPE LEGEND	MAIN PROCESS GAS	OIL/GAS COMBINED	UTILITY PROCESS
SKID BOUNDARY	SECONDARY PROCESS	INSTRUMENTATION	OIL ONLY LINE

REV.	DESCRIPTION	BY	APP.	DATE
1	ADDED PUMP, SC-595-C1 AS BUILT	SDC		02-06-06
0	ADDED PUMP, SC-595-C1	MEW		02-06-04



Jiro
5221-46 St.
Box 1450, Stettler Alberta
T0C 2L0
Phone: 403.742.5538
Fax: 403.742.5539

JIRO COMPRESSION LTD.
an EnSource company

CADD Department E-mail
cad@jirocompression.com

7400 SERIES COMPRESSOR
MYCOM 160VSRD-1.809 w/ CAT 3306NA
TRAILER, SOUR RENTAL

COMPANY:
CONOCO

JOB NO.:
74133

Drawn by:
WST

Checked by:

Approved by:

DATE:
00-07-04

SCALE:
N.T.S.


DRAWING NO.:
CDL-74133-A-01A

REV.:
1

V-110
INLET SCRUBBER
Size: 610mmø x 1,219mm S/S
(24" x 48" S/S)
MAWP: 275psi @ 100°F
Make: PENFABCO
CRN: H3189,213
Sour 1/16" CA
Serial: -

MATERIAL LIST

ITEM	DESCRIPTION	MAKE	MODEL
LSH-1101	LEVEL SWITCH HIGH	MURPHY	L1200
LC-1101	LEVEL CONTROLLER	FISHER	2680A
LI-1101	LEVEL INDICATOR, C/W 330J VALVES	PENBERTHY	1RM-7 STLNE
PSV-1101	PRESSURE SAFETY VALVE SET @ 150 PSI	MERCER	9123F5117095
LCV-1101	DUMPVALVE 1/2" PORT FC	FISHER	128PQC

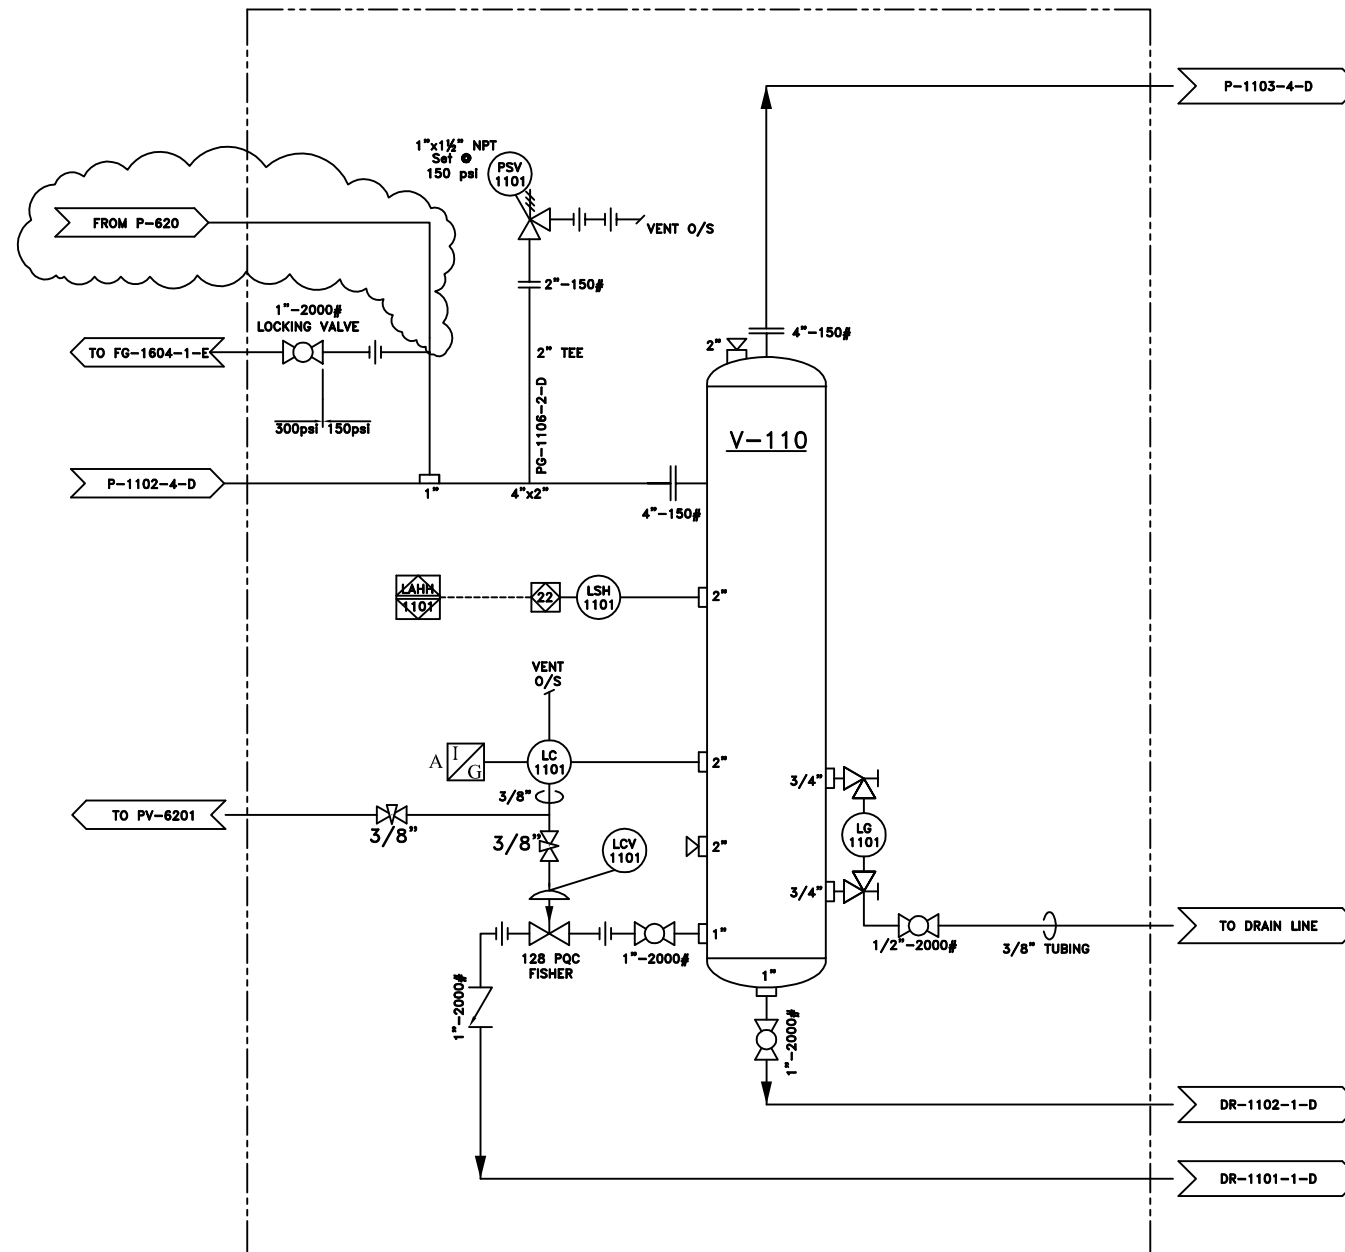

* SEE DWG CDL-74133-A-01
FOR COMPLETE 7400 P&ID

PIPING AND INSTRUMENTATION DIAGRAM

LINE TYPE LEGEND	MAIN PROCESS GAS	OIL/GAS COMBINED	UTILITY PROCESS
SKID BOUNDARY	SECONDARY PROCESS	INSTRUMENTATION	OIL ONLY LINE
COOLER LAYERS	WATER JACKET (FRONT)	OIL (TOP)	GAS (BOTTOM)

REV.	DESCRIPTION	BY	APP.	DATE
1	ADDED PUMP, SC-595-C1 AS BUILT	SDC		02-06-06
0	ADDED PUMP, SC-595-C1	MEW		02-06-04


Jiro
5221-46 St.
Box 1450, Stettler Alberta
T0C 2L0
Phone: 403.742.5538
Fax: 403.742.5539

JIRO COMPRESSION LTD.
an EnSource company


CADD Department E-mail
cad@enhancedenergy.com

7400 SERIES COMPRESSOR MYCOM 160VSRD-1.809 w/ CAT 3306NA TRAILER, SOUR RENTAL					COMPANY:		JOB NO.:	
					CONOCO		74133	
Drawn by:	Checked by:	Approved by:	DATE:	SCALE:	DRAWING NO.:	REV.:		
JAM			01-03-12	N.T.S.	CDL-74133-A-02A	1		

V-110 INLET SCRUBBER Size: 610mm $\varnothing$ x 1,219mm S/S (24" x 48" S/S) MAWP: 275psi @ 100°F Make: PENFABCO CRN: H3189.213 Sour 1/16" CA Serial: PE6525	V-150 OIL COALESCING VESSEL Size: 508mm $\varnothing$ x 960mm S/S (20" x 37-3/4" S/S) MAWP: 300psi @ 250°F Make: PENFABCO CRN: L8012.231 Serial: PE6967	S-210 SCREW COMPRESSOR Make: MYCOM Model: 160VSRD Gear Ratio: 1.81	H-410 HEATER Size: 305mm x 609mm (12" x 24") Model: CIS-CAN	C-510 OIL/GAS AFTER COOLER Model: API AIRTECH Size: 34.8"x41.2"x5.5"	P-610 PUMP Model: D2300F019012 Serial: E027576
V-140 INLET GAS FILTER Make: JIRO COMPRESSION LTD MAWP: 150psi @ 100°F Serial: 8-058	V-160 FUEL SCRUBBER Size: 102mm $\varnothing$ x 914mm S/S (4" x 36" S/S) Make: JIRO COMPRESSION LTD CRN: OH3977.231 Serial: 4DP-361	M-310 NATURAL GAS ENGINE Make: CATERPILLAR Model: 3306NA 145hp Serial: 07408345	H-420 HEATER Size: 305mm x 609mm (12" x 24") Model: CIS-CAN	C-520 ENGINE WATER JACKET Make: THERMAL TRANSFER Model: GHT-JIRO01	

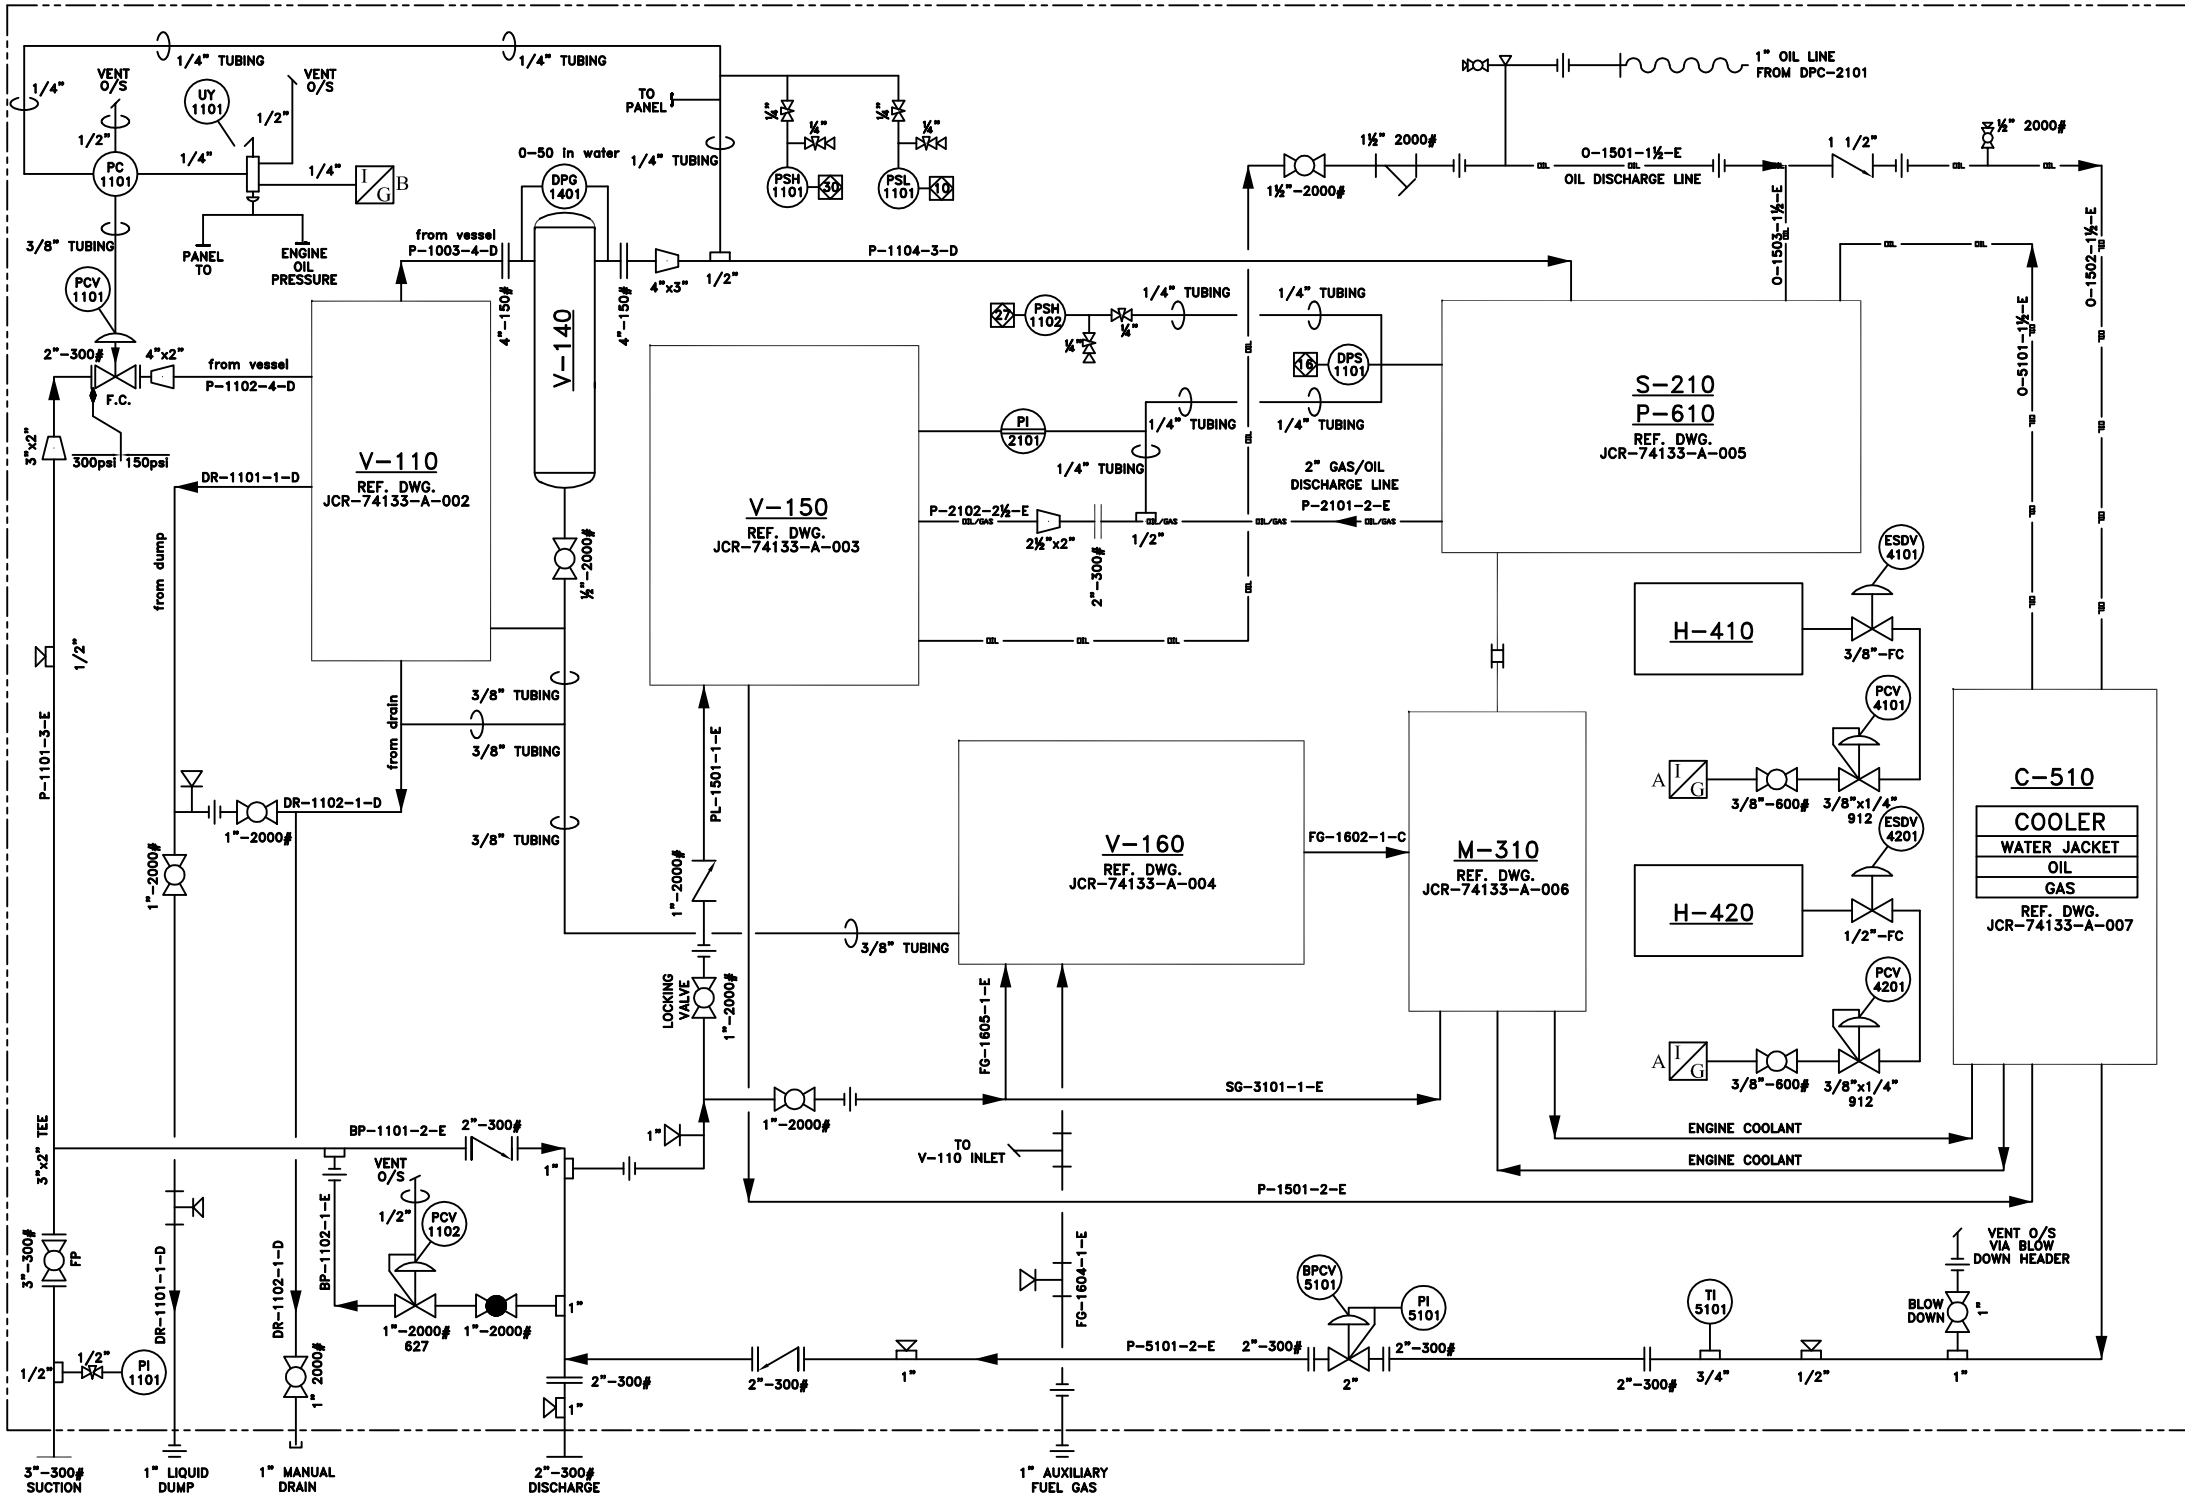

MATERIAL LIST			
ITEM	DESCRIPTION	MAKE	MODEL
PC-1101	PRESSURE CONTROLLER	FISHER	4150
PI-1101	PRESSURE INDICATOR 1/2" LM x 4 1/2"FACE, 0-300PSI/0-2000KPA	WESTERN GAUGE	-
DPS-1101	DIFFERENTIAL PRESSURE SWITCH	CUSTOM CONTROL SENSOR	604DJ2
ESDV-1101	EMERGENCY SHUT DOWN	-	-
PCV-1101	PRESSURE CONTROL VALVE - FC	FISHER	1051 V-BALL
PSL-1101	PRESSURE SWITCH LOW, Set @ 1 psi Dec.	SOR	6900GZE12
PSH-1101	PRESSURE SWITCH HIGH, Set @ 285 psi Inc.	CCS	6900GZE18
PSH-1102	PRESSURE SWITCH HIGH, Set @ 80 psi Inc.	CCS	6900GZE18
DPG-1401	DIFFERENTIAL PRESSURE GAUGE	MID WEST	141AA-00-00
TI-5101	TEMPERATURE INDICATOR 3", -40 TO 160 °F	WESTERN GAUGE	-
BPCV-5101	BACK PRESSURE CONTROL VALVE	KIMRAY	SGT-BP
PCV-1102	PRESSURE CONTROL VALVE SET @ 5-20 PSI, 1/2" PORT	FISHER	627-556
ESDV-4101	EMERGENCY SHUT DOWN	MAXITROL	ES402
PCV-4101	PRESSURE CONTROL VALVE	FISHER	912
ESDV-4201	EMERGENCY SHUT DOWN	MAXITROL	ES402
PCV-4201	PRESSURE CONTROL VALVE	FISHER	912
PI-1101	PRESSURE INDICATOR, 0-300psi	WESTERN GAUGE	-
UY-1101	PRESSURE SWITCH	AMOT	4057D025H2

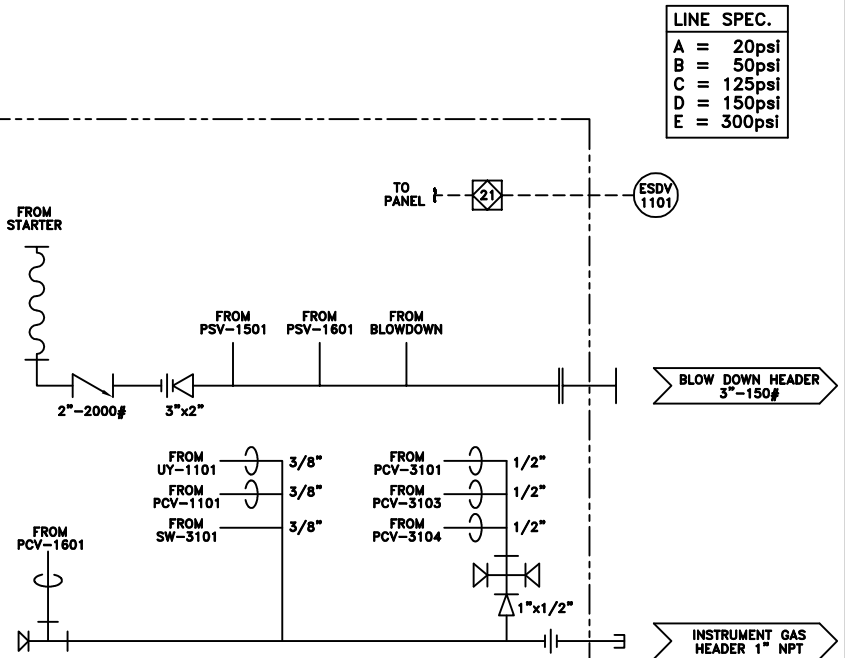

PIPING AND INSTRUMENTATION DIAGRAM

LINE TYPE	MAIN PROCESS GAS	OIL/GAS COMBINED	UTILITY PROCESS
LEDGEND	—	—	—
SKID BOUNDARY	—	—	—
SECONDARY PROCESS	—	—	—
INSTRUMENTATION	—	—	—
OIL ONLY LINE	—	—	—

COOLER LAYERS	WATER JACKET (FRONT)	OIL (TOP)	GAS (BOTTOM)
---------------	----------------------	-----------	--------------

REV.	DESCRIPTION	BY	APP.	DATE
1	AS BUILT	CRC		01-06-28
0	ISSUED FOR CONSTRUCTION	CRC		01-03-26



5221-46 St.
Box 1450, Stettler Alberta
T0C 2L0
Phone: (403) 742-5538
Fax: (403) 742-5539

JIRO COMPRESSION LTD.
an EnSource company

CADD Department E-mail
cad@enhancedenergy.com

7400 SERIES COMPRESSOR
MYCOM 160VSRD-1.809 w/ CAT 3306NA
TRAILER, SOUR RENTAL


COMPANY:	JIRO COMPRESSION		JOB NO.:	74133
Drawn by:	Checked by:	Approved by:	DATE:	01-03-12
JAM			SCALE:	N.T.S.
DRAWING NO.:	JCR-74133-A-01	REV.:	1	

V-110
INLET SCRUBBER

Size: 610mmø x 1,219mm S/S
(24" x 48" S/S)
MAWP: 275psi @ 100°F
Make: PENFABCO
CRN: H3189.213
Sour 1/16" CA
Serial: PE-6525

MATERIAL LIST

ITEM	DESCRIPTION	MAKE	MODEL
LSH-1101	LEVEL SWITCH HIGH	MURPHY	L1200
LC-1101	LEVEL CONTROLLER	FISHER	2680A
LG-1101	LEVEL GAUGE, C/W 330J VALVES	PENBERTHY	1RM-7 STLNE
PSV-1101	PRESSURE SAFETY VALVE SET @ 150 PSI	MERCER	9123F5117095
LCV-1101	DUMPVALVE 1/2" PORT FC	FISHER	128PQC

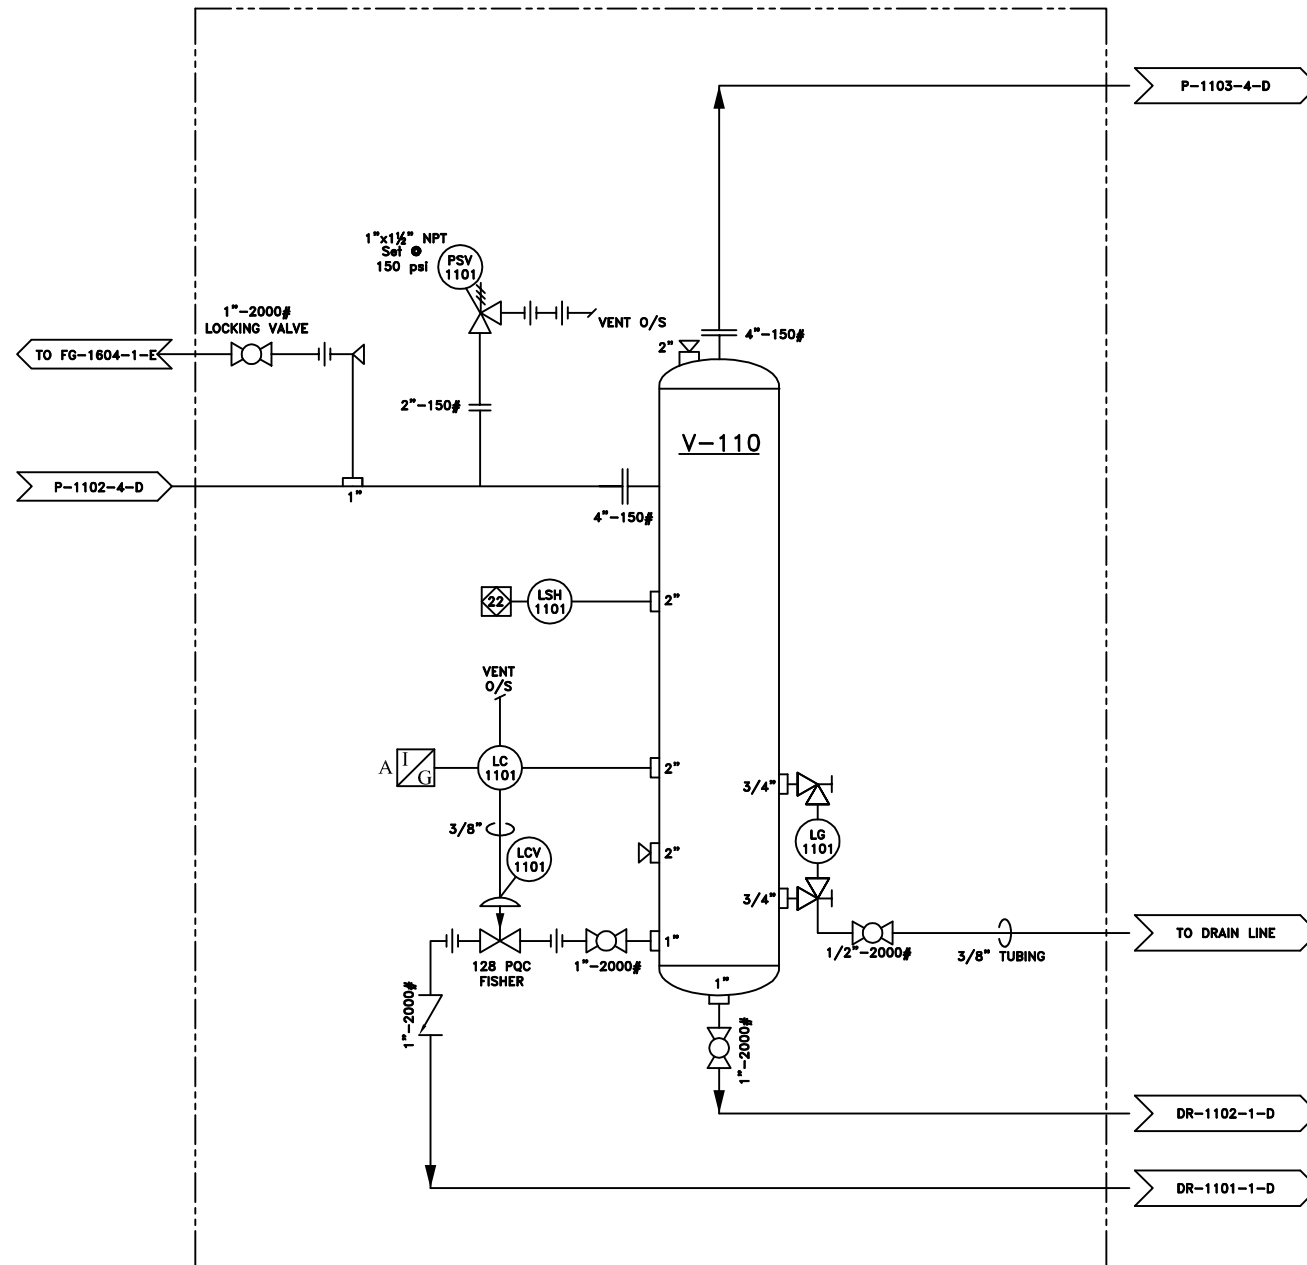

* SEE DWG JCR-74133-A-01
FOR COMPLETE 74133 P&ID

PIPING AND INSTRUMENTATION DIAGRAM

LINE TYPE LEGEND	MAIN PROCESS GAS	OIL/GAS COMBINED	UTILITY PROCESS
SKID BOUNDARY	SECONDARY PROCESS	INSTRUMENTATION	OIL ONLY LINE
COOLER LAYERS	WATER JACKET (FRONT)	OIL (TOP)	GAS (BOTTOM)

REV.	DESCRIPTION	BY	APP.	DATE
1	AS BUILT	CRC		01-06-28
0	ISSUED FOR CONSTRUCTION	CRC		01-03-28



5221-46 St.
Box 1450, Stettler Alberta
T0C 2L0
Phone: (403) 742-5538
Fax: (403) 742-5539

JIRO COMPRESSION LTD.
an EnSource company

CADD Department E-mail
cad@enhancedenergy.com

7400 SERIES COMPRESSOR
MYCOM 160VSRD-1.809 w/ CAT 3306NA
TRAILER, SOUR RENTAL

COMPANY:		JIRO COMPRESSION		JOB NO.: 74133	
Drawn by:	Checked by:	Approved by:	DATE:	SCALE:	DRAWING NO.:
JAM			01-03-12	N.T.S.	JCR-74133-A-02
					REV.: 1

V-150
OIL COALESCING VESSEL


Size: 508mmØ x 960mm S/S
(20" x 37-3/4" S/S)
RATED AT 300psi @ 250°F
Make: PENFABCO
CRN: L8012.231
1/16" CA
Serial: PE-6967

V-170
FLOAT CHAMBER

Make: MURPHY
Model: 15-05-0597
RATED AT 2000psi @ 400°F
CRN: OH1476.2

MATERIAL LIST

ITEM	DESCRIPTION	MAKE	MODEL
PSV-1501	PRESSURE SAFETY VALVE SET @ 300 PSI	MERCER	9123F511711S
LG-1501	LEVEL GAUGE	PENBERTHY	1RM-7 STLNE
LSL-1501	LOW SHUTDOWN LEVEL	MURPHY	L1200
DPSHH-1501	DIFFERENTIAL PRESSURE INDICATOR	MID WEST	

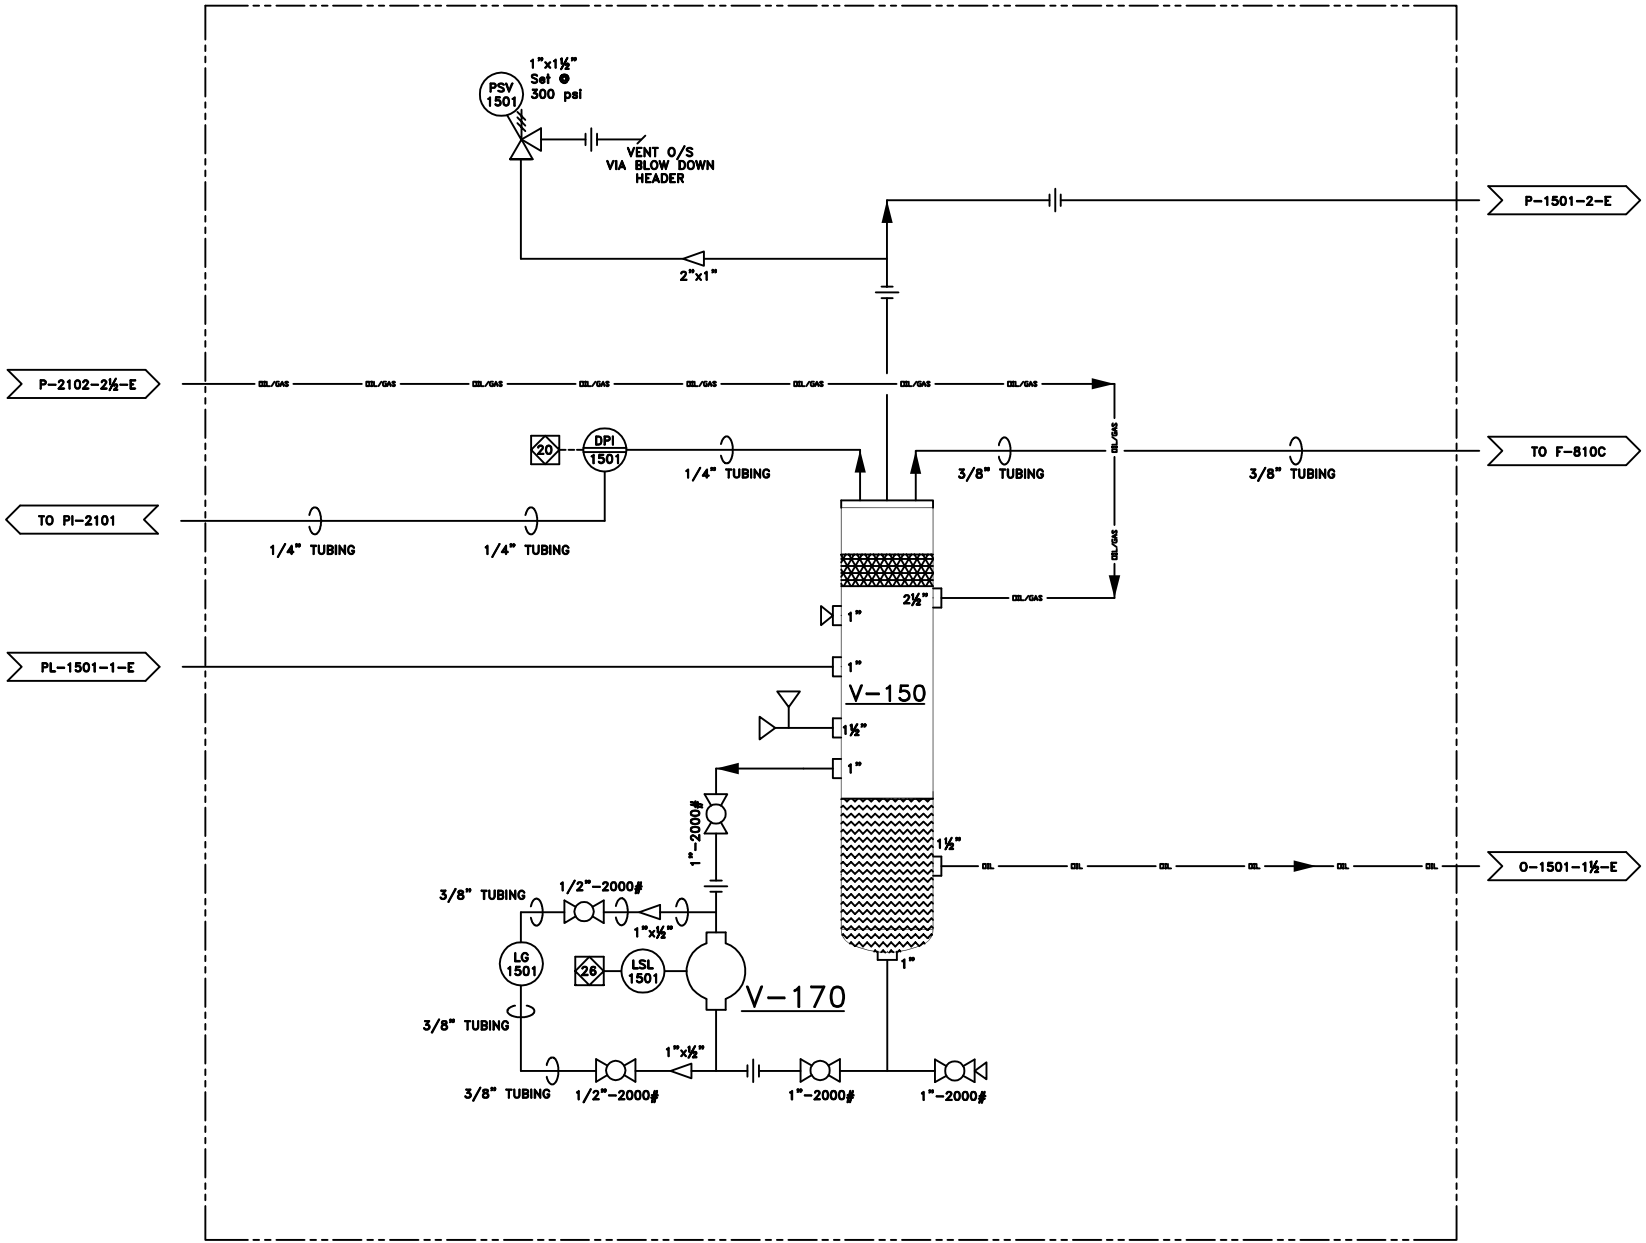

* SEE DWG JCR-74133-A-01
FOR COMPLETE 74133 P&ID

PIPING AND INSTRUMENTATION DIAGRAM

LINE TYPE LEDGEND	MAIN PROCESS GAS	OIL/GAS COMBINED	UTILITY PROCESS
SKID BOUNDARY	SECONDARY PROCESS	INSTRUMENTATION	OIL ONLY LINE
COOLER LAYERS	WATER JACKET (FRONT)	OIL (TOP)	GAS (BOTTOM)

REV.	DESCRIPTION	BY	APP.	DATE
1	AS BUILT	CRC		01-06-28
0	ISSUED FOR CONSTRUCTION	CRC		01-03-26

**Jiro**

5221-46 St.
Box 1450, Stettler, Alberta
T0C 2L0

Phone: (403) 742-5538
Fax: (403) 742-5539

JIRO COMPRESSION LTD.
an EnSource company
CADD Department E-mail
cad@enhancedenergy.com

7400 SERIES COMPRESSOR
MYCOM 160VSRD-1.809 w/ CAT 3306NA
TRAILER, SOUR RENTAL


COMPANY:		JIRO COMPRESSION		JOB NO.: 74133	
Drawn by:	Checked by:	Approved by:	DATE:	SCALE:	DRAWING NO.:
JAM			01-03-12	N.T.S.	JCR-74133-A-03
					REV.: 1

V-160
FUEL SCRUBBER
Size: 102mmø x 914mm S/S
(4" x 36" S/S)
Make: JIRO COMPRESSION
CRN: OH3977.231
Serial: 4DP-361

F-820
FUEL GAS FILTER
Make: TECHNOLAB
Model: TLH00129
Press: 0.3 MICROM

MATERIAL LIST

ITEM	DESCRIPTION	MAKE	MODEL
PI-1602	PRESSURE INDICATOR 1/4"LMx2 1/2"FACE, 0-60 PSI/0-420 KPA	WESTERN GAUGE	-
PCV-1602	PRESSURE CONTROL VALVE SET ● 0-35 PSI	WESTERN GAUGE	67CFR-362
PI-1603	PRESSURE INDICATOR 1/4"LMx2 1/2"FACE, 0-60 PSI/0-420 KPA	WESTERN GAUGE	-
PCV-1603	PRESSURE CONTROL VALVE SET ● 0-35 PSI	FISHER	67CFR-362
PI-1601	PRESSURE INDICATOR 1/4"LMx2 1/2"FACE, 0-200 PSI/1400 KPA	WESTERN GAUGE	-
PSV-1601	PRESSURE SAFETY VALVE SET ● 125 PSI	MERCER	91-17D511807E
PCV-1601	PRESSURE CONTROL VALVE SET ● 70-150 PSI, 1/2" PORT	FISHER	627-559

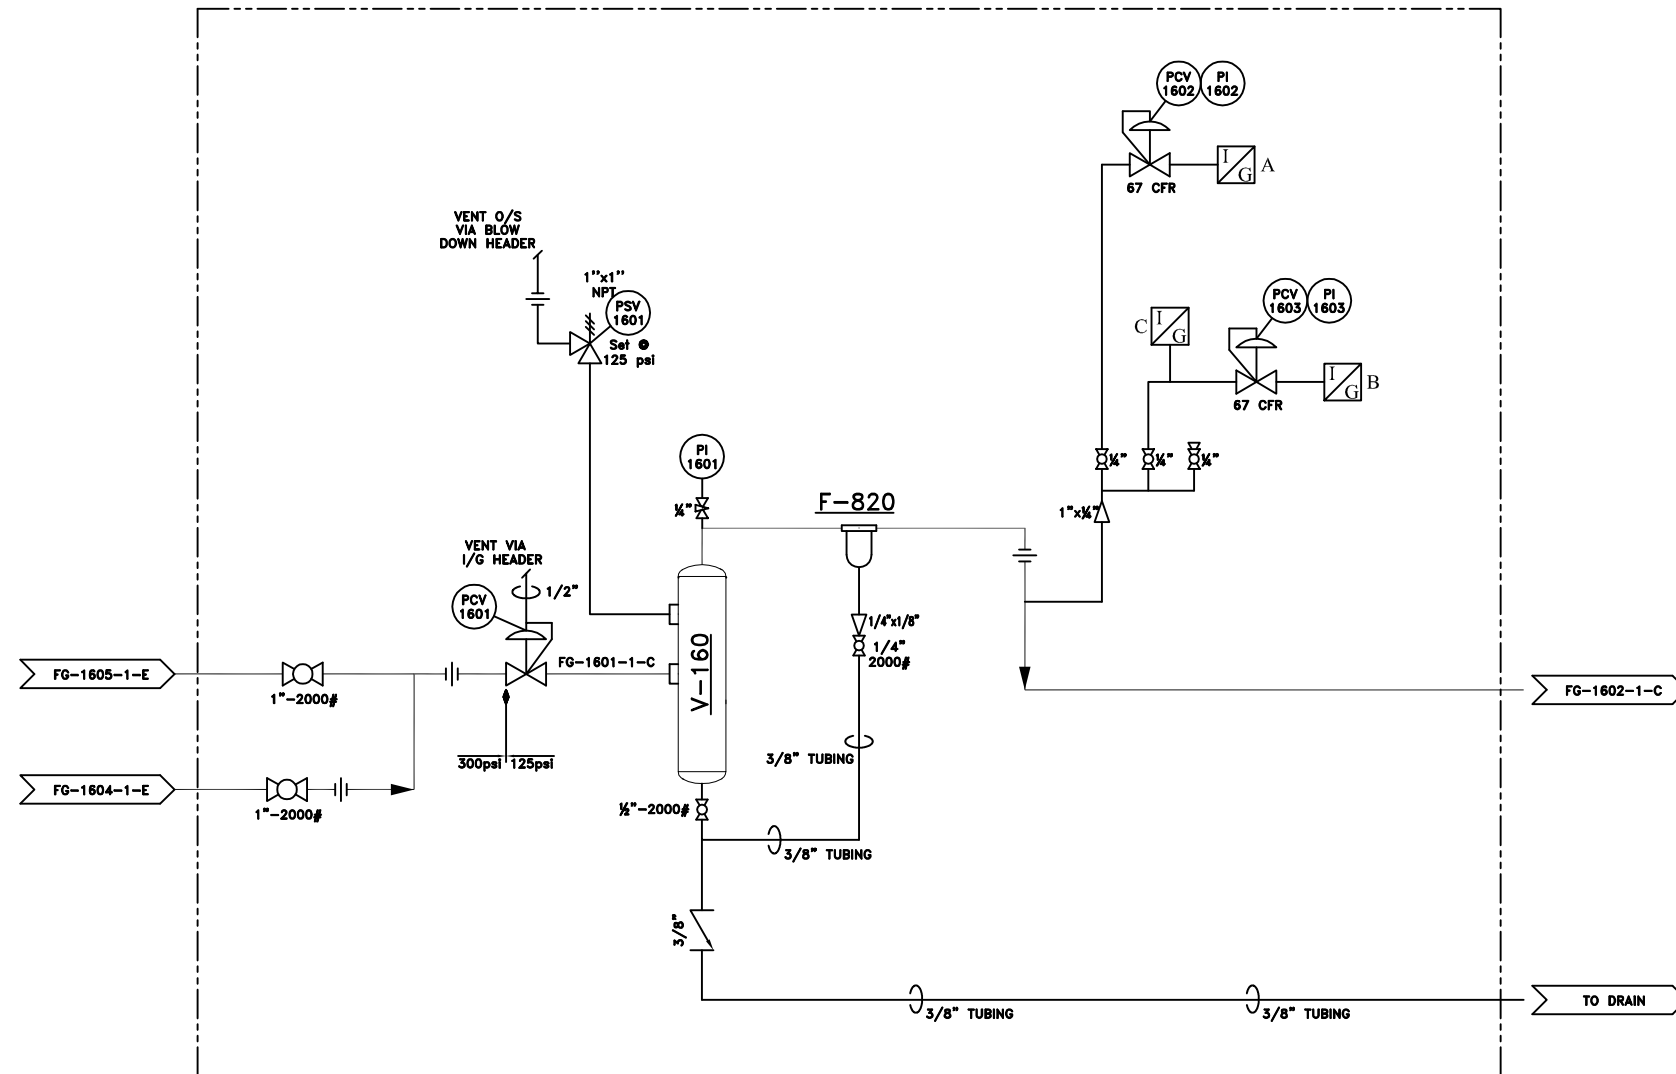

* SEE DWG JCR-74133-A-01
FOR COMPLETE 74133 P&ID

PIPING AND INSTRUMENTATION DIAGRAM

LINE TYPE LEDGEND	MAIN PROCESS GAS	OIL/GAS COMBINED	UTILITY PROCESS
SKID BOUNDARY	SECONDARY PROCESS	INSTRUMENTATION	OIL ONLY LINE
COOLER LAYERS	WATER JACKET (FRONT)	OIL (TOP)	GAS (BOTTOM)

REV.	DESCRIPTION	BY	APP.	DATE
1	AS BUILT	CRC		01-06-28
0	ISSUED FOR CONSTRUCTION	CRC		01-03-28



5221-46 St.
Box 1450, Stettler Alberta
T0C 2L0
Phone: (403) 742-5538
Fax: (403) 742-5539

JIRO COMPRESSION LTD.
an EnSource company

CADD Department E-mail
cad@enhancedenergy.com

7400 SERIES COMPRESSOR MYCOM 160VSRD-1.809 w/ CAT 3306NA TRAILER, SOUR RENTAL				JOB NO.: 74133	
COMPANY: JIRO COMPRESSION				REV.: 1	
Drawn by: JAM	Checked by:	Approved by:	DATE: 01-03-12	SCALE: N.T.S.	DRAWING NO.: JCR-74133-A-04

V-180
LUBE MANIFOLD
Manufacturer: JIRO COMPRESSION
Size: 2" x 20"
MAWP: 285psi
CRN: OH 4522.2
Serial: 2DP-229


S-210
SCREW COMPRESSOR
Make: MYCOM
Model: 160VSRD-181

P-610
PUMP
Model: D2300F019012

F-810 A-C
OIL FILTERS
Make: DONALDSON
Model: HMK25, HMK05

MATERIAL LIST

ITEM	DESCRIPTION	MAKE	MODEL
DPC-2101	DIFFERENTIAL PRESSURE CONTROLLER	SUNHYDRONICS	CAD 0A00-A2
DPSHH-2101	DIFFERENTIAL PRESSURE HI	MIDWEST	-
PI-2101	PRESSURE INDICATOR 1/4"BTMx2 1/2"FACE, 0-400 PSI/0-20 KPA	WESTERN GAUGE	-
TE-2101	TEMPERATURE ELEMENT c/w 2' PYRO	PEACOCK	151000156
UY-2101	THERMOSTATIC VALVE	AMOT	1 1/2BHCT15001
LG-2101	SIGHT GLASS	AC&R	SG 04 500WP
TI-2102	TEMPERATURE INDICATOR 3", -40 TO 160 °F	WESTERN GAUGE	-
TE-2102	TEMPERATURE ELEMENT c/w 2' PYRO	PEACOCK	151000156
PI-2102	PRESSURE INDICATOR 1/4"BTMx2 1/2"FACE, 0-400 PSI/0-28 KPA	WESTERN GAUGE	-
PI-2103	PRESSURE INDICATOR 1/4"BTMx2 1/2"FACE, 0-400 PSI/0-28 KPA	WESTERN GAUGE	-
	FLEX JOINT	-	1 1/2BHCT15001
	COUPLER	ATRA-FLEX	M3

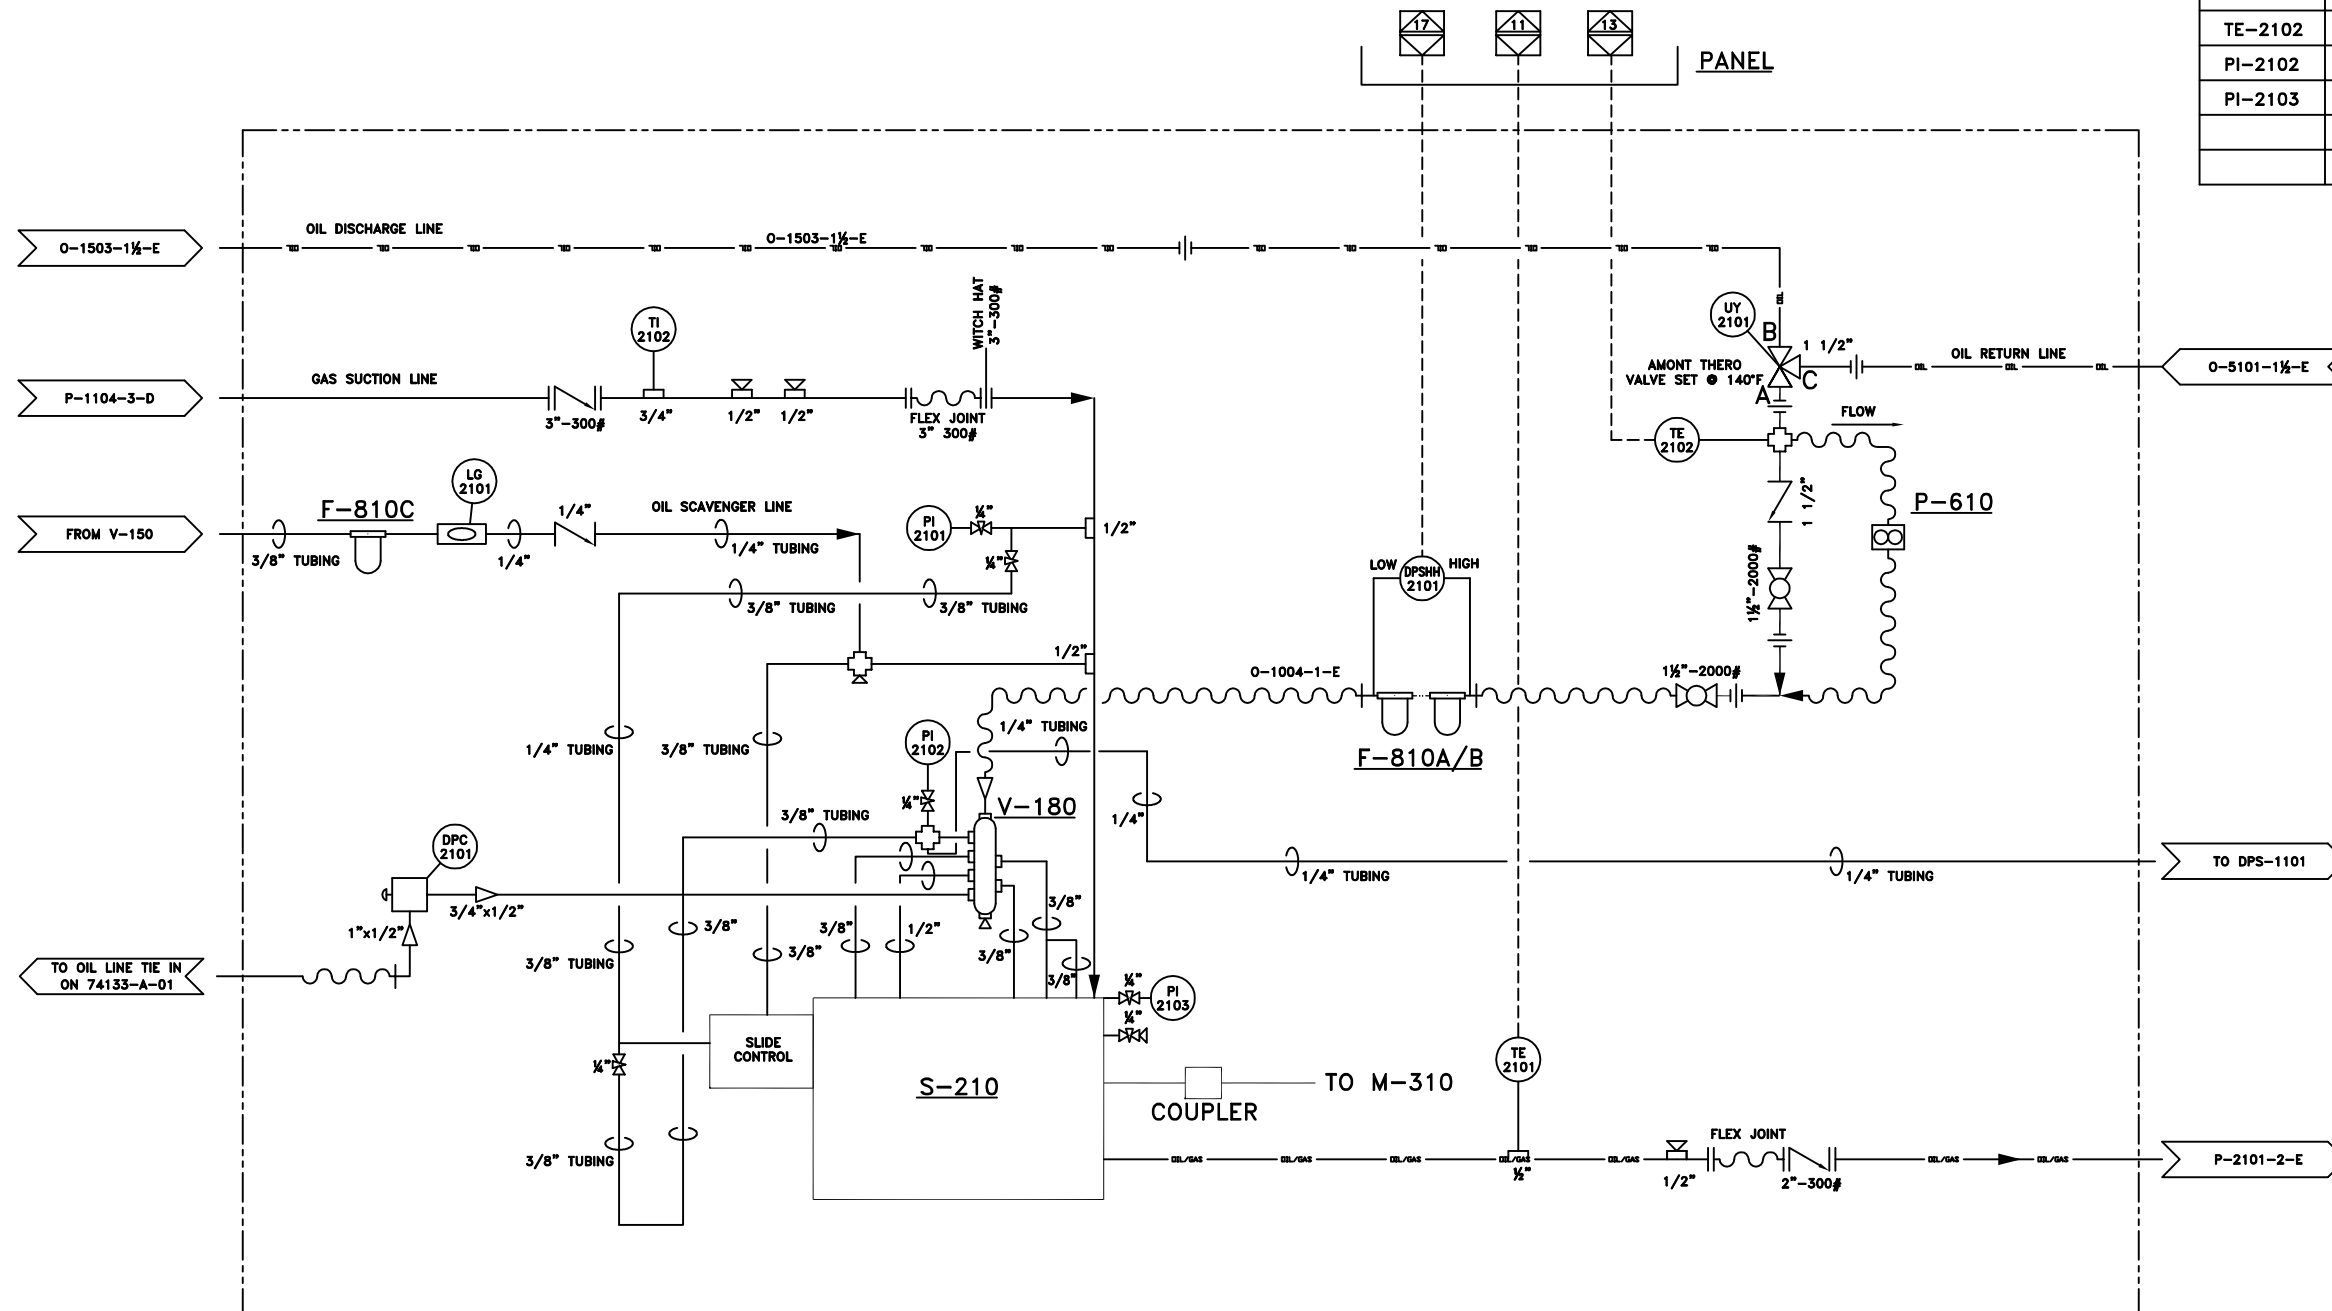

* SEE DWG JCR-74133-A-01
FOR COMPLETE 74133 P&ID

PIPING AND INSTRUMENTATION DIAGRAM

LINE TYPE	MAIN PROCESS GAS	OIL/GAS COMBINED	UTILITY PROCESS
LEGEND			
SKID BOUNDARY	SECONDARY PROCESS	INSTRUMENTATION	OIL ONLY LINE
COOLER LAYERS	WATER JACKET (FRONT)	OIL (TOP)	GAS (BOTTOM)

REV.	DESCRIPTION	BY	APP.	DATE
1	AS BUILT	CRC		01-06-28
0	ISSUED FOR CONSTRUCTION	CRC		01-03-26

Jiro
5221-48 St.
Box 1450, Steffler Alberta
T0C 2L0
Phone: (403) 742-5538
Fax: (403) 742-5539

JIRO COMPRESSION LTD.
an EnSource company


CADD Department E-mail
cad@enhancedenergy.com

7400 SERIES COMPRESSOR
MYCOM 160VSRD-1.809 w/ CAT 3306NA
TRAILER, SOUR RENTAL

COMPANY:		JIRO COMPRESSION		JOB NO.: 74133	
Drawn by:	Checked by:	Approved by:	DATE:	SCALE:	DRAWING NO.:
JAM			01-03-12	N.T.S.	JCR-74133-A-05
					REV.: 1

M-600
NATURAL GAS ENGINE

Make: CATERPILLAR
Model: 3306NA
145hp
Serial: 07408345

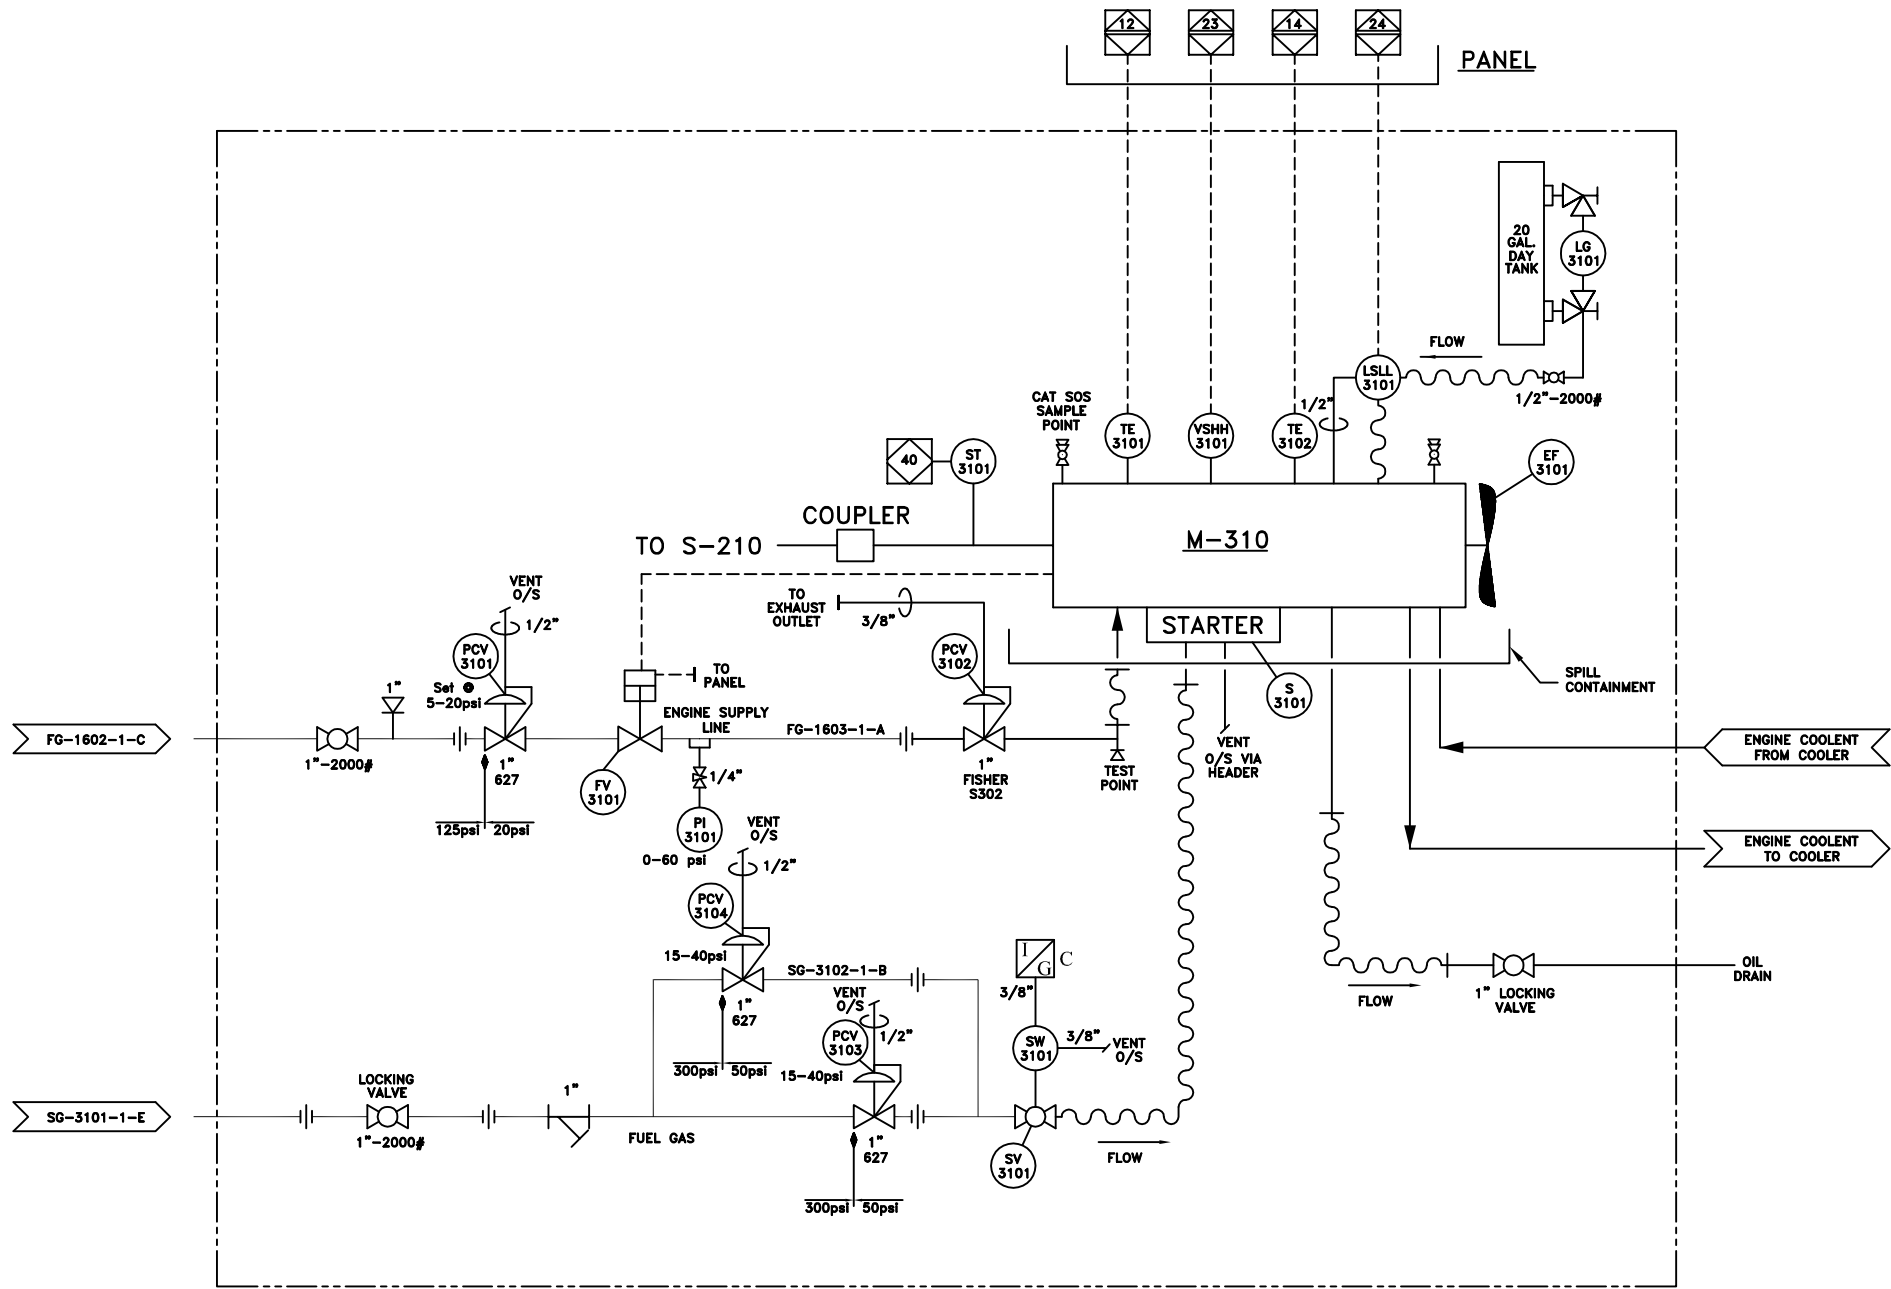

MATERIAL LIST

ITEM	DESCRIPTION	MAKE	MODEL
PI-3101	PRESSURE INDICATOR 1/4"LMx2 1/2"FACE, 0-60 PSI/0-420 KPA	WESTERN GAUGE	-
PCV-3101	PRESSURE CONTROL VALVE SET @ 5-20 PSIG, 1/2" PORT	FISHER	627-496
PCV-3102	PRESSURE CONTROL VALVE	FISHER	S302
VSHH-3101	VIBRATION SWITCH	MURPHY	VS-2
FV-3101	FUEL VALVE	MURPHY	M5081-C
LG-3101	LEVEL GAUGE - 5/8" RED LINE SIGHT GLASS	-	-
SW-3101	START SWITCH (ON PANEL)	INGERSOLL RAND	-
PCV-3103	PRESSURE CONTROL VALVE SET @ 15-40 PSIG, 1/2" PORT	FISHER	627-557
PCV-3104	PRESSURE CONTROL VALVE SET @ 15-40 PSIG, 1/2" PORT	FISHER	627-557
TE-3101	TEMPERATURE ELEMENT c/w 2" PYRO	PEACOCK	151000156
TE-3102	TEMPERATURE ELEMENT c/w 2" PYRO	PEACOCK	151000156
LSLL-3101	OIL LEVEL SWITCH	KENCO	LCE12
ST-3101	ENGINE OVERSPEED	ALTRONIC	DO 3300
SV-3101	PNEUMATIC START VALVE	TURBO START	-
S-3101	STARTER - MAWP 50 psig	TDI TURBOSTART	T30-I
EF-3101	ENGINE FAN 44"	CROWLEY	-

* SEE DWG JCR-74133-A-01
FOR COMPLETE 74133 P&ID

PIPING AND INSTRUMENTATION DIAGRAM

LINE TYPE	MAIN PROCESS GAS	OIL/GAS COMBINED	UTILITY PROCESS
LEDGEND			
SKID BOUNDARY	SECONDARY PROCESS	INSTRUMENTATION	OIL ONLY LINE
COOLER LAYERS	WATER JACKET (FRONT)	OIL (TOP)	GAS (BOTTOM)

REV.	DESCRIPTION	BY	APP.	DATE
1	AS BUILT	CRC		01-06-28
0	ISSUED FOR CONSTRUCTION	CRC		01-03-12



5221-46 St.
Box 1450, Stettler Alberta
T0C 2L0
Phone: (403) 742-5538
Fax: (403) 742-5539


JIRO COMPRESSION LTD.
an EnSource company

CADD Department E-mail
cad@enhancedenergy.com

7400 SERIES COMPRESSOR
MYCOM 160VSRD-1.809 w/ CAT 3306NA
TRAILER, SOUR RENTAL

COMPANY: JIRO COMPRESSION				JOB NO.: 74133	
Drawn by: JAM	Checked by:	Approved by:	DATE: 01-03-26	SCALE: N.T.S.	DRAWING NO.: JCR-74133-A-06
				REV.: 1	

MATERIAL LIST			
ITEM	DESCRIPTION	MAKE	MODEL
TC-5201	TEMPERATURE CONTROLER	KIMRAY	T-12
TC-5101	TEMPERATURE CONTROLER	KIMRAY	T-12
LSLL-5201	COOLENT LEVEL GAUGE	MURPHY	EL150K1
	LOUVERS	-	CS1537 1A/B
	ACTUATORS	TRACTION	S65 144

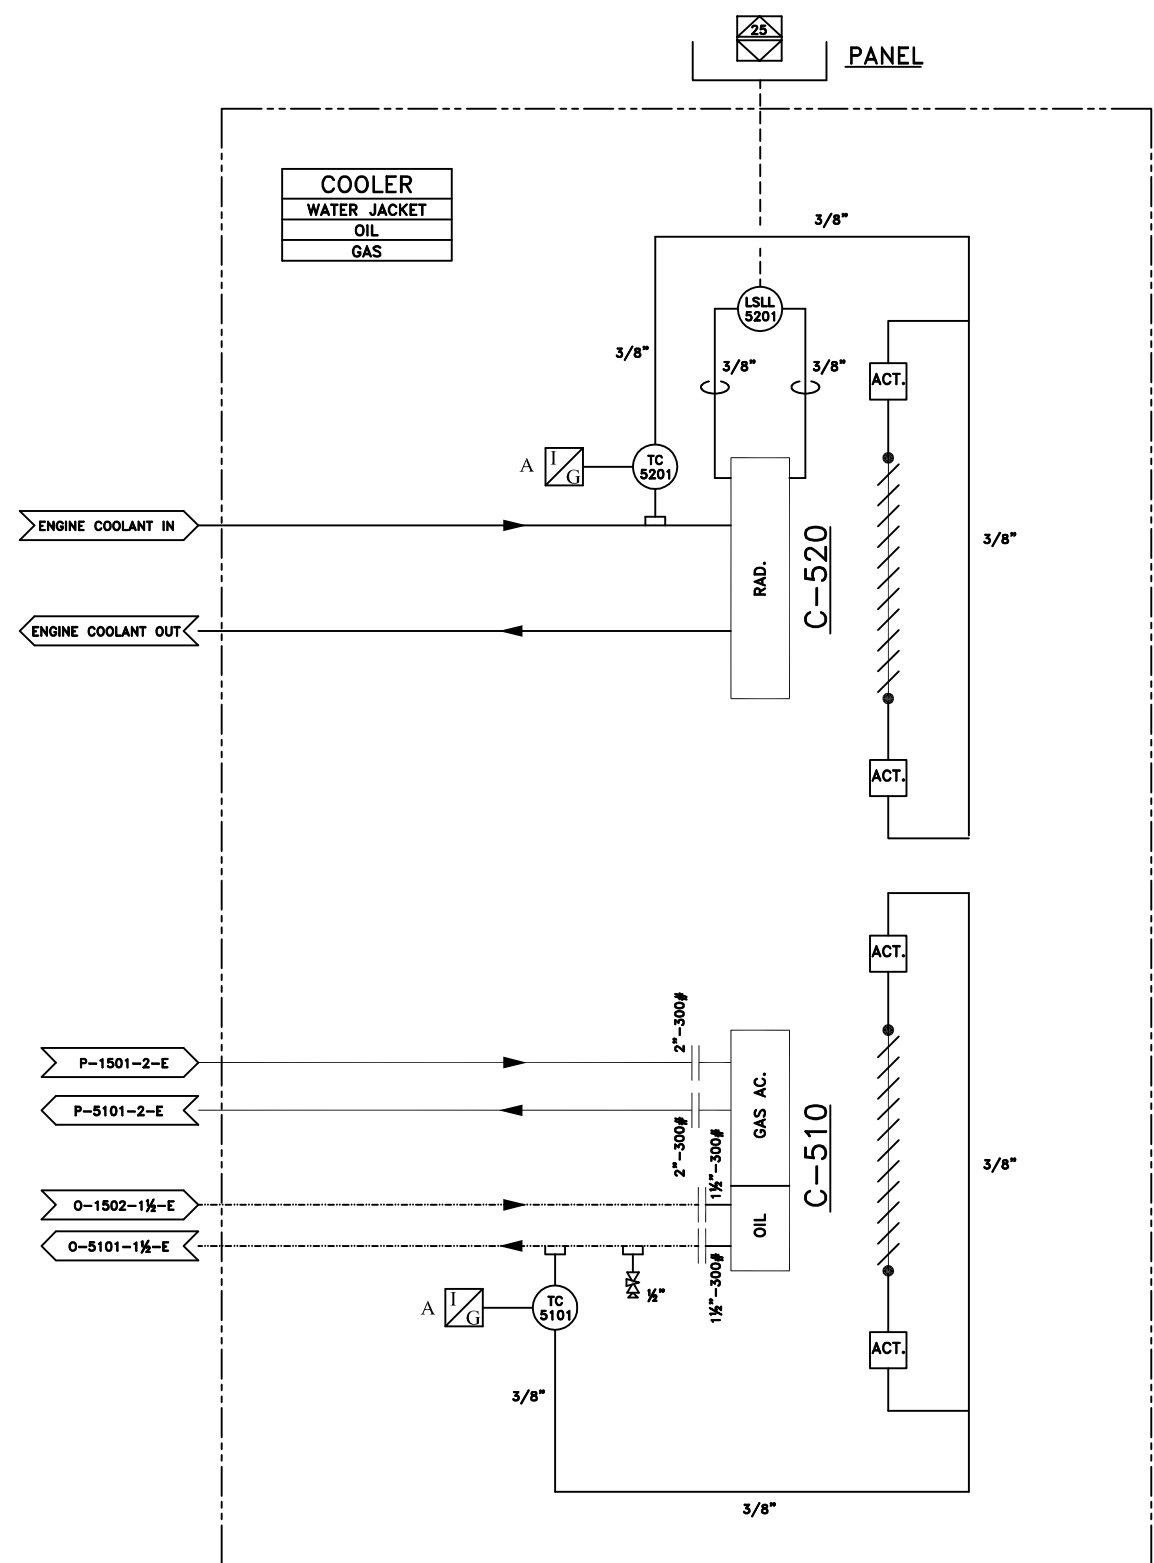

C-510
OIL/GAS AFTER COOLER
Model: API AIRTECH
Design Temp: 300°F
Design Pressure: 300psi
ALUMINUM HEADER & TUBES
Serial: 699-0324
CRN: 0H4584

C-520
ENGINE WATER JACKET
Make: THERMAL TRANSFER
Model: GHT-JIRO-01

* SEE DWG JCR-74133-A-01
FOR COMPLETE 74133 P&ID

PIPING AND INSTRUMENTATION DIAGRAM

LINE TYPE LEDGEND	MAIN PROCESS GAS	OIL/GAS COMBINED	UTILITY PROCESS
	SKID BOUNDARY	SECONDARY PROCESS	INSTRUMENTATION
COOLER LAYERS			
	WATER JACKET (FRONT)	OIL (TOP)	GAS (BOTTOM)

REV.	DESCRIPTION	BY	APP.	DATE
1	AS BUILT	CRC		01-06-28
0	ISSUED FOR CONSTRUCTION	CRC		01-03-26



Jiro
5221-46 St.
Box 1450, Steffler Alberta
T0C 2L0
Phone: (403) 742-5538
Fax: (403) 742-5539

JIRO COMPRESSION LTD.
an EnSource company
CADD Department E-mail
cad@enhancedenergy.com

7400 SERIES COMPRESSOR
MYCOM 160VSRD-1.809 w/ CAT 3306NA
TRAILER, SOUR RENTAL

COMPANY:		JIRO COMPRESSION		JOB NO.: 74133	
Drawn by:	Checked by:	Approved by:	DATE:	SCALE:	DRAWING NO.:
JAM			01-03-12	N.T.S.	JCR-74133-A-07
REV.:					1