


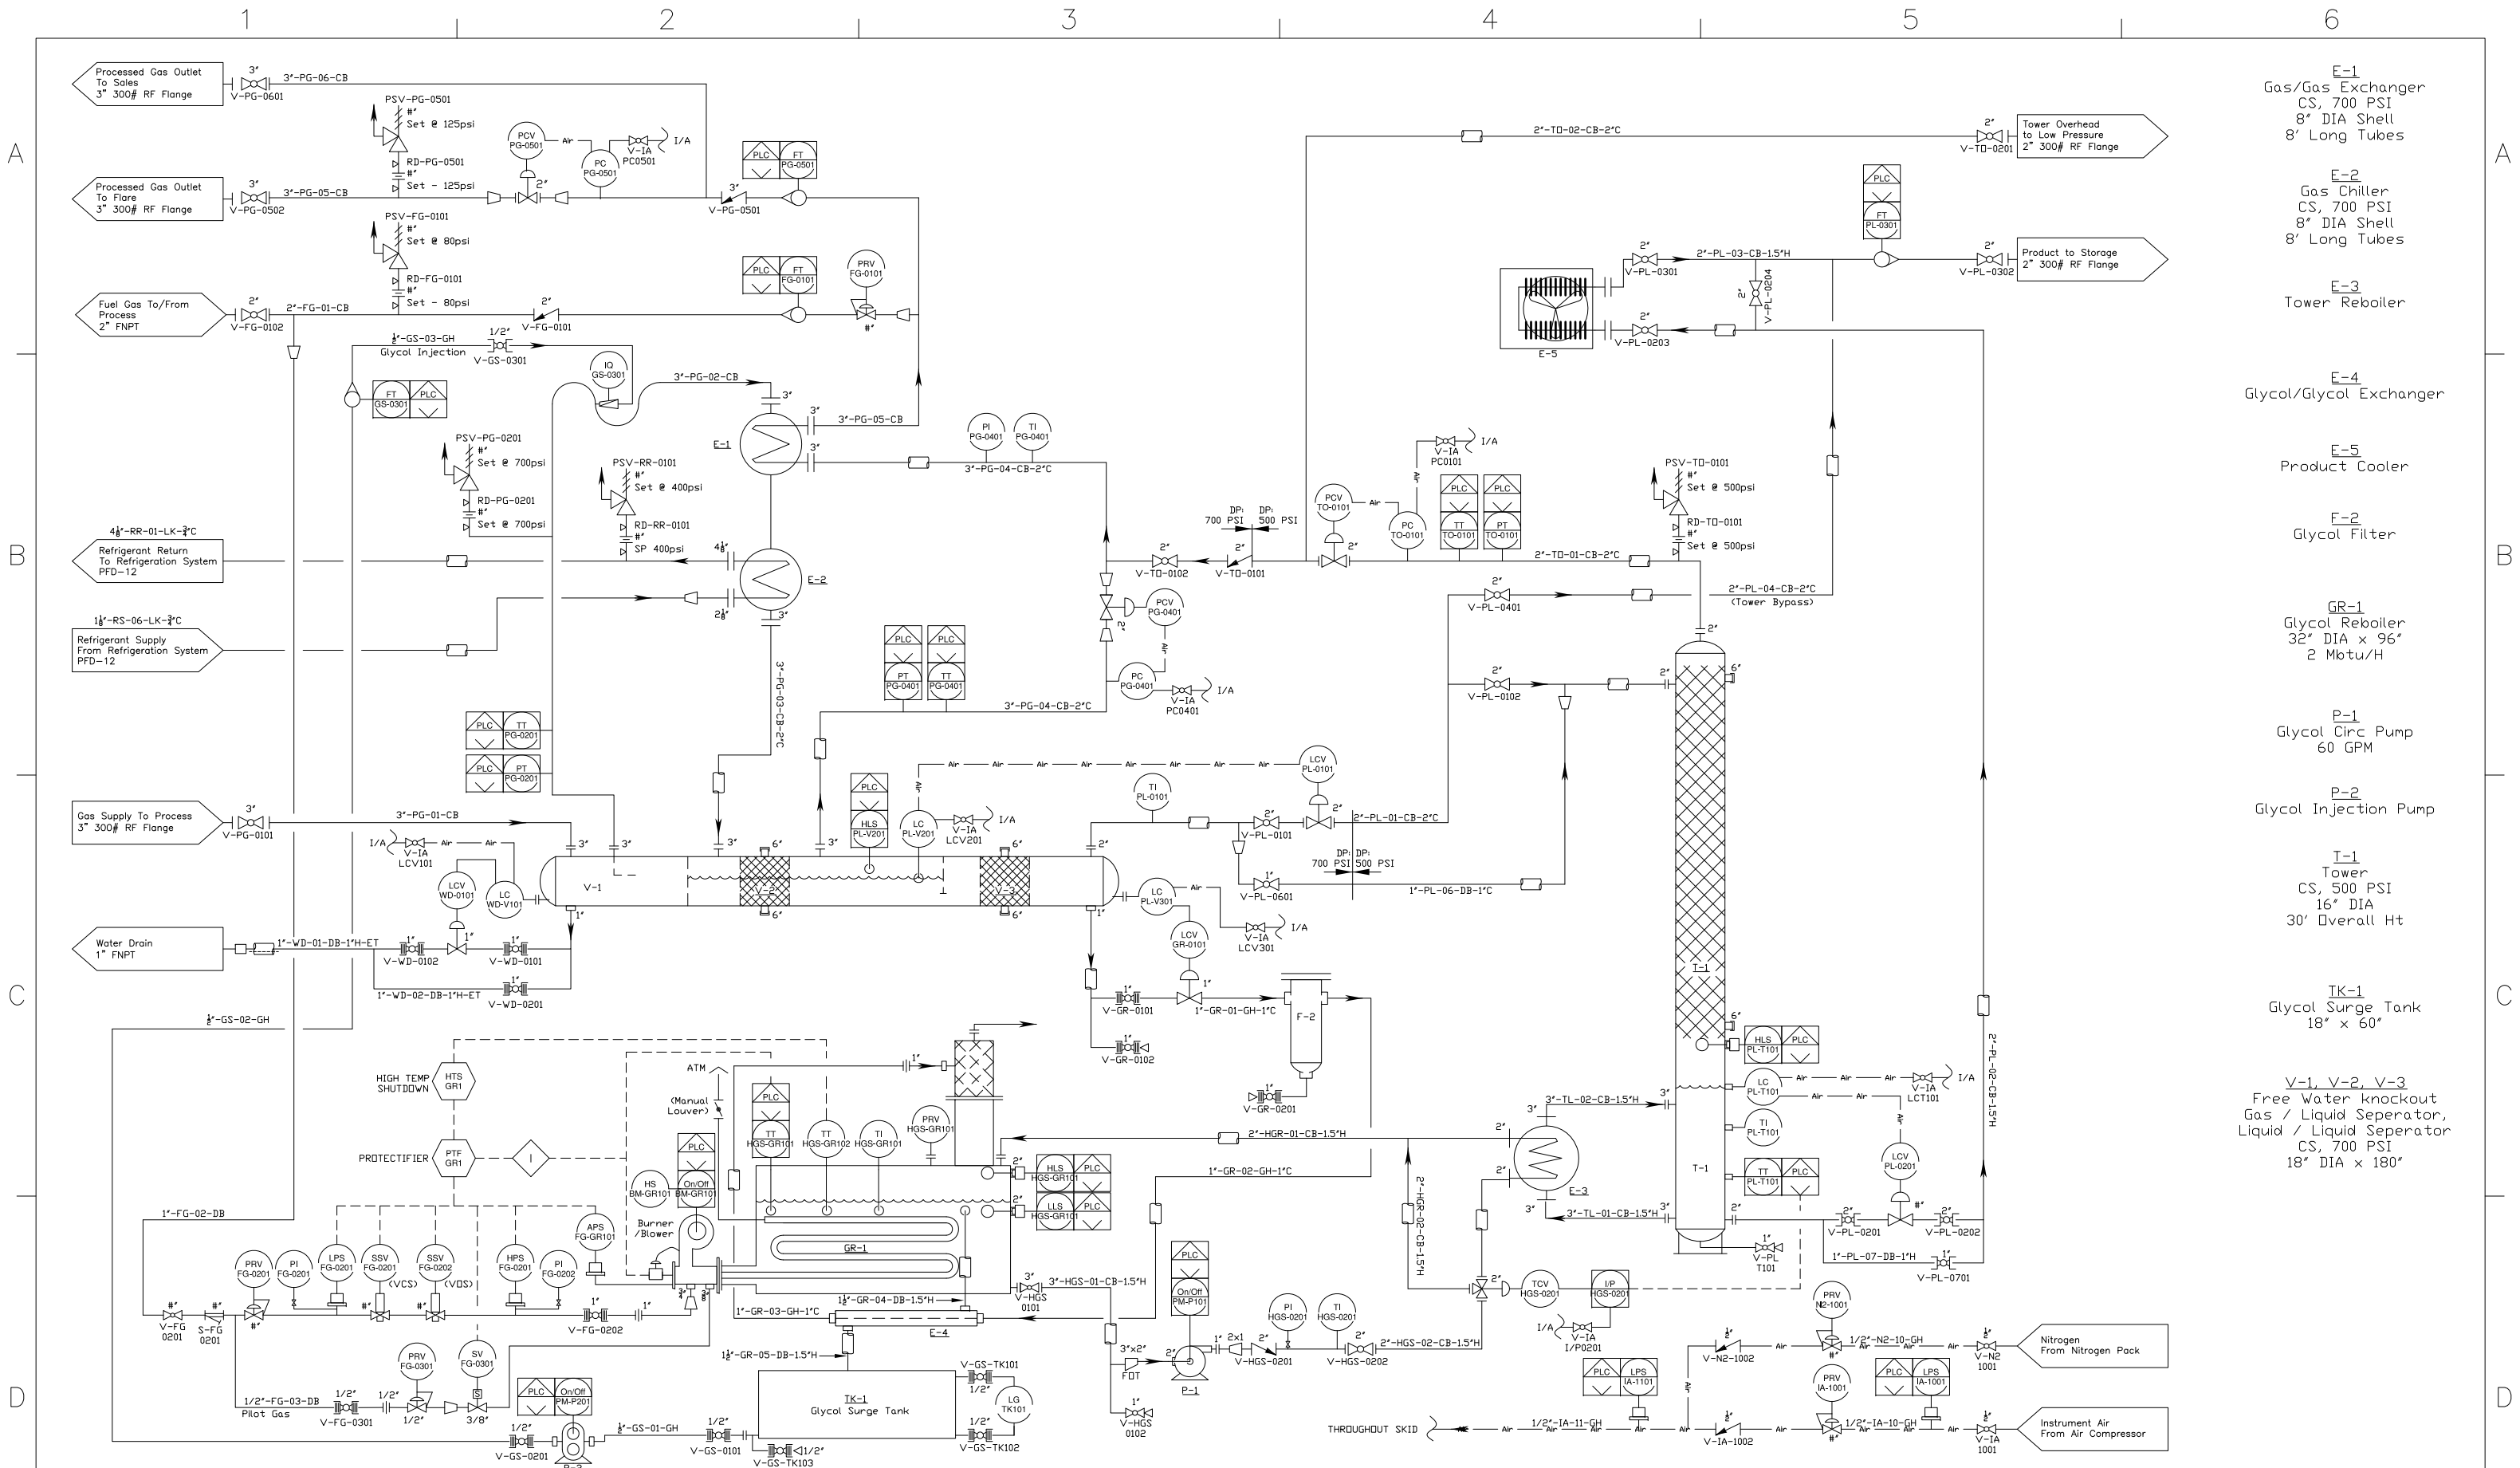

			Recapture Solutions, Inc. 1-3 MMCFD Gas / Liquids Plant		TITLE: Process Flow Diagram Gas Processing			GLYCOL SPECIALIST INC. 14 Lakeside Lane Denver, CO 80212 Ph 303-477-6999 Fax 303-458-7050		
2	Revise E-5, Misc. Instr., For Construction		12/21/14		GSI Job #2053 CMWS Job #1419			14 Lakeside Lane Denver, CO 80212 Ph 303-477-6999 Fax 303-458-7050		
1	For Review		10/22/14							
0	For Approval		09/19/14							
REV.	DESCRIPTION		DATE	DR. BY: TC	CH'D BY: JH	DATE: 12/21/14	SCALE: NONE	SHEET: 1 of 1	DWG. NO. 1419-21-PFD-11	REV. 2

THIS DRAWING IN ALL PARTICULARS IS OUR PROPERTY. ALL RIGHTS OF DESIGN, INVENTION OR USE ARE RESERVED.