


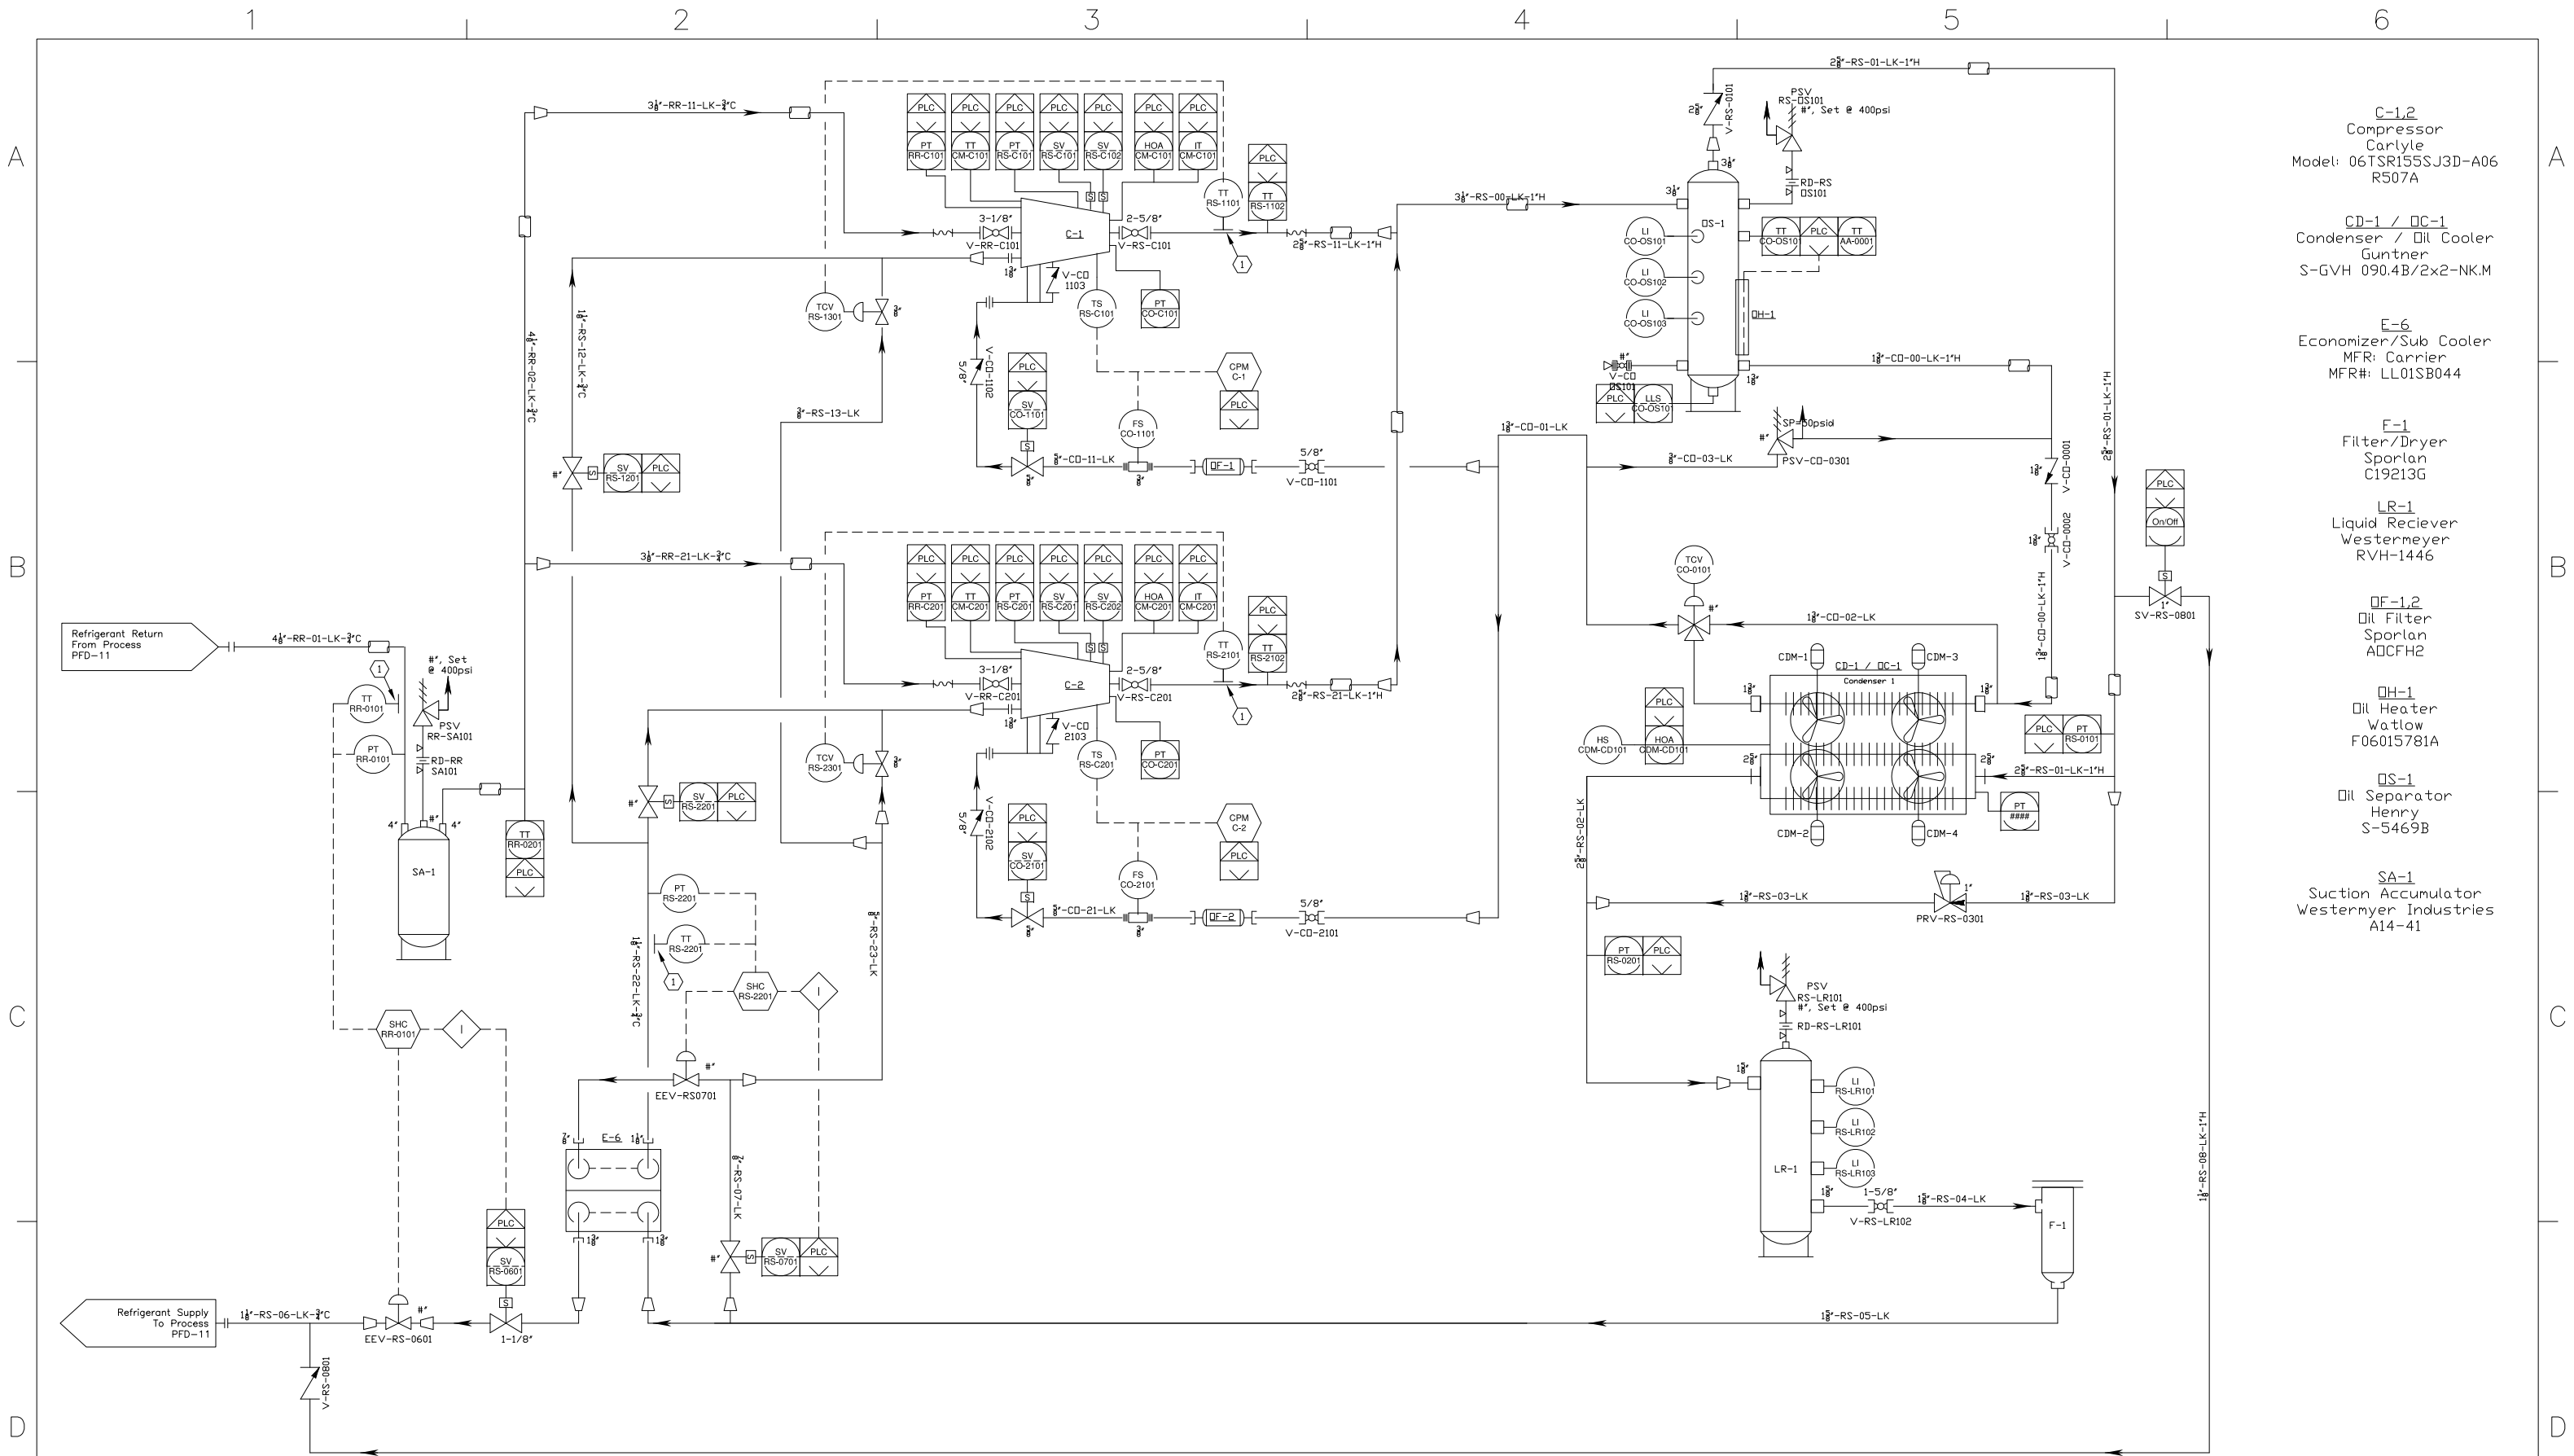

Notes:
① Surface Mounted Temp Sensor

		Recapture Solutions, Inc. 1-3 MMCFD Gas / Liquids Plant		TITLE: Process Flow Diagram Refrigeration System		GLYCOL SPECIALIST INC. 14 Lakeside Lane Denver, CO 80212 Ph 303-477-6999 Fax 303-458-7050	
2	Add Defrost Line, Misc Instr., For Construction	12/01/14					
1	For Review	10/22/14	GSI Job #2053				
0	For Approval	09/19/14	CMWS Job #1419				
REV.	DESCRIPTION	DATE	DR. BY: TC	CH'D BY: JH	DATE: 12/01/14	SCALE: NONE	SHEET: 1 of 1
					DWG. NO. 1419-21-PFD-12		REV. 2

THIS DRAWING IN ALL PARTICULARS IS OUR PROPERTY. ALL RIGHTS OF DESIGN, INVENTION OR USE ARE RESERVED.