


V-100 SEPARATOR
SIZE: 24" x 7' - 6" S/S
DESIGN PRESS: 1440 PSIG
DESIGN TEMP. - 20°F/100°F

V-200
FUEL GAS SCRUBBER
SIZE: 6" x 30"
DESIGN PRESS: 150 PSIG
DESIGN TEMP. - 20°F/100°F

H-100
SCOTT CAN HEATER
12" X 24"
12000 BTU/HR NAT. GAS

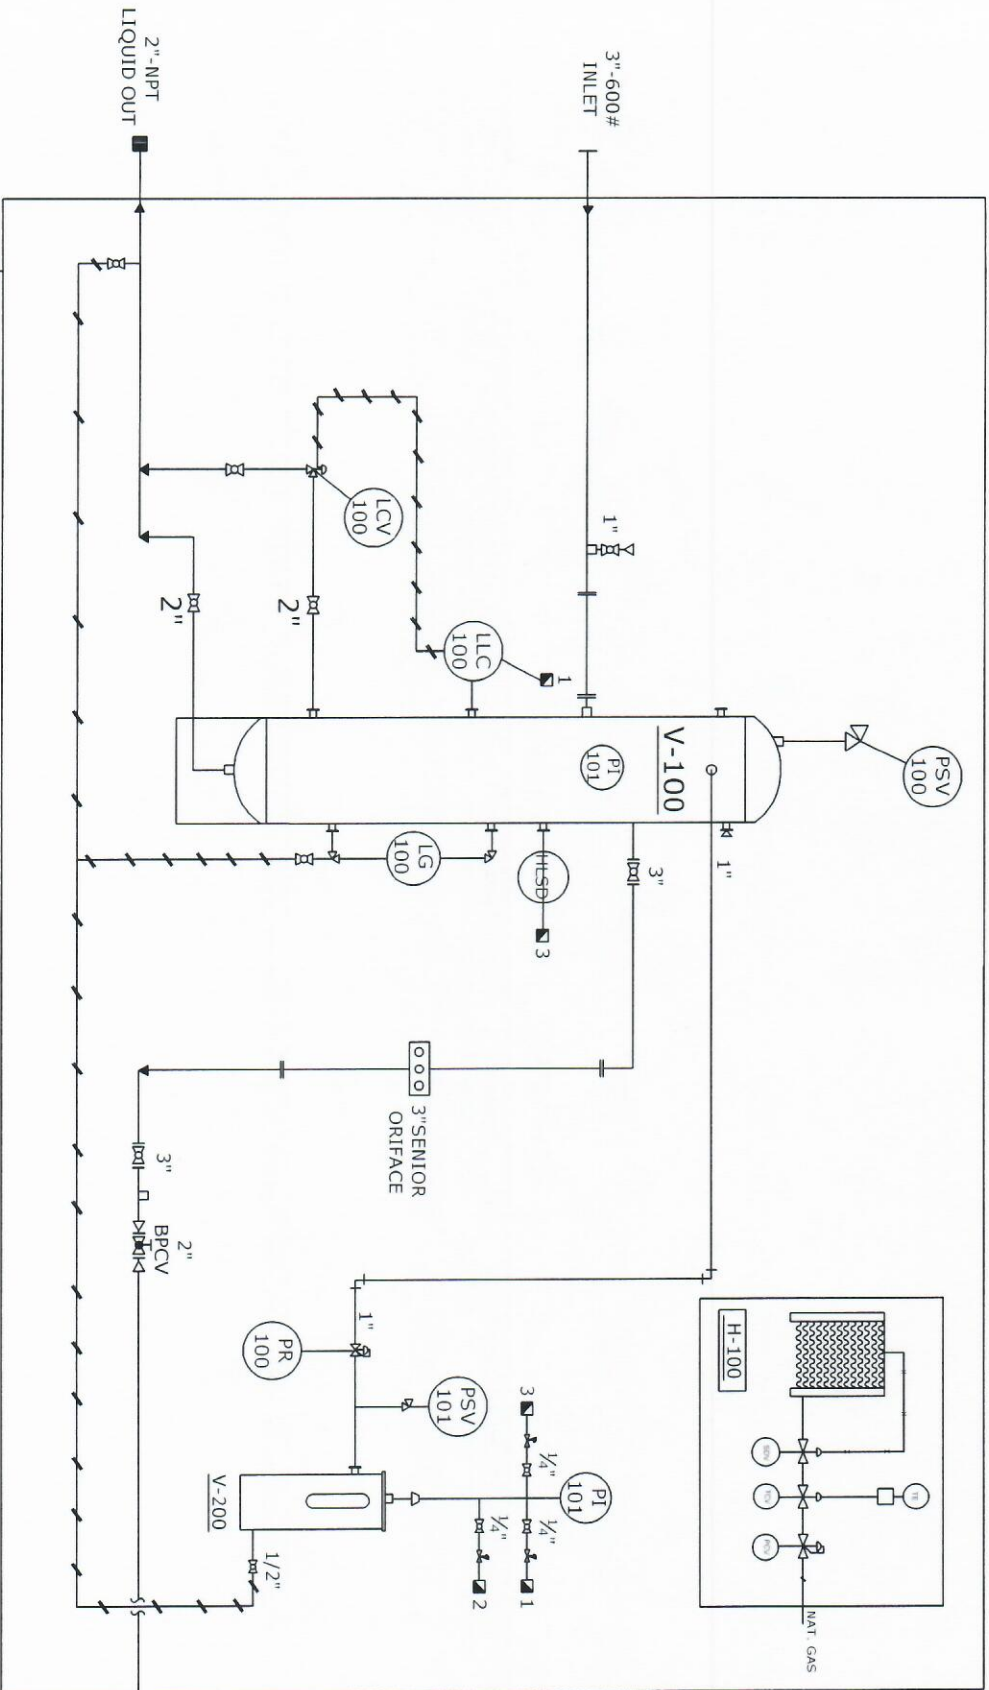

EQUIPMENT LIST			
TAG	QTY	BRAND	DESCRIPTION
FE-100	1	CANALTA	S.R. ORIFACE
LLC-100	1	NORRISEAL 1001A	SNAP ACTING
LCV-100	1	KIMRAY	2" NPT CONNECT.
LG-100	1	PENBURTHY	REFLEX
PI-100	1	WESTERN GAUGE	0-1500 PSI
PI-101	1	VALLEY INST.	0-300 PSI
PSV-100	1	TAYLOR	1440 PSI
PSV-101	1	TAYLOR	150 PSI
PRV-100	1	WELLMARK 627	30-80 PSI
PRV-101	2	WELLMARK-67FR	0-120
TI-100	1	GAUGE TECH	-20 TD +120
HLSD-100	1	MURPHY	SNAP ACTING
HTR-100	1	SCOTT CAN	12" VOLT HEATER

PIPING INFORMATION			
Flange Rating	600 ansi	A-105	
Piping	Schedule 80	A-106	
Welded Fittings	Schedule 80/40	WPB	
Threaded Fittings	2000#	A-105N	
Vessel MAWP	1440 psi		
Oper. Temp.	100 Degrees (F)		

DATE:	SEPT. 7/17
JOB #:	HP-525-17
A #:	426910
S/N #:	77864
UNIT #:	
SCALE:	NTS
DRAWN BY:	
SHEETS:	1 of 1

RARE OILFIELD SERVICES CORP.

24" x O.D. x 7'6" S/S x 1440 PSIG
SEPARATOR PACKAGE

**High Plains Oil & Gas
Equipment Sales Ltd.**
PO Box 3277, Spruce Grove, AB T7X 3A6
PH: (780) 719-8799

DWG NO.	HP-525-17 P&ID-001	REV	00
DRAWING DESCRIPTION:	P & ID DRAWING		