


24'-0"

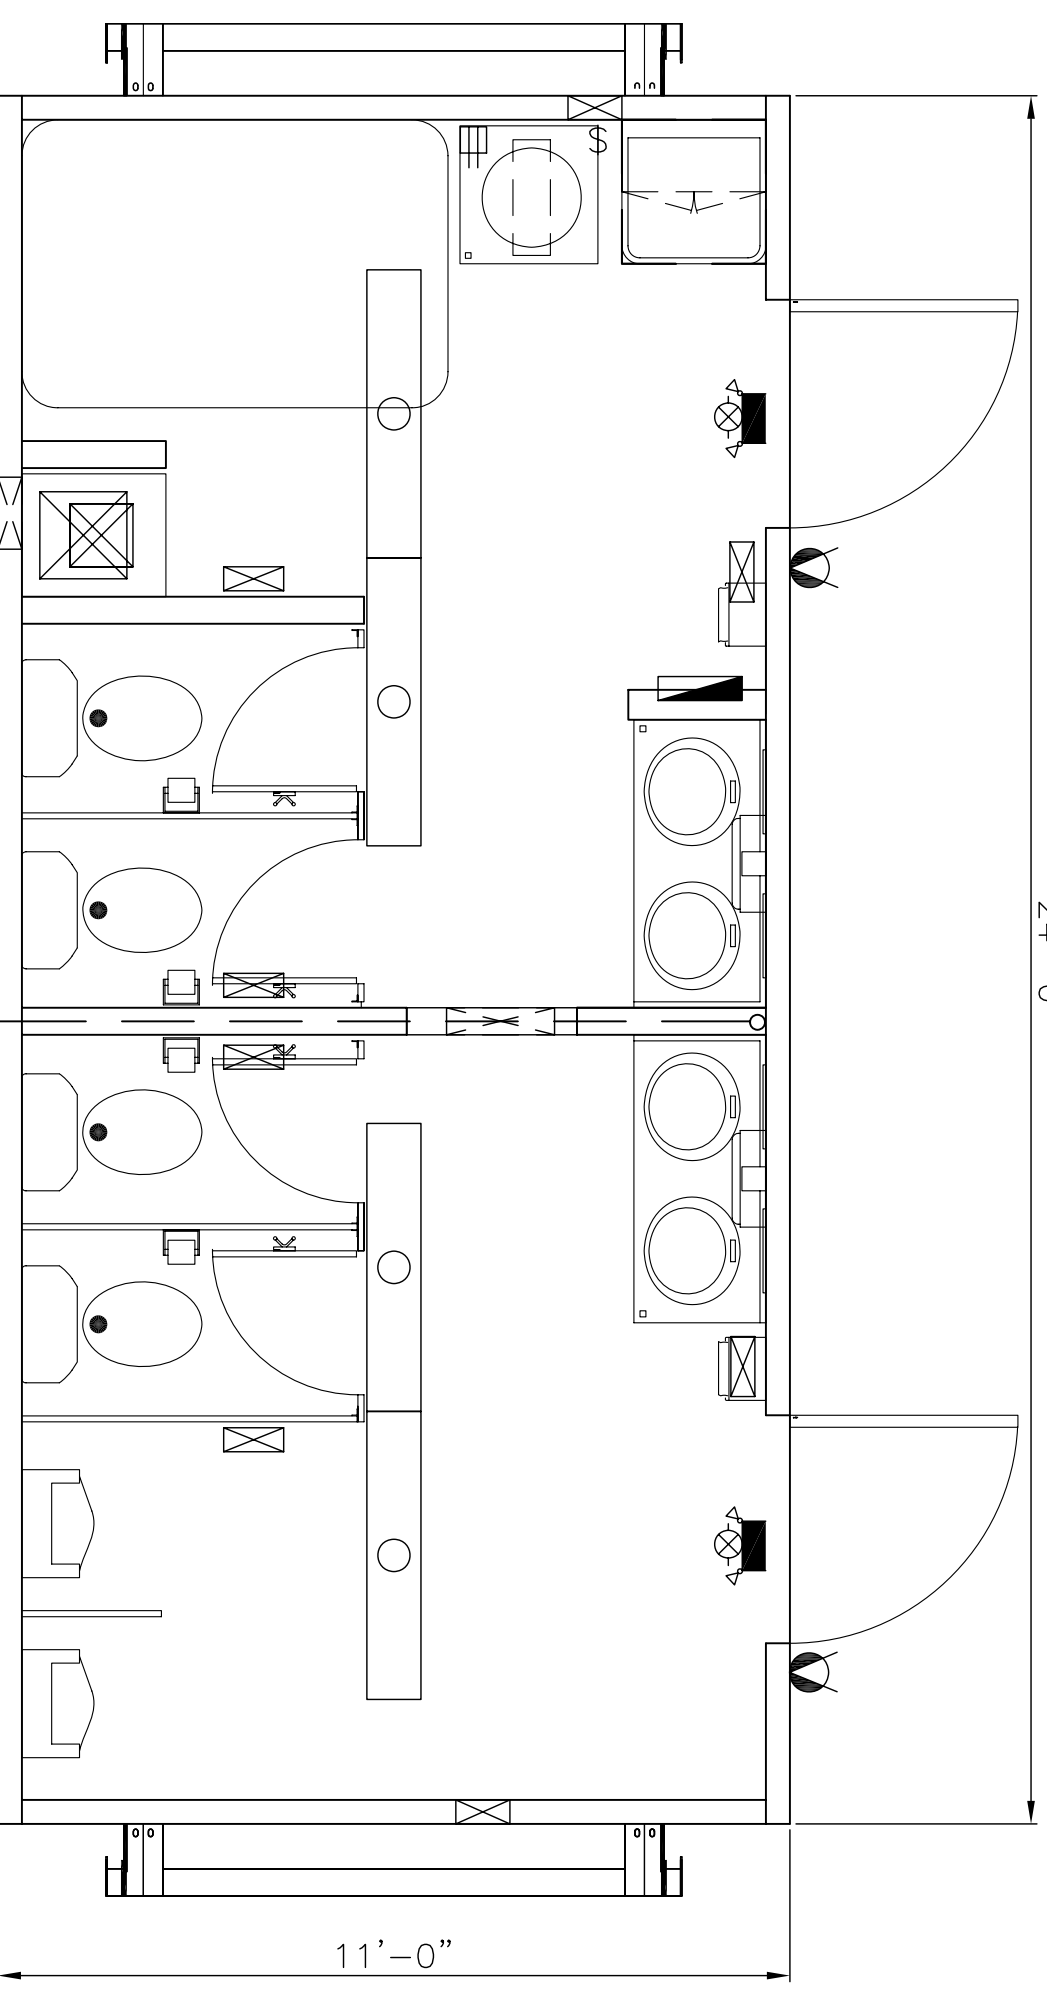

1 FLOOR PLAN
A01 CEILING HEIGHT: 8'-0 1/4"


EQUIPMENT LIST

QTY	DESCRIPTION
1	36"x80" EXTERIOR HMI DOOR
1	28"x80" DOOR SLAB ONLY W/ 4 BARREL BOLTS
1	GAS FIRED FURNACE
2	1.5 KW WALL FAN HEATER
2	ELECTRICAL POWER PANEL
2	EXTERIOR WALL MOUNTED LIGHT FIXTURE
4	48" LONG, 2 LAMP, SURFACE MOUNTED LIGHT FIXTURE
2	COMBINATION EMERGENCY LIGHT PACK
6	10"x4" SUPPLY AIR REGISTER
2	180 cfm EXHAUST FAN
2	14"x10" RETURN AIR GRILLE
1	1/2 HP PRESSURE PUMP W/ 8 GALLON PRESSURE TANK
1	630 GALLON WATER STORAGE TANK
1	10 GALLON ELECTRIC WATER HEATER & STAND

EQUIPMENT LIST

QTY	DESCRIPTION
4	2.9 GALLON WATER CLOSET
2	1.0 GALLON URINAL
1	24"x24"x10" MOP SINK
4	COUNTER MOUNTED LAVATORY W/ SUPPORT LEGS & FAUCET SET
4	SET METAL TOILET PARTITIONS
4	SINGLE ROLL TOILET PAPER HOLDER
2	LIQUID SOAP DISPENSER
4	PAPER TOWEL DISPENSER
4	14"x16" MIRROR W/ CLIPS
1	24"x24"x12" MELAMINE UPPER CABINET ABOVE MOP SINK
1	48"x24" PLASTIC LAMINATE VANITY COUNTER W/ CHROME LEGS (1-RH, 1-LH)
1	SKID FRAME

ELECTRICAL LEGEND

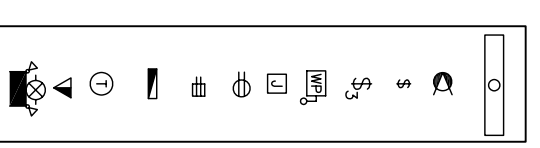

48" FLUORESCENT SURFACE MOUNTED FIXTURE, 2 LAMP/T8 C/W COOL WHITE LAMPS
 EXT. RWG-100 60W INCANDESCENT FIXTURE C/W 60W BULB
 15A/125V SINGLE POLE SWITCH-WHITE
 15A/125V 3-WAY SWITCH-WHITE
 WEATHER PROOF DISCONNECT SIZE AS SHOWN
 JUNCTION BOX SIZE AS REQUIRED
 15A/125V DUPLEX RECEPTACLE-WHITE
 HARD WIRED CONNECTION
 POWER PANEL
 MANUAL CHANGEOVER HEAT/COOL THERMOSTAT
 TELEPHONE/DATA OUTLET WITH 3/4" STUB DOWN
 COMBINATION EXIT/EMERGENCY LIGHT PACK WITH 2 HEADS 36W

**SALES DRAWING ONLY
NOT FOR CONSTRUCTION**

No	Date	Revision	By	Approved
0	11JAN08	ISSUE FOR REVIEW	RF	

© 2007 ATCO STRUCTURES INC.. ALL RIGHTS RESERVED. THESE DRAWINGS ARE THE PROPERTY OF ATCO STRUCTURES INC. AND CANNOT BE USED, COPIED, REPRODUCED, DISCLOSED, PUBLISHED, DISTRIBUTED OR OTHERWISE EXPLOITED, IN ANY FORM OR MANNER, IN WHOLE OR IN PART, FOR ANY REASON WITHOUT THE EXPRESS WRITTEN CONSENT OF ATCO STRUCTURES INC.

Title	11' X 24' SKIDDED LAVATORY FLOOR PLAN
Drawn by	RF
Date	11JAN08
Scale	3/8" = 1'-0"
Checked by	
Drwg. No.	B-970-004-A01
Rev. No.	0

