


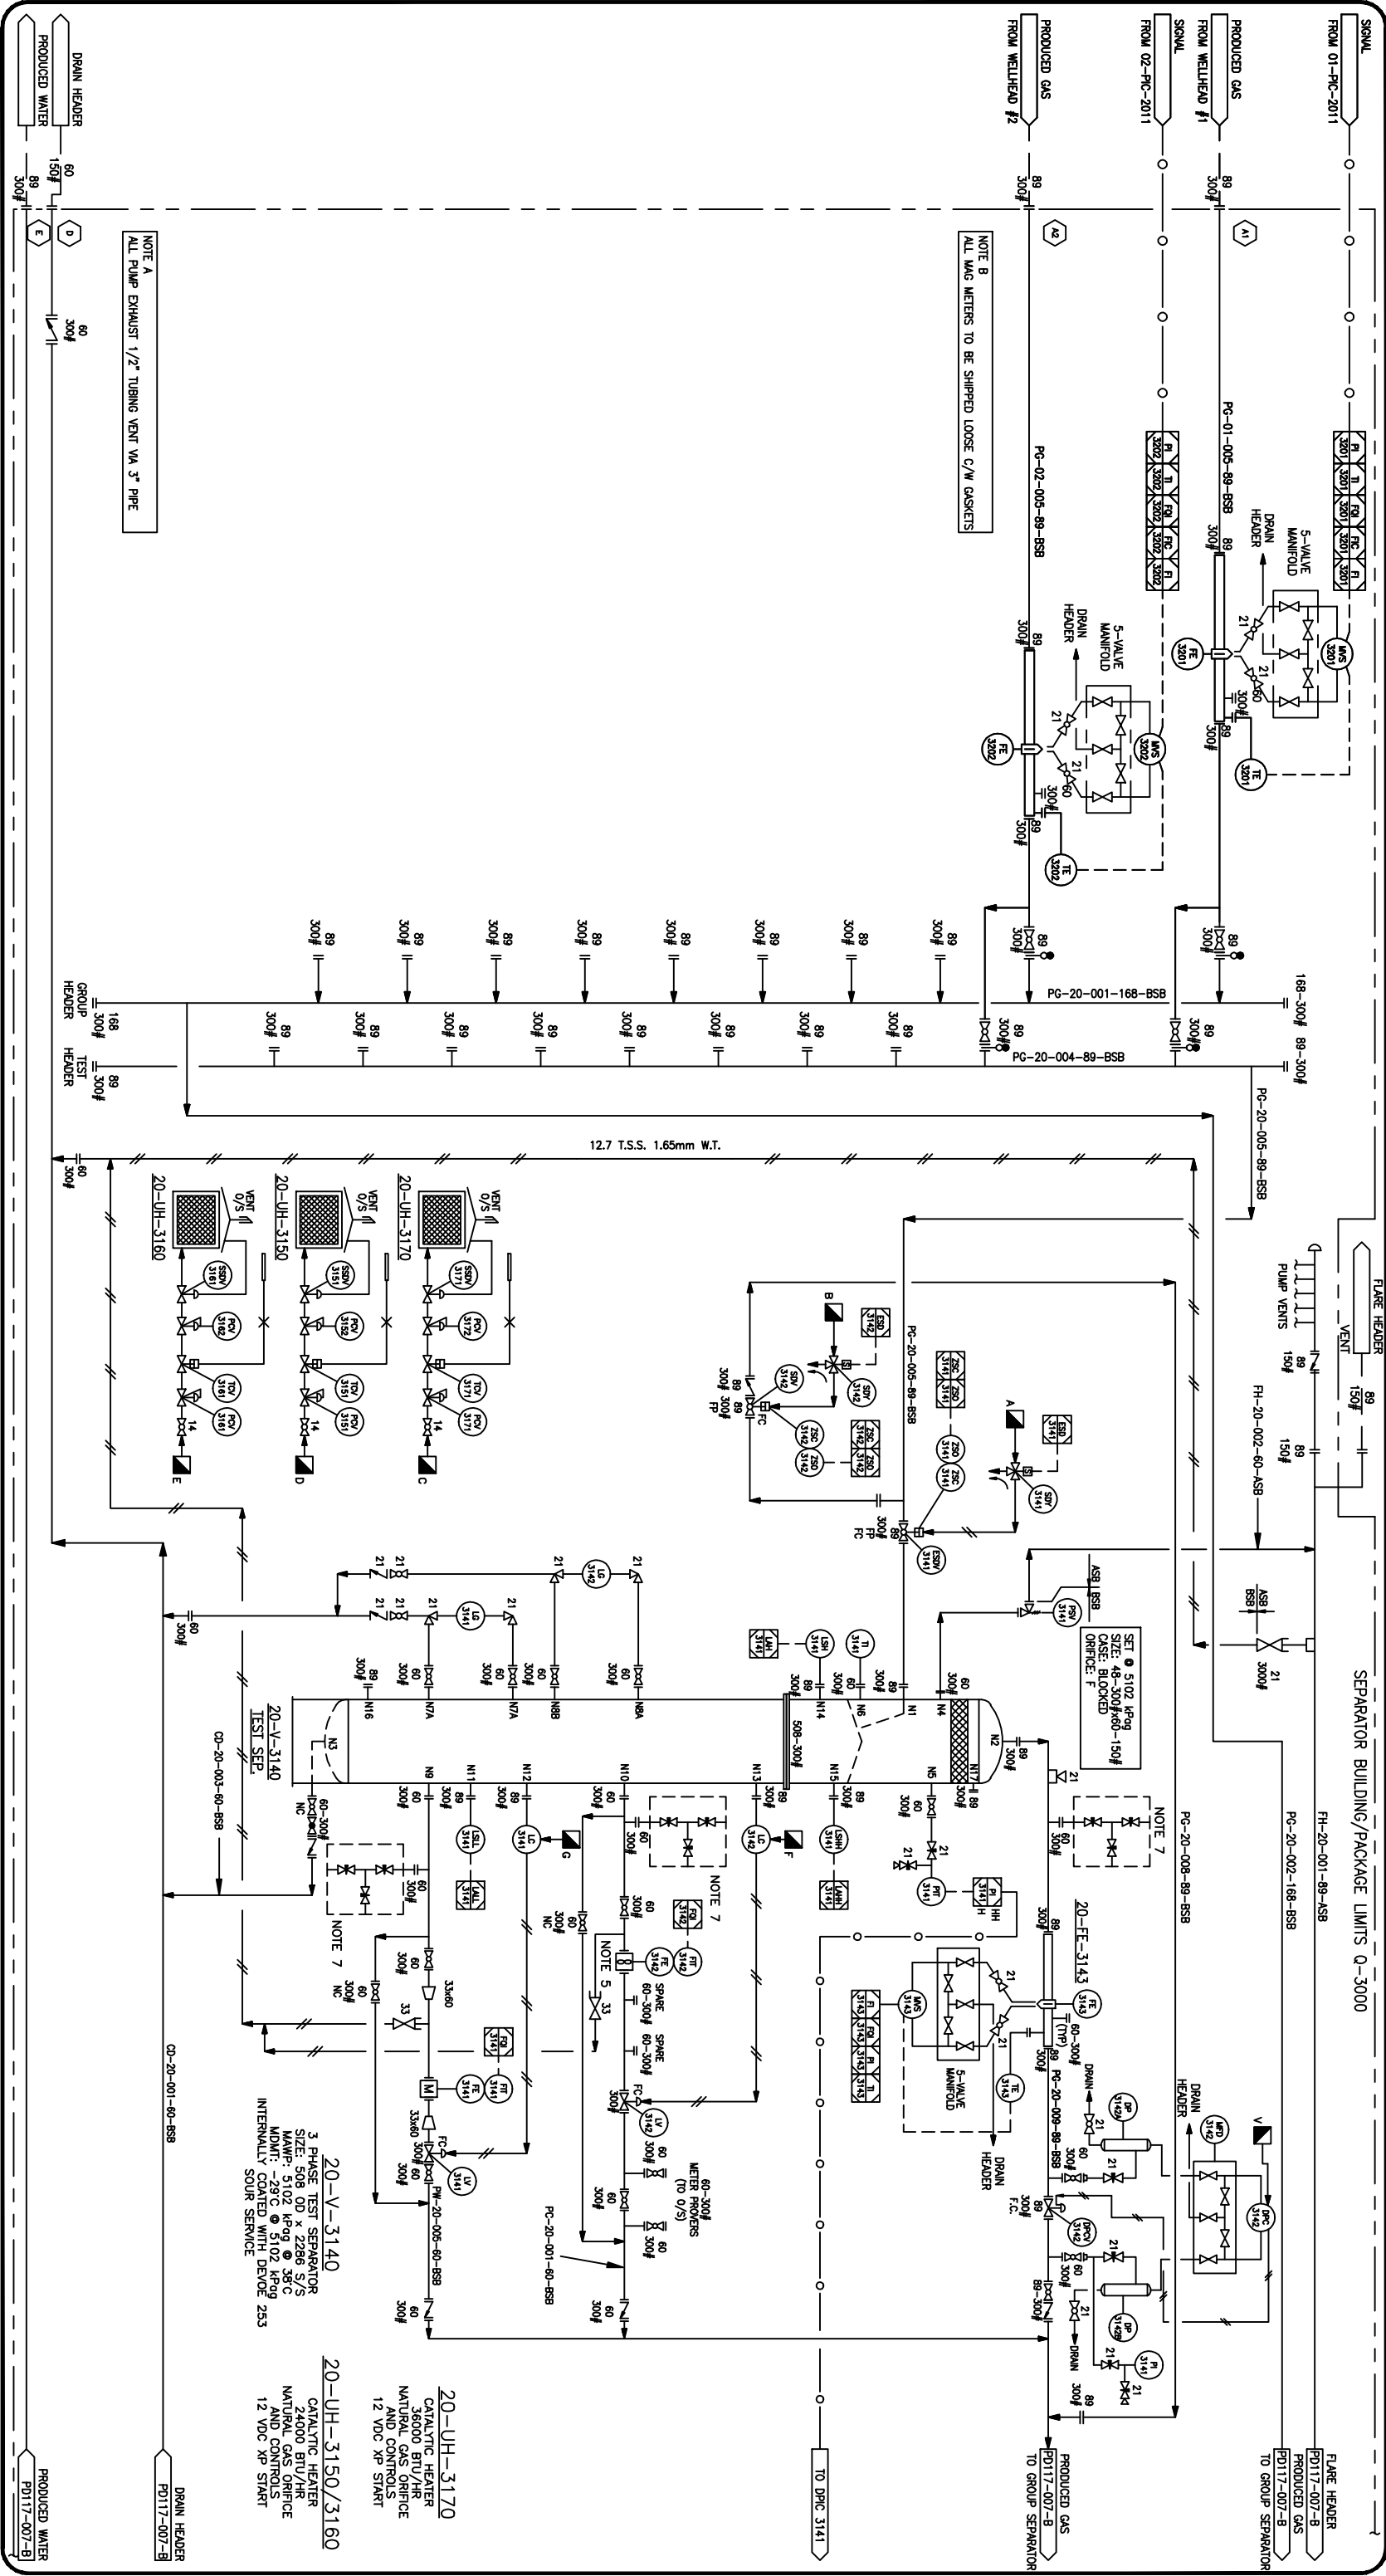

NOTE A
ALL PUMP EXHAUST 1/2" TUBING VENT VA 3" PIPE

NOTE B
ALL MAG METERS TO BE SHIPPED LOOSE C/W GASKETS

GENERAL NOTES:-

1. SEPARATORS TO BE FULLY INTERNALLY COATED.
2. CHEMICAL TANKS SUPPLIED BY ULTRAFAB.
3. PIPING SHALL BE PER EQUINOX SPEC. VENDOR TO SPECIFY MODEL NUMBERS FOR VALVES WITH SUITABLE CHLORIDE-RESISTANT MATERIAL.
4. ALL INSTRUMENT TAPS ON THIS DRAWING ARE PREFERED 20" GAS METERS
5. ALL INSTRUMENT AND 3/4" DOWNSTREAM OF METER REQUIRED PER OOC FOR LIQUID & GAS METERS
6. FUEL GAS PURGE FOR DRAIN HEADER.
7. SAMPLE QUILT PROVIDED BY EQUINOX, INSTALLED BY ULTRAFAB.
8. ALL INSTRUMENTS TO BE VENTED OUTSIDE VIA A 1/2" TUBING HEADER, 1 METER ABOVE EAVE HEIGHT.
9. TUBE FITTING TO BE 316SS SEAMLESS.
10. DISCHARGE TUBING TO THE WELHEAD TO BE 1/2" 0.085" WT.
11. ALL OTHER 1/2" TUBING TO BE 0.049" WT.
12. ALL INSTRUMENT GAS & FUEL GAS TUBING TO BE 3/8" 0.035" WT.
13. ALL INSTRUMENT GAS & FUEL GAS TUBING TO BE 3/8" 0.035" WT.

REV.	DATE	DESCRIPTION	DRAWN	CHECK	DESIGN	APPR.
2	08-NOV-11	AS BUILT				
1	14-JUL-11	REVISED & ISSUED FOR CONSTRUCTION	DZ		LM	
0	25-MAY-11	ISSUED FOR CONSTRUCTION	DZ		LM	

ULTRAFAB INDUSTRIES LTD.

CLIENT: MURPHY c/o EQUINOX ENGINEERING

TITLE: SEPARATOR PACKAGE SKID (20-PK-3000)


SHEET 1 OF 3 - P&ID

SCALE: N.T.S. DRAWING No. PD117-007-A

DATE: 05-29-11 TIME: 14:21

THIS DRAWING AND THE DESIGN IT COVERS ARE CONFIDENTIAL AND THE PROPERTY OF ULTRAFAB INDUSTRIES LTD. AND SHALL NOT BE DISCLOSED TO OTHERS OR REPRODUCED IN ANY MANNER OR USED FOR ANY PURPOSE WHATSOEVER EXCEPT BY WRITTEN CONSENT OF ULTRAFAB.

SEPARATOR BUILDING/PACKAGE LIMITS Q-3000

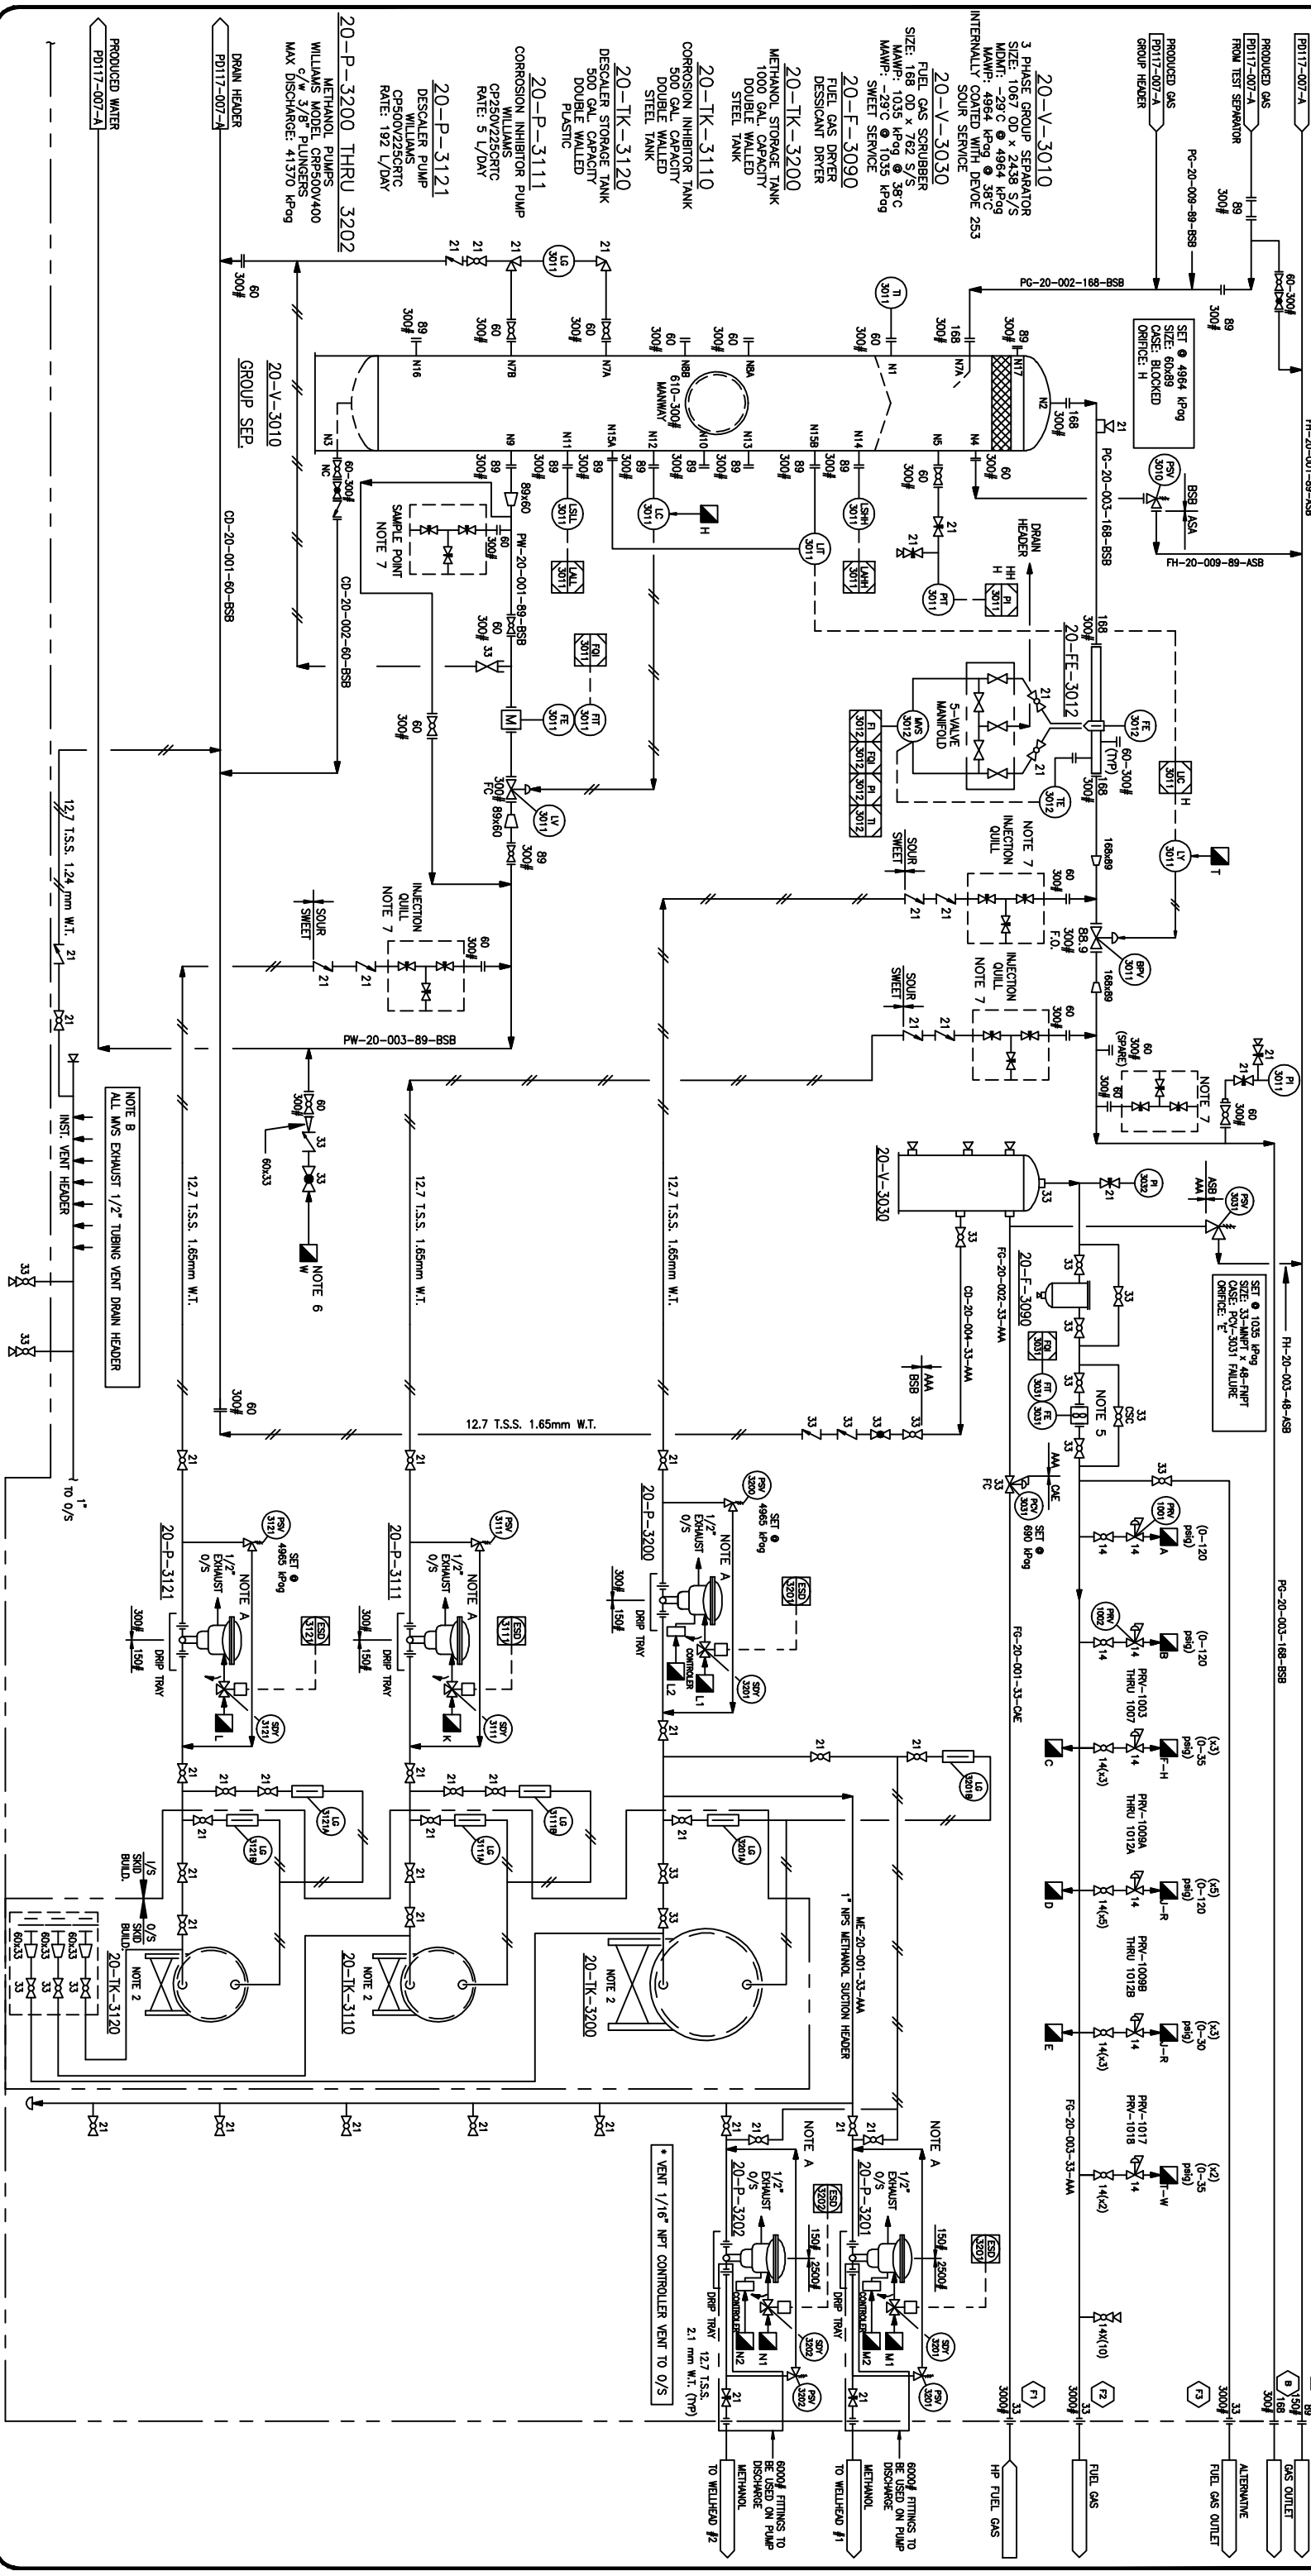

GENERAL NOTES: -									
2	08-NOV-11	AS BUILT							
1	14-JUL-11	REVISED & ISSUED FOR CONSTRUCTION	DZ			LM			
0	25-MAY-11	ISSUED FOR CONSTRUCTION	DZ			LM			
REV.	DATE	DESCRIPTION	DRAWN	CHECK	DESIGN	APPR.			

ULTRAFAB INDUSTRIES LTD.									
CLIENT: MURPHY OIL c/o EQUINOX ENGINEERING									
TITLE: SEPARATOR PACKAGE SKID (20-PK-3000)									
SHEET 2 OF 3 - <u>P&ID</u>									
SCALE:	N.T.S.	DRAWING No.	PD117-007-B	DATE	05-25-11	TIME	14:21		
FILE: - Projects 2011/117-000/117-007/Drawings/PD117-007-B									

