


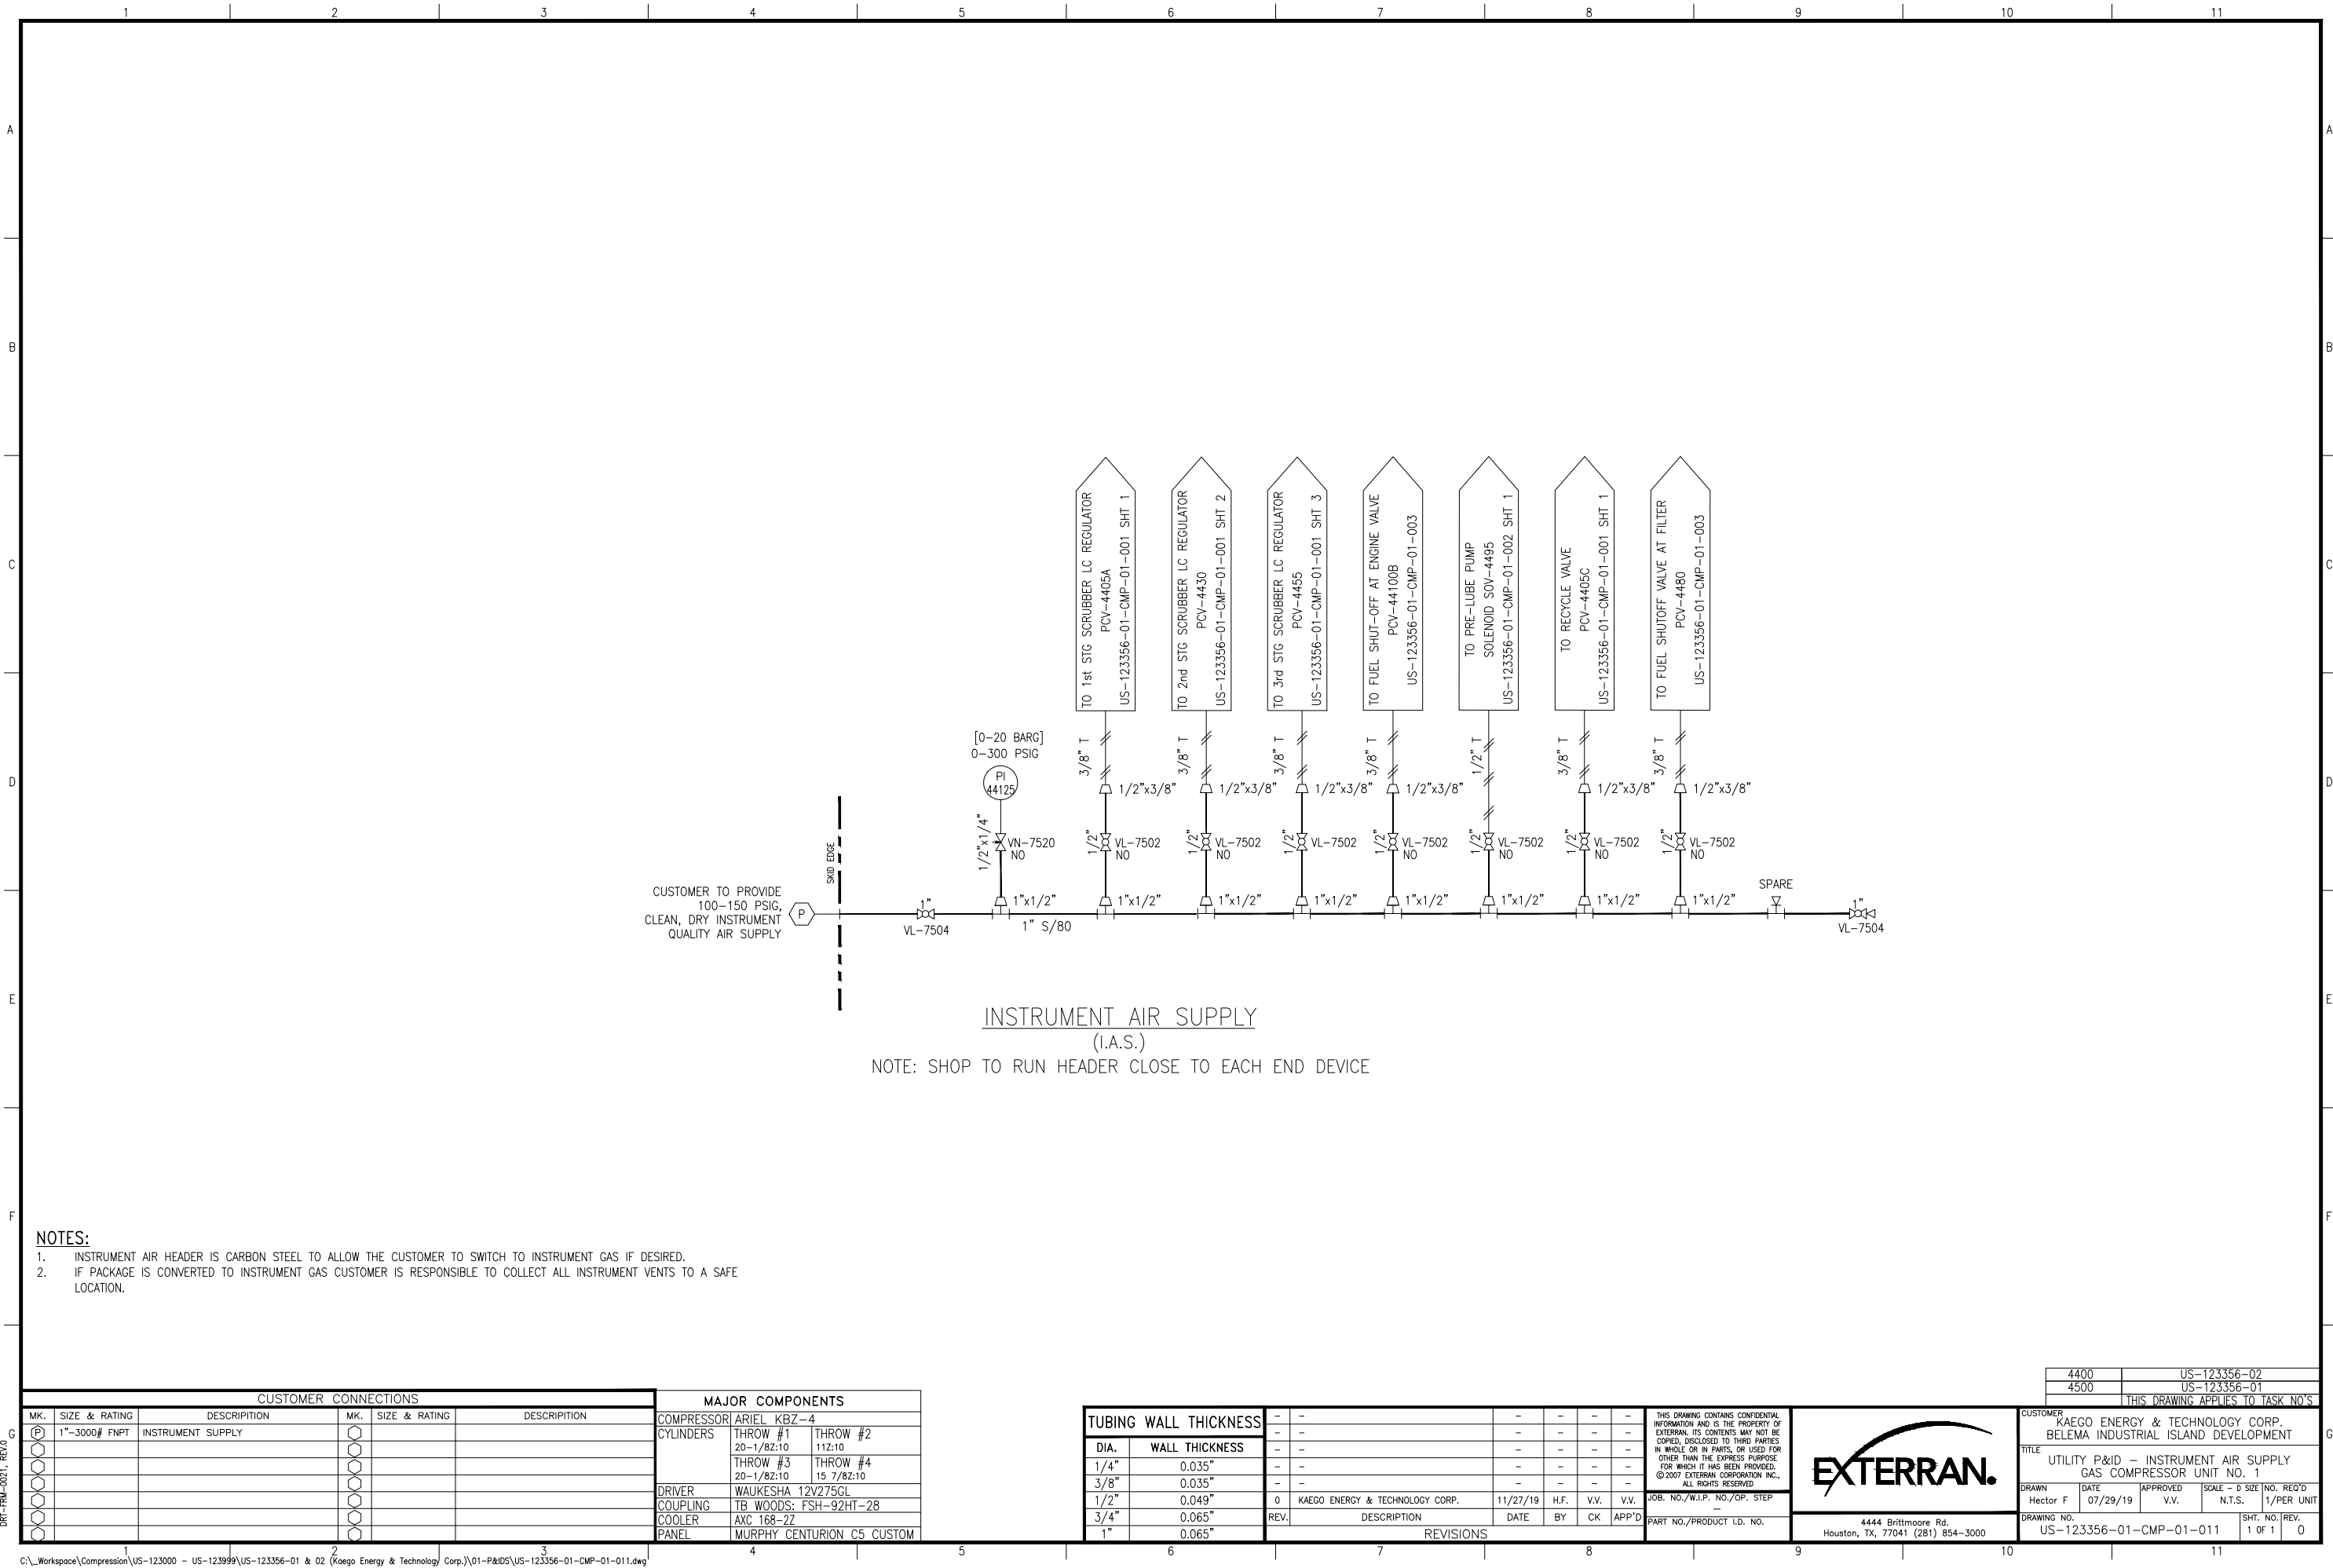

- NOTES:**
- INSTRUMENT AIR HEADER IS CARBON STEEL TO ALLOW THE CUSTOMER TO SWITCH TO INSTRUMENT GAS IF DESIRED.
 - IF PACKAGE IS CONVERTED TO INSTRUMENT GAS CUSTOMER IS RESPONSIBLE TO COLLECT ALL INSTRUMENT VENTS TO A SAFE LOCATION.

CUSTOMER CONNECTIONS			
MK.	SIZE & RATING	DESCRIPTION	
(P)	1"-3000# FNPT	INSTRUMENT SUPPLY	

MAJOR COMPONENTS		
COMPRESSOR	ARIEL KBZ-4	
CYLINDERS	THROW #1	THROW #2
	20-1/8Z:10	11Z:10
	THROW #3	THROW #4
	20-1/8Z:10	15 7/8Z:10
DRIVER	WAUKESHA 12V275GL	
COUPLING	TB WOODS: FSH-92HT-28	
COOLER	AXC 168-2Z	
PANEL	MURPHY CENTURION C5 CUSTOM	

TUBING WALL THICKNESS							
DIA.	WALL THICKNESS						
1/4"	0.035"						
3/8"	0.035"						
1/2"	0.049"						
3/4"	0.065"						
1"	0.065"						

THIS DRAWING CONTAINS CONFIDENTIAL INFORMATION AND IS THE PROPERTY OF EXTERRAN. ITS CONTENTS MAY NOT BE COPIED, DISCLOSED TO THIRD PARTIES IN WHOLE OR IN PARTS, OR USED FOR OTHER THAN THE EXPRESS PURPOSE FOR WHICH IT HAS BEEN PROVIDED. © 2007 EXTERRAN CORPORATION INC. ALL RIGHTS RESERVED.



4444 Brittmoore Rd.
Houston, TX, 77041 (281) 854-3000

4400	US-123356-02			
4500	US-123356-01			
THIS DRAWING APPLIES TO TASK NO'S				
CUSTOMER KAEGO ENERGY & TECHNOLOGY CORP. BELEMA INDUSTRIAL ISLAND DEVELOPMENT				
TITLE UTILITY P&ID - INSTRUMENT AIR SUPPLY GAS COMPRESSOR UNIT NO. 1				
DRAWN Hector F	DATE 07/29/19	APPROVED V.V.	SCALE - D N.T.S.	NO. REV'D 1/PER UNIT
DRAWING NO. US-123356-01-CMP-01-011				SHT. NO. REV. 1 OF 1 0