


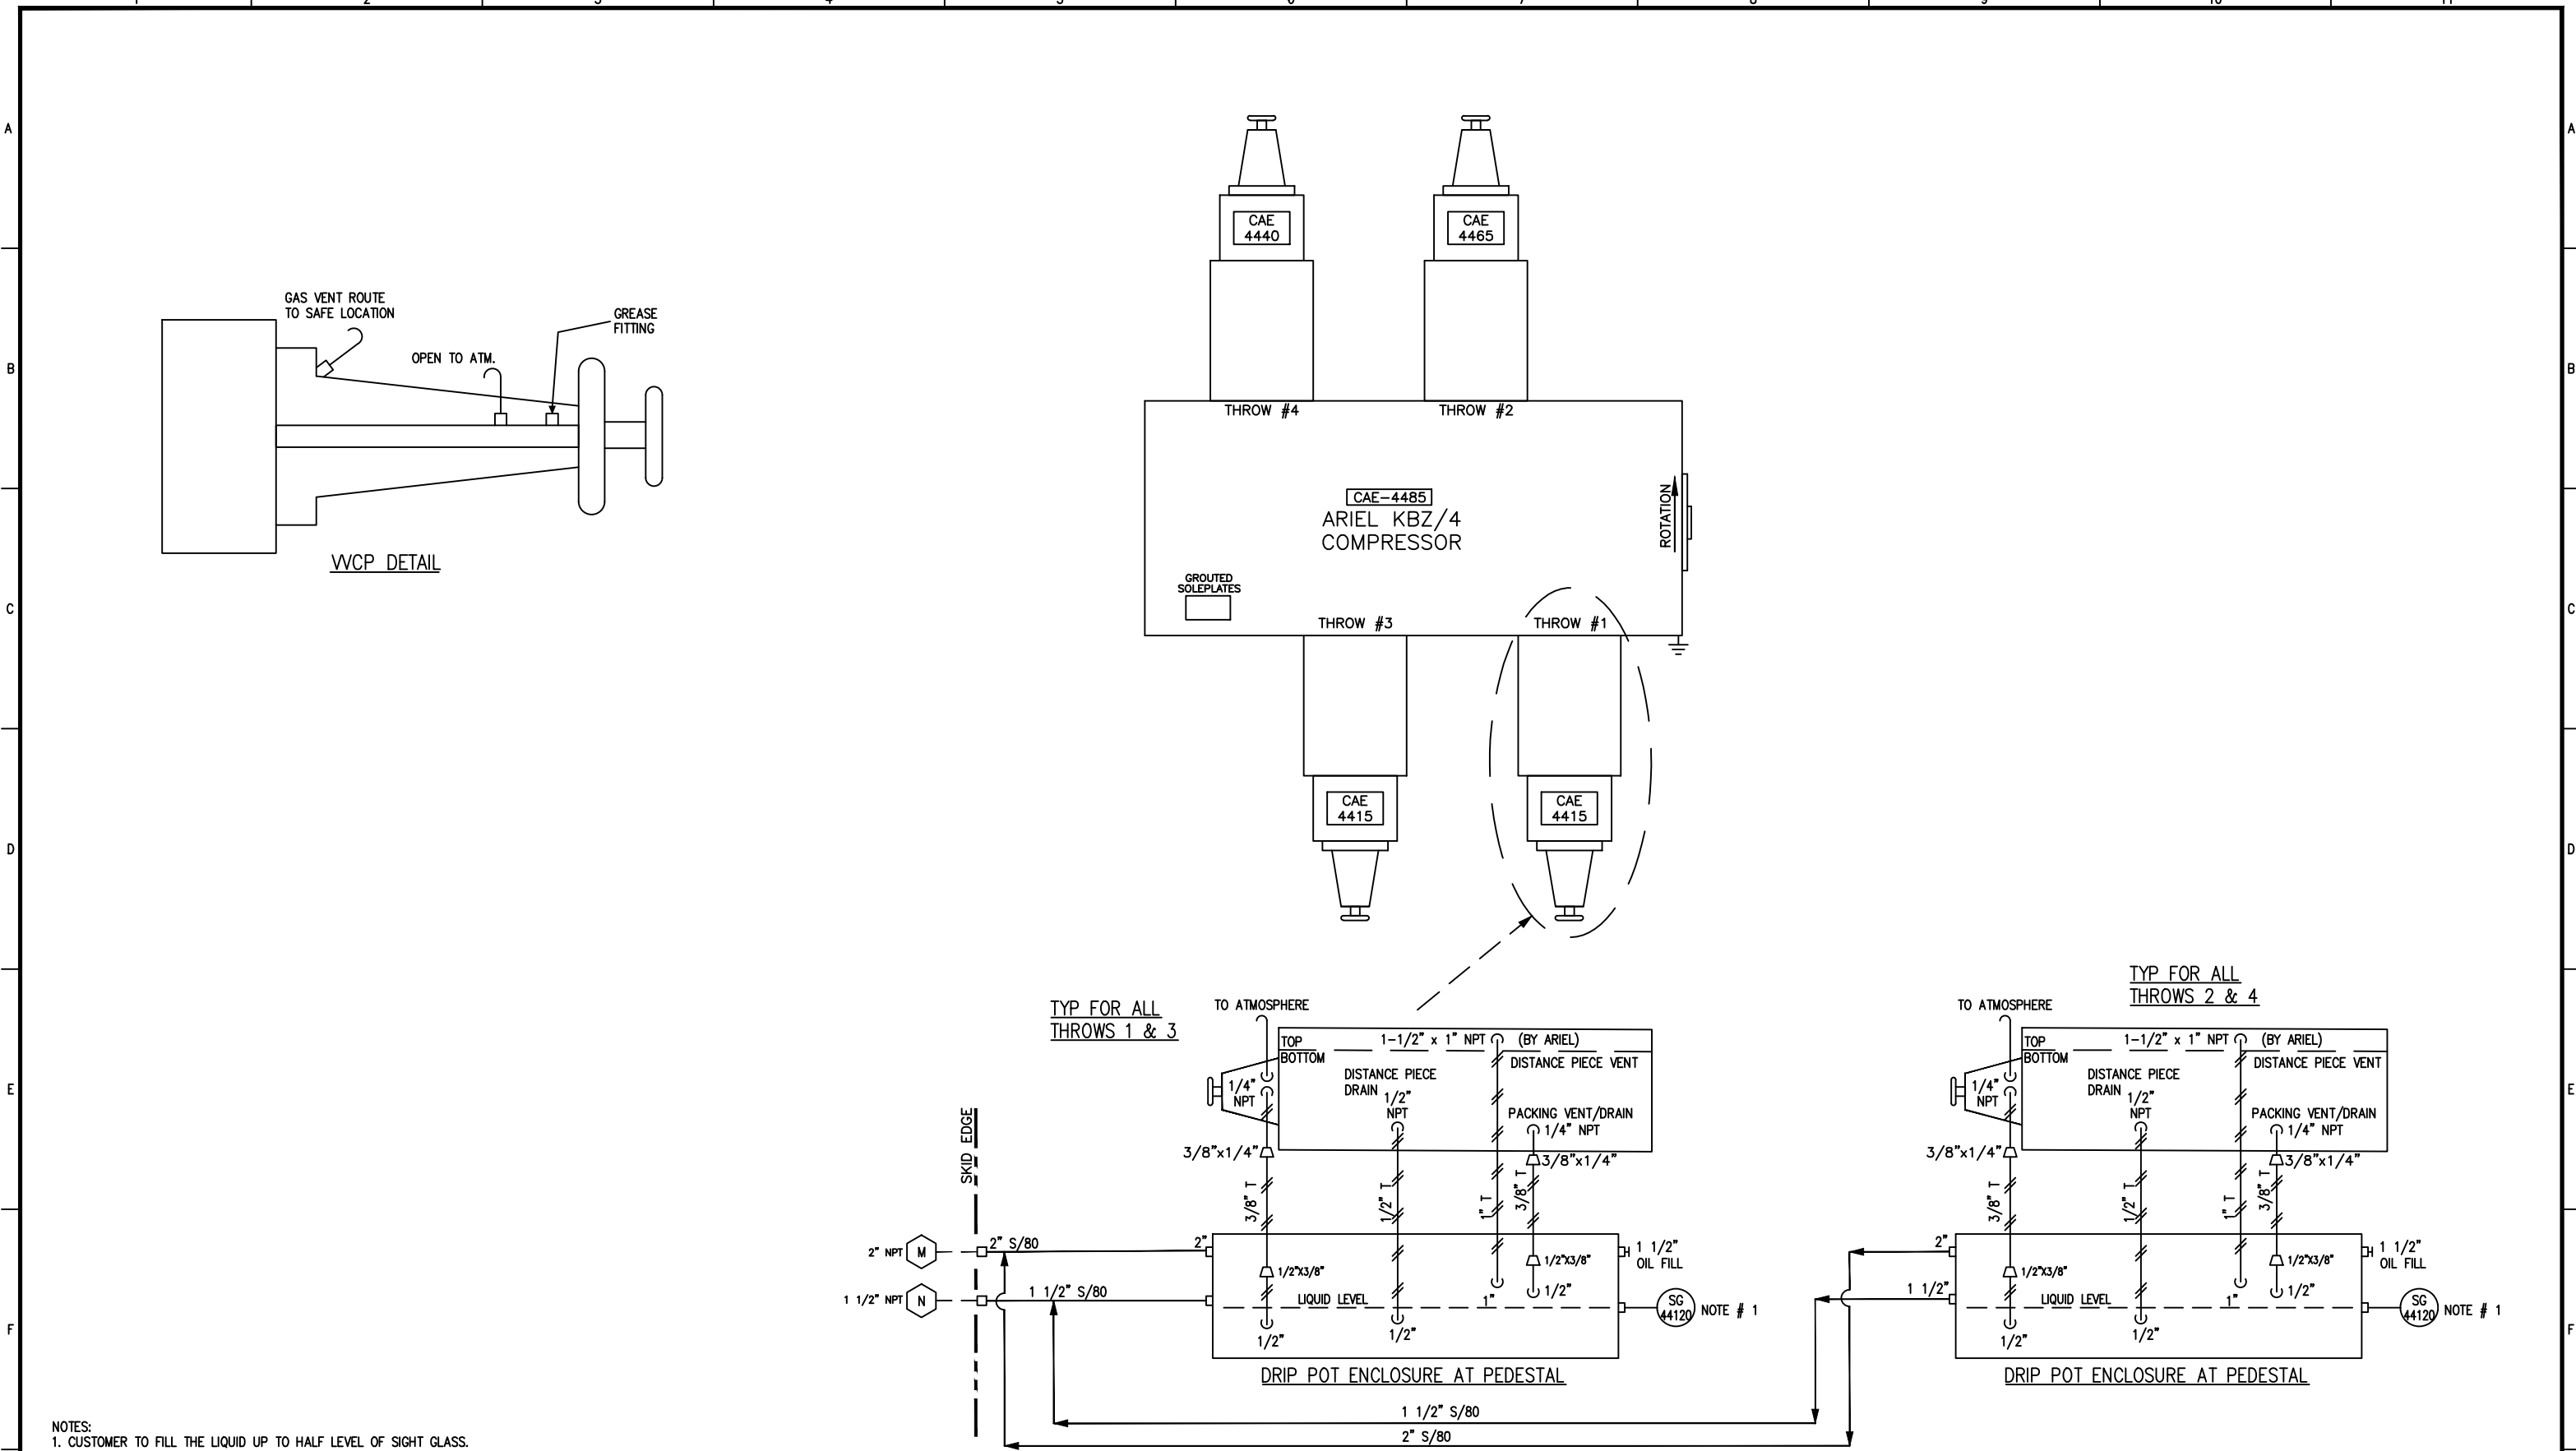

NOTES:
1. CUSTOMER TO FILL THE LIQUID UP TO HALF LEVEL OF SIGHT GLASS.

DRT-FRM-0021, REV 0

CUSTOMER CONNECTIONS				MAJOR COMPONENTS			
MK.	SIZE & RATING	DESCRIPTION		MK.	SIZE & RATING	DESCRIPTION	
(M)	2"-3000 # FNPT	DRIP POT VENT				COMPRESSOR	ARIEL KBZ-4
(N)	1 1/2"-3000 # FNPT	DRIP POT DRAIN				CYLINDERS	THROW #1 20-1/8Z:10 THROW #2 11Z:10 THROW #3 20-1/8Z:10 THROW #4 15 7/8Z:10
						DRIVER	WALKESHA 12V275GL
						COUPLING	TB WOODS: FSH-92HT-28
						COOLER	AXC 168-22
						PANEL	MURPHY CENTURION C5 CUSTOM

MAJOR COMPONENTS			
COMPRESSOR	ARIEL KBZ-4		
CYLINDERS	THROW #1 20-1/8Z:10 THROW #2 11Z:10 THROW #3 20-1/8Z:10 THROW #4 15 7/8Z:10		
DRIVER	WALKESHA 12V275GL		
COUPLING	TB WOODS: FSH-92HT-28		
COOLER	AXC 168-22		
PANEL	MURPHY CENTURION C5 CUSTOM		

TUBING WALL THICKNESS									
DIA.	WALL THICKNESS								
1/4"	0.035"	-	-	-	-	-	-	-	-
3/8"	0.035"	-	-	-	-	-	-	-	-
1/2"	0.049"	0	ISSUED FOR CONSTRUCTION	11/27/19	H.F.	V.V.	V.V.		
3/4"	0.065"	REV.	DESCRIPTION	DATE	BY	CK	APP'D		
1"	0.065"								

THIS DRAWING CONTAINS CONFIDENTIAL INFORMATION AND IS THE PROPERTY OF EXTERNAN. ITS CONTENTS MAY NOT BE COPIED, DISCLOSED TO THIRD PARTIES IN WHOLE OR IN PARTS, OR USED FOR OTHER THAN THE EXPRESS PURPOSE FOR WHICH IT HAS BEEN PROVIDED. © 2007 EXTERNAN CORPORATION INC. ALL RIGHTS RESERVED.			
JOB. NO./W.I.P. NO./OP. STEP			
PART NO./PRODUCT I.D. NO.			

4444 Brittmoores Rd.
Houston, TX, 77041 (281) 854-3000

4400	US-123356-02		
4500	US-123356-01		
THIS DRAWING APPLIES TO TASK NO'S			
CUSTOMER			
KAEGO ENERGY & TECHNOLOGY CORP.			
BELEMA INDUSTRIAL ISLAND DEVELOPMENT			
TITLE			
UTILITY P&ID (GAS COMPRESSOR UNIT NO. 1)			
DIS. PIECE VENT/DRAINS, PACKING DRAINS, WCP			
DRAWN	DATE	APPROVED	SCALE - D SIZE NO. REQ'D
Hector F	07/29/2019	V.V.	N.T.S. 1/PER UNIT
DRAWING NO.			SHT. NO. REV.
US-123356-01-CMP-01-007			1 OF 1 0