


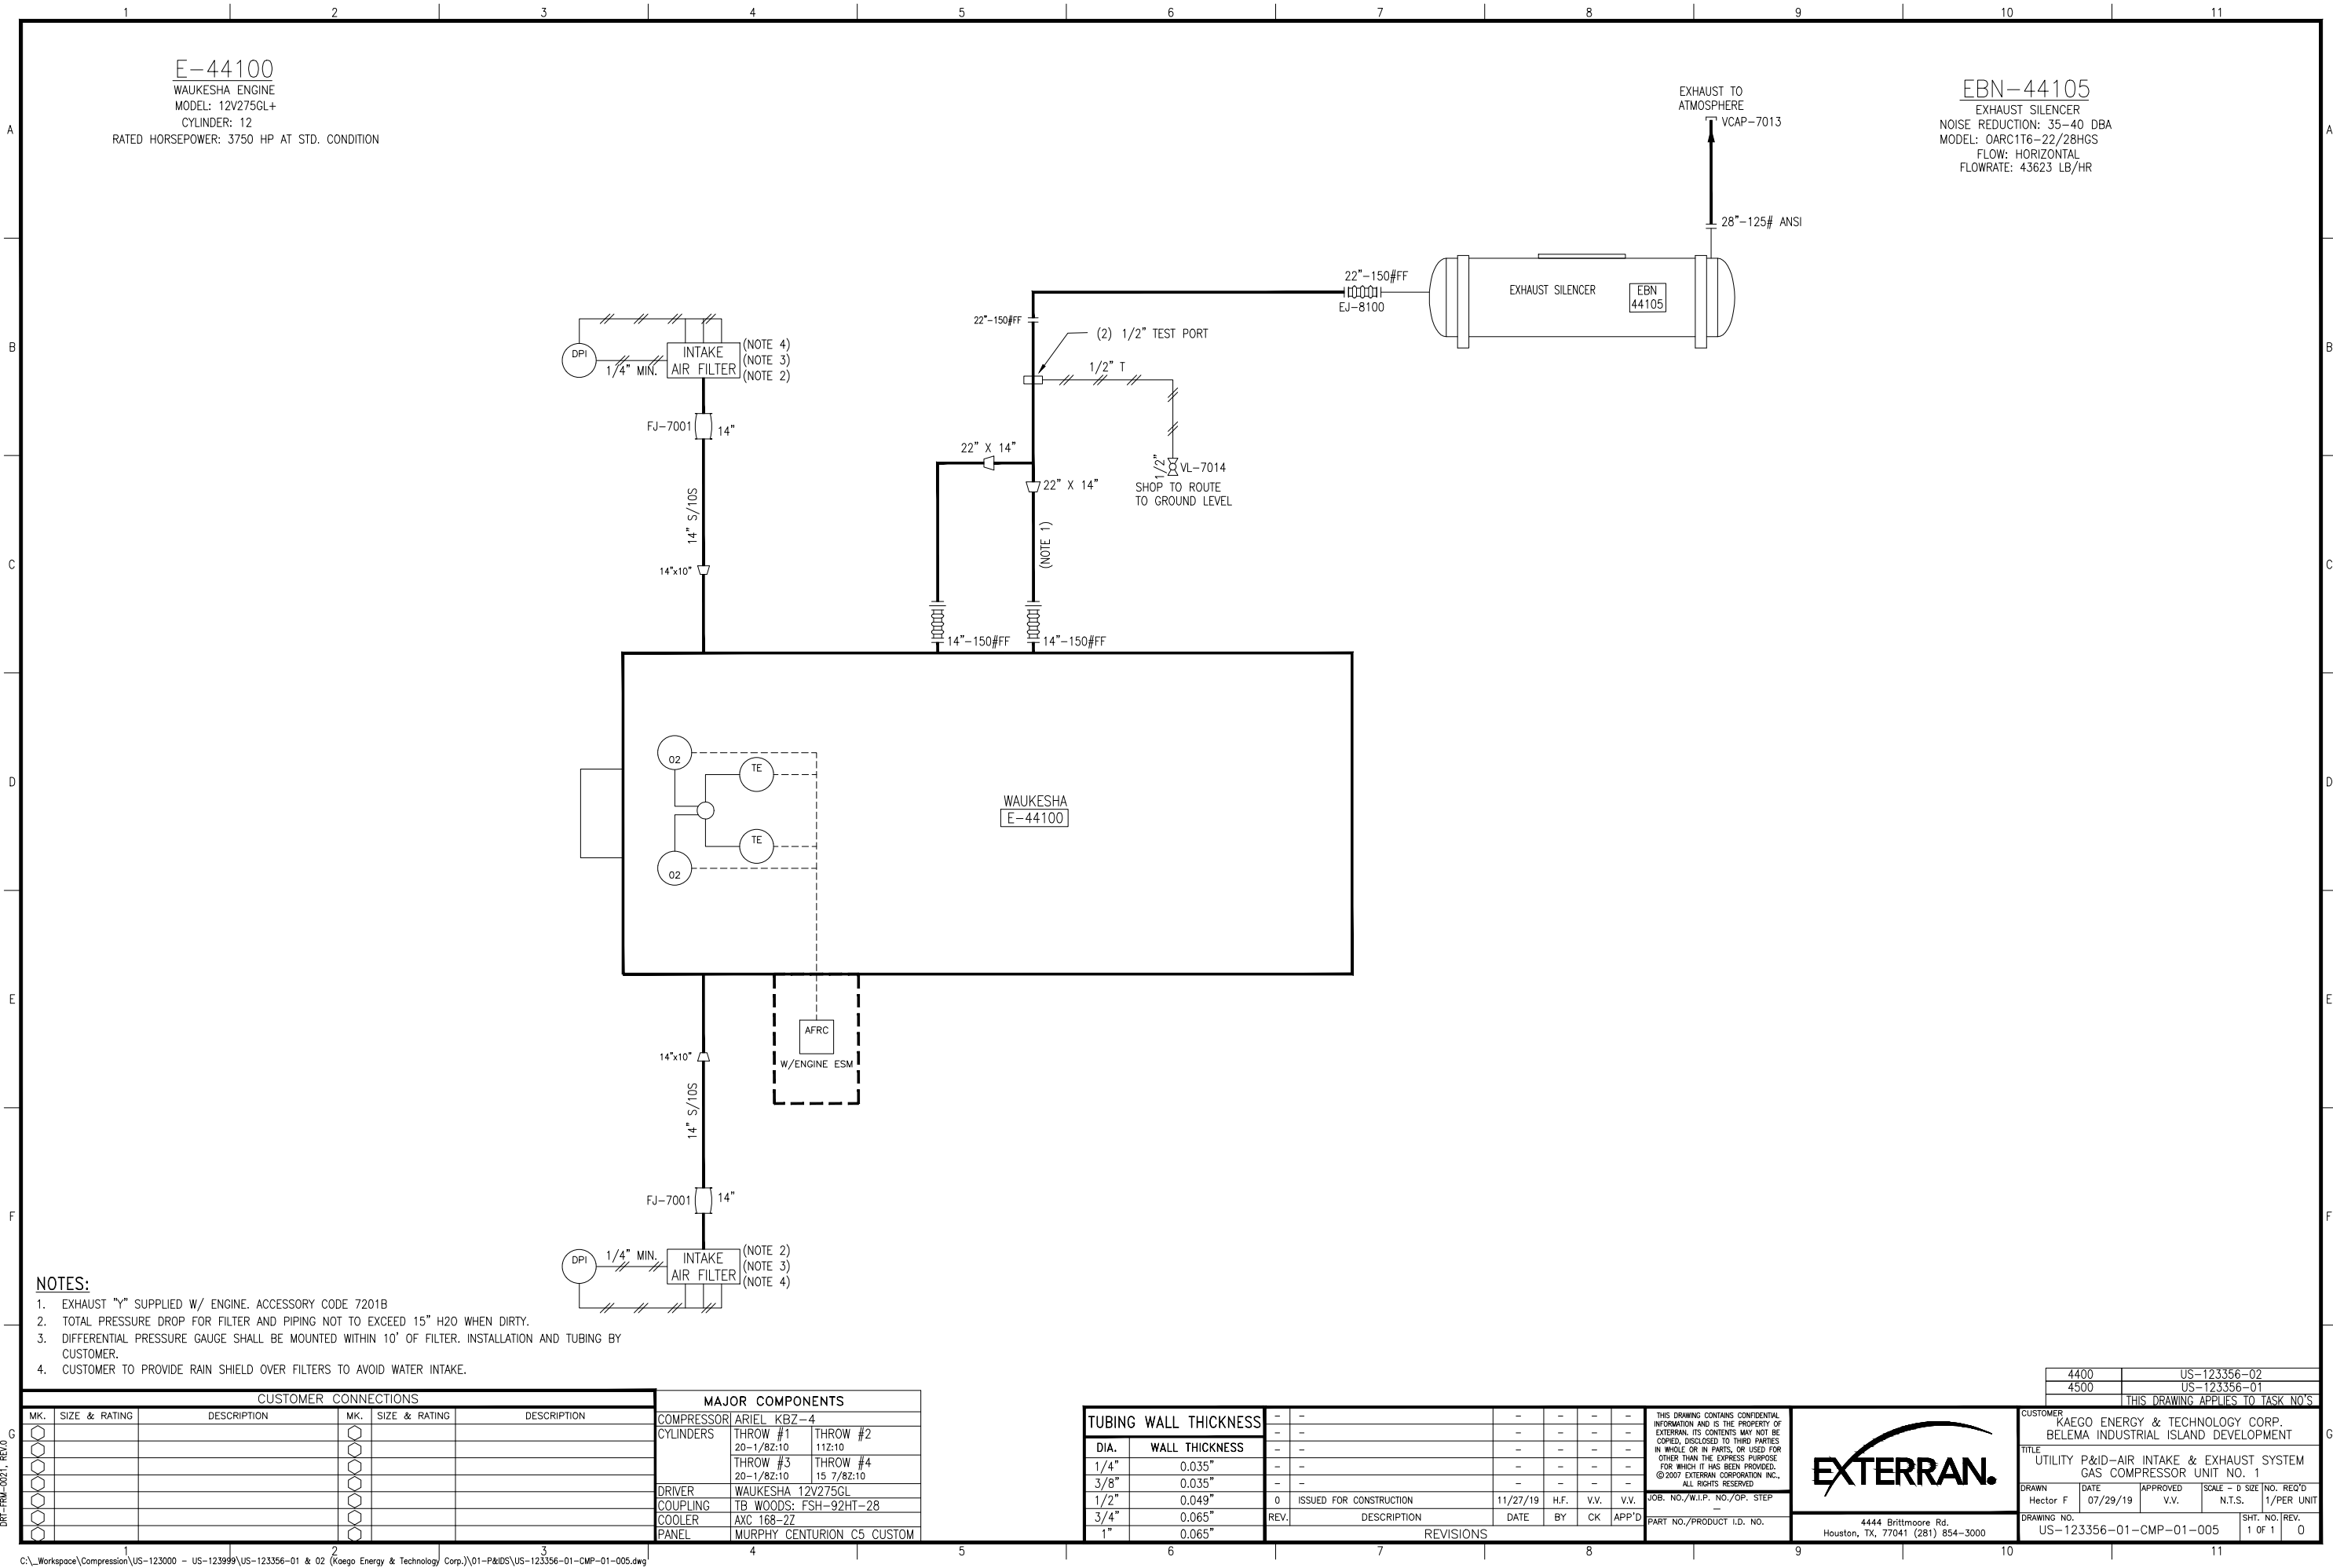

NOTES:

- 1. EXHAUST "Y" SUPPLIED W/ ENGINE. ACCESSORY CODE 7201B
- 2. TOTAL PRESSURE DROP FOR FILTER AND PIPING NOT TO EXCEED 15" H2O WHEN DIRTY.
- 3. DIFFERENTIAL PRESSURE GAUGE SHALL BE MOUNTED WITHIN 10' OF FILTER. INSTALLATION AND TUBING BY CUSTOMER.
- 4. CUSTOMER TO PROVIDE RAIN SHIELD OVER FILTERS TO AVOID WATER INTAKE.

CUSTOMER CONNECTIONS				MAJOR COMPONENTS			
MK.	SIZE & RATING	DESCRIPTION	MK.	SIZE & RATING	DESCRIPTION	COMPRESSOR	ARIEL KBZ-4
						CYLINDERS	THROW #1 20-1/8Z:10
							THROW #2 11Z:10
							THROW #3 20-1/8Z:10
							THROW #4 15 7/8Z:10
						DRIVER	WAUKESHA 12V275GL
						COUPLING	TB WOODS: FSH-92HT-28
						COOLER	AXC 168-22
						PANEL	MURPHY CENTURION C5 CUSTOM

TUBING WALL THICKNESS		-	-	-	-	-	-	THIS DRAWING CONTAINS CONFIDENTIAL INFORMATION AND IS THE PROPERTY OF EXTERRAN. ITS CONTENTS MAY NOT BE COPIED, DISCLOSED TO THIRD PARTIES IN WHOLE OR IN PARTS, OR USED FOR OTHER THAN THE EXPRESS PURPOSE FOR WHICH IT HAS BEEN PROVIDED. © 2007 EXTERRAN CORPORATION INC., ALL RIGHTS RESERVED			
DIA.	WALL THICKNESS	-	-	-	-	-	-				
1/4"	0.035"	-	-	-	-	-	-				
3/8"	0.035"	-	-	-	-	-	-				
1/2"	0.049"	0	ISSUED FOR CONSTRUCTION	11/27/19	H.F.	V.V.	V.V.	JOB. NO./W.I.P. NO./OP. STEP	-	-	-
3/4"	0.065"	REV.	DESCRIPTION	DATE	BY	CK	APP'D	PART NO./PRODUCT I.D. NO.	4444 Brittmoore Rd. Houston, TX, 77041 (281) 854-3000		
1"	0.065"	REVISIONS				PART NO./PRODUCT I.D. NO.			4444 Brittmoore Rd. Houston, TX, 77041 (281) 854-3000		

4400	US-123356-02
4500	US-123356-01
THIS DRAWING APPLIES TO TASK NO'S	

CUSTOMER		KAEGO ENERGY & TECHNOLOGY CORP.	
		BELEMA INDUSTRIAL ISLAND DEVELOPMENT	
TITLE			
UTILITY P&ID-AIR INTAKE & EXHAUST SYSTEM GAS COMPRESSOR UNIT NO. 1			
DRAWN	DATE	APPROVED	SCALE - D SIZE
Hector F	07/29/19	V.V.	N.T.S.
DRAWING NO.	US-123356-01-CMP-01-005		SHT. NO. REV.
		1 OF 1 0	