


FILE PATH: MAINDATA\CAD\TANKS\A600-A699\A662-4

LEGEND

- BALL VALVE
 - REGULATOR
 - NEEDLE VALVE
 - SWING CHECK VALVE

NOZZLE SCHEDULE

MARK	NO. REQ'D	DESCRIPTION	SIZE	ANSI	TYPE
N1	1	INLET/OUTLET	6"	150#	RFWN
N2	1	INLET/OUTLET	6"	150#	RFWN
N3	1	GAUGE	4"	150#	RFWN
N4A/B	2	LEVEL GAUGE	2"	150#	RFWN
N5	1	TRUCKOUT	3"	150#	RFSO
N6	1	VAPOR	3"	150#	RFWN
N7	1	SPARE	6"	160#	RFWN
C1	1	SUCKOUT	1"	3000#	TOL
C2A/B	2	PURGE GAS	1"	3000#	TOL
M1	1	MANWAY	24"	150#	RFSO

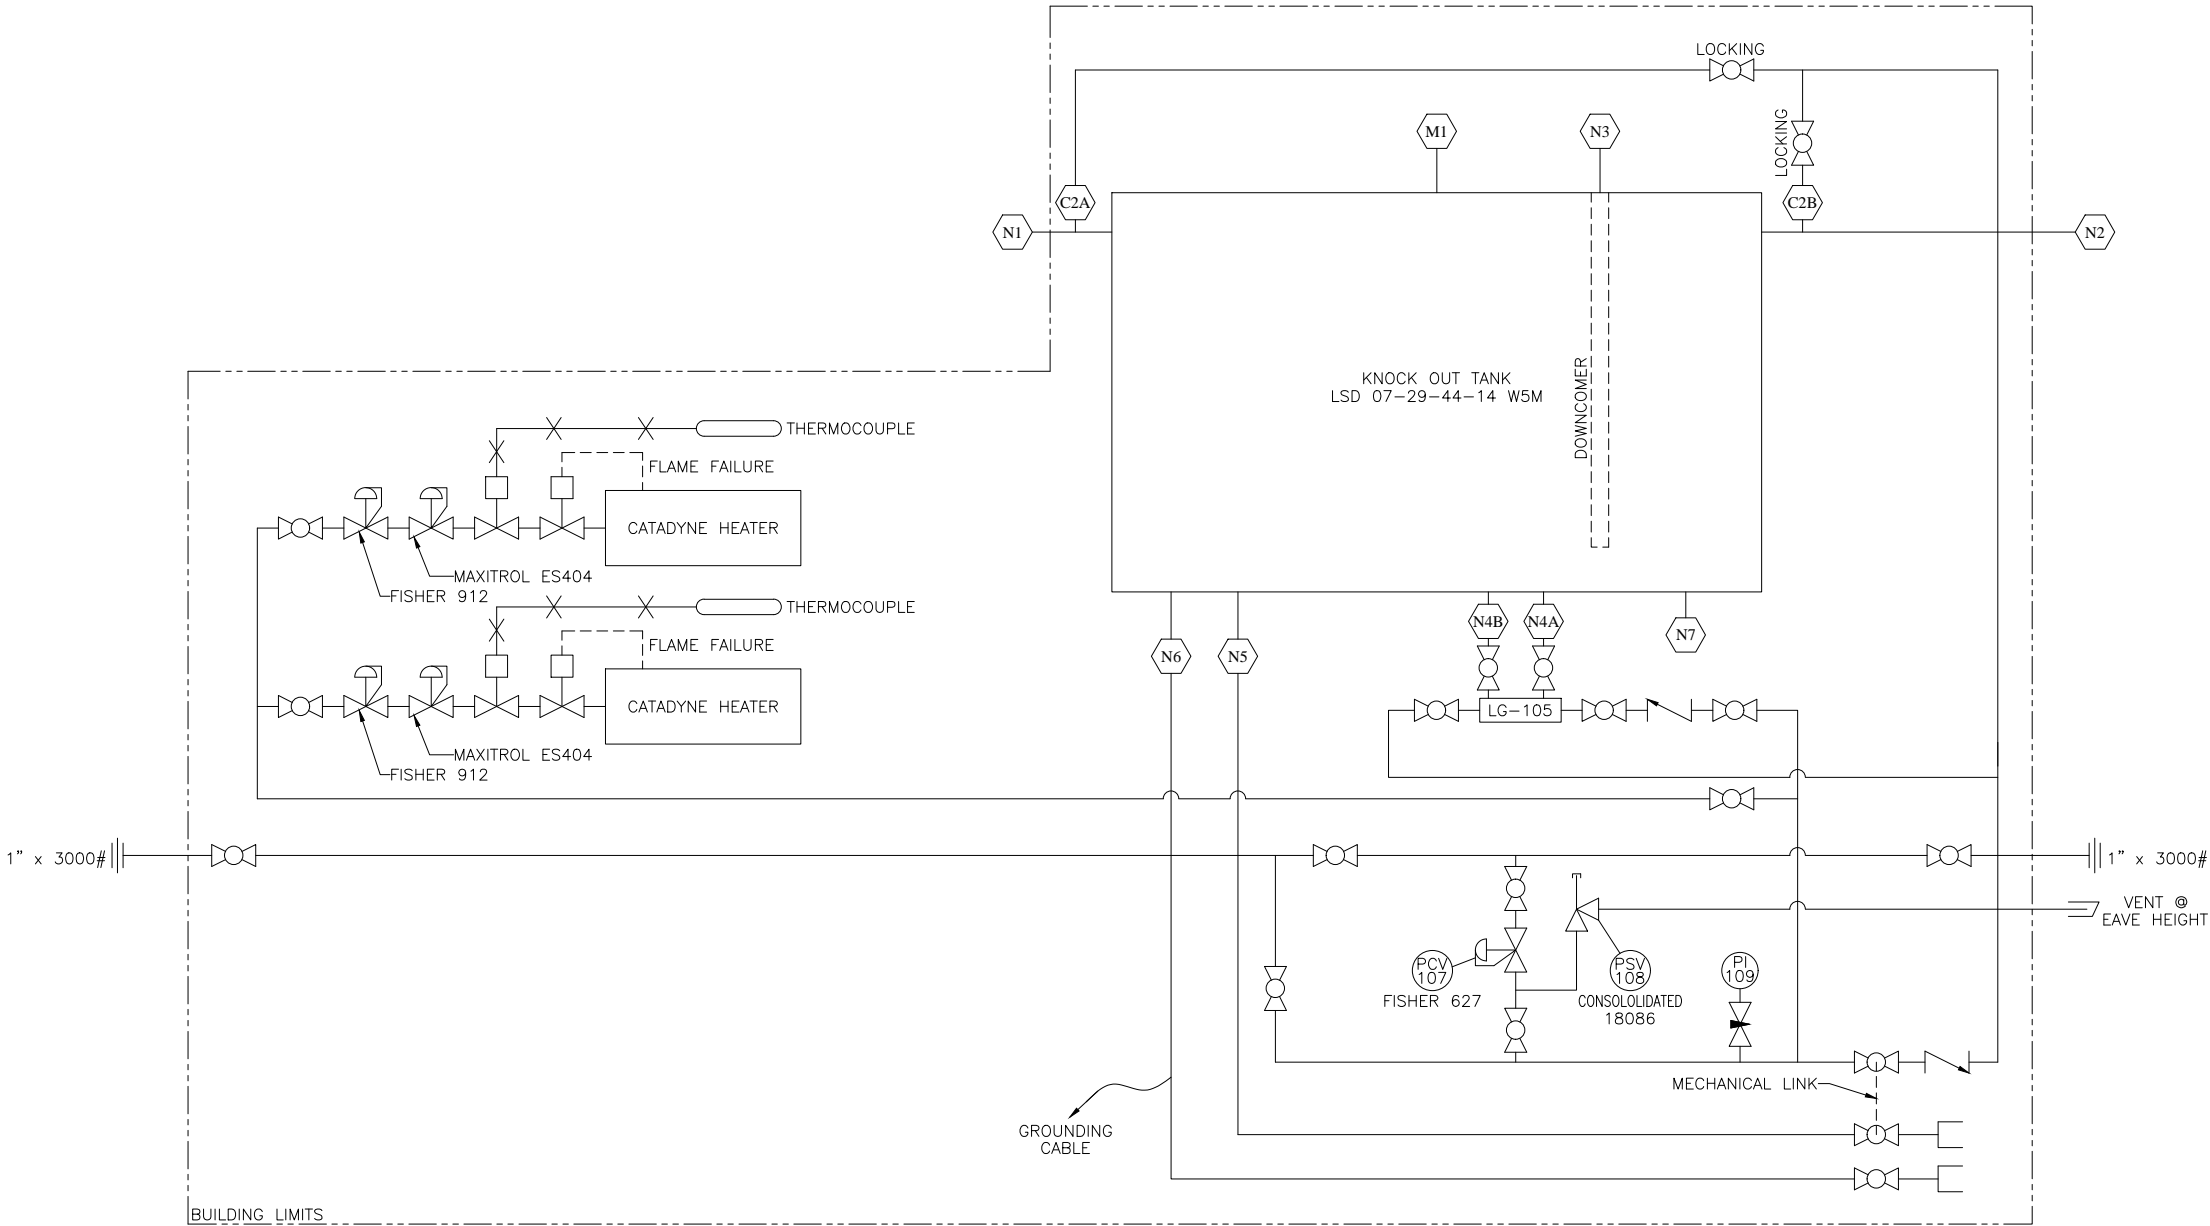

REV. NO.	DATE	REVISION	BY	APPD
0	06/20/03	ISSUED FOR FABRICATION	DSG	

BILTON
Welding & Manufacturing Ltd.

BOX 6106
5815 37 Street
INNISFAIL, AB
CANADA
403-227-7799
1-888-227-4923
FAX 227-7796

This drawing is property of BILTON WELDING & MANUFACTURING LTD. and is lent to the recipient for their confidential use only. In consideration of the loan of this drawing, the recipient promises and agrees that it shall not be used in any way detrimental to the interests of BILTON WELDING & MANUFACTURING LTD., that it shall be returned upon request, and that it shall not be reproduced, copied, lent, or otherwise disposed of, directly or indirectly, without the written consent of BILTON WELDING & MANUFACTURING LTD.

BP CANADA ENERGY

60 BBL ABOVE GROUND SINGLE WALL FLARE KNOCKOUT DRUM
P&ID

DATE: 06/20/03	SHEET: 4 OF 5
SCALE: N.T.S.	JOB NO.:
DRAWN BY: DSG	A662
PURCHASE ORDER:	SIZE D
LOCATION: 10-07 COMPRESSOR	DRAWING NO.:
APP'D BY:	A662-4
CRN: N/A	REV. 0