

REV.
DRAWING NO.

B

C

D

E


F

V-100
3-PHASE HORIZONTAL SEPARATOR

SCORE 36"OD X 10' S/S
DESIGN PRESSURE: 1440PSI @ -20°F/130°F,
REGISTERED IN AB, BC, & SK.
CRN: #V9022.213

H-400
BUILDING HEATER

CCI 20,000 BTU/HR, 24"x24"
12VDC START w/30' CABLES
SAFETY SHUT OFF, 912 REGULATOR
TEMP CONTROL, NATURAL GAS

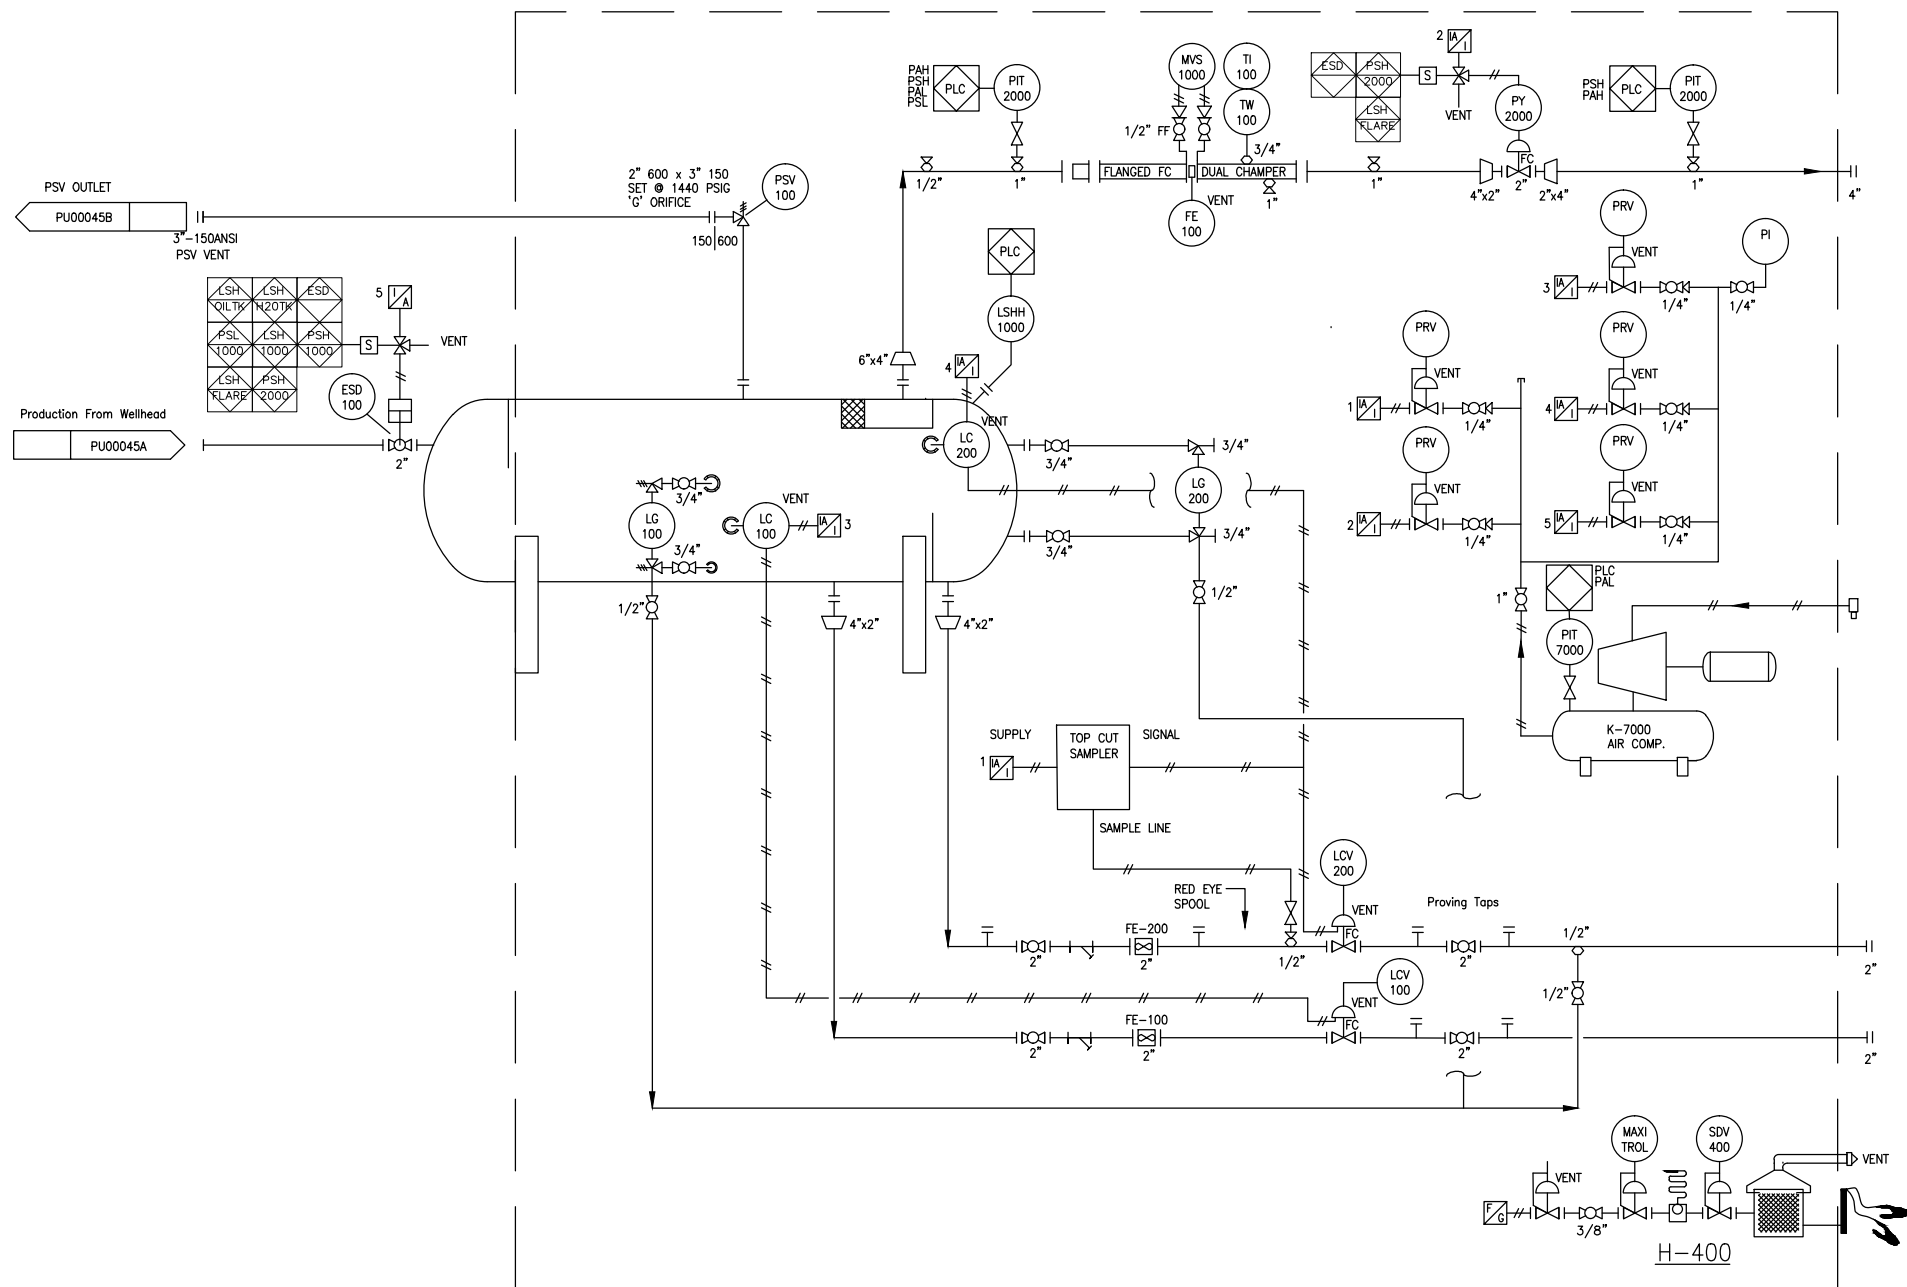

H-11 Test Separator

NOTES:
-GASKETS ARE PER SKY EYE MEASUREMENT SOUR SPEC.
-1/8" SPIRAL WOUND W/316SS WINDINGS
-BLEED RINGS TO BE 316SS RF
-TUBING FITTINGS TO BE 316SS SWAGELOK
-PAINT SPEC SKY EYE MEASUREMENT RRSPS
-FOR INSPECTION PARAMETERS SEE PIPING SPECIFICATION

LINE NUMBER
LINE SIZE
SPECIFICATION
LINE NUMBER


THIS DRAWING CONTAINS SKY EYE MEASUREMENT PROPRIETARY AND CONFIDENTIAL INFORMATION AND IS LOANED FOR LIMITED PURPOSES ONLY AND REMAINS THE PROPERTY OF SKY EYE MEASUREMENT. IT MAY NOT BE REPRODUCED IN WHOLE OR IN PART WITHOUT THE WRITTEN PERMISSION OF SKY EYE MEASUREMENT, AND MUST NOT BE DISCLOSED CONSISTENT WITH THE PURPOSE OF THE LOAN. THE DOCUMENT MUST BE RETURNED TO SKY EYE MEASUREMENT UPON REQUEST AND IN ALL EVENTS UPON COMPLETION OF THE USE FOR WHICH IT WAS LOANED.

PIPING SPECIFICATION: SEVERE SERVICE						DRAWING REVISION				
SPEC	ANSI	PRESSURE	TEMP	MAT'L	I/C	REV.	DATE	DESCRIPTION	BY	CHK.
-	-	-	-	-	-	-	-	-	-	-
-	-	-	-	-	-	-	-	-	-	-
PROCESS FLOW DIAGRAM

QUOTE:
JOB NUMBER:
DATE:
DWN:
SCALE:
DRAWING NO:

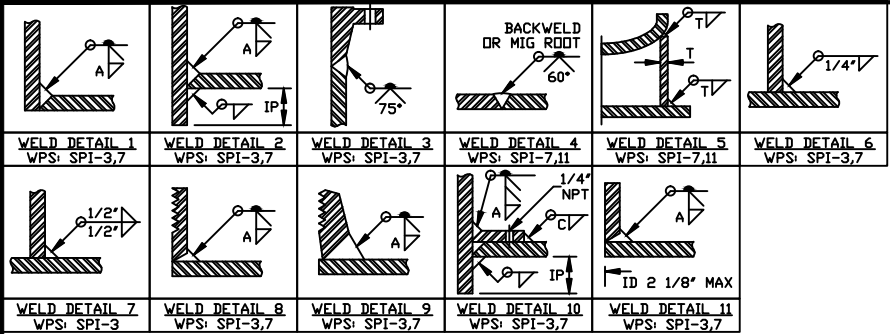

CONNECTION SCHEDULE												
MARK	QTY	SIZE	SCH	CLASS & TYPE	SERVICE	MINIMUM PROJECTION		WELD SIZE			WELD DETAIL	BOM ITEM NO.
						INSIDE	OUTSIDE	A	B	C		
N1	1	6"	1.38"	600 RFLWN	INLET	1/2"	8"	3/8"	-	-	2	4
N2	1	6"	1.38"	600 RFLWN	GAS OUT	1"	8"	3/8"	-	-	2	5
N3	1	4"	XXH	600 RFLWN	H2O OUT	0"	8"	3/8"	-	9/16"	2, 3	6, 12, 23
N4	1	4"	XXH	600 RFLWN	OIL OUT	0"	8"	3/8"	-	9/16"	2, 3	6, 12, 23
N5A	1	2"	0.655"	600 RFLWN	H2O LC	1 1/8"	AS REQ'D	3/8"	-	-	2	9
N5B	1	2"	160	600 RFLWN	H2O LC	N/A	AS REQ'D	3/8"	-	-	2, 3	10, 16
N6A	1	2"	0.655"	600 RFLWN	OIL LC	1 1/8"	AS REQ'D	3/8"	-	-	2	9
N6B	1	2"	160	600 RFLWN	OIL LC	0"	AS REQ'D	3/8"	-	-	2, 3	10, 15
N7	1	3"	0.81"	600 RFLWN	HLSD / INSP	1 1/2"	AS REQ'D	3/8"	-	-	2	7
N8	1	3"	0.81"	600 RFLWN	OIL LC	1/2"	AS REQ'D	3/8"	-	-	2	8
N9	1	2"	160	600 RFLWN	PSV	0"	6"	3/8"	-	-	3, 11	10, 14
N10	1	2"	160	600 RFLWN	LG HYDROVENT	0"	AS REQ'D	3/8"	-	-	3, 11	10, 13

BILL OF MATERIALS					
ITEM	QTY	COMMENT	DESCRIPTION		MATERIAL
1	2	HEADS	PLATE - 36"OD x 1 1/2" THK 2:1 SE, 2" SF HF (1.4375" MIN)		SA-516-70N
2	1	SHELL	PLATE - 36"OD x 10'-0" LG x 1 1/2" THK		SA-516-70N
3					
4	1	N1	FLANGE - 6" CLASS 600 RFLWN x 18" LG (1.38")		SA-350-LF2
5	1	N2	FLANGE - 6" CLASS 600 RFLWN x 12" LG (1.38")		SA-105N
6	2	N3, N4	FLANGE - 4" CLASS 600 SCH.XXH RFWN (0.674")		SA-105N
7	1	N7	FLANGE - 3" CLASS 600 RFLWN x 12" LG (0.81")		SA-105N
8	1	N8	FLANGE - 3" CLASS 600 RFLWN x 9" LG (0.81")		SA-105N
9	2	N5A, N6A	FLANGE - 2" CLASS 600 RFLWN x 9" LG (0.344")		SA-105N
10	4	N5B, N6B, N9, N10	FLANGE - 2" CLASS 600 SCH.160 RFWN (0.655")		SA-105N
11					
12	2	N3, N4	PIPE - 4" SCH.XXH x 6' LONG (0.674")		SA-106-B
13	1	N10	PIPE - 2" SCH.160 x 4' LONG (0.344")		SA-106-B
14	1	N9	PIPE - 2" SCH.160 x 6' LONG (0.344")		SA-106-B
15	1	N6B	PIPE - 2" SCH.160 x 7' LONG (0.344")		SA-106-B
16	1	N5B	PIPE - 2" SCH.160 x 16 3/4' LONG (0.344")		SA-106-B
17	1	BASE PLATE	PLATE - 33" x 9" x 3/4" THK - ANCHOR HOLE		G40.21 - 44W
18	1	BASE PLATE	PLATE - 33" x 9" x 3/4" THK - SLOTTED HOLE		G40.21 - 44W
19	2	LEGS	PLATE - 3/8" THK SEE DETAIL		G40.21 - 44W
20					
21	2	NAME PLATE	STANDARD NAME PLATE AND BRACKET		SS / SA-36
22	1	DEMISTER ASSY	DEMISTER ASSEMBLY - SEE DETAIL		G40.21 - 44W
23	2	REPAD	PLATE - 1 3/8" THICK x 2" WIDE RING		G40.21 - 44W
24	2	LUGS	PLATE - 3/4" THICK - SEE DETAIL		G40.21 - 44W
25	2	VORTEX	PLATE - 1/4" THICK - SEE DETAIL		G40.21 - 44W
26	1	DEFLECTOR	PLATE - 1/2" THICK - SEE DETAIL		G40.21 - 44W
27	1	BUILDING FLANGE	PLATE - 1/4" THICK - 36"ID x 40"OD		G40.21 - 44W
28	1	WEIR	PLATE - 1/4" THICK - 33"OD x 17 1/2" TALL SEE DETAIL		G40.21 - 44W

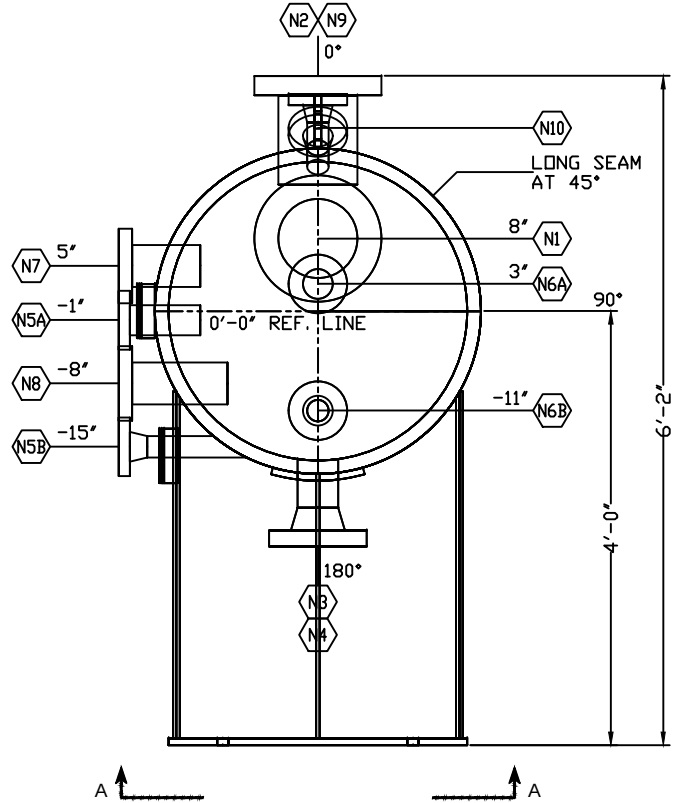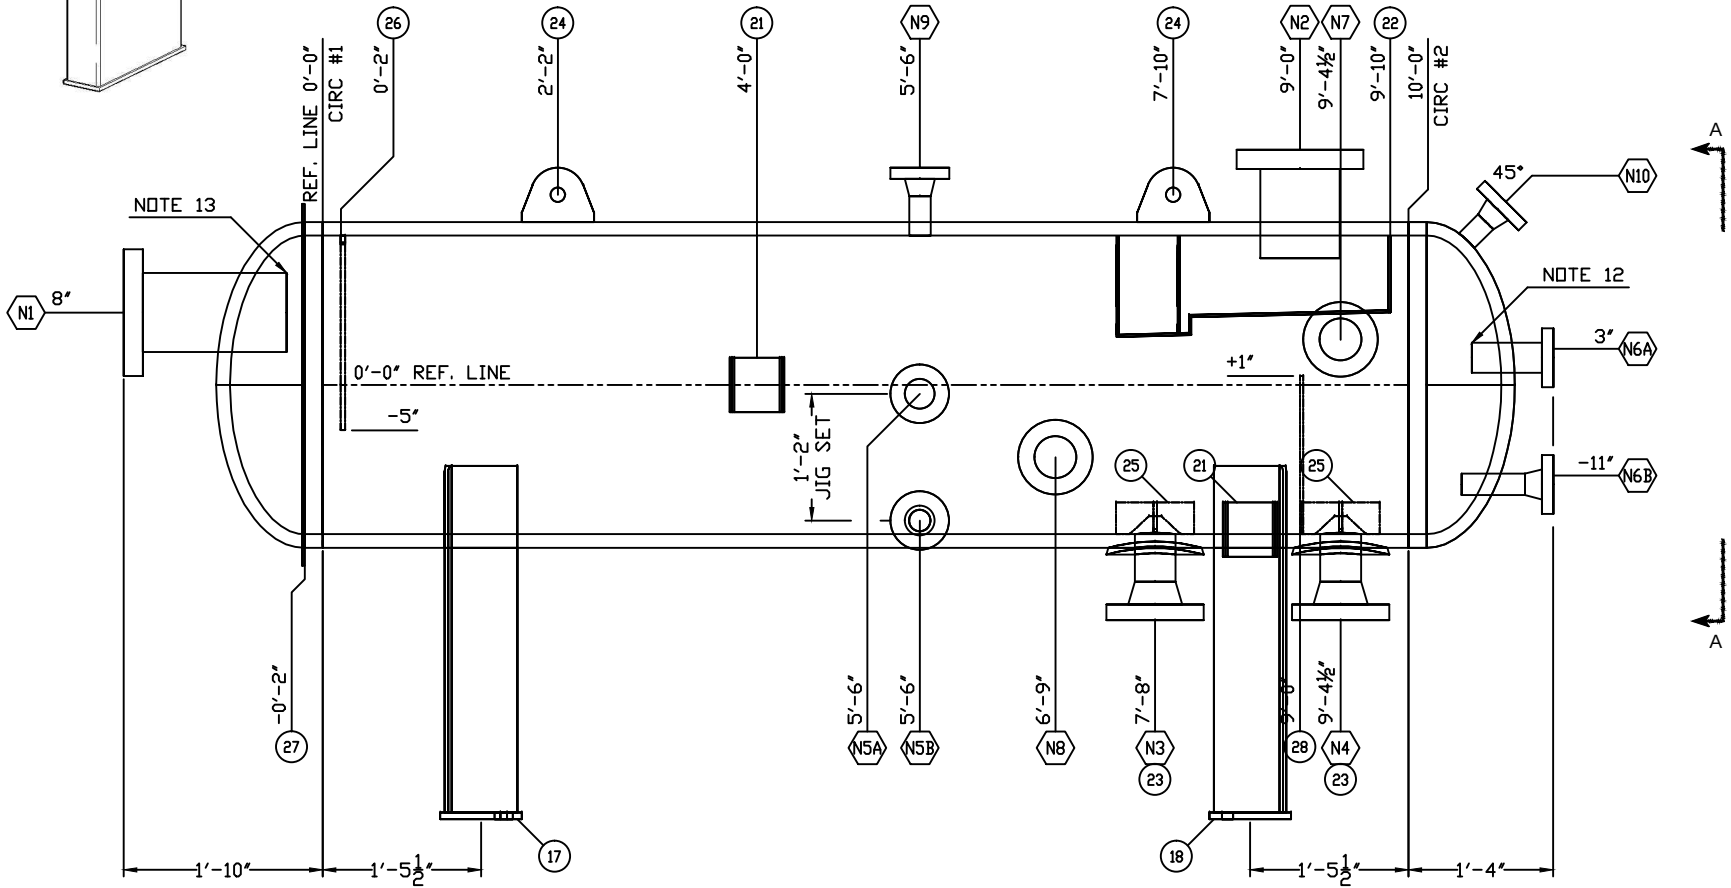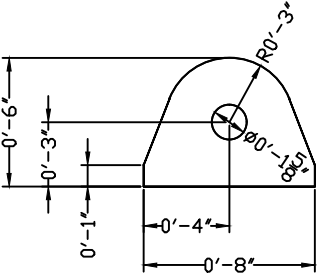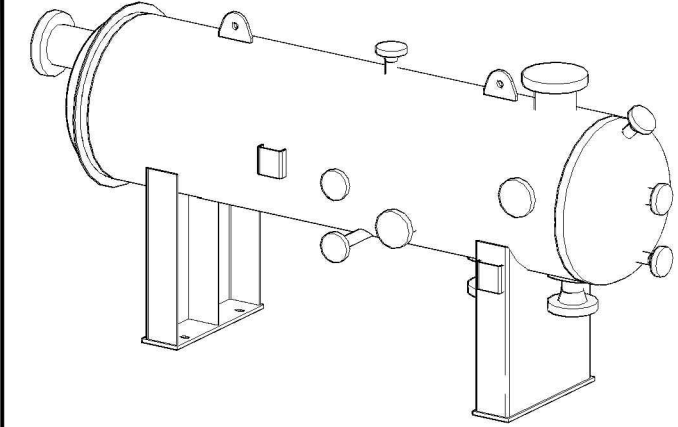

GENERAL NOTES

- QUALITY CONTROL PROGRAM NUMBER: AQP-1521
- WELDING PROCEDURE REGISTRATION NUMBER: WP-3269.2
- CAPACITY: 67 CUFT
- SERVICE: HYDROCARBONS
- EXPOSED INSIDE EDGES OF NOZZLES OR OPENINGS SHALL HAVE AN 1/8" MINIMUM RADIUS
- SURFACE PREPARATION: HAND TOOL CLEAN (MINIMUM)
- PRIME AND PAINT: AS PER CLIENT SPECIFICATIONS
- ALL BOLT HOLES TO STRADDLE CENTERLINES
- CLEAN AND COVER ALL OPENINGS FOR SHIPMENT
- USE WELD PROCEDURE SPI-3, 7, 11 FOR ALL TACK WELDS
- CRN DRAWING: 3964-1 Rev 3, 3964-2 Rev 3
- CRN: V9022.213
- 3/8" RADIUS ID OF N5A, N6A
- 1/2" RADIUS ID OF N1

DESIGN NOTES

DESIGN & FABRICATE TO: ASME SECTION VIII, DIVISION 1
2013 EDITION
MAXIMUM ALLOWABLE WORKING PRESSURE (MAWP): 1440 PSIG
DESIGN TEMPERATURE: 130°F
MINIMUM DESIGN METAL TEMPERATURE (MDMT): -20°F AT 1440 PSIG
IMPACT TEST: EXEMPT PER UG-20F 1-5, UCS66a, UCS-66b
FLANGES EXEMPT PER UCS-66c
RADIOGRAPHY: FULL PER UW-11a (RT-1)
PWHT PER UCS-56, 90 MIN @ 1125°F
HYDROSTATIC TEST PRESSURE: 1878 PSIG
CORROSION ALLOWANCE: 1/8"
WEIGHT EMPTY: 8,000 lbs
WEIGHT FULL OF WATER: 12,000 lbs

1	20/02/2014	REVISED AS PER MARKUPS	DF	JT
0	19/02/2014	ISSUED FOR CONSTRUCTION	DF	JT
REV	DATE	REVISION	BY	APP
SCORE PROJECTS INC.				
BOX 1889, 3814 - 47 AVENUE, STETTLER, AB T0C 2L0 TELEPHONE: (403) 742-2266 FAX: (888) 317-7460				
CLIENT:	TKS	SN V-13877		
DATE:	05/12/2013	<u>3 PHASE SOUR SEPARATOR</u>		
JOB NO:	V-13877	36" OD x 10'-0" S/S		
DRAWN BY:	DF	1440 PSIG AT -20° F / 130° F		
CHECKED BY:	JT	DWG NO:	V-13877	REV
APP BY:	JT	1		