


F-520
PROPANE DRYER
SPORLAN C-19212-P
w/ (4) - RC-4864 DESSICANT CORES

V-760
PROPANE ACCUMULATOR
29.25" I.D. x 10'-0" SM/SM HORIZONTAL
250 PSIG D.P. @ -20/150°F + 1/16" C.A.

A-800/810
NGL PRODUCT COOLER/PROPANE CONDENSER
ACE MODEL: #E-93 A
HORIZONTAL AERIAL COOLER c/w
20 HP, 3/60/380V AC ELEC. MOTOR
CONDENSER DESIGN DUTY: 778,000 BTU/HR
COOLER DESIGN DUTY: 35,742 BTU/HR
MAWP: 2068 kPa/2137 kPa

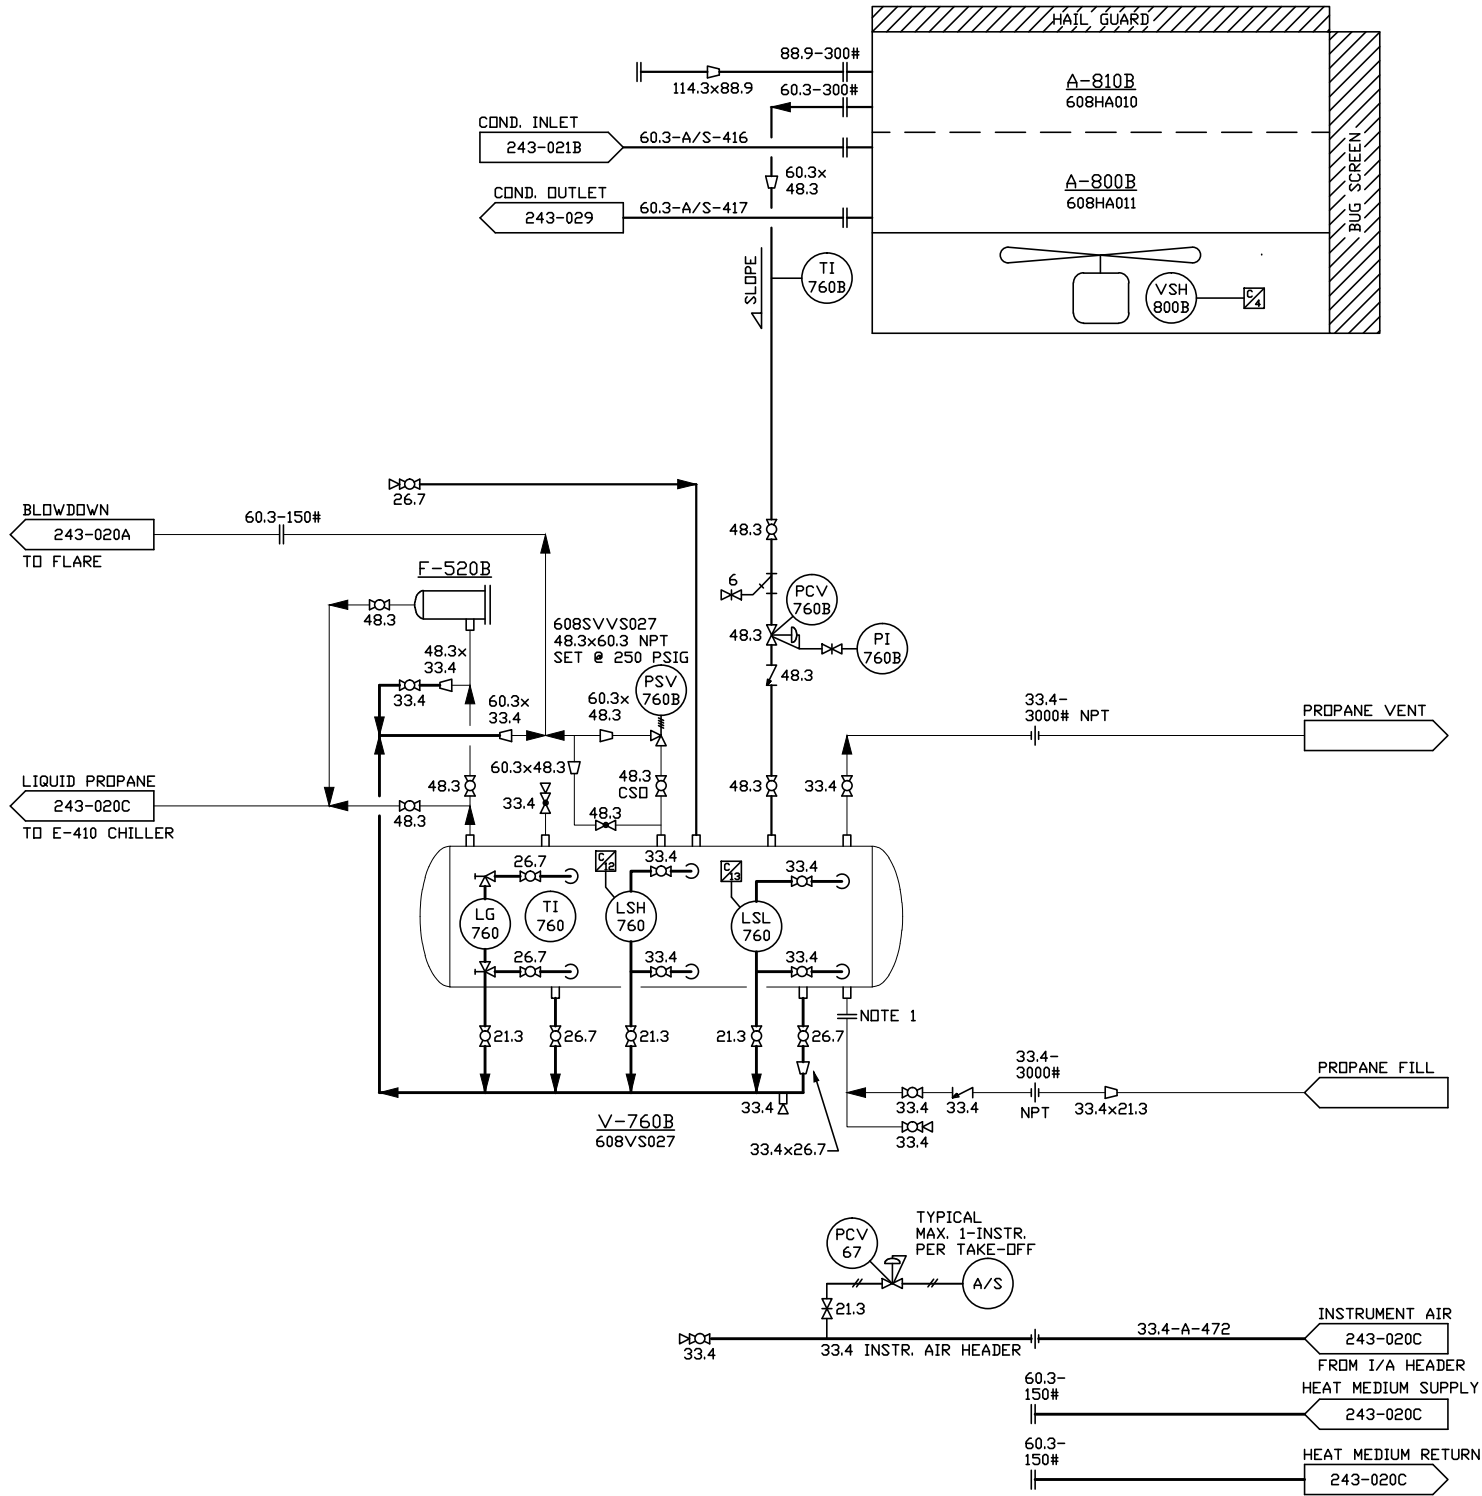

 
NOTES:
1) 114.3 300# HUB FLANGE x 33 NPT.

NO.	DATE	REVISIONS	DRAWN	CHECK	DESIGN	APPR.
1	18.06.04	ISSUED FOR DEMOLITION (TRIDYNE PROJECTS #2017089)	NS	SK	PK	KJ
0	11.02.11	AS BUILT (REI 10R-90.001)	TS	GDY/JW		
B	14.12.95	ISSUED FOR CLIENT REVIEW	BGS			
A	03.12.95	ISSUED FOR APPROVAL	BGS			
NO.	DATE	REVISIONS	DRAWN	CHECK	DESIGN	APPR.
			DRAFTING	ENGINEERING		

NO.	TITLE
	REFERENCE DRAWINGS

PROFESSIONAL AND PERMIT STAMPS AFFIXED HEREUNDER SHALL APPLY ONLY TO REVISION(S) 1

DEMOLITION DRAWING

 DENOTES ITEMS TO BE REMOVED

PROFESSIONAL AND PERMIT STAMPS

Tuxtlá GAS ENGINEERING LTD.

BY: RBC DATE: 93/06/11

BY: GCR DATE: 93/07/20

 **TAQA NORTH**

VALHALLA COMPRESSOR STATION
REFRIGERATION PACKAGE
PIPING & INSTRUMENTATION DIAGRAM D
LSD 13-21-76-9 W6M

CLIENT FILE NO.	SCALE	TUXTLA DRAWING NUMBER	REV.
CLIENT DWG NUMBER	NONE	243-020D-DEMO-2	1