


 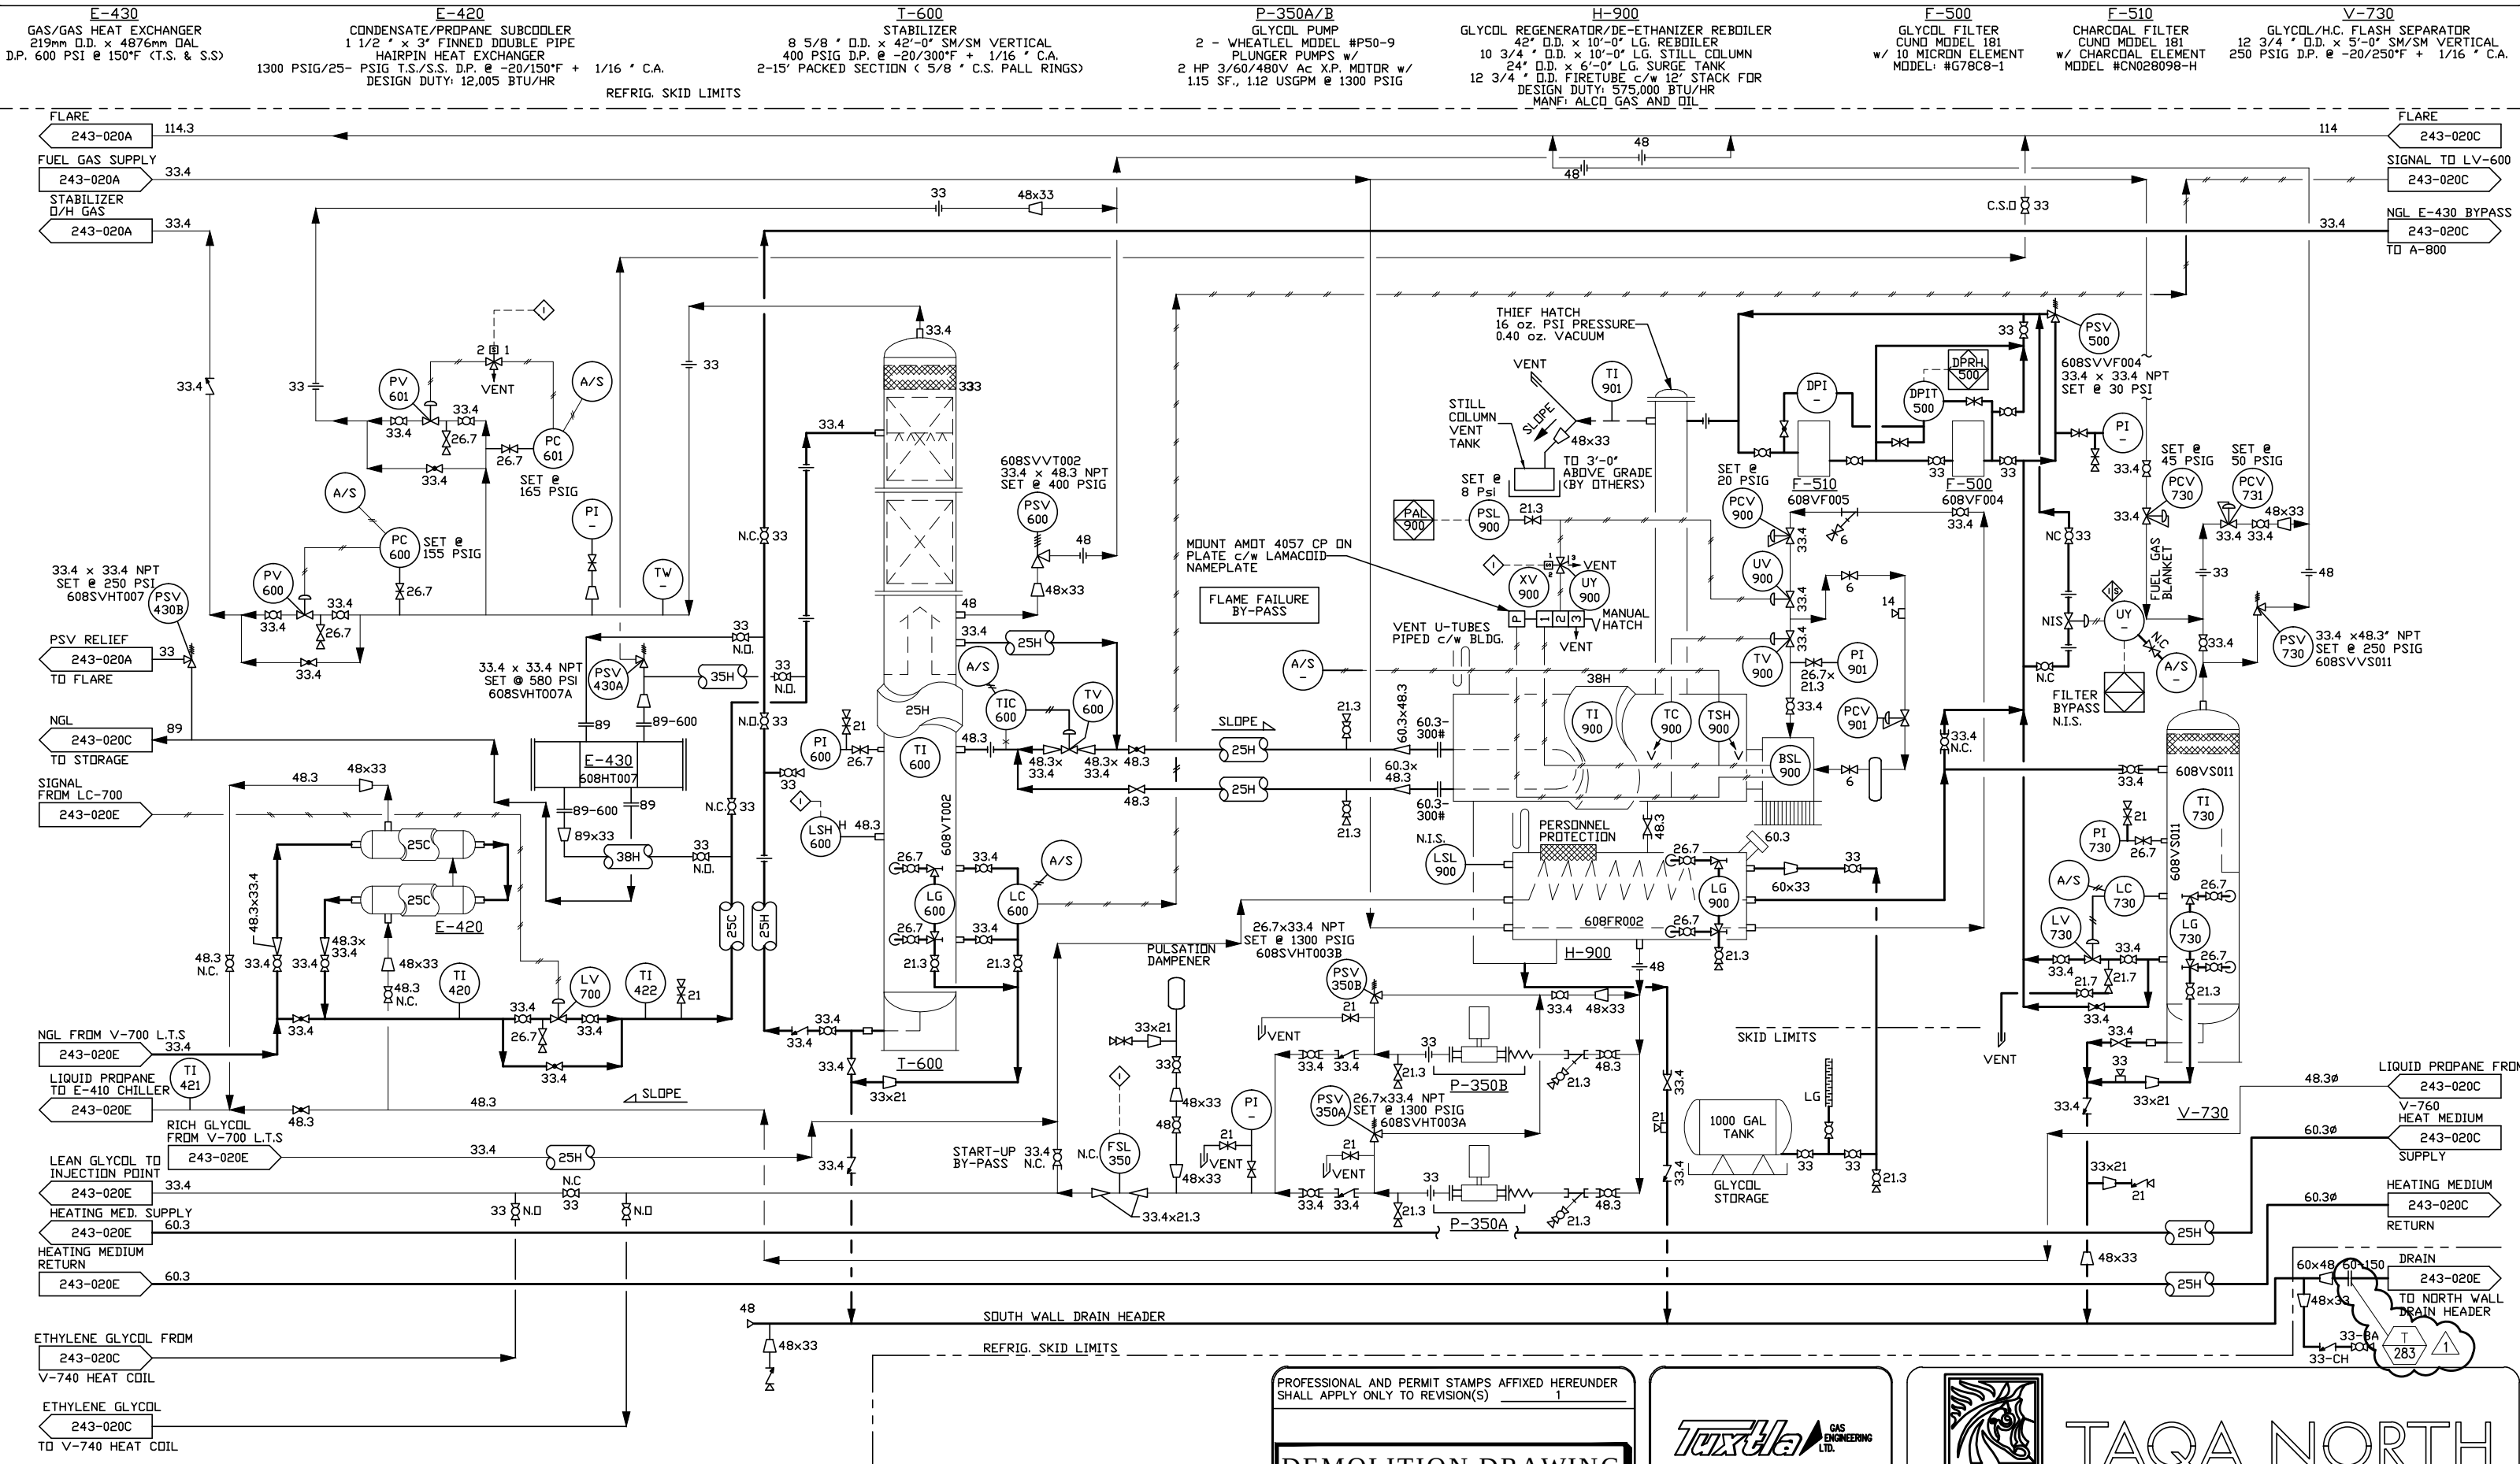


NO.	DATE	REVISIONS	DRAWN	CHECK	DESIGN	APPR.
1	18.06.04	ISSUED FOR DEMOLITION (TRIDYNE PROJECTS #2017089)	NS	SK	PK	KJ
0	11.02.11	AS BUILT (REI 10R-95.001)	KMS	GDY/DM		
B	95.12.14	ISSUED FOR CLIENT REVIEW	BGS			
A	95.12.03	ISSUED FOR APPROVAL	BGS			

NO.	TITLE
	REFERENCE DRAWINGS

PROFESSIONAL AND PERMIT STAMPS AFFIXED HEREUNDER SHALL APPLY ONLY TO REVISION(S) 1

DEMOLITION DRAWING

 DENOTES ITEMS TO BE REMOVED

PROFESSIONAL AND PERMIT STAMPS

Tuxtlá GAS ENGINEERING LTD.

BY: RBC DATE: 93/06/11

BY: GCR DATE: 93/07/20

TAQA NORTH

VALHALLA COMPRESSOR STATION
REFRIGERATION PACKAGE
PIPING & INSTRUMENTATION DIAGRAM D
LSD 13-21-76-9 W6M

CLIENT FILE NO.	SCALE	TUXTLA DRAWING NUMBER	REV.
	NONE	243-020B-DEMO-2	1