


Plot Date: Wednesday, June 26, 2019 1:39:04 PM File Name: X:\KANATA\VALHALLA 13-21-76-09 W6M\MECHANICAL\03 PID\CWA-2 PID\KAN-VAL-13-21-PID-124.DWG By: NS

H-613
AMINE RE-BOILER
DUTY: 211.0 KW (0.72 MMBTU/HR)
SIZE: 1067 mm OD x 7315 mm S/S
DESIGN: 345 kPag @ -29/149°C

H-615
BUILDING HEATER
CATADYNE MODEL #BX 24x36
DUTY: 9.9 KW (33,750 BTU/HR)

P-514A/B
MAKE-UP WATER PUMPS
CAPACITY: 2.27 m³/h (10 USGPM) @ 20.7 m HEAD
POWER: 0.7 KW (1HP) 460/3/60

T-614
MAKE-UP WATER TANK
SIZE: 2896 mm DIA. x 2438 mm HT.
CAPACITY: 15.9 m³ (100 BBL)
DESIGN: 345 kPag @ -29/149°C

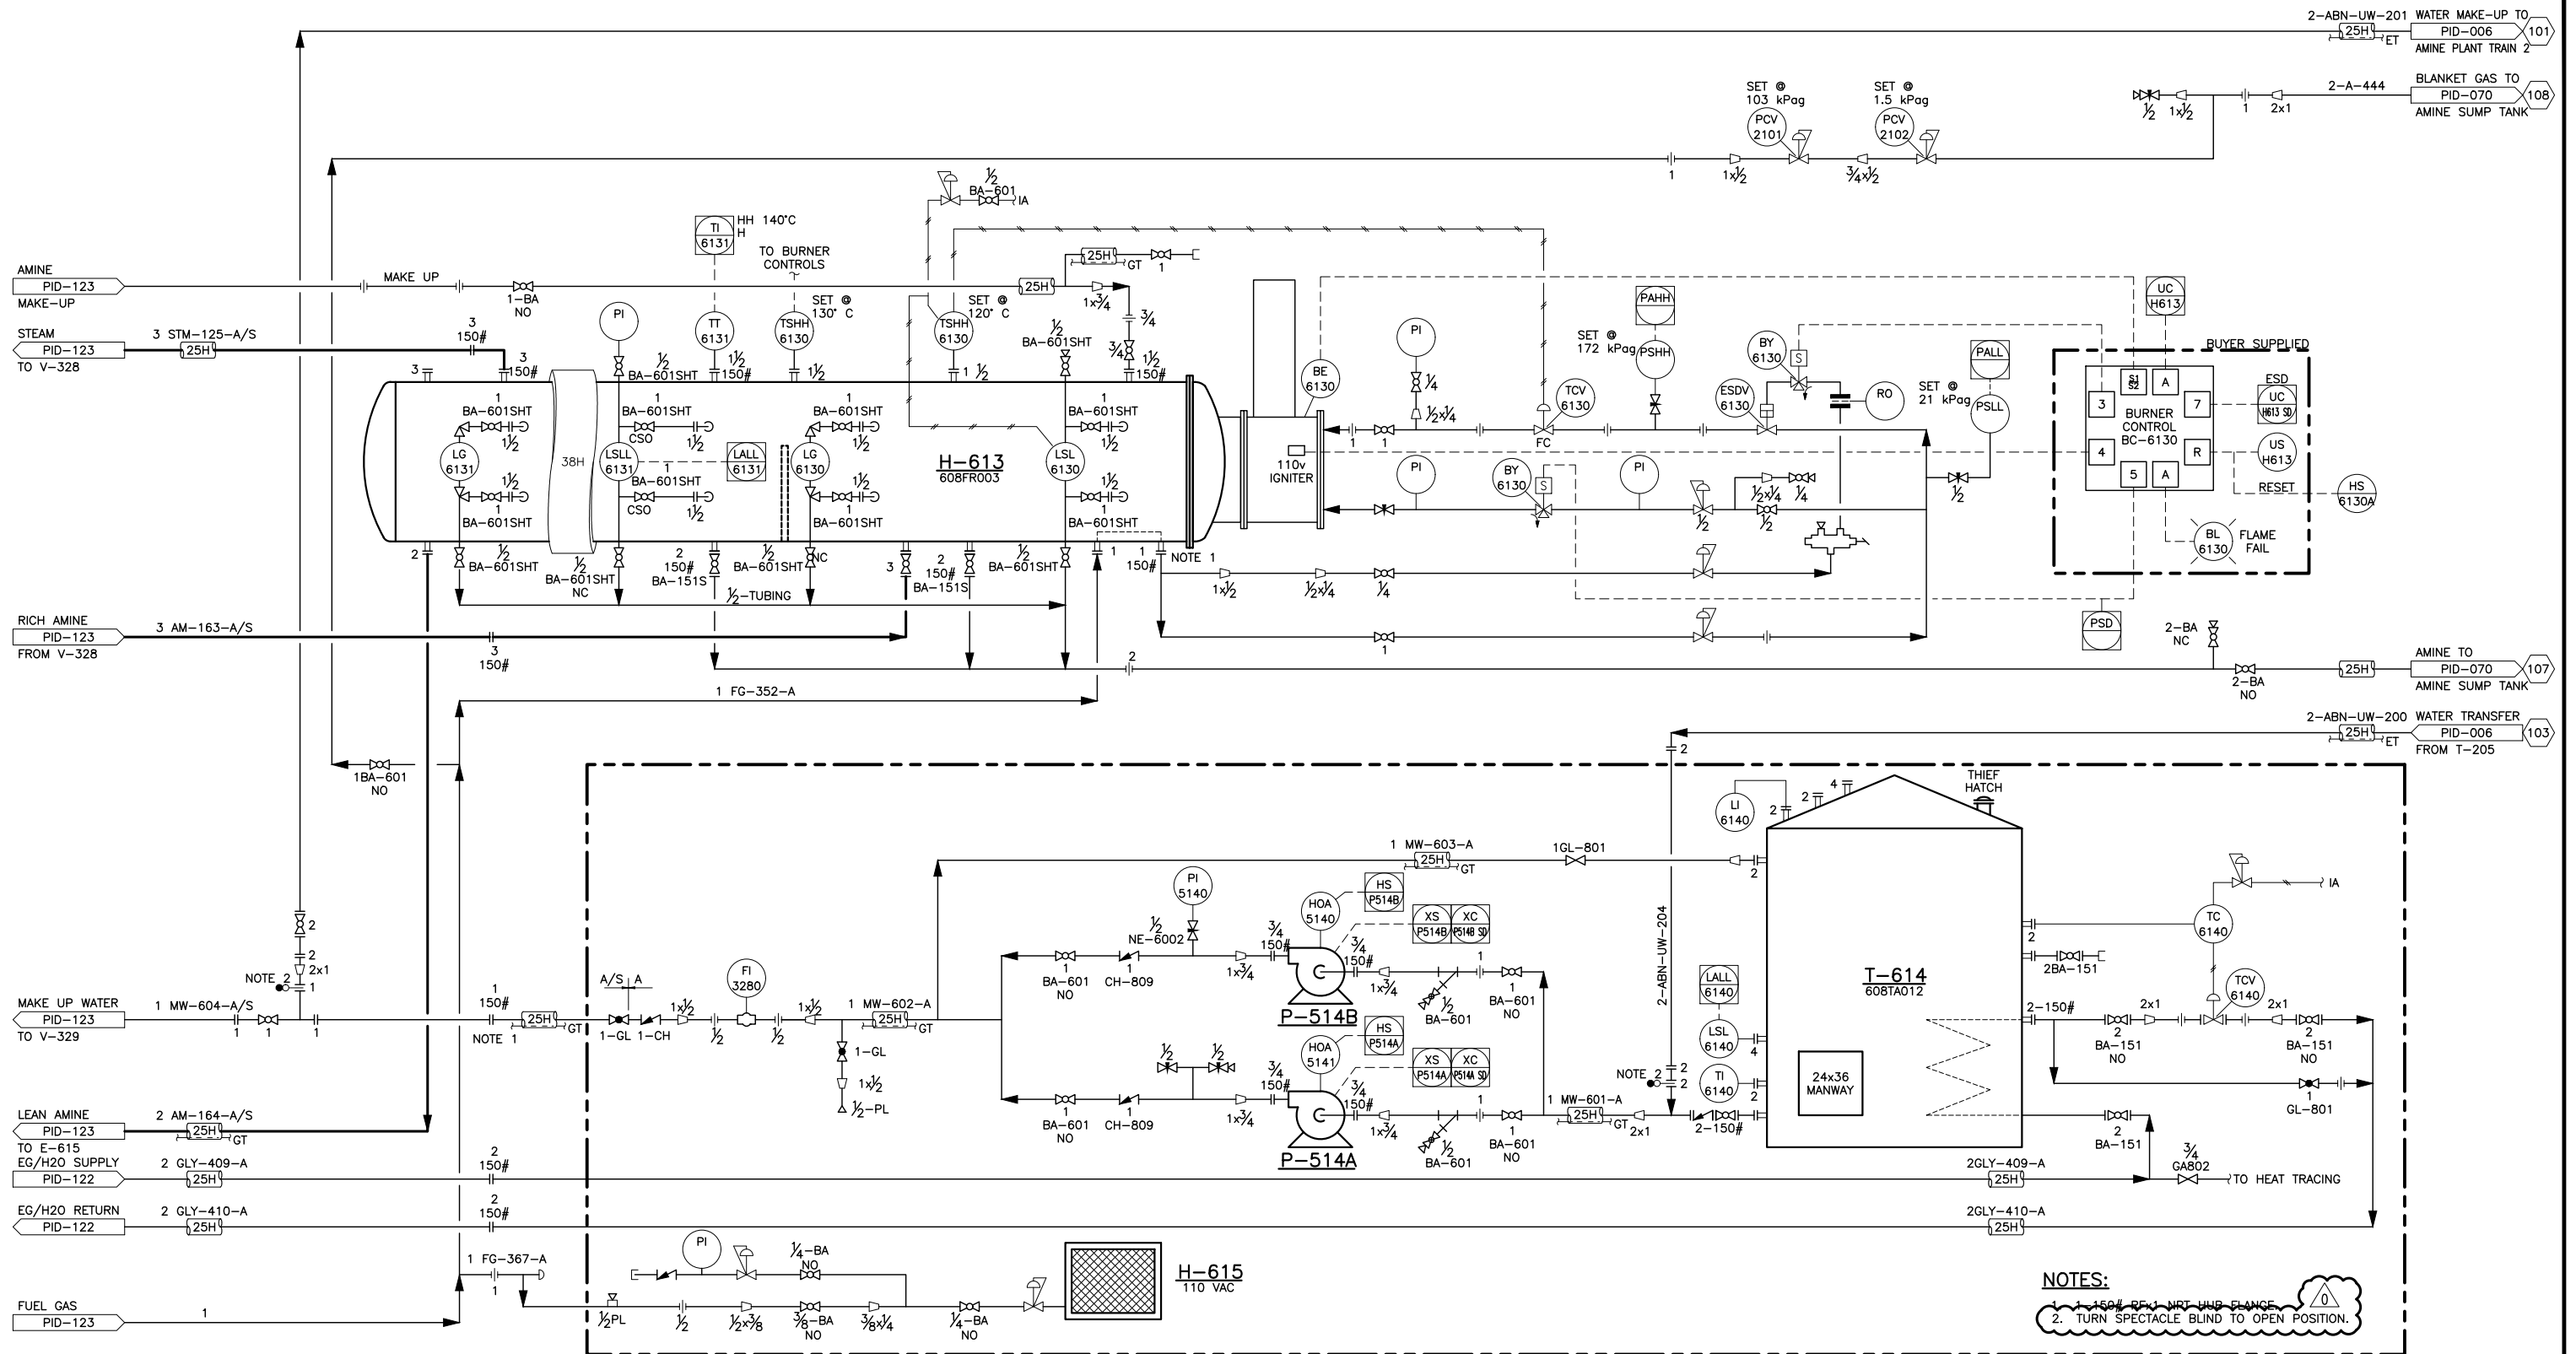

ENG STAMP & PERMIT BELOW APPLY TO REVISION 1 ONLY

AS-BUILT DRAWING

TRIDYNE PROJECTS CORPORATION WAS NOT RETAINED TO PROVIDE FULL TIME FIELD REVIEW OF THE CONSTRUCTION. AS SUCH, THIS AS-BUILT DRAWING HAS BEEN PREPARED IN PART ON THE BASIS OF INFORMATION COMPILED AND FURNISHED BY OTHERS. TRIDYNE PROJECTS CORPORATION CANNOT BE RESPONSIBLE FOR ANY ERRORS OR OMISSIONS WHICH HAVE BEEN INCORPORATED INTO THIS DRAWING.

PROJ. No.	REV.	REVISION DESCRIPTION	DATE	BY	CHK'D	APP'D
2017089	3	AS-BUILT	2019.03.18	CB	DZ	-
2017089	2	RE-ISSUED FOR CONSTRUCTION	2018.10.06	-	-	KJ
2017089	1	RE-ISSUED FOR CONSTRUCTION	2018.09.14	NS	DZ	KJ
2017089	0	ISSUED FOR CONSTRUCTION	2018.06.04	NS	SK	KJ

TRIDYNE PROJ. No.: 2017089
DATE: 2018.06.04
DRAWN BY: NS
CHECKED: SK
APPROVED: KJ



TRIDYNE PROJECTS
CORPORATION



VALHALLA 13-21 GAS PLANT

LSD: 13-21-76-09 W6M

AMINE PLANT
TRAIN 1 PACKAGE
RE-BOILER & MAKE-UP WATER TANK
PIPING & INSTRUMENTATION DIAGRAM

SCALE (D-SIZE):
NONE

DWG No.:
KAN-VAL-13-21-PID-124

REV.
3