


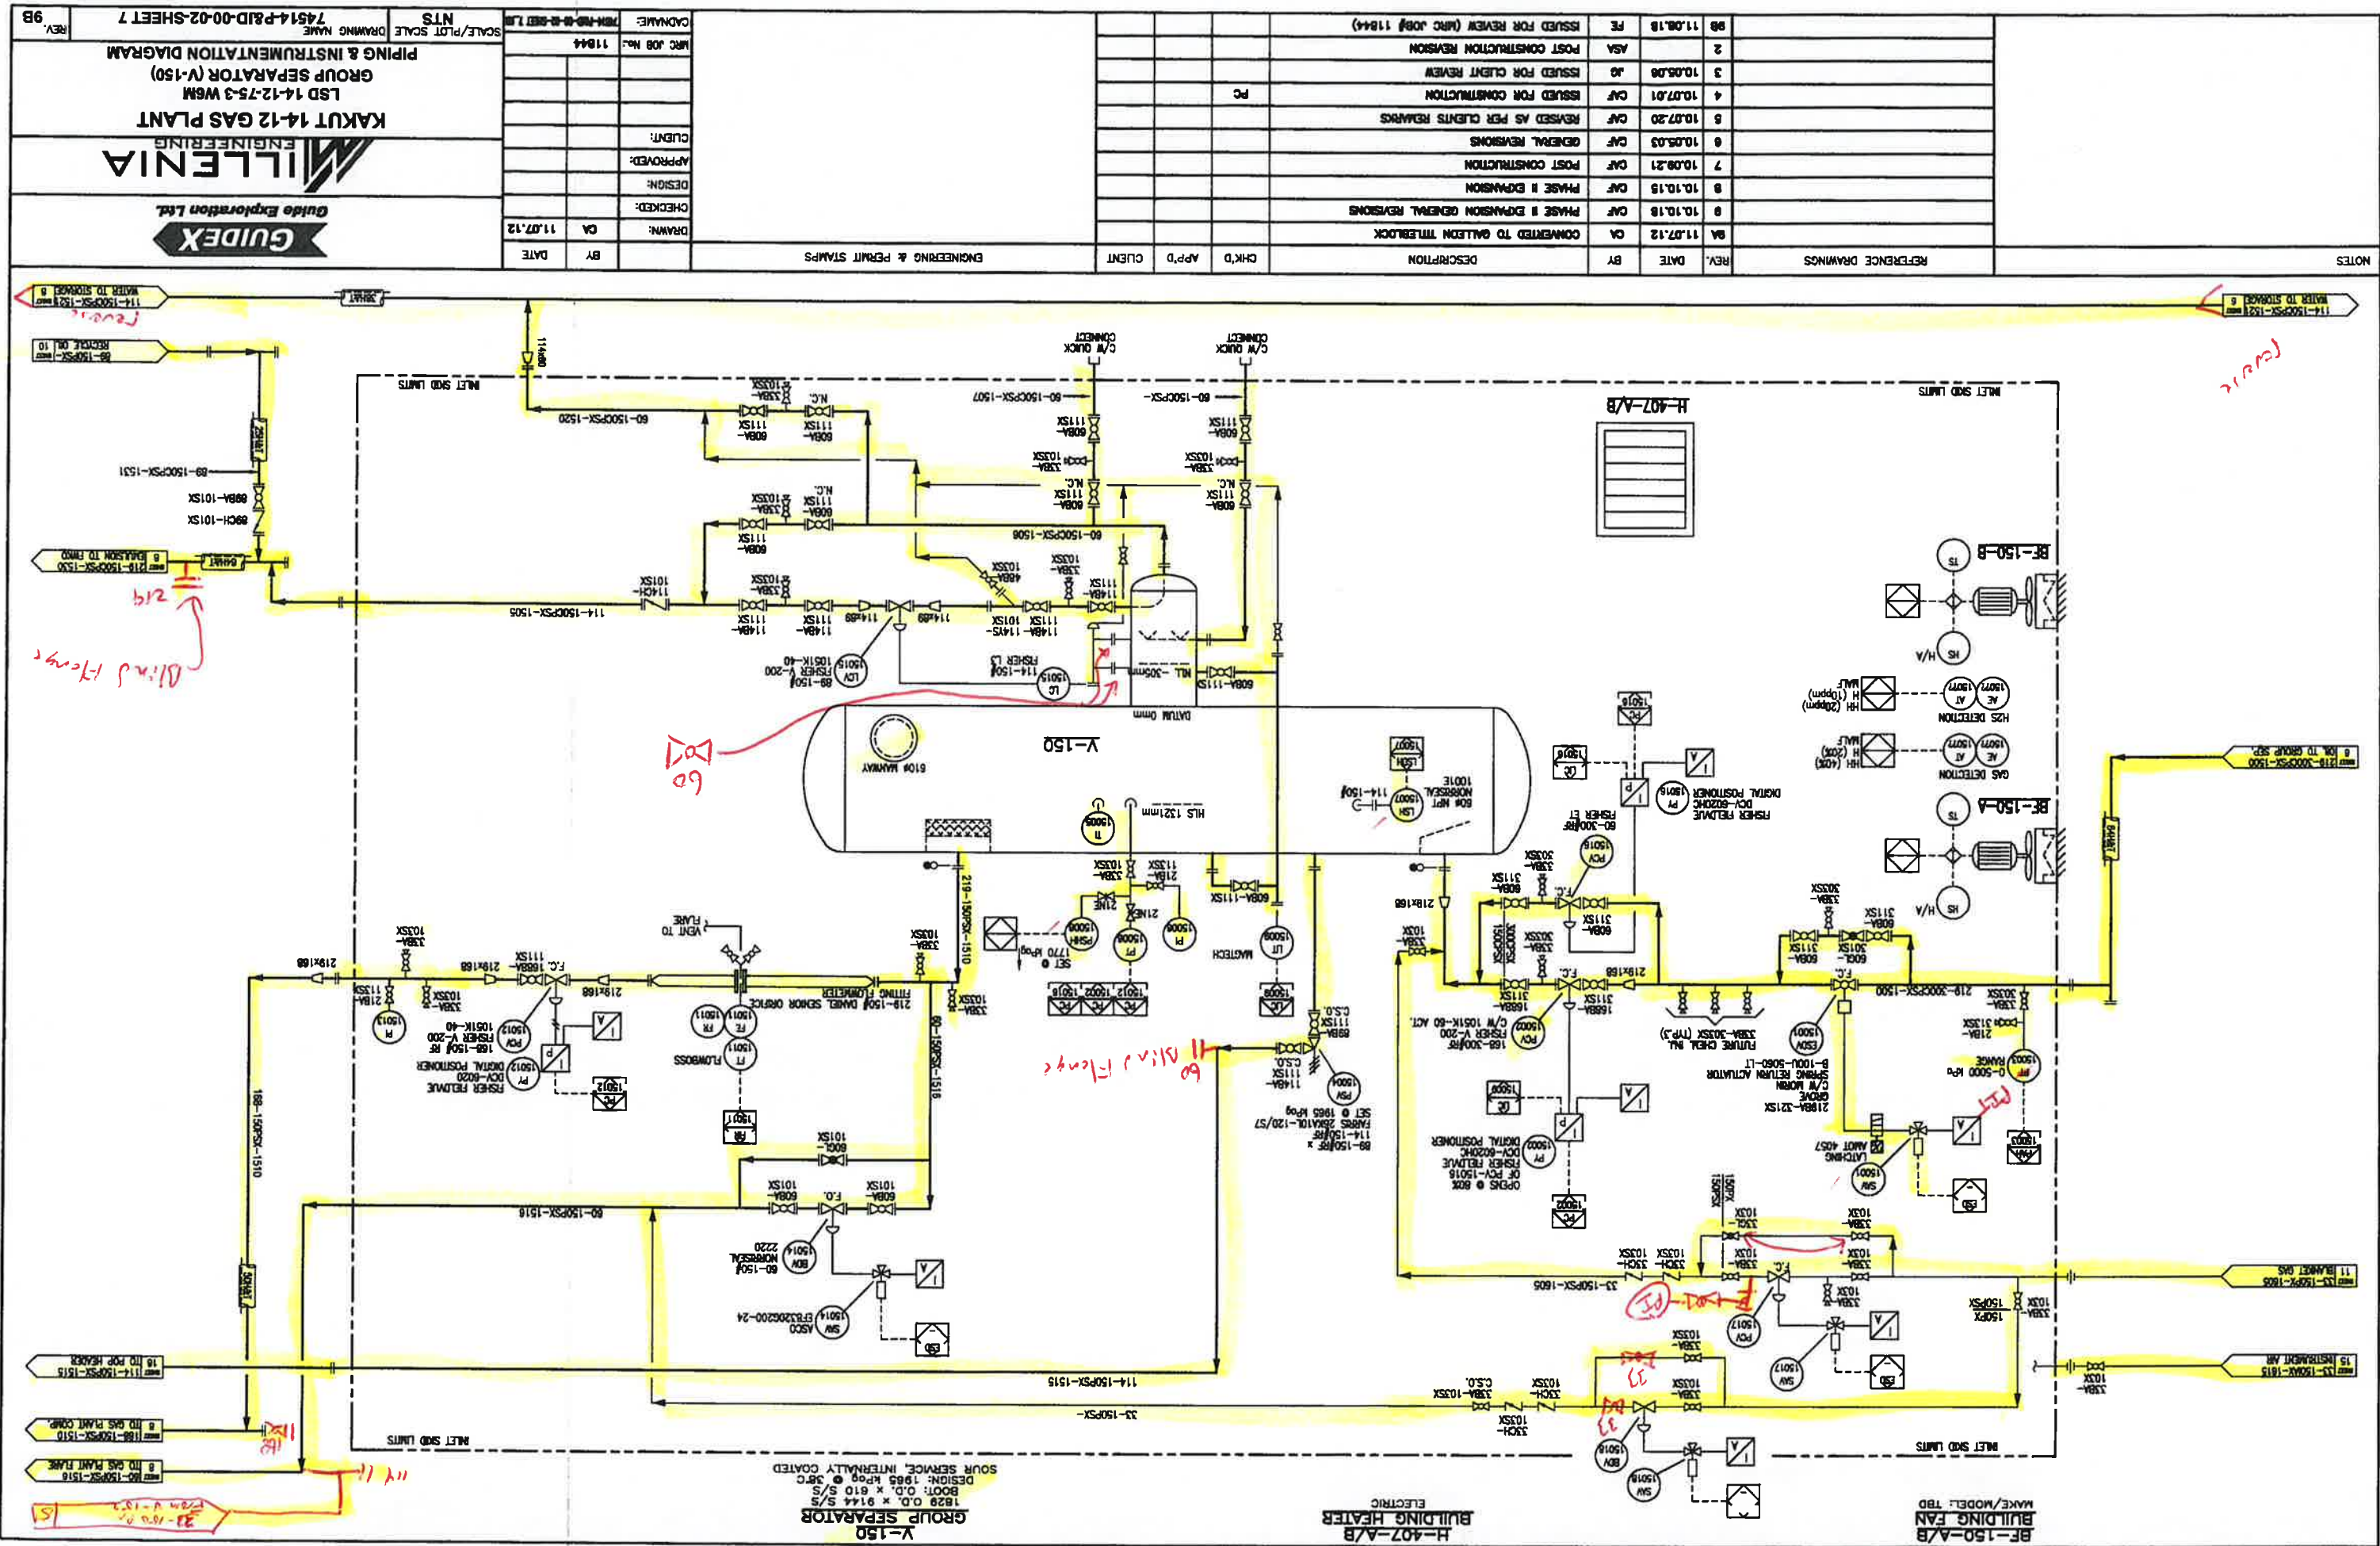

NOTES		REFERENCE DRAWINGS		REV.	DATE	BY	DESCRIPTION	CHK'D	AP'D	CLIENT	ENGINEERING & PERMIT STAMPS		DATE	BY	CHECKED:	DESIGN:	APPROVED:	CLIENT:	WRC JOB No:	CADNAME:	SCALE/PILOT SCALE	DRAWING NAME	REV
				9A	11.07.12	CA	COMPLETED TO GATEWAY TITLEBLOCK						11.07.12	CA									
				8A	10.10.18	CAF	PHASE II EXPANSION GENERAL REVISIONS																
				8	10.10.18	CAF	PHASE II EXPANSION																
				7	10.09.21	CAF	POST CONSTRUCTION																
				6	10.05.03	CAF	GENERAL REVISIONS																
				5	10.07.20	CAF	REVISED AS PER CLIENTS REMARKS																
				4	10.07.01	CAF	ISSUED FOR CONSTRUCTION																
				3	10.06.08	JA	ISSUED FOR CLIENT REVIEW																
				2		ASA	POST CONSTRUCTION REVISION																
				1	11.08.18	FE	ISSUED FOR REVIEW (WRC JOB# 11844)																

KAKUT 14-12 GAS PLANT
LSD 14-12-75-3 W6M
GROUP SEPARATOR (V-150)
PIPING & INSTRUMENTATION DIAGRAM

NTS
74514-P&ID-00-02-SHEET 7

GUIDEX
Guide Exploration Ltd.