

NOTE#1: EXISTING IN BUILDING, NOT IN SERVICE


THE AS-BUILT REVISION 3 REFLECTS ALL PROVIDED AND AVAILABLE QA/QC DOCUMENTATION AND OTHER AVAILABLE INFORMATION



ENGINEER AND PERMIT STAMPS	
Drawn	Date
BN	010628
Checked	Date
Ratio	Job No
1:50	99C2511
Drawing No.	Rev.
1214	M17
Reference Drawings	Revisions
No	Date
9	170809
8	160823
7	160404
6	160404
5	150302

Engineer	Date
Project Manager	Date
Job No	Drawing No.
99C2511	1214
Rev.	Date
9	

NORTH KOBES
c-97-G / 94-B-9
DEHYDRATION SKID
P & ID

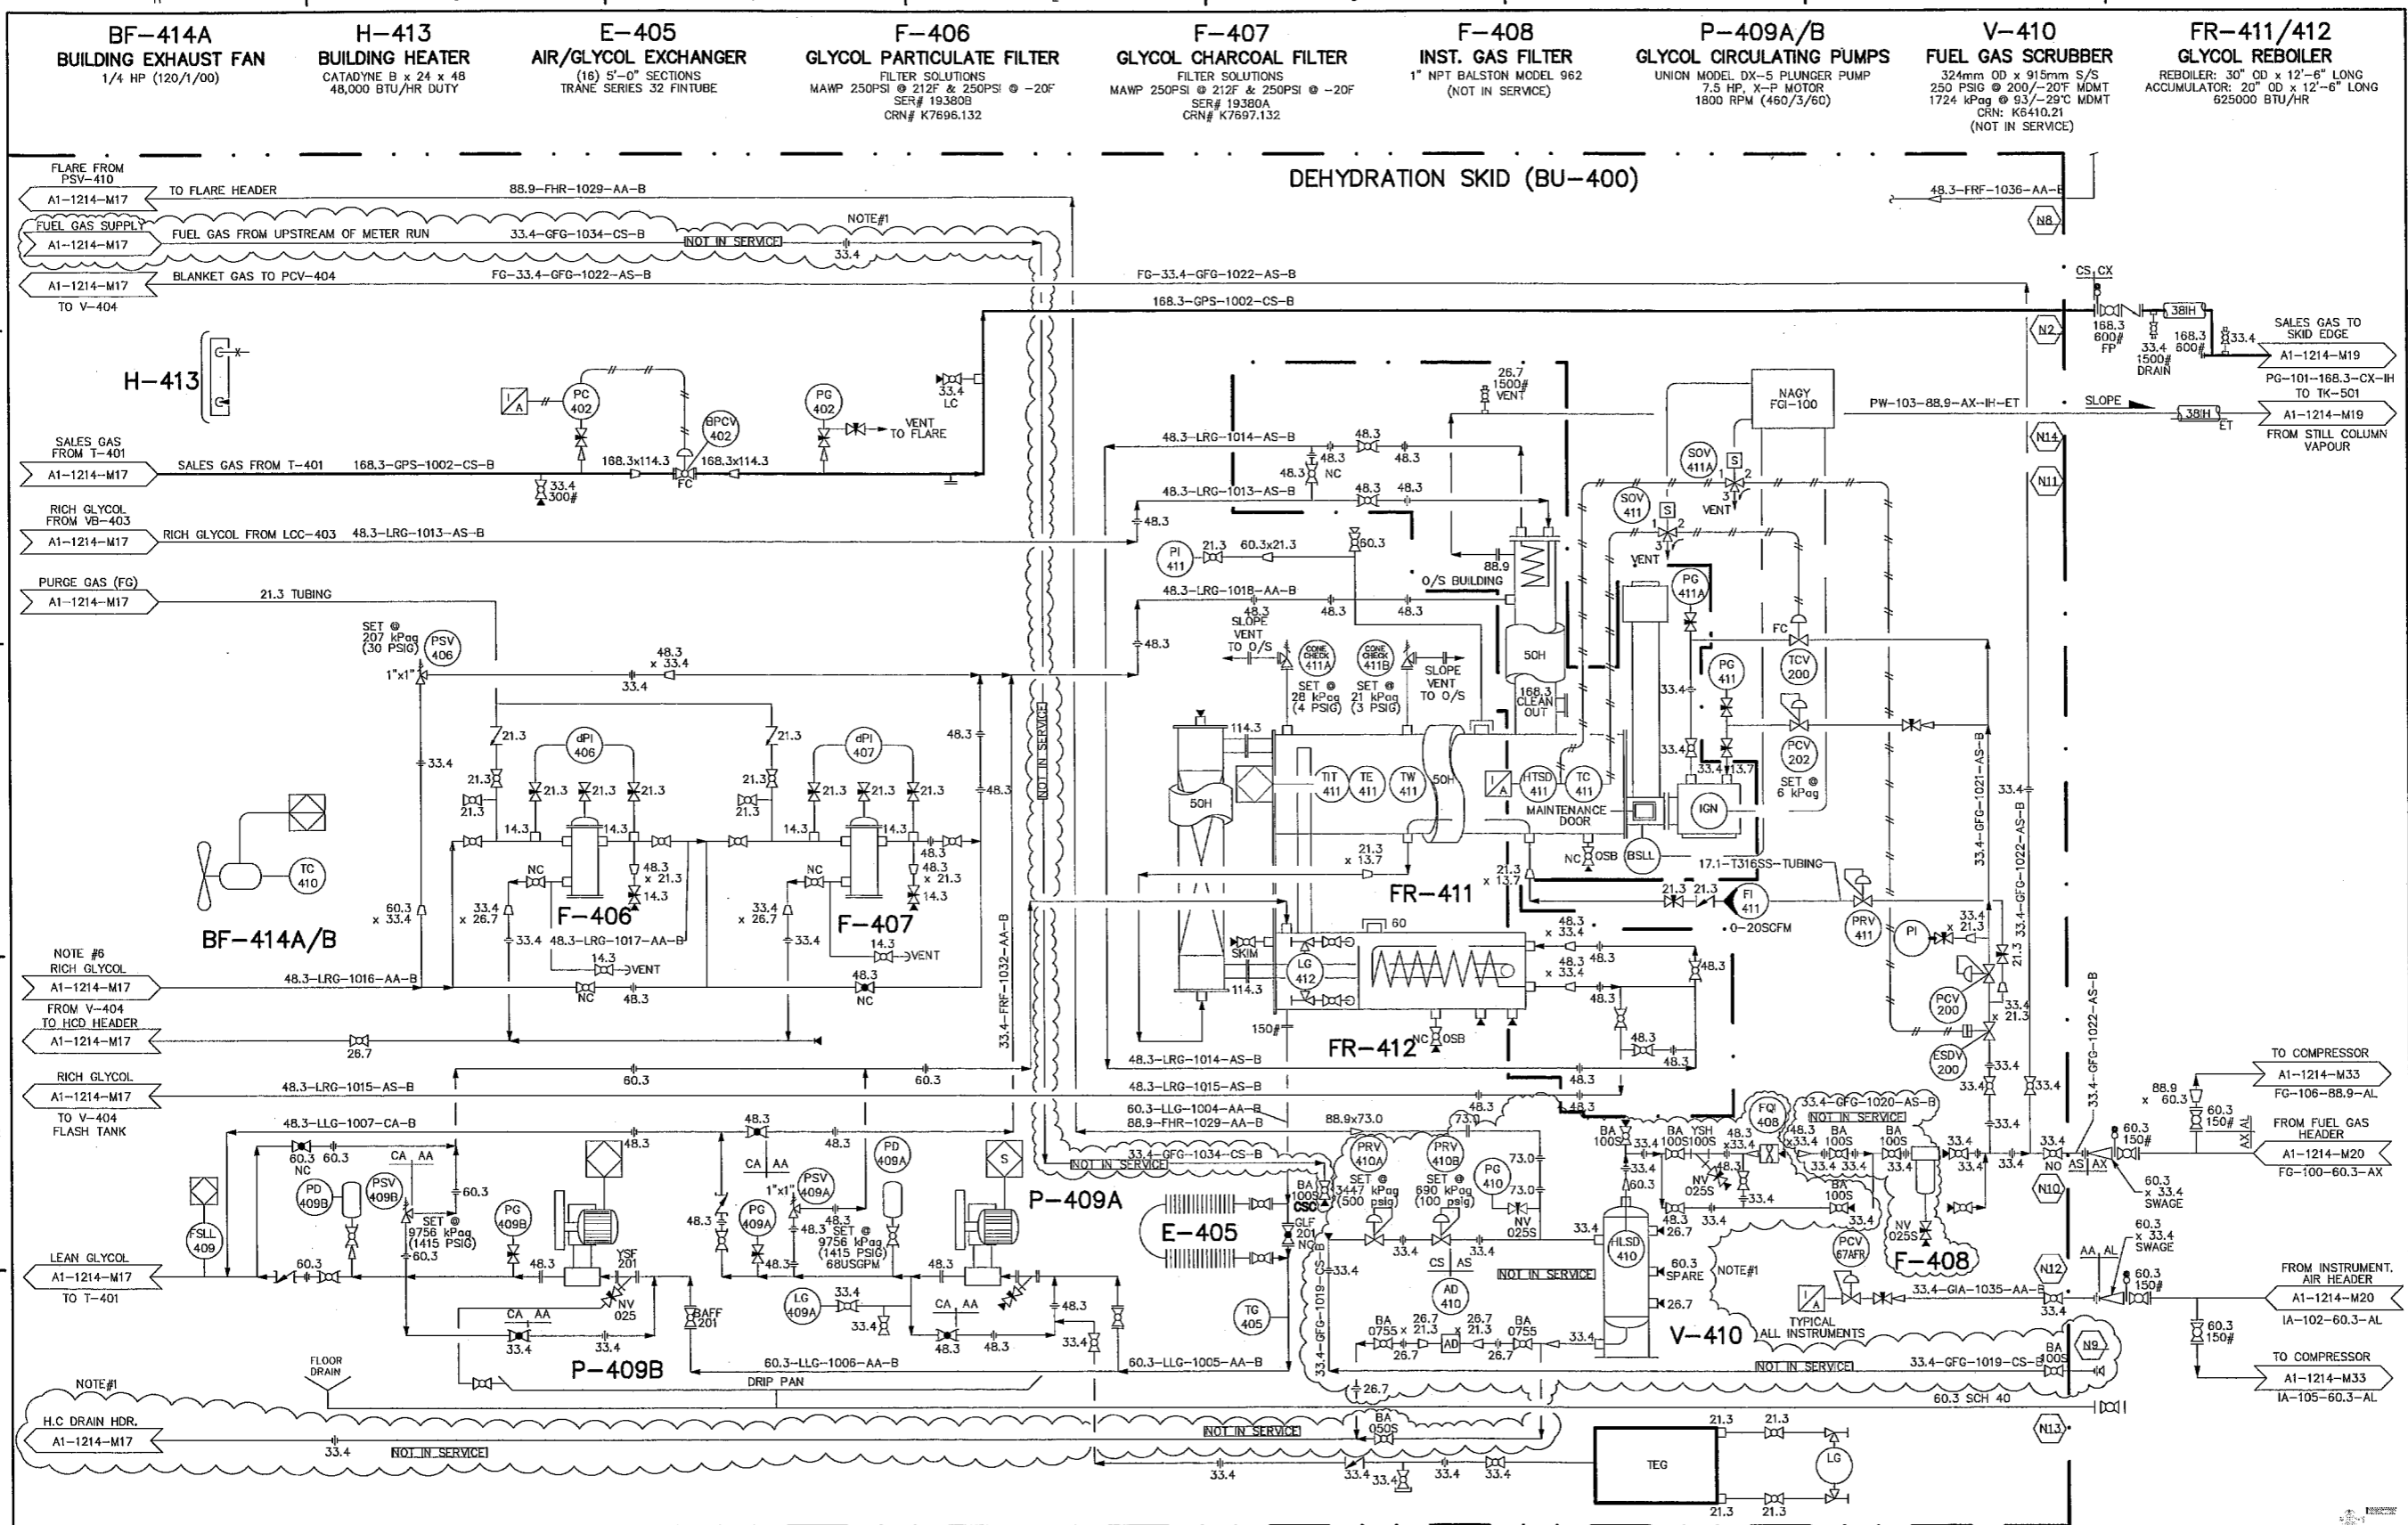

NOTE#1: LINE NOT IN SERVICE, PIPING REMAINS

THE AS-BUILT REVISION 5 REFLECTS ALL PROVIDED AND AVAILABLE QA/QC DOCUMENTATION AND OTHER AVAILABLE INFORMATION



Revision	Date	Description	By	Chk'd	Eng	App'd
10	170808	UPDATE AS PER FIELD REDLINES	CP	IS		
9	160831	UPDATE AS PER FIELD REDLINES (BLAINE.P)	CP	RD		
8	160405	UPDATE AS PER FIELD REDLINES	CP	RD		
7	160405	UPDATE AS PER FIELD REDLINES (REMOVE)	CP	RD		
6	140305	AS-BUILT (NEDG PROJECT #1730NE)	RP			
5	100430	AS-BUILT PER AVAILABLE DOCUMENTATION	HW	RL		
4	041013	AS-BUILT IS BASED ON MARK-UPS PROVIDED BY OTHERS VERIFICATION THAT CONSTRUCTION IS IN ACCORDANCE WITH THE DRAWINGS HAS NOT BEEN DONE	SP			
A1-1214-Z05		DRAWING CONTROL				
		Reference Drawings	No	Date		

ENGINEER AND PERMIT STAMPS			
Drawn	Date	Engineer	Date
BN	010628		
Checked	Date	Project Manager	Date
Ratio	Job No.	Drawing No.	Rev.
1:50	99C2511	1214 M18 PID	10

NORTH KOBES
c-97-G / 94-B-9
DEHYDRATION SKID (REBOILER)
P & ID