


THIS DRAWING IS THE EXCLUSIVE PROPERTY OF PRESSON ENERGEX AND MAY NOT BE COPIED OR COMMUNICATED TO A THIRD PARTY WITHOUT THE WRITTEN AUTHORIZATION OF PRESSON ENERGEX.

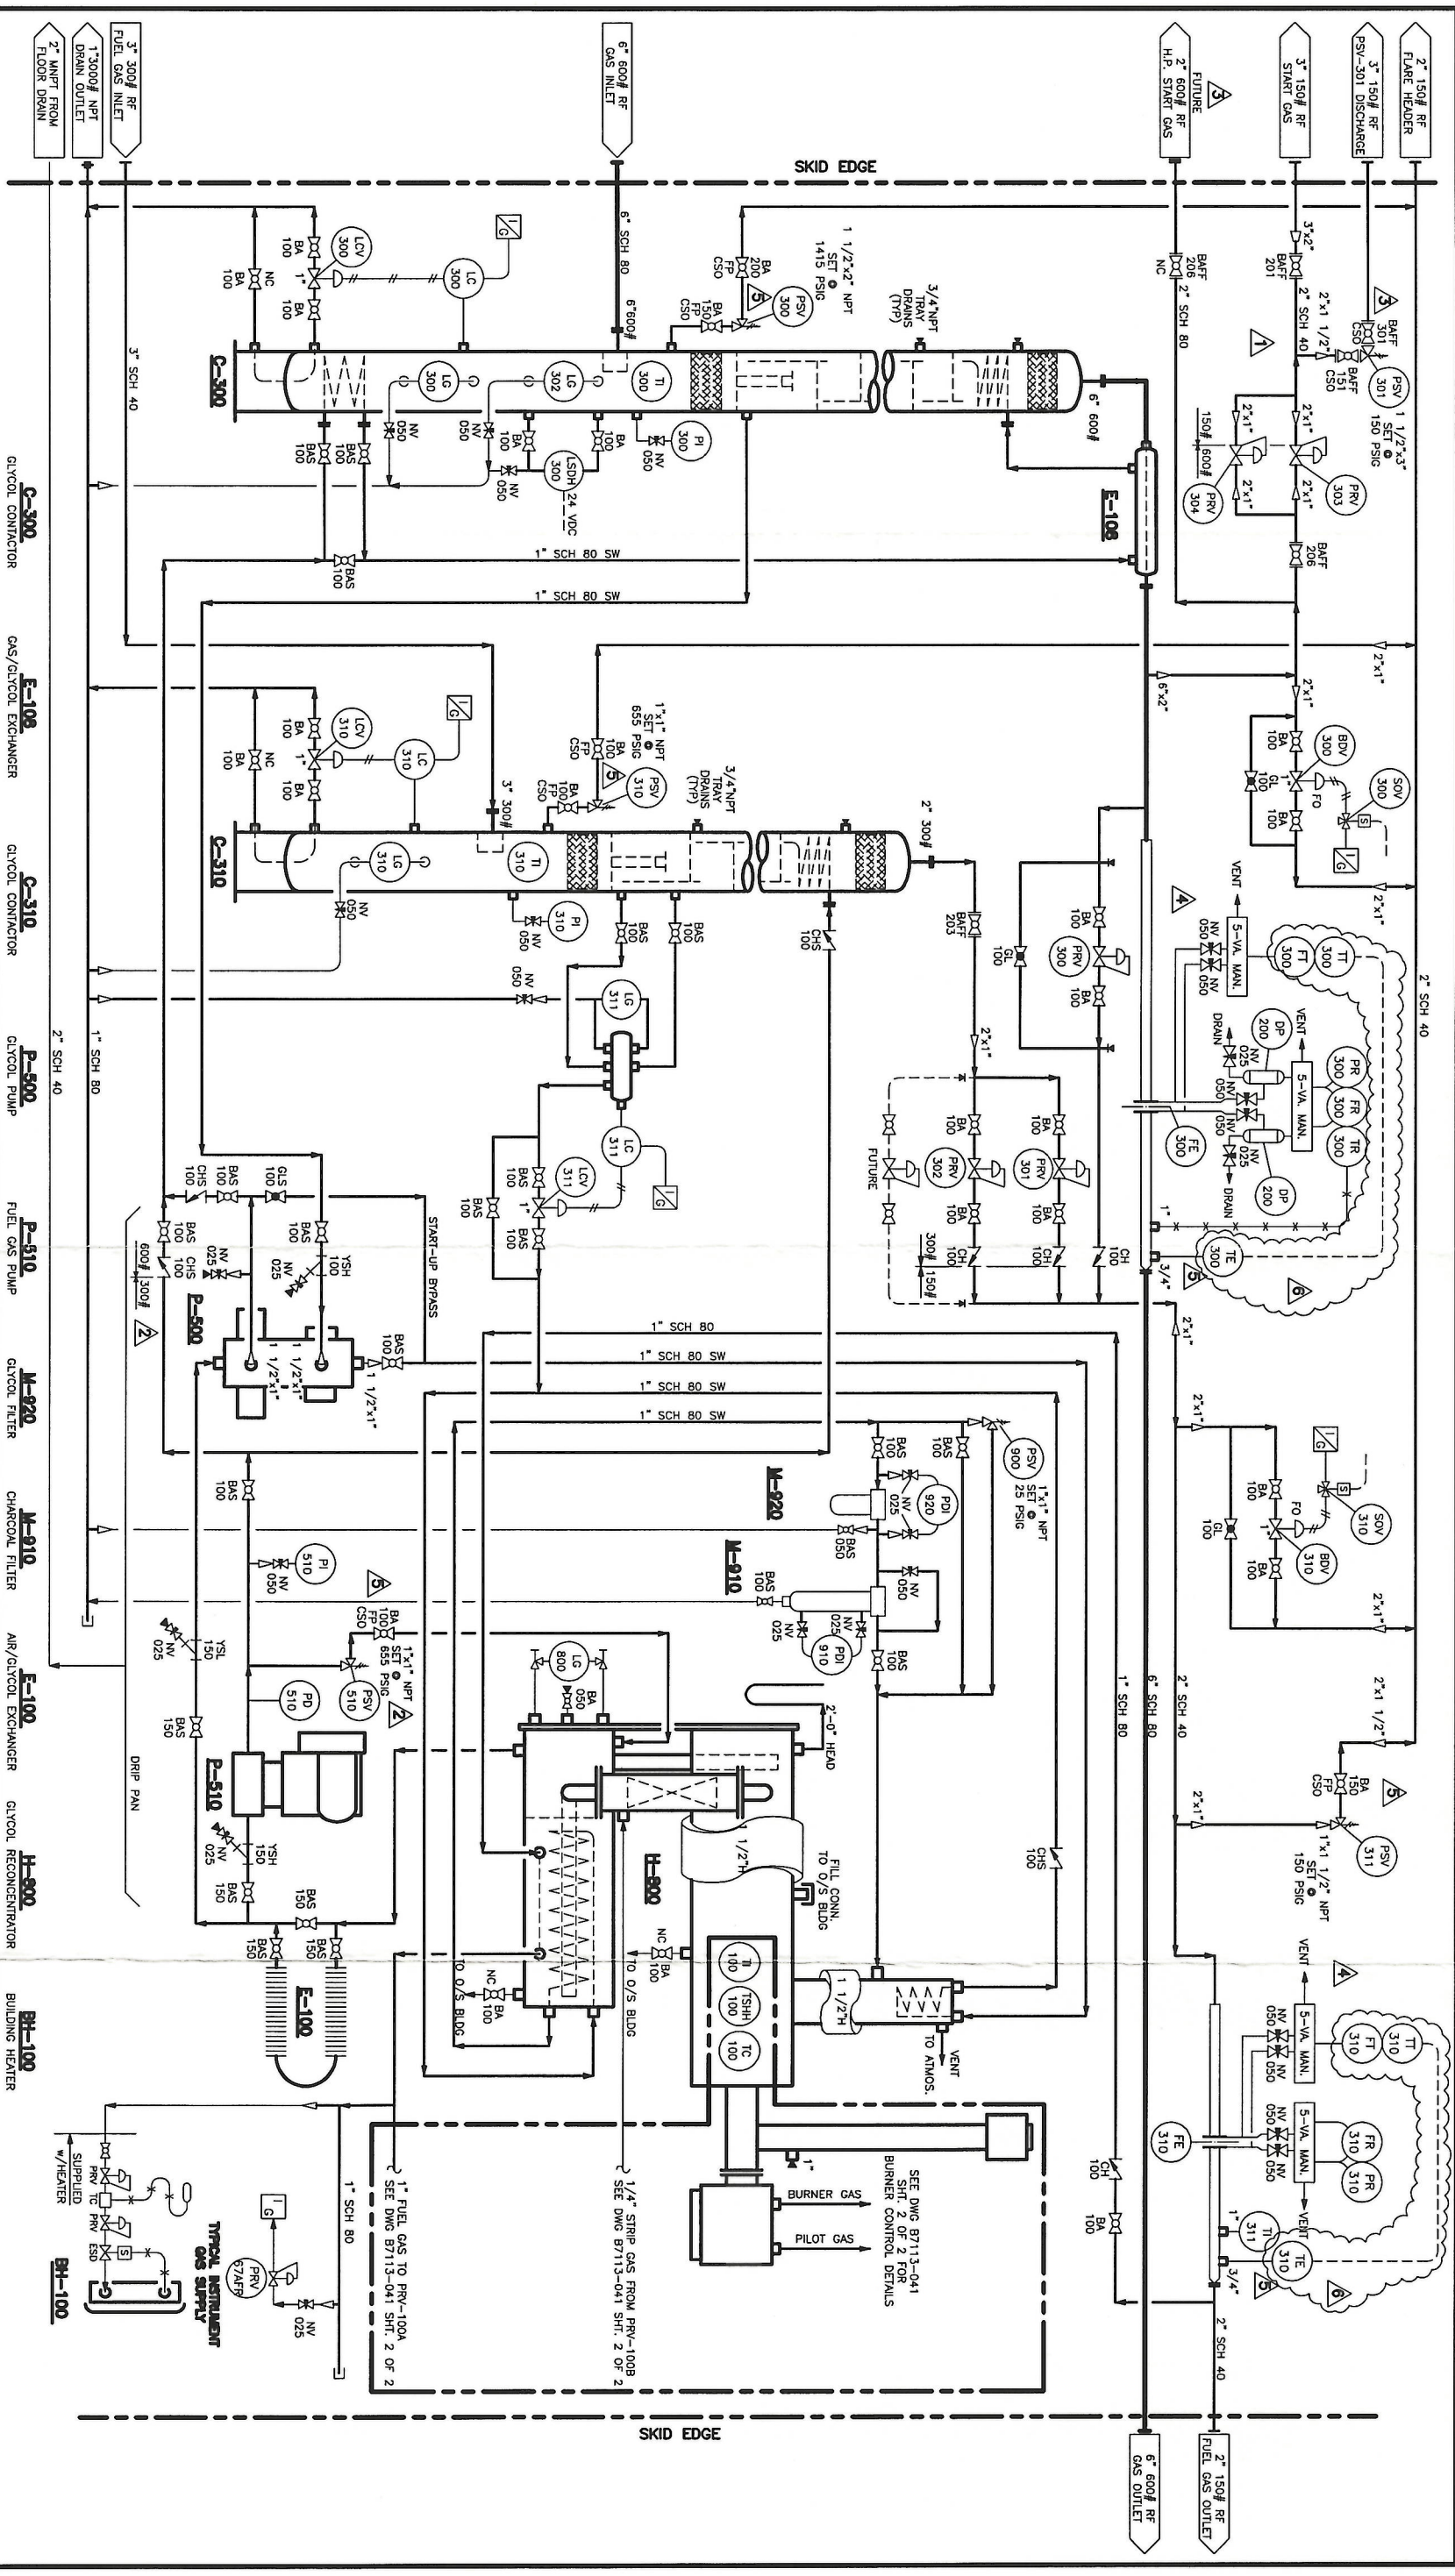

- C-300 GLYCOL COMPRESSOR
- E-108 GAS/GLYCOL EXCHANGER
- C-310 GLYCOL COMPRESSOR
- P-500 GLYCOL PUMP
- P-510 FUEL GAS PUMP
- M-820 GLYCOL FILTER
- M-910 CHARCOAL FILTER
- E-100 AIR/GLYCOL EXCHANGER
- H-900 GLYCOL RECONCENTRATOR
- BH-100 BUILDING HEATER

NO.	REVISION	BY	CHKD	DATE
0	ISSUED FOR CONSTRUCTION	KB		04/09/22
1	ADDED 3" 150# START GAS LINE	TBB		04/11/20
2	REVISED AS SHOWN	D.S.		04/11/10
3	ADDED BLOCK VALVES TO PSV-301	KB		04/11/10
4	ADDED FT-300 & FT-310 WITH SWM	G.SB		04/11/18
5	REVISED AS SHOWN	KB		04/11/18
6	CHANGED FROM PNEUMATIC TO ELECTRICAL	BB		04/12/09


Presson

ENERGEX

PROJECT	CLIENT
TRIDENT EXPLORATION LTD.	B7113-04
DEHYDRATION PACKAGE / CBM COMPRESSOR STATION	LSD T.B.A.
GLYCOL DEHYDRATION UNIT	P&ID

DATE	BY	CHKD	DATE	BY	CHKD
04/09/17	NIS		04/09/17	NIS	


DRAWING NUMBER: B7113-041 SH. 1 OF 2

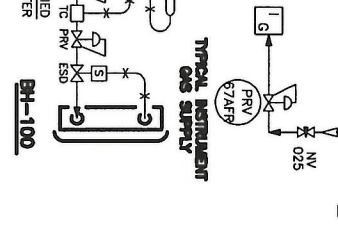

SEE DWG B7113-041 SH. 2 OF 2 FOR BURNER CONTROL DETAILS

1/4" STRIP GAS FROM PRV-100B SEE DWG B7113-041 SH. 2 OF 2

1" FUEL GAS TO PRV-100A SEE DWG B7113-041 SH. 2 OF 2

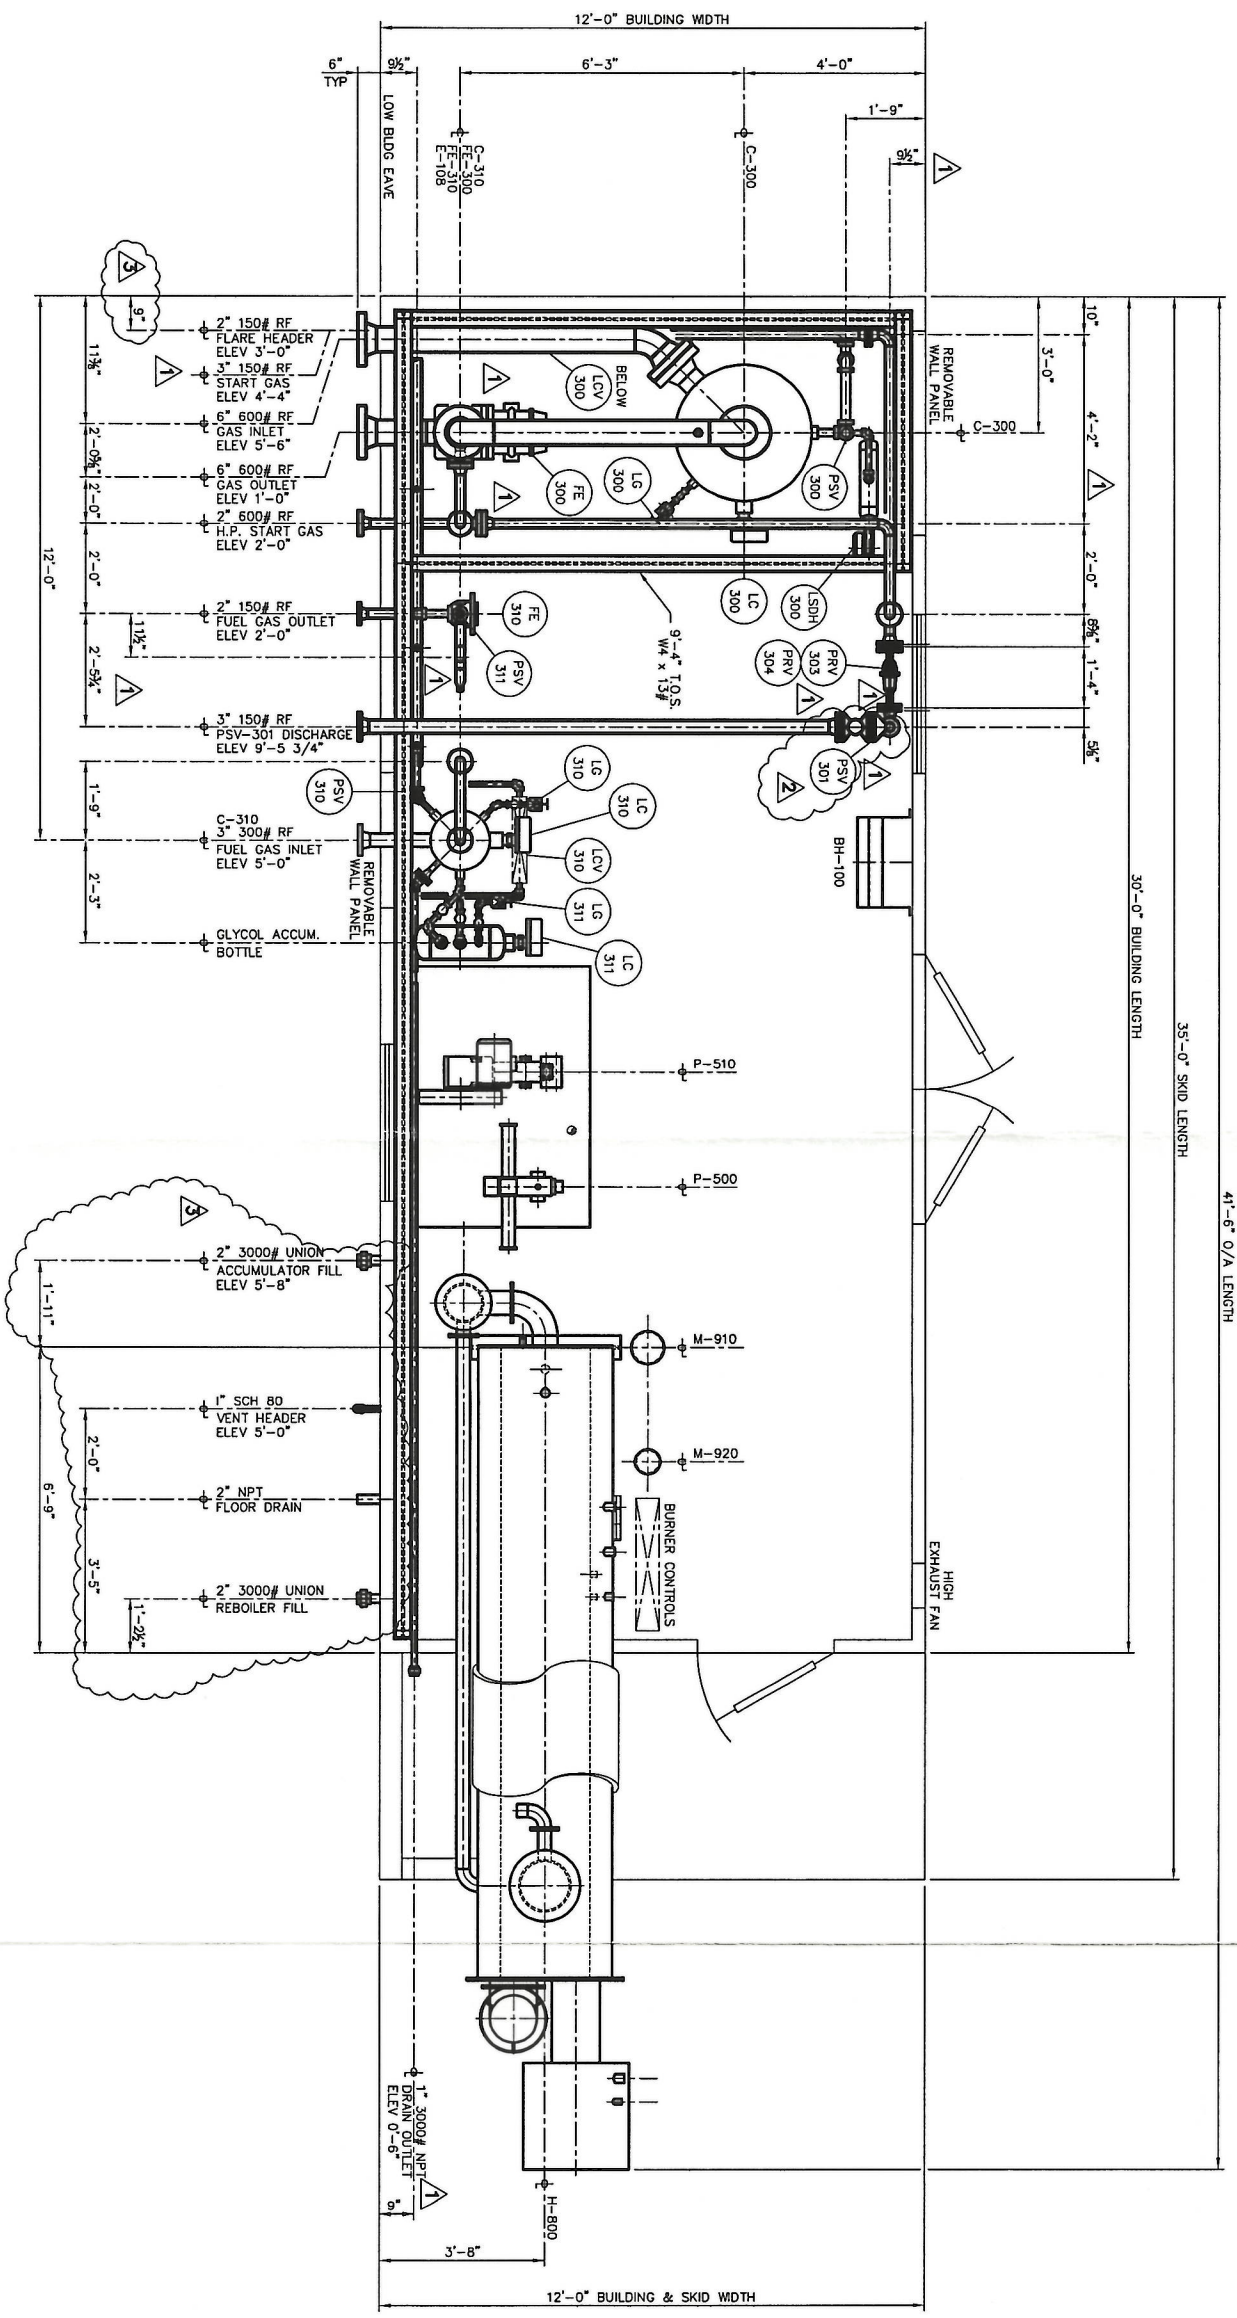

- NOTES:**
- 1) ALL ELEVATIONS ARE TAKEN FROM TOP OF CHECKER PL REF ELEV 0'-0".
 - 2) FOR PIPING SURFACE PREP AND PAINT NOTES SEE INSTR LIST DWG #B7113-040.
 - 3) SKID SUPPORT ALL PIPING AS REQUIRED BEFORE USE.
 - 4) TOTAL ESTIMATED PACKAGE WEIGHT: 53000 lbs (24091 kg).
 - 5) TOTAL ESTIMATED PACKAGE WEIGHT: 53000 lbs (24091 kg).

NO.	REVISION	DATE	BY	CHKD.	APPD.
3	AS-BUILT	05/07/18	GSB		
2	ADDED BLOCK VALVE ON PSV-301	04/11/10	KB		
1	ADDED (2) 3" 150# RF TIE-INS	04/11/03	TP		
A	ISSUED FOR APPROVAL	04/09/17			

<p style="text-align: center;">Presson ENERGLEX</p>		<p style="text-align: center;">T.B.A</p>	
<p style="text-align: center;">TRIDENT EXPLORATION LTD.</p>		<p style="text-align: center;">B7113-04</p>	
<p style="text-align: center;">DEHYDRATION PACKAGE / CBM COMPRESSOR STATION</p>		<p style="text-align: center;">LSD T.B.A</p>	
<p style="text-align: center;">GENERAL ARRANGEMENT</p>		<p style="text-align: center;">DATE: 04/08/17</p>	
<p style="text-align: center;">DRAWN: TP</p>		<p style="text-align: center;">SCALE: 1/2"=1'-0"</p>	
<p style="text-align: center;">CHECKED: [Signature]</p>		<p style="text-align: center;">DATE: 04/08/17</p>	
<p style="text-align: center;">APPROVED: [Signature]</p>		<p style="text-align: center;">PROJECT: B7113-340 SH. 1 OF 1</p>	