


T-700
WATER TANK
 CAPACITY: 400 BBL
 SIZE: 3658mm OD x 6096mm HIGH
 FIRETUBE:
 EXISTING

T-710
WATER TANK
 CAPACITY: 400 BBL
 SIZE: 3658mm OD x 6096mm HIGH
 FIRETUBE:
 EXISTING

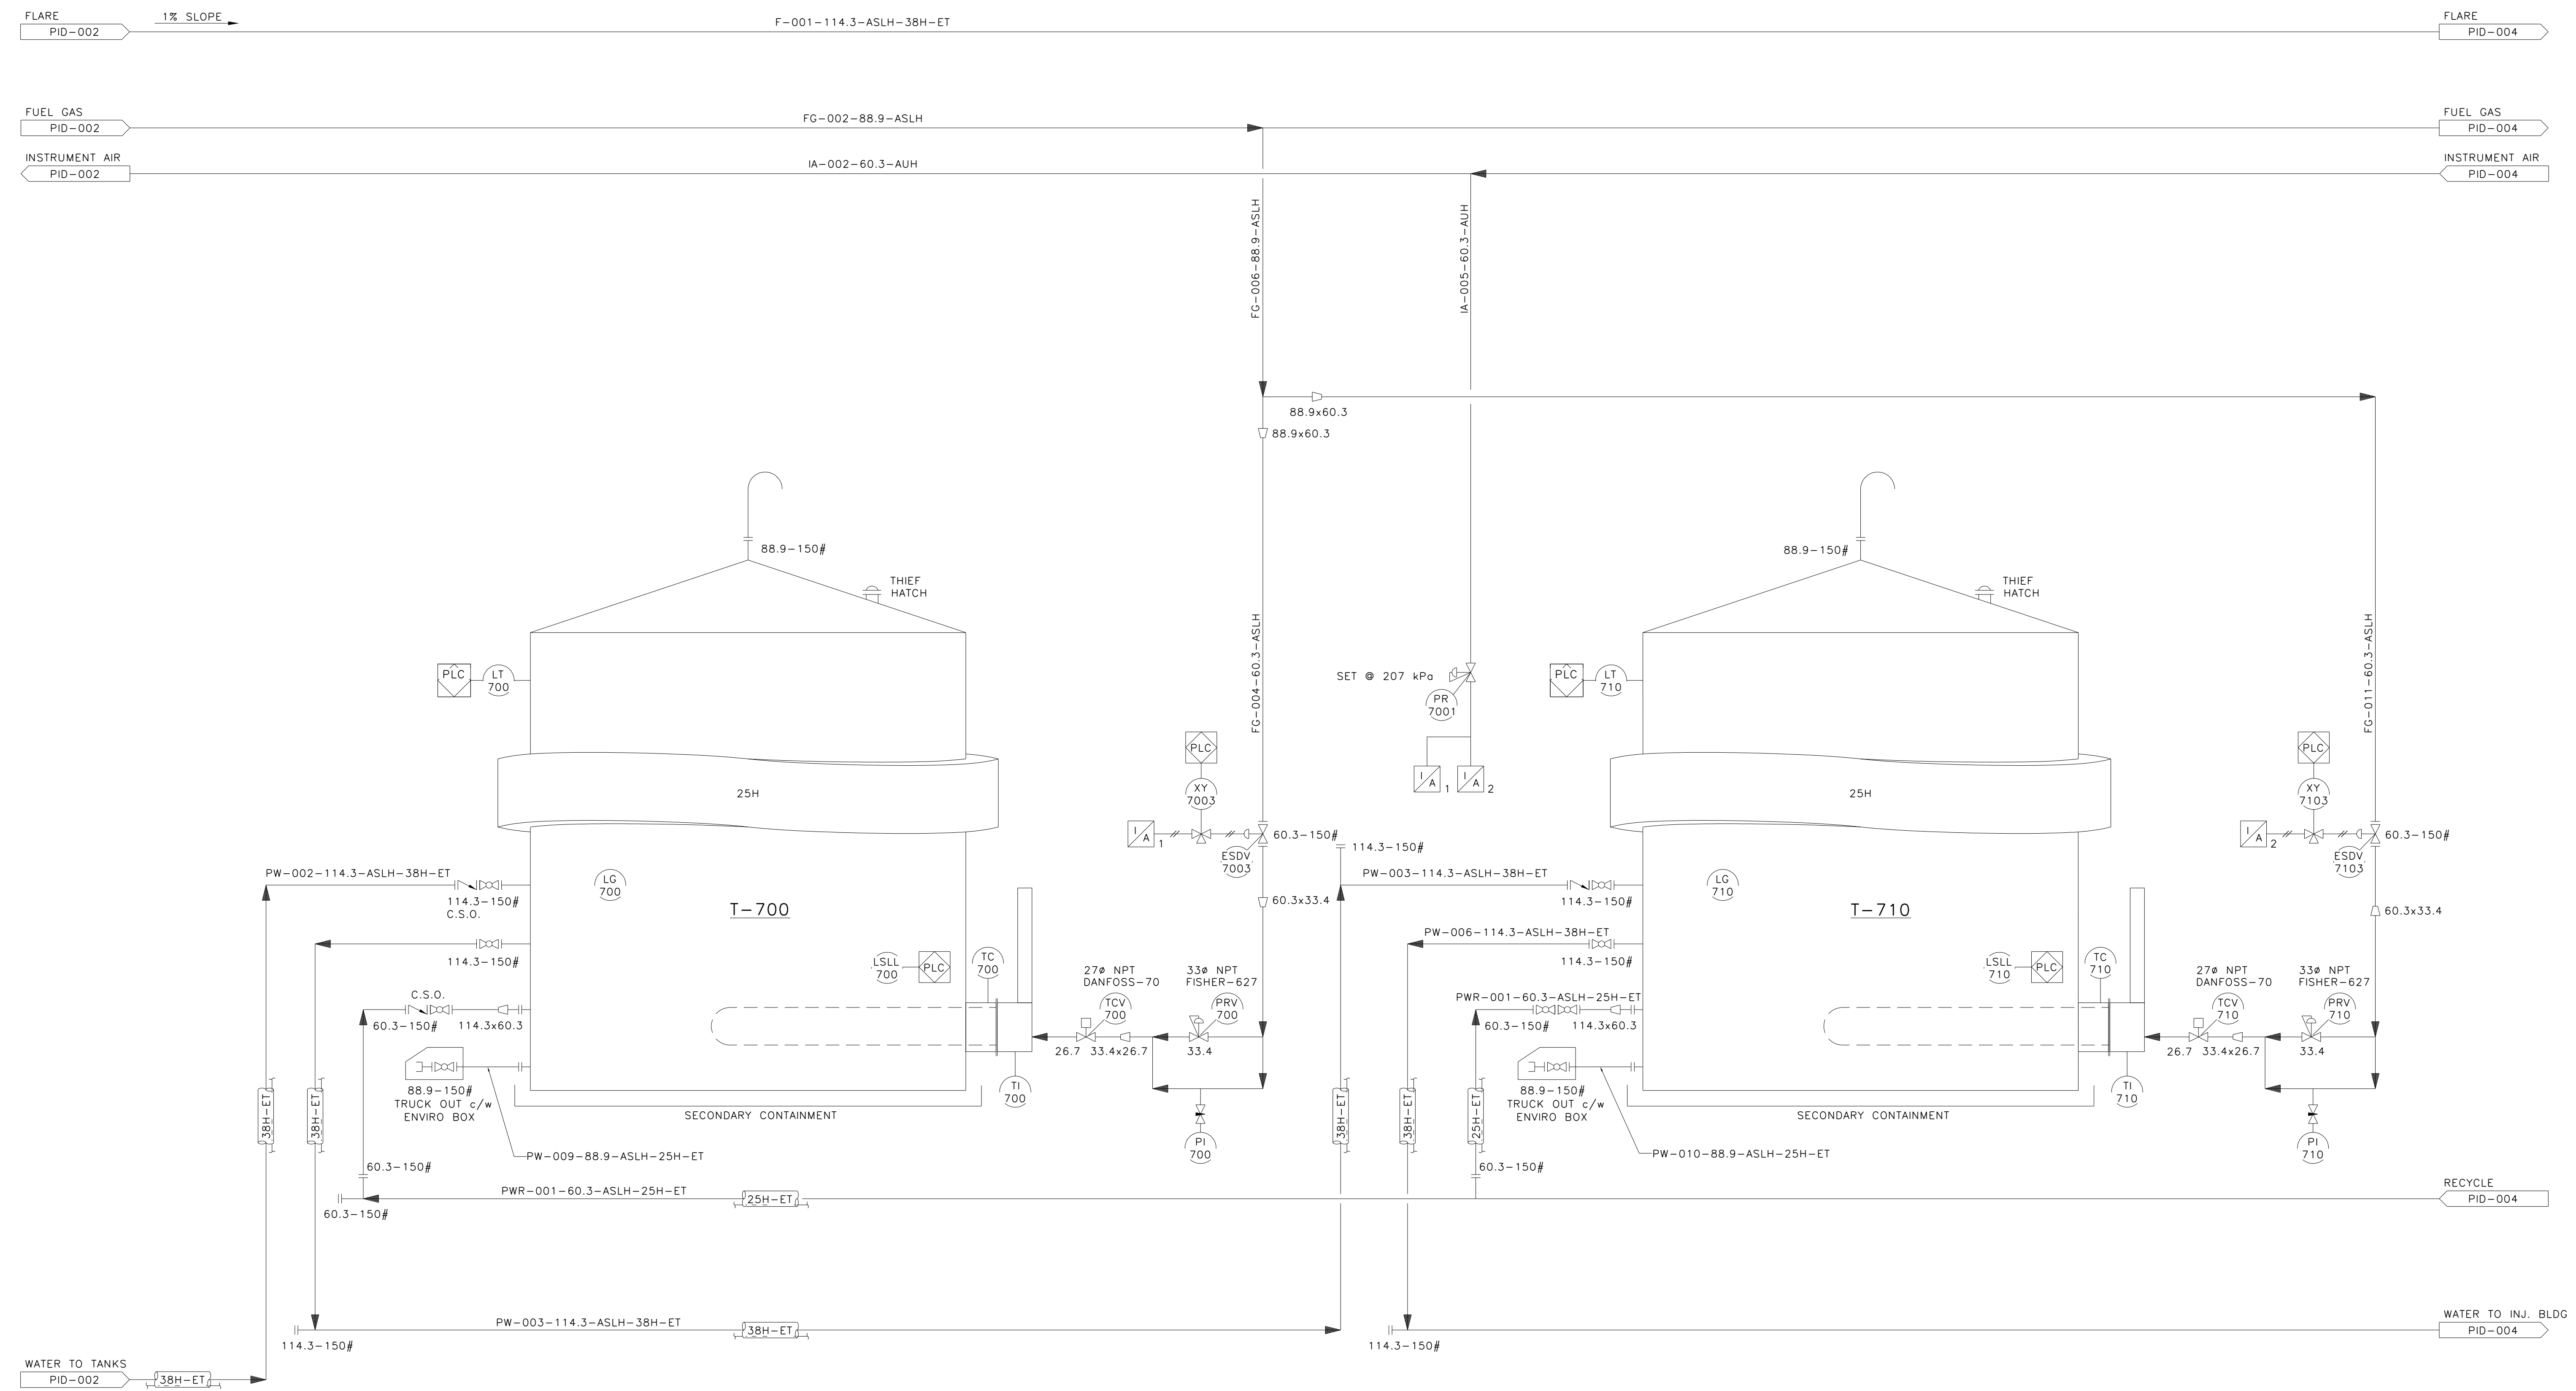

DRAWING No.	REFERENCE DRAWINGS	REV	DESCRIPTION	DATE	BY	APRD
D-02490-B-03-02	MUSKWA 08-34 BOOSTER STATION WATER INJECTION AREA PIPING PLAN	A	ISSUED FOR APPROVAL	03/09/17	RS	BW
	REV 2	B	RE-ISSUED FOR APPROVAL	03/11/10	RD	BW
		0	ISSUED FOR CONSTRUCTION	03/12/01	RD	BW
		1	REVISED PIPING SPECIFICATIONS	03/12/08	RS	BW
		2	AS-BUILT AS PER FIELD MARK UPS	04/03/13	RD	KJV

NOTES:
 1. CLOUDED AREAS DENOTE NEW EQUIPMENT/CHANGES WITHIN EXISTING SKID
 2. FOUR DIGIT TAG NO'S DENOTE NEW INSTRUMENTATION

FALCON
EDF LTD.
 CALGARY ALBERTA
 DRAWN BY: RD
 DATE 03/09/16
 CHKD BY: BW
 DATE
 DESIGN BY: KJV
 DATE 03/09/16

Husky Energy

MUSKWA COMPRESSOR & WATER INJECTION
 LSD 5-25-84-26 W4M
 WATER TANKS P&ID

SCALE: NONE	PROJ. H-3066	DRAWING NUMBER H3066-PID-003	REV 2
----------------	-----------------	---------------------------------	----------

CAD FILE: