


7

THE INFORMATION AND DATA CONTAINED IN THIS DRAWING IS CONFIDENTIAL, PROPRIETARY IN NATURE AND SUBJECT TO COPYRIGHT, AND MAY NOT BE REPRODUCED, COPIED, MIRACED, REPRODUCED, ALTERED, CHANGED, MODIFIED, SOLD, DISTRIBUTED, OR UTILIZED IN ANY FORM WITHOUT THE EXPRESS PERMISSION OF CONOCOPhillips CANADA.

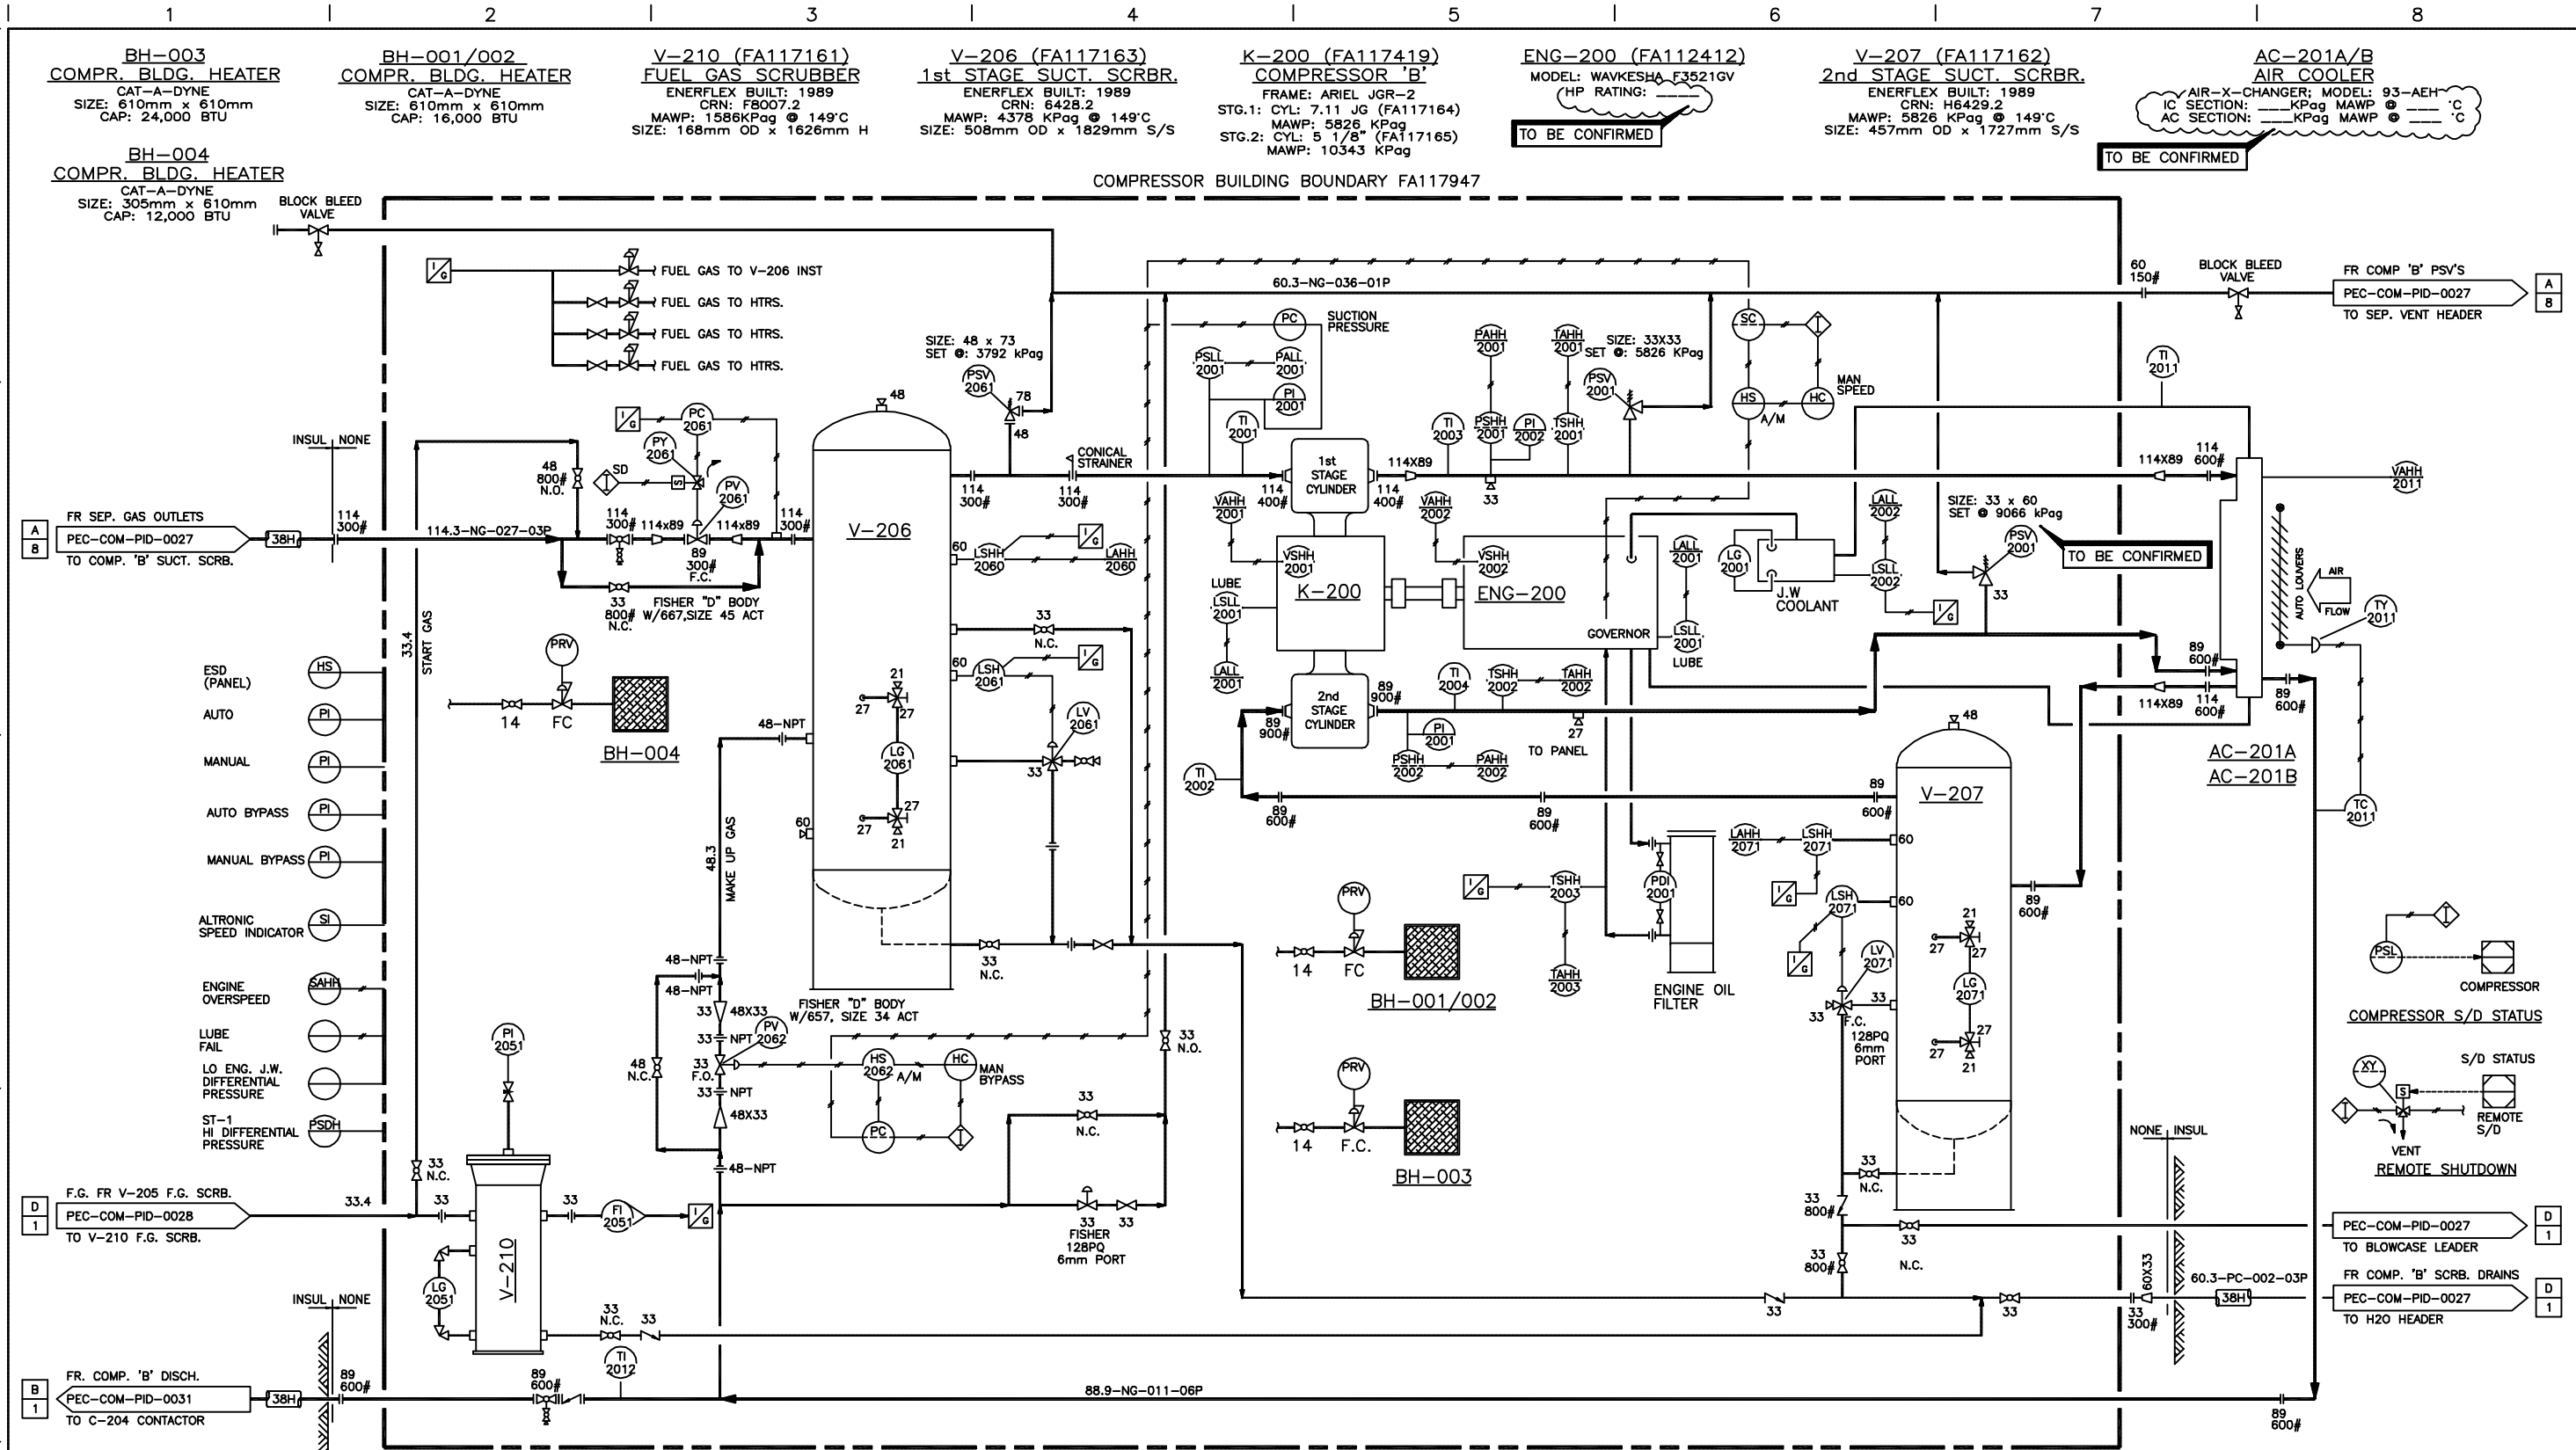

REFERENCE DRAWINGS	
DWG. NO.	TITLE

REVISIONS						
REV.	DATE	BY	CHK'D	CHK'D	APP'D	REVISION ISSUE
0	05/03/28	GW	WOT	ENG	TDM	AS-BUILT 2005, CALTECH PROJECT #11303, ISSUED FOR HAZOP
1	05/08/22	LZ	PGP		TDM	AS-BUILT 2005, CALTECH PROJECT #11303, ISSUED POST HAZOP

ENGINEERING SEAL

PERMIT

PREPARED BY: Caltech

DESIGNED:	TDM	DATE:	05/03/28
DRAWN:	GW	DATE:	05/04/08
CHECKED:	WOT	DATE:	05/04/20
PROCESS CK:			
STRUCT. CK:			
ELECT. CK:			
INSTR. CK:			
ENG. CO. APPR:			
CLIENT APPR:			

Canada Resources Corp.

PECO 06-21 COMPRESSOR STATION

COMPRESSOR BUILDING 'B'

PIPING & INSTRUMENTATION DIAGRAM

LEGAL DESC. FROM: 06-21-048-16 WSM

LEGAL DESC. TO (IF APPLICABLE):

ENG. CO. PROJ. NO.:	CDI-11303	SCALE:	NTS	DESIGN:	TDM	CPC DWG. NO.:	PEC-COM-PID-0030	REV.:	1
ENG. CO. DWG. NO.:	PEC-COM-PID-0030	DATE:	05/04/08	DRAWN:	GW				

7